
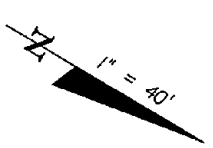


SR 600

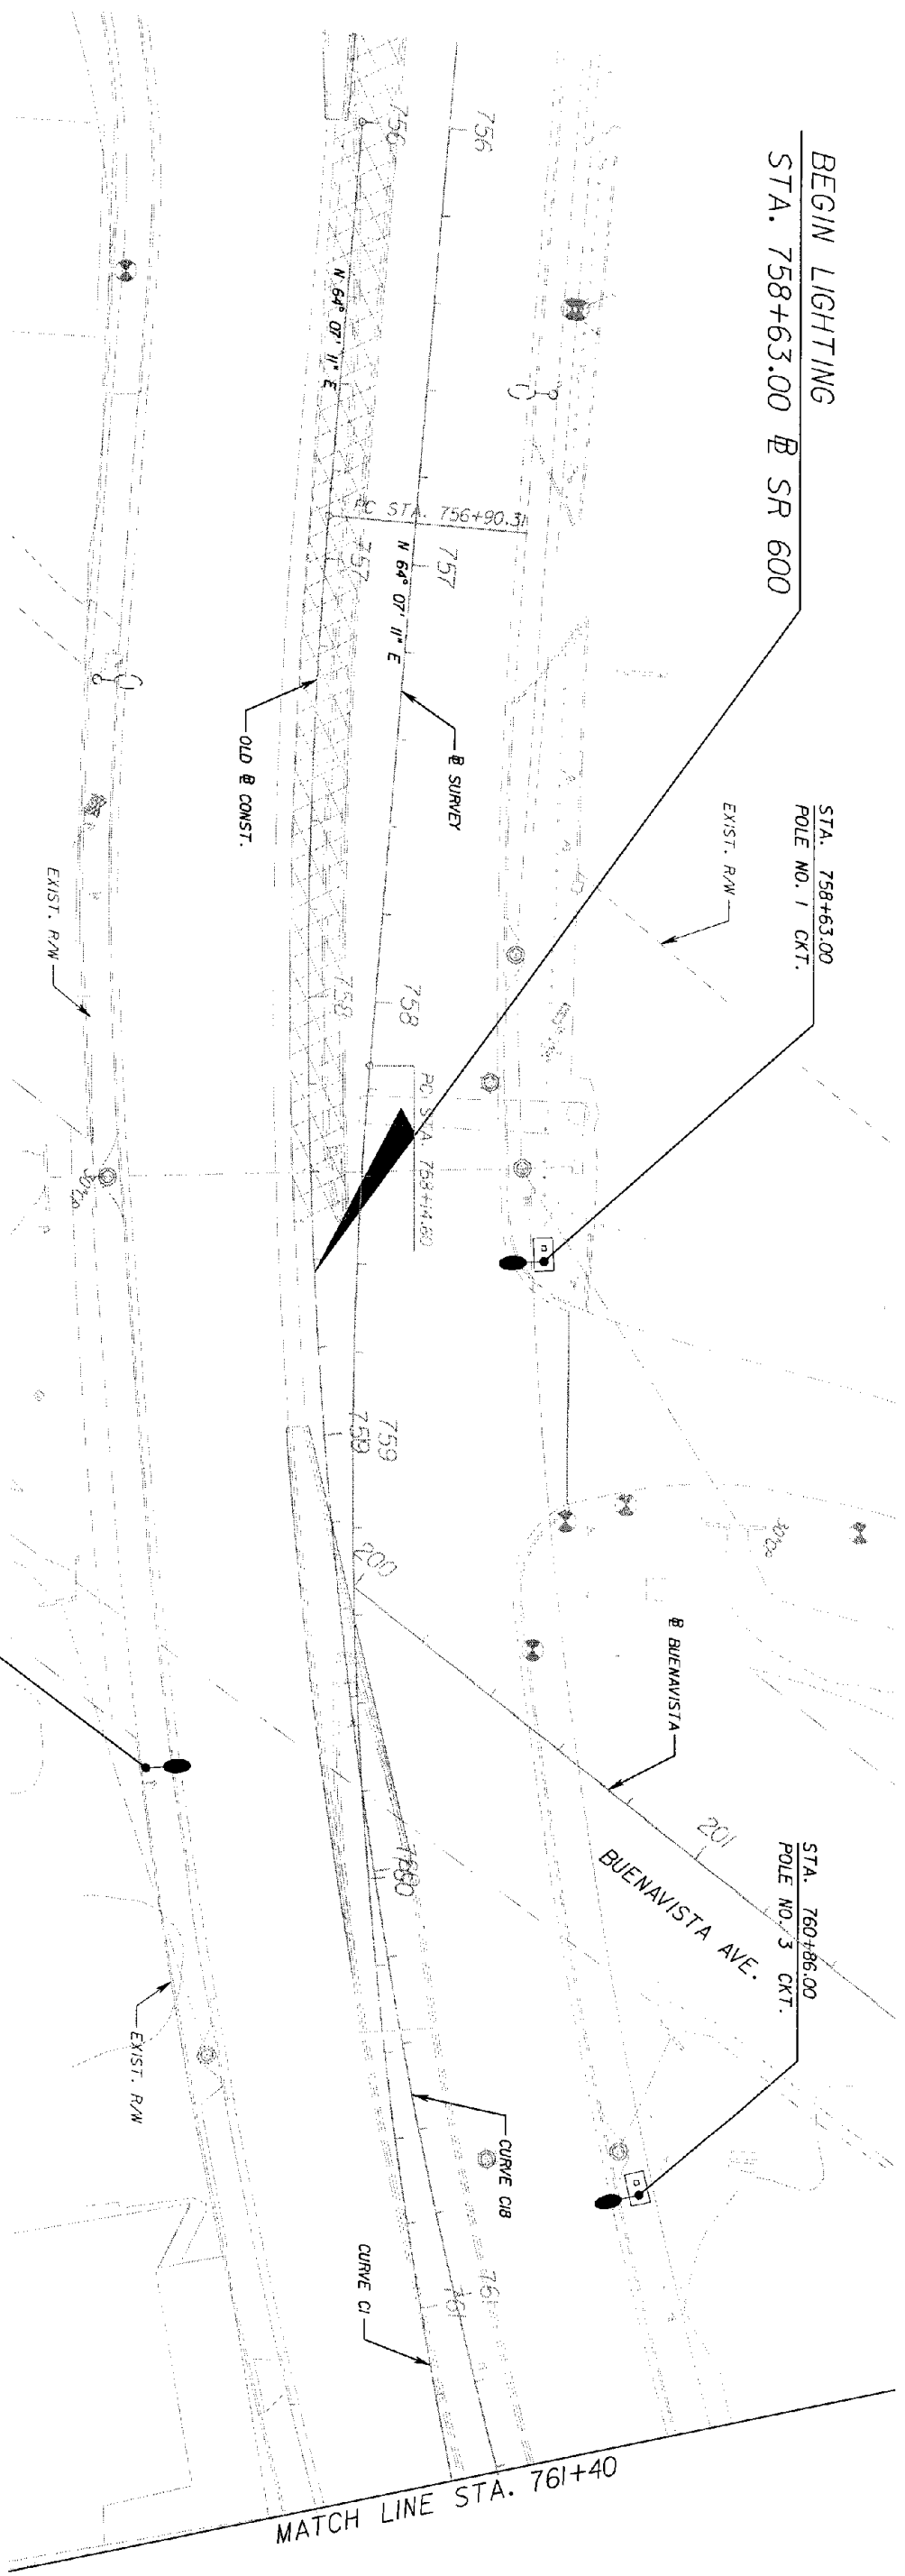



DATE		BY		DESCRIPTION	

DATE		BY		DESCRIPTION	

<p><i>Talley, Davis & Associates, Inc.</i> 5505 W. GORPSS ST. - SUITE 300 TAMPA, FLORIDA 33607-107 ERBIE A. GARRETT, P.E. NO.: 45219</p>		<p>STATE OF FLORIDA DEPARTMENT OF TRANSPORTATION ROAD NO. SR 600 COUNTY POLK FINANCIAL PROJECT ID 197593-1-52-01</p>		<p>LIGHTING PLAN NORTHBOUND</p>	
---	--	--	--	--	--

SHEET NO.	L-8
-----------	-----

SR 600

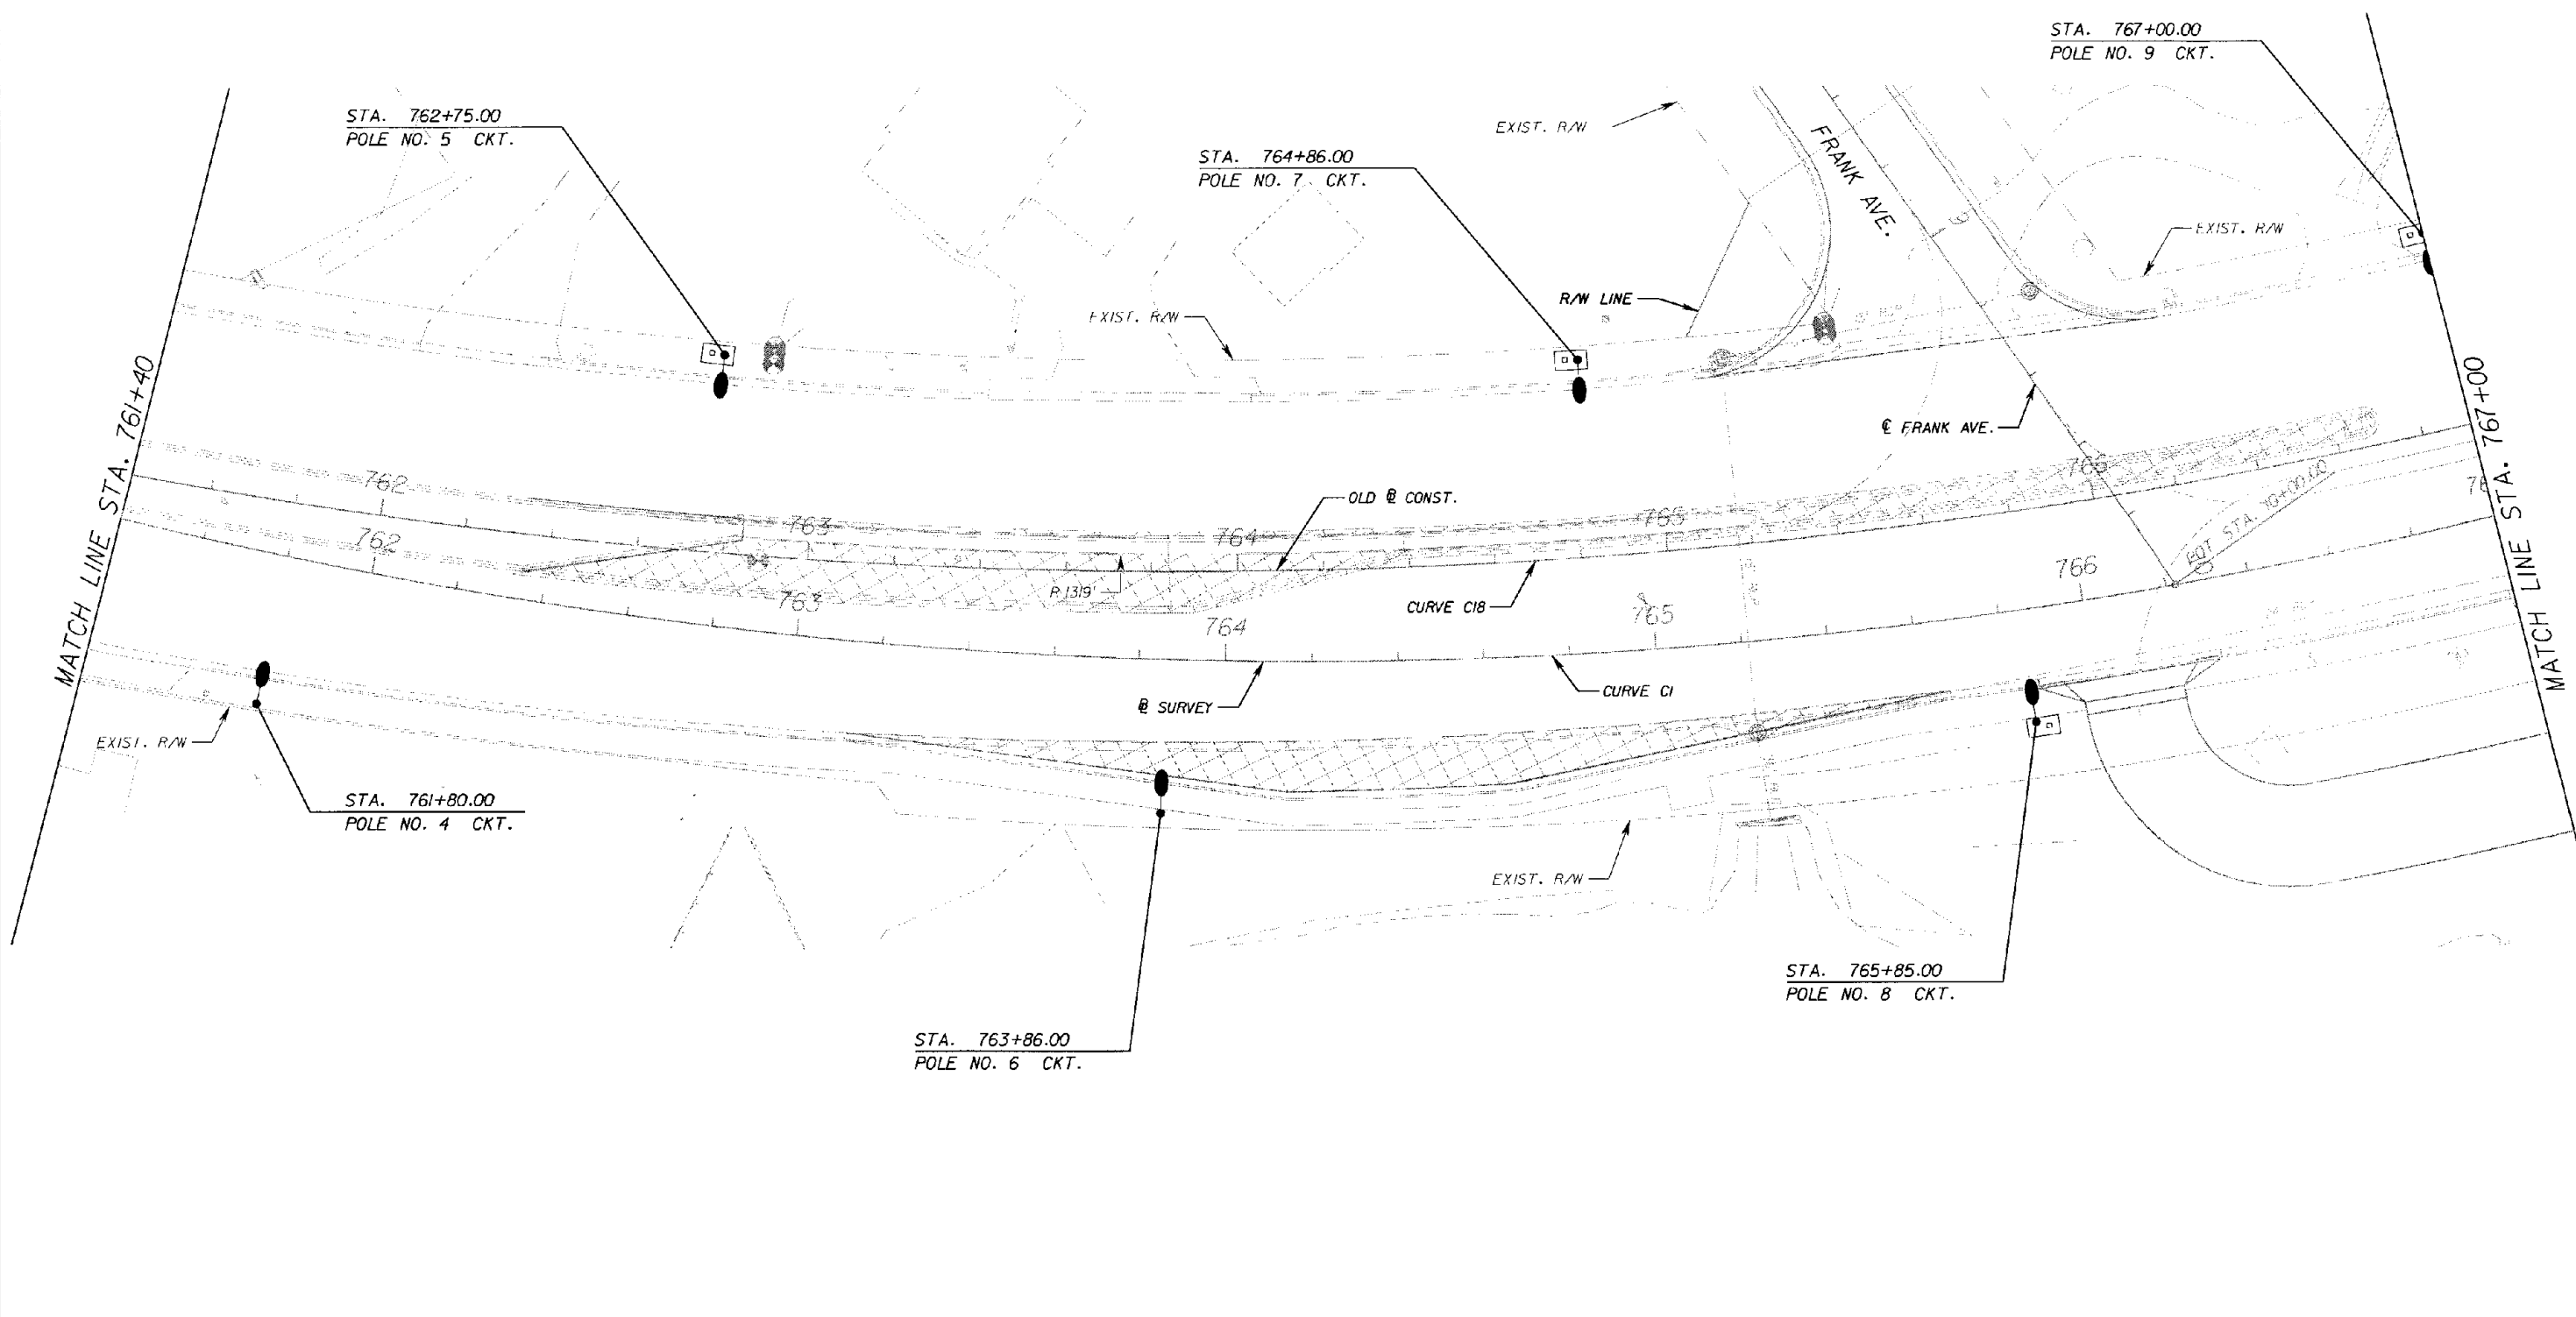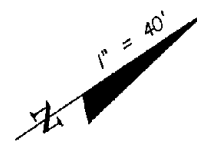

REVISIONS					
DATE	BY	DESCRIPTION	DATE	BY	DESCRIPTION

Fallen Davis & Associates, Inc.
 5525 W. CYPRESS ST. - SUITE 300
 TAMPA, FLORIDA 33607-1707
 CERTIFICATE OF AUTHORIZATION NO.: 5864
 ERBIE A. GARRETT, P.E. NO.: 45219



STATE OF FLORIDA DEPARTMENT OF TRANSPORTATION		
ROAD NO.	COUNTY	FINANCIAL PROJECT ID.
SR 600	POLK	197593-1-52-01

**LIGHTING PLAN
NORTHBOUND**

SHEET NO.
L-9

NOTICE: THE OFFICIAL RECORD OF THIS SHEET IS THE ELECTRONIC FILE SIGNED AND SEALED UNDER RULE 61G05-23.003, F.A.C.

 SR 600

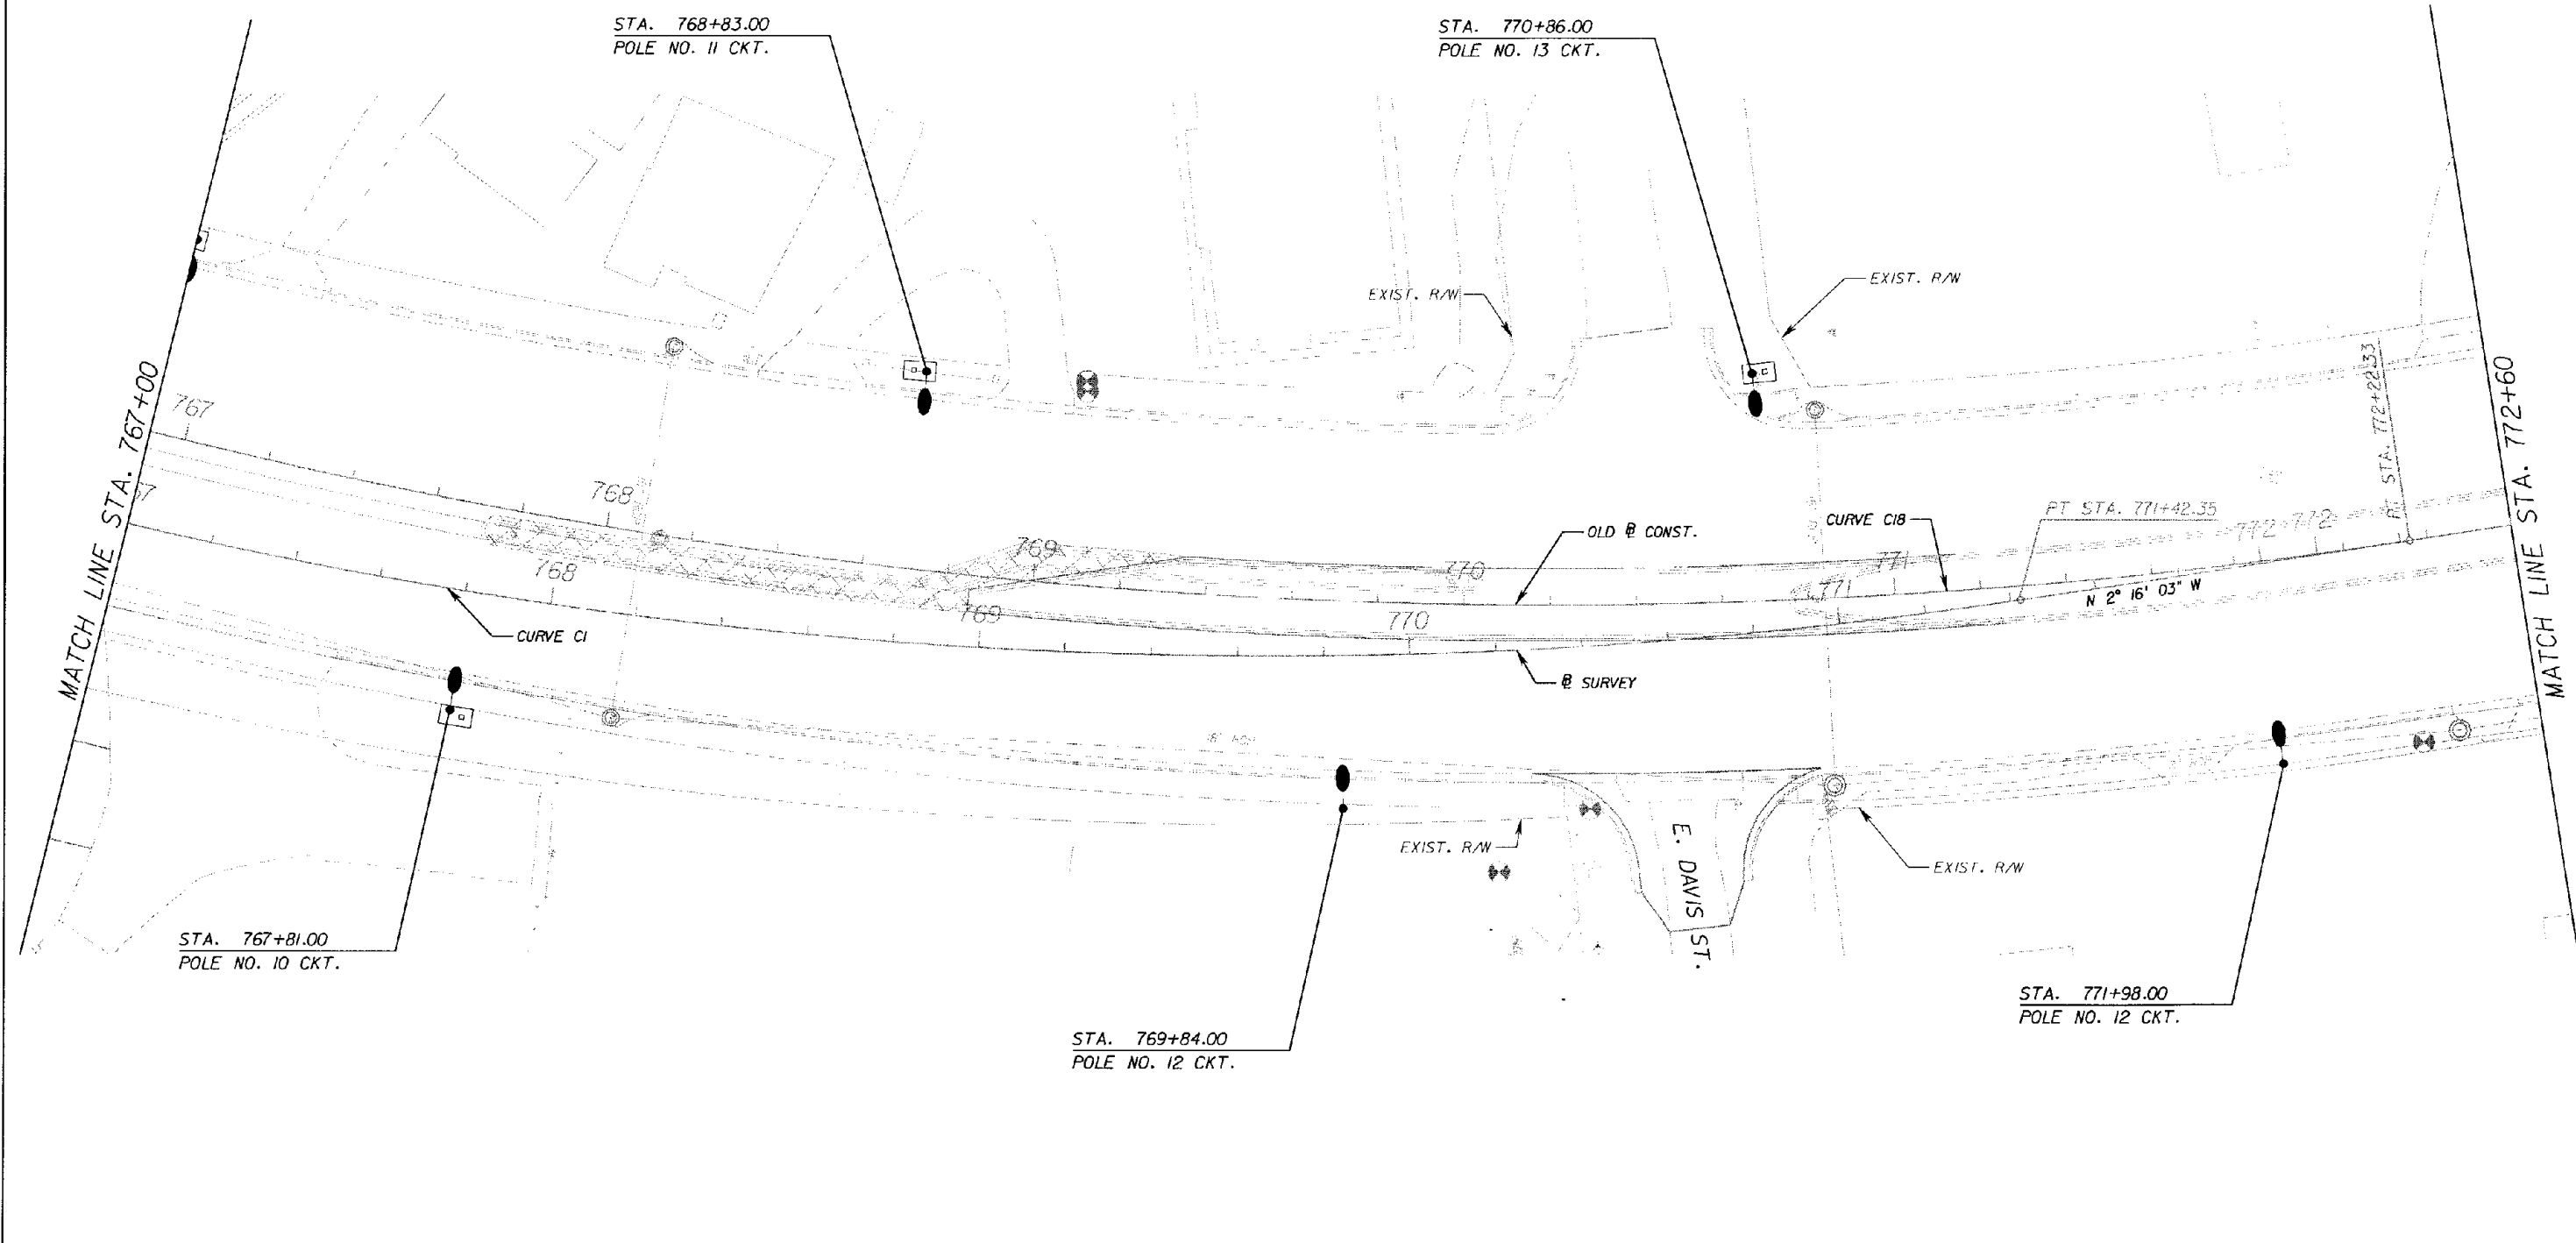

REVISIONS					
DATE	BY	DESCRIPTION	DATE	BY	DESCRIPTION

Faller Davis & Associates, Inc.
 5525 W. CYPRESS ST. - SUITE 300
 TAMPA, FLORIDA 33607-1707
 CERTIFICATE OF AUTHORIZATION NO.: 5864
 ERBIE A. GARRETT, P.E. NO.: 45219


STATE OF FLORIDA DEPARTMENT OF TRANSPORTATION		
ROAD NO.	COUNTY	FINANCIAL PROJECT ID
SR 600	POLK	197593-1-52-01

**LIGHTING PLAN
NORTHBOUND**

SHEET NO.
L-10

NOTICE: THE OFFICIAL RECORD OF THIS SHEET IS THE ELECTRONIC FILE SIGNED AND SEALED UNDER RULE 61G15-23.003, F.A.C.

 SR 600



STA. 773+12.00
POLE NO. 15 CKT.

STA. 775+41.00
POLE NO. 17 CKT.

STA. 777+70.00
POLE NO. 19 CKT.

STA. 774+26.00
POLE NO. 16 CKT.

STA. 776+55.00
POLE NO. 18 CKT.

MATCH LINE STA. 772+60

MATCH LINE STA. 778+20

SCOTT AVE.

EXIST. P/W

EXIST. R/W

EXIST. P/W

EXIST. R/W

⊕ SURVEY

773

774

775

776

777

778

S-1081B
S-1081A
S-1081C
S-1081D
S-1081E
S-1081F
S-1081G
S-1081H
S-1081I
S-1081J
S-1081K
S-1081L
S-1081M
S-1081N
S-1081O
S-1081P
S-1081Q
S-1081R
S-1081S
S-1081T
S-1081U
S-1081V
S-1081W
S-1081X
S-1081Y
S-1081Z

REVISIONS					
DATE	BY	DESCRIPTION	DATE	BY	DESCRIPTION

Faller, Davis & Associates, Inc.
5525 W. CYPRESS ST. - SUITE 300
TAMPA, FLORIDA 33607-1707
CERTIFICATE OF AUTHORIZATION NO.: 5864
ERBIE A. GARRETT, P.E. NO.: 45219


STATE OF FLORIDA DEPARTMENT OF TRANSPORTATION		
ROAD NO.	COUNTY	FINANCIAL PROJECT ID
SR 600	POIK	197593-1-52-01

**LIGHTING PLAN
NORTHBOUND**

SHEET NO.
L-11

SR 600

1" = 40'

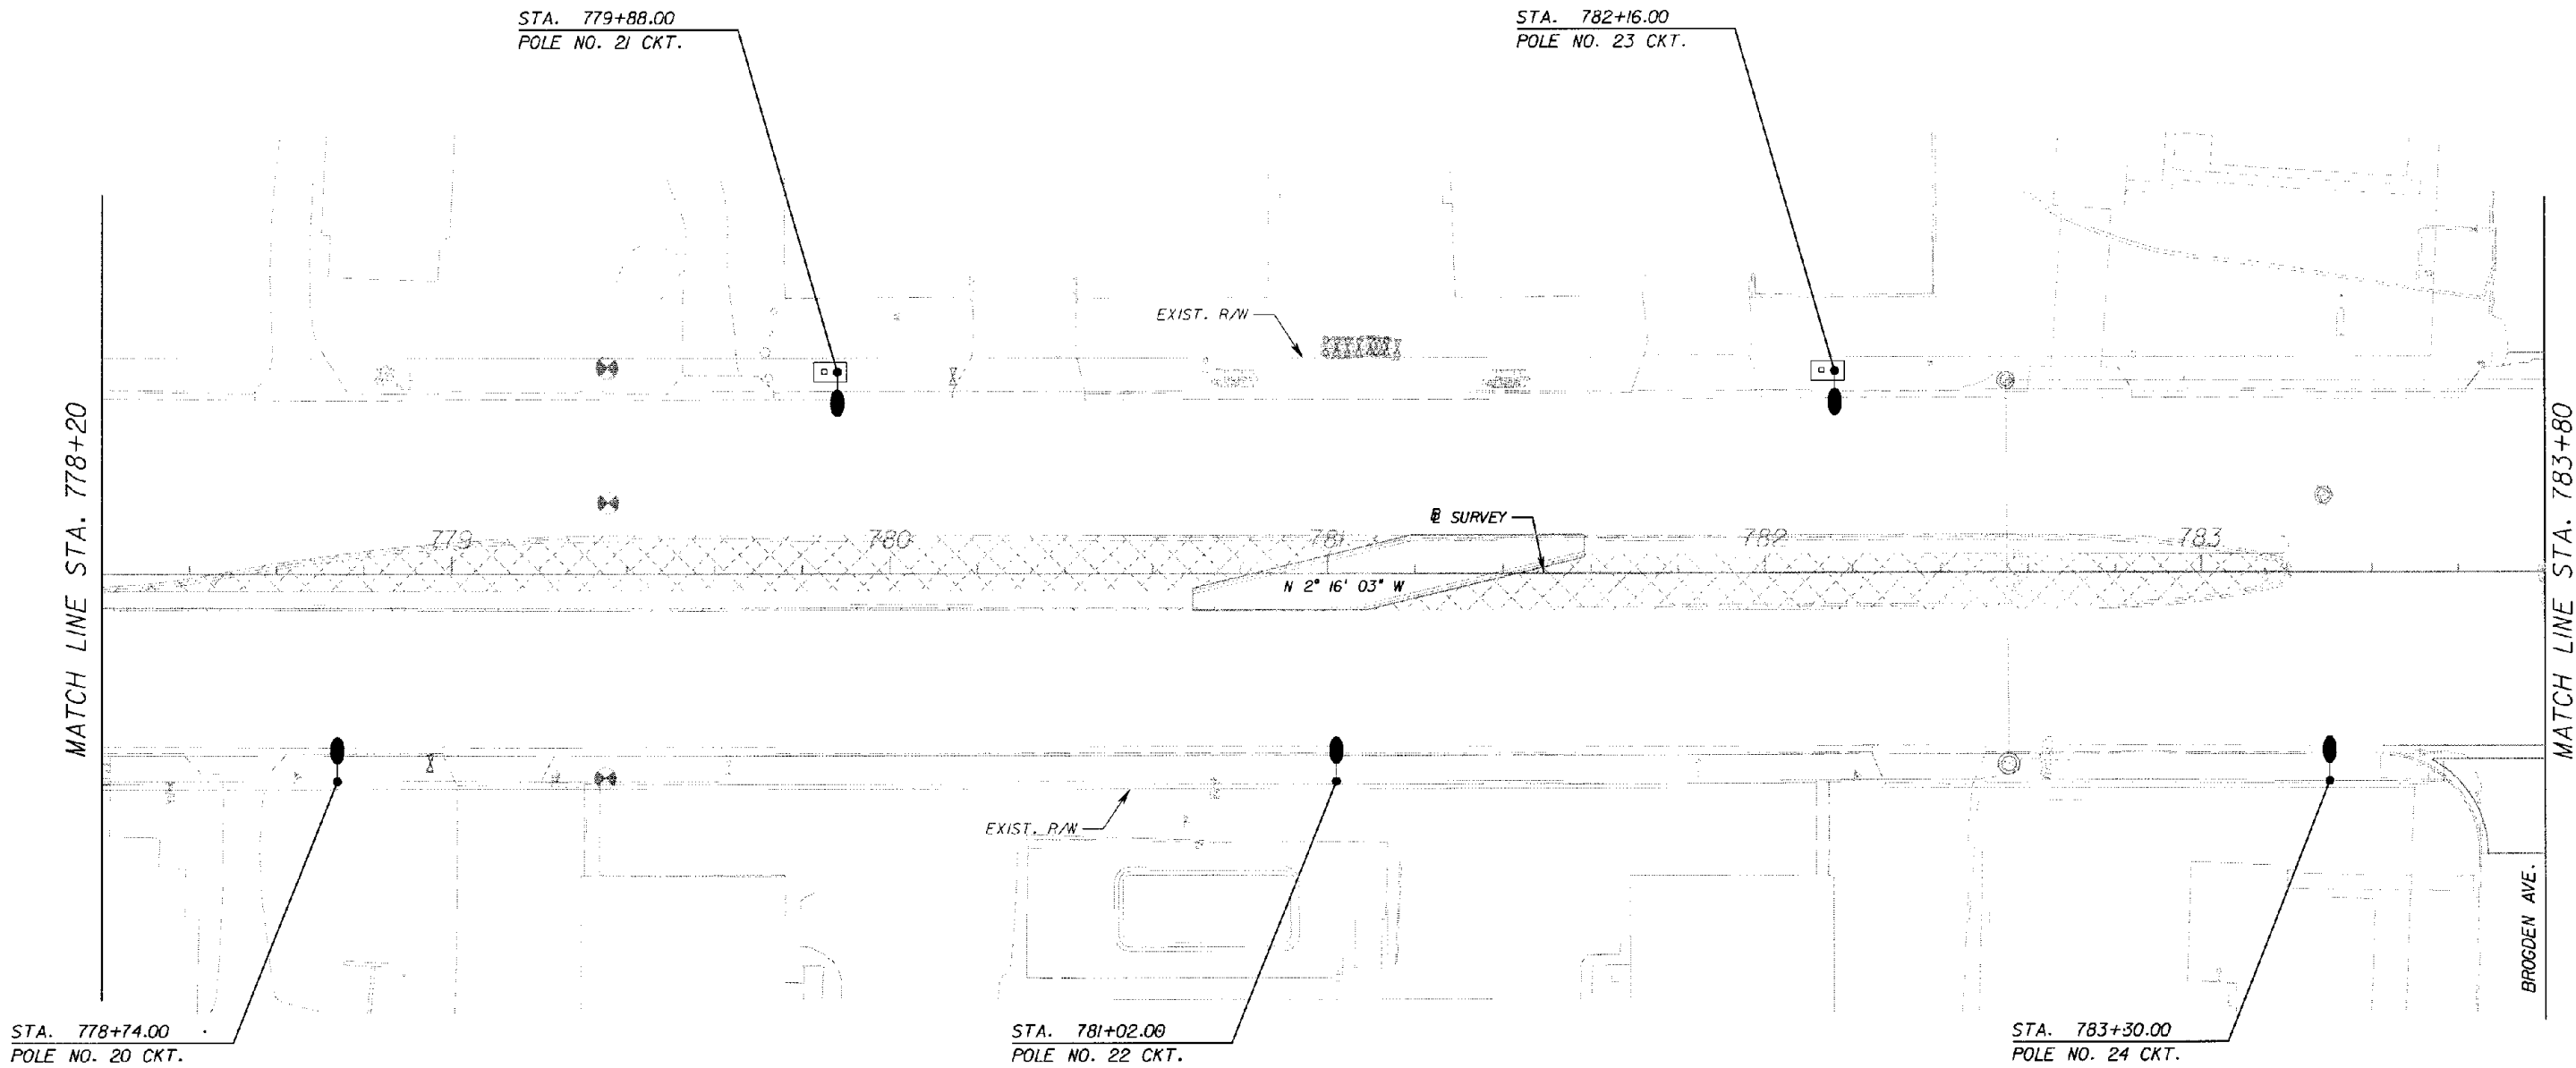

REVISIONS					
DATE	BY	DESCRIPTION	DATE	BY	DESCRIPTION

Fuller, Davis & Associates, Inc.
 5525 W. CYPRESS ST. - SUITE 300
 TAMPA, FLORIDA 33607-1707
 CERTIFICATE OF AUTHORIZATION NO.: 5864
 ERBIE A. GARRETT, P.E. NO.: 45219

STATE OF FLORIDA DEPARTMENT OF TRANSPORTATION		
ROAD NO.	COUNTY	FINANCIAL PROJECT ID
SR 600	POLK	197593-1-52-01

LIGHTING PLAN NORTHBOUND	
DATE	SHEET NO.
	L-12

NOTICE: THE OFFICIAL RECORD OF THIS SHEET IS THE ELECTRONIC FILE SIGNED AND SEALED UNDER RULE 68J5-23.003, F.A.C.

SR 600

1" = 40'


STA. 784+40.00
POLE NO. 25 CKT.

STA. 786+60.00
POLE NO. 27 CKT.

STA. 788+73.00
POLE NO. 29 CKT.

MATCH LINE STA. 783+80

MATCH LINE STA. 789+40

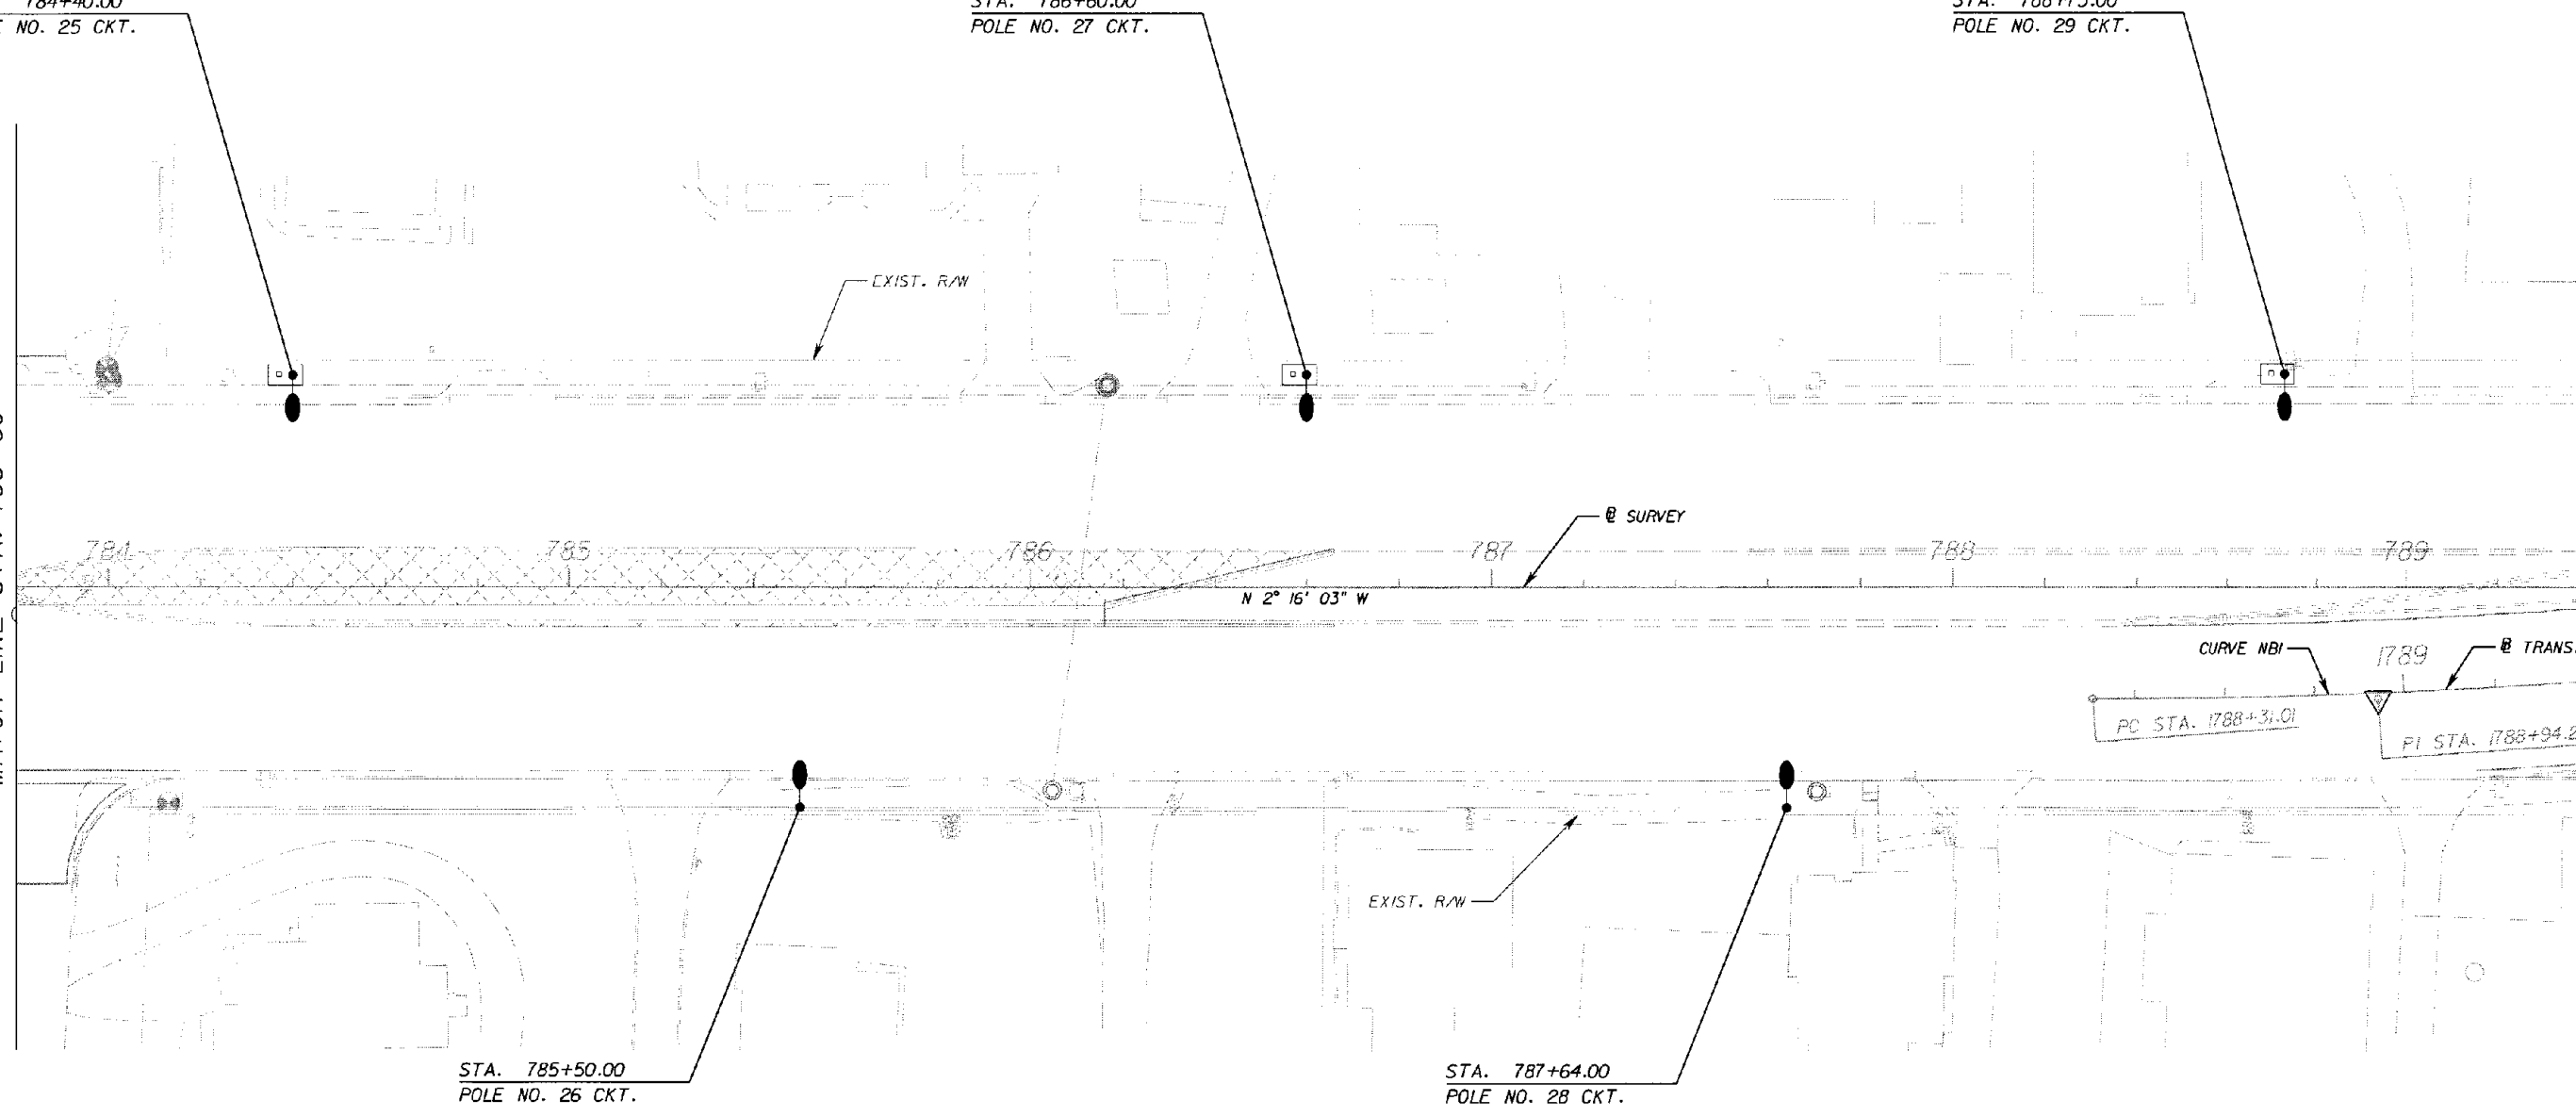

REVISIONS					
DATE	BY	DESCRIPTION	DATE	BY	DESCRIPTION

Fuller, Davis & Associates, Inc.
 5525 W. CYPRESS ST. - SUITE 300
 TAMPA, FLORIDA 33607-1707
 CERTIFICATE OF AUTHORIZATION NO.: 5864
 ERBIE A. GARRETT, P.E. NO.: 45209



STATE OF FLORIDA DEPARTMENT OF TRANSPORTATION		
ROAD NO.	COUNTY	FINANCIAL PROJECT ID
SR 600	POLK	197593-1-52-01

**LIGHTING PLAN
NORTHBOUND**

SHEET NO.
L-13

NOTICE: THE OFFICIAL RECORD OF THIS SHEET IS THE ELECTRONIC FILE SIGNED AND SEALED UNDER RULE 60C5-23.003, F.A.C.

 SR 600

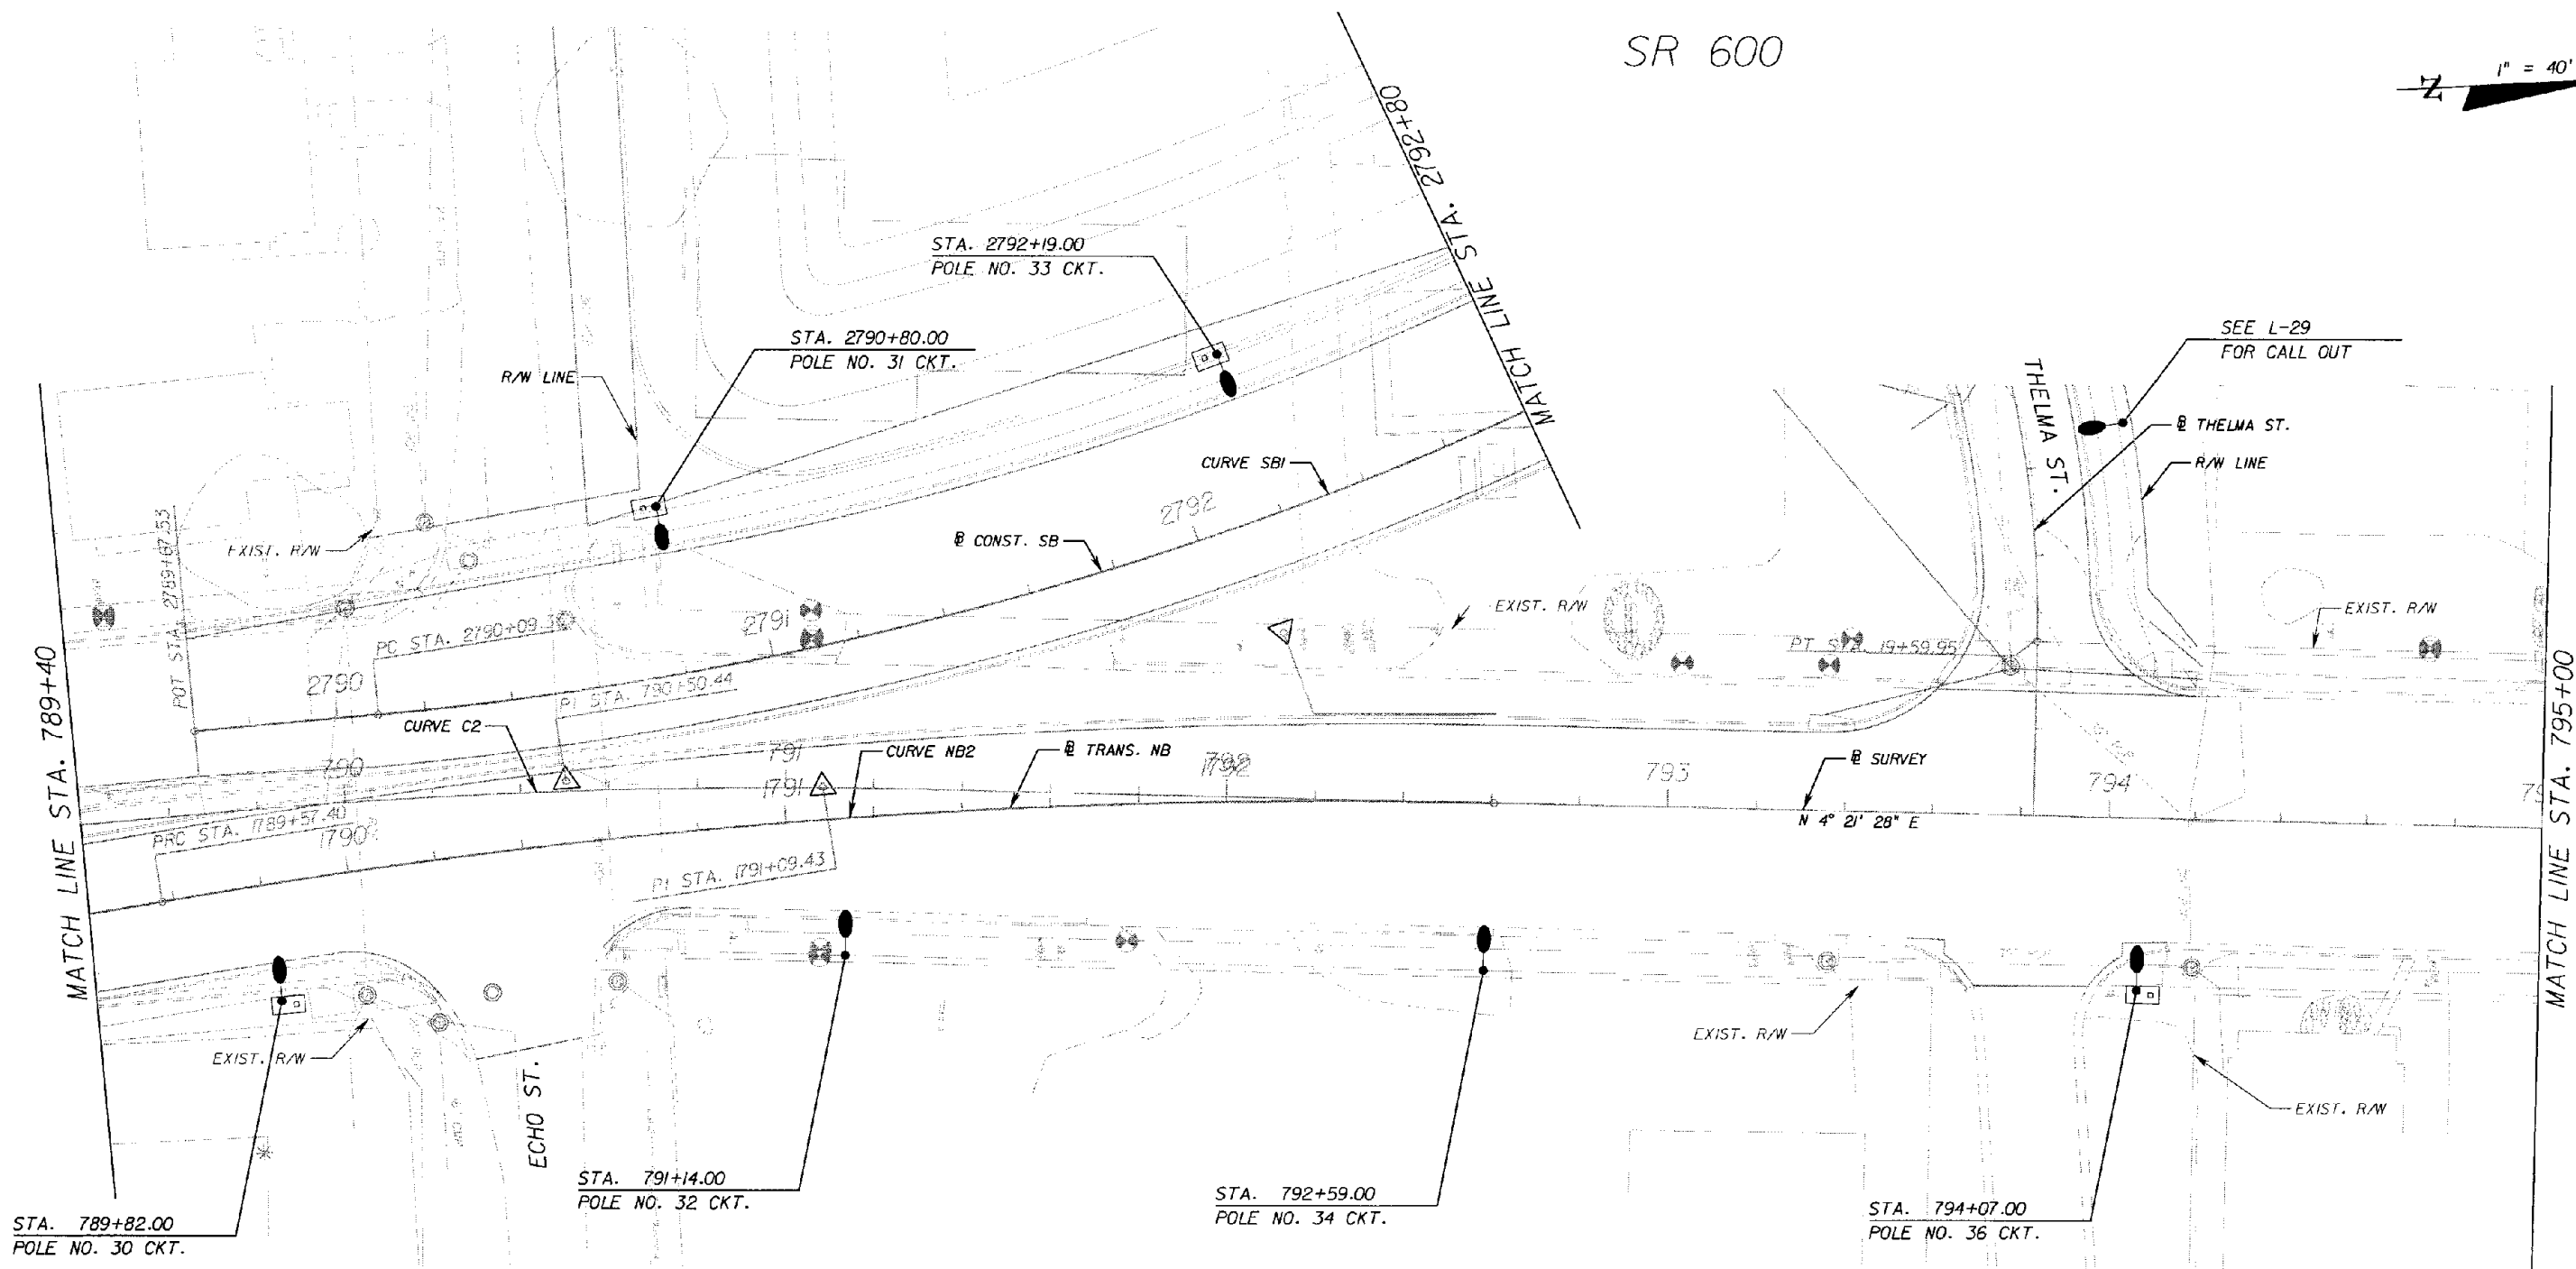

REVISIONS					
DATE	BY	DESCRIPTION	DATE	BY	DESCRIPTION

Faller Davis & Associates, Inc.
 5525 W. CYPRESS ST. - SUITE 300
 TAMPA, FLORIDA 33607-1707
 CERTIFICATE OF AUTHORIZATION NO.: 5864
 ERBIE A. GARRETT, P.E. NO.: 45219

STATE OF FLORIDA DEPARTMENT OF TRANSPORTATION		
ROAD NO.	COUNTY	FINANCIAL PROJECT ID
SR 600	POLK	197593-1-52-01


**LIGHTING PLAN
NORTHBOUND**

SHEET NO.
L-14

NOTICE: THE OFFICIAL RECORD OF THIS SHEET IS THE ELECTRONIC FILE SIGNED AND SEALED UNDER RULE 6615-23.003, F.A.C.

SR 600

1" = 40'

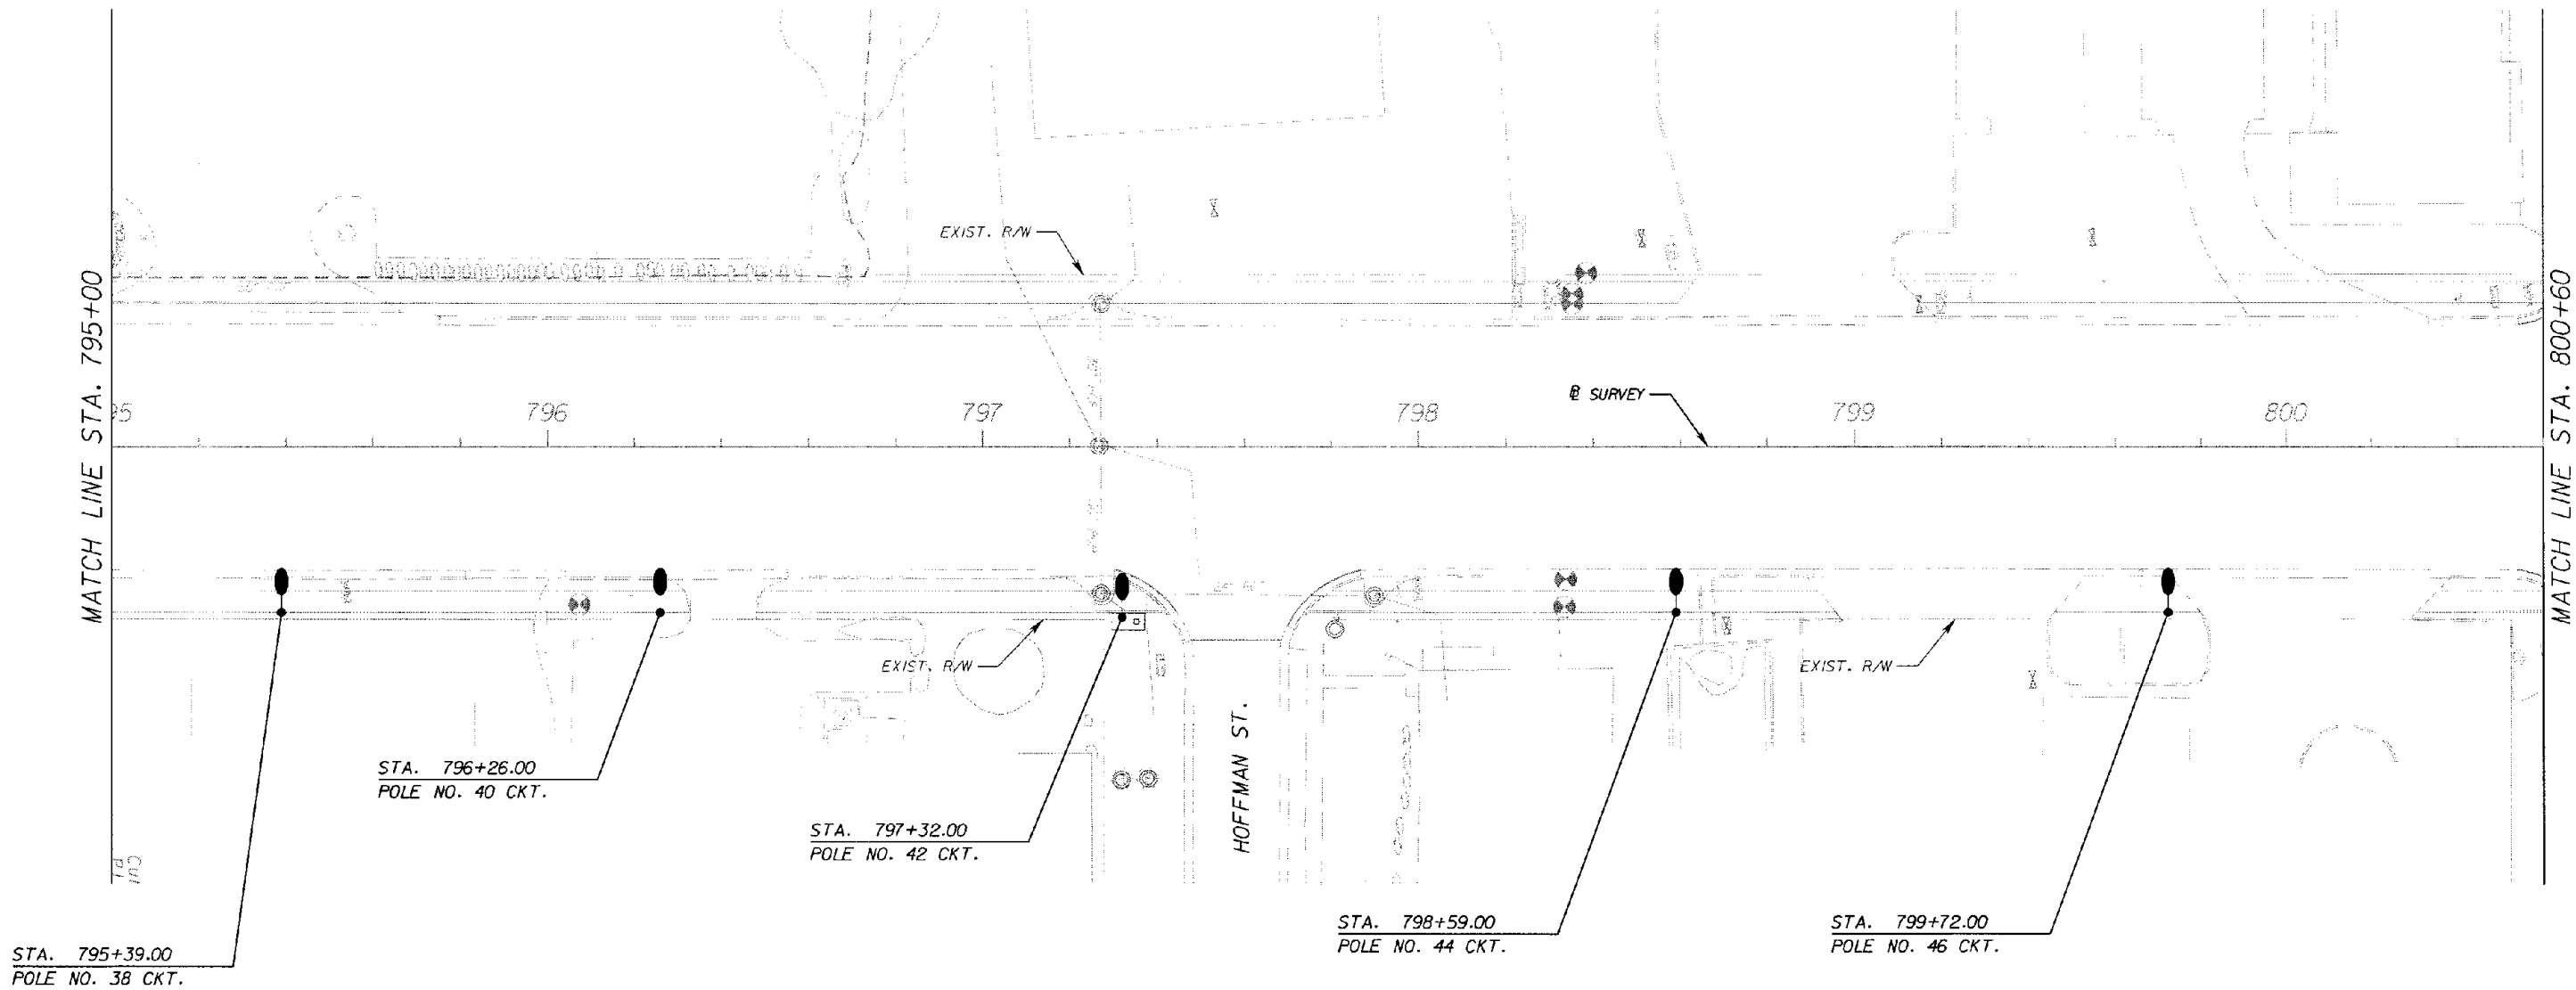

REVISIONS					
DATE	BY	DESCRIPTION	DATE	BY	DESCRIPTION

Faller Davis & Associates, Inc.
 5525 W. CYPRESS ST. - SUITE 300
 TAMPA, FLORIDA 33607-1707
 CERTIFICATE OF AUTHORIZATION NO.: 5864
 ERBIE A. GARRETT, P.E. NO.: 45219


STATE OF FLORIDA DEPARTMENT OF TRANSPORTATION		
ROAD NO.	COUNTY	FINANCIAL PROJECT ID
SR 600	POLK	197593-1-52-01

<p>LIGHTING PLAN NORTHBOUND</p>	<p>SHEET NO. L-15</p>
---	------------------------------------

NOTICE: THE OFFICIAL RECORD OF THIS SHEET IS THE ELECTRONIC FILE SIGNED AND SEALED UNDER RULE 61G15-23.003, F.A.C.

SR 600

1" = 40'

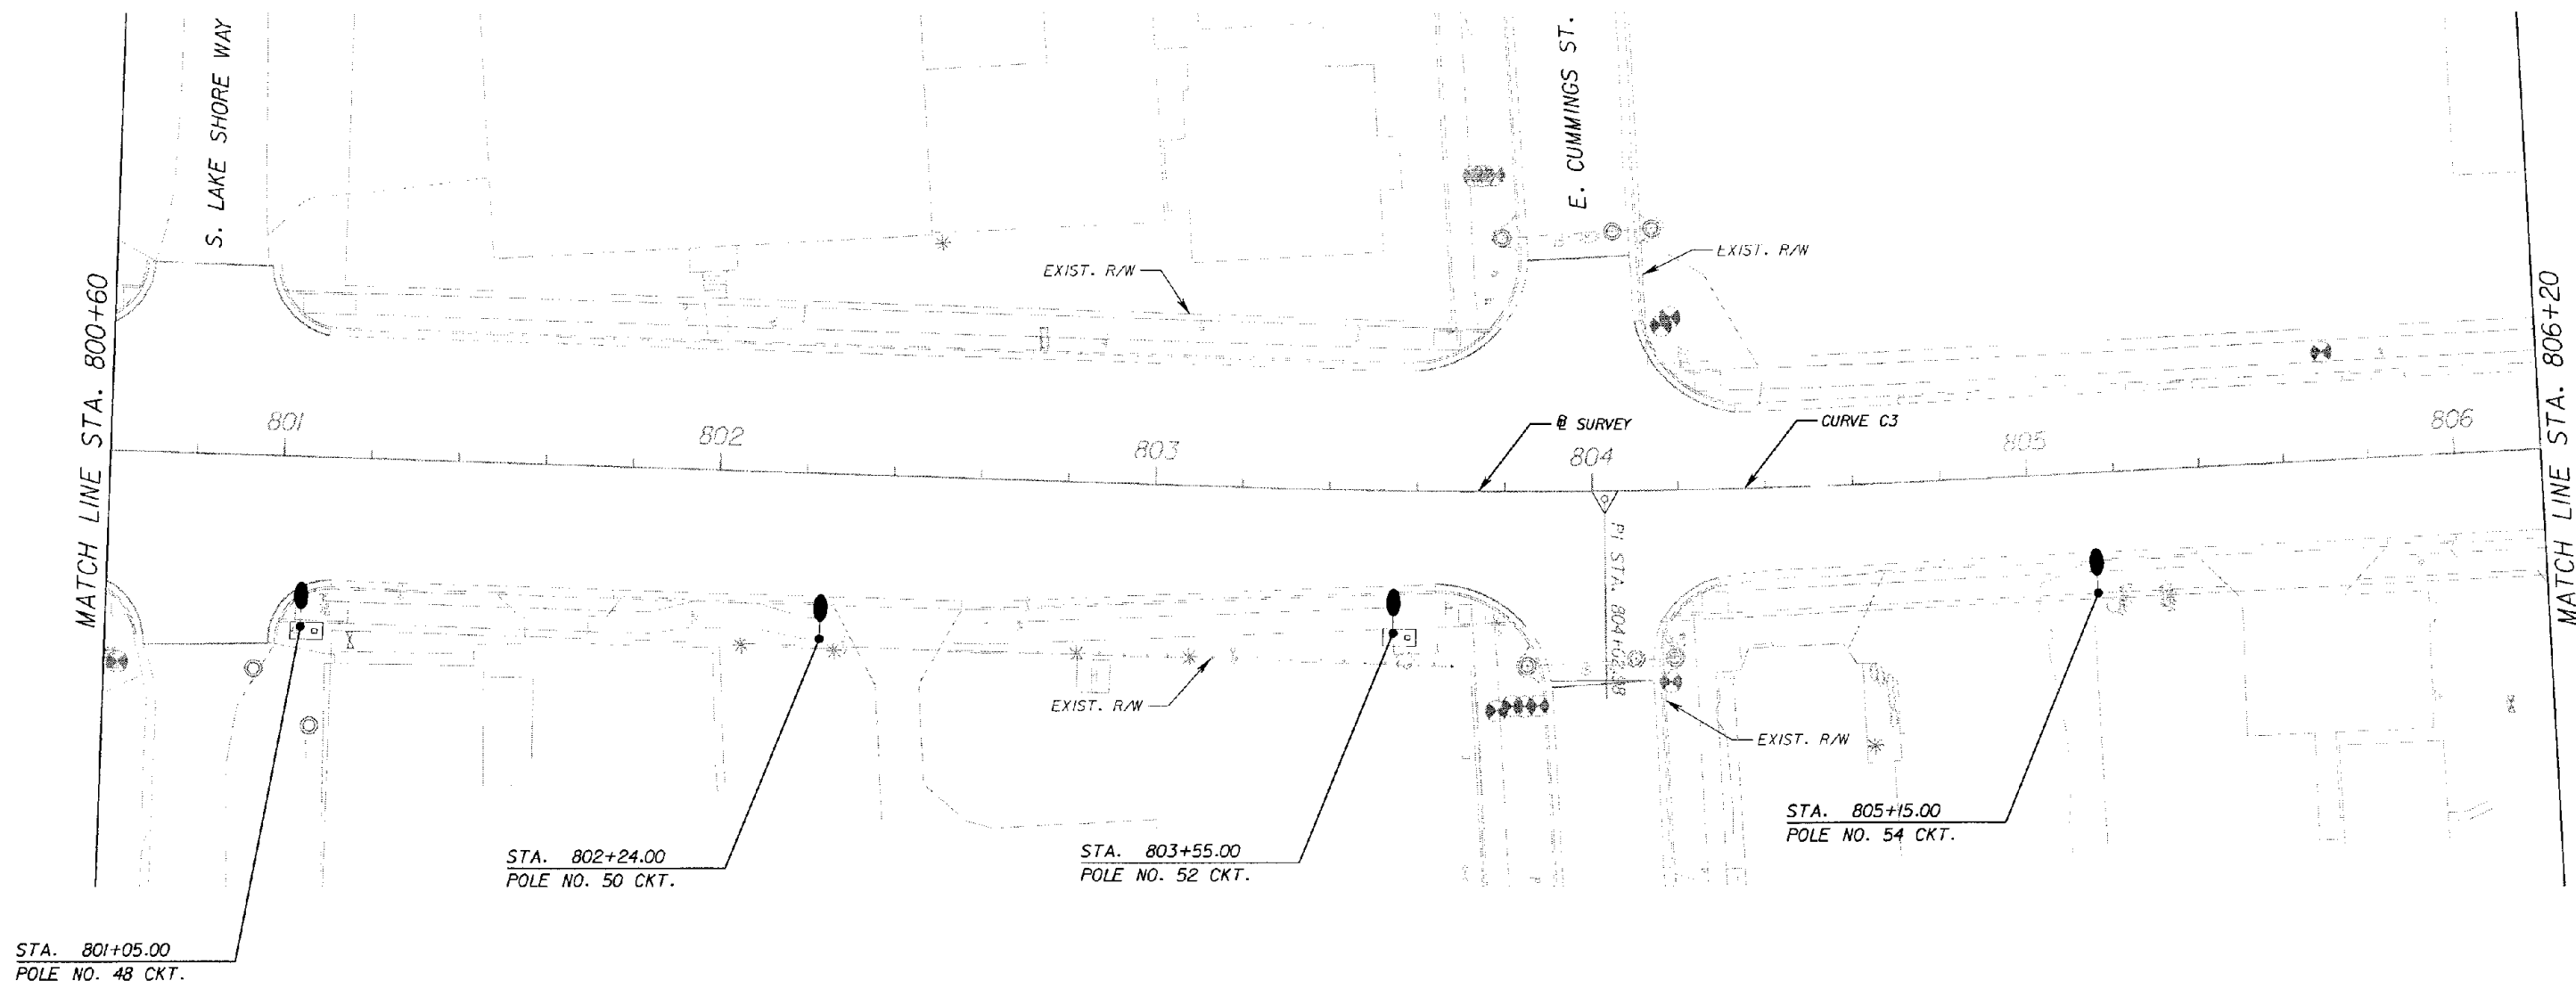

REVISIONS					
DATE	BY	DESCRIPTION	DATE	BY	DESCRIPTION

Faller, Davis & Associates, Inc.
 5525 W. CYPRESS ST. - SUITE 300
 TAMPA, FLORIDA 33607-1707
 CERTIFICATE OF AUTHORIZATION NO.: 5864
 ERBIE A. GARRETT, P.E. NO.: 45219


STATE OF FLORIDA DEPARTMENT OF TRANSPORTATION		
ROAD NO.	COUNTY	FINANCIAL PROJECT ID
SR 600	POLK	197593-1-52-01

**LIGHTING PLAN
NORTHBOUND**

SHEET NO.
L-16

NOTICE: THE OFFICIAL RECORD OF THIS SHEET IS THE ELECTRONIC FILE SIGNED AND SEALED UNDER RULE 68J5 23.003, F.A.C.

SR 600

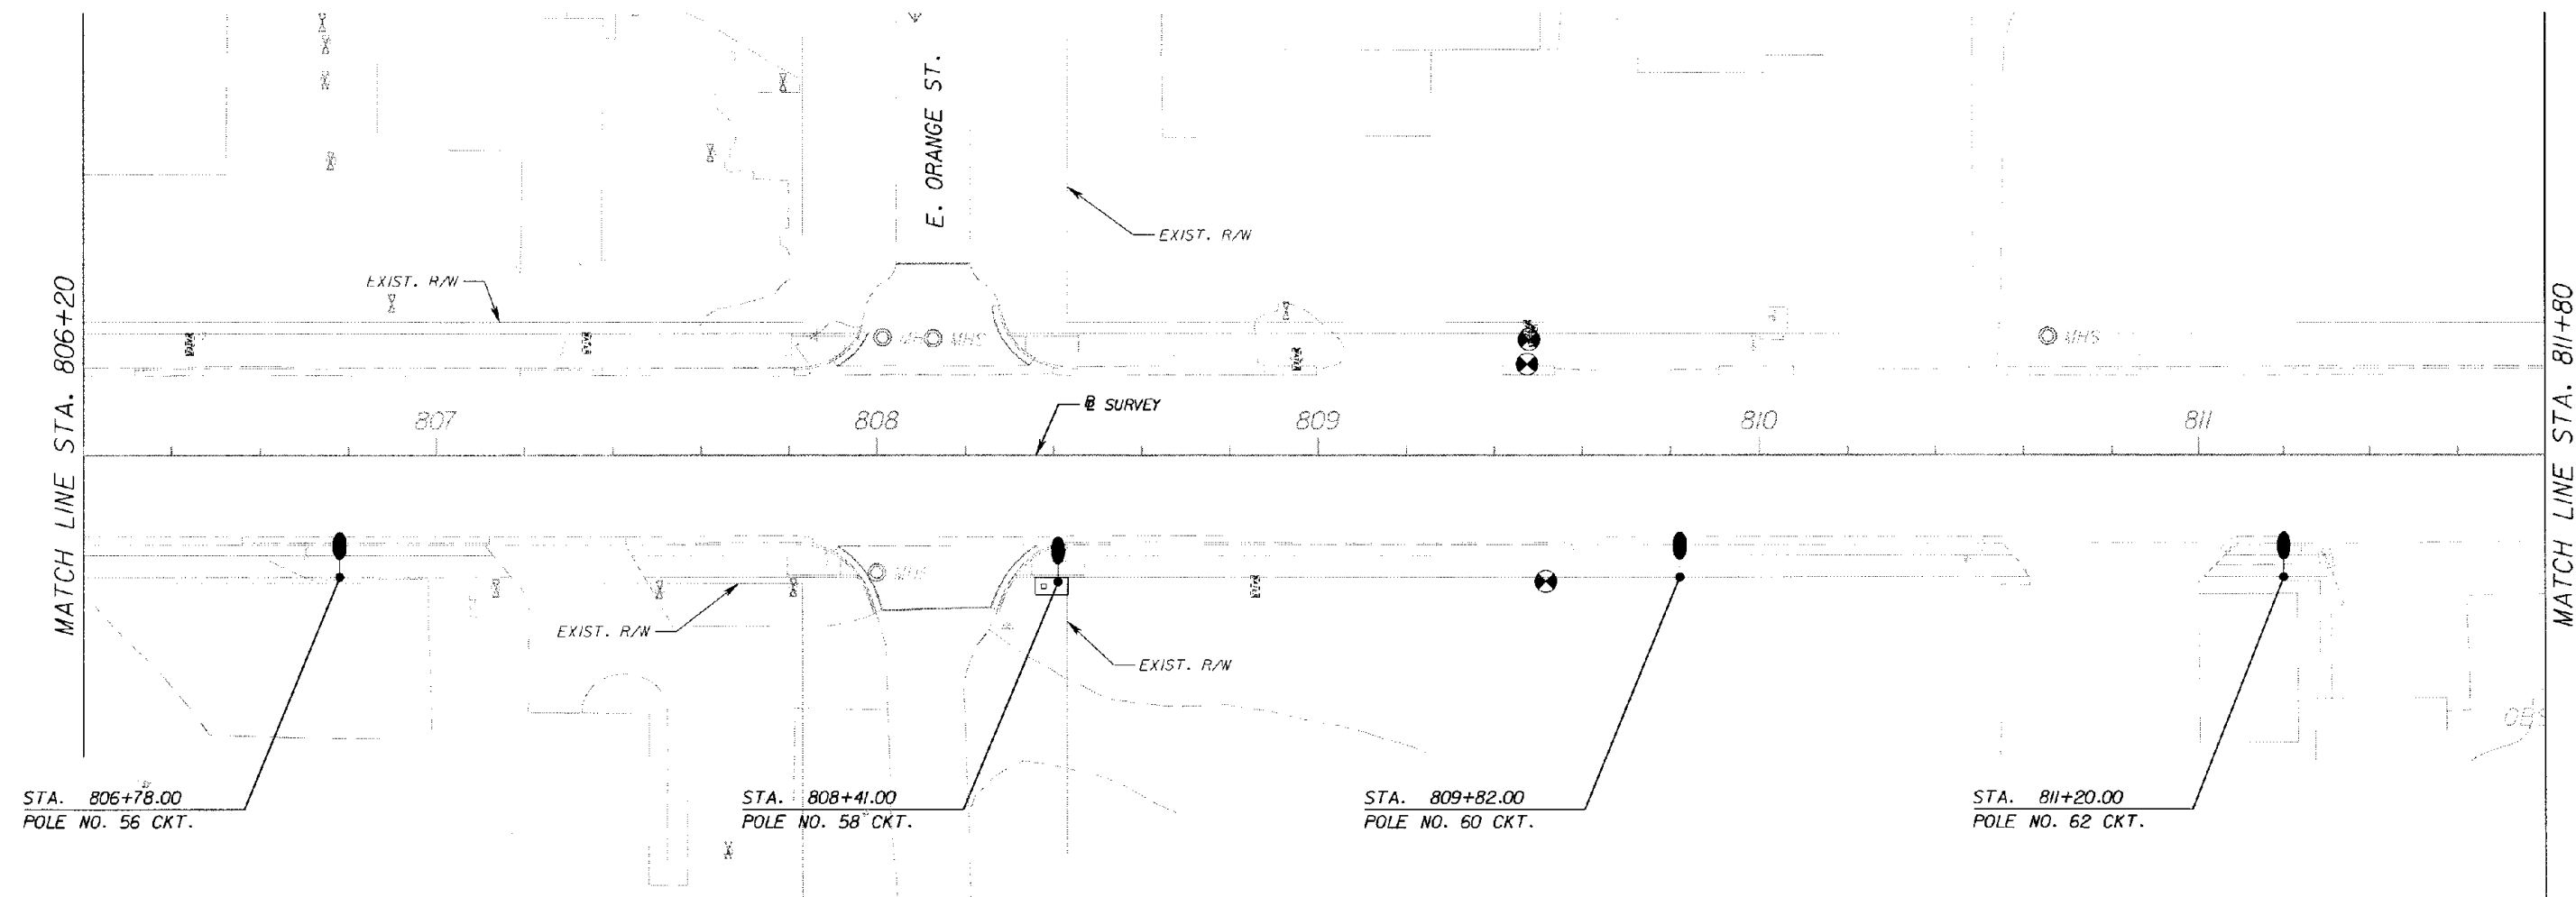

REVISIONS					
DATE	BY	DESCRIPTION	DATE	BY	DESCRIPTION

Fallen Davis & Associates, Inc.
 5525 W. CYPRESS ST. - SUITE 300
 TAMPA, FLORIDA 33607-1707
 CERTIFICATE OF AUTHORIZATION NO.: 5864
 ERBIE A. GARRETT, P.E. NO.: 45219

STATE OF FLORIDA DEPARTMENT OF TRANSPORTATION		
ROAD NO.	COUNTY	FINANCIAL PROJECT ID
SR 600	POLK	197593-1-52-01


**LIGHTING PLAN
NORTHBOUND**

SHEET NO.
L-17

NOTICE: THE OFFICIAL RECORD OF THIS SHEET IS THE ELECTRONIC FILE SIGNED AND SEALED UNDER RULE 61G5-23.003, F.A.C.

SR 600

1" = 40'

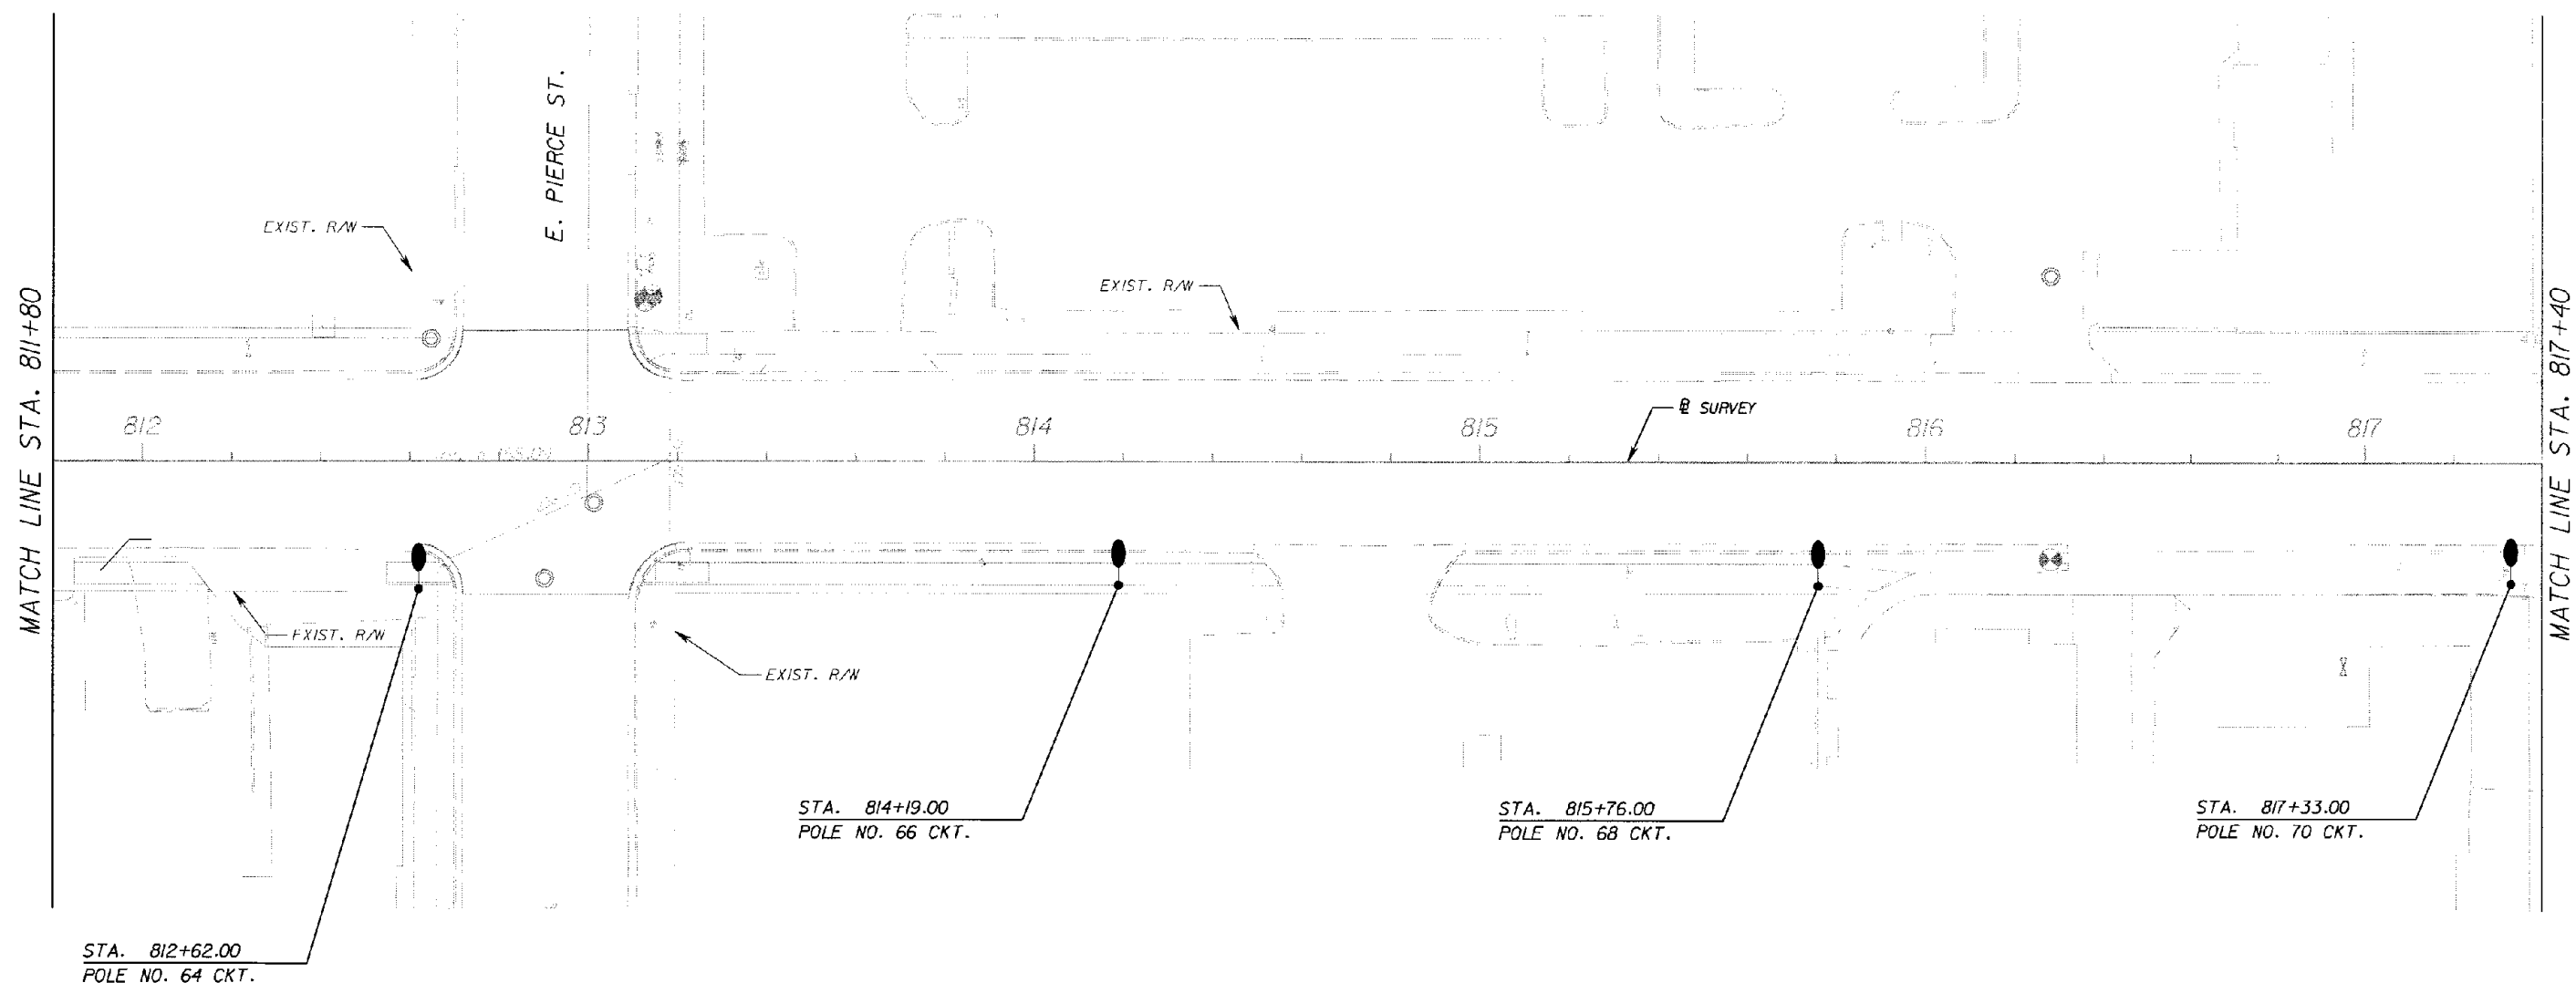

REVISIONS					
DATE	BY	DESCRIPTION	DATE	BY	DESCRIPTION

Faller, Davis & Associates, Inc.
 5525 W. CYPRESS ST. - SUITE 300
 TAMPA, FLORIDA 33607-1707
 CERTIFICATE OF AUTHORIZATION NO.: 5864
 ERBIE A. GARRETT, P.E. NO.: 45219

STATE OF FLORIDA DEPARTMENT OF TRANSPORTATION		
ROAD NO.	COUNTY	FINANCIAL PROJECT ID
SR 600	POLK	197593-1-52-01


**LIGHTING PLAN
NORTHBOUND**

SHEET NO.
L-18

NOTICE: THE OFFICIAL RECORD OF THIS SHEET IS THE ELECTRONIC FILE SIGNED AND SEALED UNDER RULE 68G5-23.003, F.A.C.

SR 600

1" = 40'

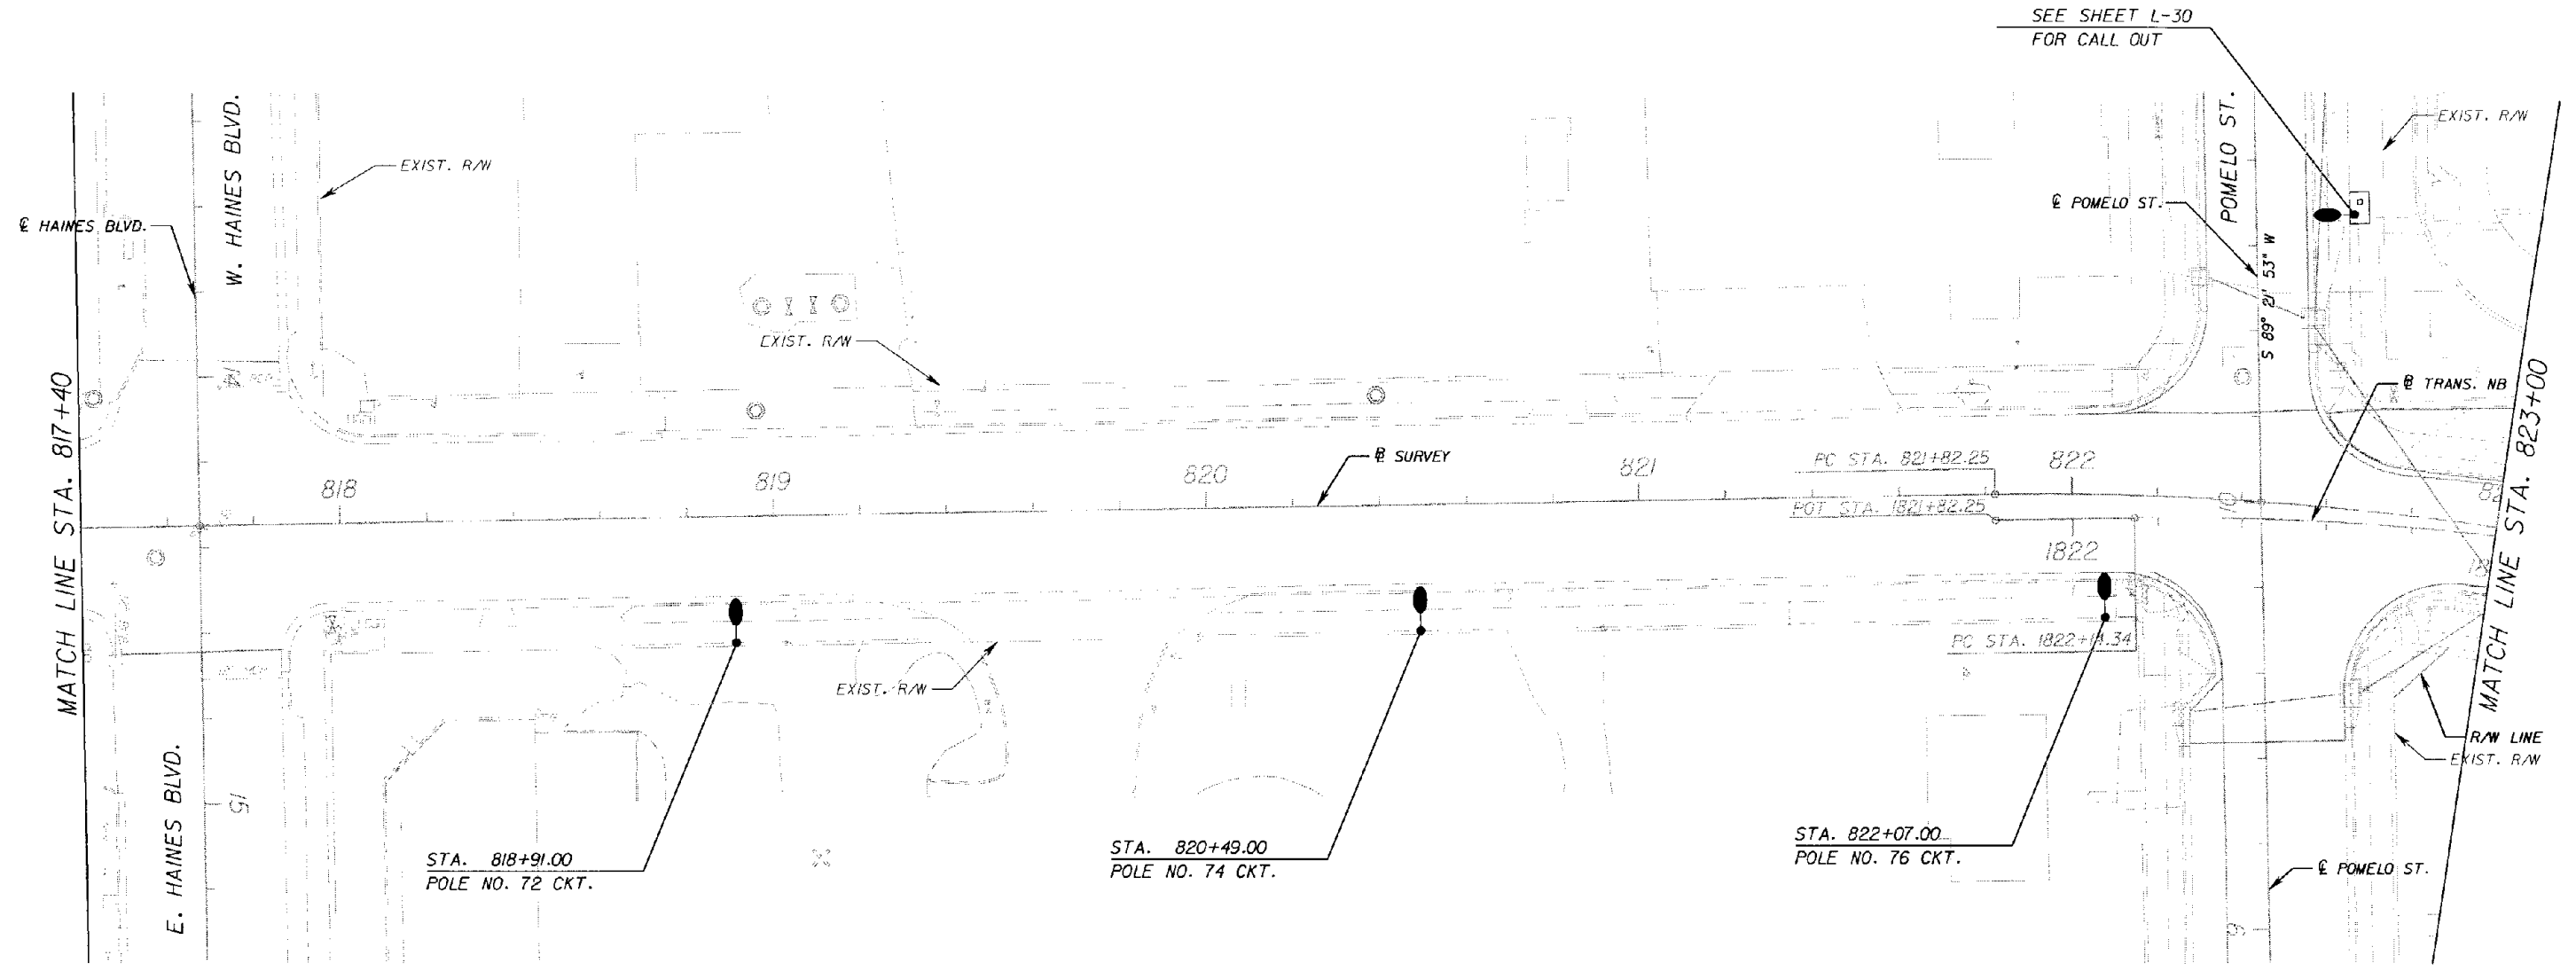

REVISIONS					
DATE	BY	DESCRIPTION	DATE	BY	DESCRIPTION

Faller, Davis & Associates, Inc.
 5525 W. CYPRESS ST. - SUITE 300
 TAMPA, FLORIDA 33607-1707
 CERTIFICATE OF AUTHORIZATION NO.: 5864
 ERBIE A. GARRETT, P.E. NO.: 45219



STATE OF FLORIDA DEPARTMENT OF TRANSPORTATION		
ROAD NO.	COUNTY	FINANCIAL PROJECT ID
SR 600	POLK	197593 1 52-01

**LIGHTING PLAN
NORTHBOUND**

SHEET NO.
L-19

NOTICE: THE OFFICIAL RECORD OF THIS SHEET IS THE ELECTRONIC FILE SIGNED AND SEALED UNDER RULE 68G15-23.003, F.A.C.

SR 600

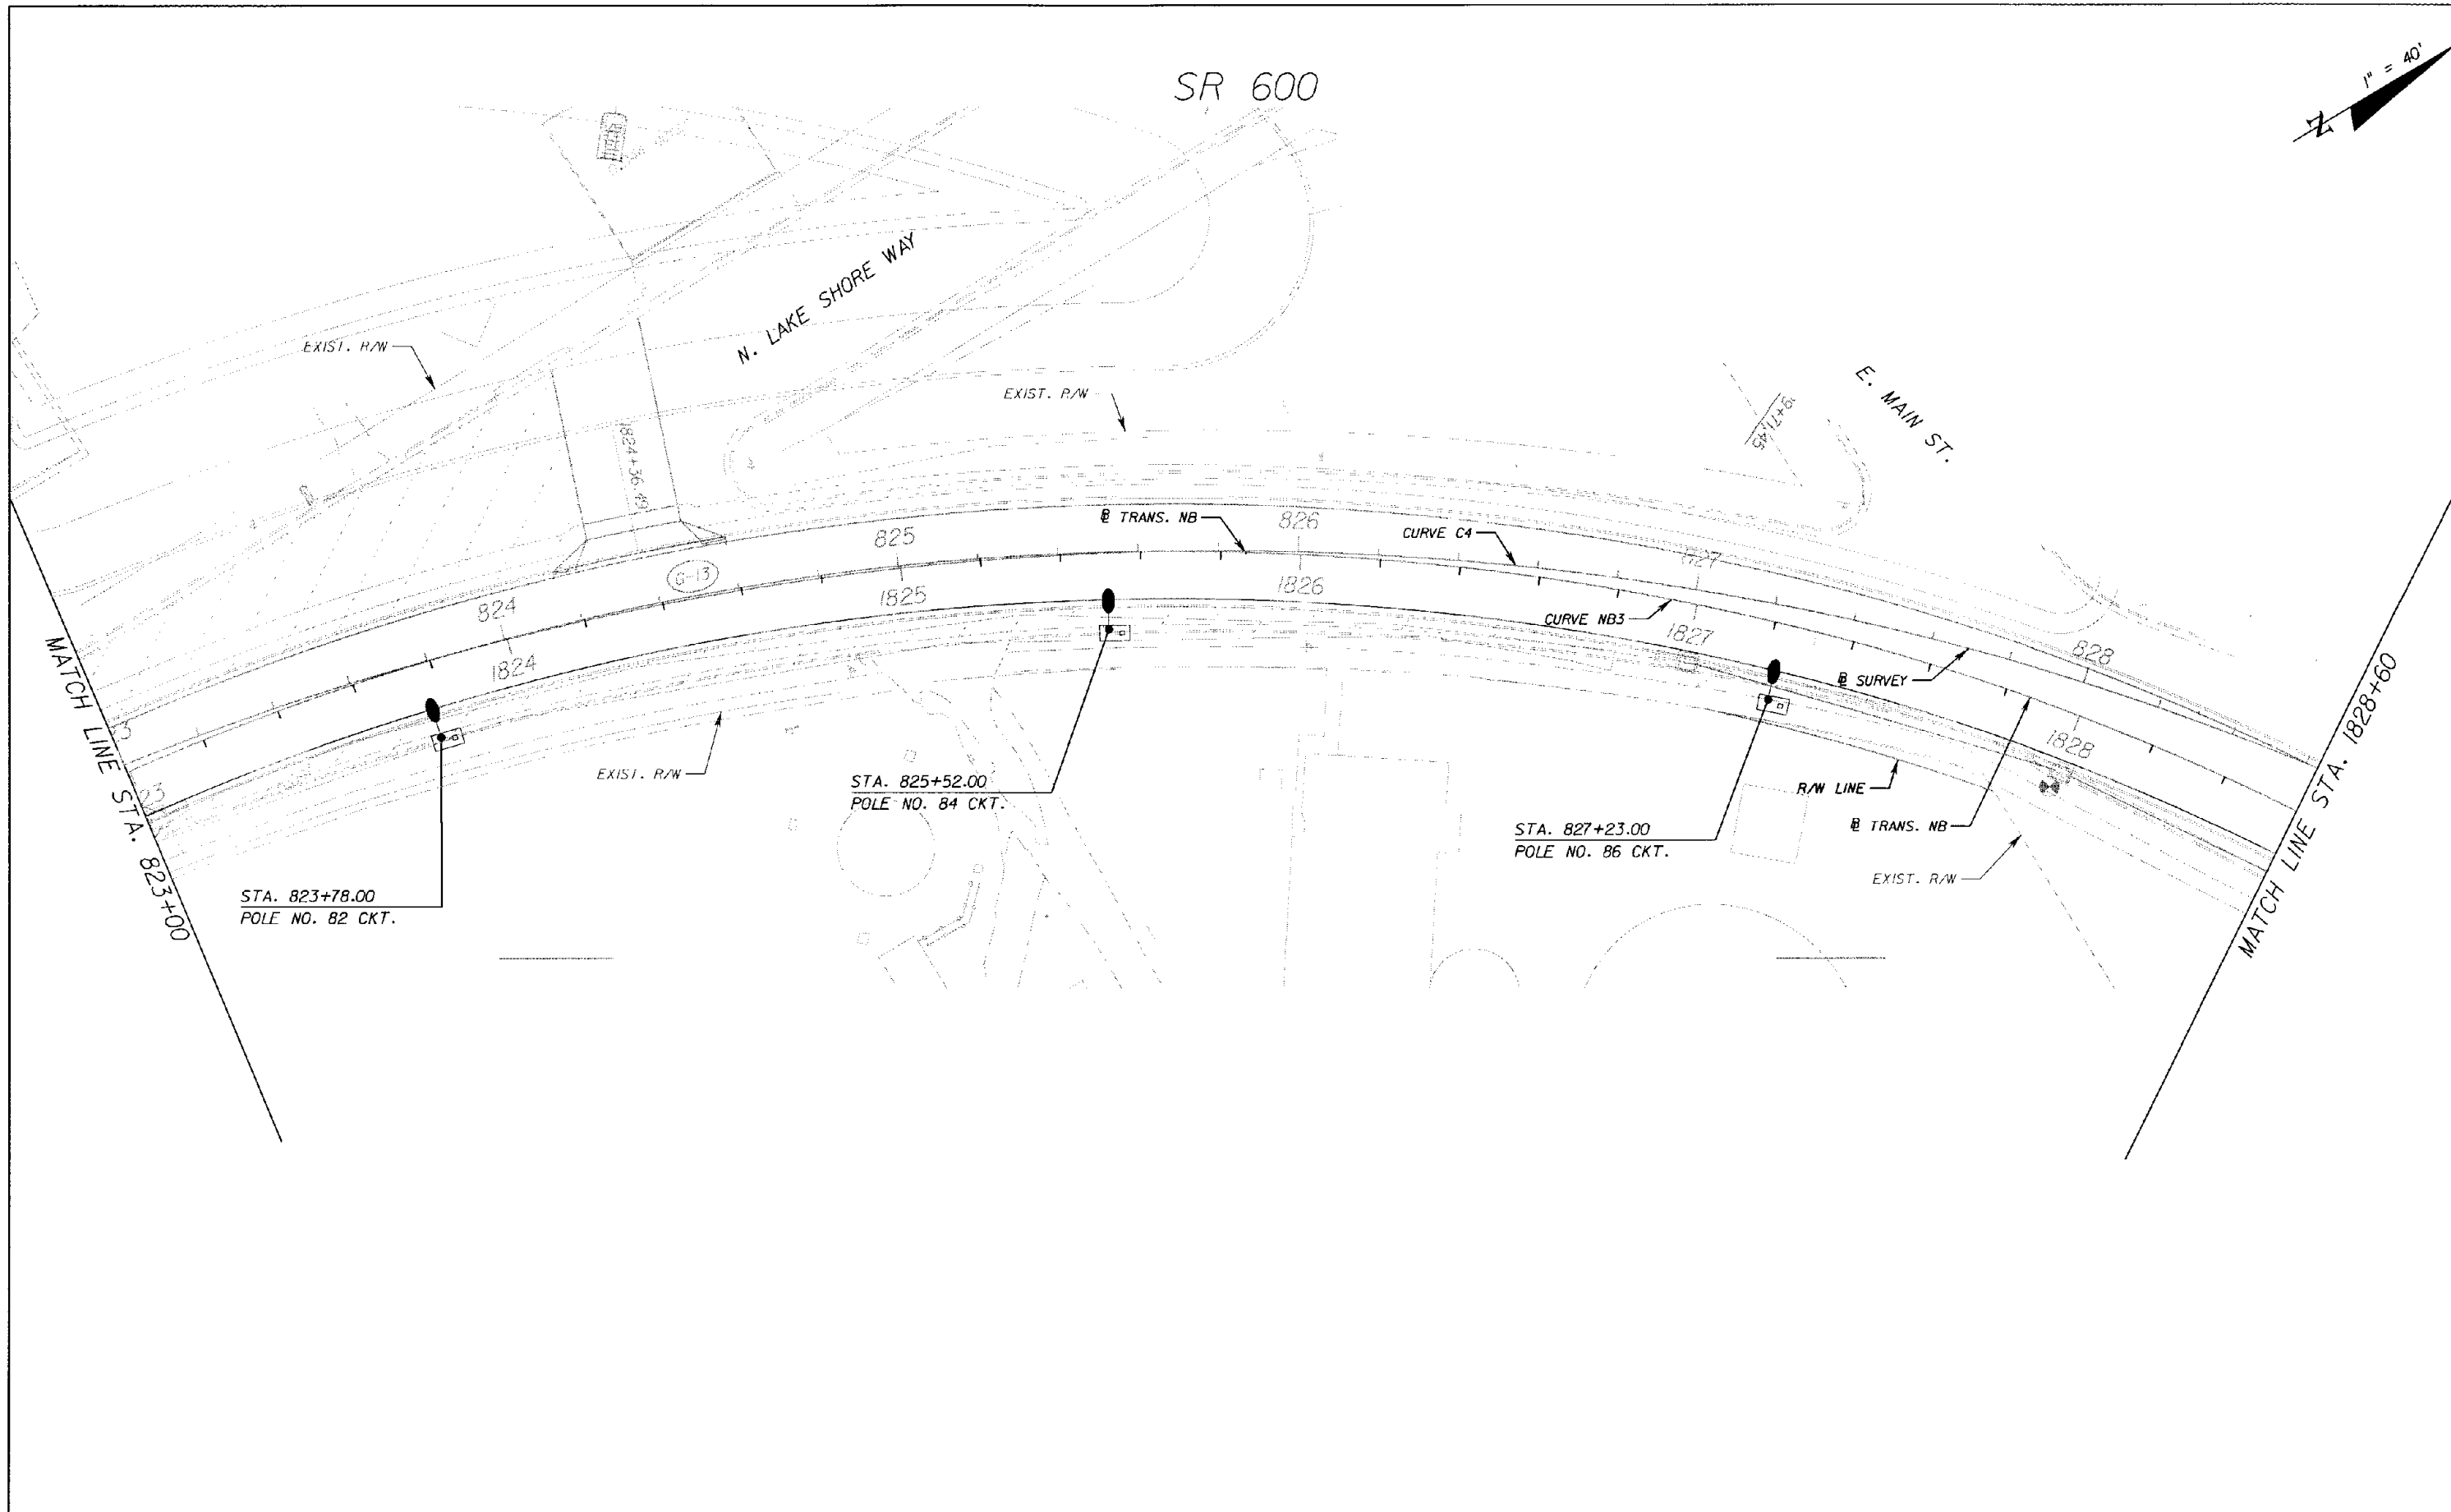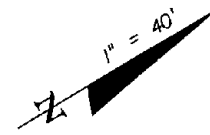

REVISIONS					
DATE	BY	DESCRIPTION	DATE	BY	DESCRIPTION

Faller, Davis & Associates, Inc.
 5525 W. CYPRESS ST. - SUITE 300
 TAMPA, FLORIDA 33607-1707
 CERTIFICATE OF AUTHORIZATION NO.: 5864
 ERBIE A. GARRETT, P.E. NO.: 45219


STATE OF FLORIDA DEPARTMENT OF TRANSPORTATION		
ROAD NO.	COUNTY	FINANCIAL PROJECT ID
SR 600	POLK	197593-1-52-01

**LIGHTING PLAN
NORTHBOUND**


SHEET NO.
L-20

NOTICE: THE OFFICIAL RECORD OF THIS SHEET IS THE ELECTRONIC FILE SIGNED AND SEALED UNDER RULE 66G5-23.003, F.A.C.

SR 600 (E. ALFRED ST.)

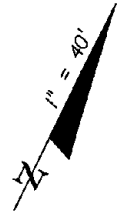

END LIGHTING
STA. 832+10.00 @ SR 600

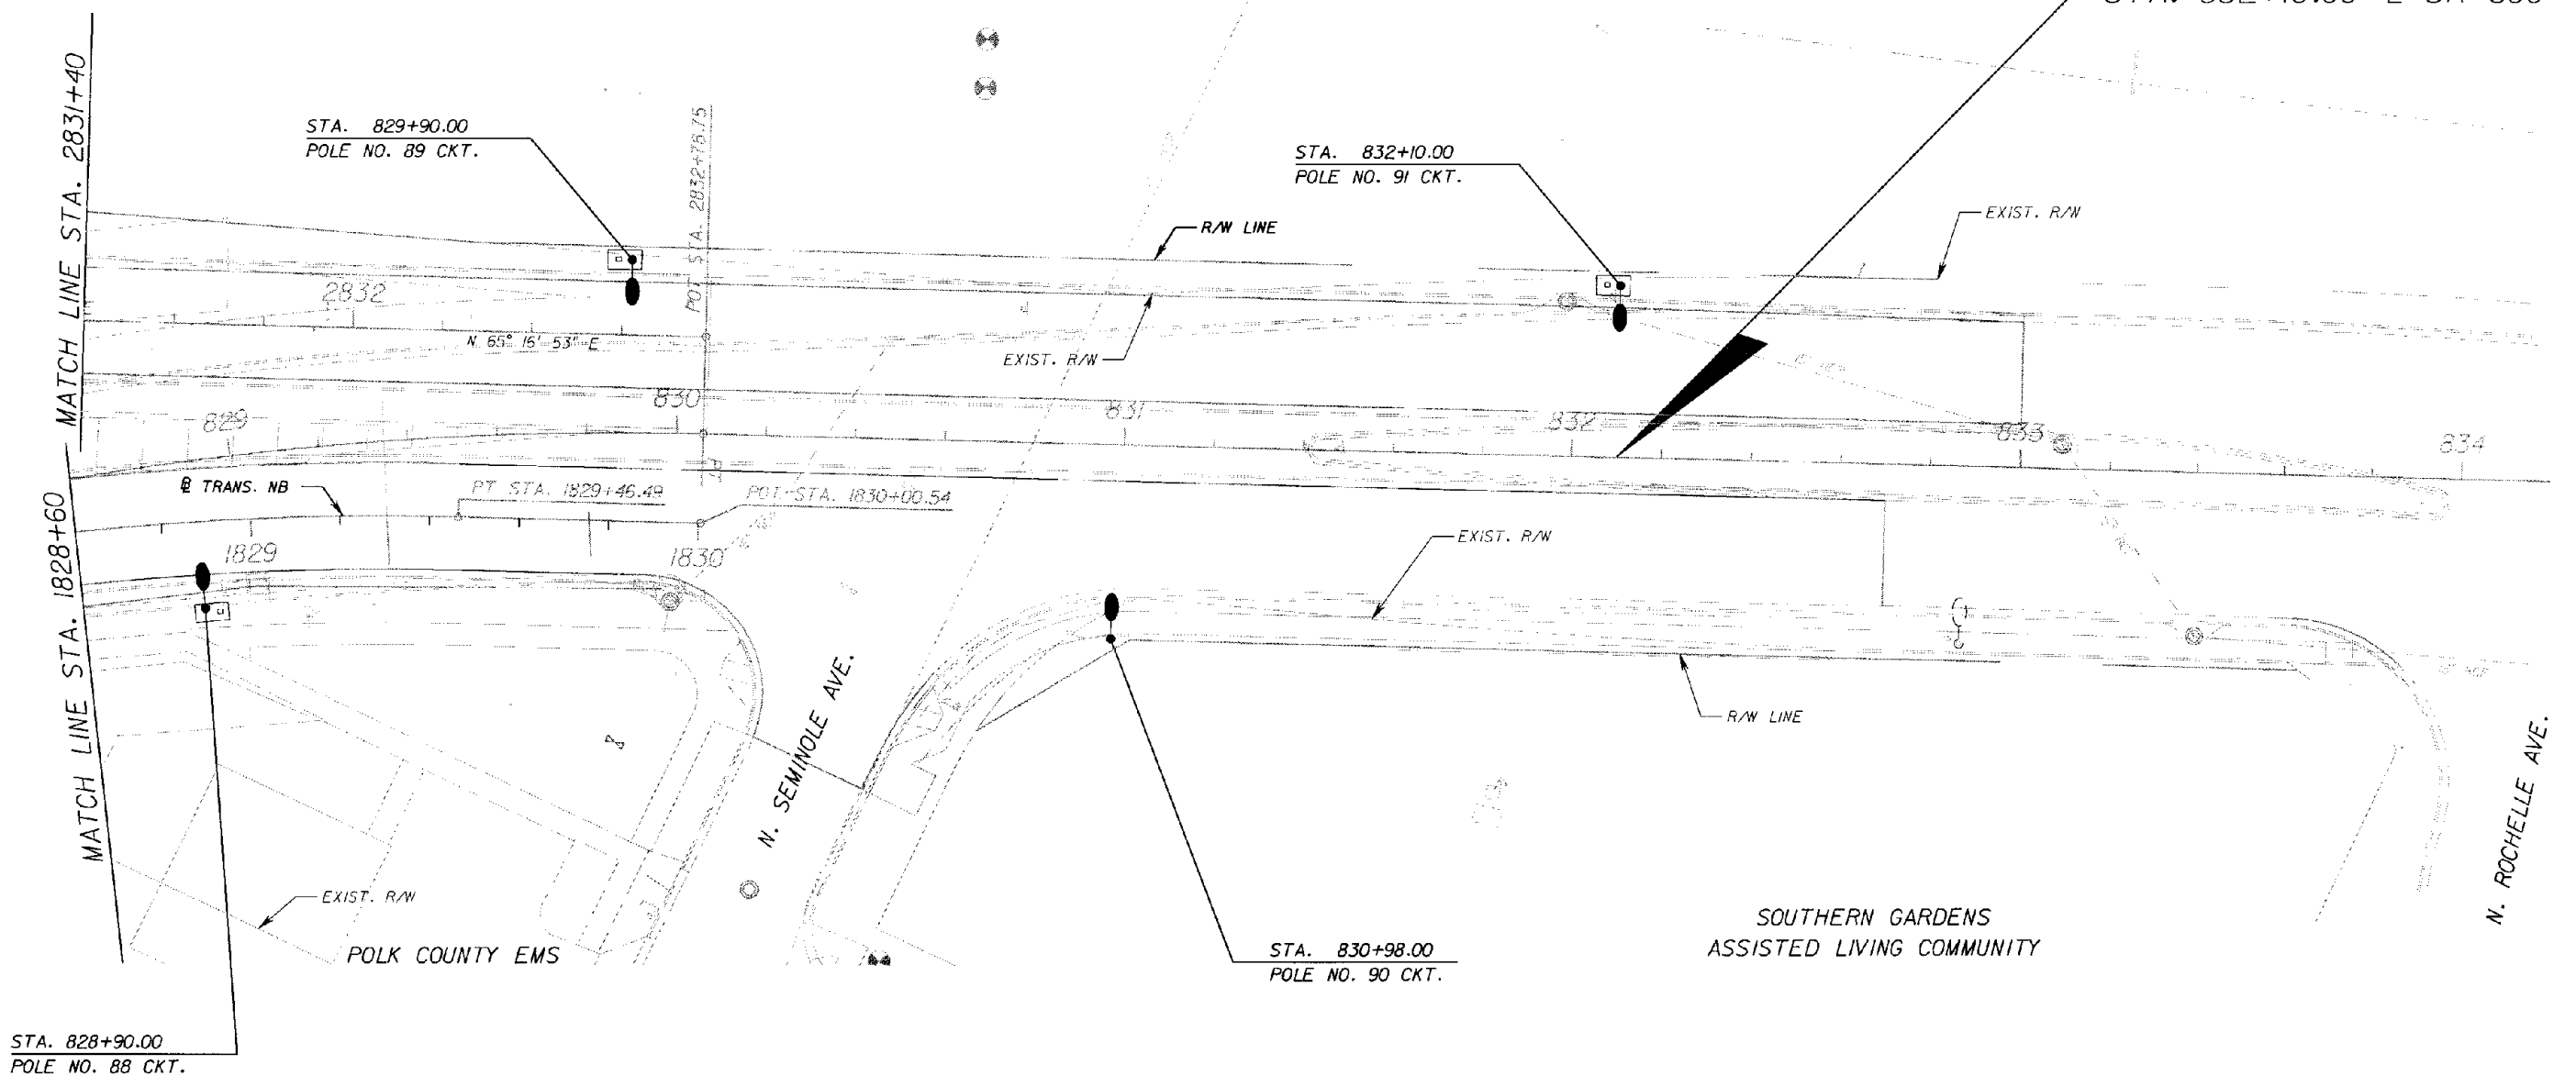

REVISIONS					
DATE	BY	DESCRIPTION	DATE	BY	DESCRIPTION

Faller Davis & Associates, Inc.
 5525 W. CYPRESS ST. - SUITE 300
 TAMPA, FLORIDA 33607-1707
 CERTIFICATE OF AUTHORIZATION NO.: 5864
 ERBIE A. GARRETT, P.E. NO.: 45219


STATE OF FLORIDA DEPARTMENT OF TRANSPORTATION		
ROAD NO.	COUNTY	FINANCIAL PROJECT ID
SR 600	POLK	197593-1-52-01

**LIGHTING PLAN
NORTHBOUND**

SHEET NO.
L-21

NOTICE: THE OFFICIAL RECORD OF THIS SHEET IS THE ELECTRONIC FILE SIGNED AND SEALED UNDER RULE 61G05-23.003, F.A.C.

SR 600

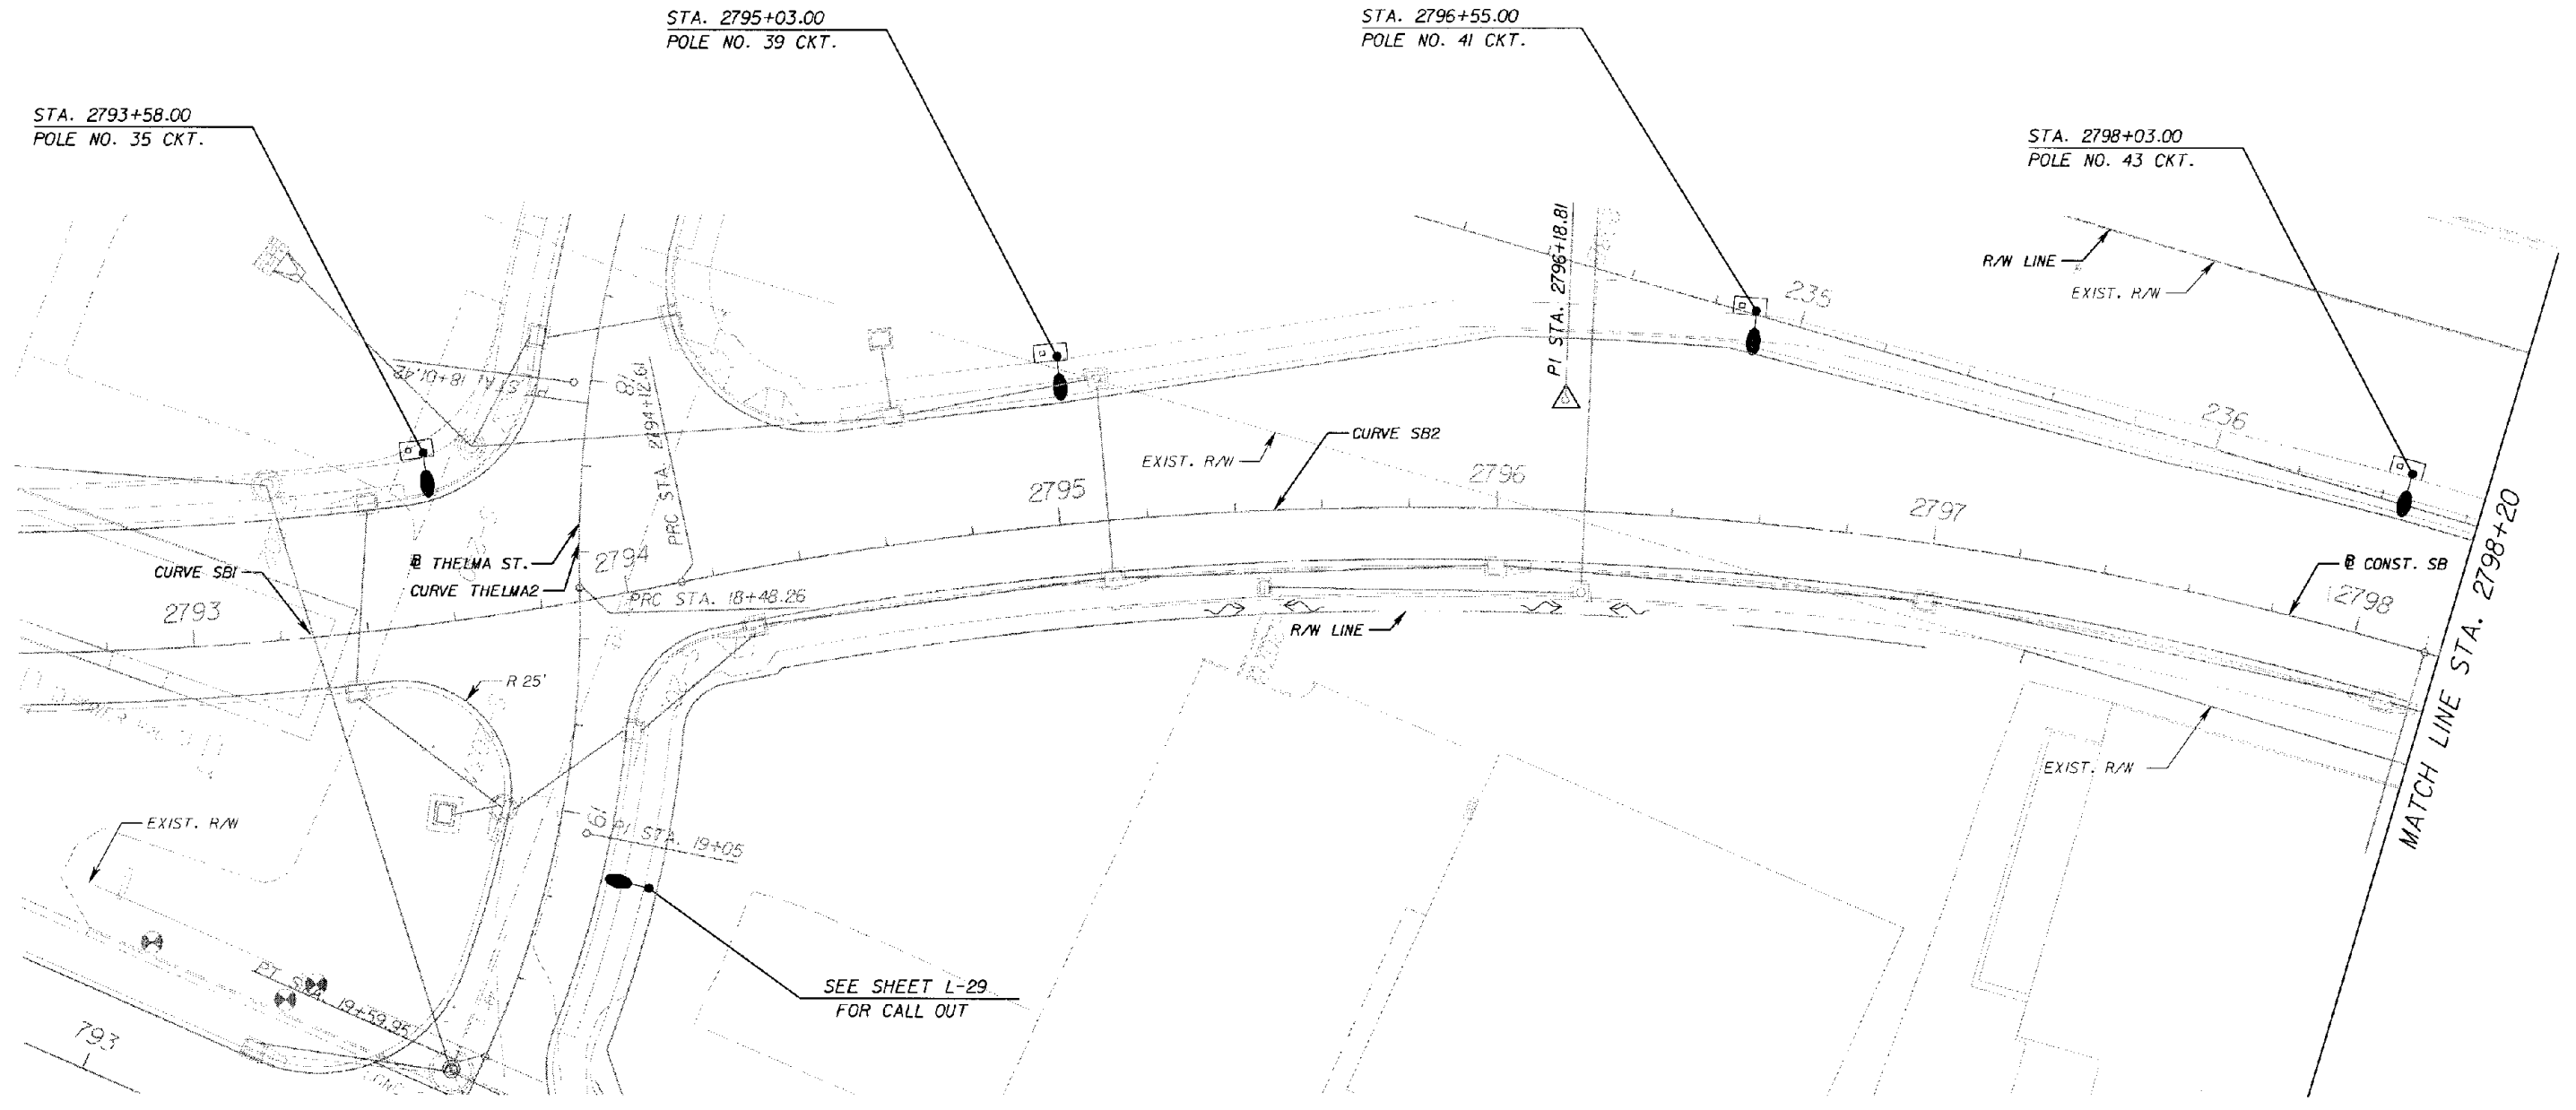

REVISIONS					
DATE	BY	DESCRIPTION	DATE	BY	DESCRIPTION

Faller, Davis & Associates, Inc.
 5525 W. CYPRESS ST. - SUITE 300
 TAMPA, FLORIDA 33607-1707
 CERTIFICATE OF AUTHORIZATION NO.: 5864
 ERBIE A. GARRETT, P.E. NO.: 45219

STATE OF FLORIDA DEPARTMENT OF TRANSPORTATION		
ROAD NO.	COUNTY	FINANCIAL PROJECT ID
SR 600	POIK	197593-1-52-01


**LIGHTING PLAN
SOUTHBOUND**

SHEET NO.
L-22

NOTICE: THE OFFICIAL RECORD OF THIS SHEET IS THE ELECTRONIC FILE SIGNED AND SEALED UNDER RULE 6615-23.003, F.A.C.

SR 600

1" = 40'

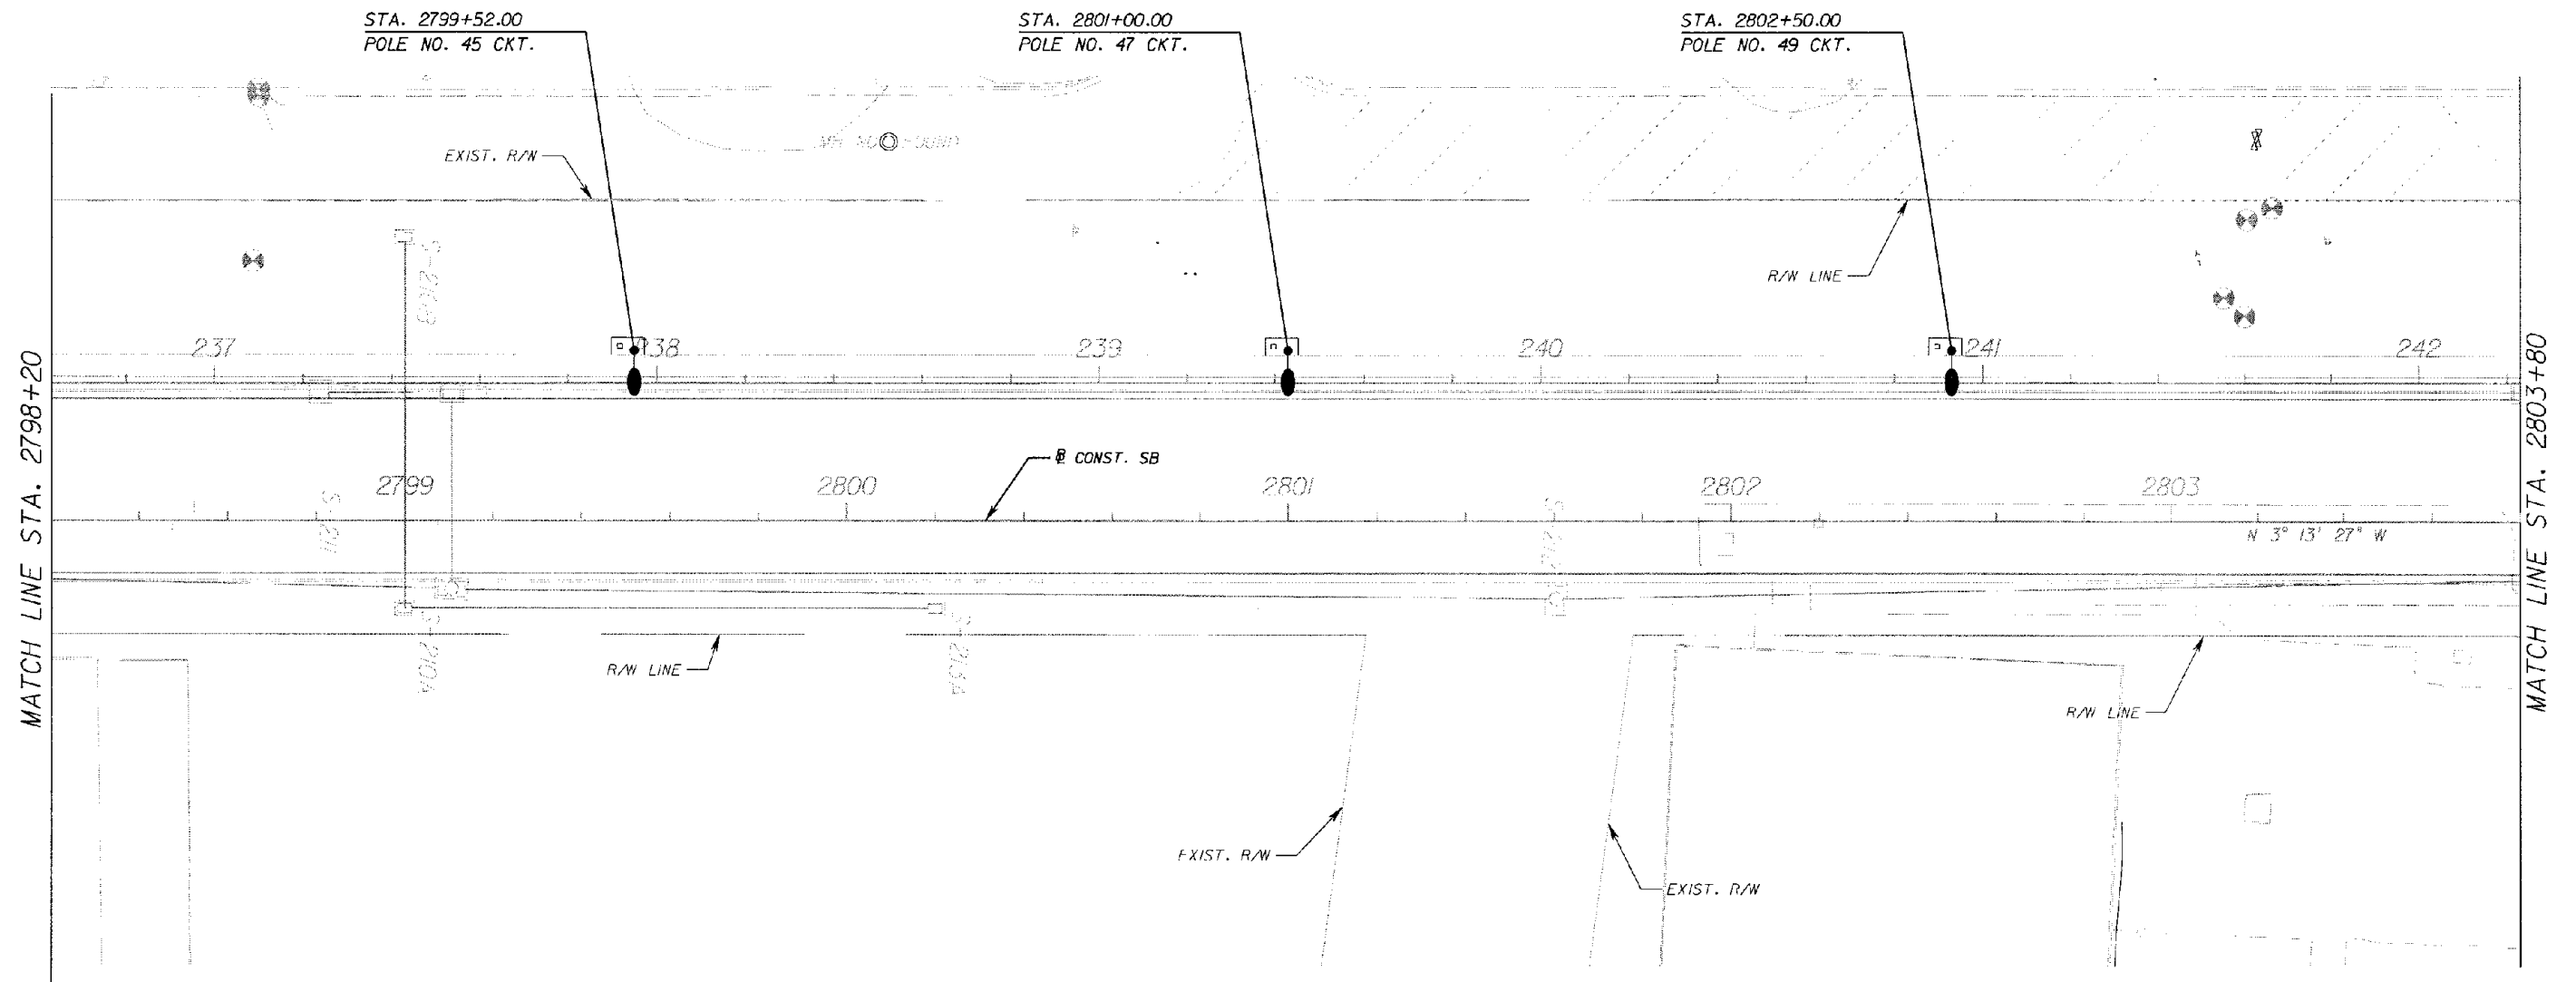

REVISIONS					
DATE	BY	DESCRIPTION	DATE	BY	DESCRIPTION

Faller, Davis & Associates, Inc.
 5525 W. CYPRESS ST. - SUITE 300
 TAMPA, FLORIDA 33607-1707
 CERTIFICATE OF AUTHORIZATION NO.: 5864
 ERBIE A. GARRETT, P.E. NO.: 4529

STATE OF FLORIDA DEPARTMENT OF TRANSPORTATION		
ROAD NO.	COUNTY	FINANCIAL PROJECT ID
SR 600	POLK	197593-1-52-01


LIGHTING PLAN
SOUTHBOUND

SHEET NO.
 L-23

NOTICE: THE OFFICIAL RECORD OF THIS SHEET IS THE ELECTRONIC FILE SIGNED AND SEALED UNDER RULE 61G15-23.003, F.A.C.

SR 600

1" = 40'

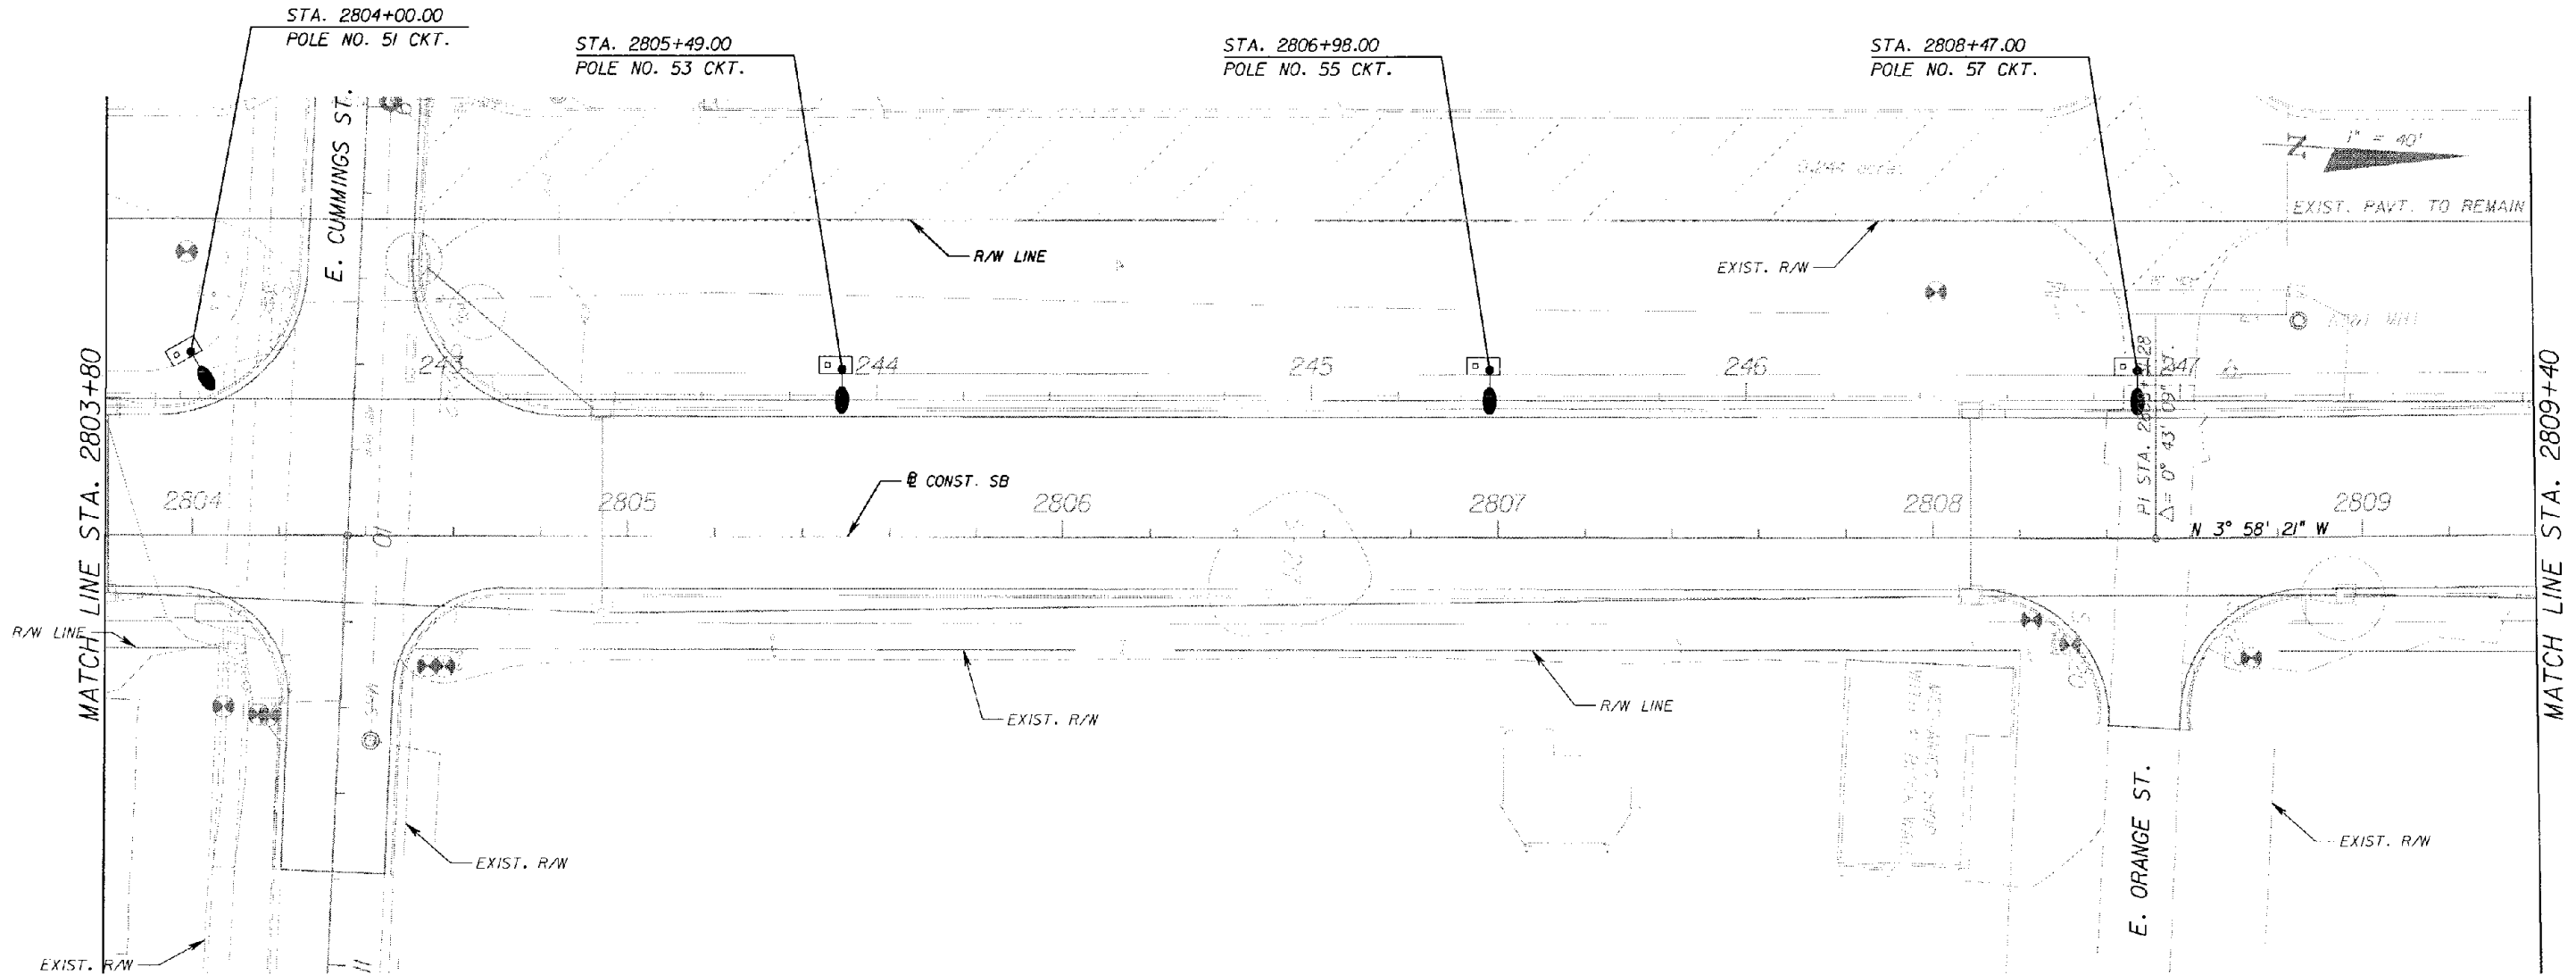

REVISIONS					
DATE	BY	DESCRIPTION	DATE	BY	DESCRIPTION

Faller, Davis & Associates, Inc.
 5525 W. CYPRESS ST. - SUITE 300
 TAMPA, FLORIDA 33607-1707
 CERTIFICATE OF AUTHORIZATION NO.: 5864
 ERBIE A. GARRETT, P.E. NO.: 45219

STATE OF FLORIDA DEPARTMENT OF TRANSPORTATION		
ROAD NO.	COUNTY	FINANCIAL PROJECT ID
SR 600	POLK	197593-1-52-01


**LIGHTING PLAN
SOUTHBOUND**

SHEET NO.
L-24

NOTICE: THE OFFICIAL RECORD OF THIS SHEET IS THE ELECTRONIC FILE SIGNED AND SEALED UNDER RULE 61G5-23.003, F.A.C.

SR 600

1" = 40'

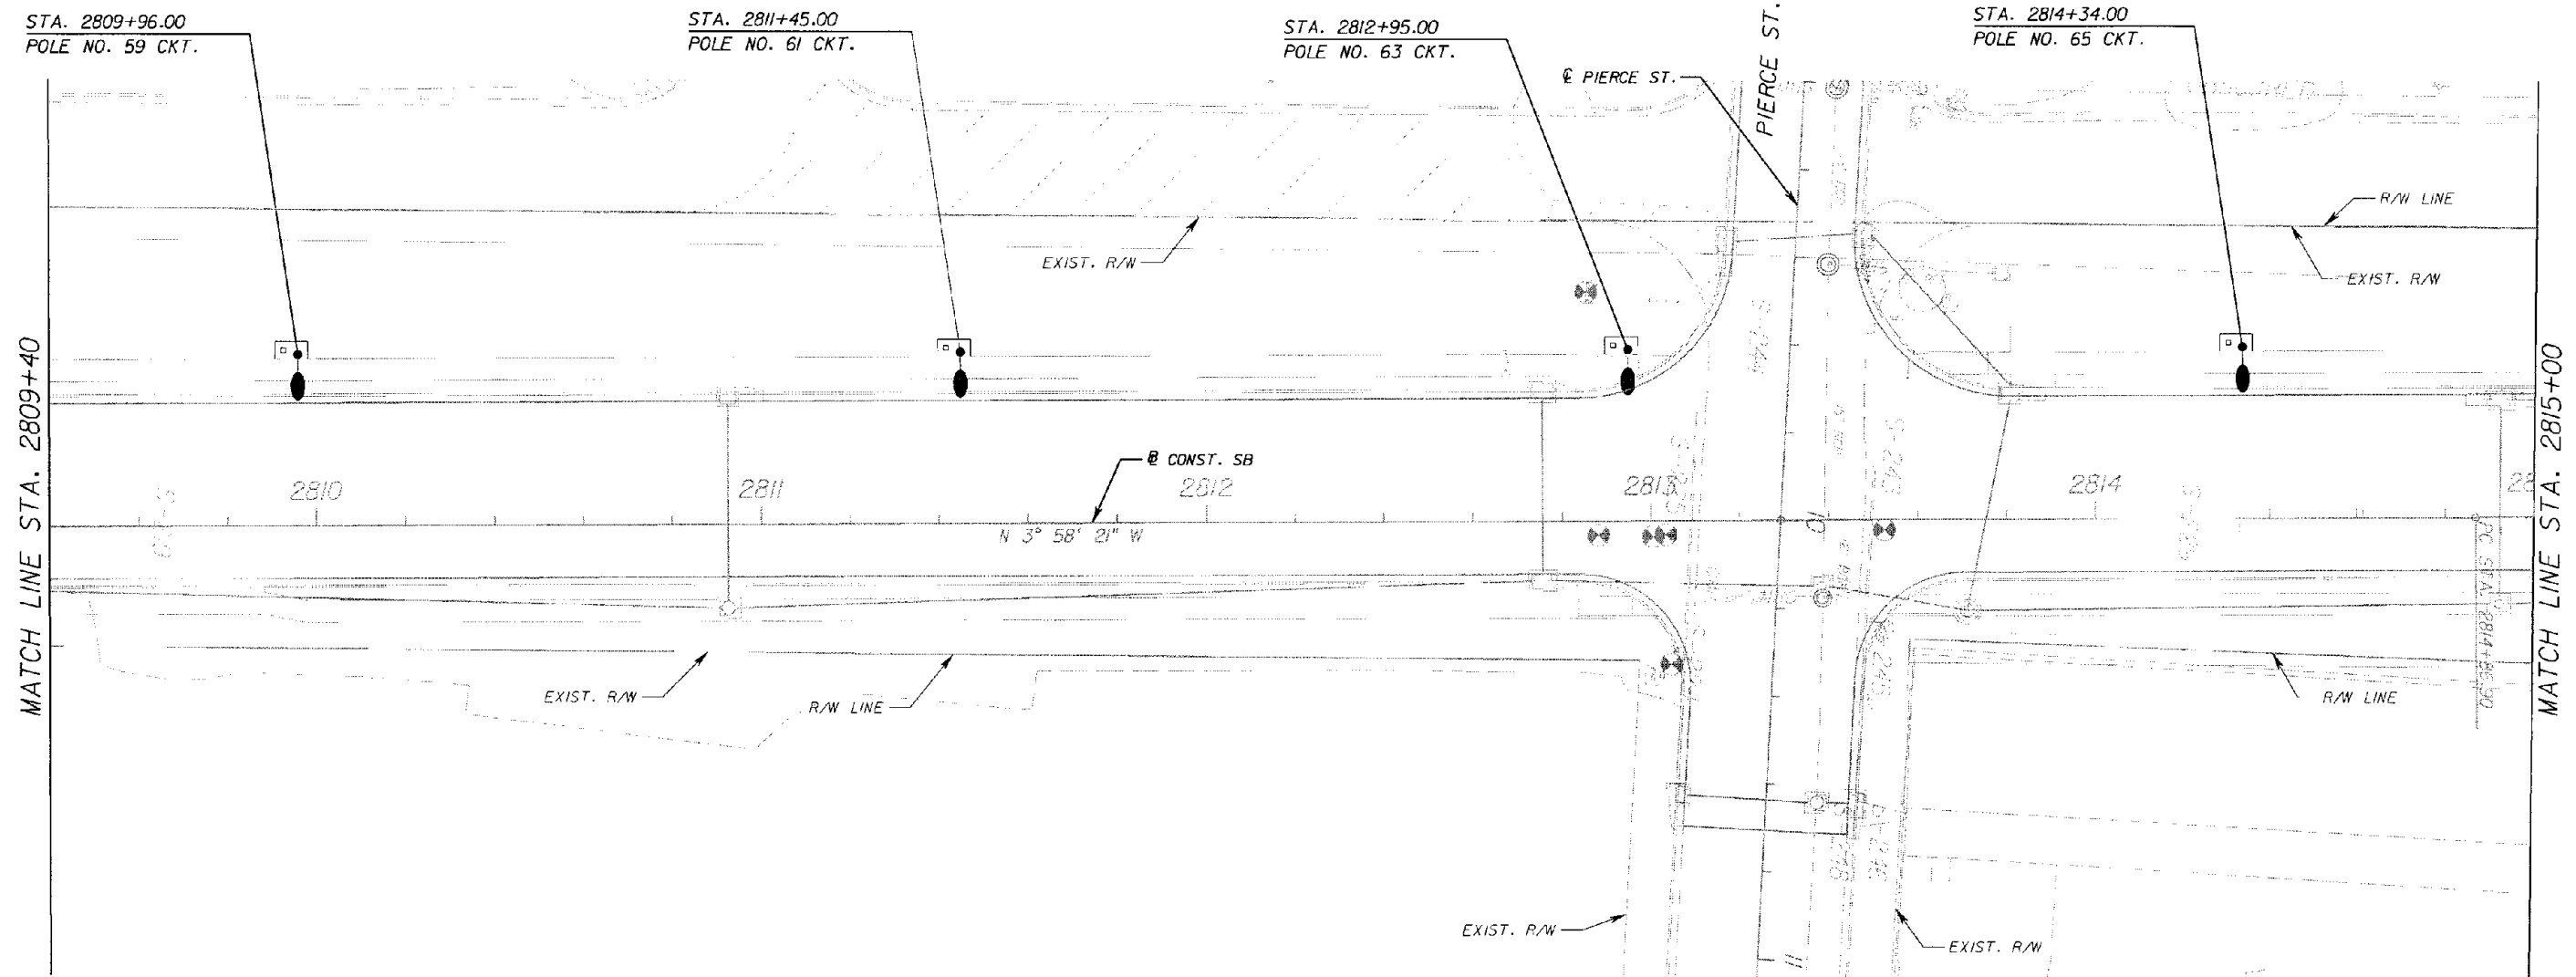

REVISIONS					
DATE	BY	DESCRIPTION	DATE	BY	DESCRIPTION

Faller, Davis & Associates, Inc.
 5525 W. CYPRESS ST. - SUITE 300
 TAMPA, FLORIDA 33607-1707
 CERTIFICATE OF AUTHORIZATION NO.: 5864
 ERBIE A. GARRETT, P.E. NO.: 45219

STATE OF FLORIDA DEPARTMENT OF TRANSPORTATION		
ROAD NO.	COUNTY	FINANCIAL PROJECT ID
SR 600	POLK	191593-1-52-01


**LIGHTING PLAN
SOUTHBOUND**

SHEET NO.
L-25

NOTICE: THE OFFICIAL RECORD OF THIS SHEET IS THE ELECTRONIC FILE SIGNED AND SEALED UNDER RULE 61G15-23.003, F.A.C.

SR 600

1" = 40'

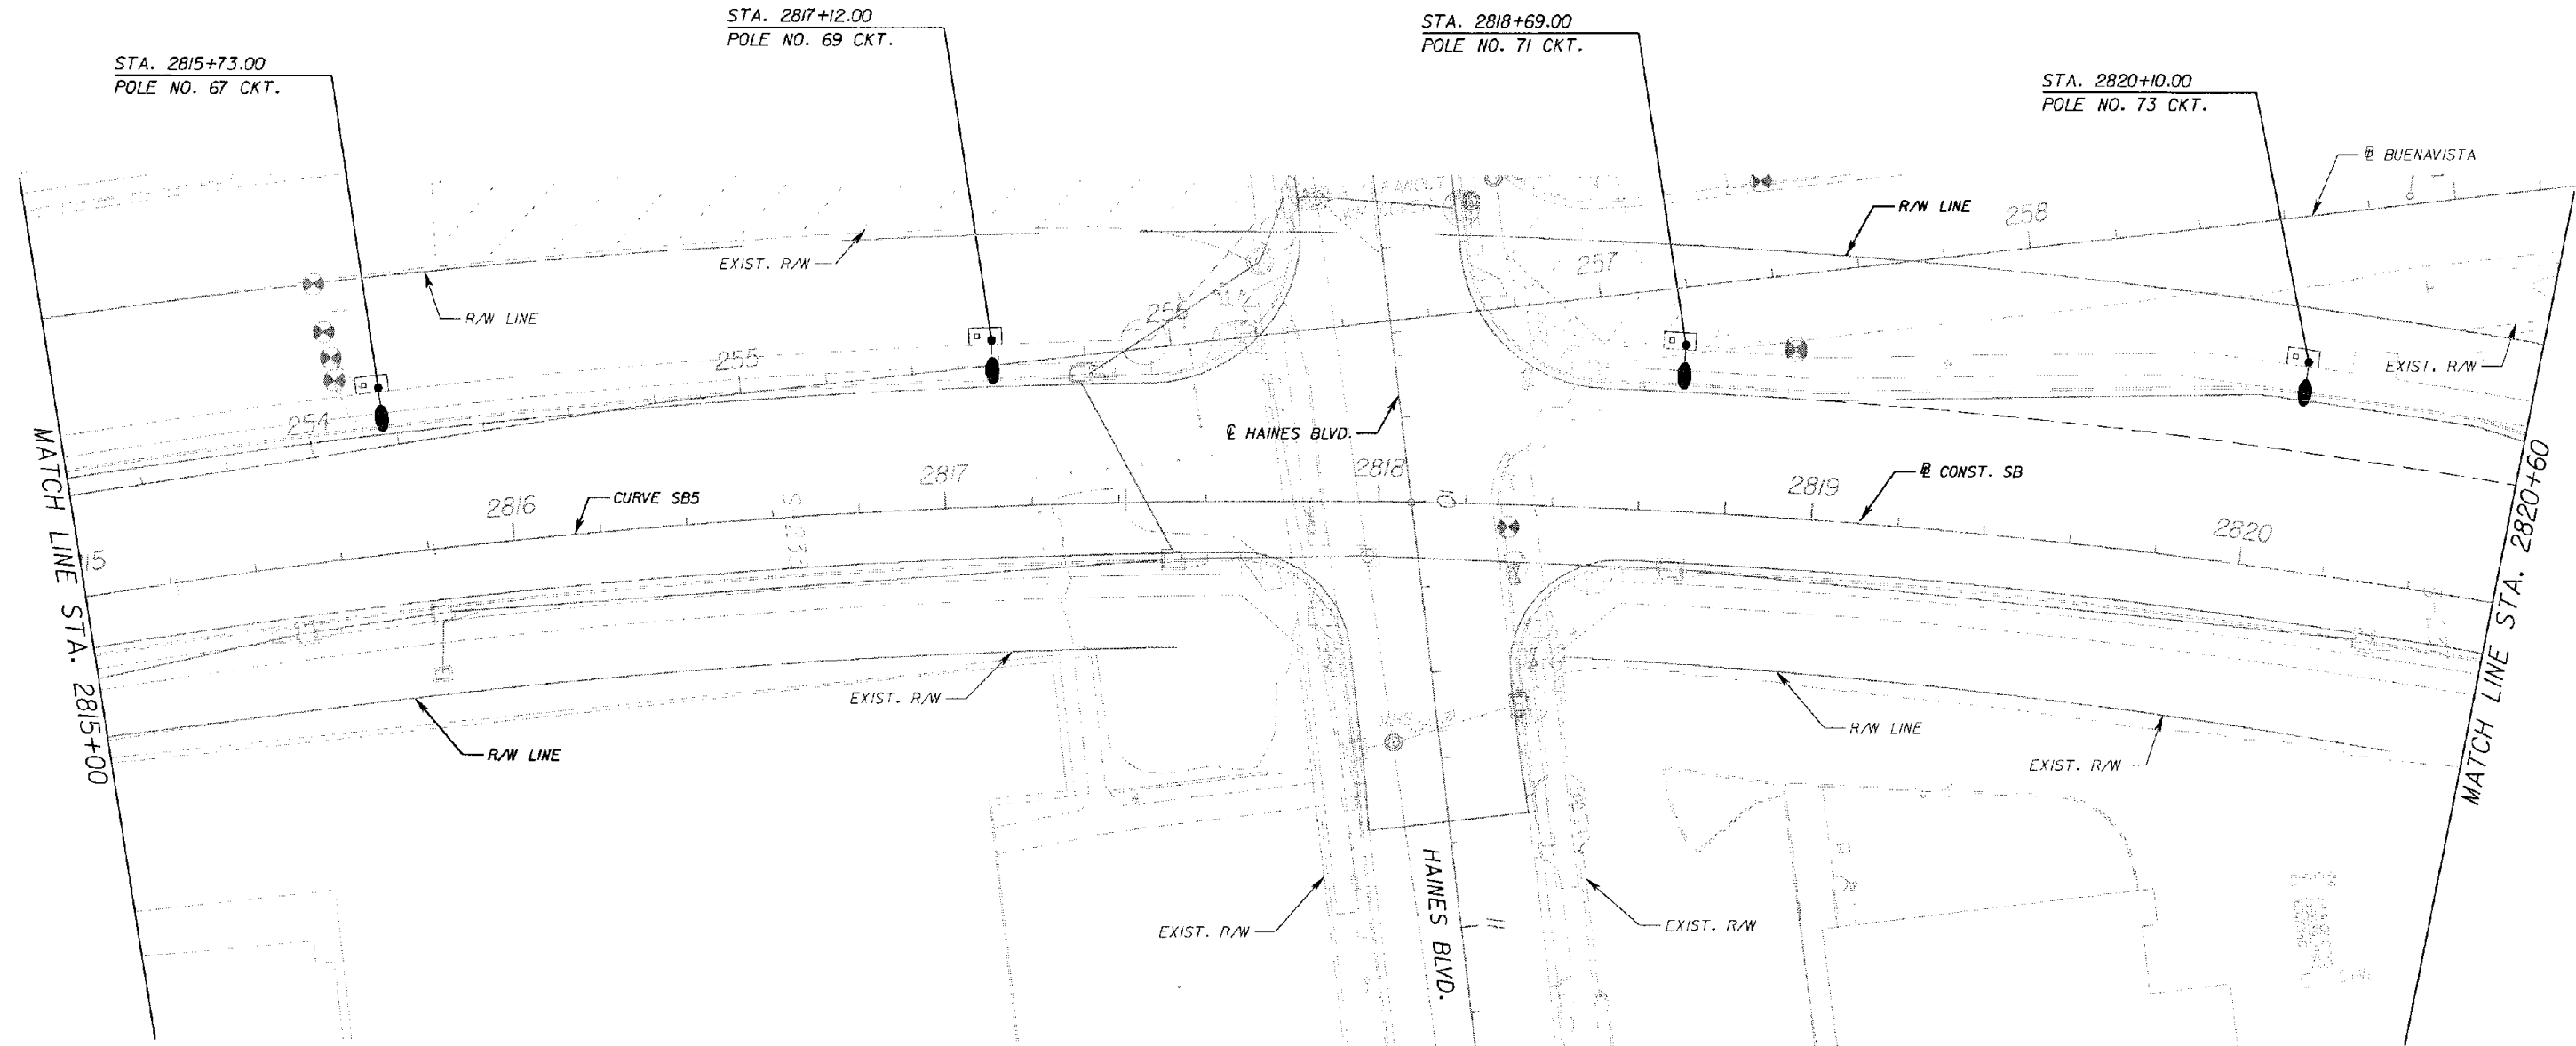

REVISIONS					
DATE	BY	DESCRIPTION	DATE	BY	DESCRIPTION

Faller, Davis & Associates, Inc.
 5525 W. CYPRESS ST. - SUITE 300
 TAMPA, FLORIDA 33607-1707
 CERTIFICATE OF AUTHORIZATION NO.: 5864
 ERBIE A. GARRETT, P.E. NO.: 45219



STATE OF FLORIDA DEPARTMENT OF TRANSPORTATION		
ROAD NO.	COUNTY	FINANCIAL PROJECT ID
SR 600	POIK	197593-1-52-01

**LIGHTING PLAN
SOUTHBOUND**

SHEET NO.
L-26

NOTICE: THE OFFICIAL RECORD OF THIS SHEET IS THE ELECTRONIC FILE SIGNED AND SEALED UNDER RULE 61G15-23.003, F.A.C.

 SR 600

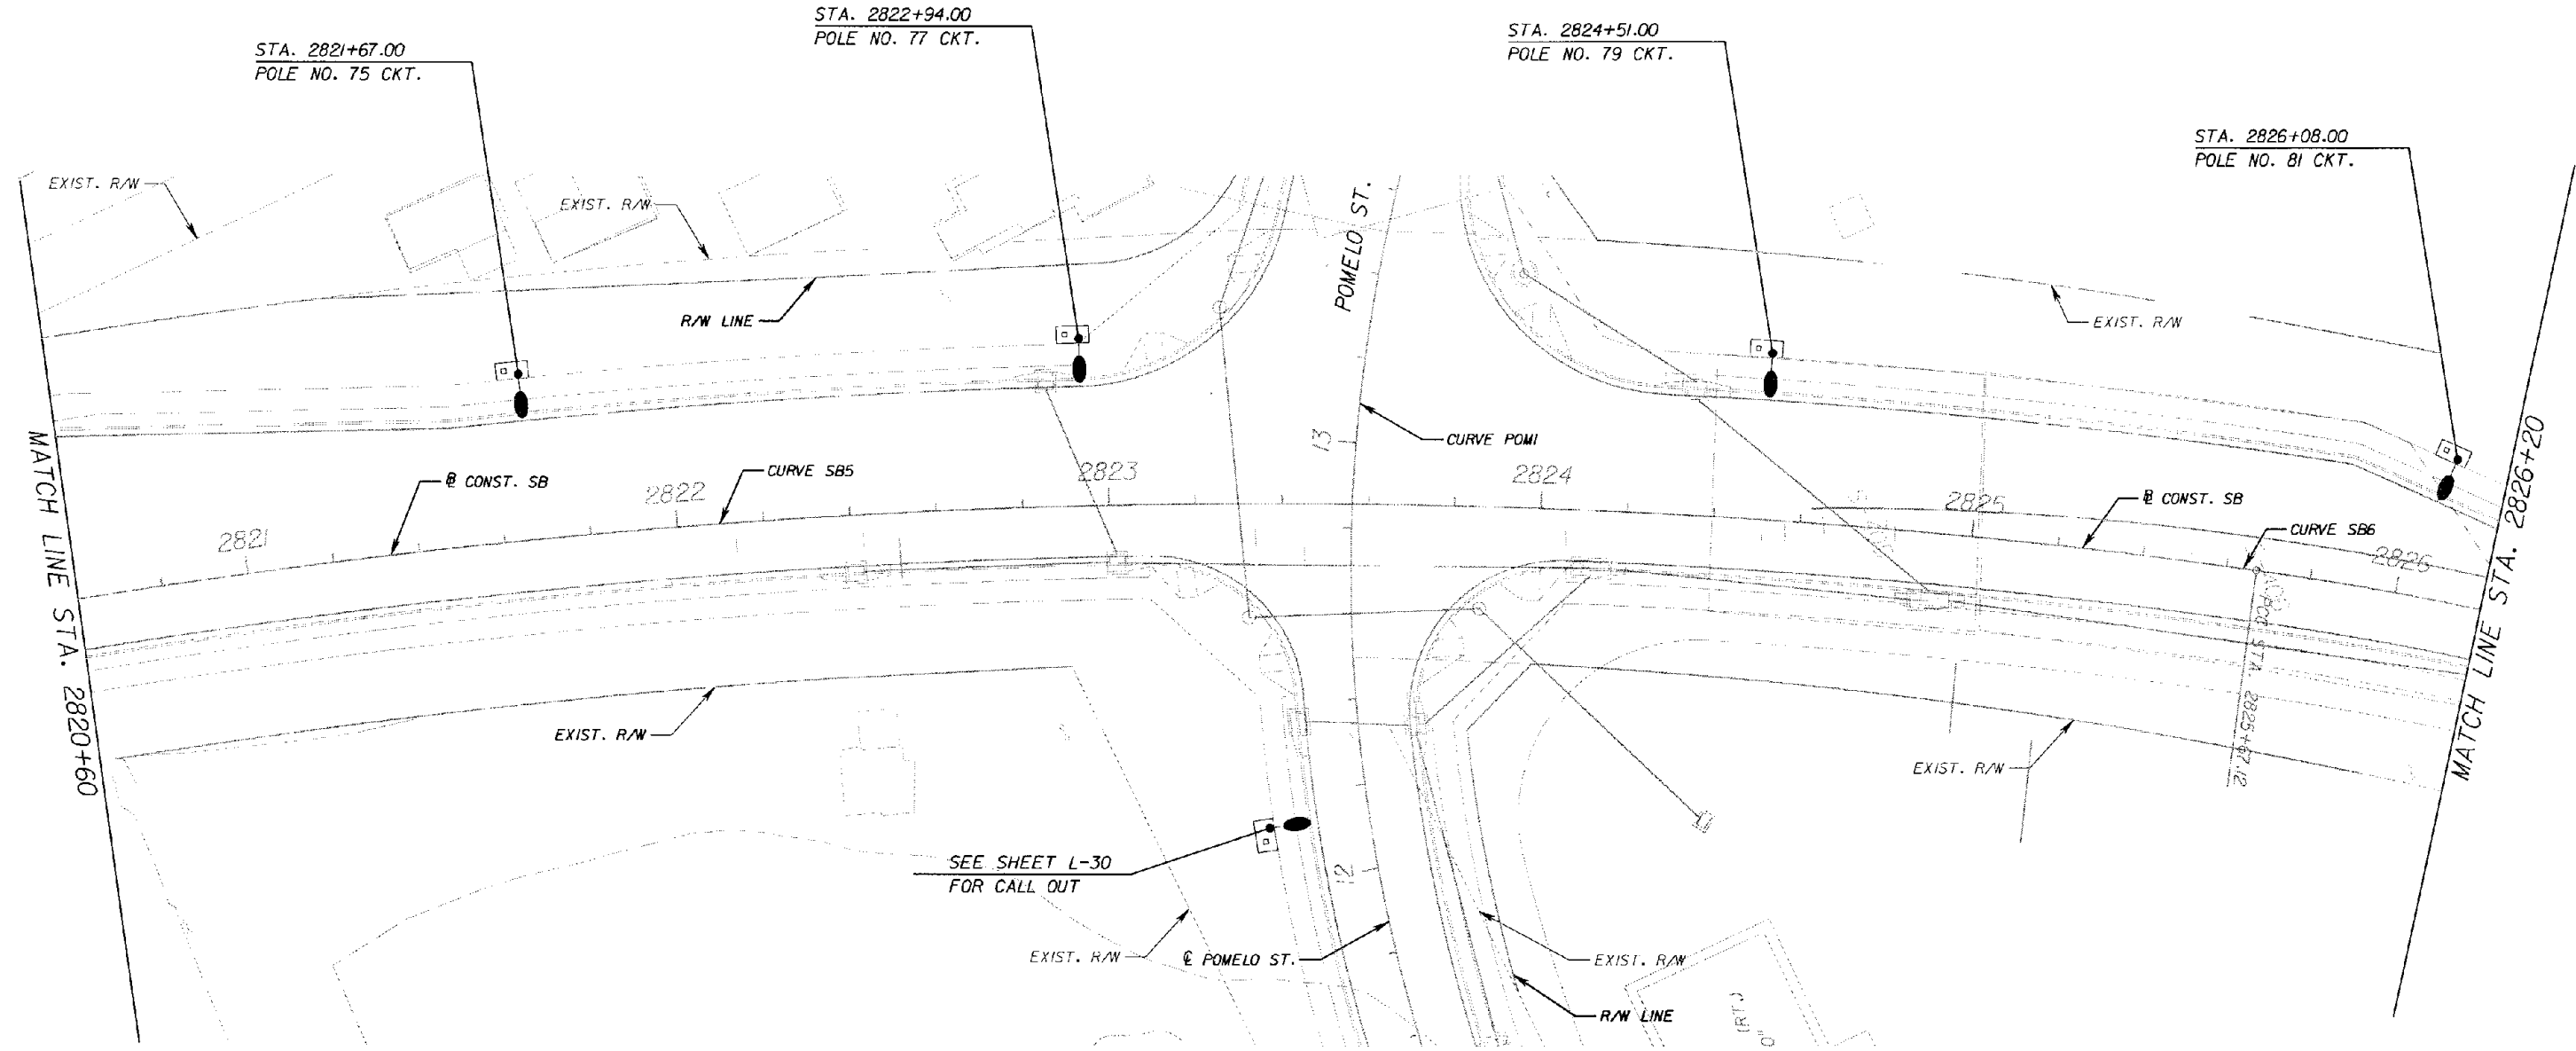

REVISIONS					
DATE	BY	DESCRIPTION	DATE	BY	DESCRIPTION

Faller, Davis & Associates, Inc.
 5525 W. CYPRESS ST. - SUITE 300
 TAMPA, FLORIDA 33607-1707
 CERTIFICATE OF AUTHORIZATION NO.: 5864
 ERBIE A. GARRETT, P.E. NO.: 45219



STATE OF FLORIDA DEPARTMENT OF TRANSPORTATION		
ROAD NO.	COUNTY	FINANCIAL PROJECT ID
SR 600	POLK	197593-1-52-01

**LIGHTING PLAN
SOUTHBOUND**

SHEET NO.
L-27

NOTICE: THE OFFICIAL RECORD OF THIS SHEET IS THE ELECTRONIC FILE SIGNED AND SEALED UNDER RULE 61G15-23.003, F.A.C.

SR 600

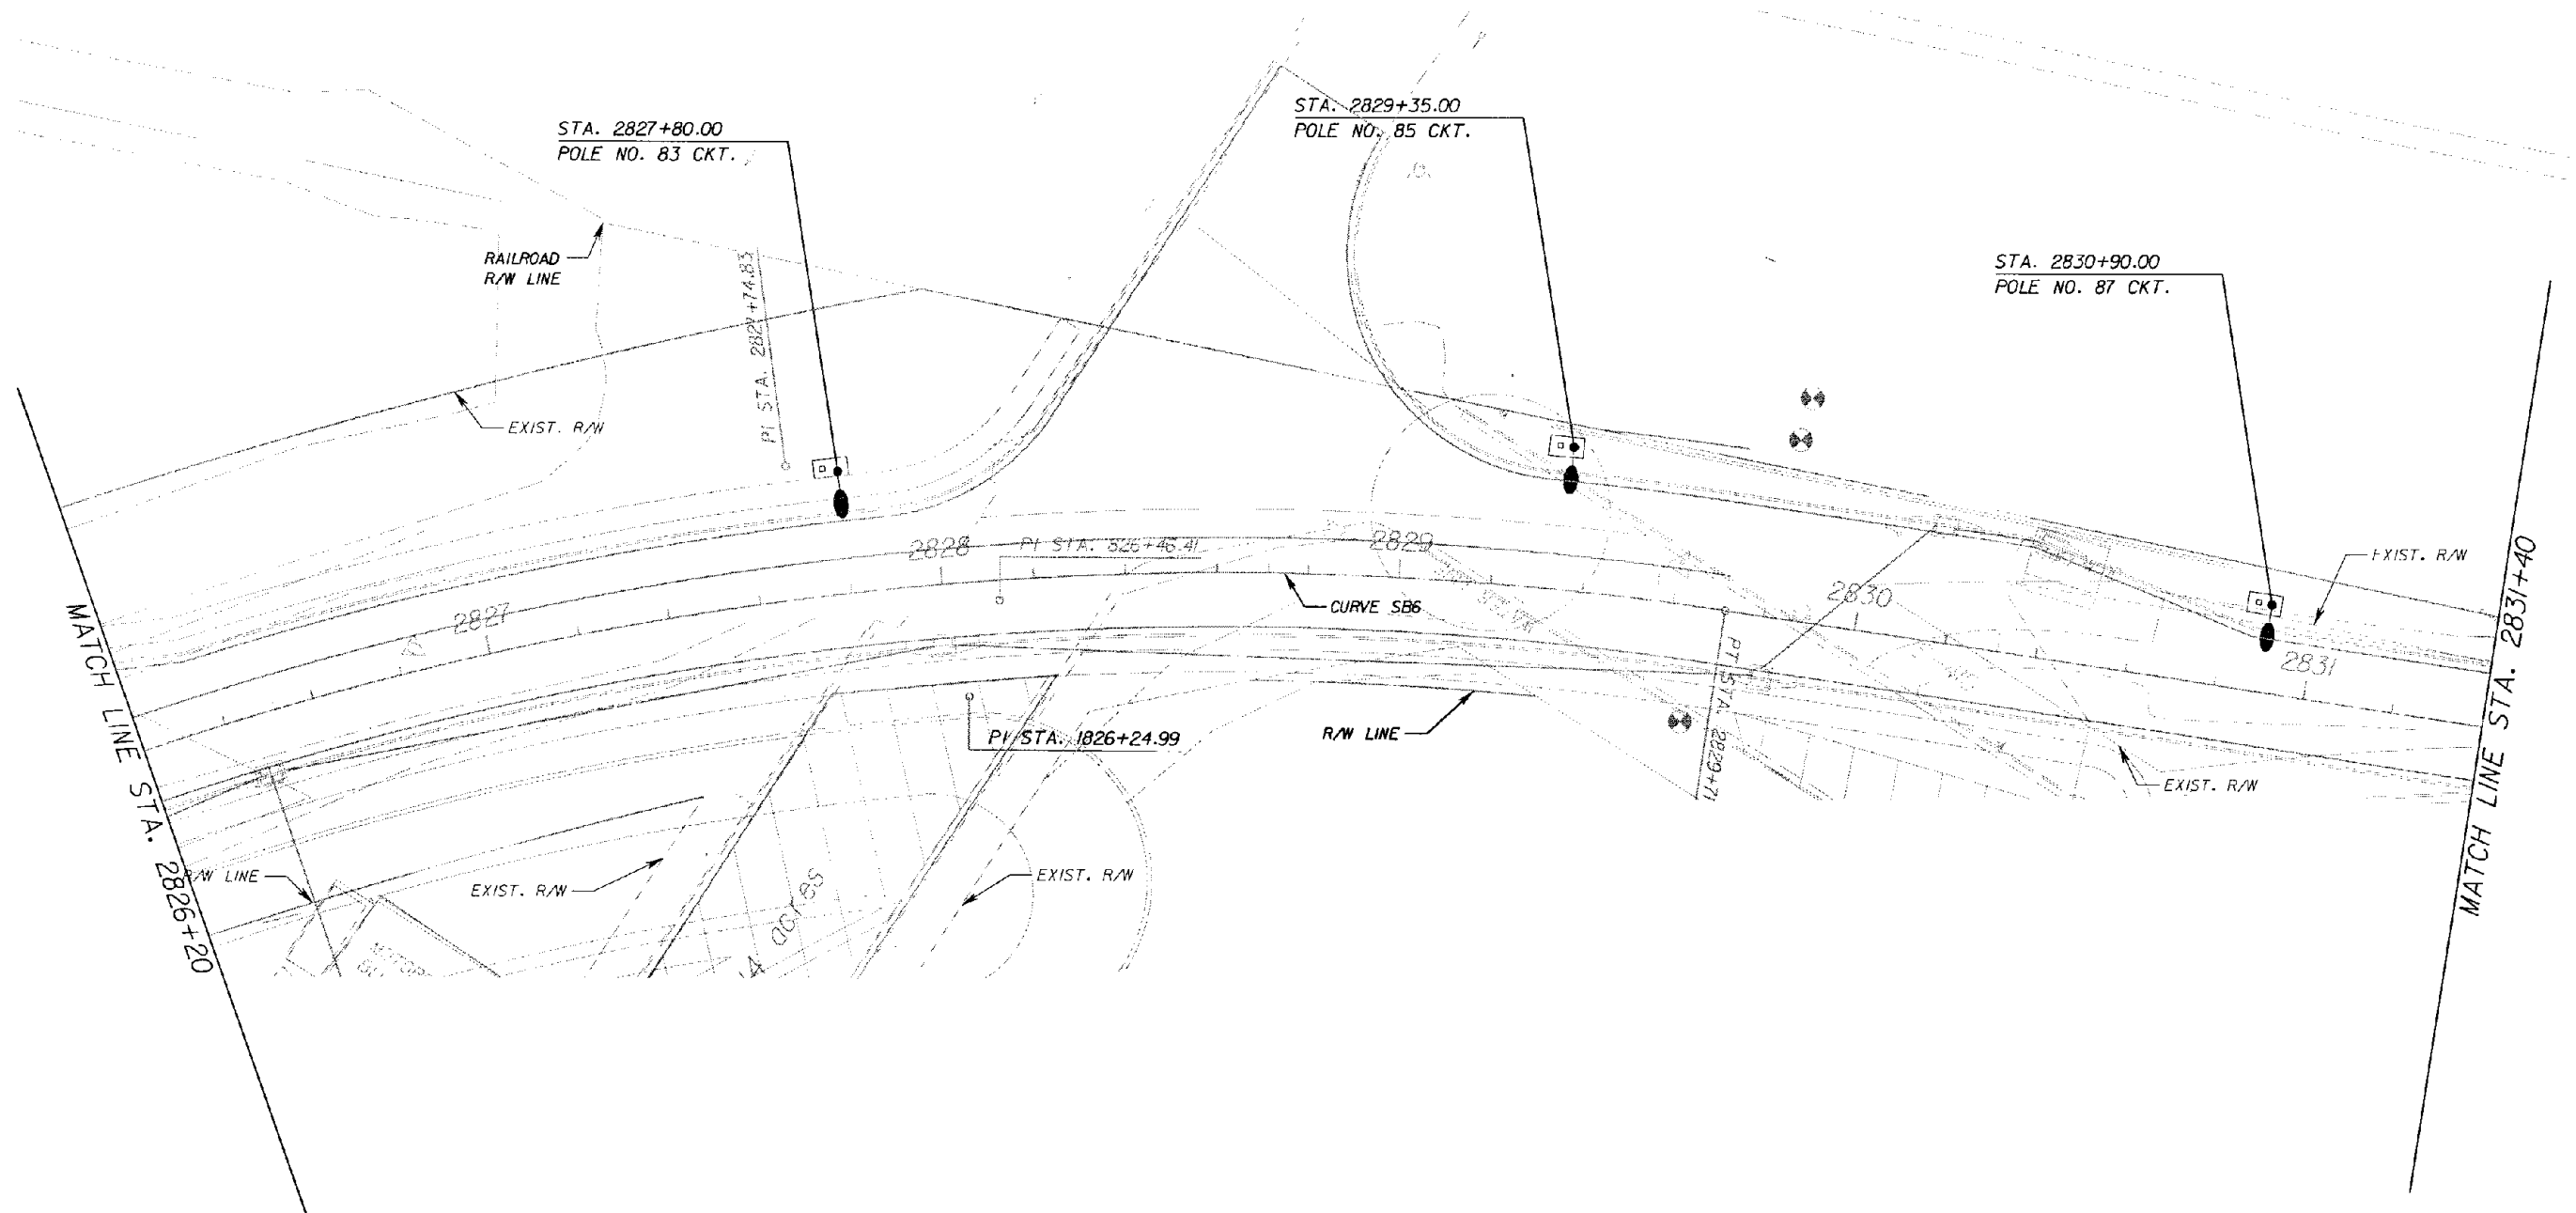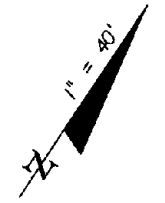

REVISIONS					
DATE	BY	DESCRIPTION	DATE	BY	DESCRIPTION

Faller Davis & Associates, Inc.
 5525 W. CYPRESS ST. - SUITE 300
 TAMPA, FLORIDA 33607-1707
 CERTIFICATE OF AUTHORIZATION NO.: 5864
 ERBIE A. GARRETT, P.E. NO.: 45219


STATE OF FLORIDA DEPARTMENT OF TRANSPORTATION		
ROAD NO.	COUNTY	FINANCIAL PROJECT ID
SR 600	POLK	197593-1-52-01

**LIGHTING PLAN
SOUTHBOUND**

SHEET NO.
L-28

NOTICE: THE OFFICIAL RECORD OF THIS SHEET IS THE ELECTRONIC FILE SIGNED AND SEALED UNDER RULE 61G15-23.003, F.A.C.


THELMA ST.

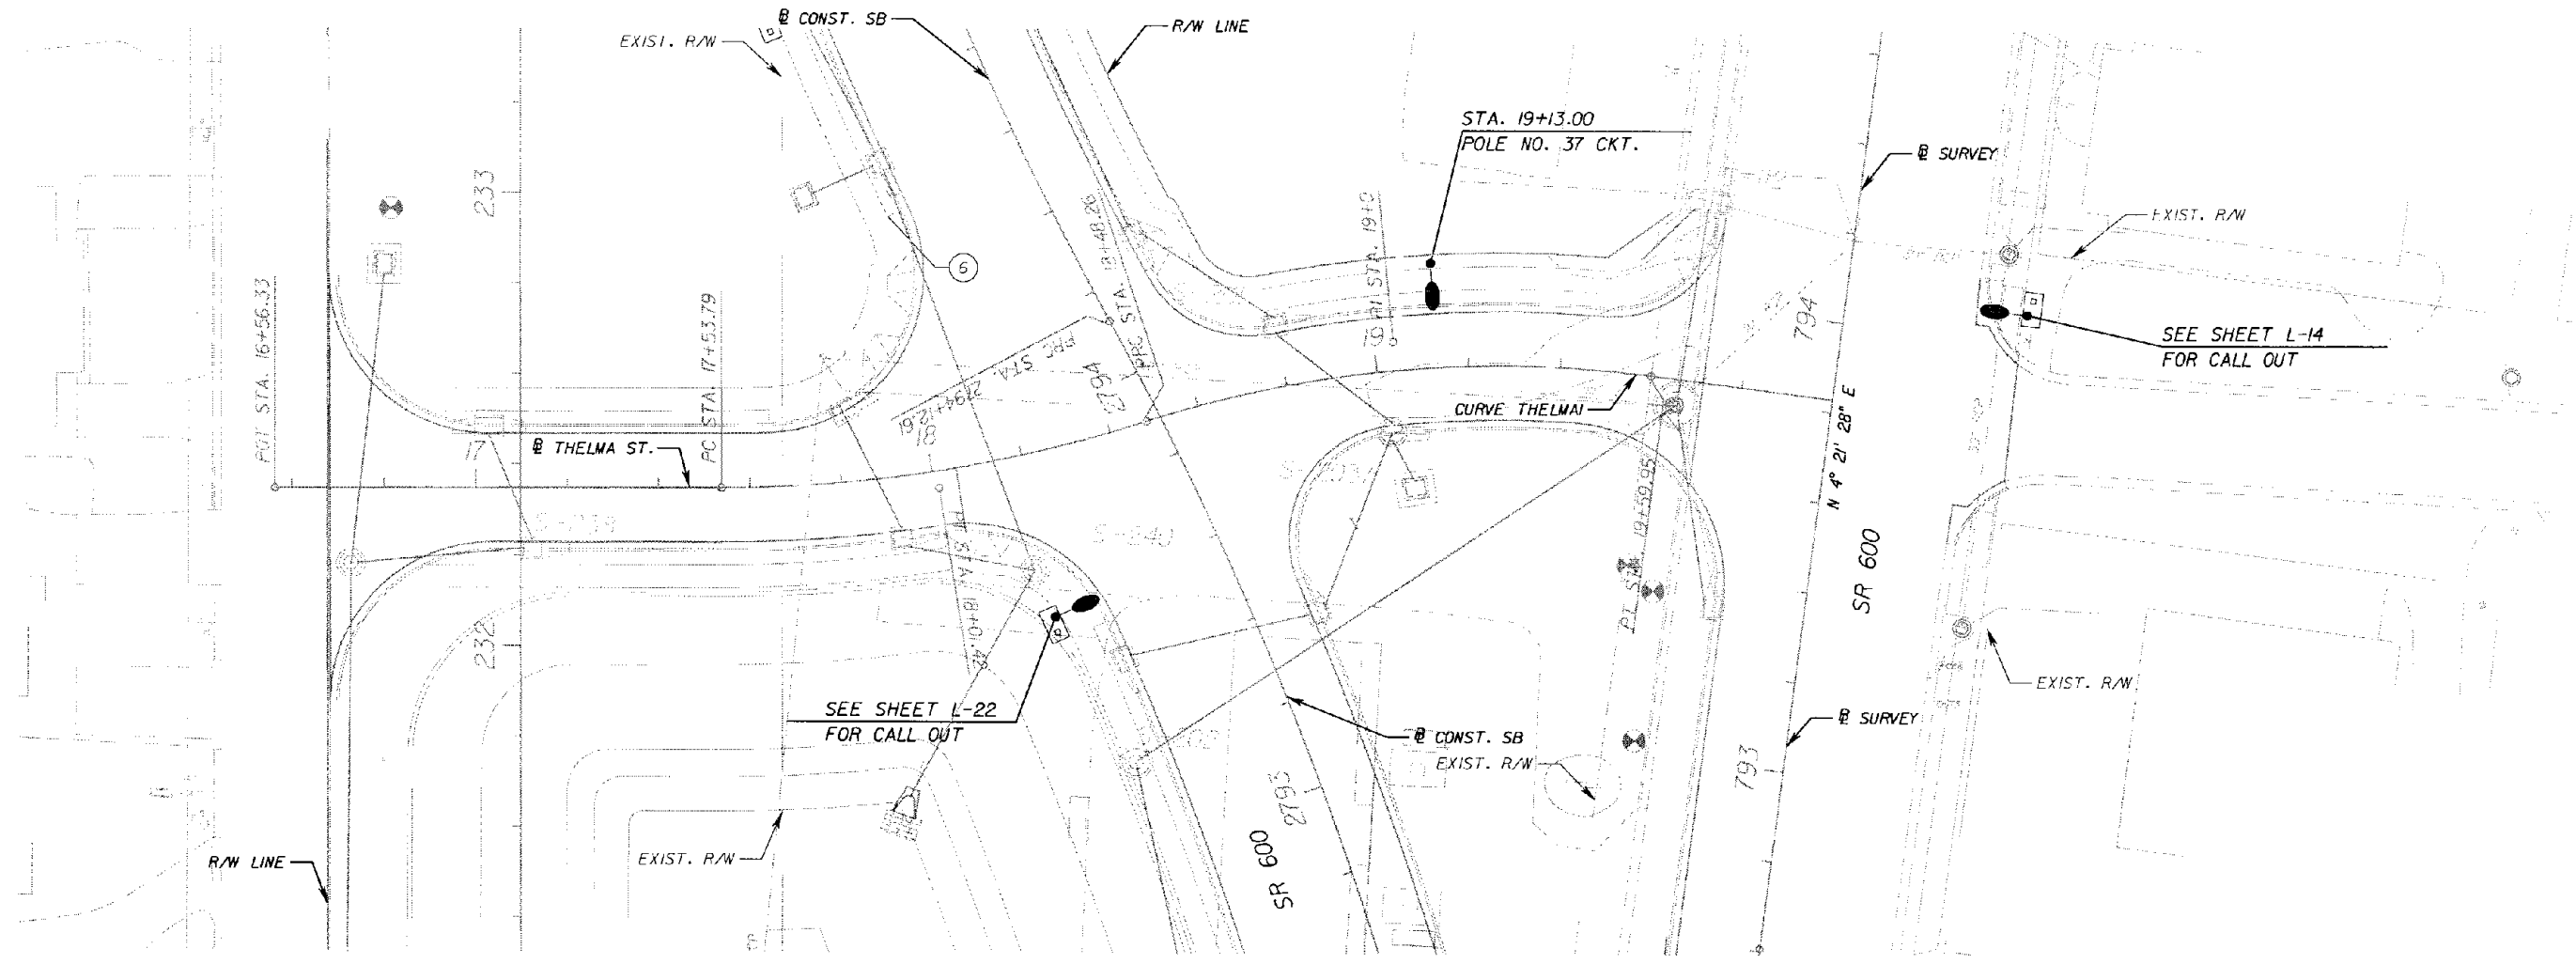

REVISIONS						Faller, Davis & Associates, Inc. 5525 W. CYPRESS ST. - SUITE 300 TAMPA, FLORIDA 33607-1707 CERTIFICATE OF AUTHORIZATION NO.: 5864 ERBIE A. GARRETT, P.E. NO.: 45219	STATE OF FLORIDA DEPARTMENT OF TRANSPORTATION			LIGHTING PLAN THELMA STREET	SHEET NO.
DATE	BY	DESCRIPTION	DATE	BY	DESCRIPTION		ROAD NO.	COUNTY	FINANCIAL PROJECT ID		L-29
							SR 600	POLK	197593-1-52-01		

NOTICE: THE OFFICIAL RECORD OF THIS SHEET IS THE ELECTRONIC FILE SIGNED AND SEALED UNDER RULE 68D5-23.003, F.A.C.

POMELO ST.

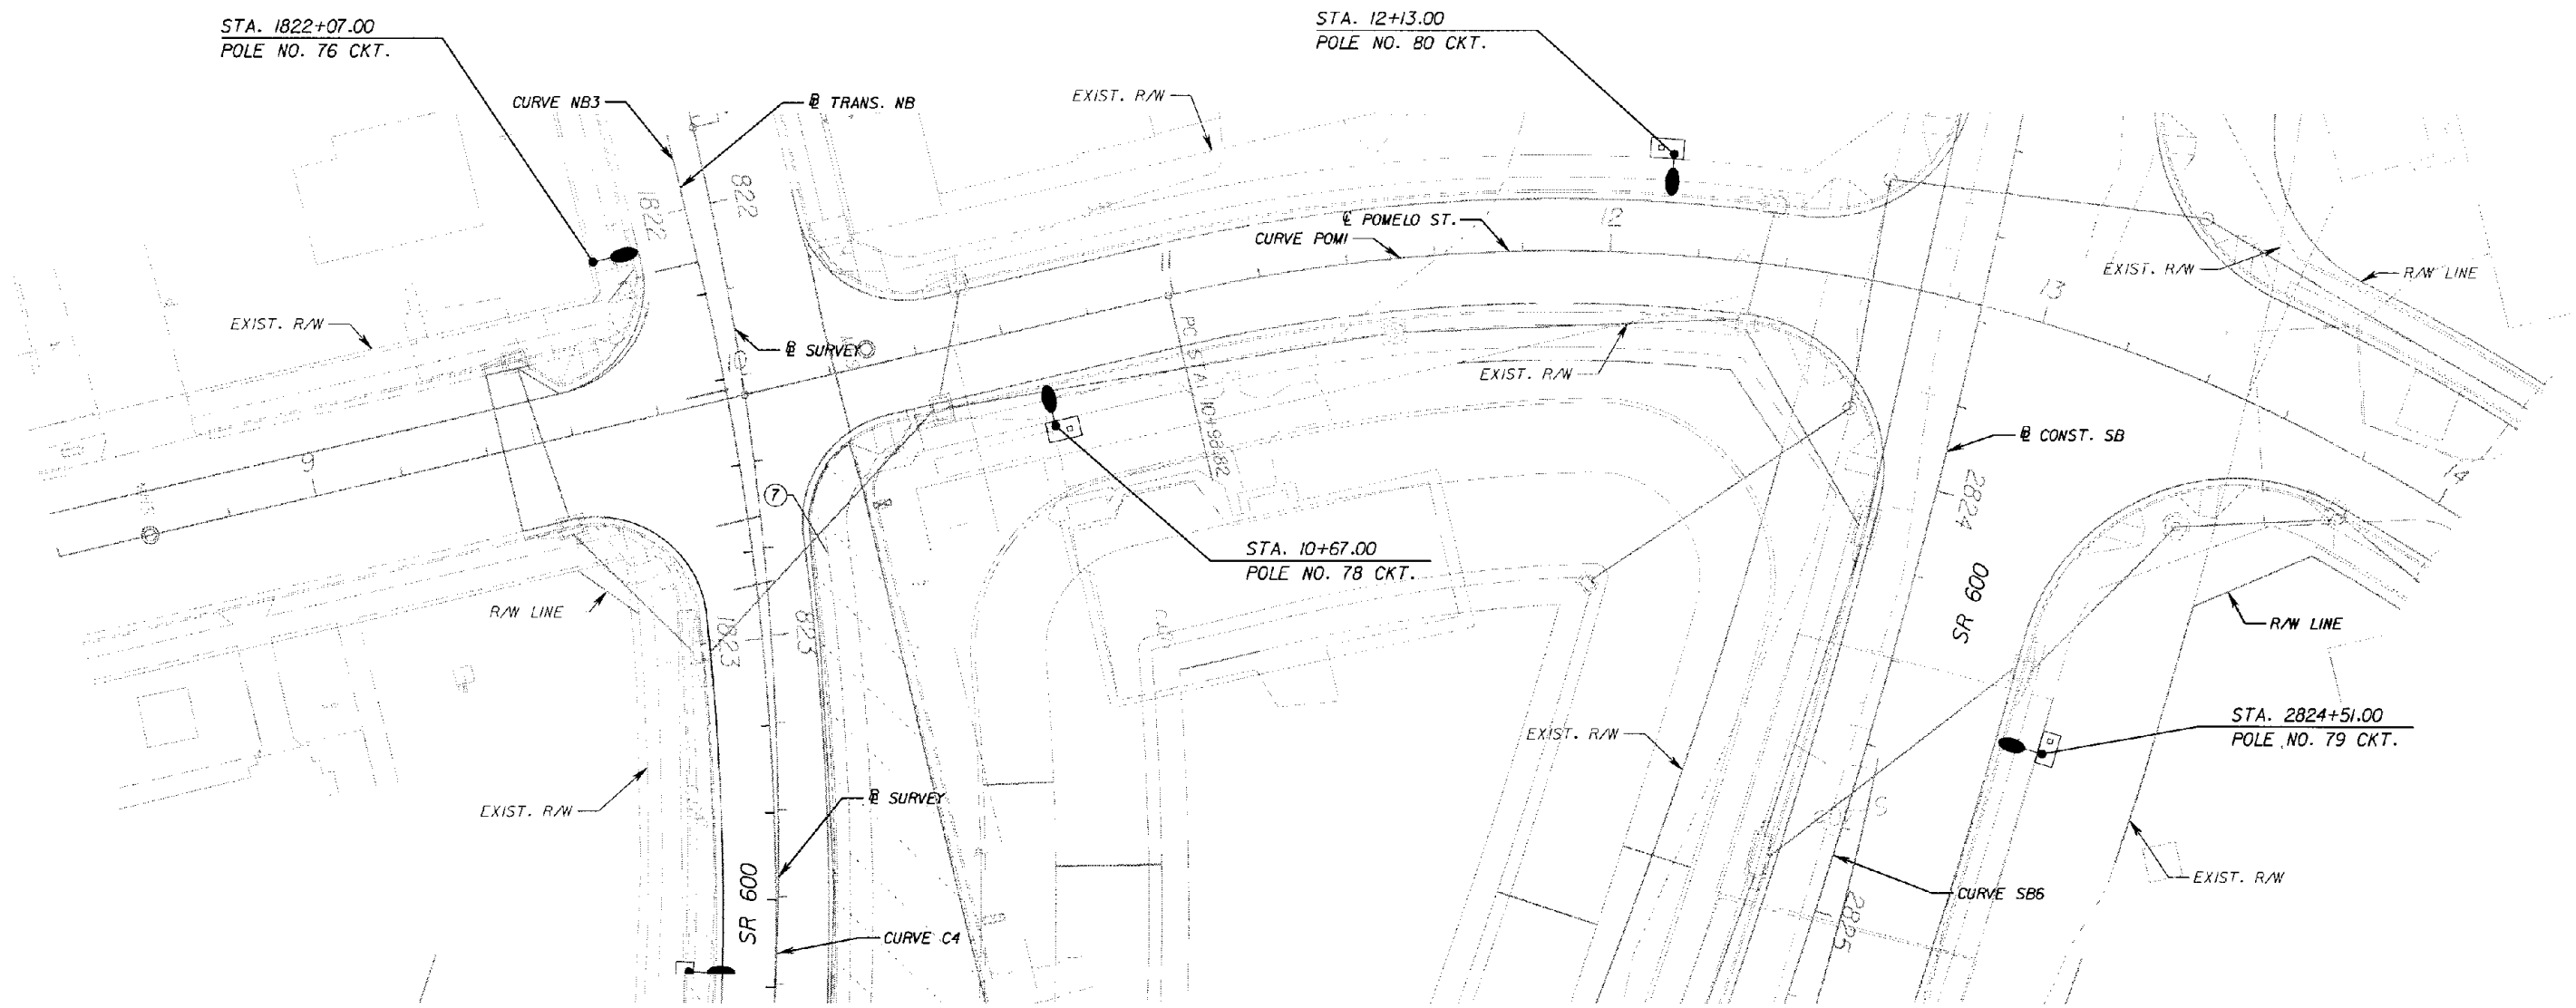

REVISIONS					
DATE	BY	DESCRIPTION	DATE	BY	DESCRIPTION

Faller, Davis & Associates, Inc.
 5525 W. CYPRESS ST. - SUITE 300
 TAMPA, FLORIDA 33607-1707
 CERTIFICATE OF AUTHORIZATION NO.: 5864
 ERBIE A. GARRETT, P.E. NO.: 45219

STATE OF FLORIDA DEPARTMENT OF TRANSPORTATION		
ROAD NO.	COUNTY	FINANCIAL PROJECT ID
SR 600	POLK	197593-1-52-01

LIGHTING PLAN
POMELO STREET

SHEET NO.
 L-30

NOTICE: THE OFFICIAL RECORD OF THIS SHEET IS THE ELECTRONIC FILE SIGNED AND SEALED UNDER RULE 6105-23.003, F.A.C.