

**CONTRACT PLANS COMPONENTS**

- ROADWAY PLANS
- SIGNING AND PAVEMENT MARKING PLANS
- SIGNALIZATION PLANS
- LIGHTING PLANS
- STRUCTURE PLANS


*STATE OF FLORIDA*  
**DEPARTMENT OF TRANSPORTATION**  
SIGNING AND PAVEMENT MARKING PLANS

FINANCIAL PROJECT ID 448974-1-52-01

OKEECHOBEE COUNTY (91020)

STATE ROAD NO. 15 (US 441/US 98)


(MILL AND RESURFACE FROM NW 3RD ST. TO N OF NE 120TH ST.)

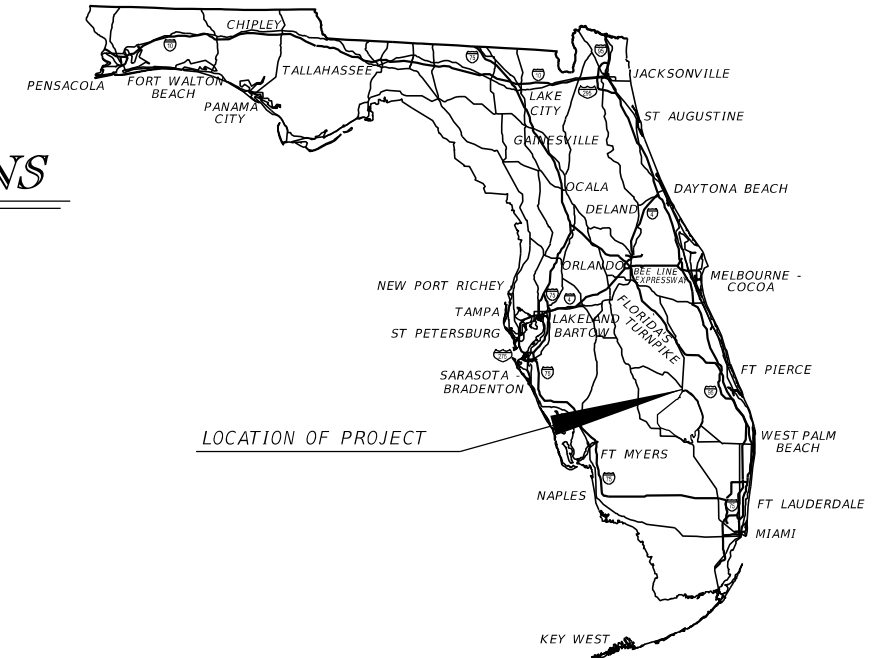

**INDEX OF SIGNING AND PAVEMENT MARKING PLANS**

SHEET NO.	SHEET DESCRIPTION
S-1	KEY SHEET
S-2 - S-54	SIGNING AND PAVEMENT MARKING PLAN
T-1 - T-2	SIGNALIZATION PLAN

PROJECT LOCATION URL:	<a href="https://goo.gl/maps/5bxeQcP8T5tfrJsf6">https://goo.gl/maps/5bxeQcP8T5tfrJsf6</a>
PROJECT LIMITS:	BEGIN MP 3.280 - END MP 11.066
EXCEPTIONS:	NONE
BRIDGE LIMITS:	BR#910021 MP 6.729 TO MP 6.772 BRIDGE CULVERT: 910087 MP 5.642 910022 MP 6.913
RAILROAD CROSSING:	RR#628062 MP 3.684 TO MP 3.694

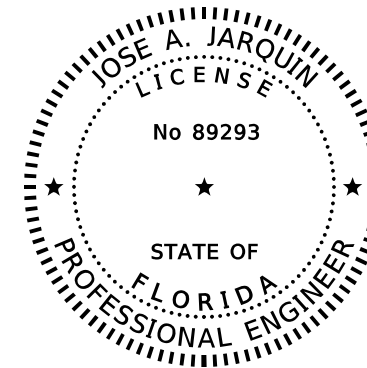

THIS ITEM HAS BEEN DIGITALLY  
SIGNED AND SEALED BY

ON THE DATE ADJACENT TO THE SEAL

PRINTED COPIES OF THIS DOCUMENT ARE  
NOT CONSIDERED SIGNED AND SEALED  
AND THE SIGNATURE MUST BE VERIFIED  
ON ANY ELECTRONIC COPIES.

THE ABOVE NAMED PROFESSIONAL IS  
RESPONSIBLE FOR THE FOLLOWING SHEETS  
IN ACCORDANCE WITH RULE 61G15-23.004, F.A.C.

**SIGNING AND  
PAVEMENT MARKING PLANS  
ENGINEER OF RECORD:**

JOSE A. JARQUIN, P.E.  
P.E. LICENSE NUMBER 89293  
AMERICAN STRUCTUREPOINT, INC.  
5405 CYPRESS CENTER DR, SUITE 310  
TAMPA, FL 33609  
CONTRACT NO.: CAL11  
VENDOR NO.: F351127317002

**FDOT PROJECT MANAGER:**

BRANDON FERNANDEZ, PE

**GOVERNING STANDARD PLANS:**

Florida Department of Transportation, FY2024-25 Standard Plans for Road and Bridge Construction and applicable Interim Revisions (IRs).


Standard Plans for Road Construction and associated IRs are available at the following website: <http://www.fdot.gov/design/standardplans>

Standard Plans for Bridge Construction are included in the Structure Plans Component.


**GOVERNING STANDARD SPECIFICATIONS:**

Florida Department of Transportation, 2024-25 Standard Specifications for Road and Bridge Construction at the following website: <http://www.fdot.gov/programmanagement/Implemented/SpecBooks>

CONSTRUCTION CONTRACT NO.	FISCAL YEAR	SHEET NO.
	25	S-1

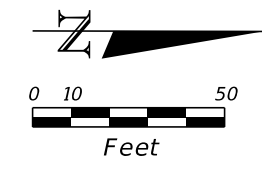

- R5-1a 42"X30"
- 700-1-111 2 EA
- 700-13-12 2 EA
- STA. 242+18

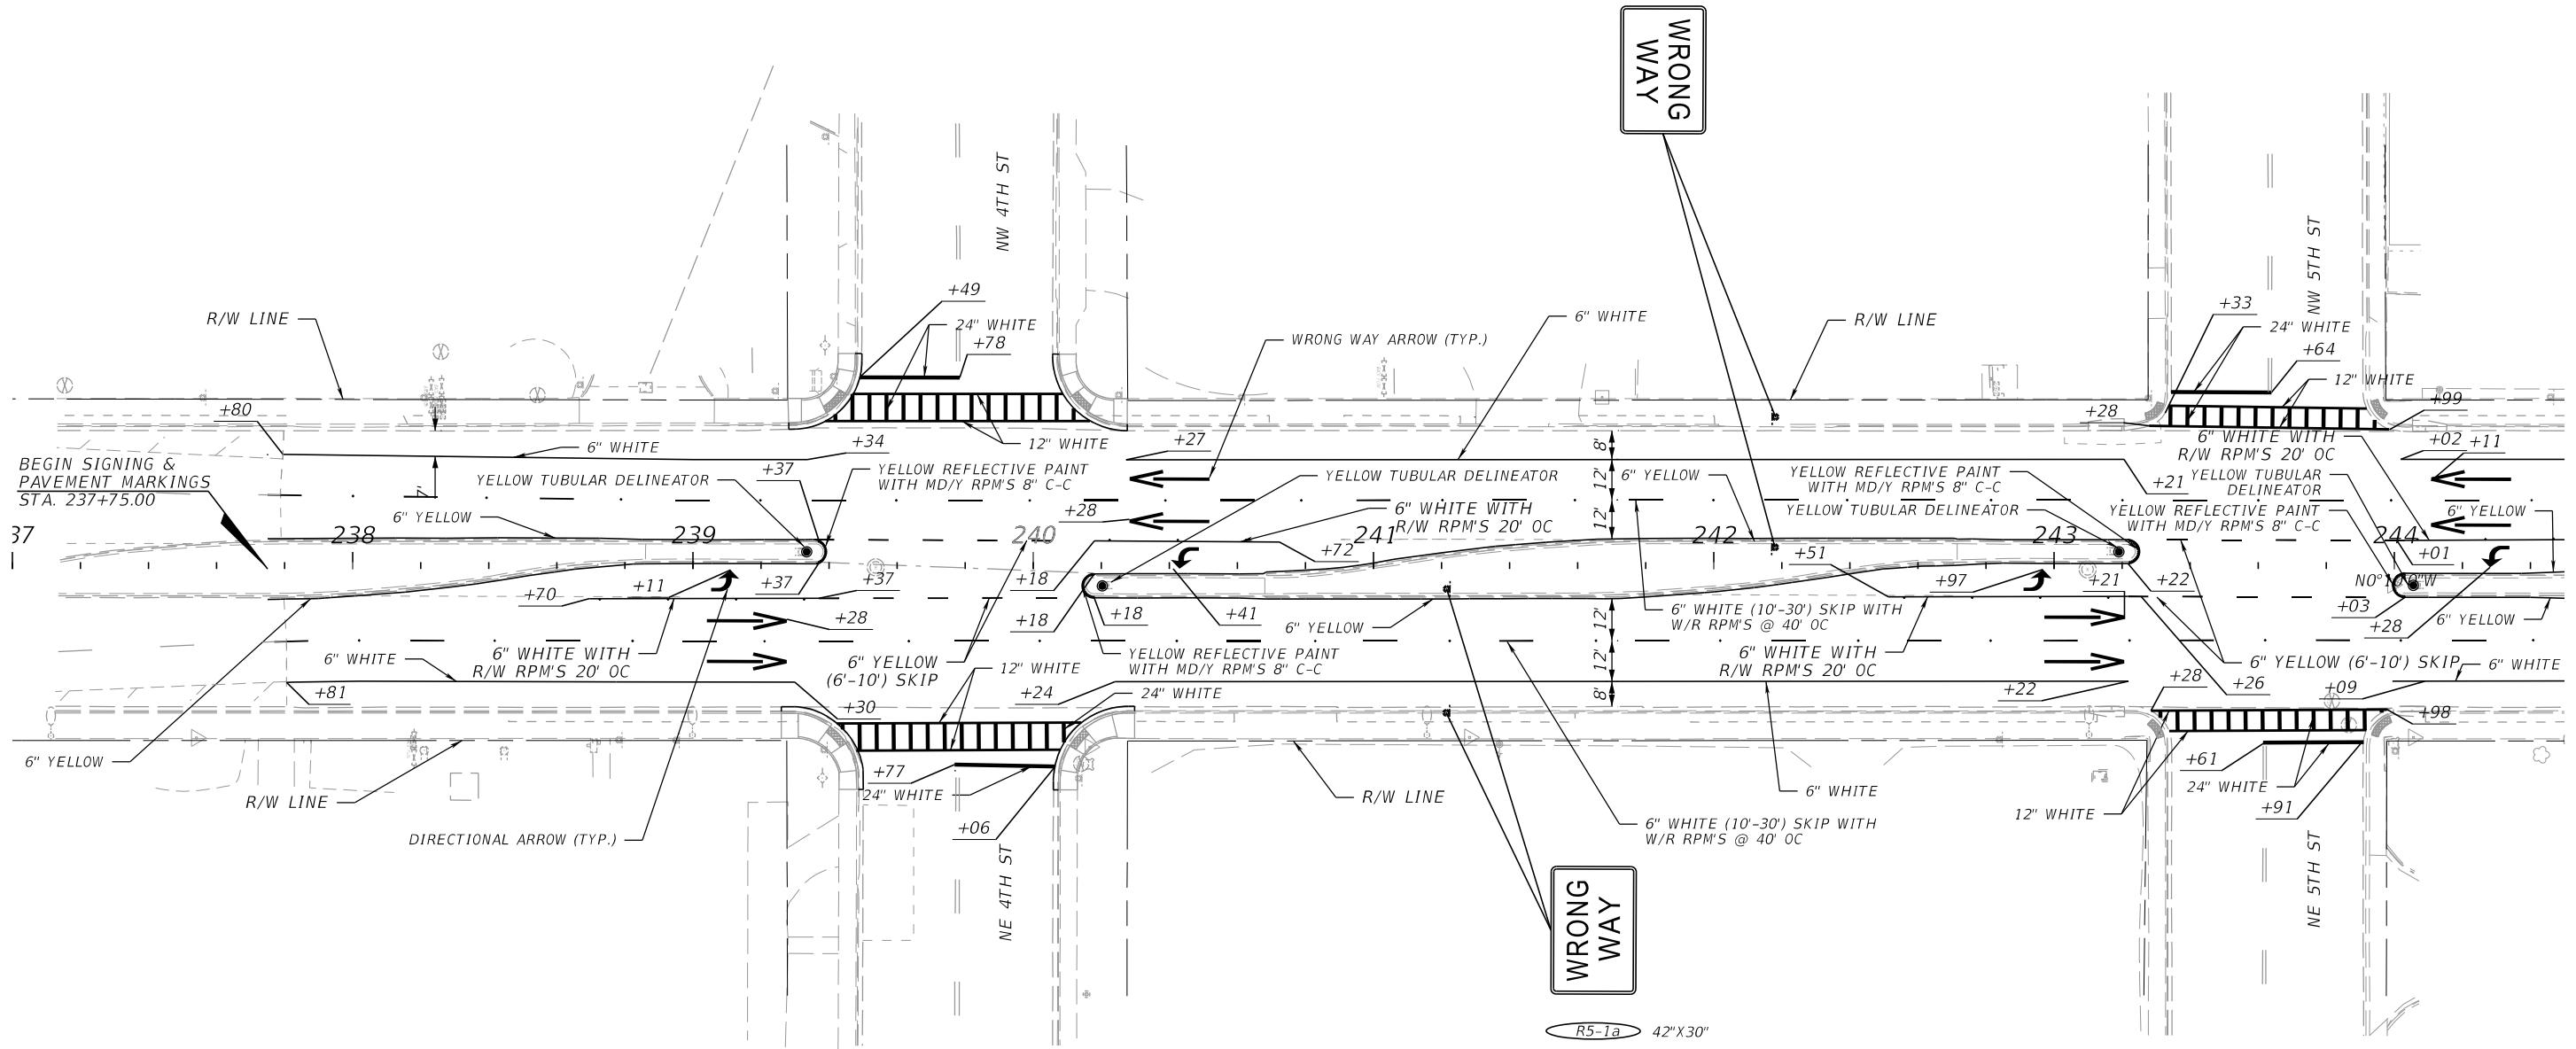


WRONG WAY

- R5-1a 42"X30"
- 700-1-111 2 EA
- 700-13-12 2 EA
- STA. 241+21

11/9/2023 11:58:17 AM MNADIR  
c:\pwworking\kpkpw01\nassim\adir\dms05209\PLAN\SP02.dgn

REVISIONS				ENGINEER OF RECORD		STATE OF FLORIDA DEPARTMENT OF TRANSPORTATION			SHEET NO.
DATE	DESCRIPTION	DATE	DESCRIPTION	JOSE A. JARQUIN, P.E. LICENSE NUMBER: 89293 AMERICAN STRUCTUREPOINT, INC 5405 CYPRESS CENTER DR, SUITE 310 TAMPA, FL 33609		ROAD NO.	COUNTY	FINANCIAL PROJECT ID	
						SR 15	OKEECHOBEE	448974-1-52-01	
<b>SIGNING AND PAVEMENT MARKING PLAN</b>									S-2

THE OFFICIAL RECORD OF THIS SHEET IS THE ELECTRONIC FILE DIGITALLY SIGNED AND SEALED UNDER RULE 61G15-23.004, F.A.C.

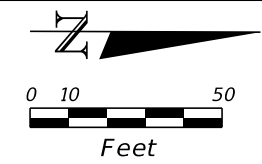


R5-1a 42"X30"  
 700-1-111 2 EA  
 700-13-12 2 EA  
 STA. 246+03

R5-1a 42"X30"  
 700-1-111 2 EA  
 700-13-12 2 EA  
 STA. 249+73

R5-1a 42"X30"  
 700-1-111 2 EA  
 700-13-12 2 EA  
 STA. 244+92

R5-1a 42"X30"  
 700-1-111 2 EA  
 700-13-12 2 EA  
 STA. 248+47

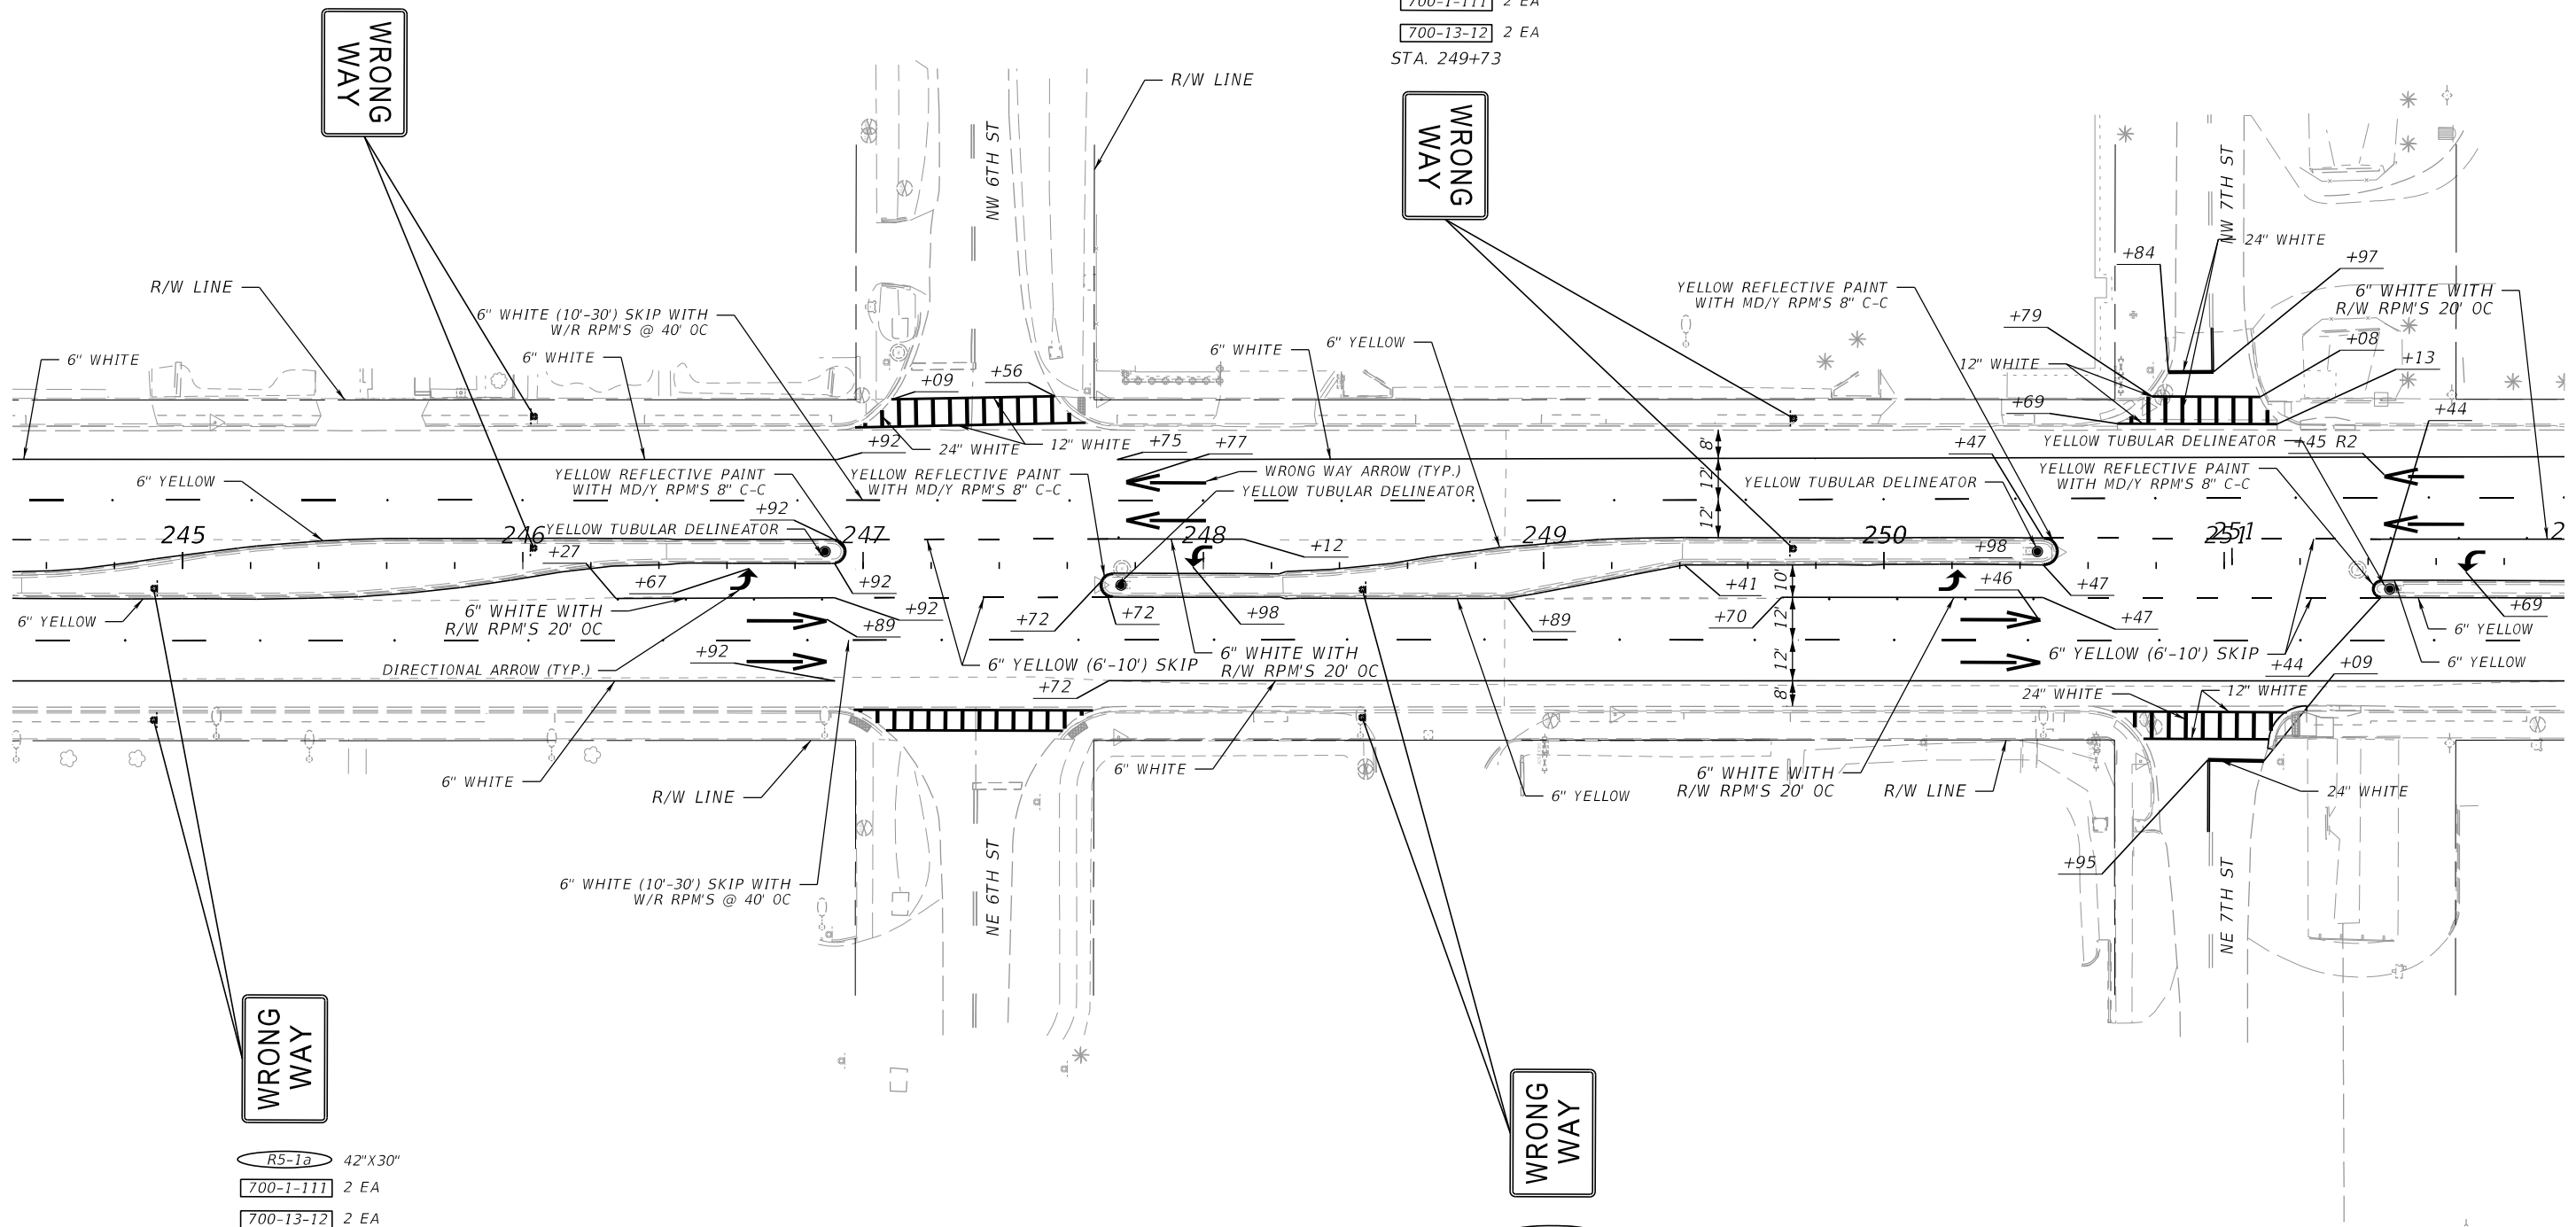

11/9/2023 11:58:20 AM MNADIR c:\pwworking\kkipw01\nassim\nadir\dms05209\PLAN\SP02.dgn


THE OFFICIAL RECORD OF THIS SHEET IS THE ELECTRONIC FILE DIGITALLY SIGNED AND SEALED UNDER RULE 61G15-23.004, F.A.C.

REVISIONS				ENGINEER OF RECORD			STATE OF FLORIDA DEPARTMENT OF TRANSPORTATION			SHEET NO.
DATE	DESCRIPTION	DATE	DESCRIPTION	JOSE A. JARQUIN, P.E. LICENSE NUMBER: 89293 AMERICAN STRUCTUREPOINT, INC 5405 CYPRESS CENTER DR, SUITE 310 TAMPA, FL 33609			ROAD NO.	COUNTY	FINANCIAL PROJECT ID	
							SR 15	OKEECHOBEE	448974-1-52-01	S-3

**SIGNING AND PAVEMENT  
MARKING PLAN**



R5-1a 42"X30"  
 700-1-111 2 EA  
 700-13-12 2 EA  
 STA. 253+44


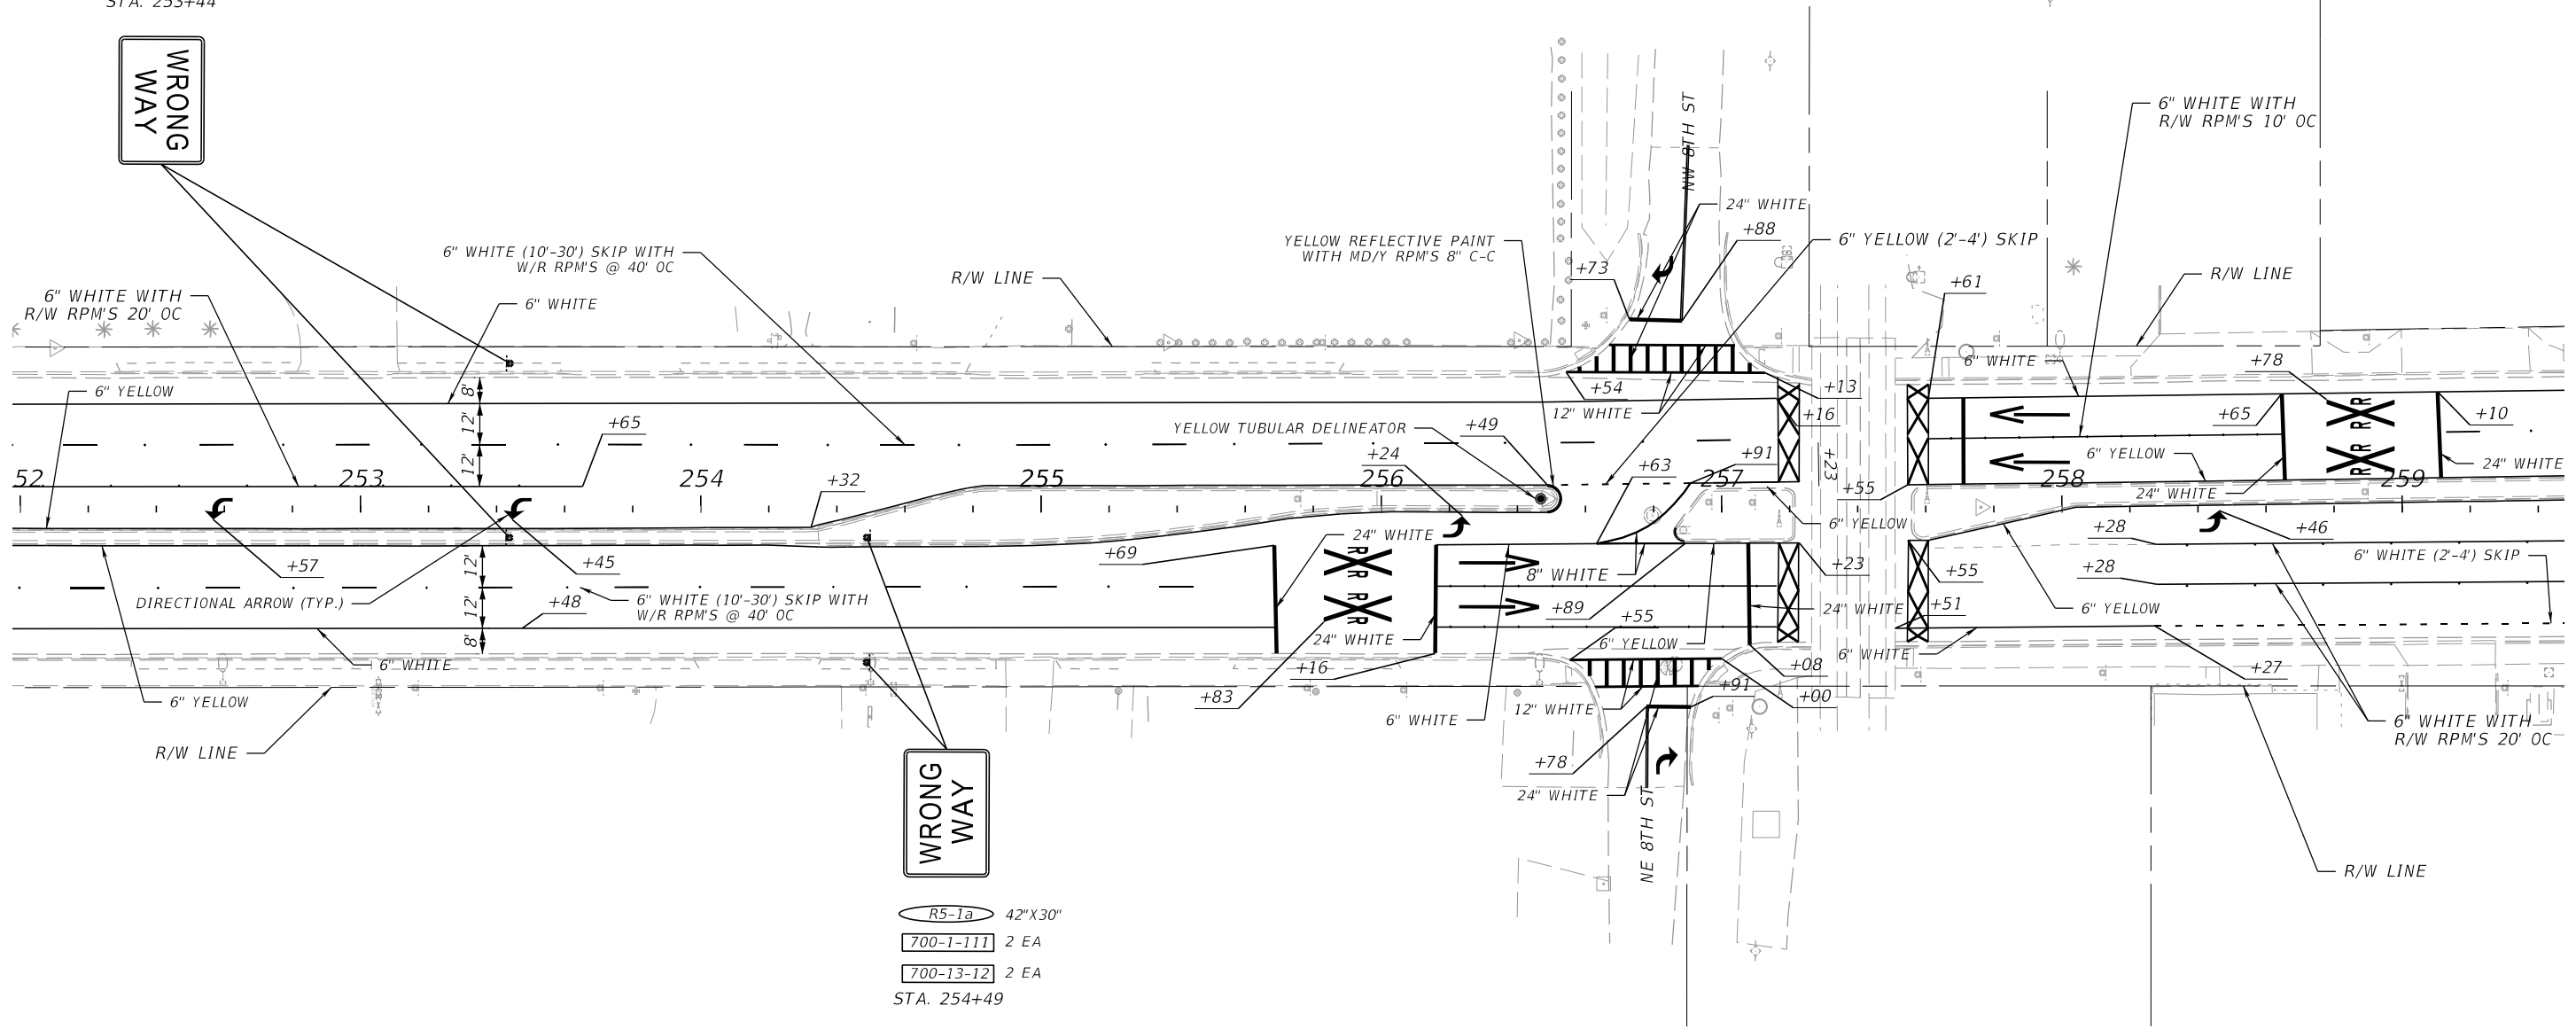


R5-1a 42"X30"  
 700-1-111 2 EA  
 700-13-12 2 EA  
 STA. 254+49

11/9/2023 11:58:23 AM MWADIR  
 c:\pwworking\yfkpw01\massim nadir\dms05209\PLAN\SP02.dgn

REVISIONS				ENGINEER OF RECORD			STATE OF FLORIDA DEPARTMENT OF TRANSPORTATION			SIGNING AND PAVEMENT MARKING PLAN	SHEET NO.
DATE	DESCRIPTION	DATE	DESCRIPTION	JOSE A. JARQUIN, P.E. LICENSE NUMBER: 89293 AMERICAN STRUCTUREPOINT, INC 5405 CYPRESS CENTER DR, SUITE 310 TAMPA, FL 33609			ROAD NO.	COUNTY	FINANCIAL PROJECT ID		
							SR 15	OKEECHOBEE	448974-1-52-01		S-4

THE OFFICIAL RECORD OF THIS SHEET IS THE ELECTRONIC FILE DIGITALLY SIGNED AND SEALED UNDER RULE 61G15-23.004, F.A.C.

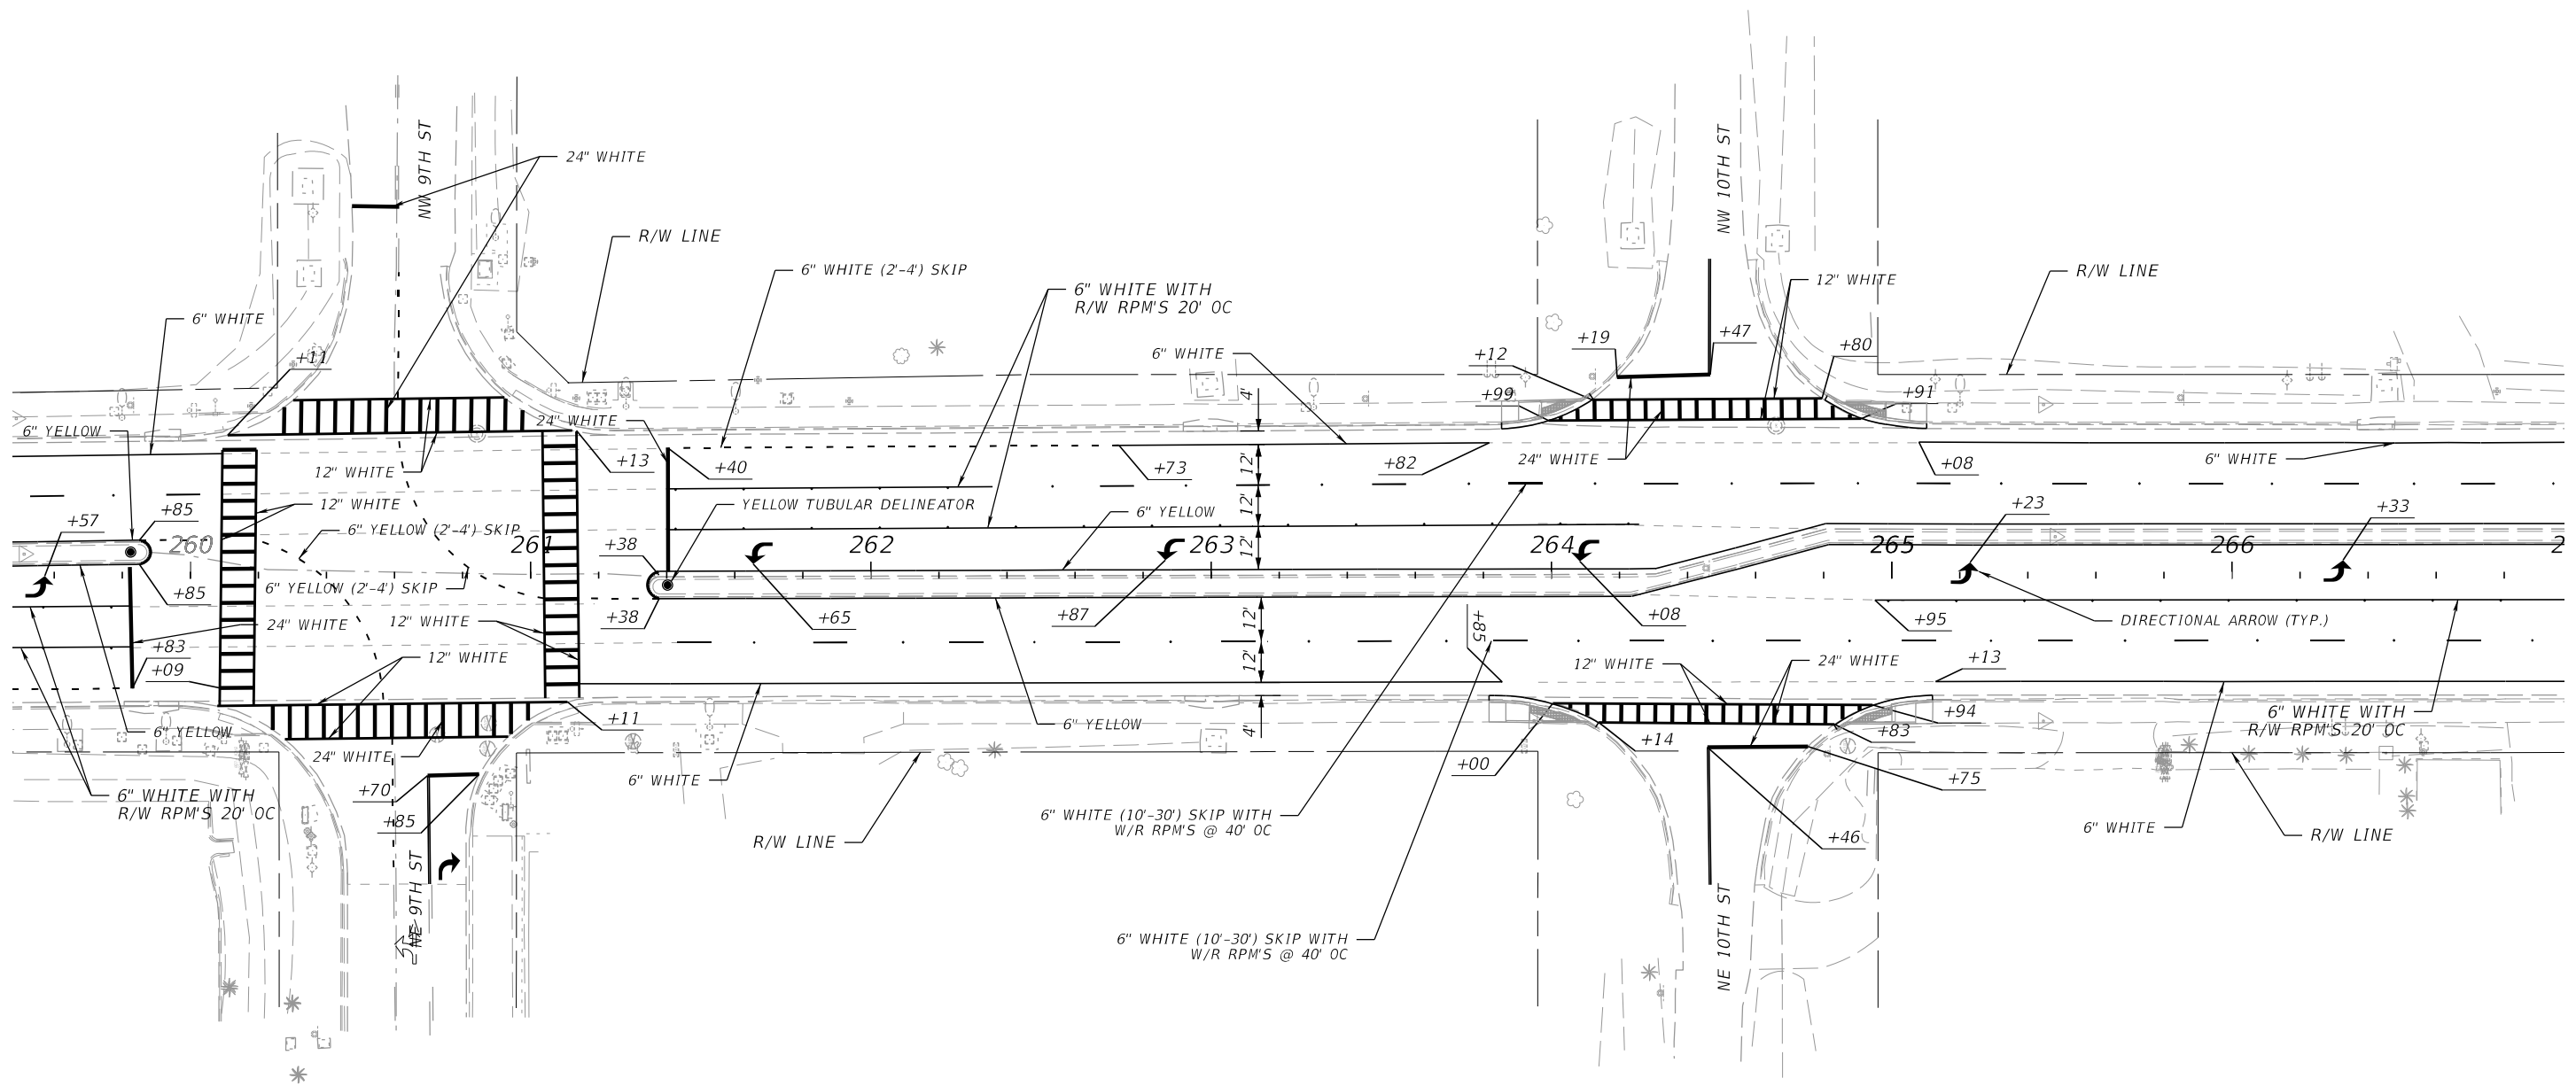
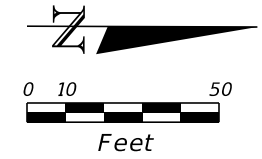


11/9/2023 11:58:26 AM MNADIR  
 c:\pwworking\ykp\p01\massim\adir\dms05209\PLAN\SP02.dgn

REVISIONS				ENGINEER OF RECORD			STATE OF FLORIDA DEPARTMENT OF TRANSPORTATION			SHEET NO.
DATE	DESCRIPTION	DATE	DESCRIPTION	JOSE A. JARQUIN, P.E. LICENSE NUMBER: 89293 AMERICAN STRUCTUREPOINT, INC 5405 CYPRESS CENTER DR, SUITE 310 TAMPA, FL 33609			ROAD NO.	COUNTY	FINANCIAL PROJECT ID	
							SR 15	OKEECHOBEE	448974-1-52-01	

**SIGNING AND PAVEMENT  
MARKING PLAN**

THE OFFICIAL RECORD OF THIS SHEET IS THE ELECTRONIC FILE DIGITALLY SIGNED AND SEALED UNDER RULE 61G15-23.004, F.A.C.

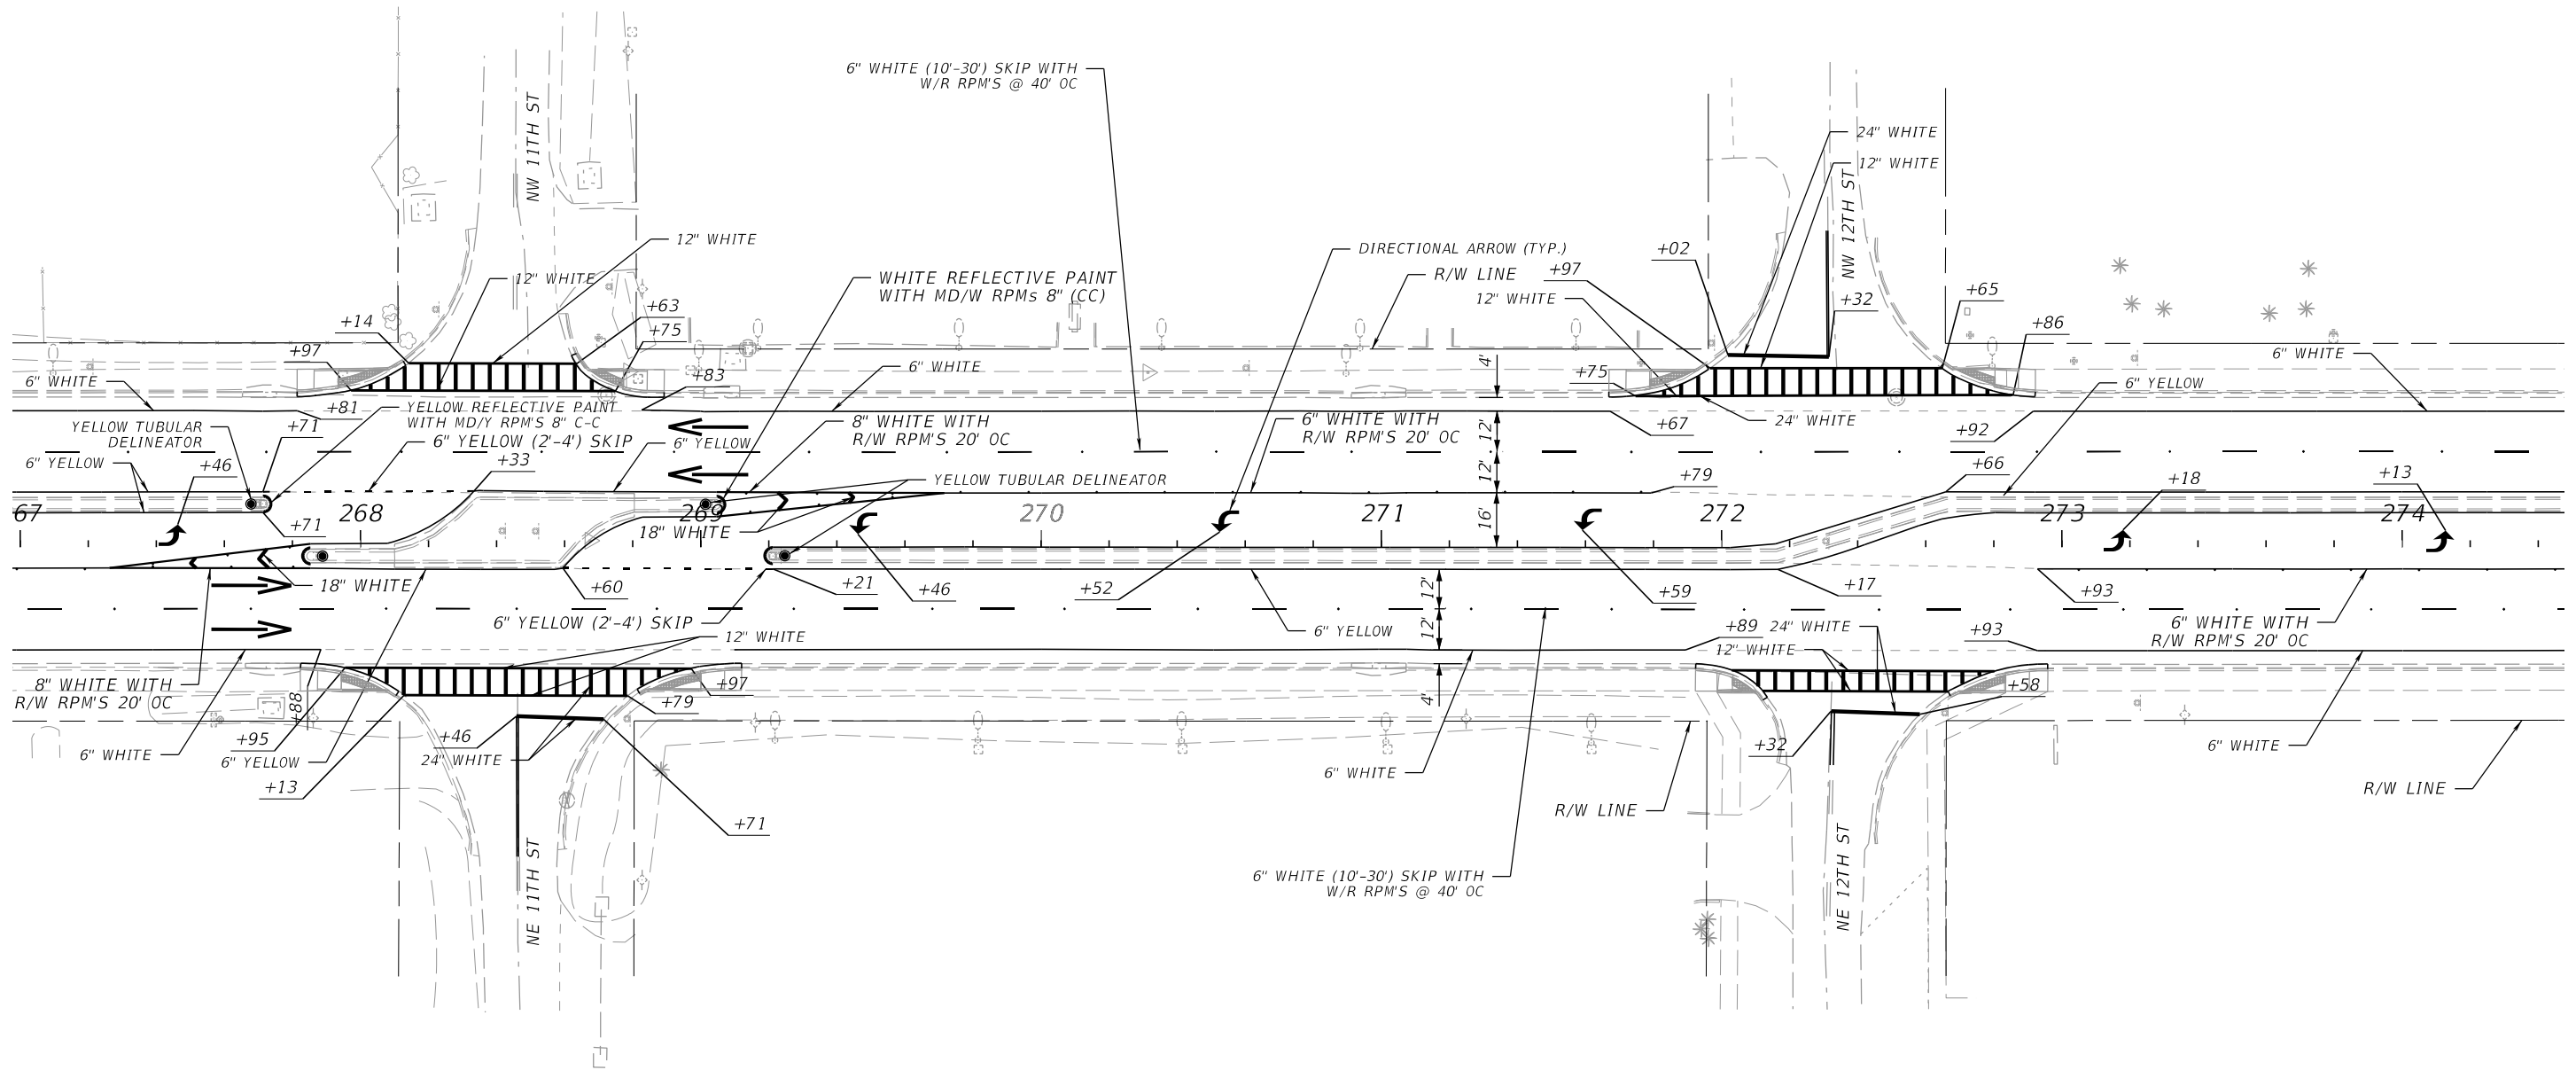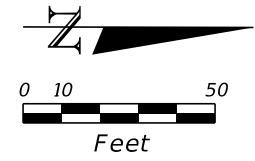

11/9/2023 11:58:29 AM MNADIR  
 c:\pwworking\ykkpw01\nassim\adir\dms05209\PLAN\SP02.dgn

REVISIONS			
DATE	DESCRIPTION	DATE	DESCRIPTION



**ENGINEER OF RECORD**  
 JOSE A. JARQUIN, P.E.  
 LICENSE NUMBER: 89293  
 AMERICAN STRUCTUREPOINT, INC  
 5405 CYPRESS CENTER DR, SUITE 310  
 TAMPA, FL 33609

STATE OF FLORIDA DEPARTMENT OF TRANSPORTATION		
ROAD NO.	COUNTY	FINANCIAL PROJECT ID
SR 15	OKEECHOBEE	448974-1-52-01

**SIGNING AND PAVEMENT  
MARKING PLAN**

**SHEET NO.**  
 5-6

THE OFFICIAL RECORD OF THIS SHEET IS THE ELECTRONIC FILE DIGITALLY SIGNED AND SEALED UNDER RULE 61G15-23.004, F.A.C.

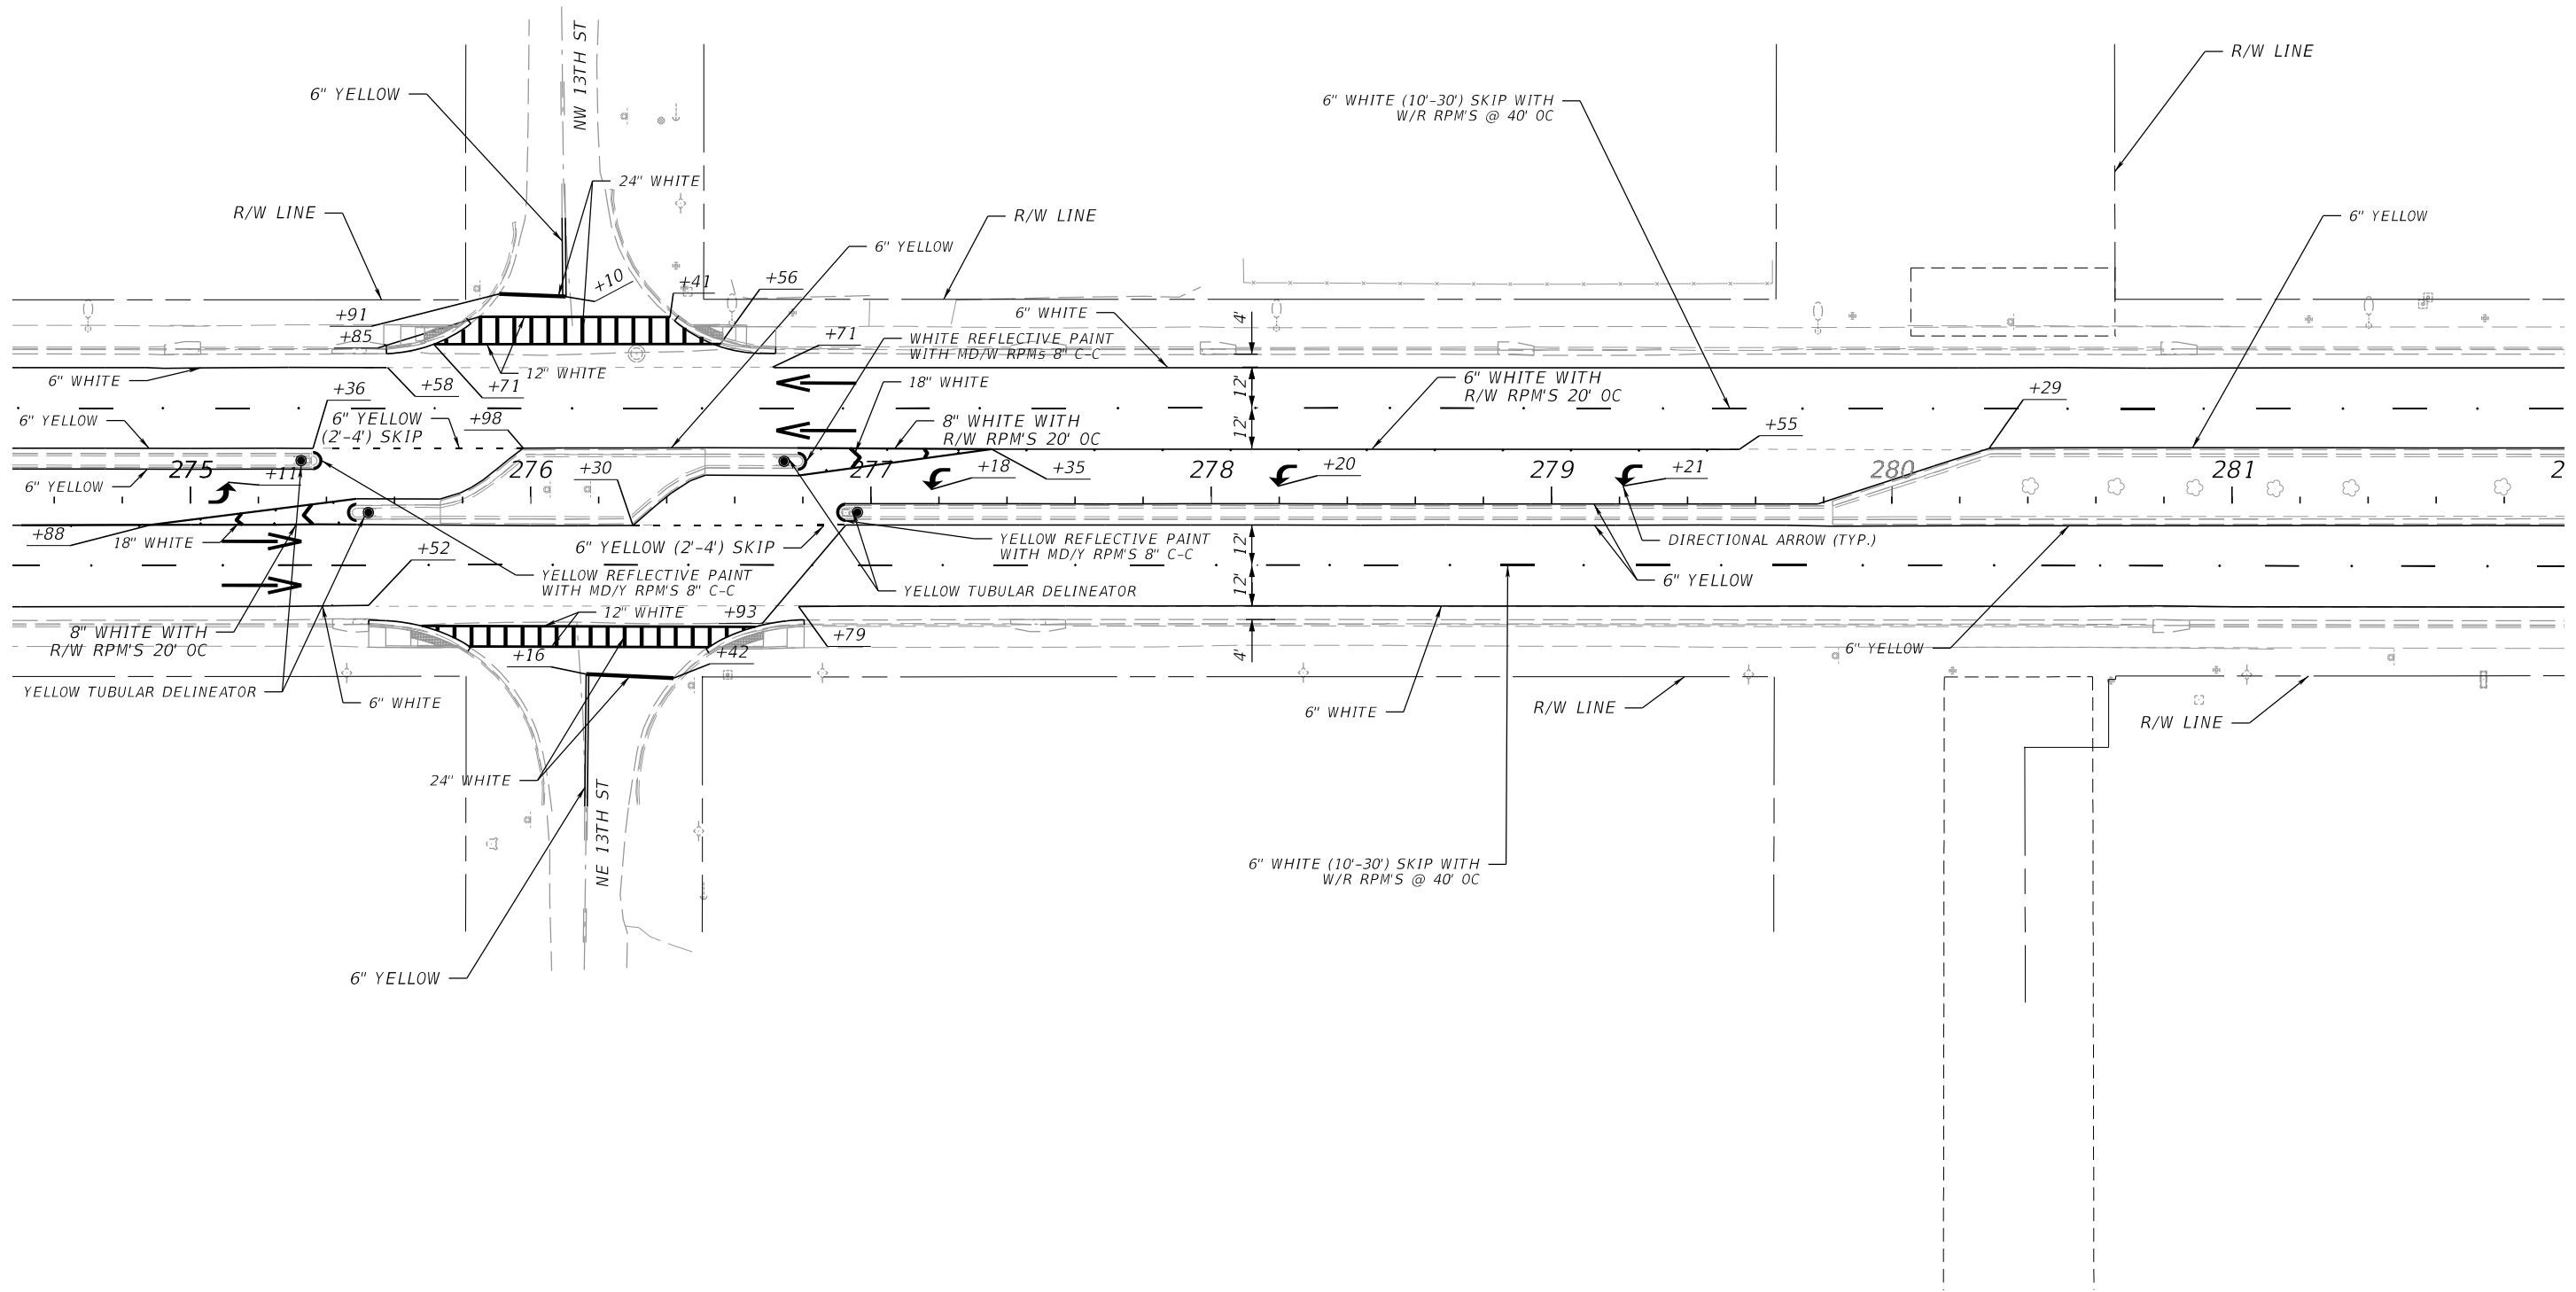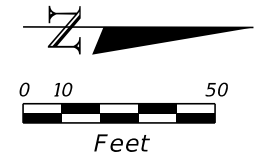

11/9/2023 11:58:31 AM MWADIR  
 c:\pwworking\ykkpw01\massim nadir\dms05209\PLAN\SP02.dgn

REVISIONS			
DATE	DESCRIPTION	DATE	DESCRIPTION

**ENGINEER OF RECORD**  
 JOSE A. JARQUIN, P.E.  
 LICENSE NUMBER: 89293  
 AMERICAN STRUCTUREPOINT, INC  
 5405 CYPRESS CENTER DR, SUITE 310  
 TAMPA, FL 33609

STATE OF FLORIDA DEPARTMENT OF TRANSPORTATION		
ROAD NO.	COUNTY	FINANCIAL PROJECT ID
SR 15	OKEECHOBEE	448974-1-52-01


**SIGNING AND PAVEMENT  
MARKING PLAN**

**SHEET NO.**  
 5-7


THE OFFICIAL RECORD OF THIS SHEET IS THE ELECTRONIC FILE DIGITALLY SIGNED AND SEALED UNDER RULE 61G15-23.004, F.A.C.





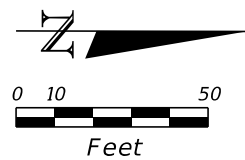



- R5-1a 42"X30"
  - 700-1-111 2 EA
  - 700-13-12 2 EA
- STA. 290+30

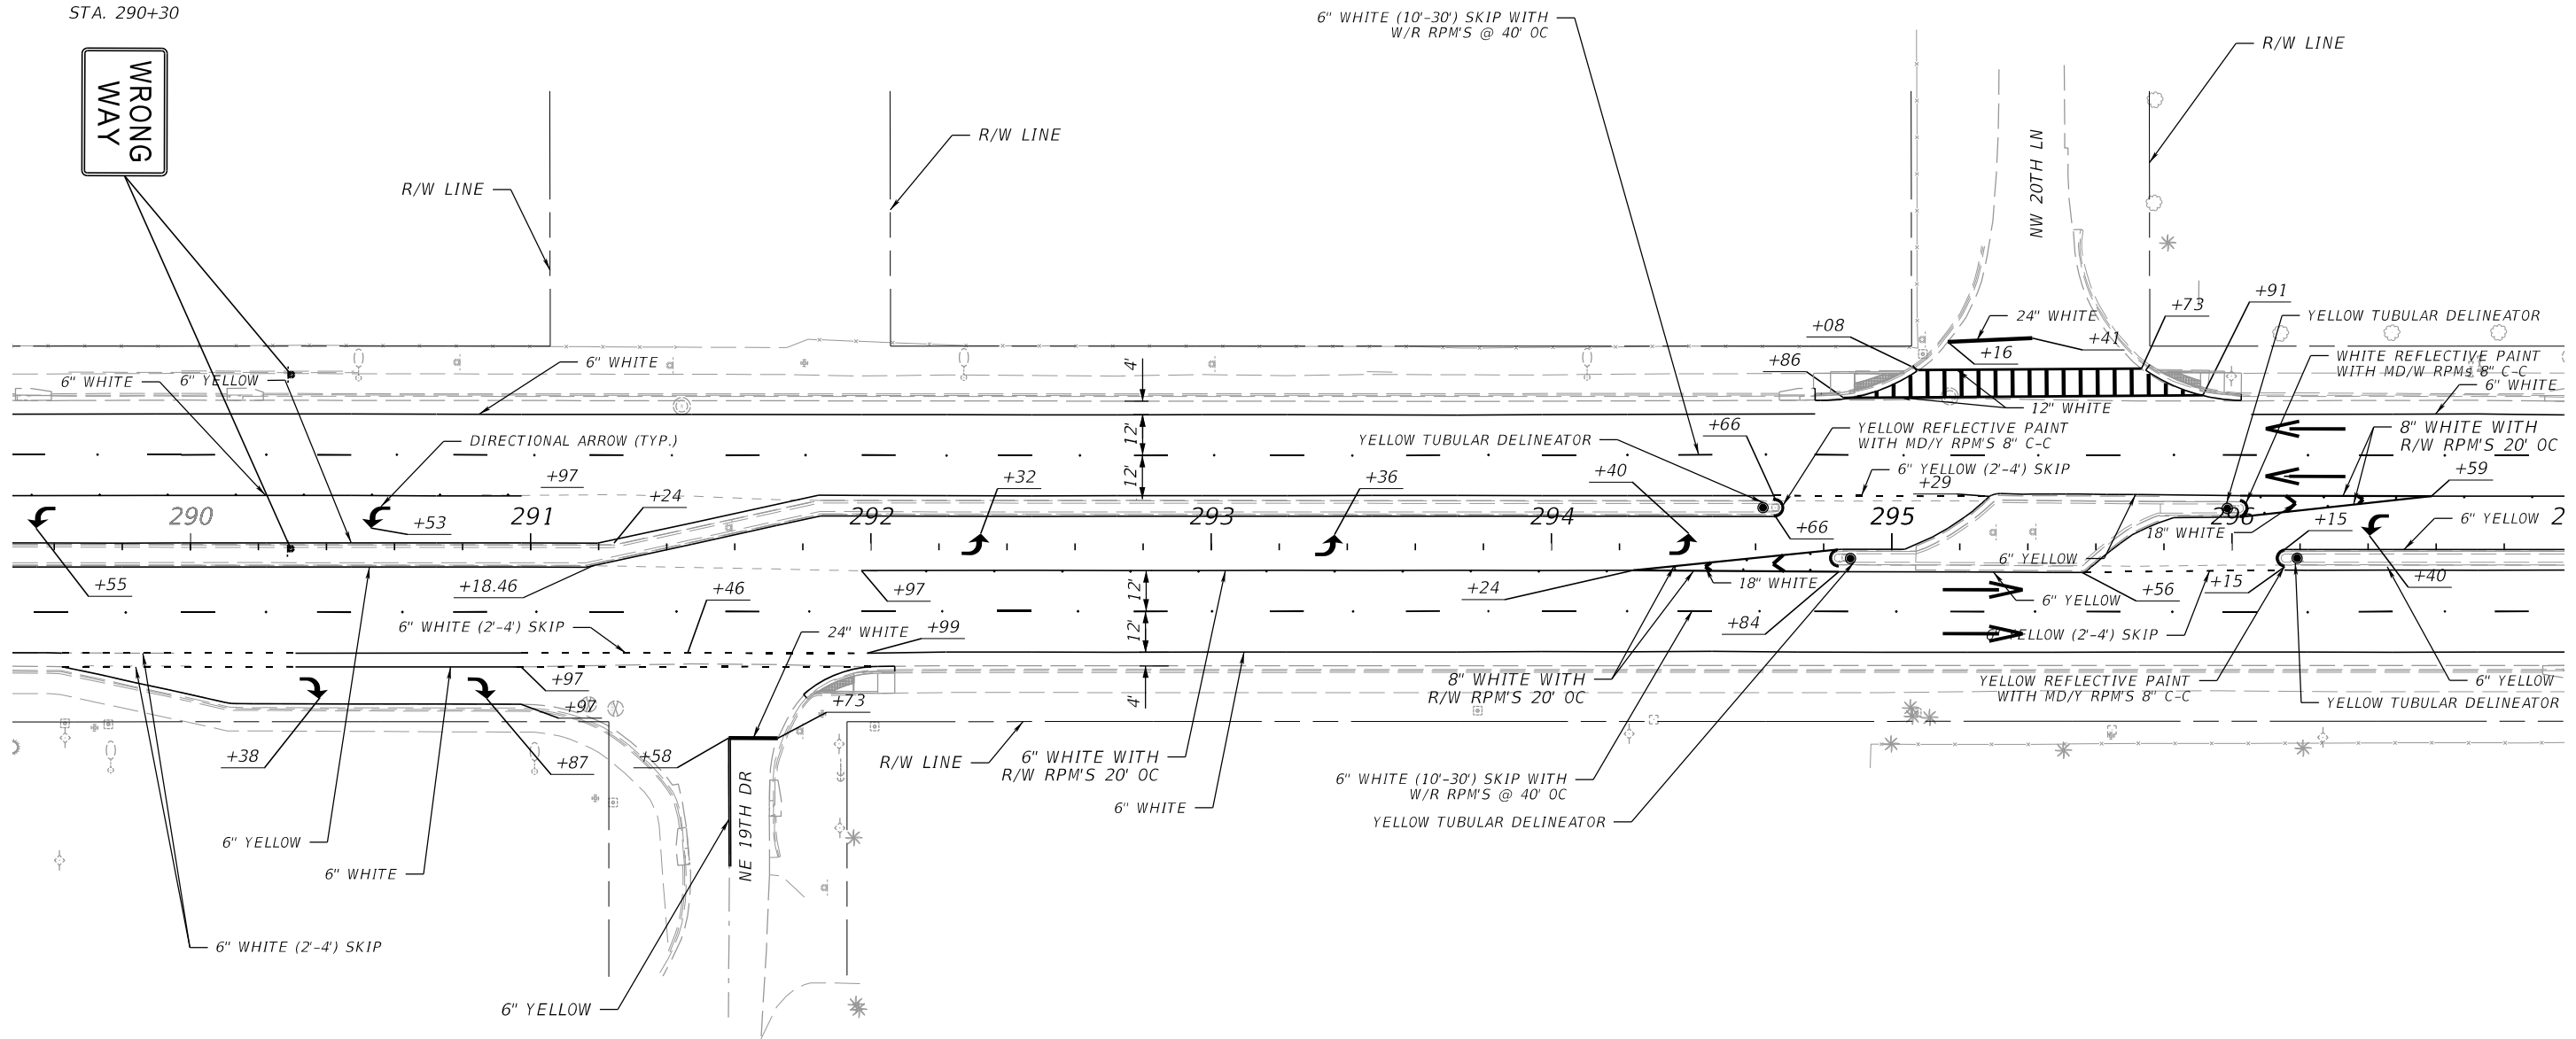

11/9/2023 11:58:37 AM MNADIR c:\pwworking\kkipw01\massim nadir\dms05209\PLAN\SP02.dgn

REVISIONS				ENGINEER OF RECORD		STATE OF FLORIDA DEPARTMENT OF TRANSPORTATION			<b>SIGNING AND PAVEMENT MARKING PLAN</b>	SHEET NO.
DATE	DESCRIPTION	DATE	DESCRIPTION	JOSE A. JARQUIN, P.E. LICENSE NUMBER: 89293 AMERICAN STRUCTUREPOINT, INC 5405 CYPRESS CENTER DR, SUITE 310 TAMPA, FL 33609		ROAD NO.	COUNTY	FINANCIAL PROJECT ID		5-9
								SR 15		

THE OFFICIAL RECORD OF THIS SHEET IS THE ELECTRONIC FILE DIGITALLY SIGNED AND SEALED UNDER RULE 61G15-23.004, F.A.C.

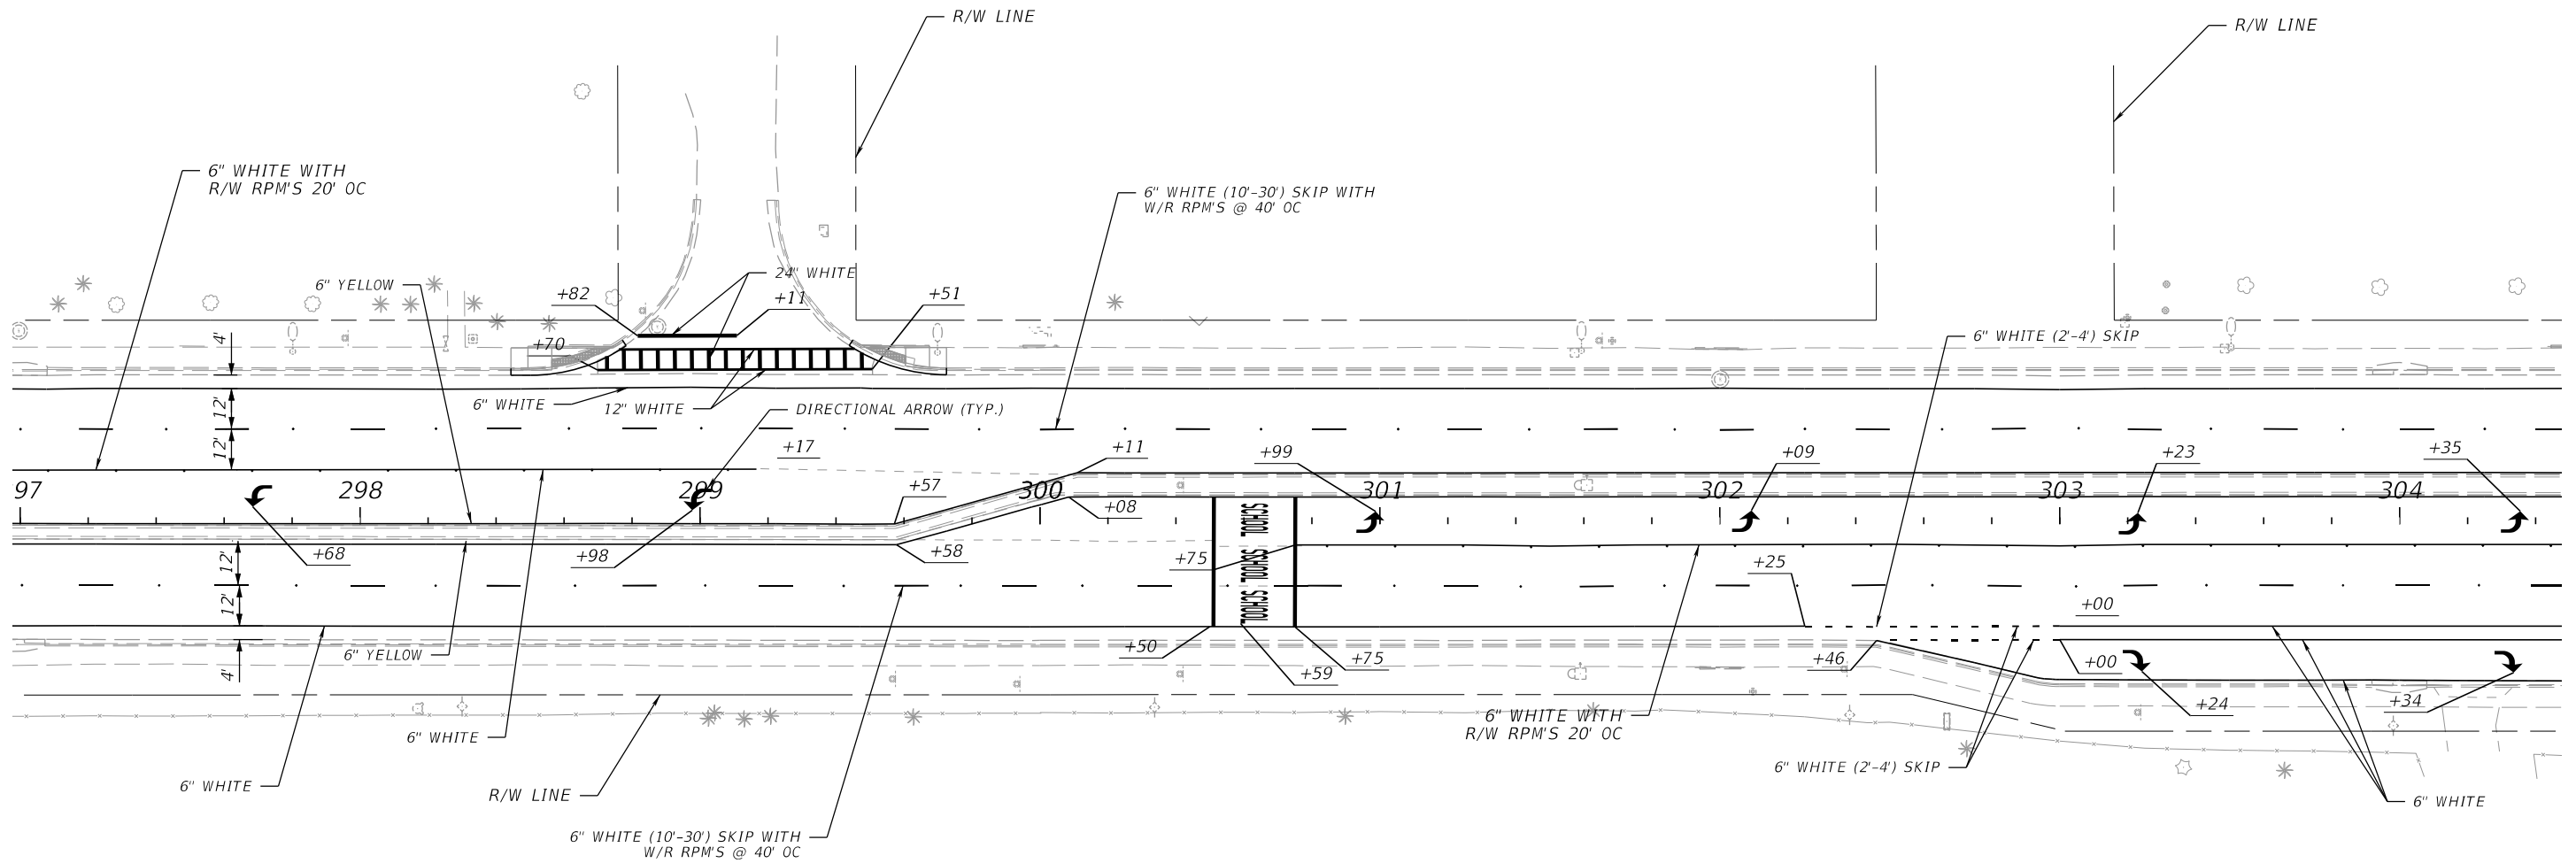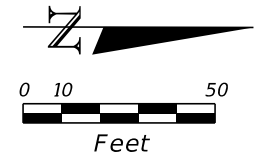

11/9/2023 11:58:40 AM MNADIR  
 c:\pwworking\kpkpw01\nadim\adim\05209\PLAN\SP02.dgn

REVISIONS			
DATE	DESCRIPTION	DATE	DESCRIPTION



**ENGINEER OF RECORD**  
 JOSE A. JARQUIN, P.E.  
 LICENSE NUMBER: 89293  
 AMERICAN STRUCTUREPOINT, INC  
 5405 CYPRESS CENTER DR, SUITE 310  
 TAMPA, FL 33609

STATE OF FLORIDA DEPARTMENT OF TRANSPORTATION		
ROAD NO.	COUNTY	FINANCIAL PROJECT ID
SR 15	OKEECHOBEE	448974-1-52-01

**SIGNING AND PAVEMENT  
MARKING PLAN**

SHEET  
NO.  
  
S-10

THE OFFICIAL RECORD OF THIS SHEET IS THE ELECTRONIC FILE DIGITALLY SIGNED AND SEALED UNDER RULE 61G15-23.004, F.A.C.

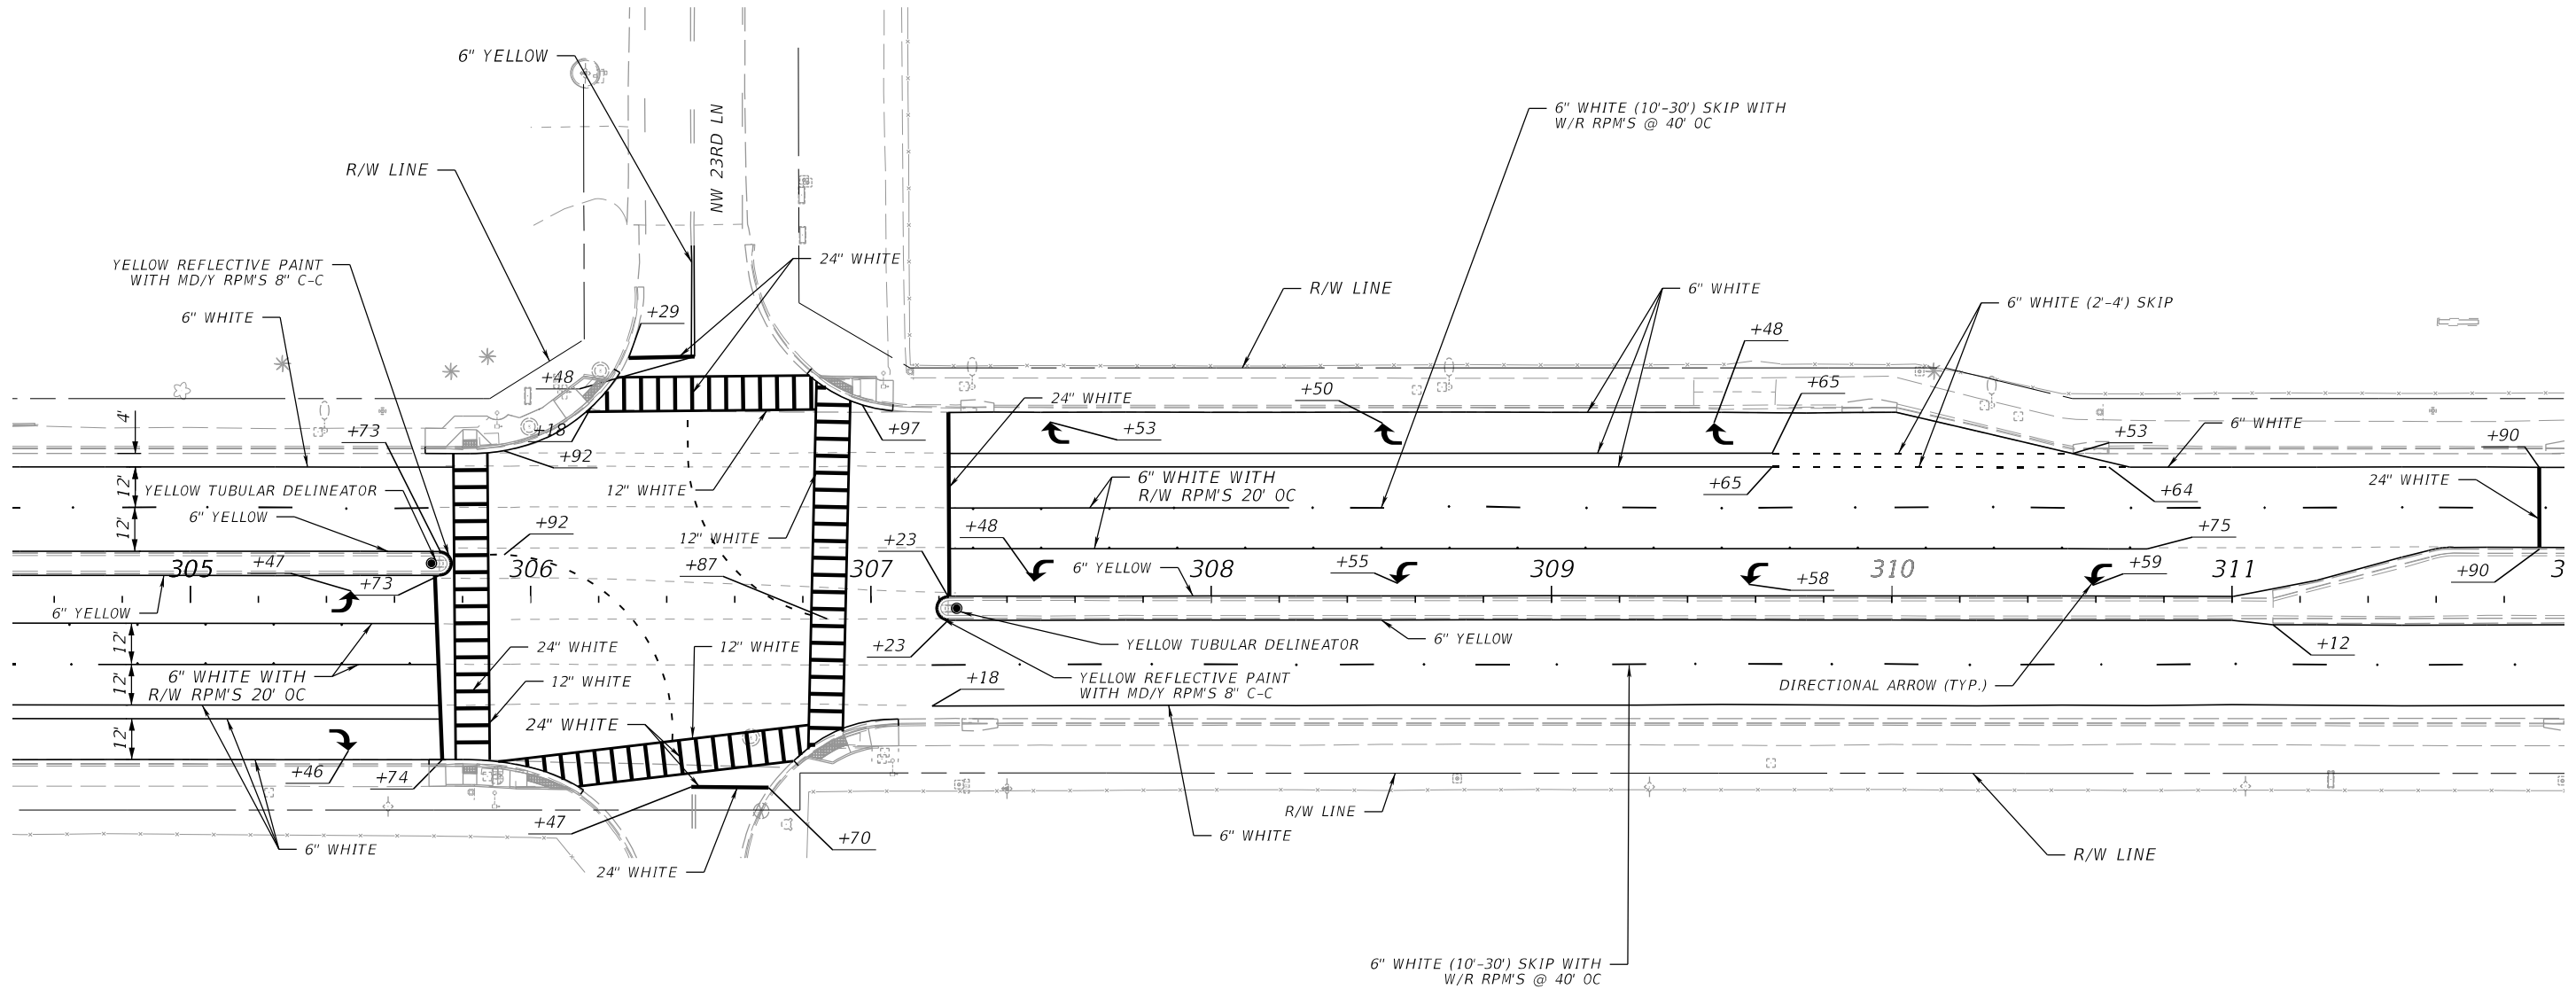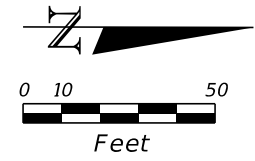

11/9/2023 11:58:43 AM MNADIR  
 c:\pwworking\yfk\p01\massim\adir\dms05209\PLAN\SP02.dgn

REVISIONS			
DATE	DESCRIPTION	DATE	DESCRIPTION



**ENGINEER OF RECORD**  
 JOSE A. JARQUIN, P.E.  
 LICENSE NUMBER: 89293  
 AMERICAN STRUCTUREPOINT, INC  
 5405 CYPRESS CENTER DR, SUITE 310  
 TAMPA, FL 33609

STATE OF FLORIDA DEPARTMENT OF TRANSPORTATION		
ROAD NO.	COUNTY	FINANCIAL PROJECT ID
SR 15	OKEECHOBEE	448974-1-52-01

**SIGNING AND PAVEMENT  
MARKING PLAN**

**SHEET NO.**  
 S-11

THE OFFICIAL RECORD OF THIS SHEET IS THE ELECTRONIC FILE DIGITALLY SIGNED AND SEALED UNDER RULE 61G15-23.004, F.A.C.

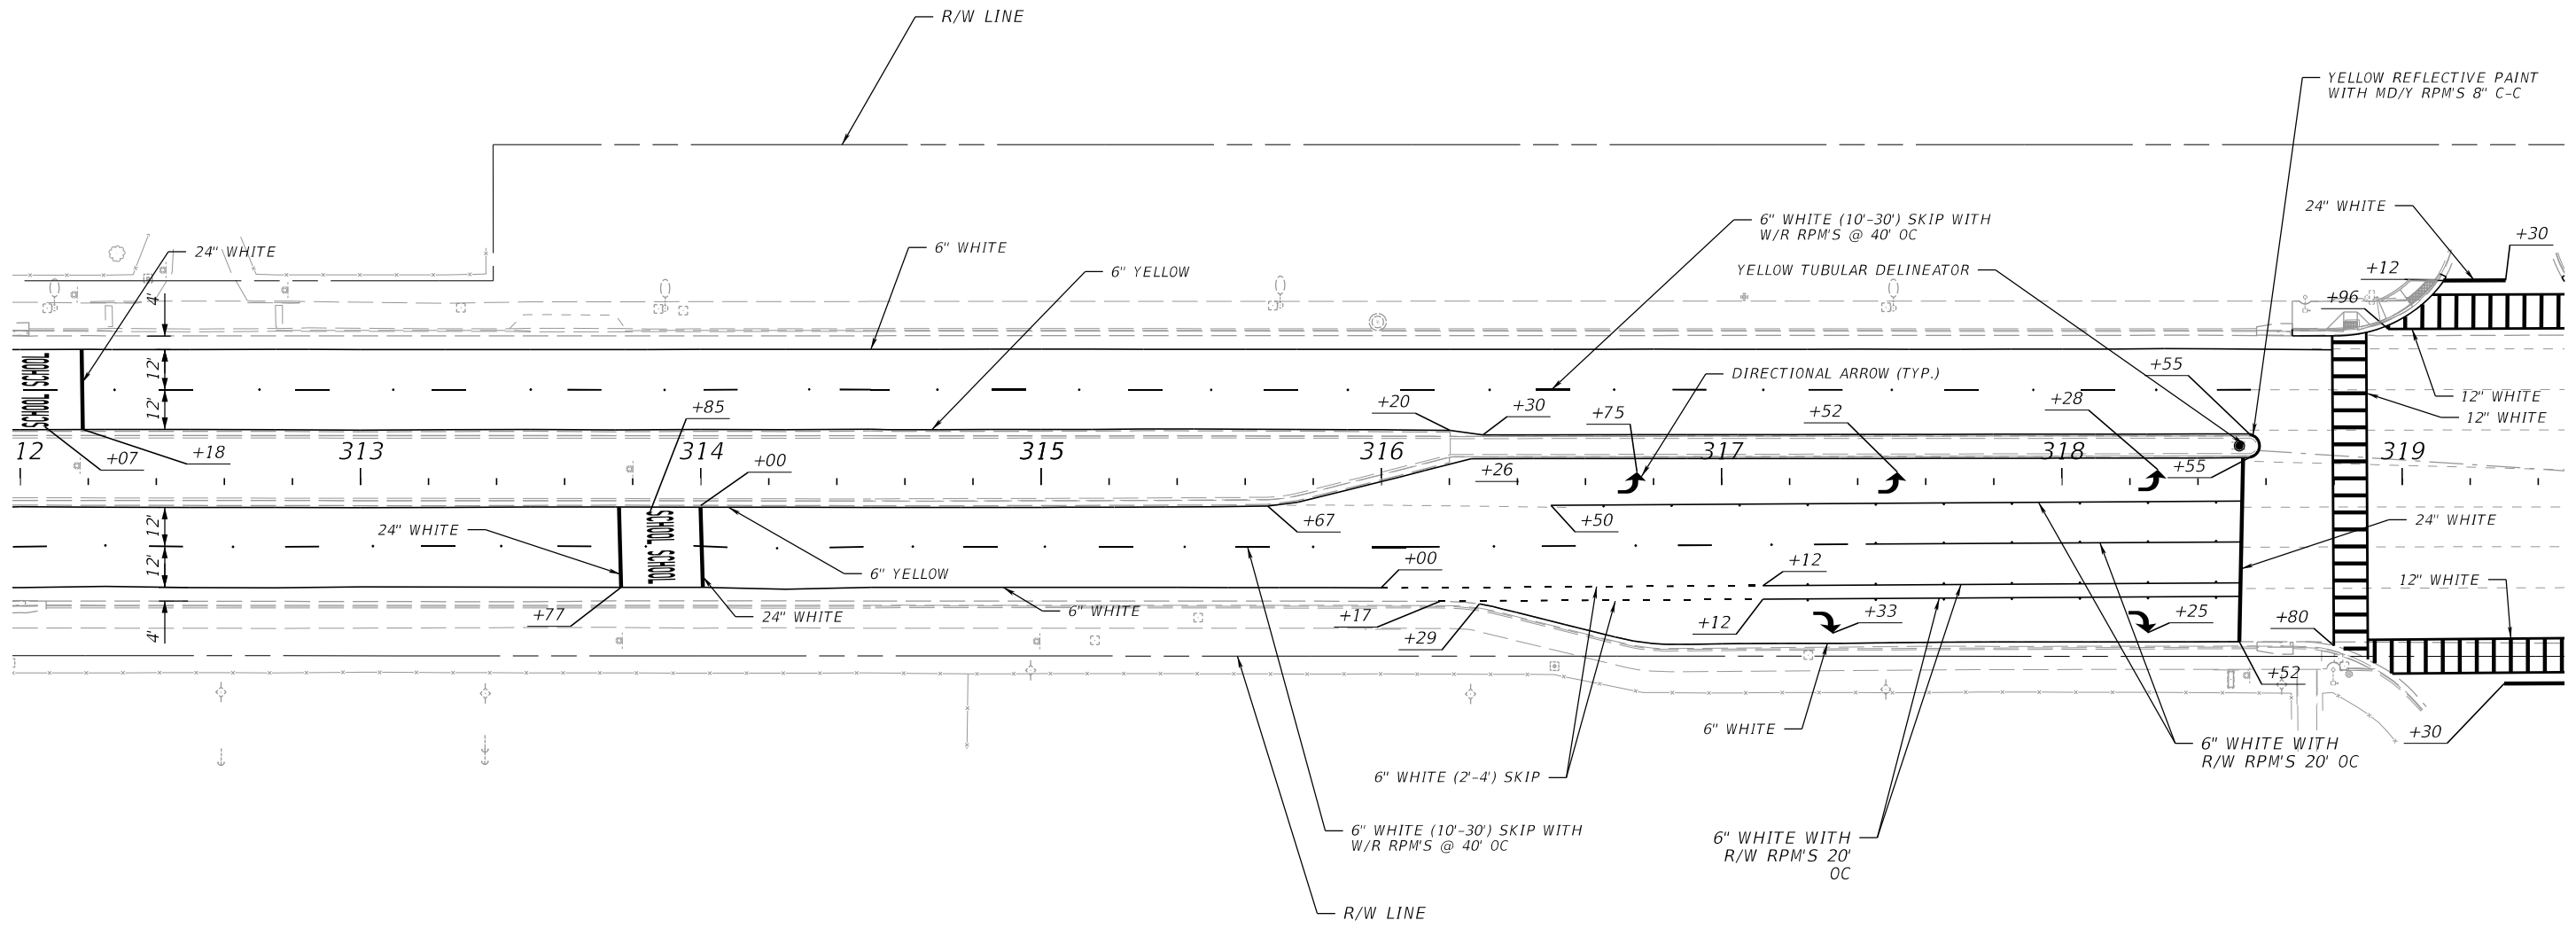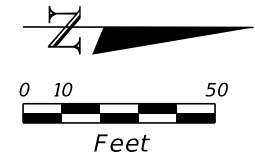

11/9/2023 11:58:46 AM MWADIR  
 c:\pwworking\kkipw01\massim nadir\dms05209\PLAN\SP02.dgn

REVISIONS			
DATE	DESCRIPTION	DATE	DESCRIPTION



**ENGINEER OF RECORD**  
 JOSE A. JARQUIN, P.E.  
 LICENSE NUMBER: 89293  
 AMERICAN STRUCTUREPOINT, INC  
 5405 CYPRESS CENTER DR, SUITE 310  
 TAMPA, FL 33609

STATE OF FLORIDA DEPARTMENT OF TRANSPORTATION		
ROAD NO.	COUNTY	FINANCIAL PROJECT ID
SR 15	OKEECHOBEE	448974-1-52-01

**SIGNING AND PAVEMENT  
MARKING PLAN**

**SHEET NO.**  
 S-12

THE OFFICIAL RECORD OF THIS SHEET IS THE ELECTRONIC FILE DIGITALLY SIGNED AND SEALED UNDER RULE 61G15-23.004, F.A.C.

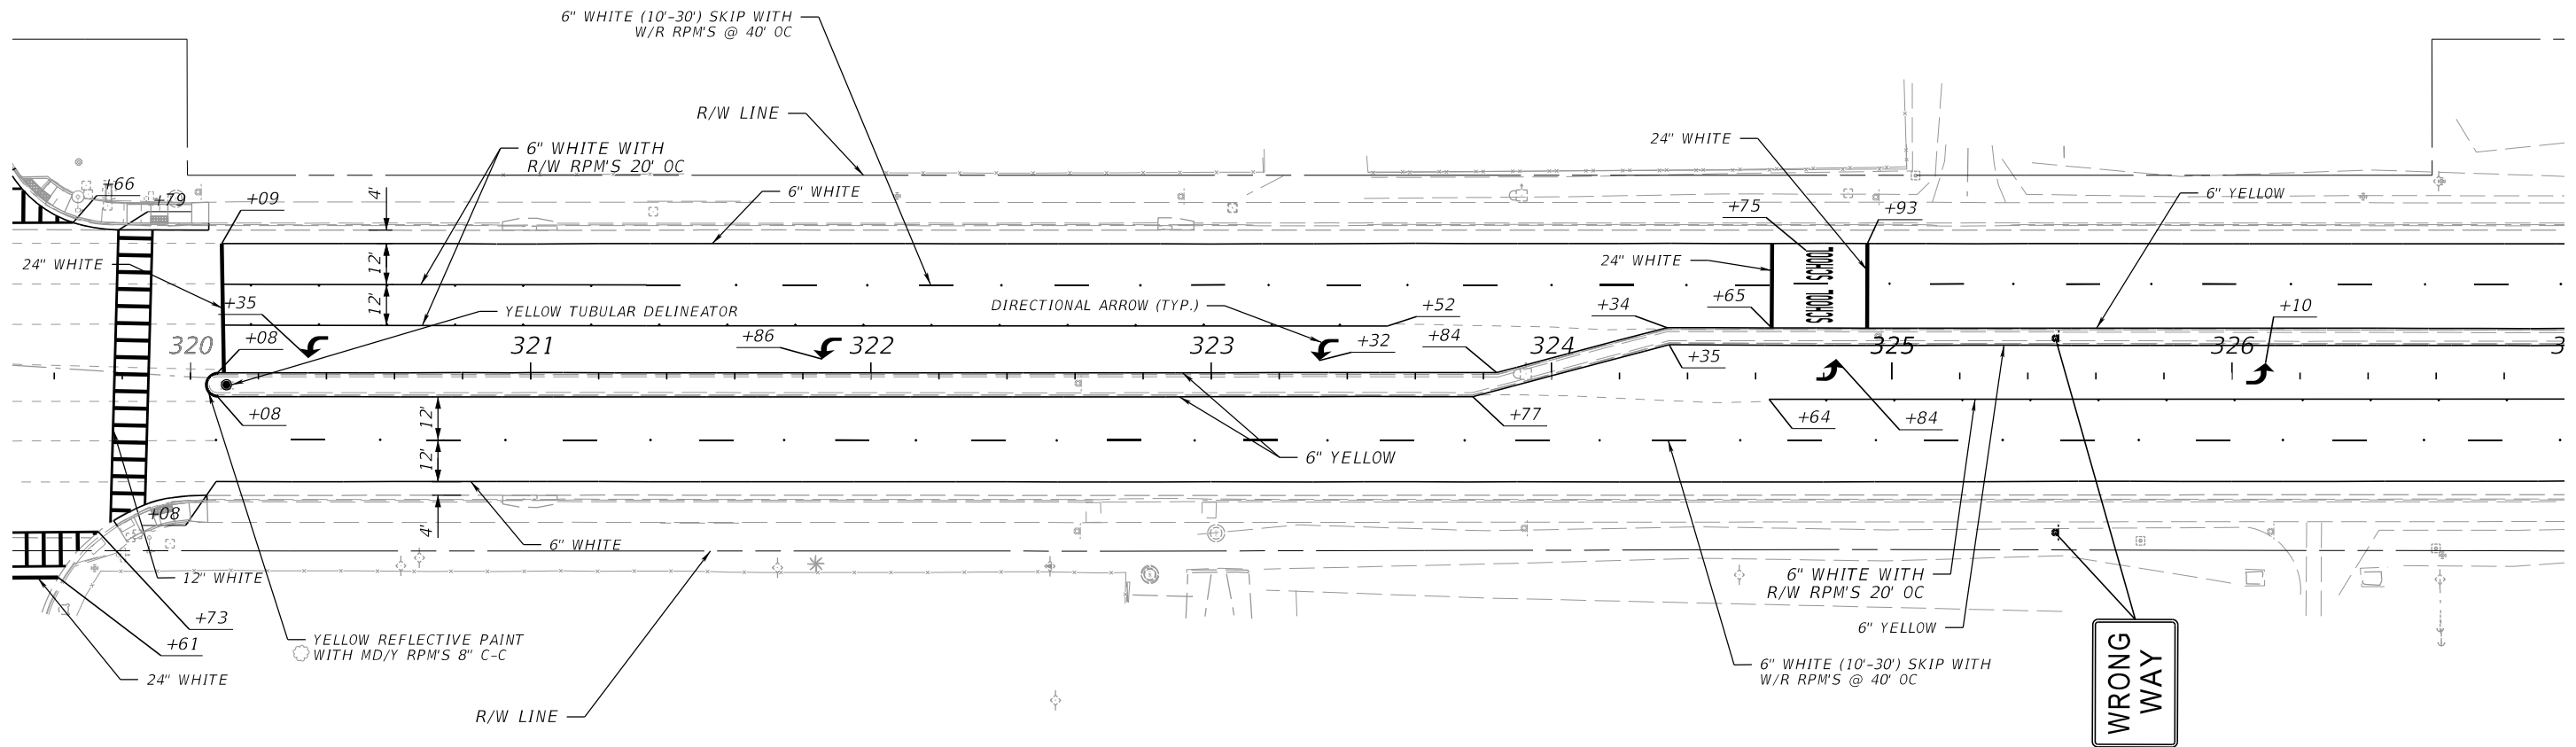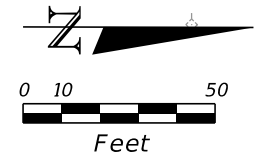


- R5-1a 42"X30"
  - 700-1-111 2 EA
  - 700-13-12 2 EA
- STA. 325+48


11/9/2023 11:58:48 AM MNADIR c:\pwworking\kpkpw01\massim nadir\dms05209\PLAN\SP02.dgn

REVISIONS				ENGINEER OF RECORD		STATE OF FLORIDA DEPARTMENT OF TRANSPORTATION			<b>SIGNING AND PAVEMENT MARKING PLAN</b>	SHEET NO.
DATE	DESCRIPTION	DATE	DESCRIPTION	JOSE A. JARQUIN, P.E. LICENSE NUMBER: 89293 AMERICAN STRUCTUREPOINT, INC 5405 CYPRESS CENTER DR, SUITE 310 TAMPA, FL 33609		ROAD NO.	COUNTY	FINANCIAL PROJECT ID		S-13
						SR 15	OKEECHOBEE	448974-1-52-01		

THE OFFICIAL RECORD OF THIS SHEET IS THE ELECTRONIC FILE DIGITALLY SIGNED AND SEALED UNDER RULE 61G15-23.004, F.A.C.

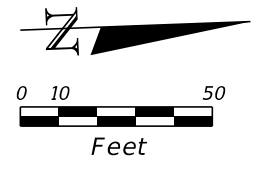

- R5-1a 42'X30'
- 700-1-111 2 EA
- 700-13-12 2 EA
- STA. 330+60

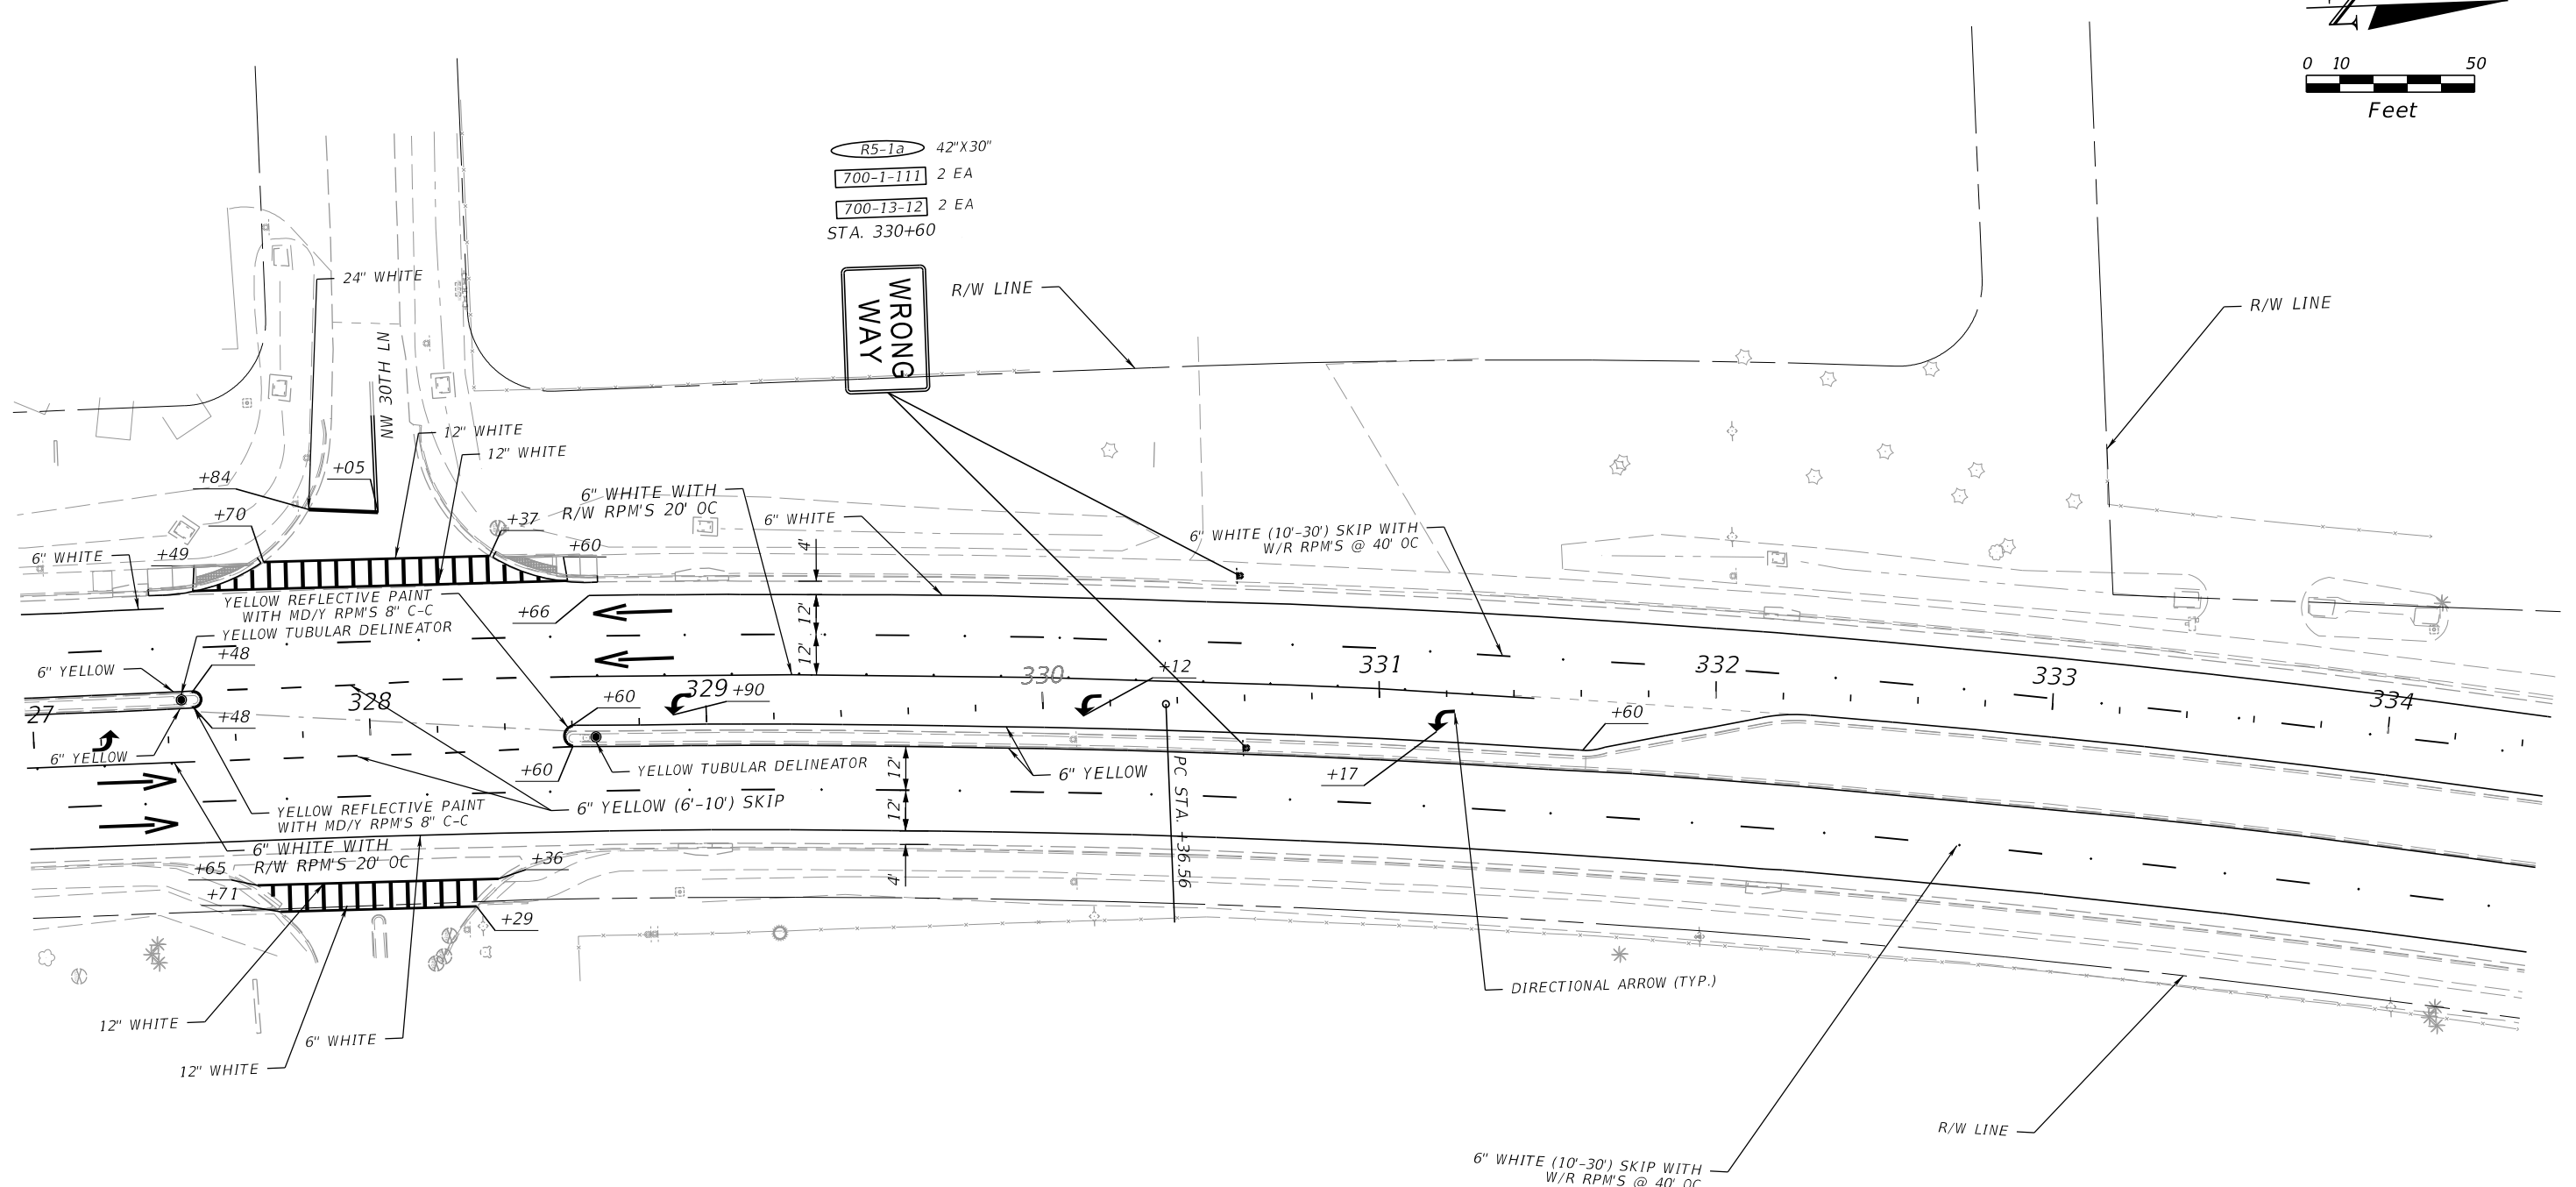

11/9/2023 11:58:51 AM MNADIR  
 c:\pwworking\kpkpw01\massim\adir\dms05209\PLAN\SP02.dgn

REVISIONS			
DATE	DESCRIPTION	DATE	DESCRIPTION



**ENGINEER OF RECORD**  
 JOSE A. JARQUIN, P.E.  
 LICENSE NUMBER: 89293  
 AMERICAN STRUCTUREPOINT, INC.  
 5405 CYPRESS CENTER DR, SUITE 310  
 TAMPA, FL 33609

STATE OF FLORIDA DEPARTMENT OF TRANSPORTATION		
ROAD NO.	COUNTY	FINANCIAL PROJECT ID
SR 15	OKEECHOBEE	448974-1-52-01

**SIGNING AND PAVEMENT  
MARKING PLAN**

SHEET NO.  
 S-14



THE OFFICIAL RECORD OF THIS SHEET IS THE ELECTRONIC FILE DIGITALLY SIGNED AND SEALED UNDER RULE 61G15-23.004, F.A.C.

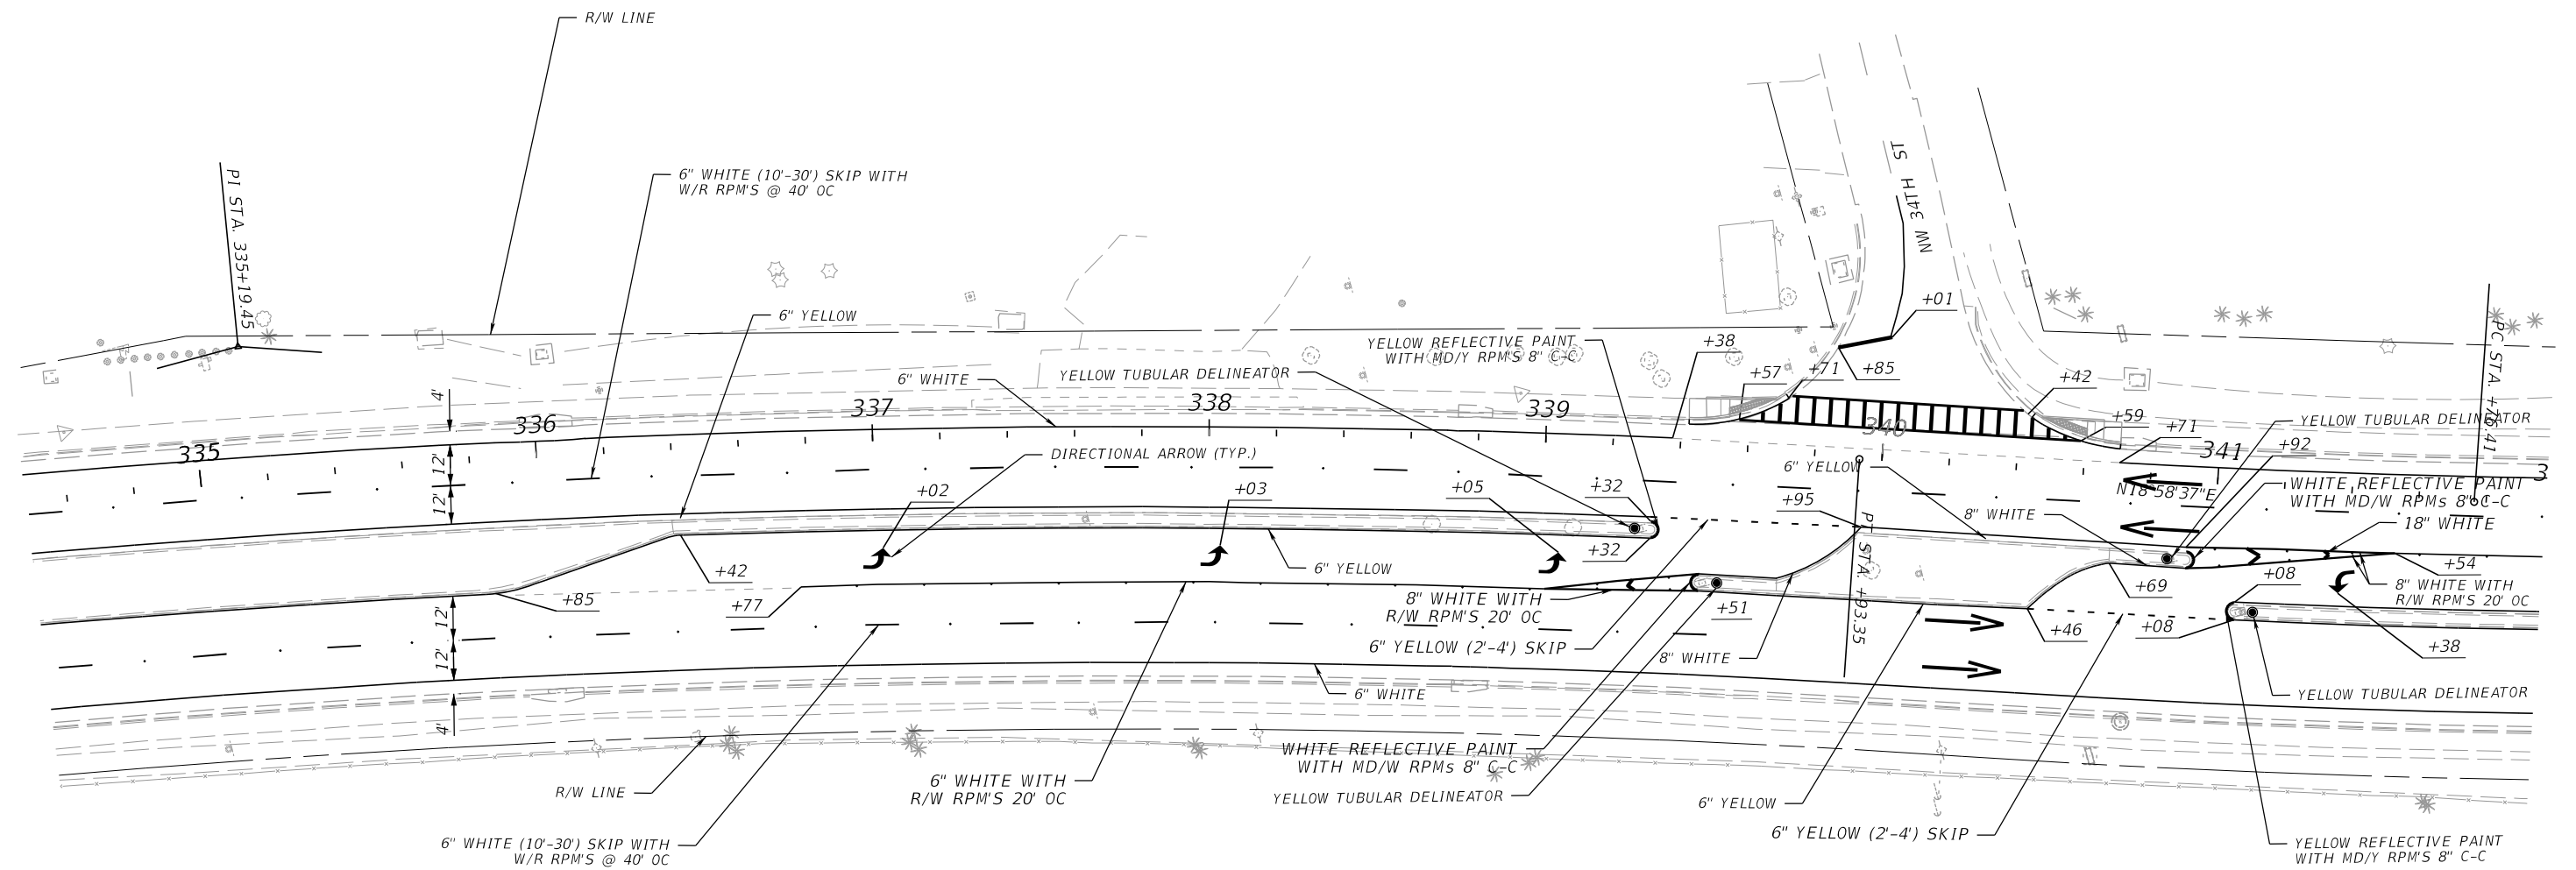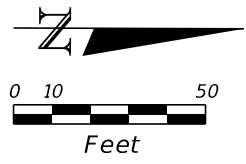

11/9/2023 11:58:54 AM MWADIR  
 c:\pwworking\ykp\p01\massim nadir\dms05209\PLAN\SP02.dgn

THE OFFICIAL RECORD OF THIS SHEET IS THE ELECTRONIC FILE DIGITALLY SIGNED AND SEALED UNDER RULE 61G15-23.004, F.A.C.

REVISIONS				ENGINEER OF RECORD		STATE OF FLORIDA DEPARTMENT OF TRANSPORTATION			SIGNING AND PAVEMENT MARKING PLAN	SHEET NO.
DATE	DESCRIPTION	DATE	DESCRIPTION	JOSE A. JARQUIN, P.E. LICENSE NUMBER: 89293 AMERICAN STRUCTUREPOINT, INC. 5405 CYPRESS CENTER DR, SUITE 310 TAMPA, FL 33609		ROAD NO.	COUNTY	FINANCIAL PROJECT ID		5-15
								SR 15		

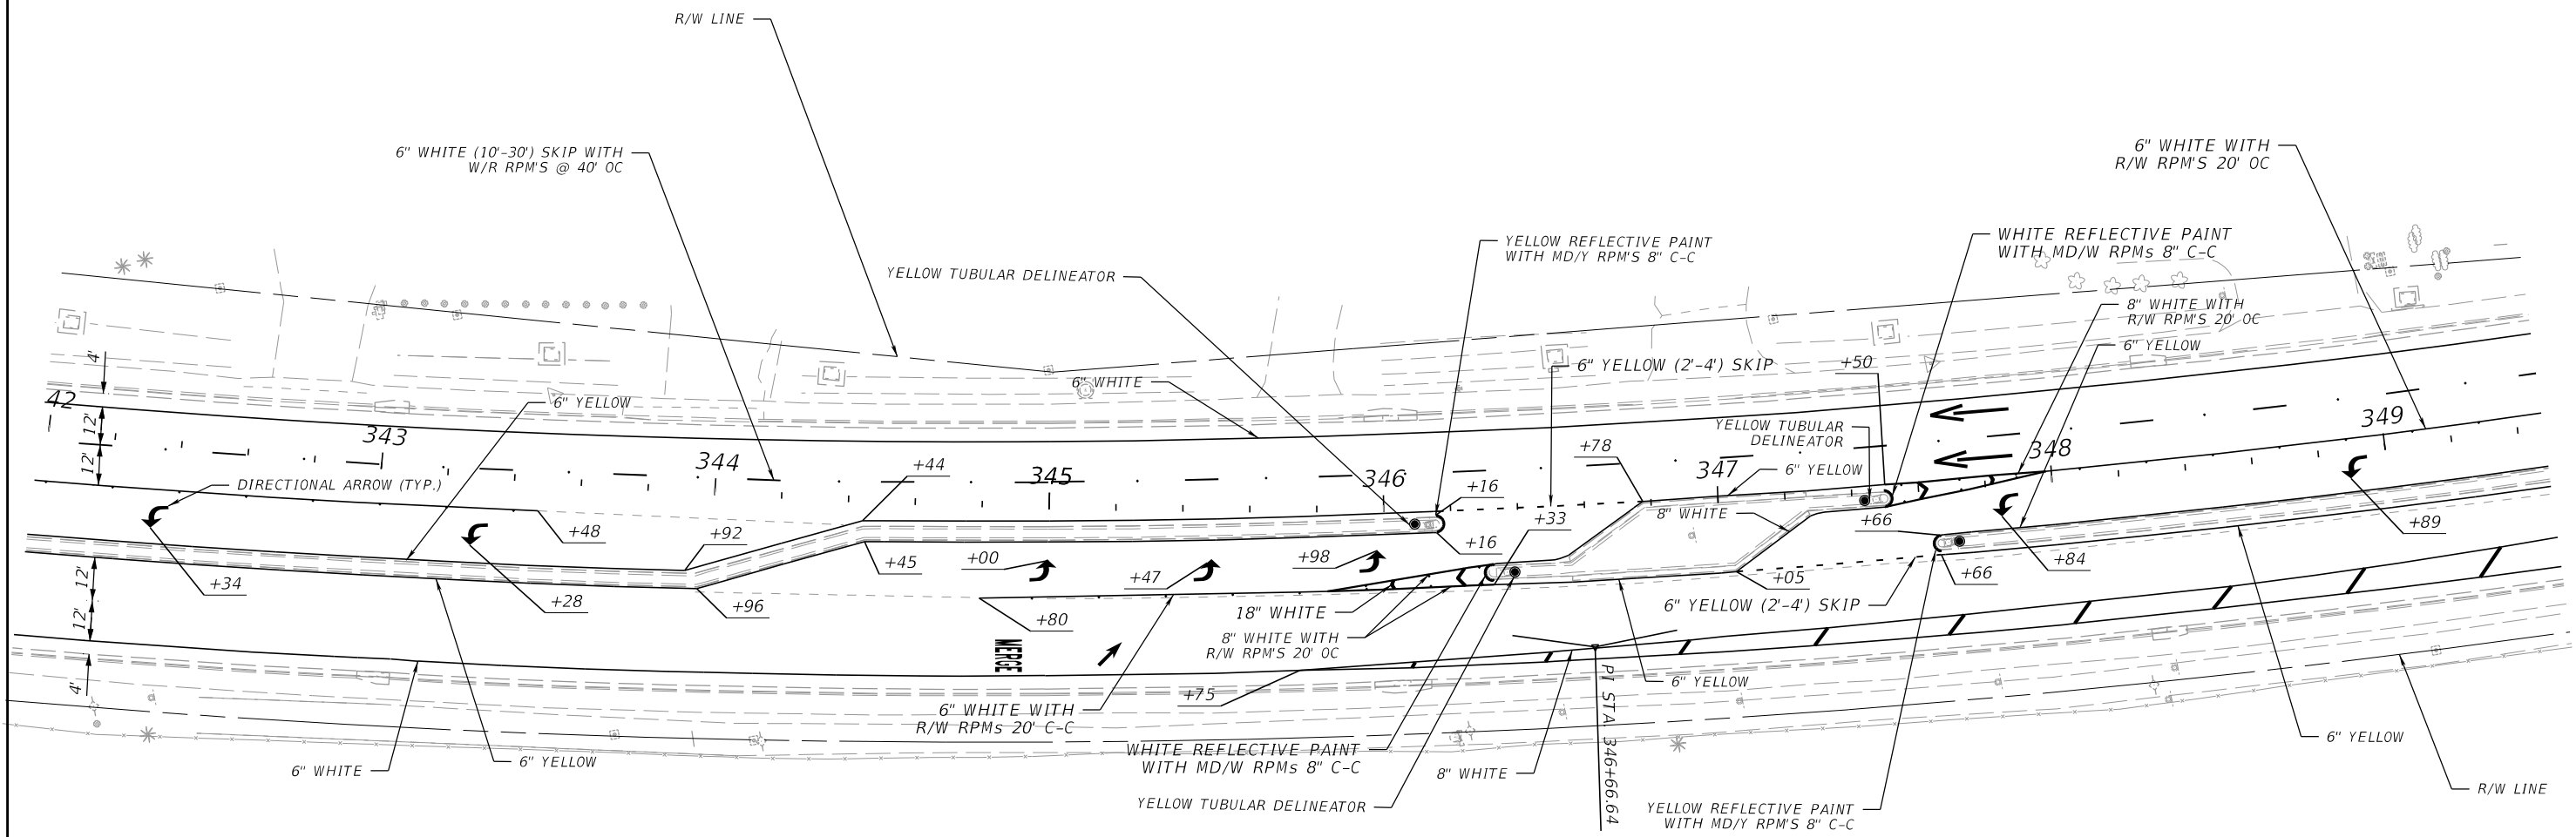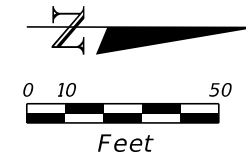



11/9/2023 11:58:57 AM MNADIR  
 c:\pwworking\yfk\p01\massim nadir\dms05209\PLAN\SP02.dgn

THE OFFICIAL RECORD OF THIS SHEET IS THE ELECTRONIC FILE DIGITALLY SIGNED AND SEALED UNDER RULE 61G15-23.004, F.A.C.

REVISIONS				ENGINEER OF RECORD		STATE OF FLORIDA DEPARTMENT OF TRANSPORTATION			SIGNING AND PAVEMENT MARKING PLAN	SHEET NO.
DATE	DESCRIPTION	DATE	DESCRIPTION			ROAD NO.	COUNTY	FINANCIAL PROJECT ID		
				JOSE A. JARQUIN, P.E. LICENSE NUMBER: 89293 AMERICAN STRUCTUREPOINT, INC. 5405 CYPRESS CENTER DR, SUITE 310 TAMPA, FL 33609		SR 15	OKEECHOBEE	448974-1-52-01		5-16





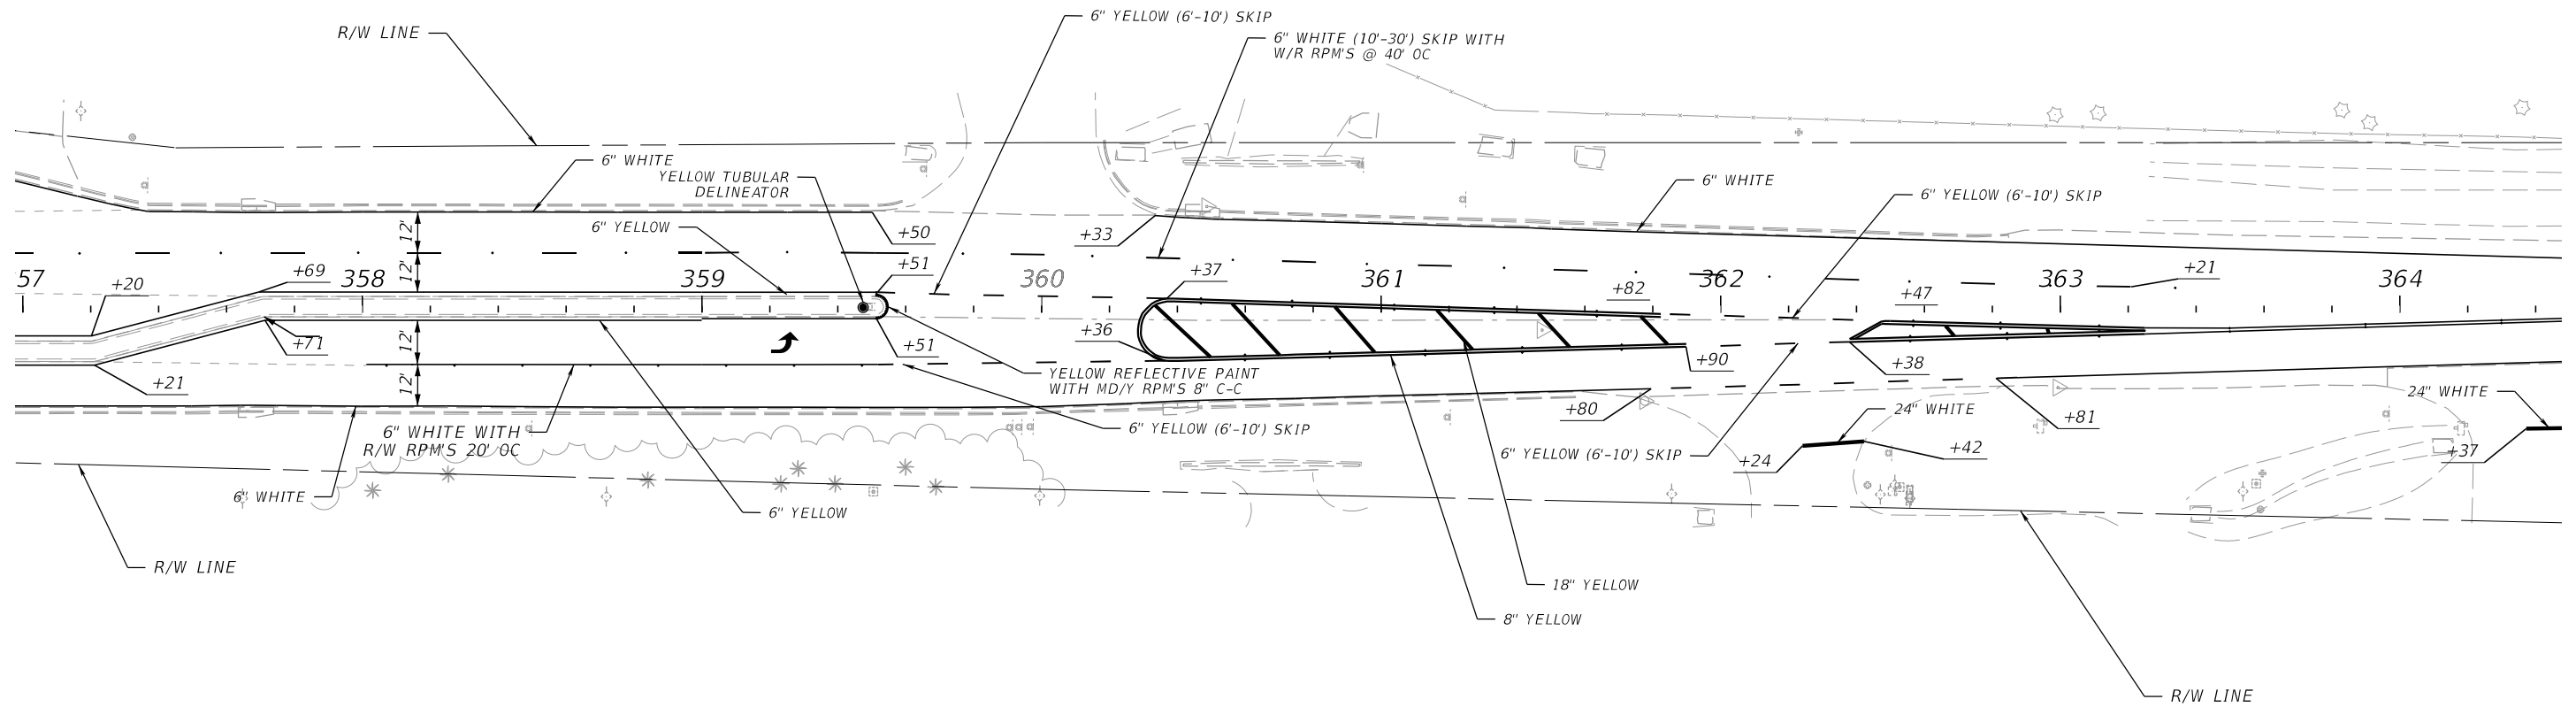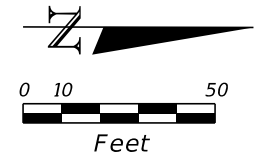

11/9/2023 11:59:03 AM MNADIR  
 c:\pwworking\ykp\p01\madsim\madr\dms05209\PLAN\SP02.dgn

REVISIONS			
DATE	DESCRIPTION	DATE	DESCRIPTION



**ENGINEER OF RECORD**  
 JOSE A. JARQUIN, P.E.  
 LICENSE NUMBER: 89293  
 AMERICAN STRUCTUREPOINT, INC.  
 5405 CYPRESS CENTER DR, SUITE 310  
 TAMPA, FL 33609

STATE OF FLORIDA DEPARTMENT OF TRANSPORTATION		
ROAD NO.	COUNTY	FINANCIAL PROJECT ID
SR 15	OKEECHOBEE	448974-1-52-01

**SIGNING AND PAVEMENT  
MARKING PLAN**

SHEET  
NO.  
S-18

THE OFFICIAL RECORD OF THIS SHEET IS THE ELECTRONIC FILE DIGITALLY SIGNED AND SEALED UNDER RULE 61G15-23.004, F.A.C.

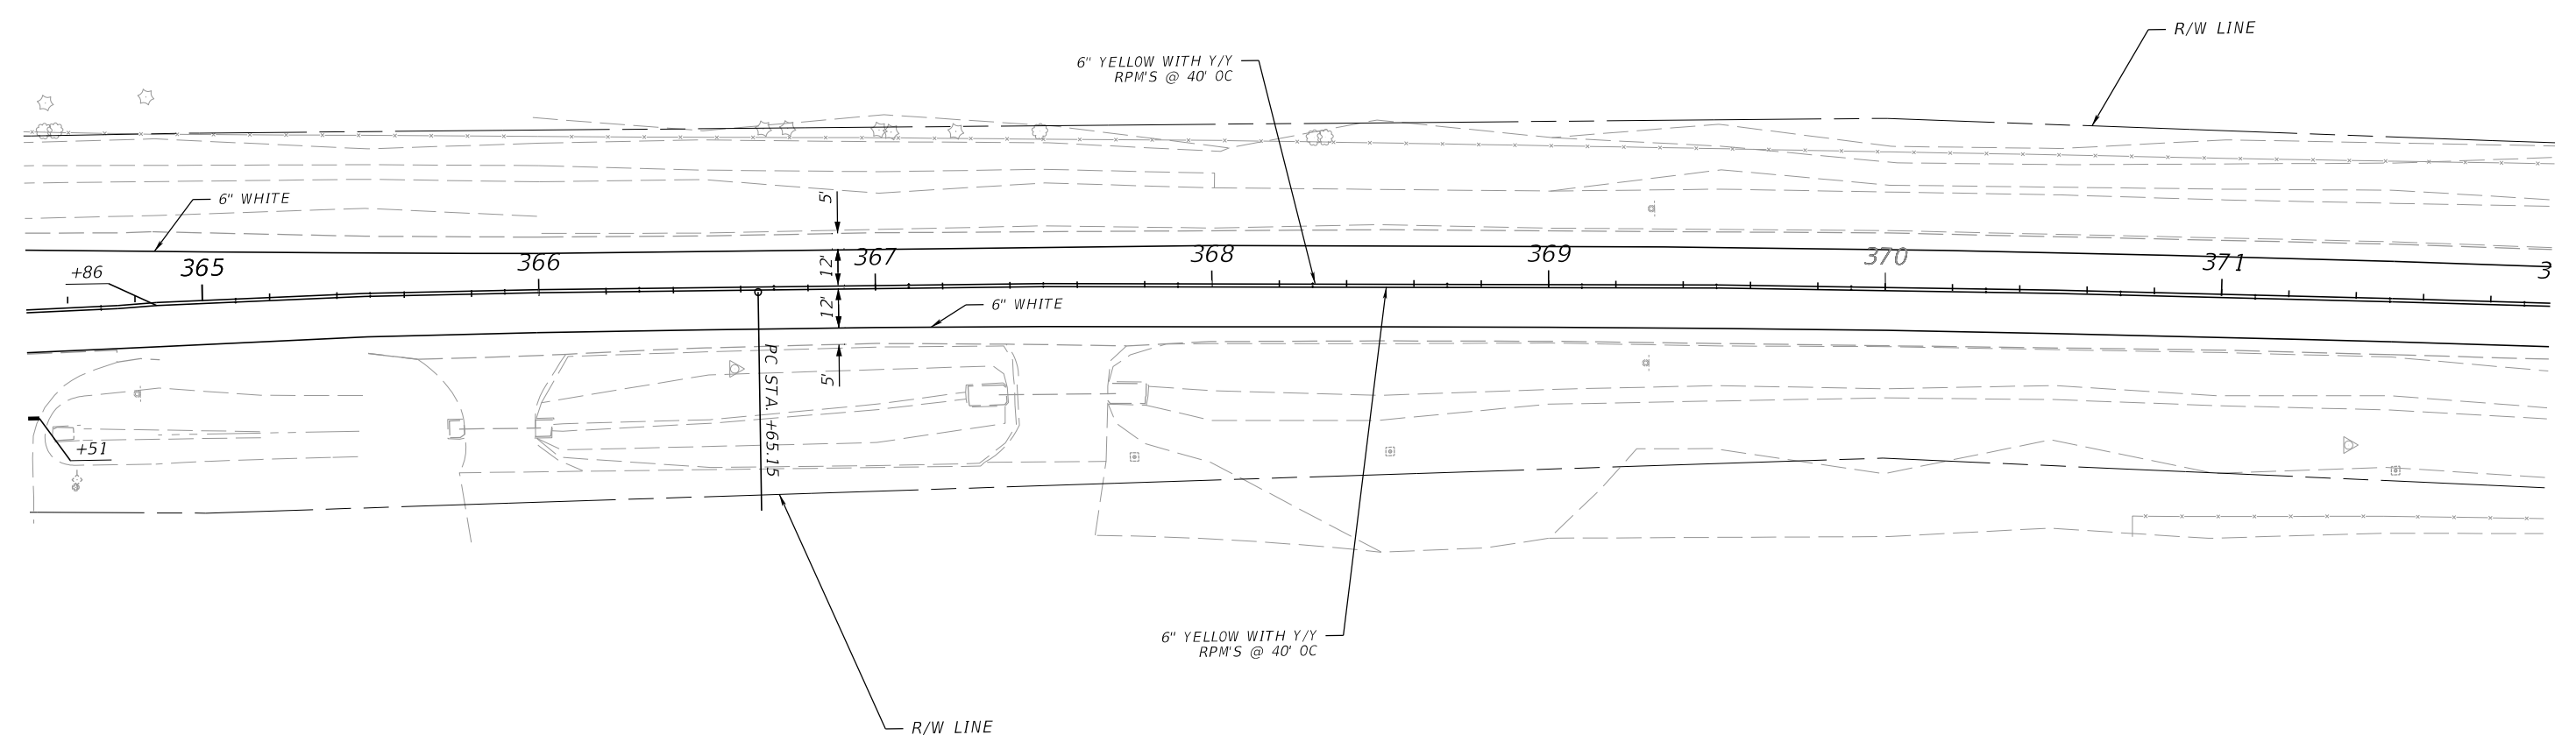
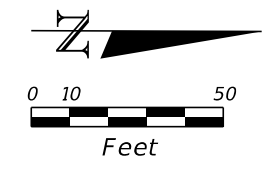


11/9/2023 11:59:05 AM MNADIR  
 c:\pwworking\kpkpw01\nassim\nadir\dms05209\PLAN\SP02.dgn

THE OFFICIAL RECORD OF THIS SHEET IS THE ELECTRONIC FILE DIGITALLY SIGNED AND SEALED UNDER RULE 61G15-23.004, F.A.C.

REVISIONS				ENGINEER OF RECORD		STATE OF FLORIDA DEPARTMENT OF TRANSPORTATION			SHEET NO.
DATE	DESCRIPTION	DATE	DESCRIPTION			ROAD NO.	COUNTY	FINANCIAL PROJECT ID	
				JOSE A. JARQUIN, P.E. LICENSE NUMBER: 89293 AMERICAN STRUCTUREPOINT, INC. 5405 CYPRESS CENTER DR, SUITE 310 TAMPA, FL 33609		SR 15	OKEECHOBEE	448974-1-52-01	5-19

**SIGNING AND PAVEMENT  
MARKING PLAN**

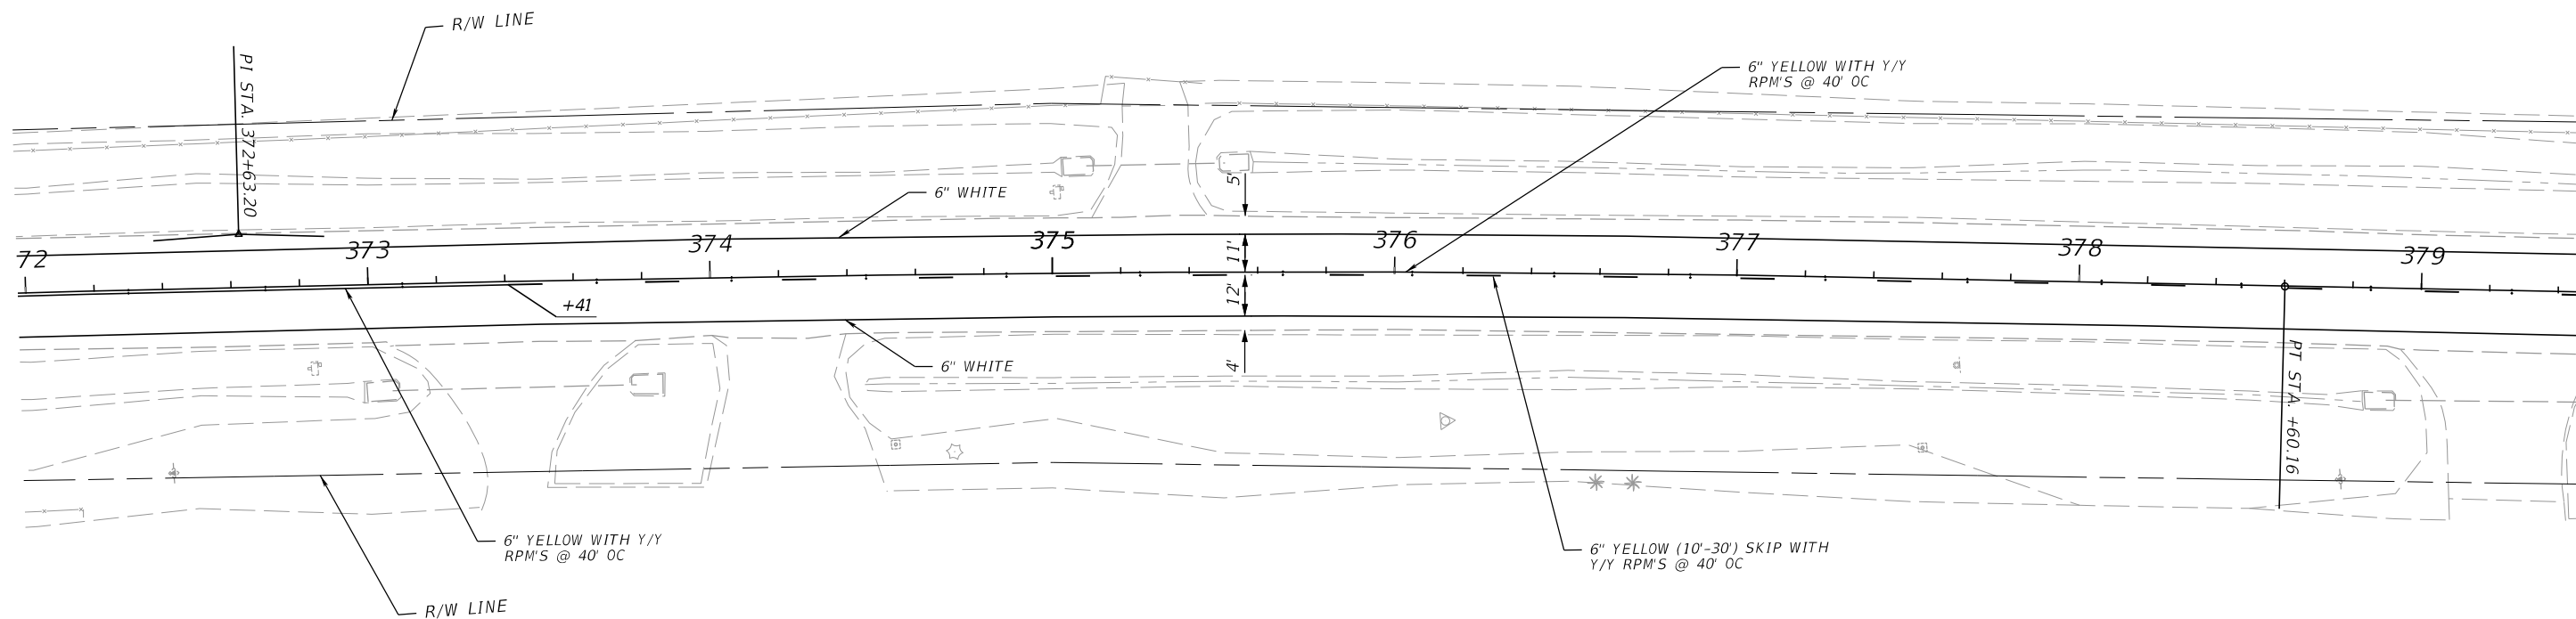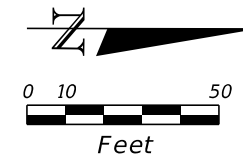

11/9/2023 11:59:08 AM MNADIR c:\pwworking\kpkpw01\nassim\nadir\dms05209\PLAN\SP02.dgn

REVISIONS			
DATE	DESCRIPTION	DATE	DESCRIPTION



ENGINEER OF RECORD  
 JOSE A. JARQUIN, P.E.  
 LICENSE NUMBER: 89293  
 AMERICAN STRUCTUREPOINT, INC.  
 5405 CYPRESS CENTER DR, SUITE 310  
 TAMPA, FL 33609

STATE OF FLORIDA DEPARTMENT OF TRANSPORTATION		
ROAD NO.	COUNTY	FINANCIAL PROJECT ID
SR 15	OKEECHOBEE	448974-1-52-01

**SIGNING AND PAVEMENT  
MARKING PLAN**

SHEET NO.  
S-20

THE OFFICIAL RECORD OF THIS SHEET IS THE ELECTRONIC FILE DIGITALLY SIGNED AND SEALED UNDER RULE 61G15-23.004, F.A.C.

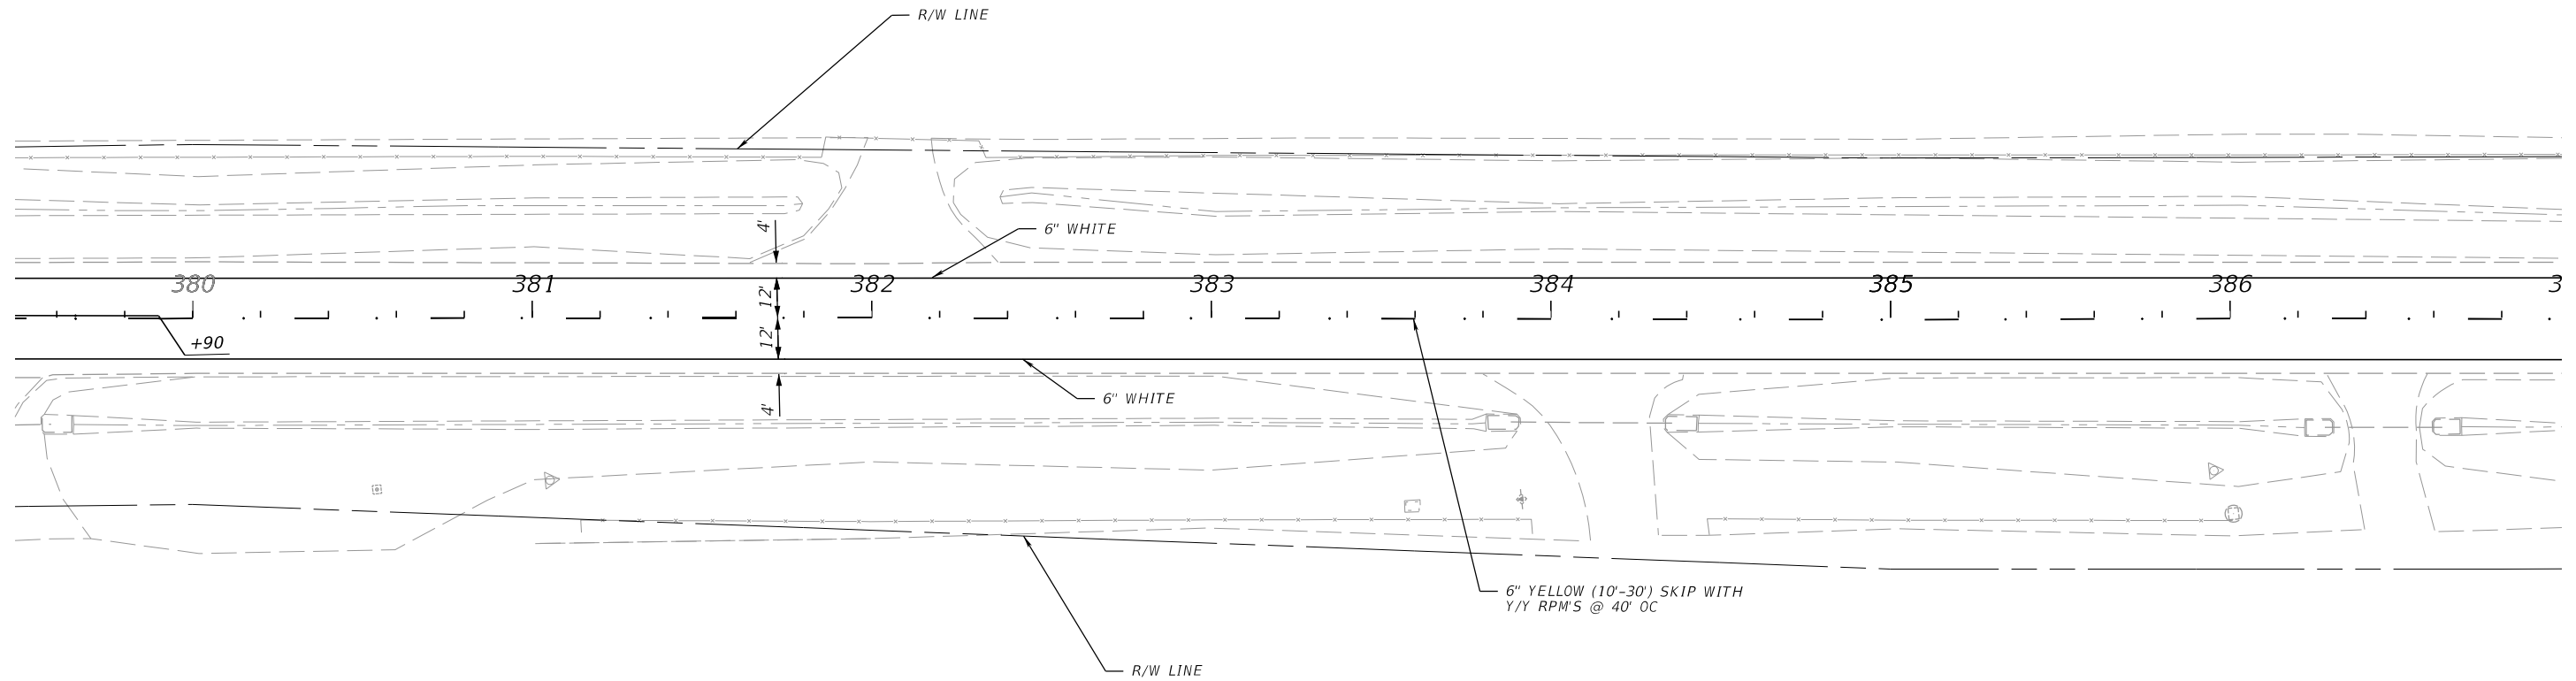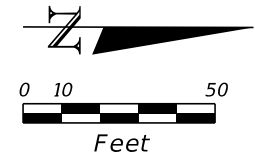

11/9/2023 11:59:11 AM MWADIR  
 c:\pwworking\kpkpw01\massim nadir\dms05209\PLAN\SP02.dgn

REVISIONS			
DATE	DESCRIPTION	DATE	DESCRIPTION



**ENGINEER OF RECORD**  
 JOSE A. JARQUIN, P.E.  
 LICENSE NUMBER: 89293  
 AMERICAN STRUCTUREPOINT, INC.  
 5405 CYPRESS CENTER DR, SUITE 310  
 TAMPA, FL 33609

STATE OF FLORIDA DEPARTMENT OF TRANSPORTATION		
ROAD NO.	COUNTY	FINANCIAL PROJECT ID
SR 15	OKEECHOBEE	448974-1-52-01

**SIGNING AND PAVEMENT  
MARKING PLAN**

**SHEET  
NO.**  
 S-21



THE OFFICIAL RECORD OF THIS SHEET IS THE ELECTRONIC FILE DIGITALLY SIGNED AND SEALED UNDER RULE 61G15-23.004, F.A.C.

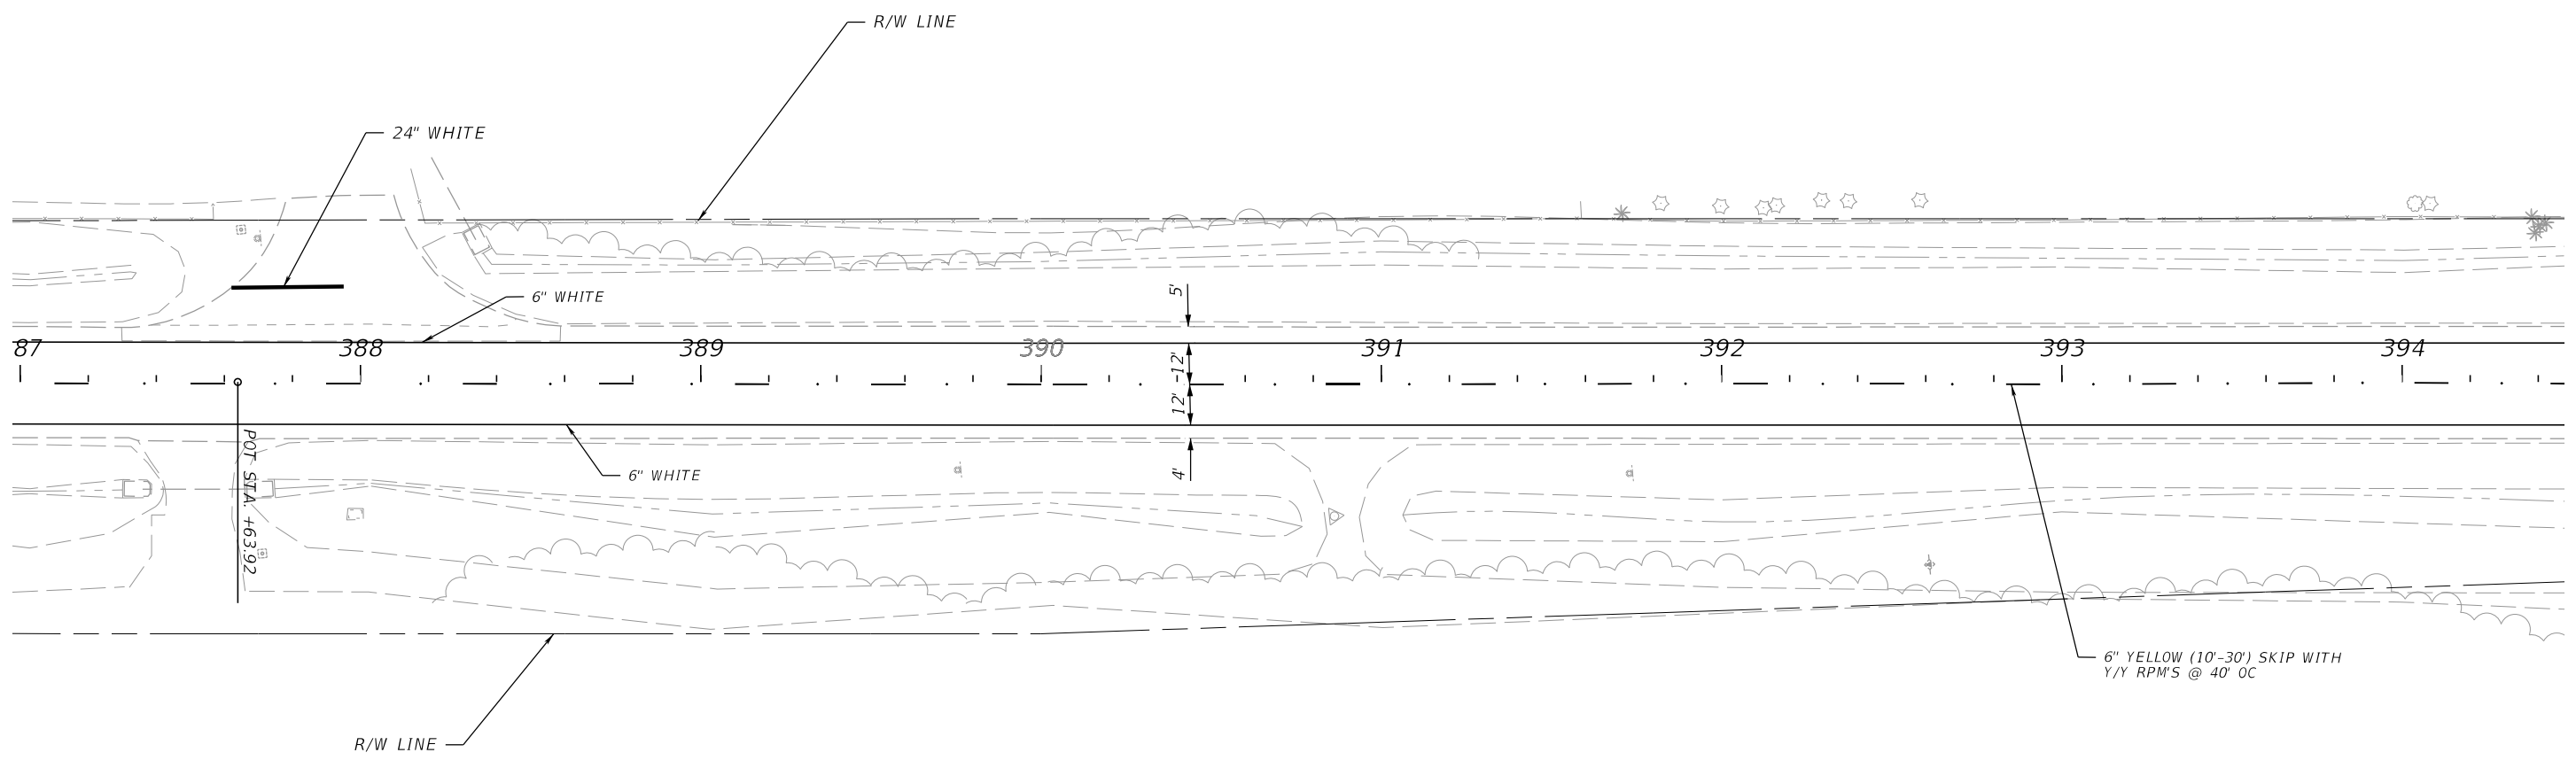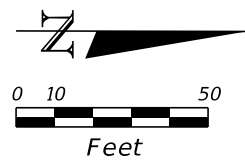

11/9/2023 11:59:14 AM MWADIR c:\pwworking\kpkpw01\nassim\nadr\dms05209\PLAN\SP02.dgn

THE OFFICIAL RECORD OF THIS SHEET IS THE ELECTRONIC FILE DIGITALLY SIGNED AND SEALED UNDER RULE 61G15-23.004, F.A.C.

REVISIONS				ENGINEER OF RECORD		STATE OF FLORIDA DEPARTMENT OF TRANSPORTATION			<b>SIGNING AND PAVEMENT MARKING PLAN</b>	SHEET NO.
DATE	DESCRIPTION	DATE	DESCRIPTION	JOSE A. JARQUIN, P.E. LICENSE NUMBER: 89293 AMERICAN STRUCTUREPOINT, INC. 5405 CYPRESS CENTER DR, SUITE 310 TAMPA, FL 33609		ROAD NO.	COUNTY	FINANCIAL PROJECT ID		S-22
						SR 15	OKEECHOBEE	448974-1-52-01		

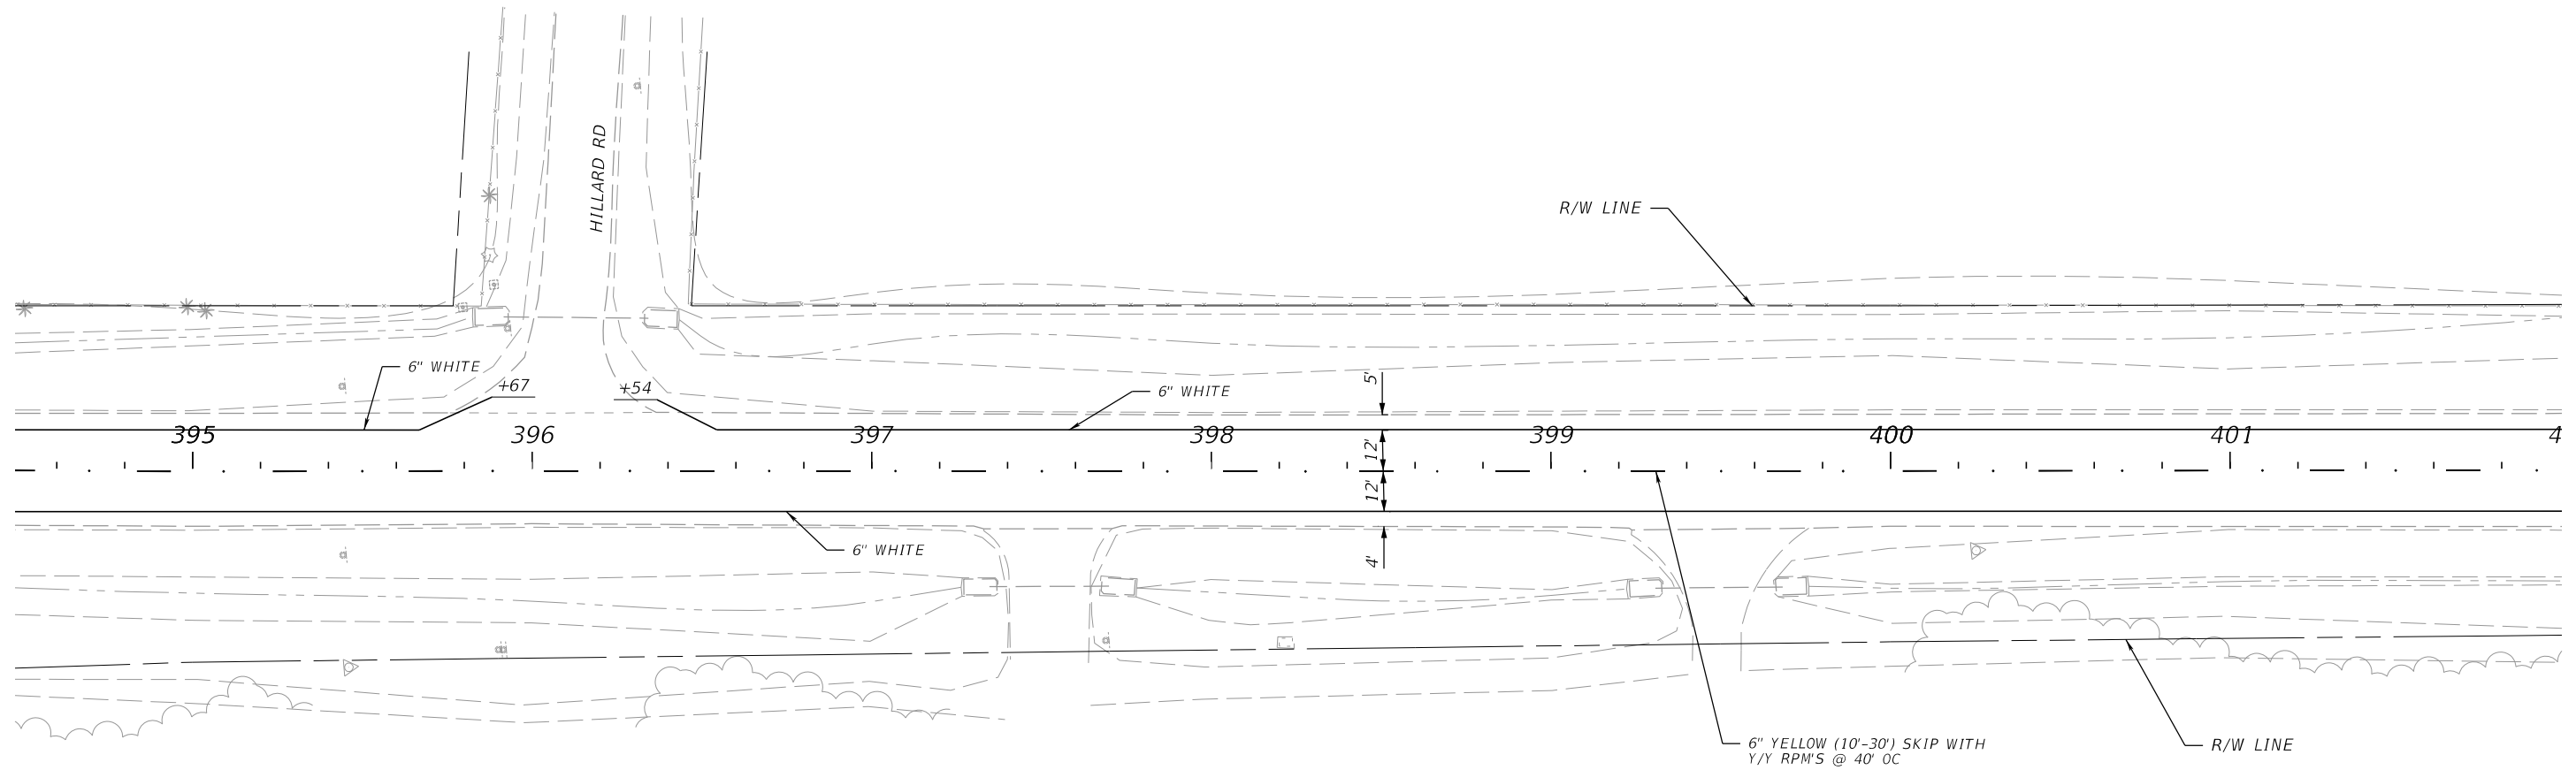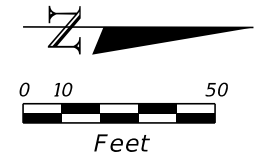

11/9/2023 11:59:17 AM MWADIR  
 c:\pwworking\kkipw01\massim nadir\dms05209\PLAN\SP02.dgn

REVISIONS			
DATE	DESCRIPTION	DATE	DESCRIPTION



**ENGINEER OF RECORD**  
 JOSE A. JARQUIN, P.E.  
 LICENSE NUMBER: 89293  
 AMERICAN STRUCTUREPOINT, INC.  
 5405 CYPRESS CENTER DR, SUITE 310  
 TAMPA, FL 33609

STATE OF FLORIDA DEPARTMENT OF TRANSPORTATION		
ROAD NO.	COUNTY	FINANCIAL PROJECT ID
SR 15	OKEECHOBEE	448974-1-52-01

**SIGNING AND PAVEMENT  
MARKING PLAN**

SHEET NO.  
 S-23

THE OFFICIAL RECORD OF THIS SHEET IS THE ELECTRONIC FILE DIGITALLY SIGNED AND SEALED UNDER RULE 61G15-23.004, F.A.C.

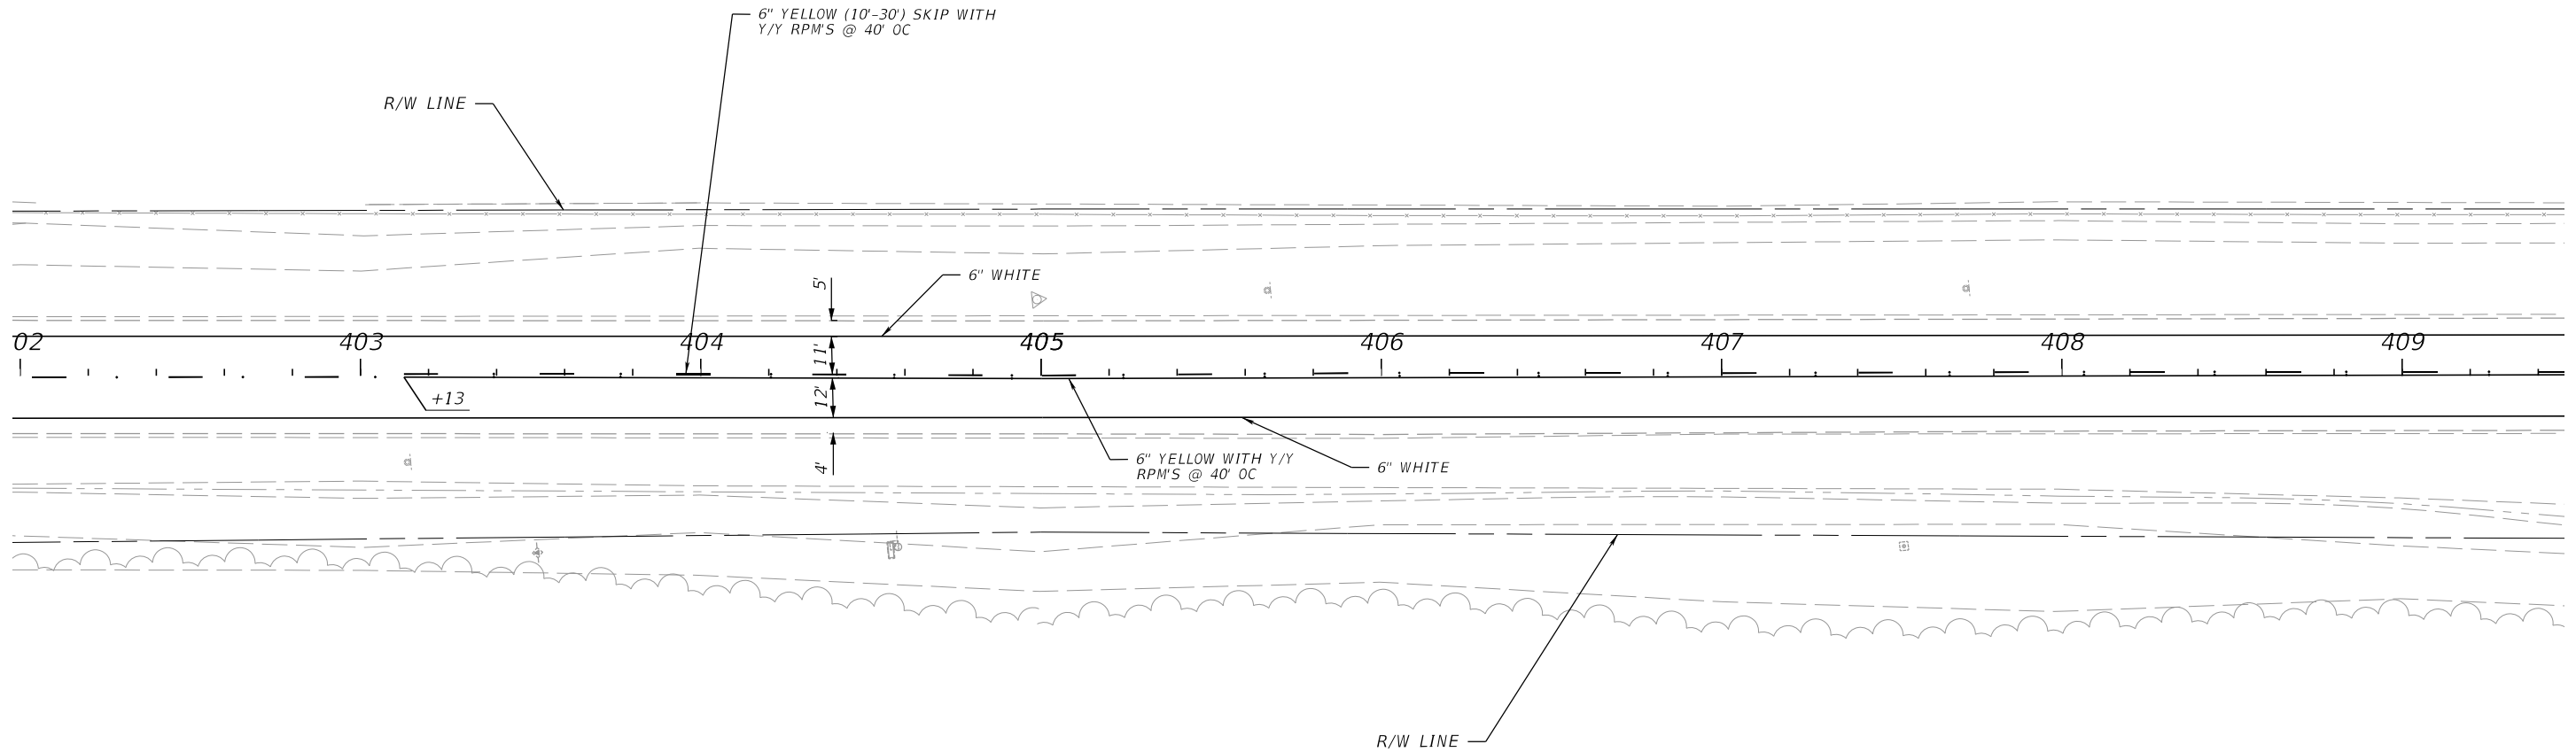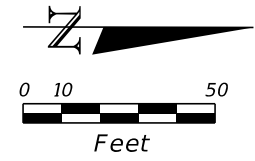

11/9/2023 11:59:19 AM MWADIR c:\pwworking\ykp\p01\massim\adir\dms05209\PLAN\SP02.dgn

REVISIONS			
DATE	DESCRIPTION	DATE	DESCRIPTION

ENGINEER OF RECORD  
 JOSE A. JARQUIN, P.E.  
 LICENSE NUMBER: 89293  
 AMERICAN STRUCTUREPOINT, INC.  
 5405 CYPRESS CENTER DR, SUITE 310  
 TAMPA, FL 33609



STATE OF FLORIDA DEPARTMENT OF TRANSPORTATION		
ROAD NO.	COUNTY	FINANCIAL PROJECT ID
SR 15	OKEECHOBEE	448974-1-52-01

**SIGNING AND PAVEMENT  
MARKING PLAN**

SHEET NO.  
S-24

THE OFFICIAL RECORD OF THIS SHEET IS THE ELECTRONIC FILE DIGITALLY SIGNED AND SEALED UNDER RULE 61G15-23.004, F.A.C.



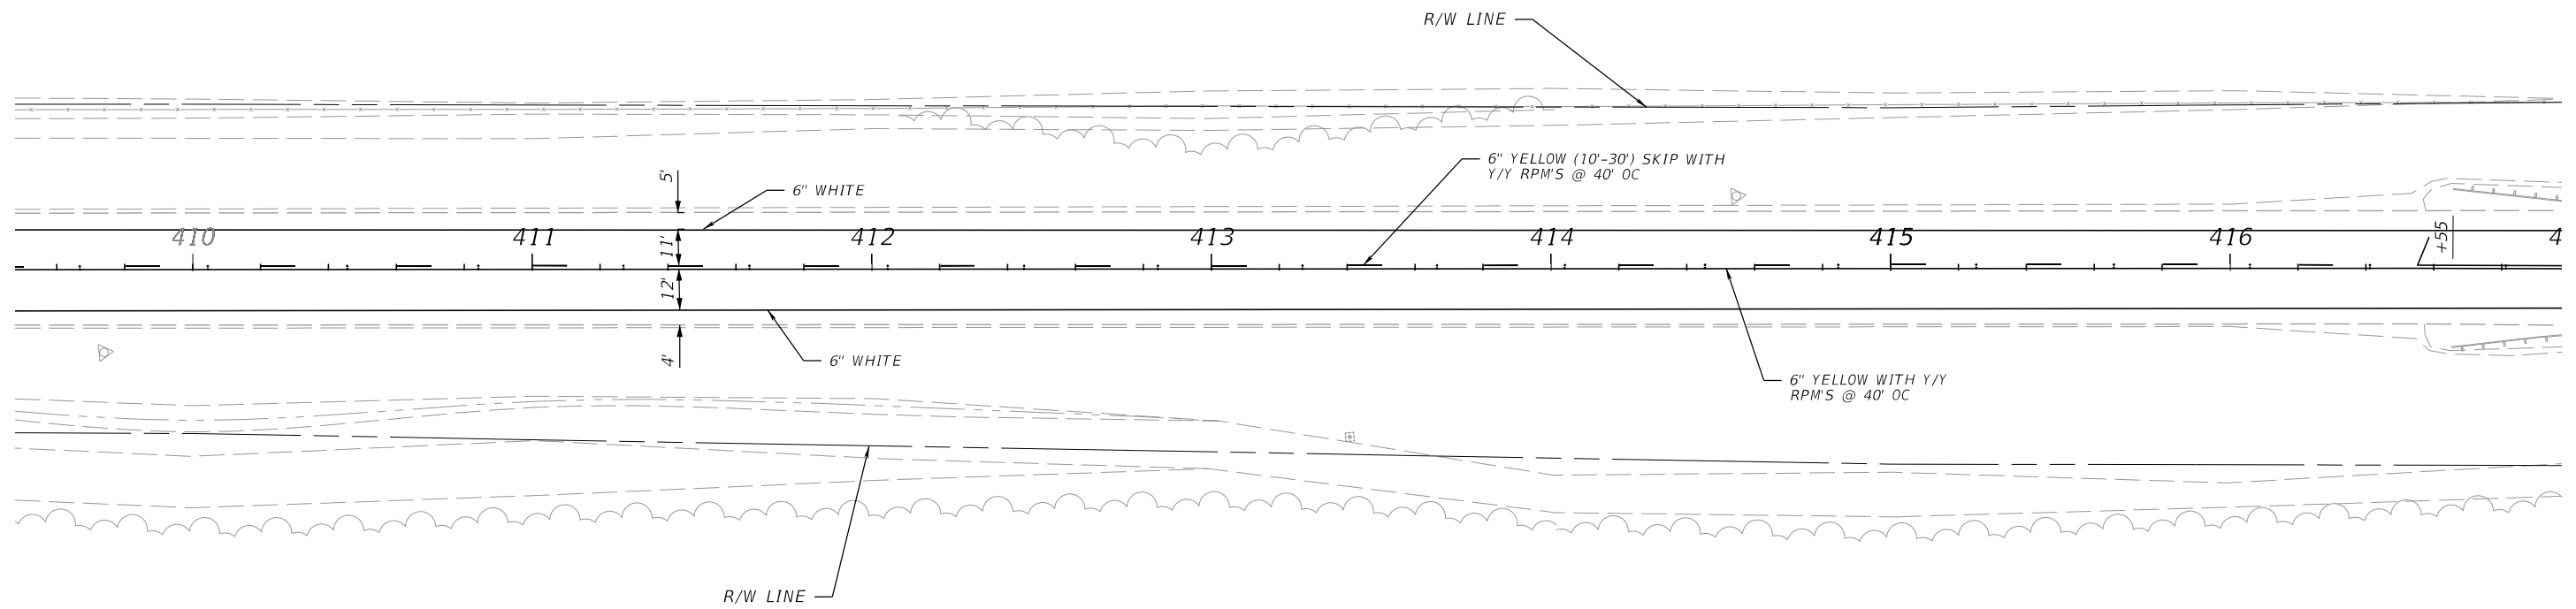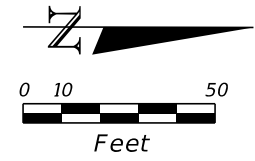

11/9/2023 11:59:22 AM MWADIR  
 c:\pwworking\kkipw01\nassim\nadir\dms05209\PLAN\SP02.dgn

REVISIONS			
DATE	DESCRIPTION	DATE	DESCRIPTION



**ENGINEER OF RECORD**  
 JOSE A. JARQUIN, P.E.  
 LICENSE NUMBER: 89293  
 AMERICAN STRUCTUREPOINT, INC.  
 5405 CYPRESS CENTER DR, SUITE 310  
 TAMPA, FL 33609

STATE OF FLORIDA DEPARTMENT OF TRANSPORTATION		
ROAD NO.	COUNTY	FINANCIAL PROJECT ID
SR 15	OKEECHOBEE	448974-1-52-01

**SIGNING AND PAVEMENT  
MARKING PLAN**

**SHEET NO.**  
 S-25

THE OFFICIAL RECORD OF THIS SHEET IS THE ELECTRONIC FILE DIGITALLY SIGNED AND SEALED UNDER RULE 61G15-23.004, F.A.C.

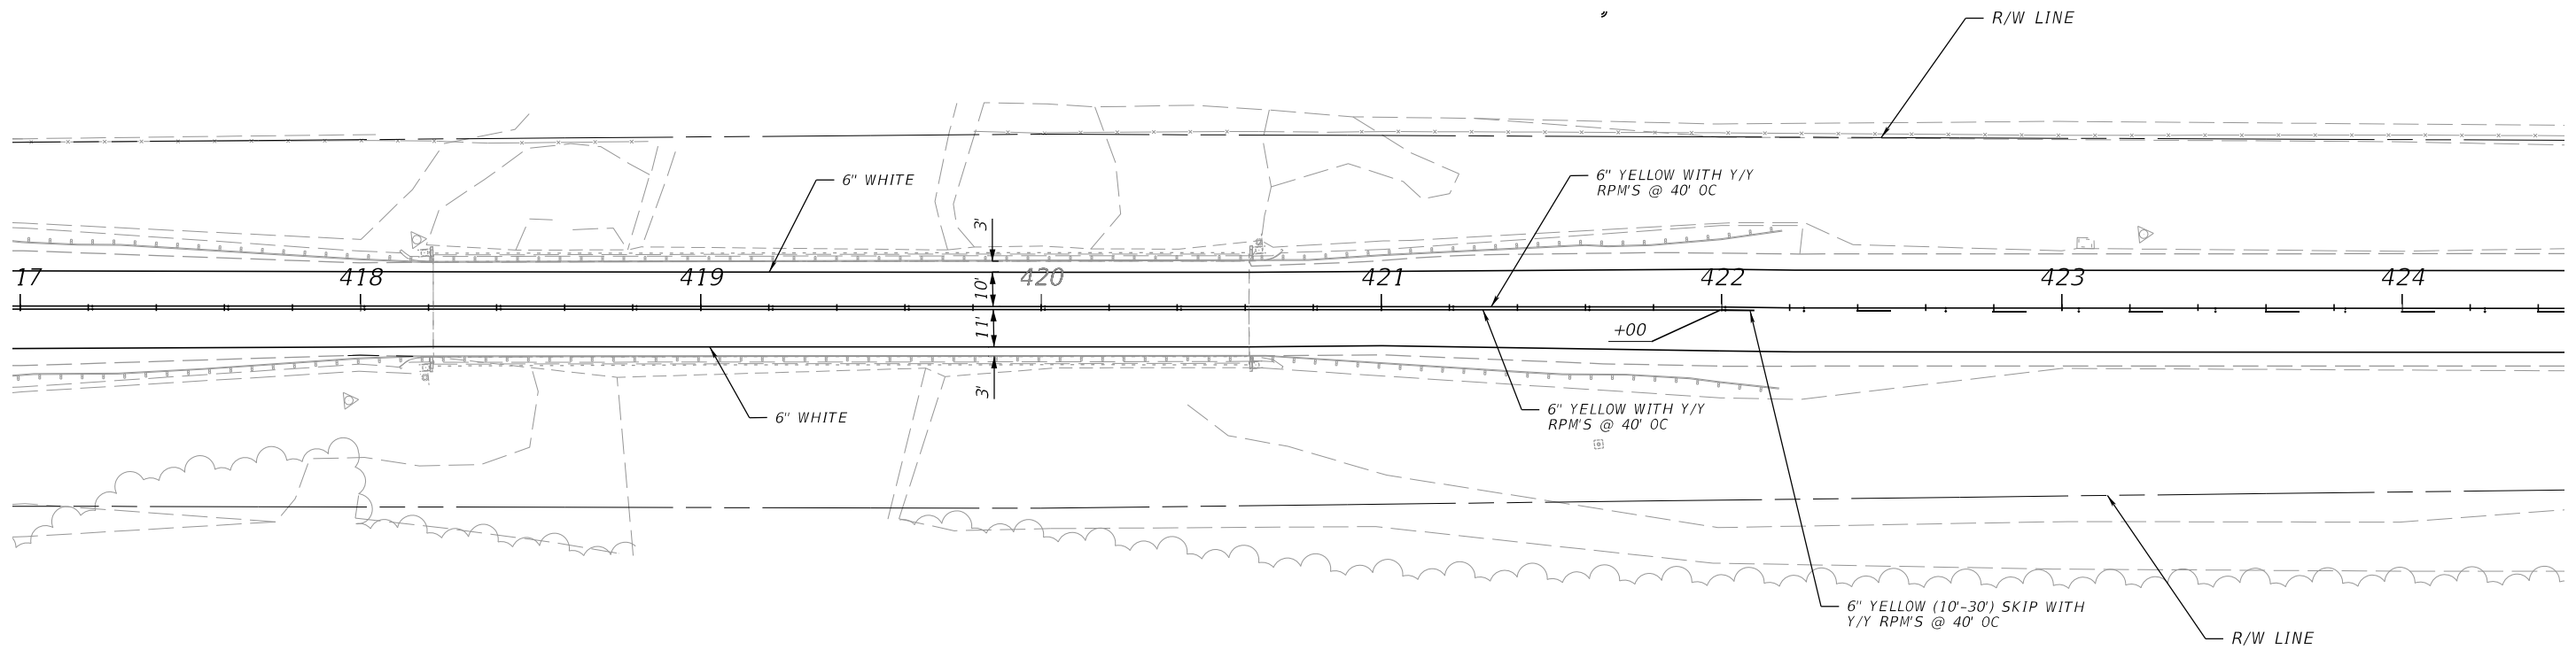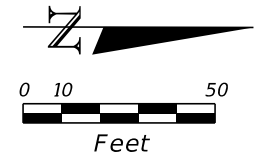

11/9/2023 11:59:25 AM MWADIR  
 c:\pwworking\kpkpw01\nassim\nadir\dms05209\PLAN\SP02.dgn

REVISIONS			
DATE	DESCRIPTION	DATE	DESCRIPTION



**ENGINEER OF RECORD**  
 JOSE A. JARQUIN, P.E.  
 LICENSE NUMBER: 89293  
 AMERICAN STRUCTUREPOINT, INC.  
 5405 CYPRESS CENTER DR, SUITE 310  
 TAMPA, FL 33609

STATE OF FLORIDA DEPARTMENT OF TRANSPORTATION		
ROAD NO.	COUNTY	FINANCIAL PROJECT ID
SR 15	OKEECHOBEE	448974-1-52-01

**SIGNING AND PAVEMENT  
MARKING PLAN**

SHEET NO.  
 S-26

THE OFFICIAL RECORD OF THIS SHEET IS THE ELECTRONIC FILE DIGITALLY SIGNED AND SEALED UNDER RULE 61G15-23.004, F.A.C.

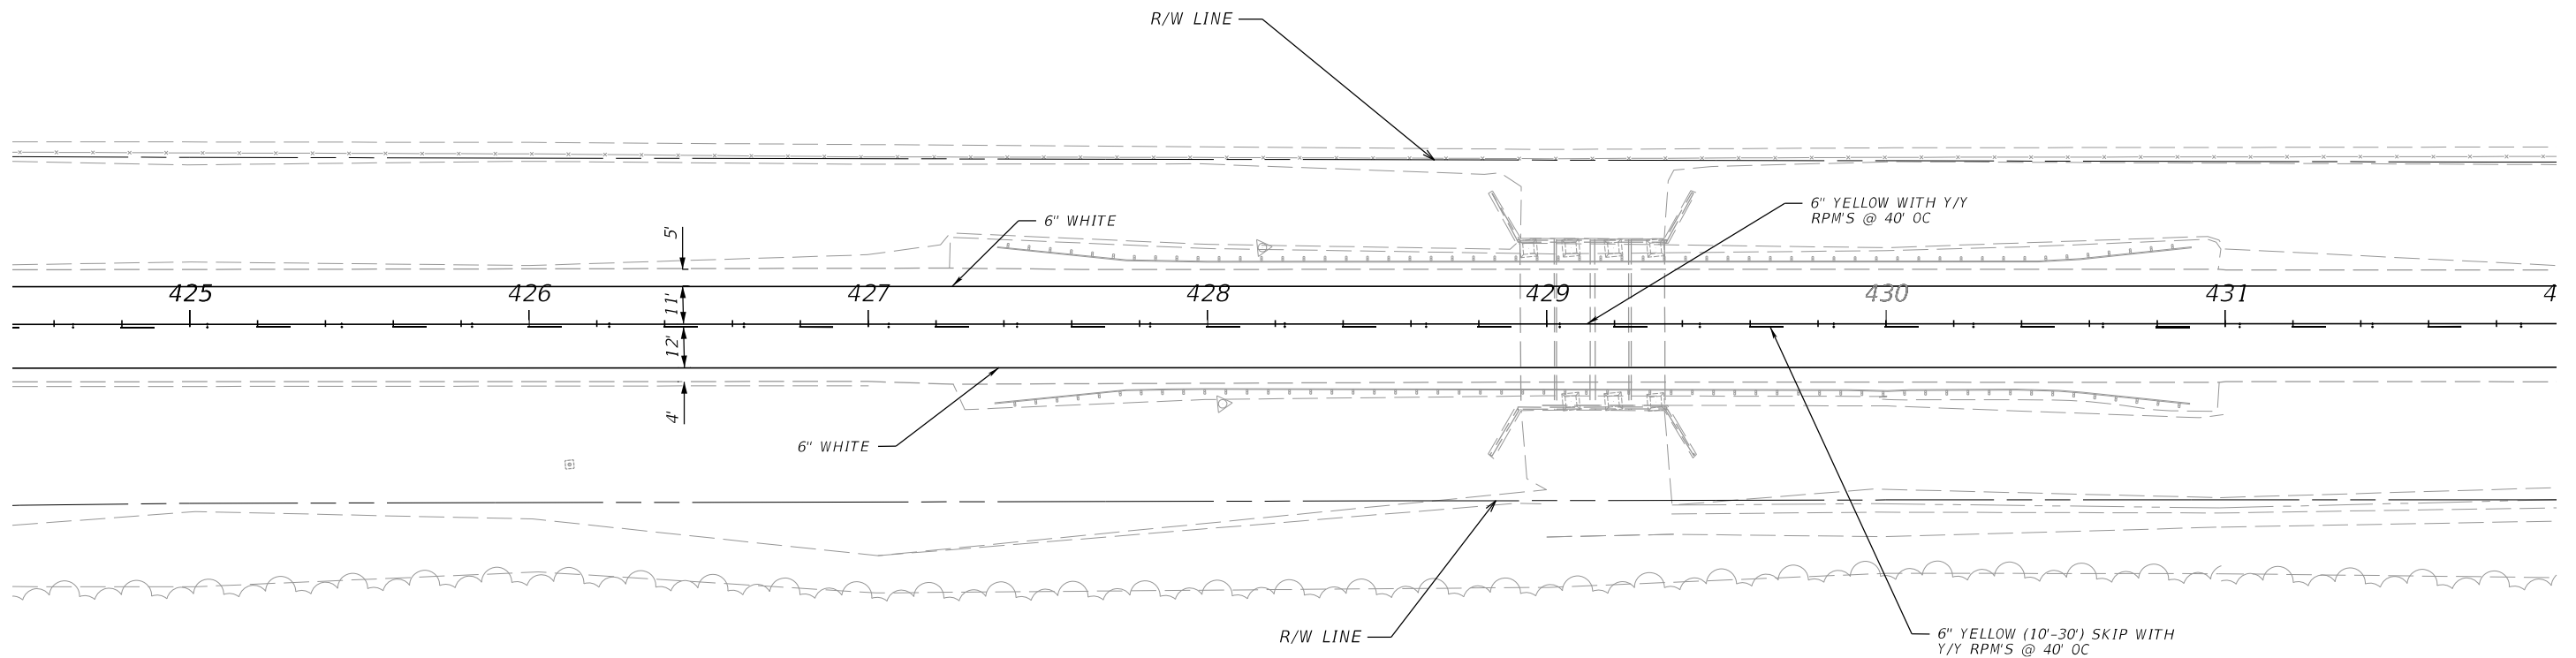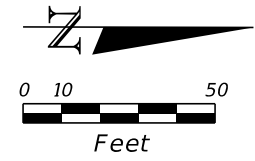

11/9/2023 11:59:27 AM MWADIR  
 c:\pwworking\kkipw01\massim nadir\dms05209\PLAN\SP02.dgn

REVISIONS			
DATE	DESCRIPTION	DATE	DESCRIPTION



**ENGINEER OF RECORD**  
 JOSE A. JARQUIN, P.E.  
 LICENSE NUMBER: 89293  
 AMERICAN STRUCTUREPOINT, INC.  
 5405 CYPRESS CENTER DR, SUITE 310  
 TAMPA, FL 33609

STATE OF FLORIDA DEPARTMENT OF TRANSPORTATION		
ROAD NO.	COUNTY	FINANCIAL PROJECT ID
SR 15	OKEECHOBEE	448974-1-52-01

**SIGNING AND PAVEMENT  
MARKING PLAN**

**SHEET NO.**  
 S-27

THE OFFICIAL RECORD OF THIS SHEET IS THE ELECTRONIC FILE DIGITALLY SIGNED AND SEALED UNDER RULE 61G15-23.004, F.A.C.

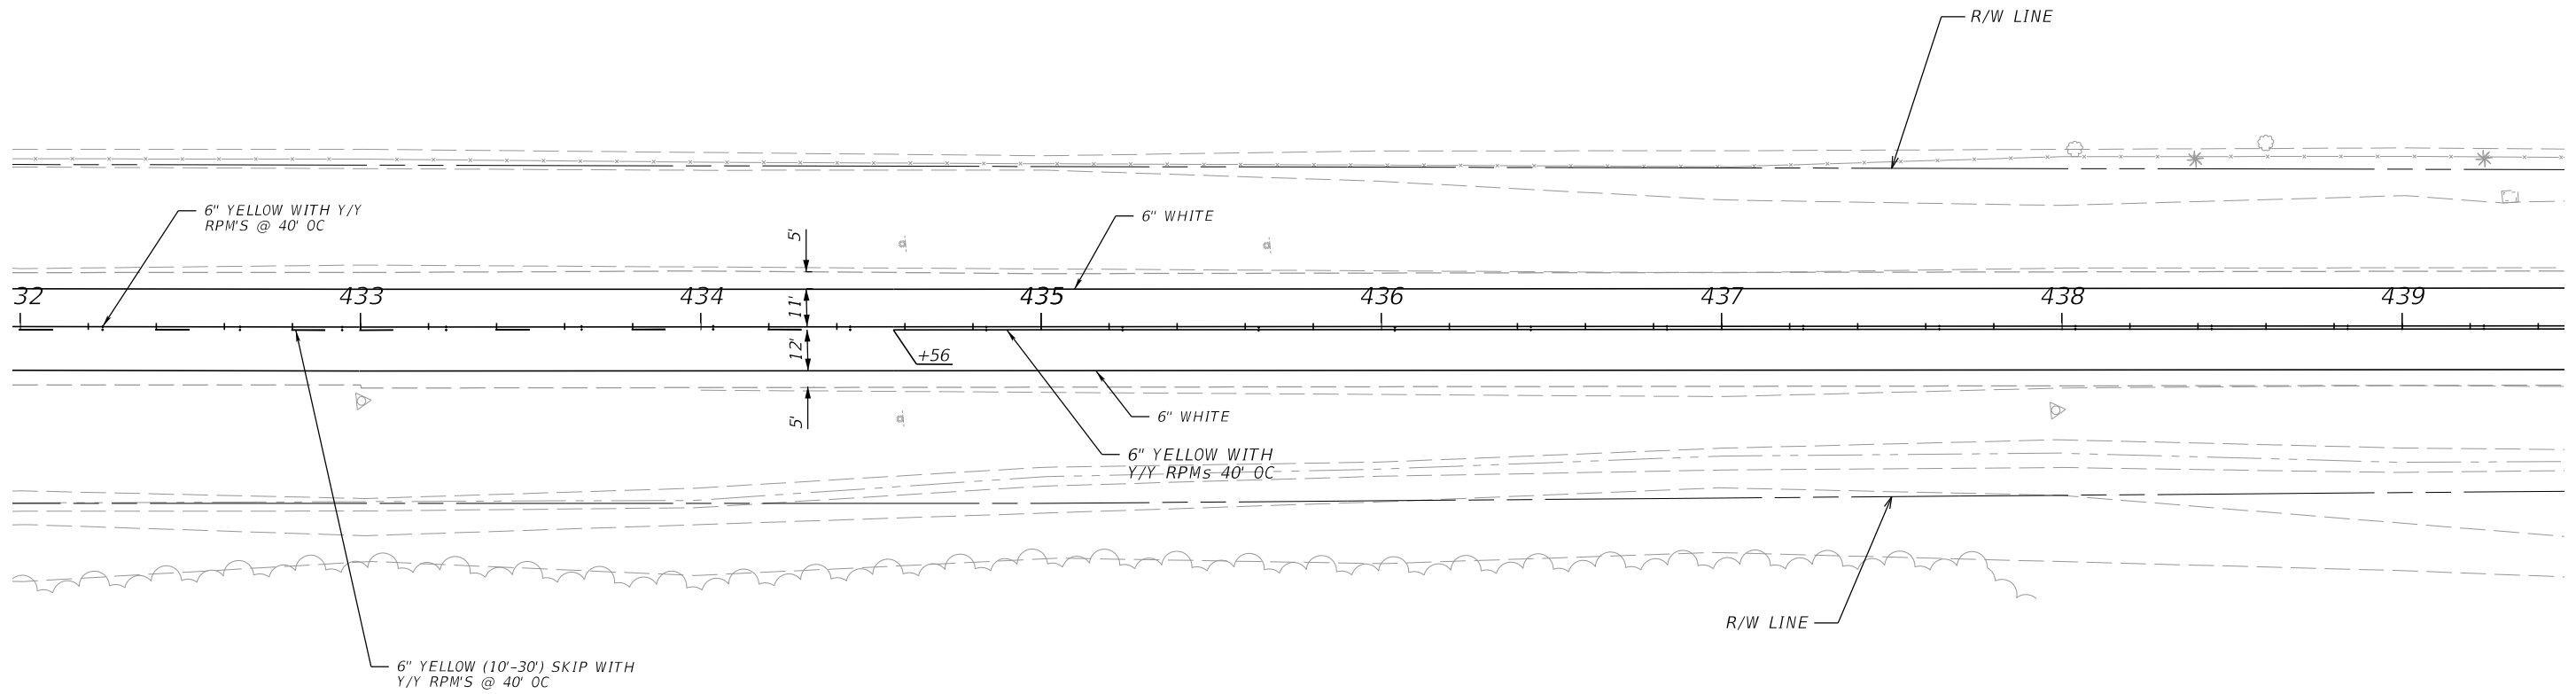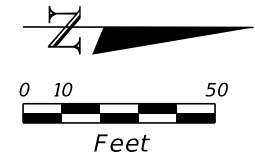

11/9/2023 11:59:30 AM MNADIR c:\pwworking\kpkpw01\massim\nadir\dms05209\PLAN\SP02.dgn

REVISIONS			
DATE	DESCRIPTION	DATE	DESCRIPTION



ENGINEER OF RECORD  
 JOSE A. JARQUIN, P.E.  
 LICENSE NUMBER: 89293  
 AMERICAN STRUCTUREPOINT, INC.  
 5405 CYPRESS CENTER DR, SUITE 310  
 TAMPA, FL 33609

STATE OF FLORIDA DEPARTMENT OF TRANSPORTATION		
ROAD NO.	COUNTY	FINANCIAL PROJECT ID
SR 15	OKEECHOBEE	448974-1-52-01

**SIGNING AND PAVEMENT  
MARKING PLAN**

SHEET NO.  
S-28

THE OFFICIAL RECORD OF THIS SHEET IS THE ELECTRONIC FILE DIGITALLY SIGNED AND SEALED UNDER RULE 61G15-23.004, F.A.C.

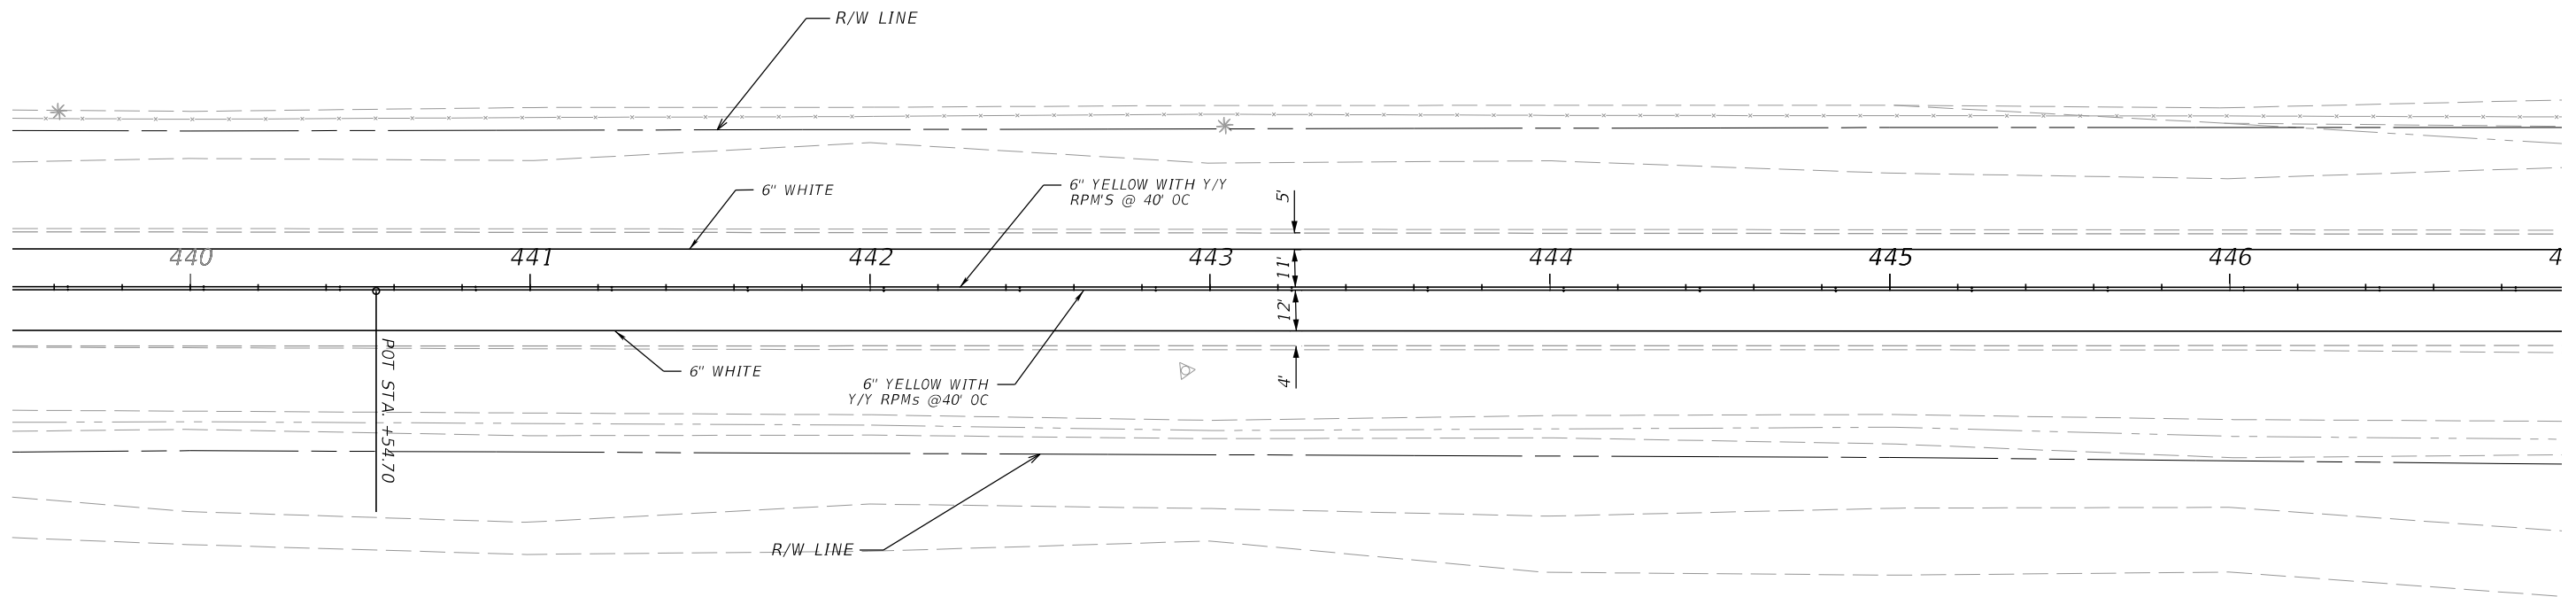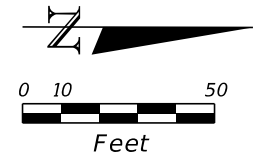

11/9/2023 11:59:33 AM MNADIR  
 c:\pwworking\kpkpw01\nassim\nadir\dms05209\PLAN\SP02.dgn

REVISIONS			
DATE	DESCRIPTION	DATE	DESCRIPTION



**ENGINEER OF RECORD**  
 JOSE A. JARQUIN, P.E.  
 LICENSE NUMBER: 89293  
 AMERICAN STRUCTUREPOINT, INC.  
 5405 CYPRESS CENTER DR, SUITE 310  
 TAMPA, FL 33609

STATE OF FLORIDA DEPARTMENT OF TRANSPORTATION		
ROAD NO.	COUNTY	FINANCIAL PROJECT ID
SR 15	OKEECHOBEE	448974-1-52-01

**SIGNING AND PAVEMENT  
MARKING PLAN**

SHEET NO.  
 S-29

THE OFFICIAL RECORD OF THIS SHEET IS THE ELECTRONIC FILE DIGITALLY SIGNED AND SEALED UNDER RULE 61G15-23.004, F.A.C.

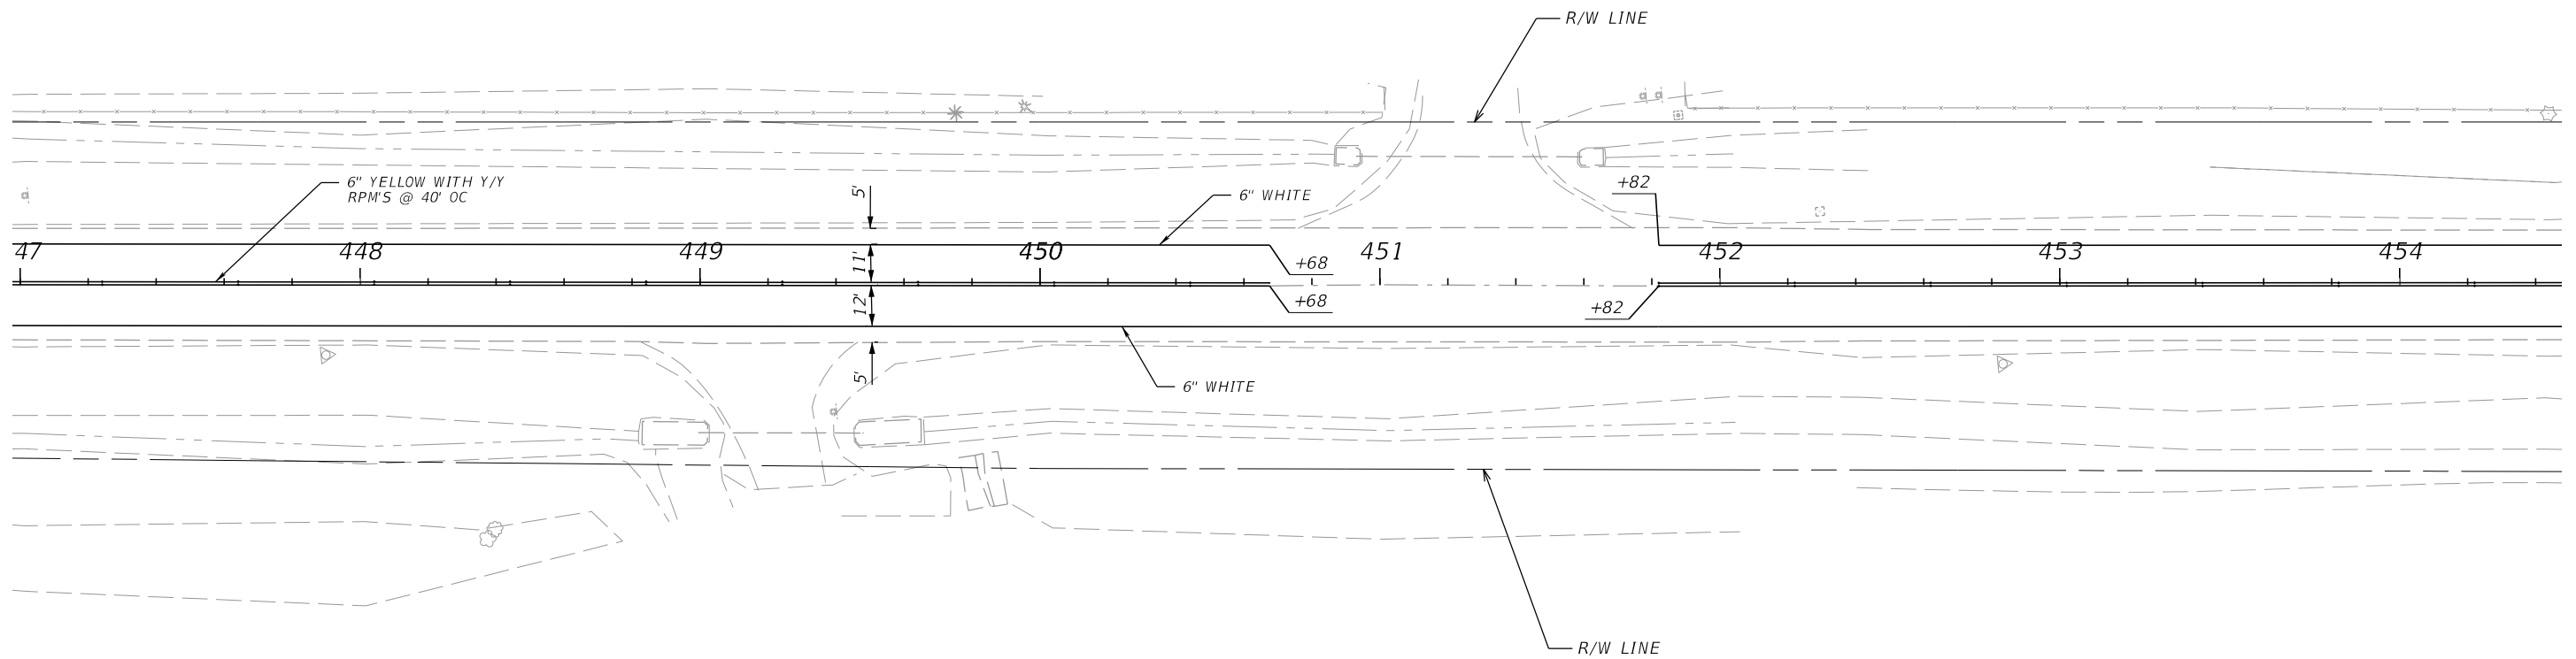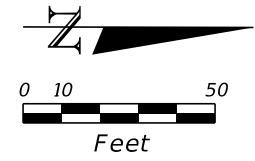

11/9/2023 11:59:35 AM MWADIR  
 c:\pwworking\kkipw01\nassim\adri\dms05209\PLAN\SP02.dgn

REVISIONS			
DATE	DESCRIPTION	DATE	DESCRIPTION



**ENGINEER OF RECORD**  
 JOSE A. JARQUIN, P.E.  
 LICENSE NUMBER: 89293  
 AMERICAN STRUCTUREPOINT, INC.  
 5405 CYPRESS CENTER DR, SUITE 310  
 TAMPA, FL 33609

STATE OF FLORIDA DEPARTMENT OF TRANSPORTATION		
ROAD NO.	COUNTY	FINANCIAL PROJECT ID
SR 15	OKEECHOBEE	448974-1-52-01

**SIGNING AND PAVEMENT  
MARKING PLAN**

SHEET NO.  
 S-30

THE OFFICIAL RECORD OF THIS SHEET IS THE ELECTRONIC FILE DIGITALLY SIGNED AND SEALED UNDER RULE 61G15-23.004, F.A.C.

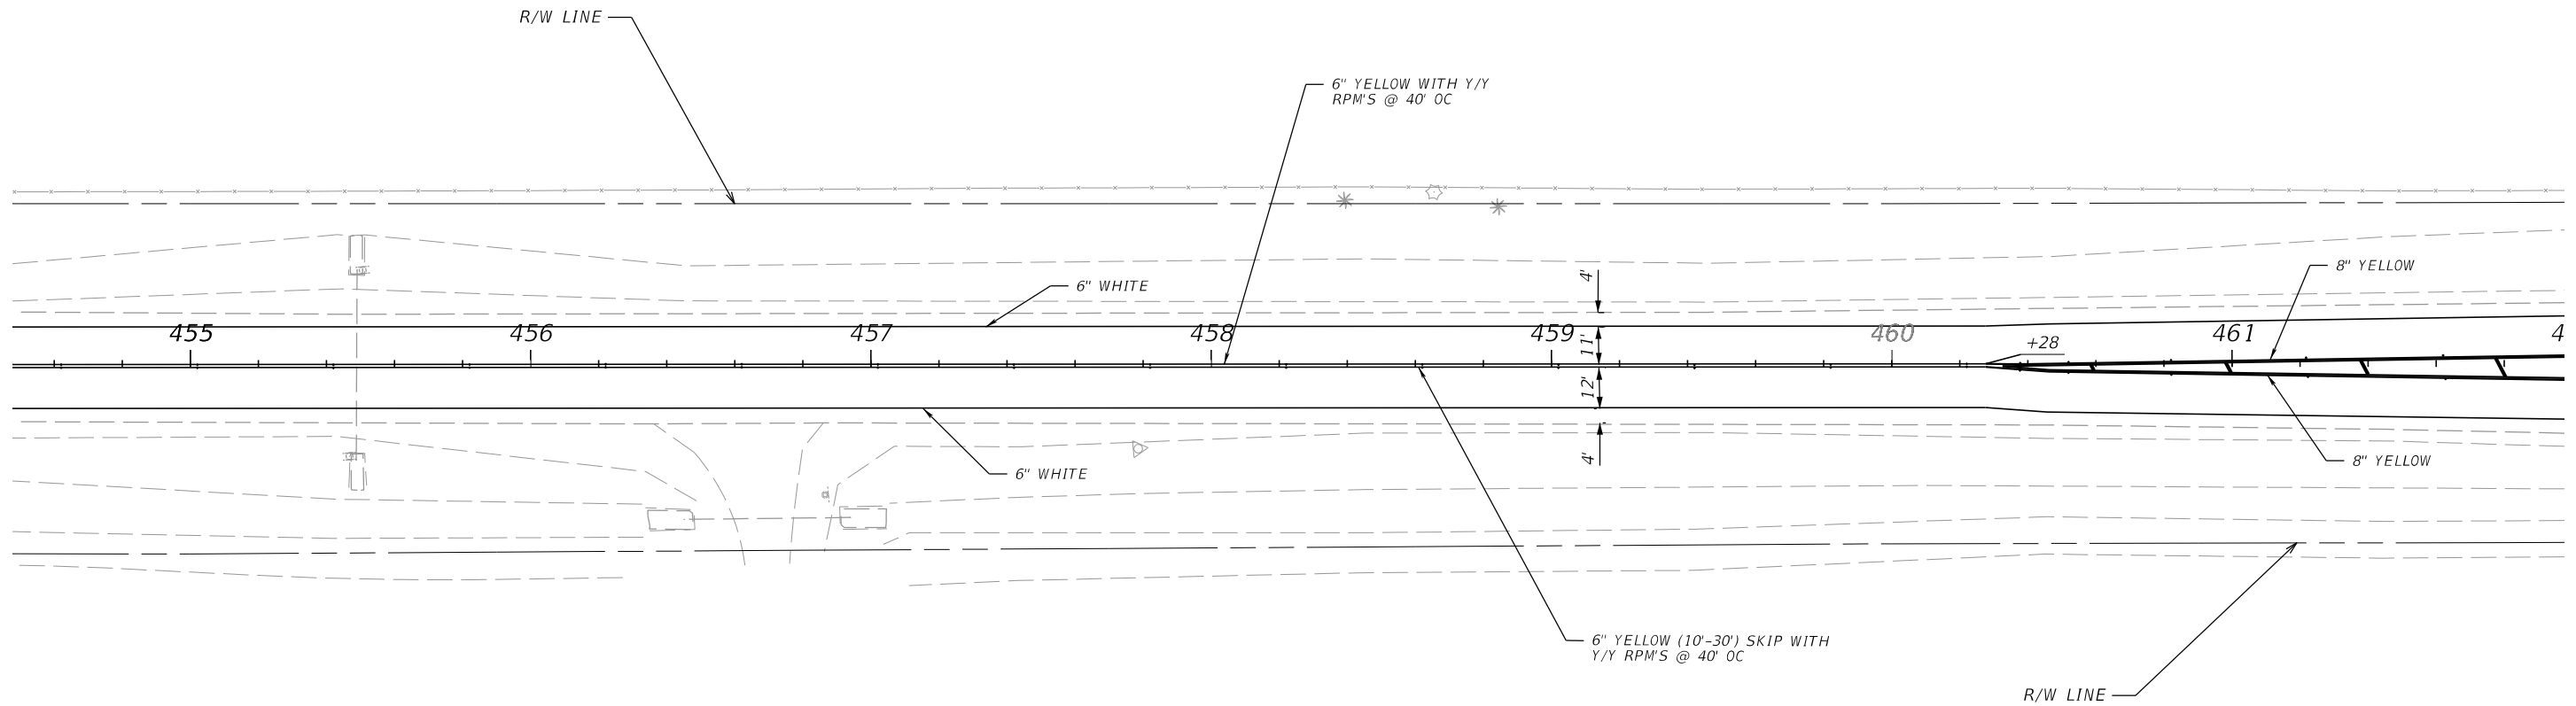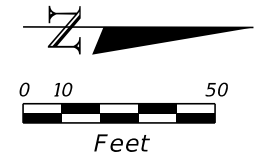

11/9/2023 11:59:38 AM MNADIR c:\pwworking\kkipw01\massim nadir\dms05209\PLAN\SP02.dgn

REVISIONS			
DATE	DESCRIPTION	DATE	DESCRIPTION



ENGINEER OF RECORD  
 JOSE A. JARQUIN, P.E.  
 LICENSE NUMBER: 89293  
 AMERICAN STRUCTUREPOINT, INC.  
 5405 CYPRESS CENTER DR, SUITE 310  
 TAMPA, FL 33609

STATE OF FLORIDA DEPARTMENT OF TRANSPORTATION		
ROAD NO.	COUNTY	FINANCIAL PROJECT ID
SR 15	OKEECHOBEE	448974-1-52-01

**SIGNING AND PAVEMENT  
MARKING PLAN**

SHEET NO.  
S-31

THE OFFICIAL RECORD OF THIS SHEET IS THE ELECTRONIC FILE DIGITALLY SIGNED AND SEALED UNDER RULE 61G15-23.004, F.A.C.

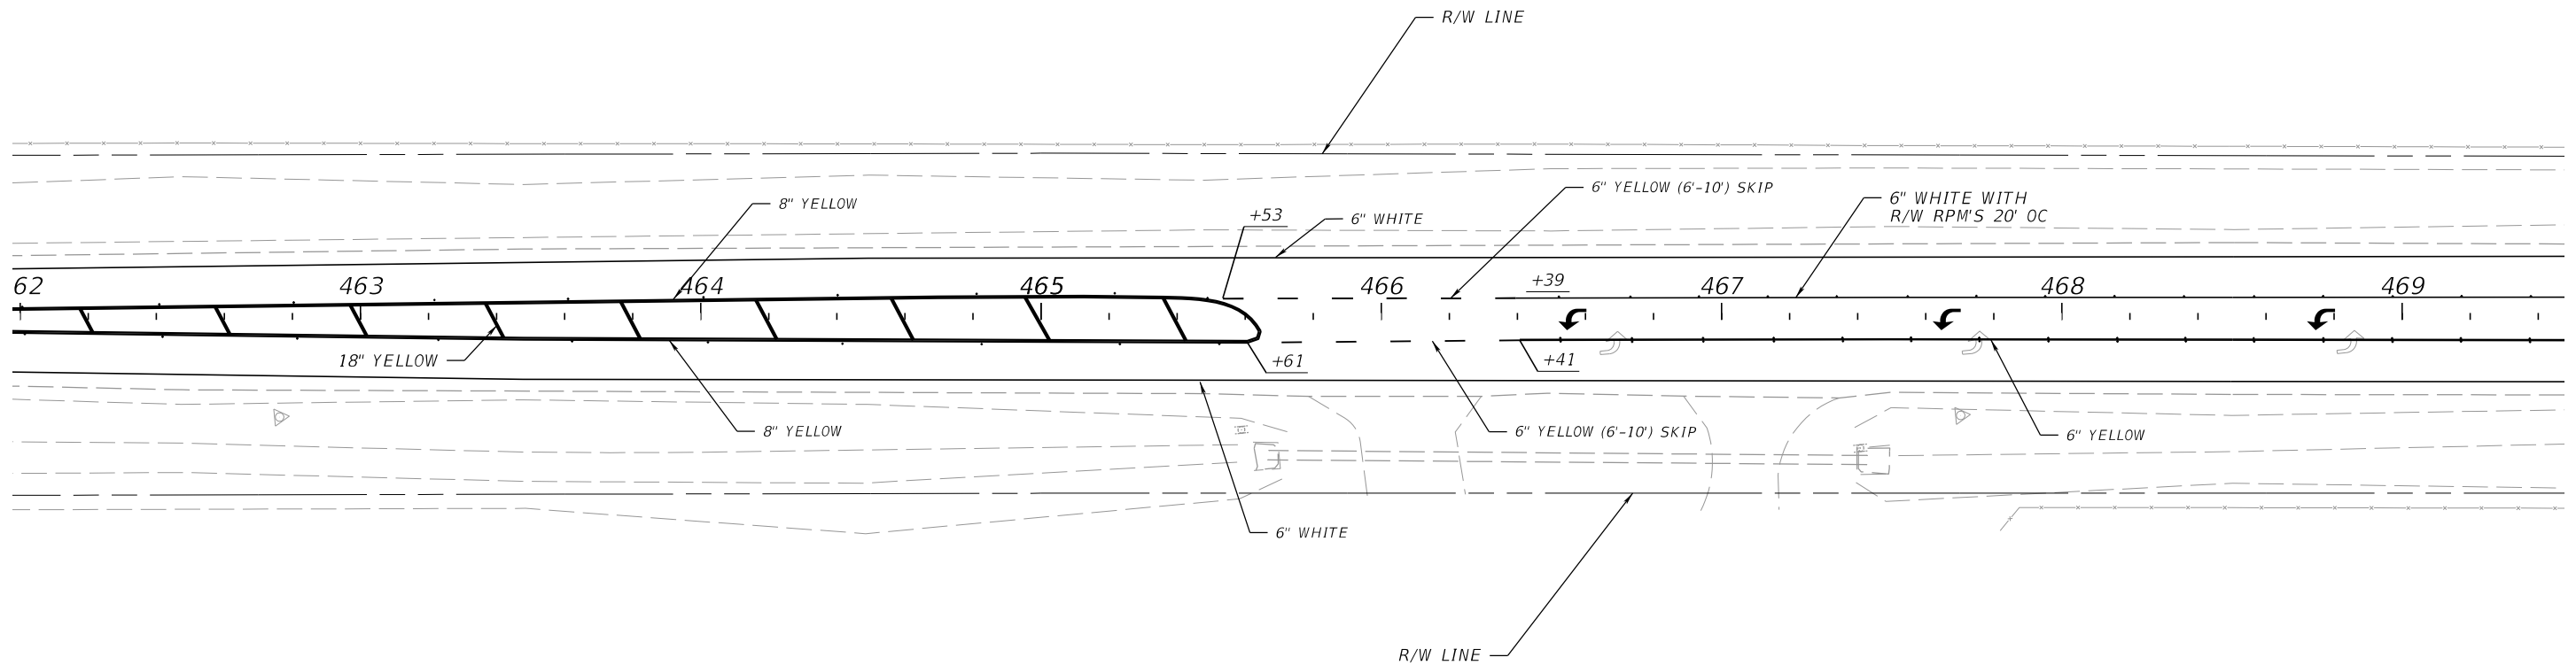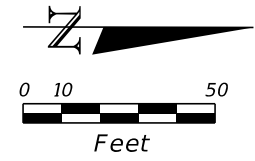

11/9/2023 11:59:41 AM MWADIR  
c:\pwworking\kpkpw01\nassim\nadir\dms05209\PLAN\SP02.dgn

REVISIONS			
DATE	DESCRIPTION	DATE	DESCRIPTION

ENGINEER OF RECORD  
 JOSE A. JARQUIN, P.E.  
 LICENSE NUMBER: 89293  
 AMERICAN STRUCTUREPOINT, INC.  
 5405 CYPRESS CENTER DR, SUITE 310  
 TAMPA, FL 33609



STATE OF FLORIDA DEPARTMENT OF TRANSPORTATION		
ROAD NO.	COUNTY	FINANCIAL PROJECT ID
SR 15	OKEECHOBEE	448974-1-52-01

**SIGNING AND PAVEMENT  
MARKING PLAN**

SHEET NO.  
S-32

THE OFFICIAL RECORD OF THIS SHEET IS THE ELECTRONIC FILE DIGITALLY SIGNED AND SEALED UNDER RULE 61G15-23.004, F.A.C.



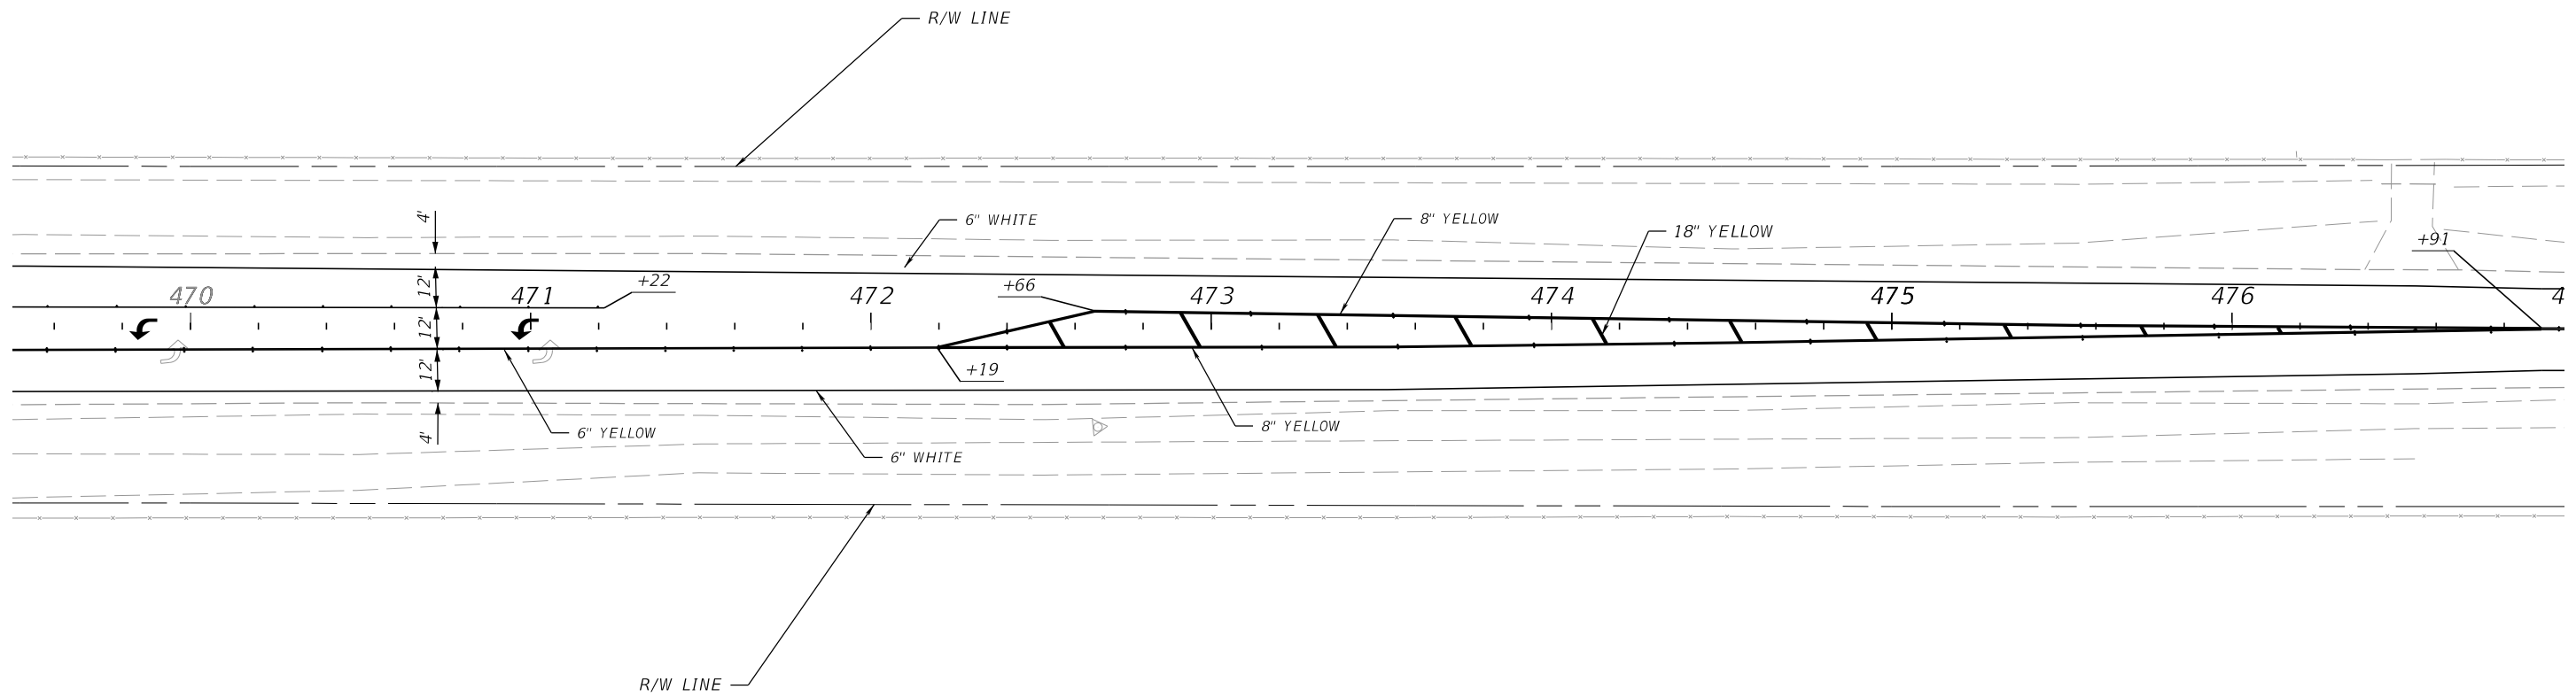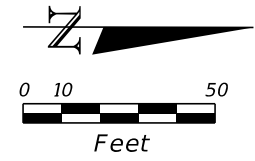

11/9/2023 11:59:43 AM MWADIR  
 c:\pwworking\kpkpw01\nassim\nadir\dms05209\PLAN\SP02.dgn

REVISIONS			
DATE	DESCRIPTION	DATE	DESCRIPTION



**ENGINEER OF RECORD**  
 JOSE A. JARQUIN, P.E.  
 LICENSE NUMBER: 89293  
 AMERICAN STRUCTUREPOINT, INC.  
 5405 CYPRESS CENTER DR, SUITE 310  
 TAMPA, FL 33609

STATE OF FLORIDA DEPARTMENT OF TRANSPORTATION		
ROAD NO.	COUNTY	FINANCIAL PROJECT ID
SR 15	OKEECHOBEE	448974-1-52-01

**SIGNING AND PAVEMENT  
MARKING PLAN**

**SHEET NO.**  
 S-33



THE OFFICIAL RECORD OF THIS SHEET IS THE ELECTRONIC FILE DIGITALLY SIGNED AND SEALED UNDER RULE 61G15-23.004, F.A.C.

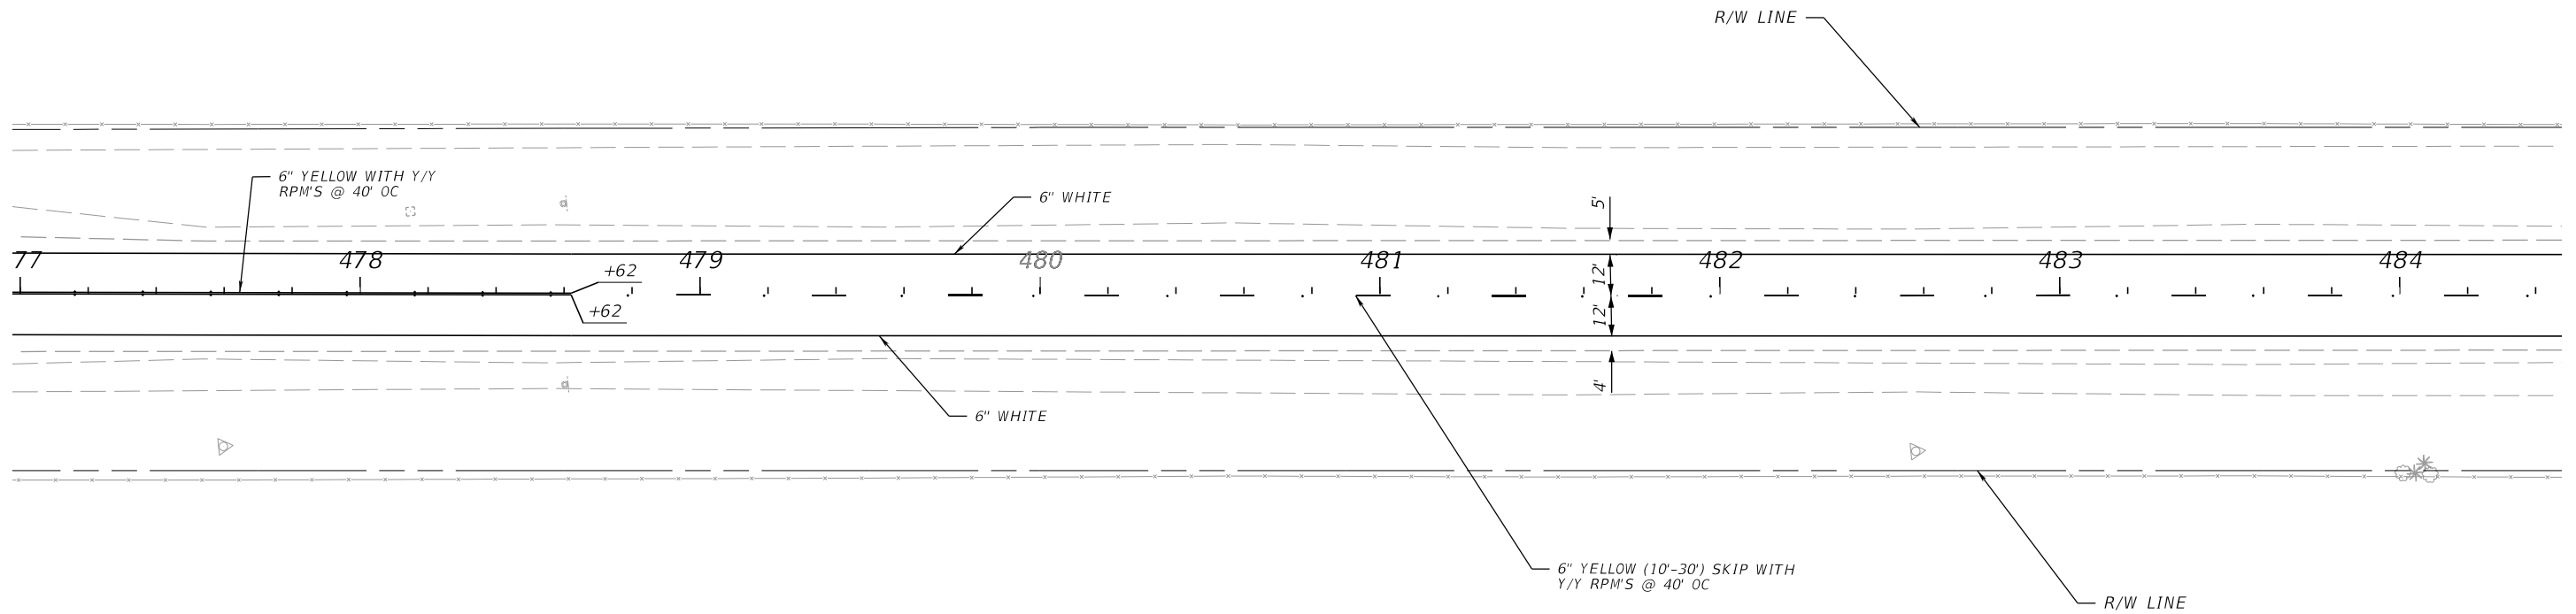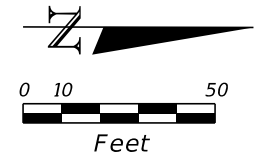

11/9/2023 11:59:46 AM MNADIR c:\pwworking\kpkpw01\massim nadir\dms05209\PLAN\SP02.dgn

THE OFFICIAL RECORD OF THIS SHEET IS THE ELECTRONIC FILE DIGITALLY SIGNED AND SEALED UNDER RULE 61G15-23.004, F.A.C.



REVISIONS				ENGINEER OF RECORD		STATE OF FLORIDA DEPARTMENT OF TRANSPORTATION			<b>SIGNING AND PAVEMENT MARKING PLAN</b>	SHEET NO.
DATE	DESCRIPTION	DATE	DESCRIPTION	JOSE A. JARQUIN, P.E. LICENSE NUMBER: 89293 AMERICAN STRUCTUREPOINT, INC. 5405 CYPRESS CENTER DR, SUITE 310 TAMPA, FL 33609		ROAD NO.	COUNTY	FINANCIAL PROJECT ID		S-34
						SR 15	OKEECHOBEE	448974-1-52-01		

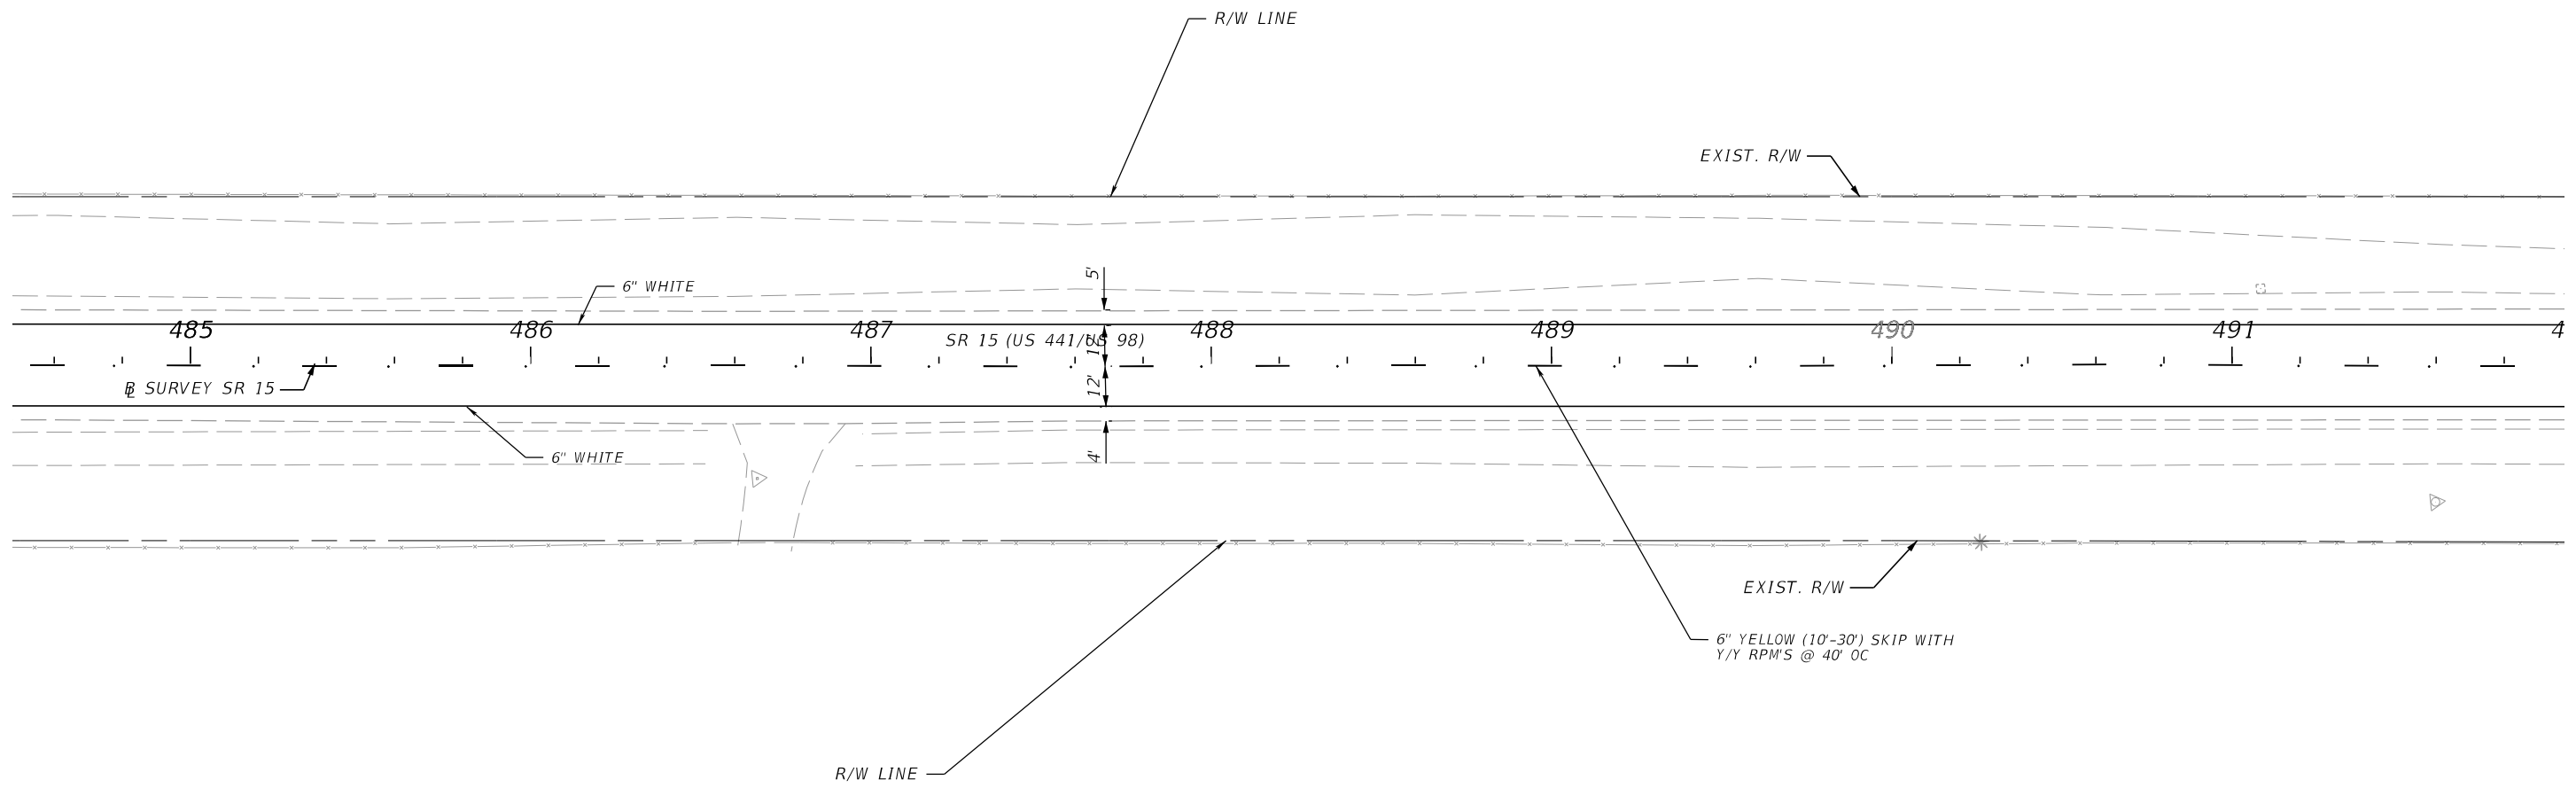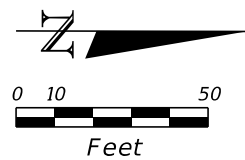

11/9/2023 11:59:49 AM MWADIR c:\pwworking\kpkpw01\massim\nadir\dms05209\PLAN\SP02.dgn

THE OFFICIAL RECORD OF THIS SHEET IS THE ELECTRONIC FILE DIGITALLY SIGNED AND SEALED UNDER RULE 61G15-23.004, F.A.C.

REVISIONS				ENGINEER OF RECORD		STATE OF FLORIDA DEPARTMENT OF TRANSPORTATION			SIGNING AND PAVEMENT MARKING PLAN	SHEET NO.	
DATE	DESCRIPTION	DATE	DESCRIPTION				ROAD NO.	COUNTY		FINANCIAL PROJECT ID	
				JOSE A. JARQUIN, P.E. LICENSE NUMBER: 89293 AMERICAN STRUCTUREPOINT, INC. 5405 CYPRESS CENTER DR, SUITE 310 TAMPA, FL 33609			SR 15	OKEECHOBEE		448974-1-52-01	S-35

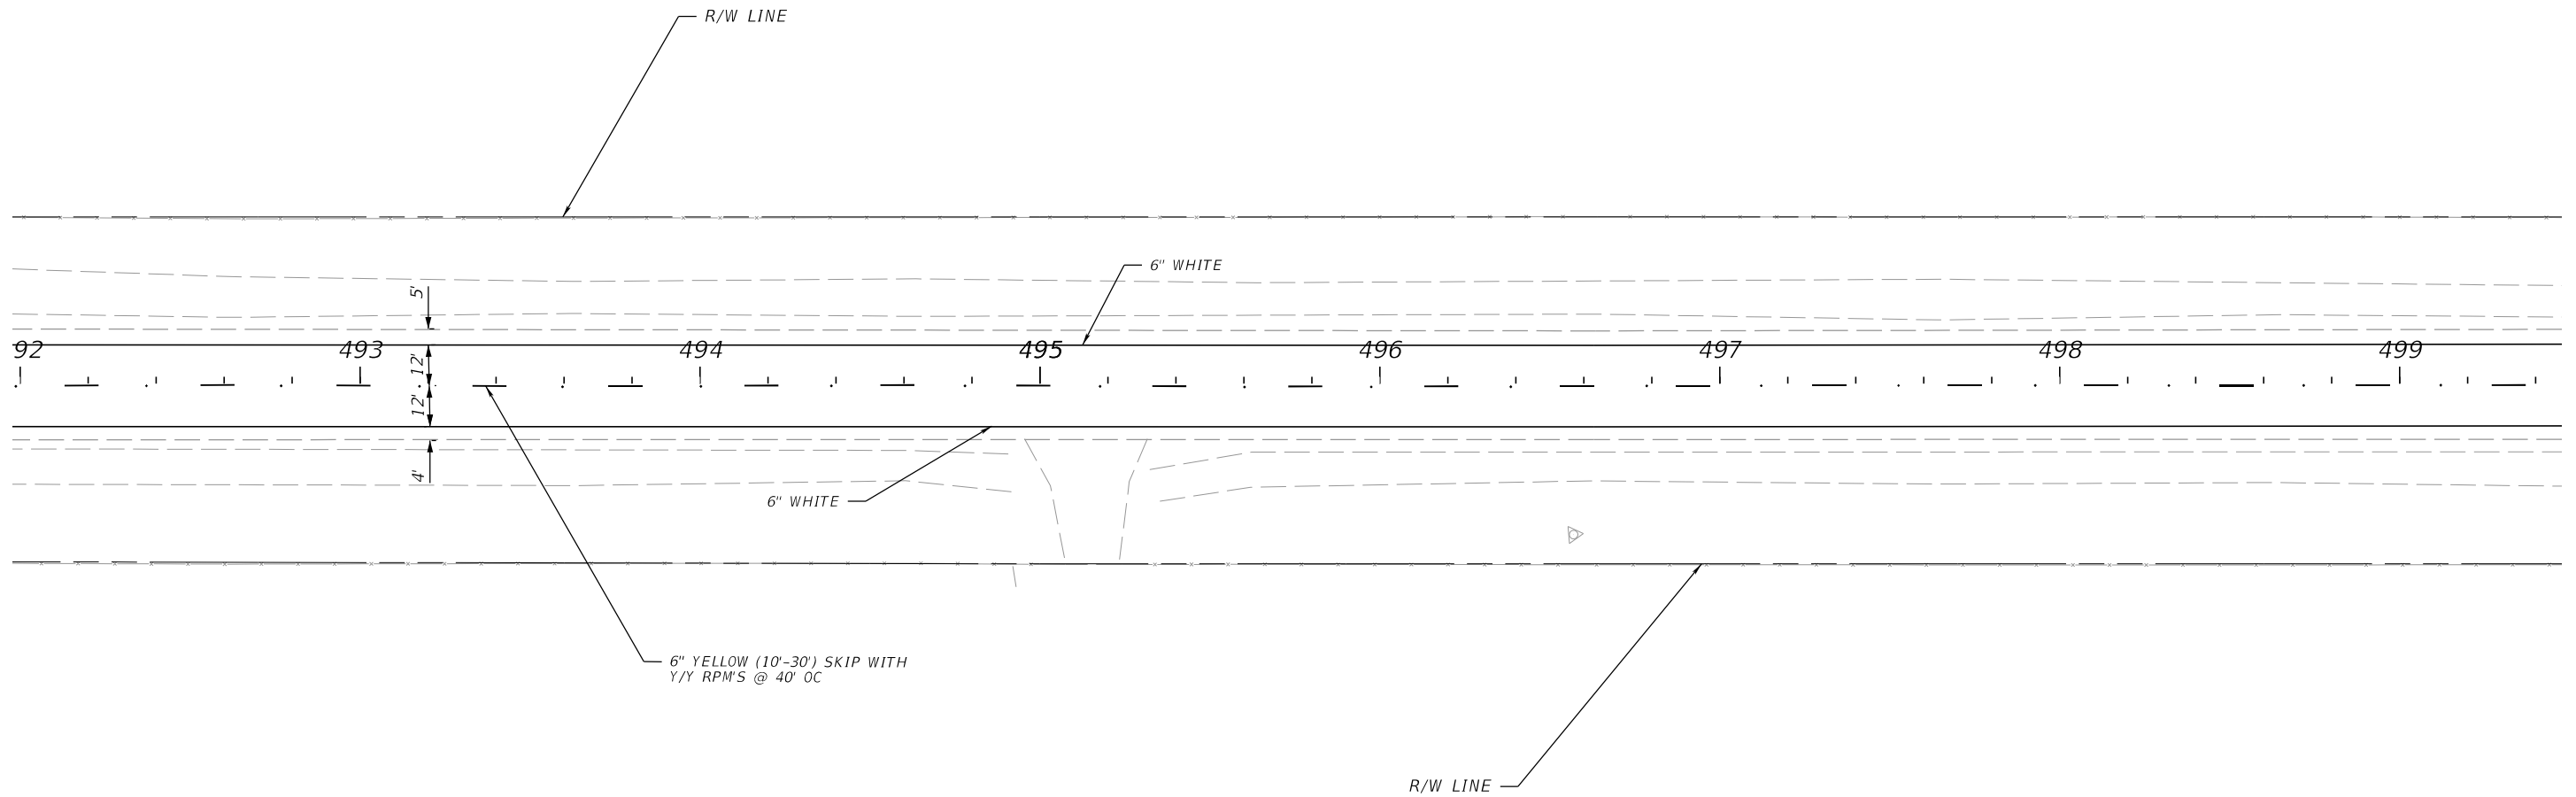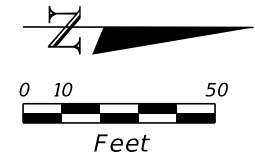

11/9/2023 11:59:52 AM MNADIR  
 c:\pwworking\kpkpw01\massim nadir\dms05209\PLAN\SP02.dgn

REVISIONS			
DATE	DESCRIPTION	DATE	DESCRIPTION



**ENGINEER OF RECORD**  
 JOSE A. JARQUIN, P.E.  
 LICENSE NUMBER: 89293  
 AMERICAN STRUCTUREPOINT, INC.  
 5405 CYPRESS CENTER DR, SUITE 310  
 TAMPA, FL 33609

STATE OF FLORIDA DEPARTMENT OF TRANSPORTATION		
ROAD NO.	COUNTY	FINANCIAL PROJECT ID
SR 15	OKEECHOBEE	448974-1-52-01

**SIGNING AND PAVEMENT  
MARKING PLAN**

**SHEET NO.**  
 S-36

THE OFFICIAL RECORD OF THIS SHEET IS THE ELECTRONIC FILE DIGITALLY SIGNED AND SEALED UNDER RULE 61G15-23.004, F.A.C.

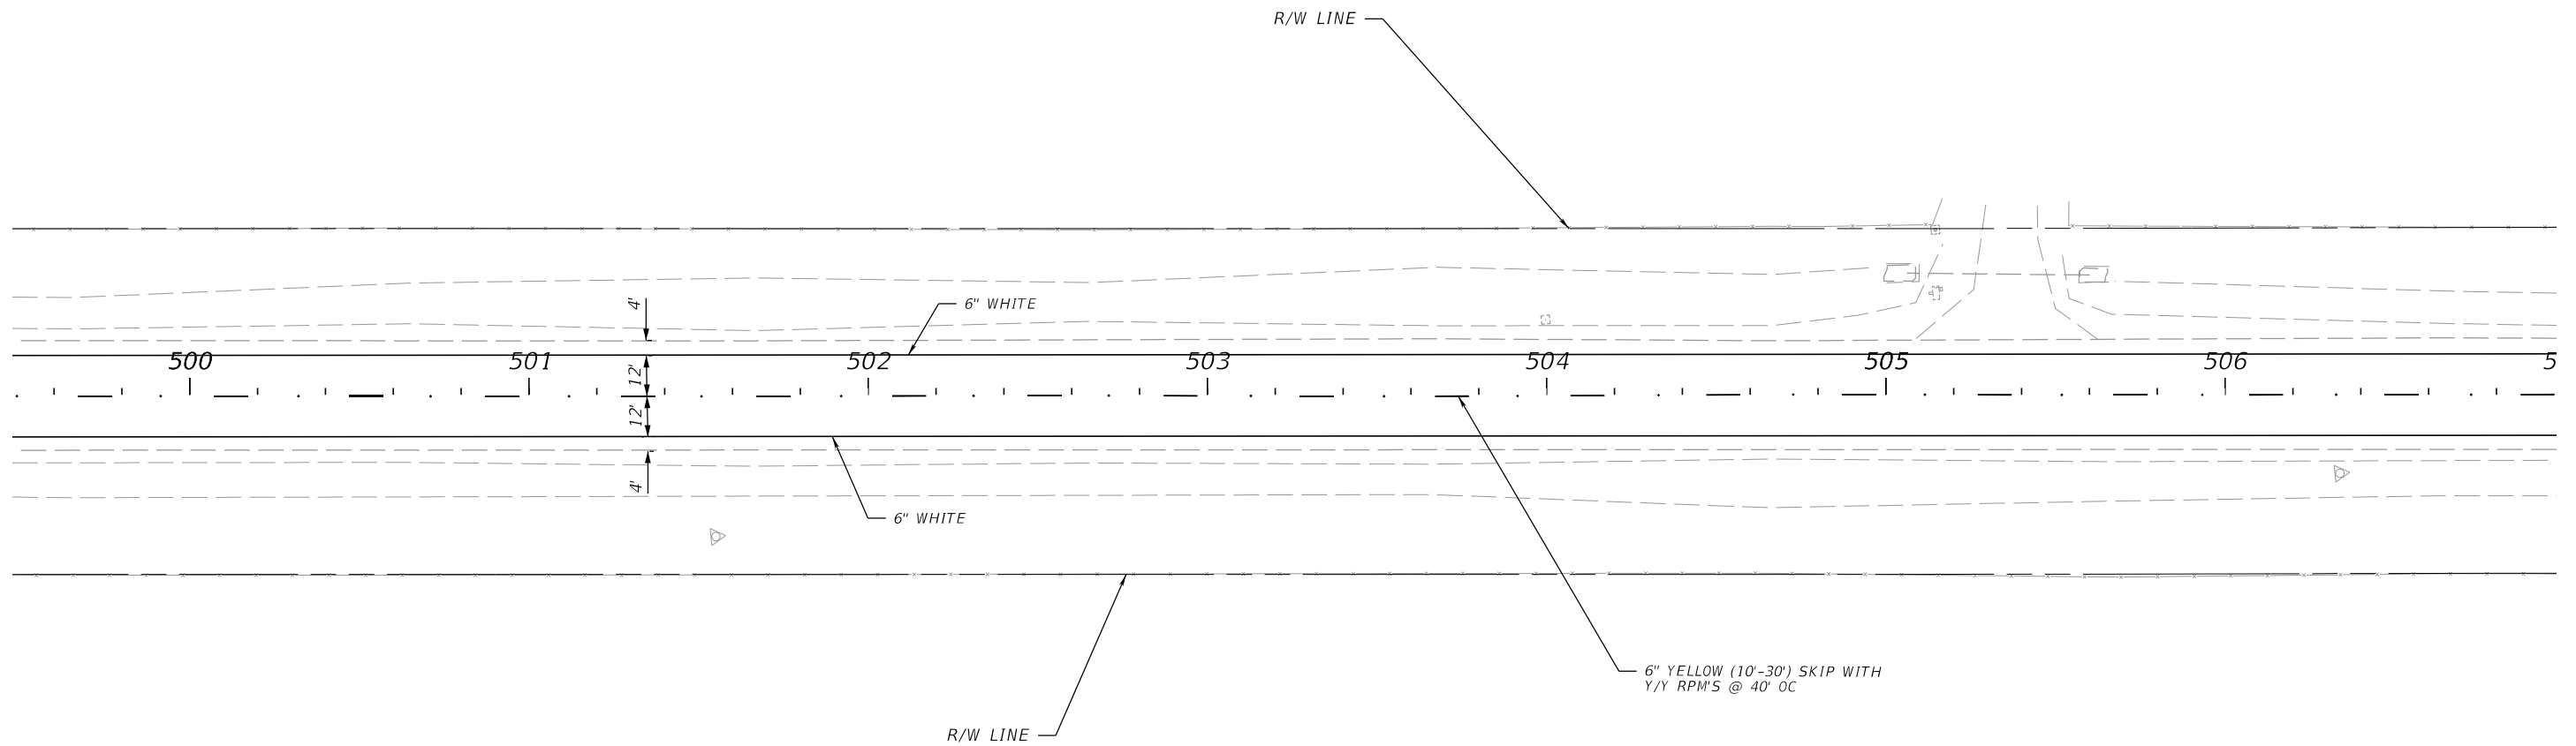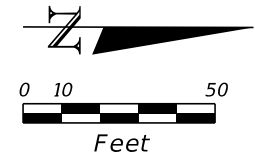

11/9/2023 11:59:54 AM MWADIR c:\pwworking\kpkpw01\nassim nadir\dms05209\PLAN\SP02.dgn

REVISIONS			
DATE	DESCRIPTION	DATE	DESCRIPTION



ENGINEER OF RECORD  
 JOSE A. JARQUIN, P.E.  
 LICENSE NUMBER: 89293  
 AMERICAN STRUCTUREPOINT, INC.  
 5405 CYPRESS CENTER DR, SUITE 310  
 TAMPA, FL 33609

STATE OF FLORIDA DEPARTMENT OF TRANSPORTATION		
ROAD NO.	COUNTY	FINANCIAL PROJECT ID
SR 15	OKEECHOBEE	448974-1-52-01

**SIGNING AND PAVEMENT  
MARKING PLAN**

SHEET NO.  
S-37

THE OFFICIAL RECORD OF THIS SHEET IS THE ELECTRONIC FILE DIGITALLY SIGNED AND SEALED UNDER RULE 61G15-23.004, F.A.C.

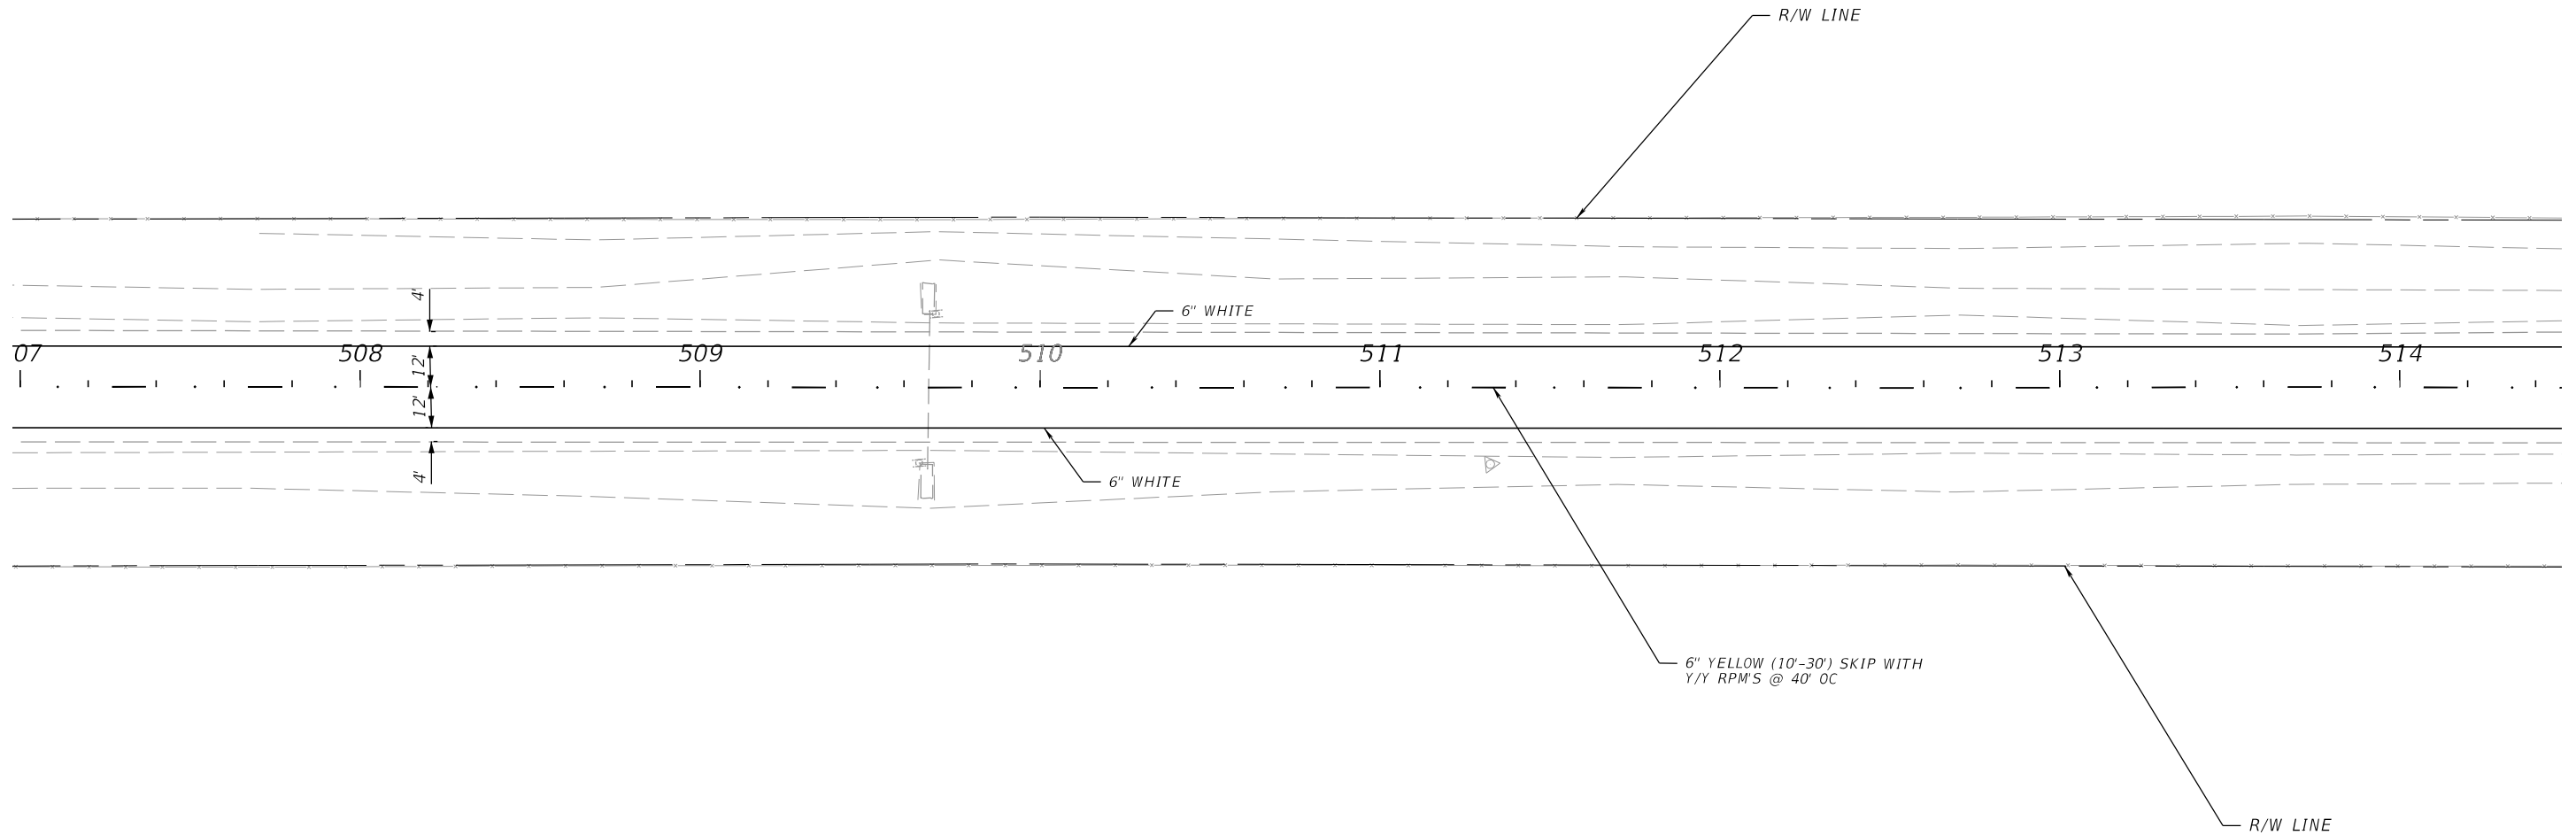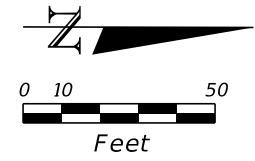

11/9/2023 11:59:57 AM MWADIR  
 c:\pwworking\kpkpw01\massim nadir\dms05209\PLAN\SP02.dgn

REVISIONS			
DATE	DESCRIPTION	DATE	DESCRIPTION



**ENGINEER OF RECORD**  
 JOSE A. JARQUIN, P.E.  
 LICENSE NUMBER: 89293  
 AMERICAN STRUCTUREPOINT, INC.  
 5405 CYPRESS CENTER DR, SUITE 310  
 TAMPA, FL 33609

STATE OF FLORIDA DEPARTMENT OF TRANSPORTATION		
ROAD NO.	COUNTY	FINANCIAL PROJECT ID
SR 15	OKEECHOBEE	448974-1-52-01

**SIGNING AND PAVEMENT  
MARKING PLAN**

**SHEET NO.**  
 S-38

THE OFFICIAL RECORD OF THIS SHEET IS THE ELECTRONIC FILE DIGITALLY SIGNED AND SEALED UNDER RULE 61G15-23.004, F.A.C.

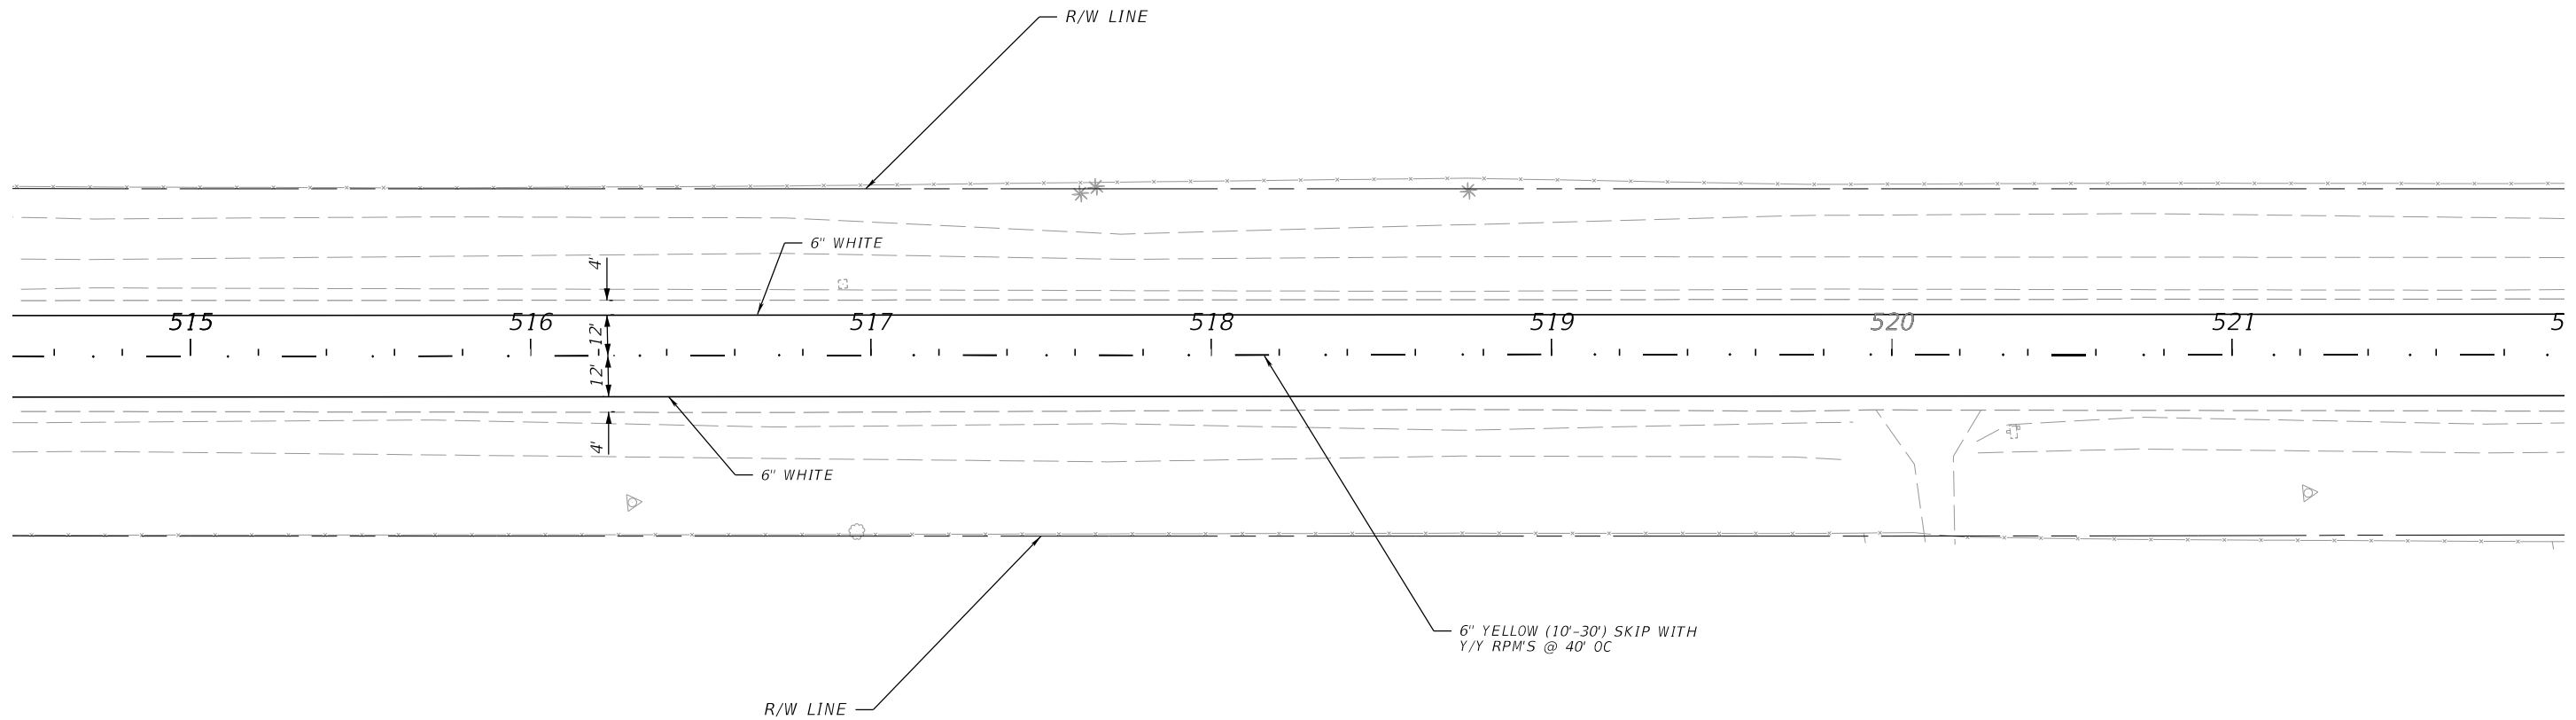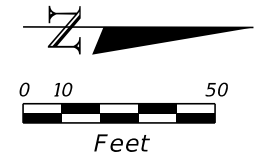

11/9/2023 12:00:00 PM MNADIR c:\pwworking\kpkpw01\massim nadir\dms05209\PLAN\SP02.dgn

REVISIONS			
DATE	DESCRIPTION	DATE	DESCRIPTION



ENGINEER OF RECORD  
 JOSE A. JARQUIN, P.E.  
 LICENSE NUMBER: 89293  
 AMERICAN STRUCTUREPOINT, INC.  
 5405 CYPRESS CENTER DR, SUITE 310  
 TAMPA, FL 33609

STATE OF FLORIDA DEPARTMENT OF TRANSPORTATION		
ROAD NO.	COUNTY	FINANCIAL PROJECT ID
SR 15	OKEECHOBEE	448974-1-52-01

**SIGNING AND PAVEMENT  
MARKING PLAN**

SHEET NO.  
S-39

THE OFFICIAL RECORD OF THIS SHEET IS THE ELECTRONIC FILE DIGITALLY SIGNED AND SEALED UNDER RULE 61G15-23.004, F.A.C.

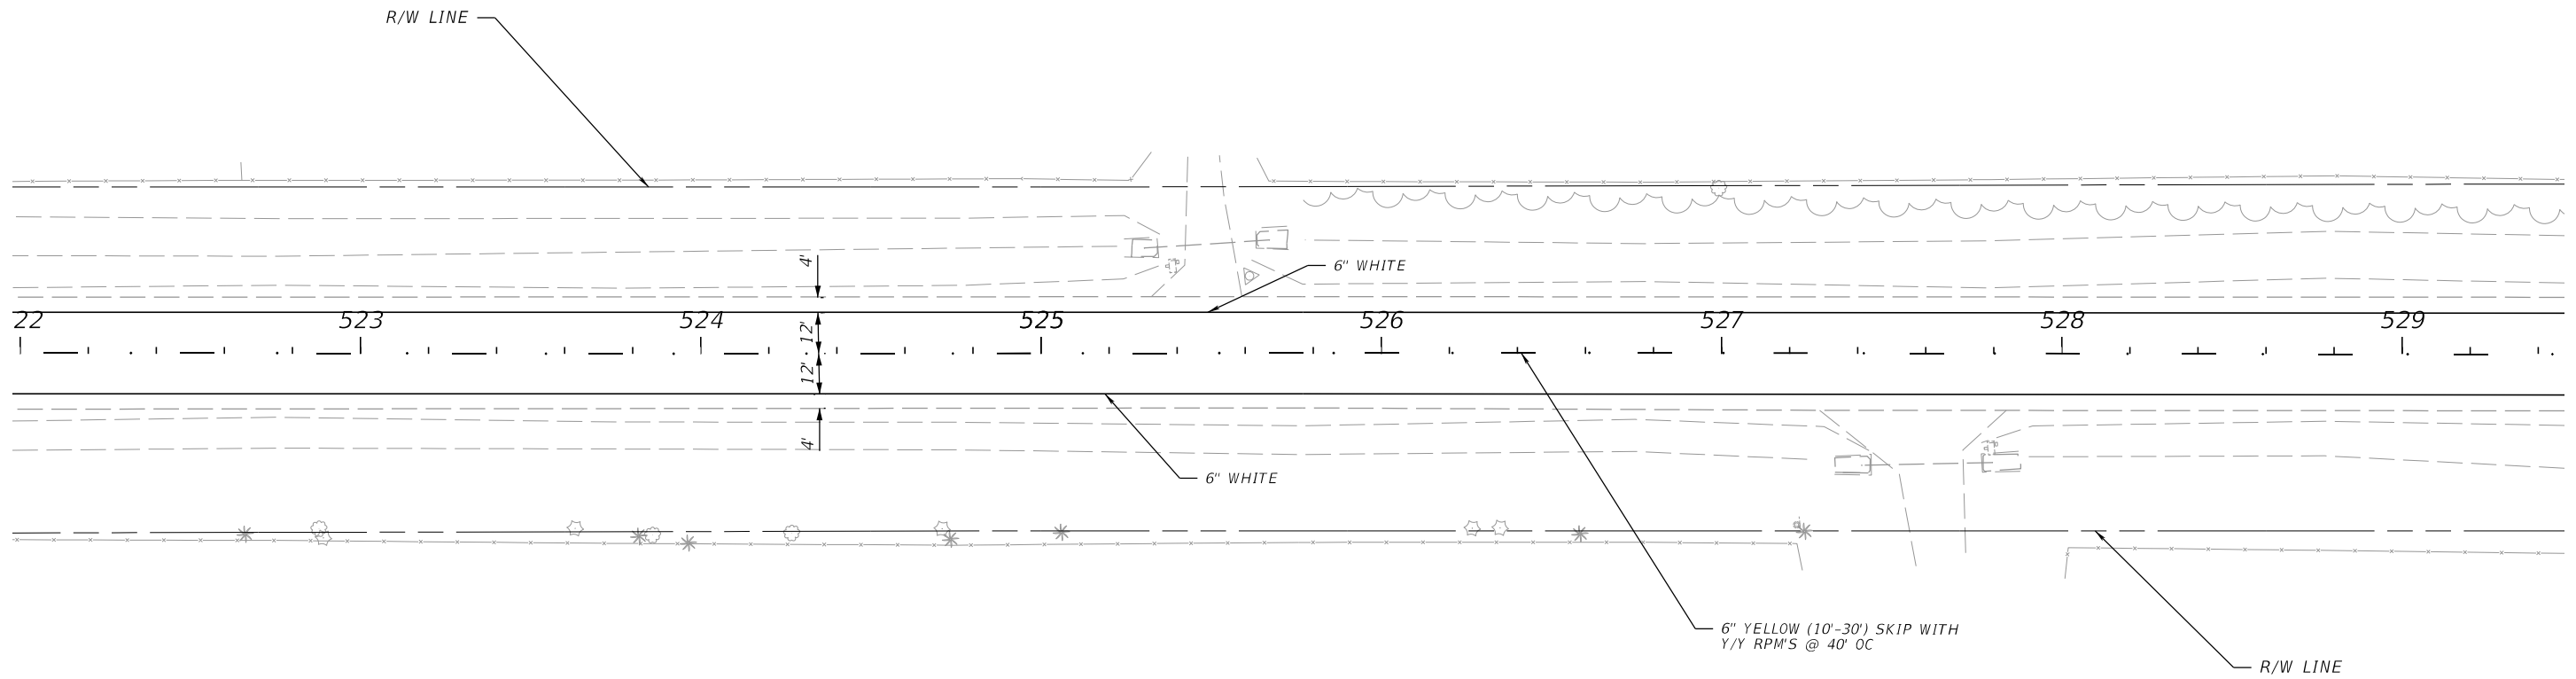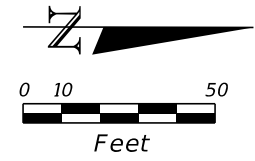

11/9/2023 12:00:03 PM MNADIR c:\pwworking\kkipw01\nassim\nadir\dms05209\PLAN\SP02.dgn

REVISIONS			
DATE	DESCRIPTION	DATE	DESCRIPTION

ENGINEER OF RECORD  
 JOSE A. JARQUIN, P.E.  
 LICENSE NUMBER: 89293  
 AMERICAN STRUCTUREPOINT, INC.  
 5405 CYPRESS CENTER DR, SUITE 310  
 TAMPA, FL 33609



STATE OF FLORIDA DEPARTMENT OF TRANSPORTATION		
ROAD NO.	COUNTY	FINANCIAL PROJECT ID
SR 15	OKEECHOBEE	448974-1-52-01

**SIGNING AND PAVEMENT  
MARKING PLAN**

SHEET NO.  
S-40

THE OFFICIAL RECORD OF THIS SHEET IS THE ELECTRONIC FILE DIGITALLY SIGNED AND SEALED UNDER RULE 61G15-23.004, F.A.C.



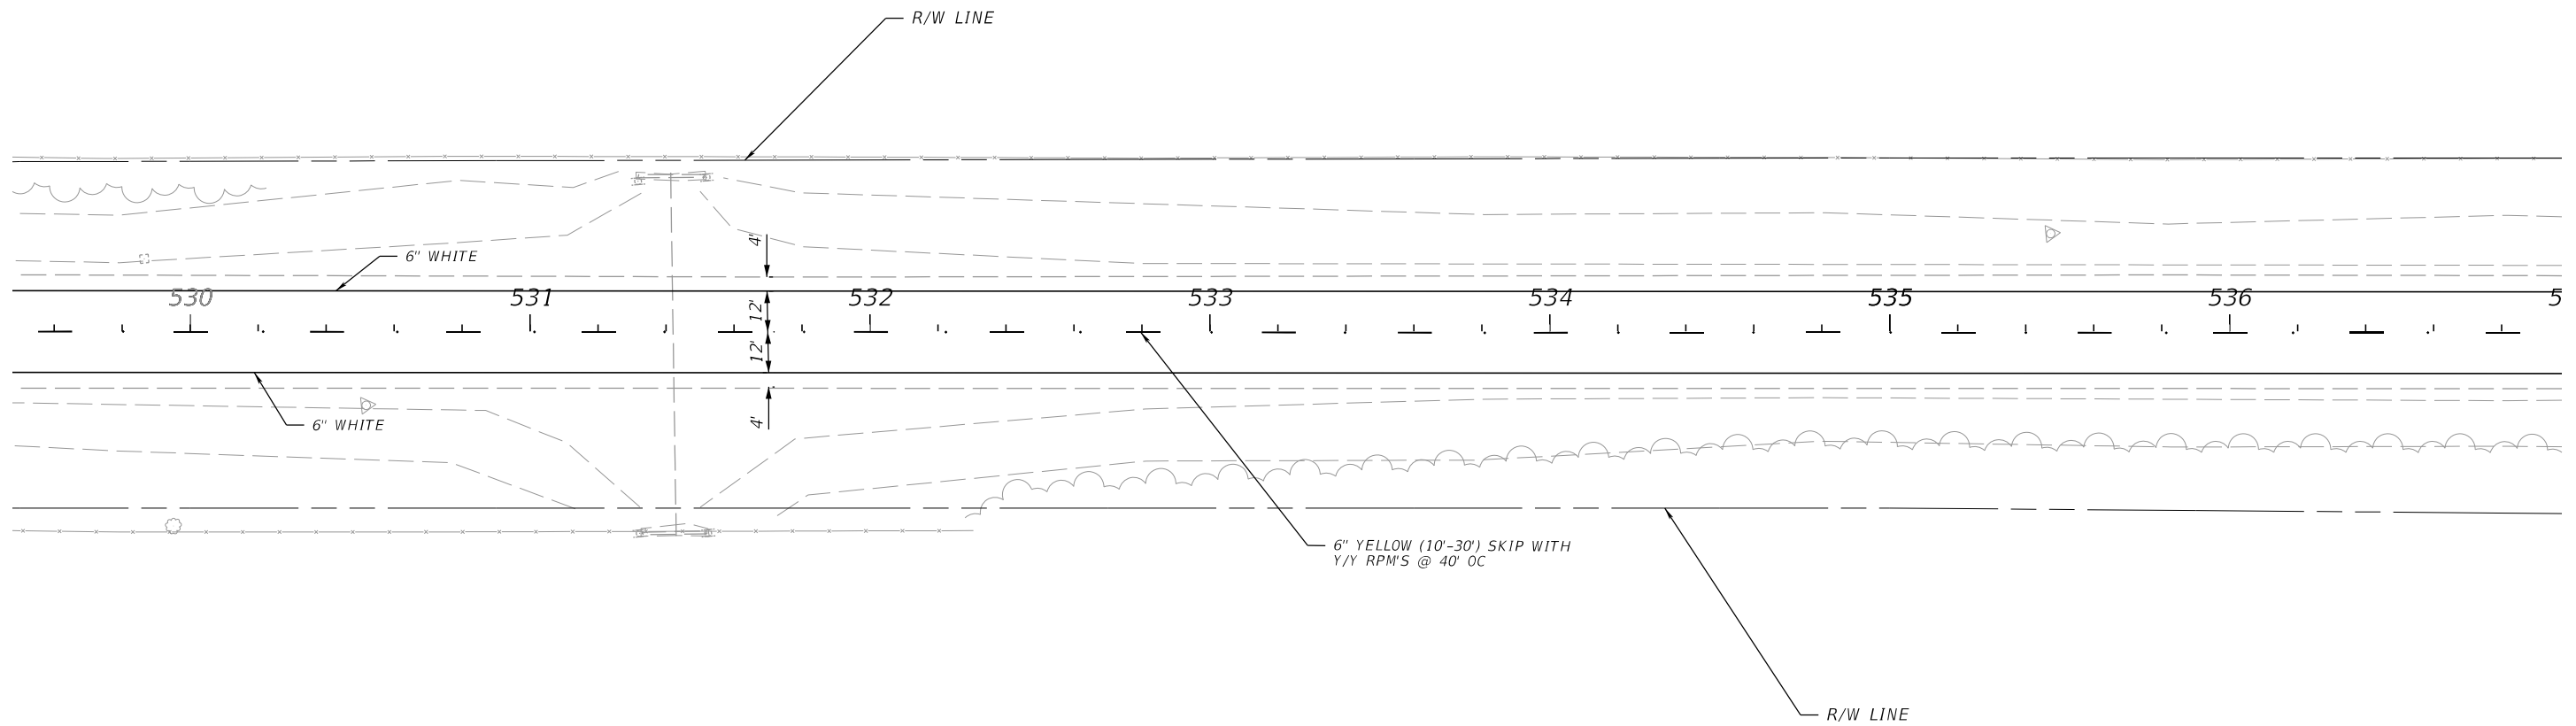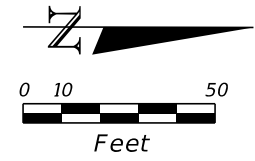

11/9/2023 12:00:06 PM MNADIR  
 c:\pwworking\kpkpw01\nassim\nadir\dms05209\PLAN\SP02.dgn

REVISIONS			
DATE	DESCRIPTION	DATE	DESCRIPTION



**ENGINEER OF RECORD**  
 JOSE A. JARQUIN, P.E.  
 LICENSE NUMBER: 89293  
 AMERICAN STRUCTUREPOINT, INC.  
 5405 CYPRESS CENTER DR, SUITE 310  
 TAMPA, FL 33609

STATE OF FLORIDA DEPARTMENT OF TRANSPORTATION		
ROAD NO.	COUNTY	FINANCIAL PROJECT ID
SR 15	OKEECHOBEE	448974-1-52-01

**SIGNING AND PAVEMENT  
MARKING PLAN**

SHEET NO.  
 S-41



THE OFFICIAL RECORD OF THIS SHEET IS THE ELECTRONIC FILE DIGITALLY SIGNED AND SEALED UNDER RULE 61G15-23.004, F.A.C.

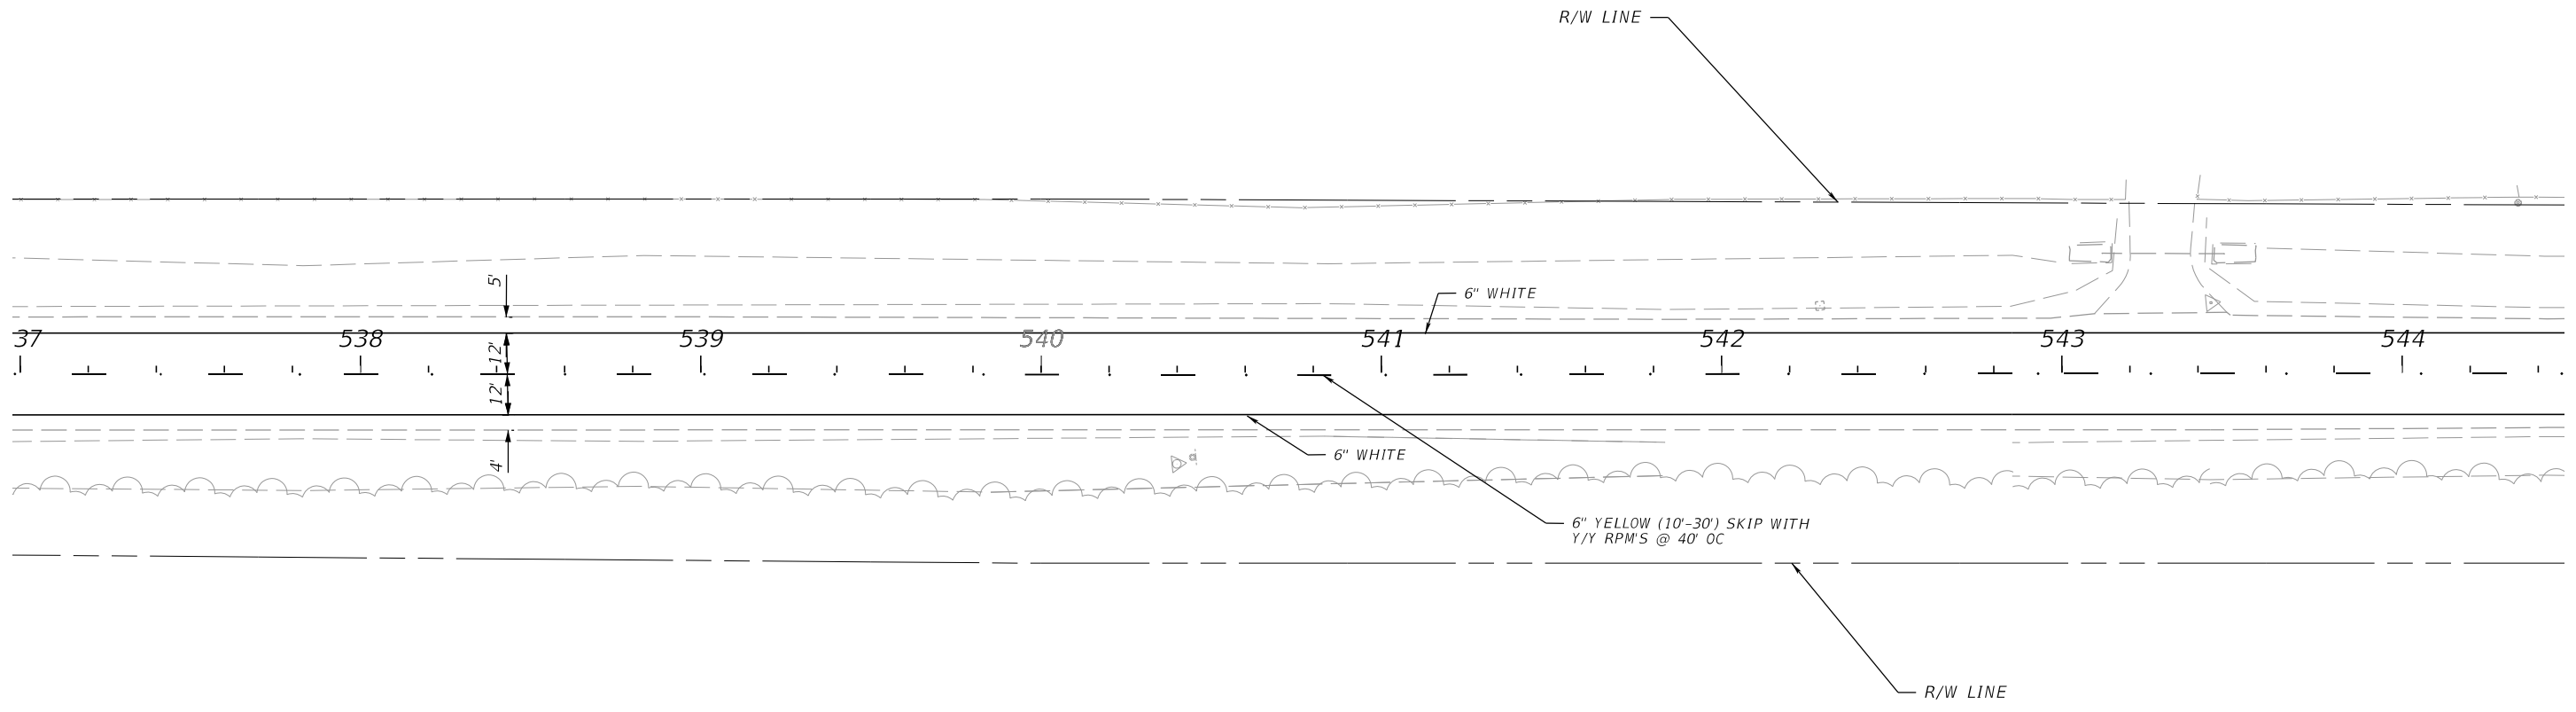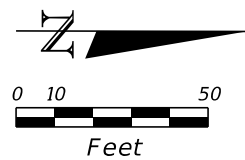

11/9/2023 12:00:09 PM MNADIR c:\pwworking\kkipw01\nassim\adir\dms05209\PLAN\SP02.dgn

THE OFFICIAL RECORD OF THIS SHEET IS THE ELECTRONIC FILE DIGITALLY SIGNED AND SEALED UNDER RULE 61G15-23.004, F.A.C.

REVISIONS				ENGINEER OF RECORD		STATE OF FLORIDA DEPARTMENT OF TRANSPORTATION			<b>SIGNING AND PAVEMENT MARKING PLAN</b>	SHEET NO.
DATE	DESCRIPTION	DATE	DESCRIPTION	JOSE A. JARQUIN, P.E. LICENSE NUMBER: 89293 AMERICAN STRUCTUREPOINT, INC. 5405 CYPRESS CENTER DR, SUITE 310 TAMPA, FL 33609		ROAD NO.	COUNTY	FINANCIAL PROJECT ID		S-42
						SR 15	OKEECHOBEE	448974-1-52-01		

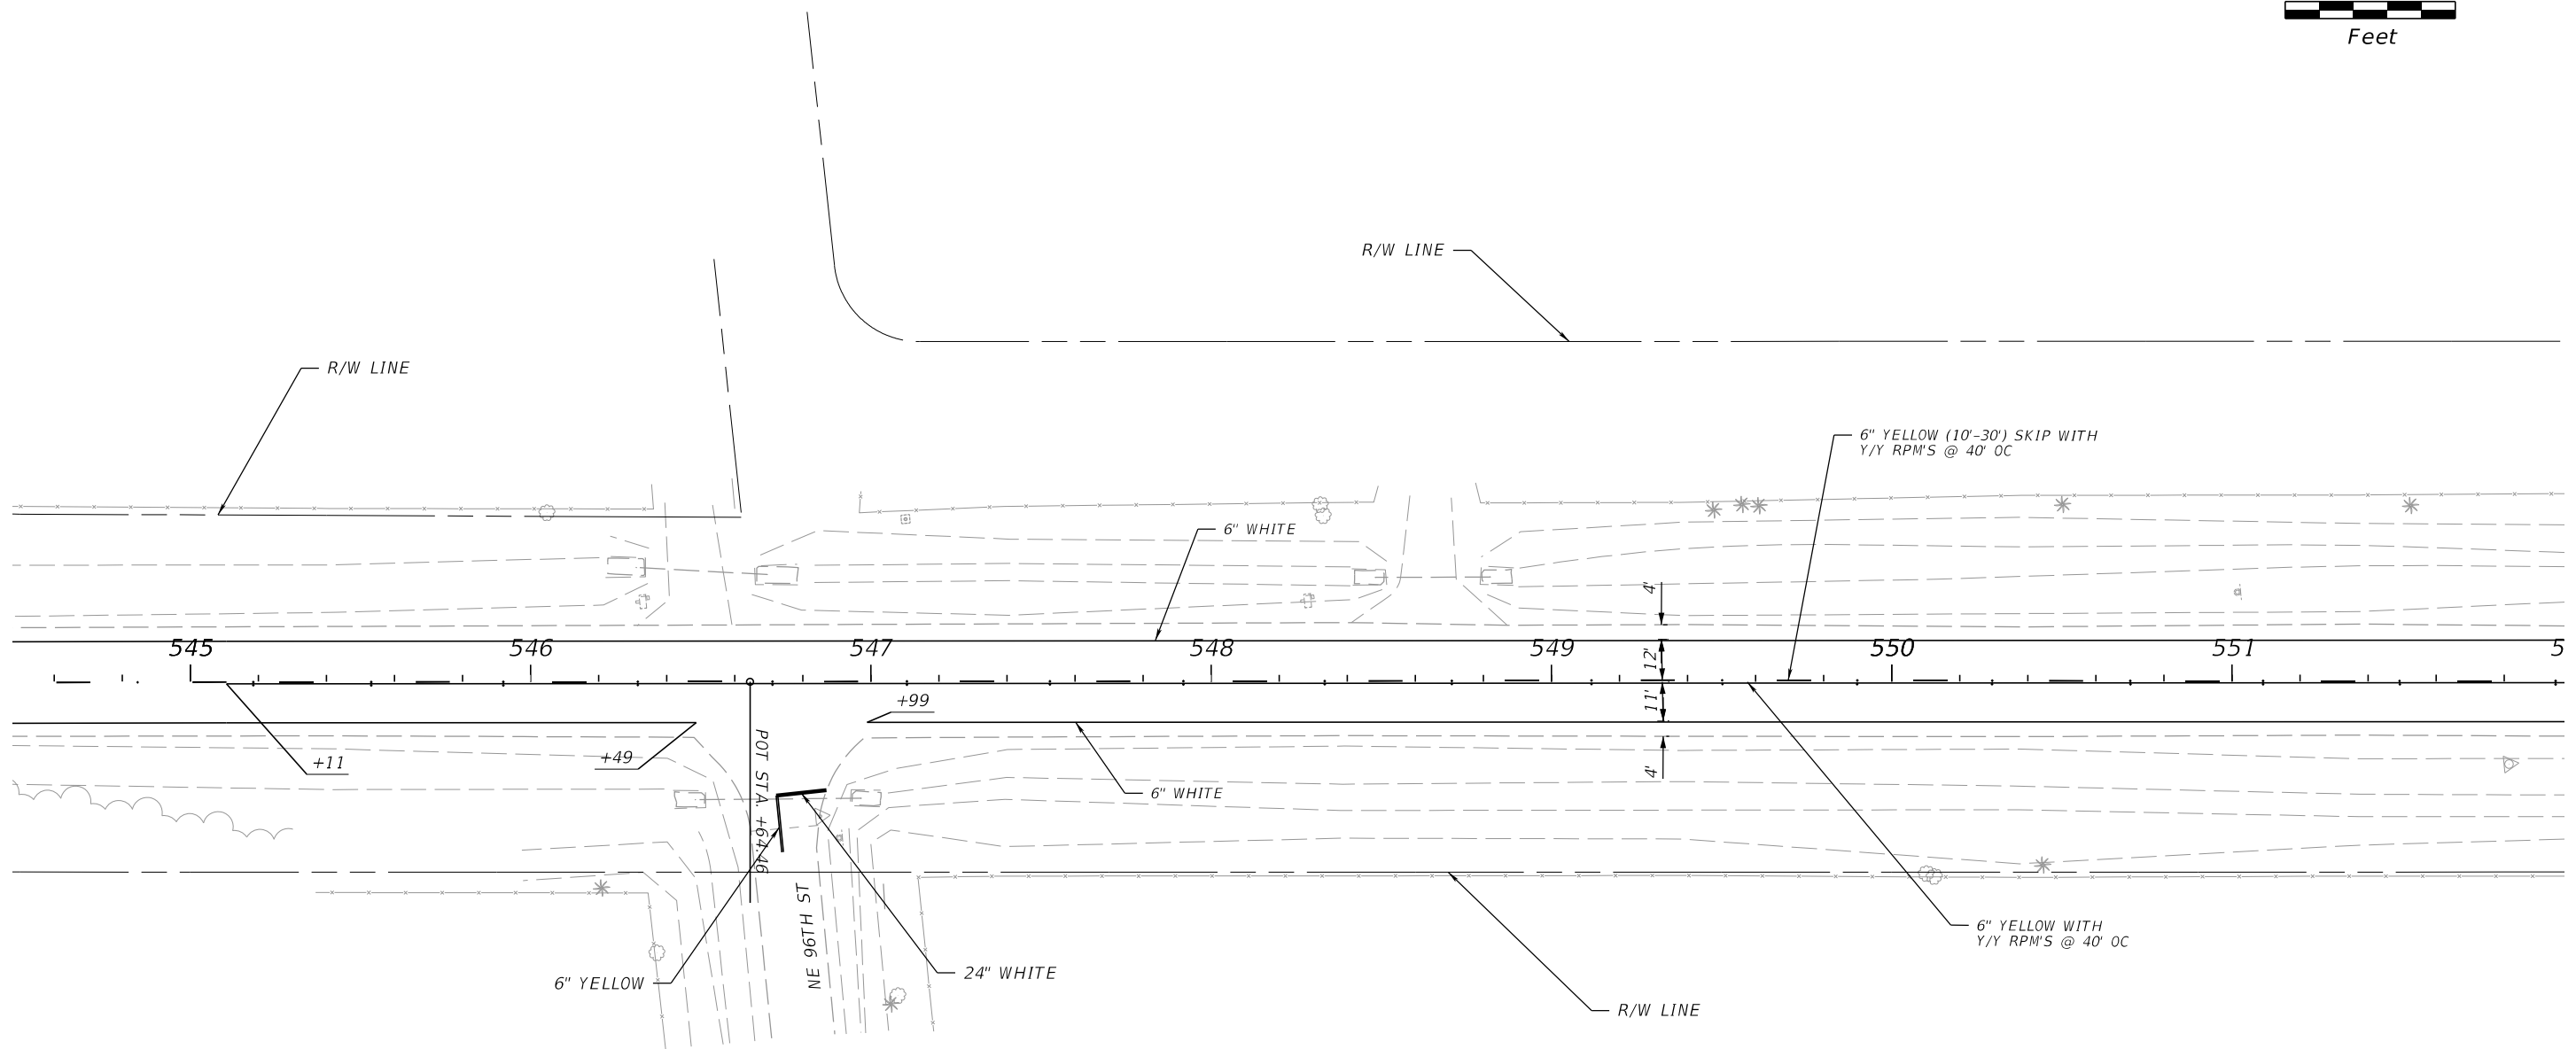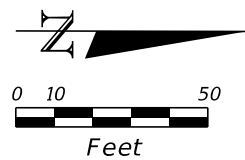

11/9/2023 12:00:11 PM MNADIR c:\pwworking\kkipw01\massim nadir\dms05209\PLAN\SP02.dgn

REVISIONS			
DATE	DESCRIPTION	DATE	DESCRIPTION



ENGINEER OF RECORD  
 JOSE A. JARQUIN, P.E.  
 LICENSE NUMBER: 89293  
 AMERICAN STRUCTUREPOINT, INC.  
 5405 CYPRESS CENTER DR, SUITE 310  
 TAMPA, FL 33609

STATE OF FLORIDA DEPARTMENT OF TRANSPORTATION		
ROAD NO.	COUNTY	FINANCIAL PROJECT ID
SR 15	OKEECHOBEE	448974-1-52-01

**SIGNING AND PAVEMENT  
MARKING PLAN**

SHEET NO.  
S-43

THE OFFICIAL RECORD OF THIS SHEET IS THE ELECTRONIC FILE DIGITALLY SIGNED AND SEALED UNDER RULE 61G15-23.004, F.A.C.

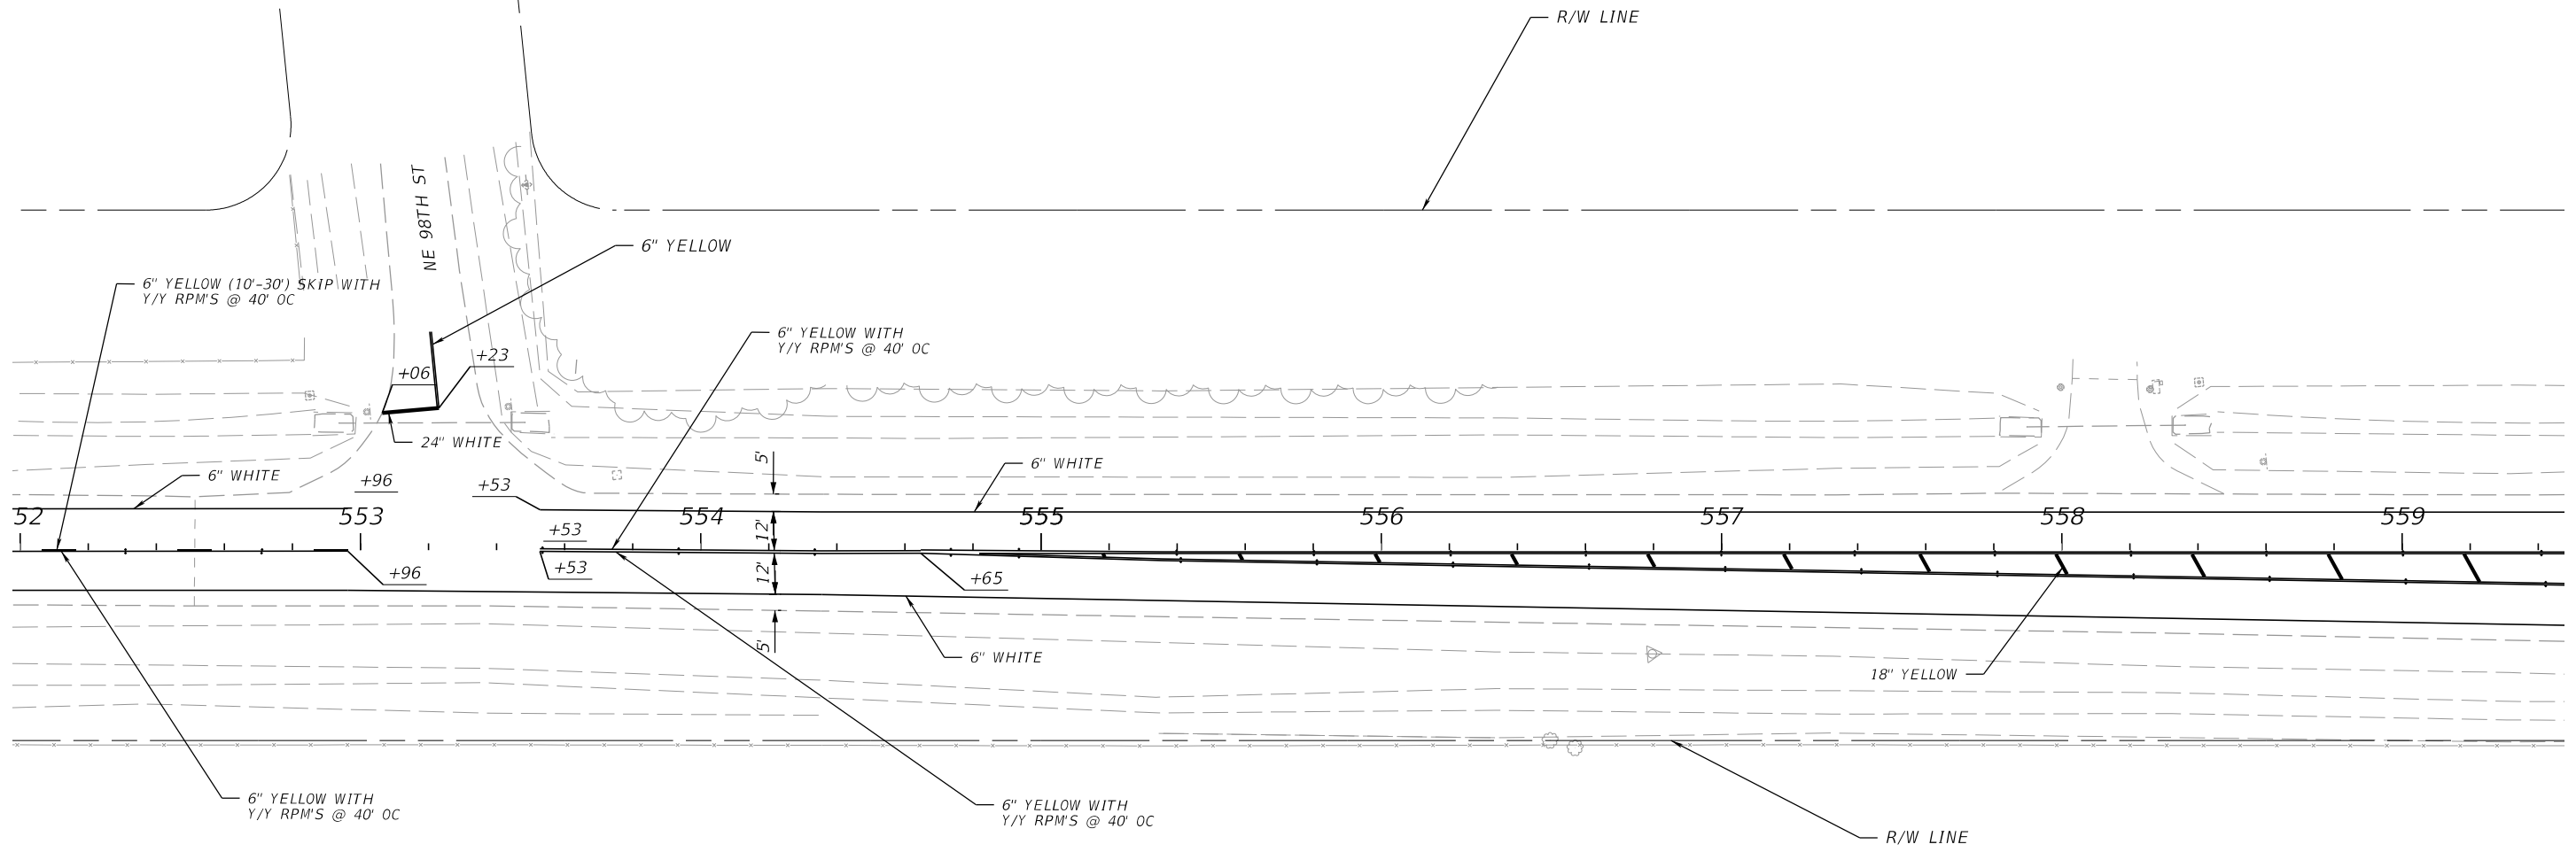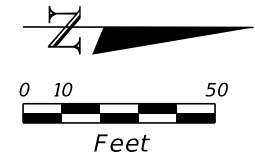

11/9/2023 12:00:14 PM MNADIR c:\pwworking\kpkpw01\nadim\adim\dm505209\PLAN\SP02.dgn

REVISIONS			
DATE	DESCRIPTION	DATE	DESCRIPTION



ENGINEER OF RECORD  
 JOSE A. JARQUIN, P.E.  
 LICENSE NUMBER: 89293  
 AMERICAN STRUCTUREPOINT, INC.  
 5405 CYPRESS CENTER DR, SUITE 310  
 TAMPA, FL 33609

STATE OF FLORIDA DEPARTMENT OF TRANSPORTATION		
ROAD NO.	COUNTY	FINANCIAL PROJECT ID
SR 15	OKEECHOBEE	448974-1-52-01

**SIGNING AND PAVEMENT  
MARKING PLAN**

SHEET NO.  
S-44



THE OFFICIAL RECORD OF THIS SHEET IS THE ELECTRONIC FILE DIGITALLY SIGNED AND SEALED UNDER RULE 61G15-23.004, F.A.C.

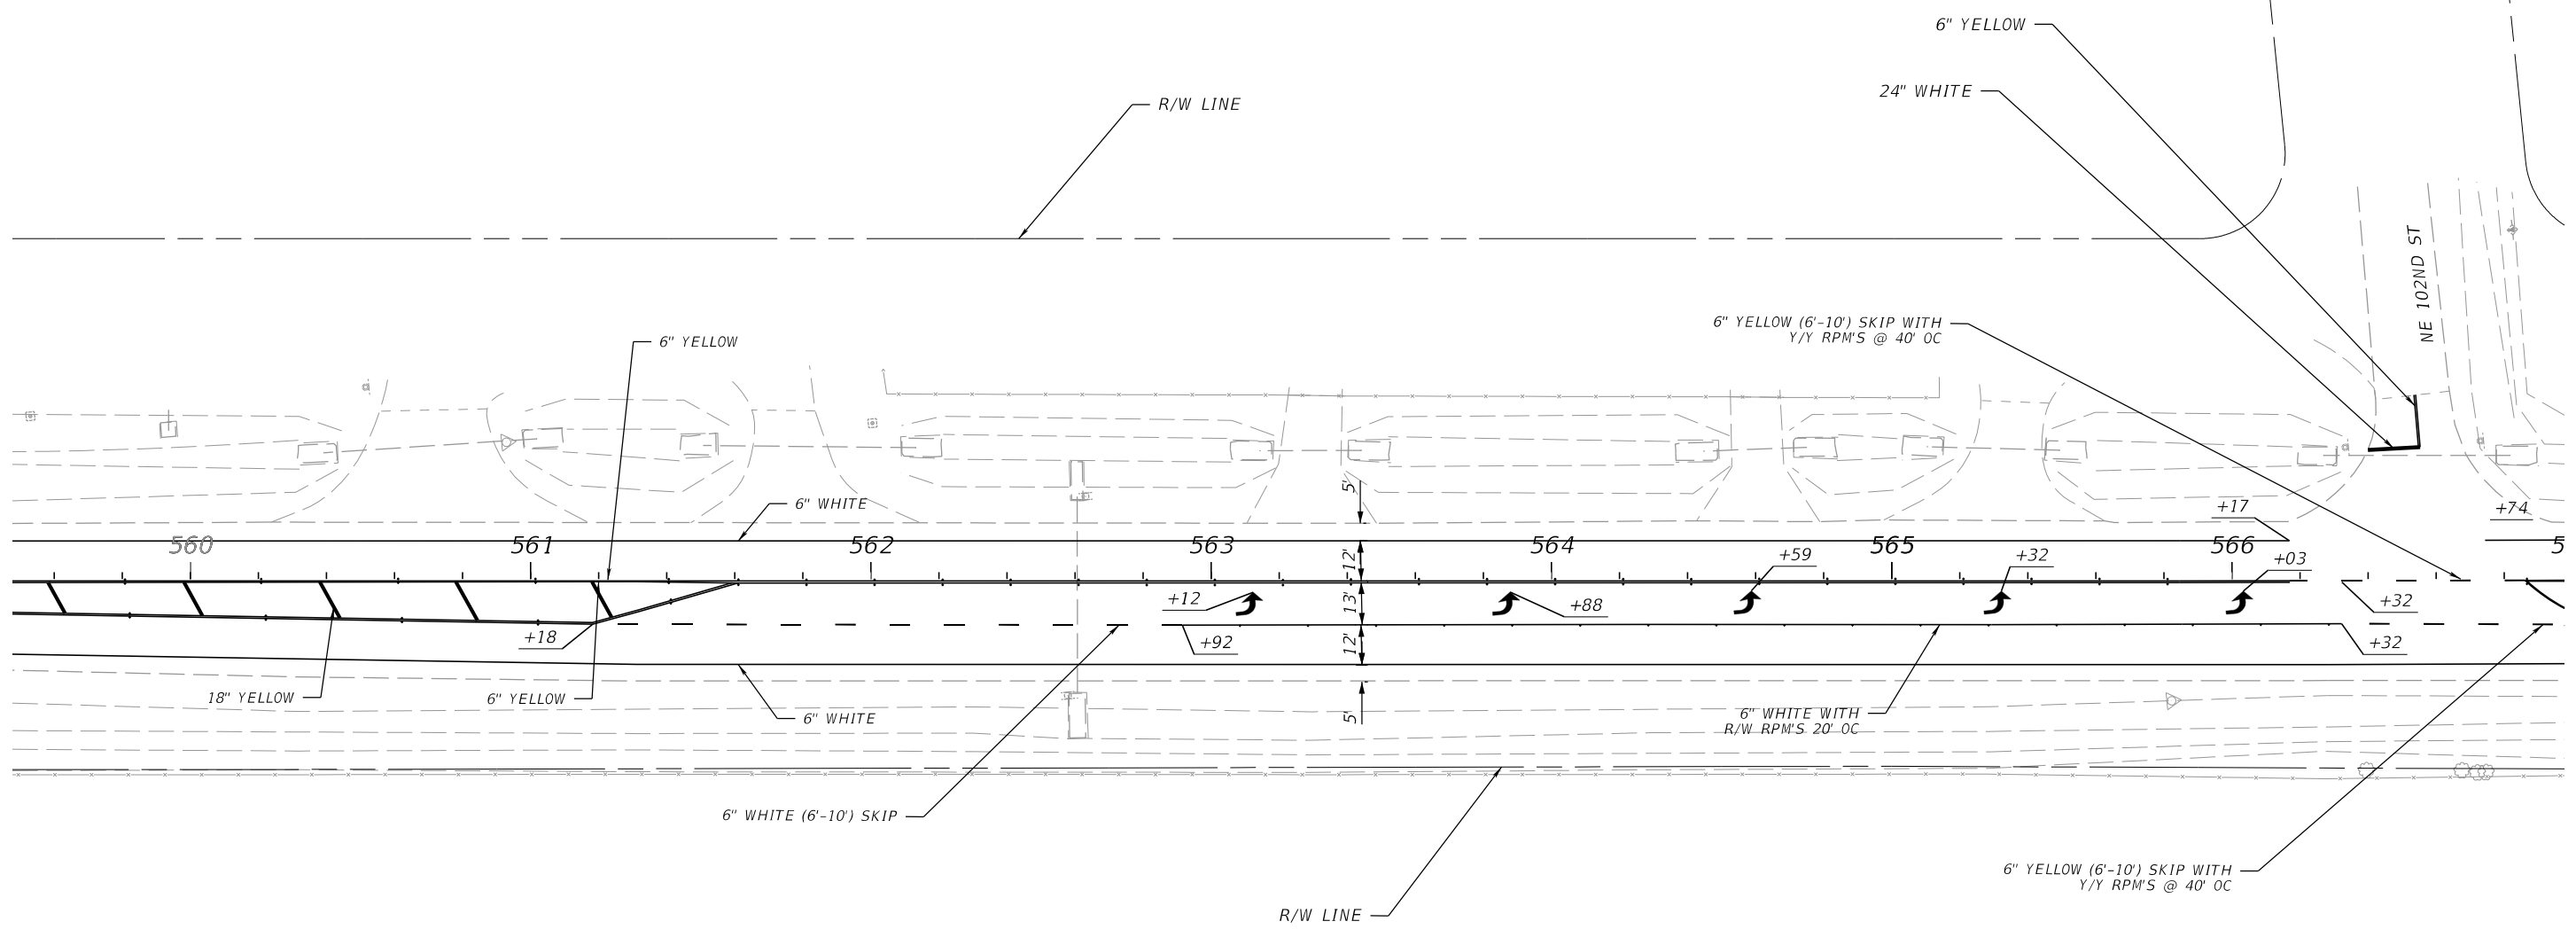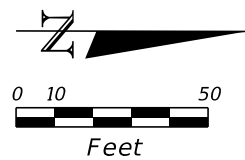

11/9/2023 12:00:17 PM MWADIR c:\pwworking\kpkpw01\nassim nadir\dms05209\PLAN\SP02.dgn

THE OFFICIAL RECORD OF THIS SHEET IS THE ELECTRONIC FILE DIGITALLY SIGNED AND SEALED UNDER RULE 61G15-23.004, F.A.C.

REVISIONS				ENGINEER OF RECORD		STATE OF FLORIDA DEPARTMENT OF TRANSPORTATION			<b>SIGNING AND PAVEMENT MARKING PLAN</b>	SHEET NO.
DATE	DESCRIPTION	DATE	DESCRIPTION	JOSE A. JARQUIN, P.E. LICENSE NUMBER: 89293 AMERICAN STRUCTUREPOINT, INC. 5405 CYPRESS CENTER DR, SUITE 310 TAMPA, FL 33609		ROAD NO.	COUNTY	FINANCIAL PROJECT ID		S-45
						SR 15	OKEECHOBEE	448974-1-52-01		

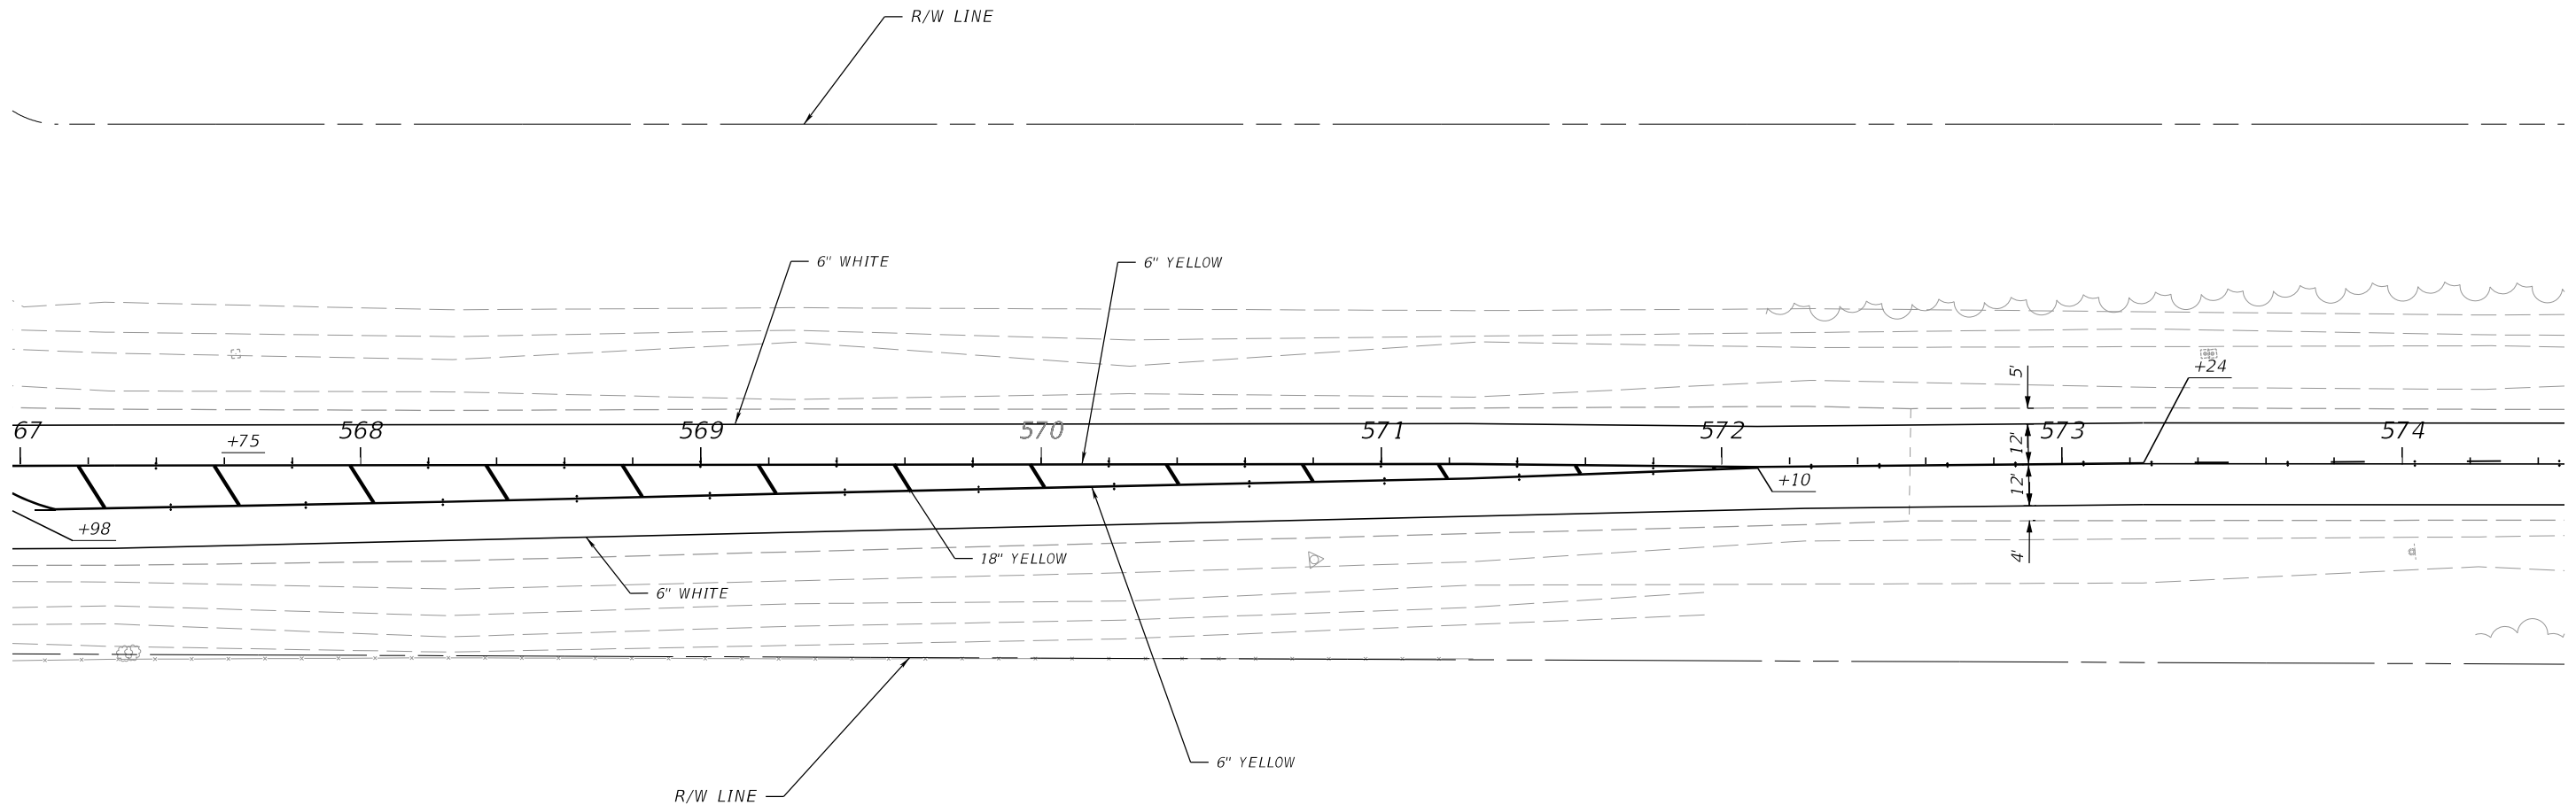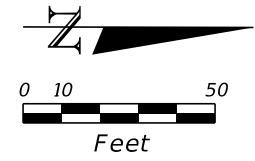

11/9/2023 12:00:20 PM MNADIR  
 c:\pwworking\kpkpw01\nassim\nadir\dms05209\PLAN\SP02.dgn

REVISIONS			
DATE	DESCRIPTION	DATE	DESCRIPTION



**ENGINEER OF RECORD**  
 JOSE A. JARQUIN, P.E.  
 LICENSE NUMBER: 89293  
 AMERICAN STRUCTUREPOINT, INC.  
 5405 CYPRESS CENTER DR, SUITE 310  
 TAMPA, FL 33609

STATE OF FLORIDA DEPARTMENT OF TRANSPORTATION		
ROAD NO.	COUNTY	FINANCIAL PROJECT ID
SR 15	OKEECHOBEE	448974-1-52-01

**SIGNING AND PAVEMENT  
MARKING PLAN**

SHEET NO.  
 S-46

THE OFFICIAL RECORD OF THIS SHEET IS THE ELECTRONIC FILE DIGITALLY SIGNED AND SEALED UNDER RULE 61G15-23.004, F.A.C.

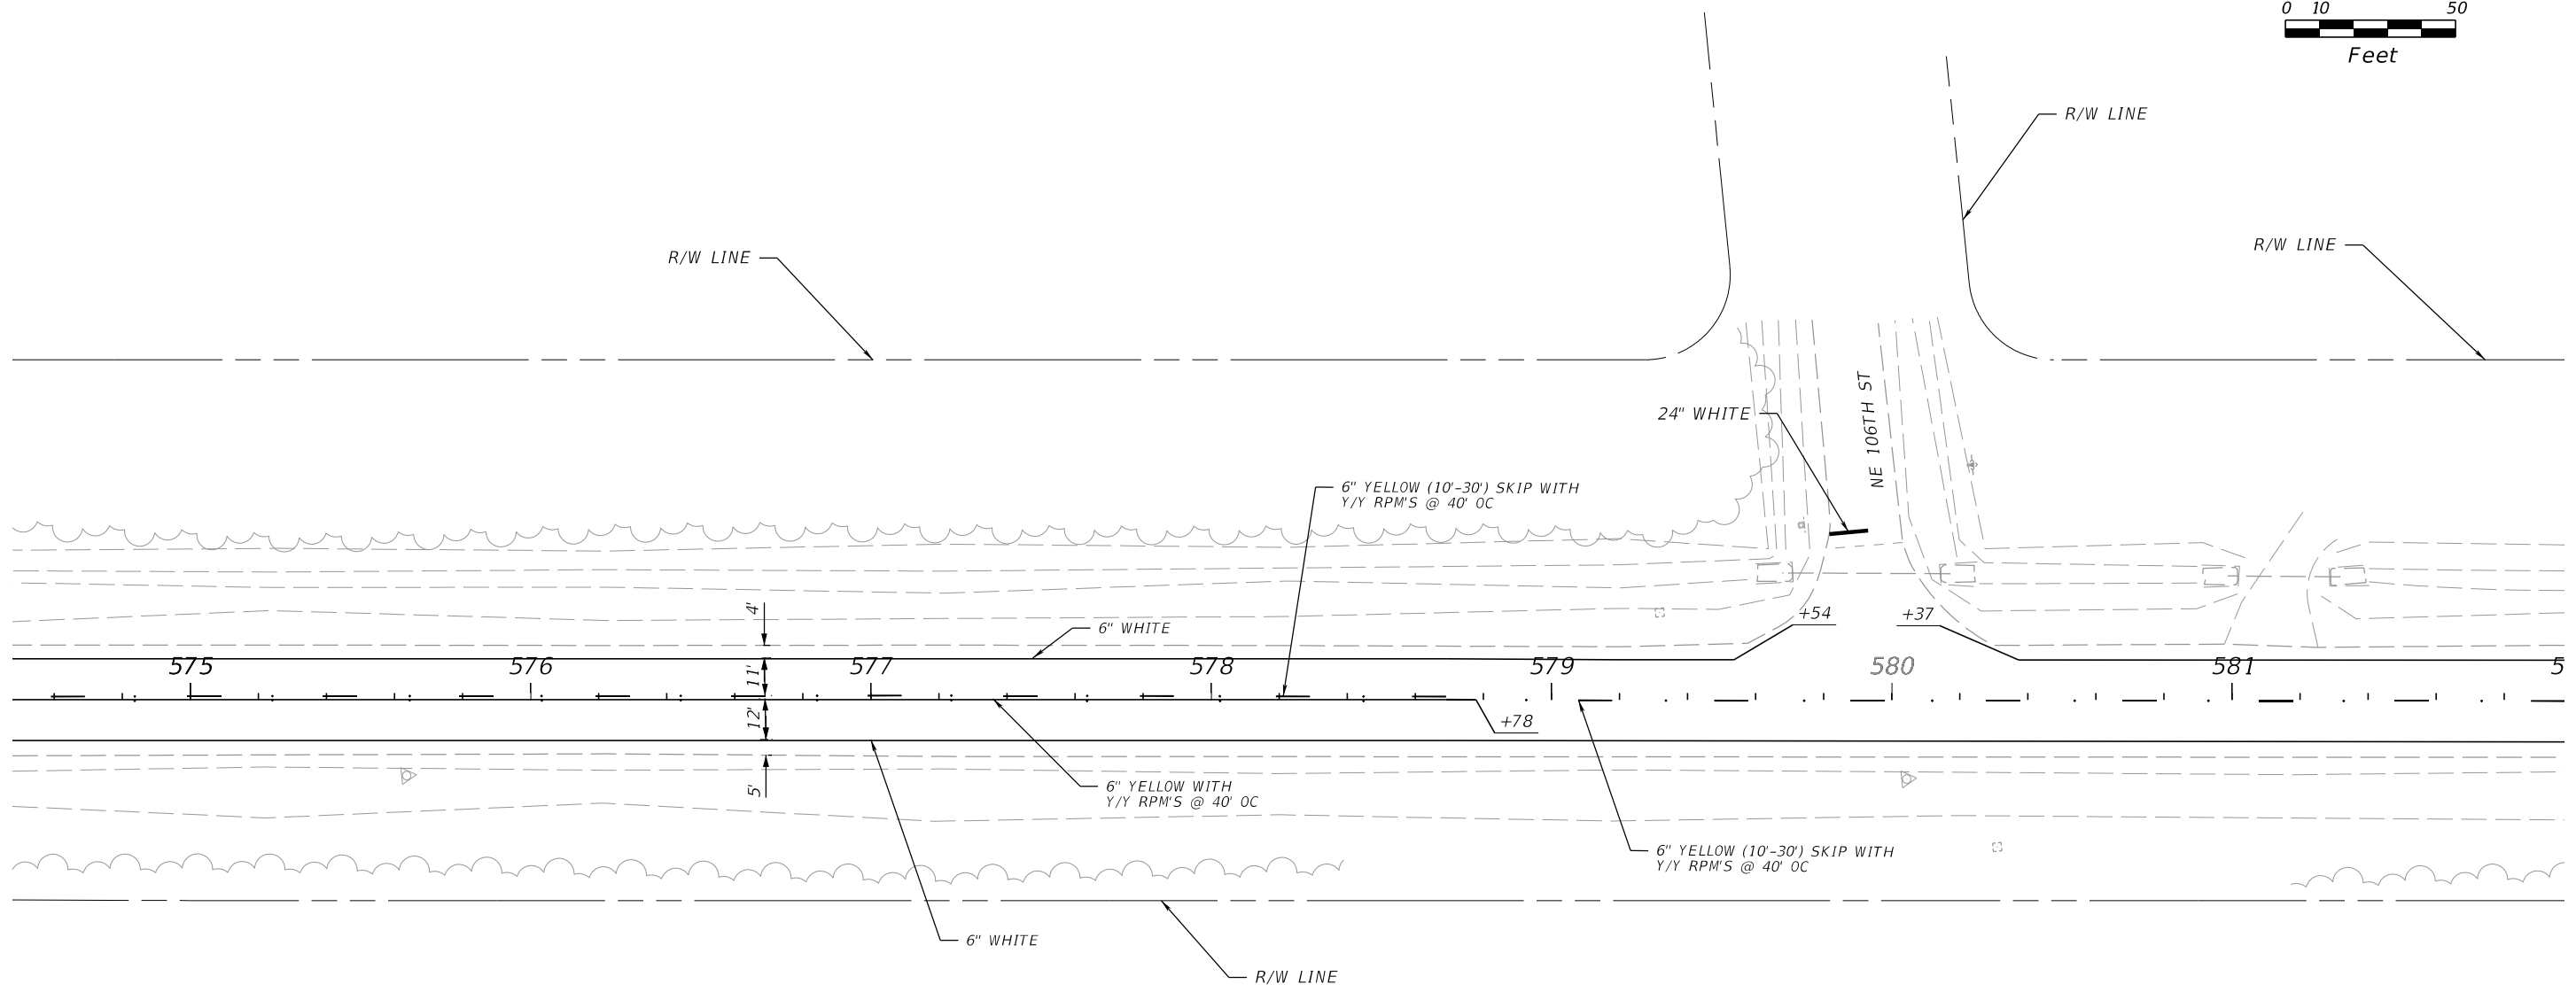
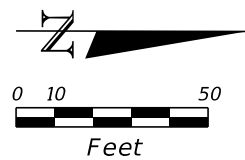


11/9/2023 12:00:23 PM MNADIR c:\pwworking\kkipw01\massim nadir\dms05209\PLAN\SP02.dgn

THE OFFICIAL RECORD OF THIS SHEET IS THE ELECTRONIC FILE DIGITALLY SIGNED AND SEALED UNDER RULE 61G15-23.004, F.A.C.

REVISIONS				ENGINEER OF RECORD		STATE OF FLORIDA DEPARTMENT OF TRANSPORTATION			SHEET NO.
DATE	DESCRIPTION	DATE	DESCRIPTION	JOSE A. JARQUIN, P.E. LICENSE NUMBER: 89293 AMERICAN STRUCTUREPOINT, INC. 5405 CYPRESS CENTER DR, SUITE 310 TAMPA, FL 33609		ROAD NO.	COUNTY	FINANCIAL PROJECT ID	
						SR 15	OKEECHOBEE	448974-1-52-01	S-47

**SIGNING AND PAVEMENT  
MARKING PLAN**

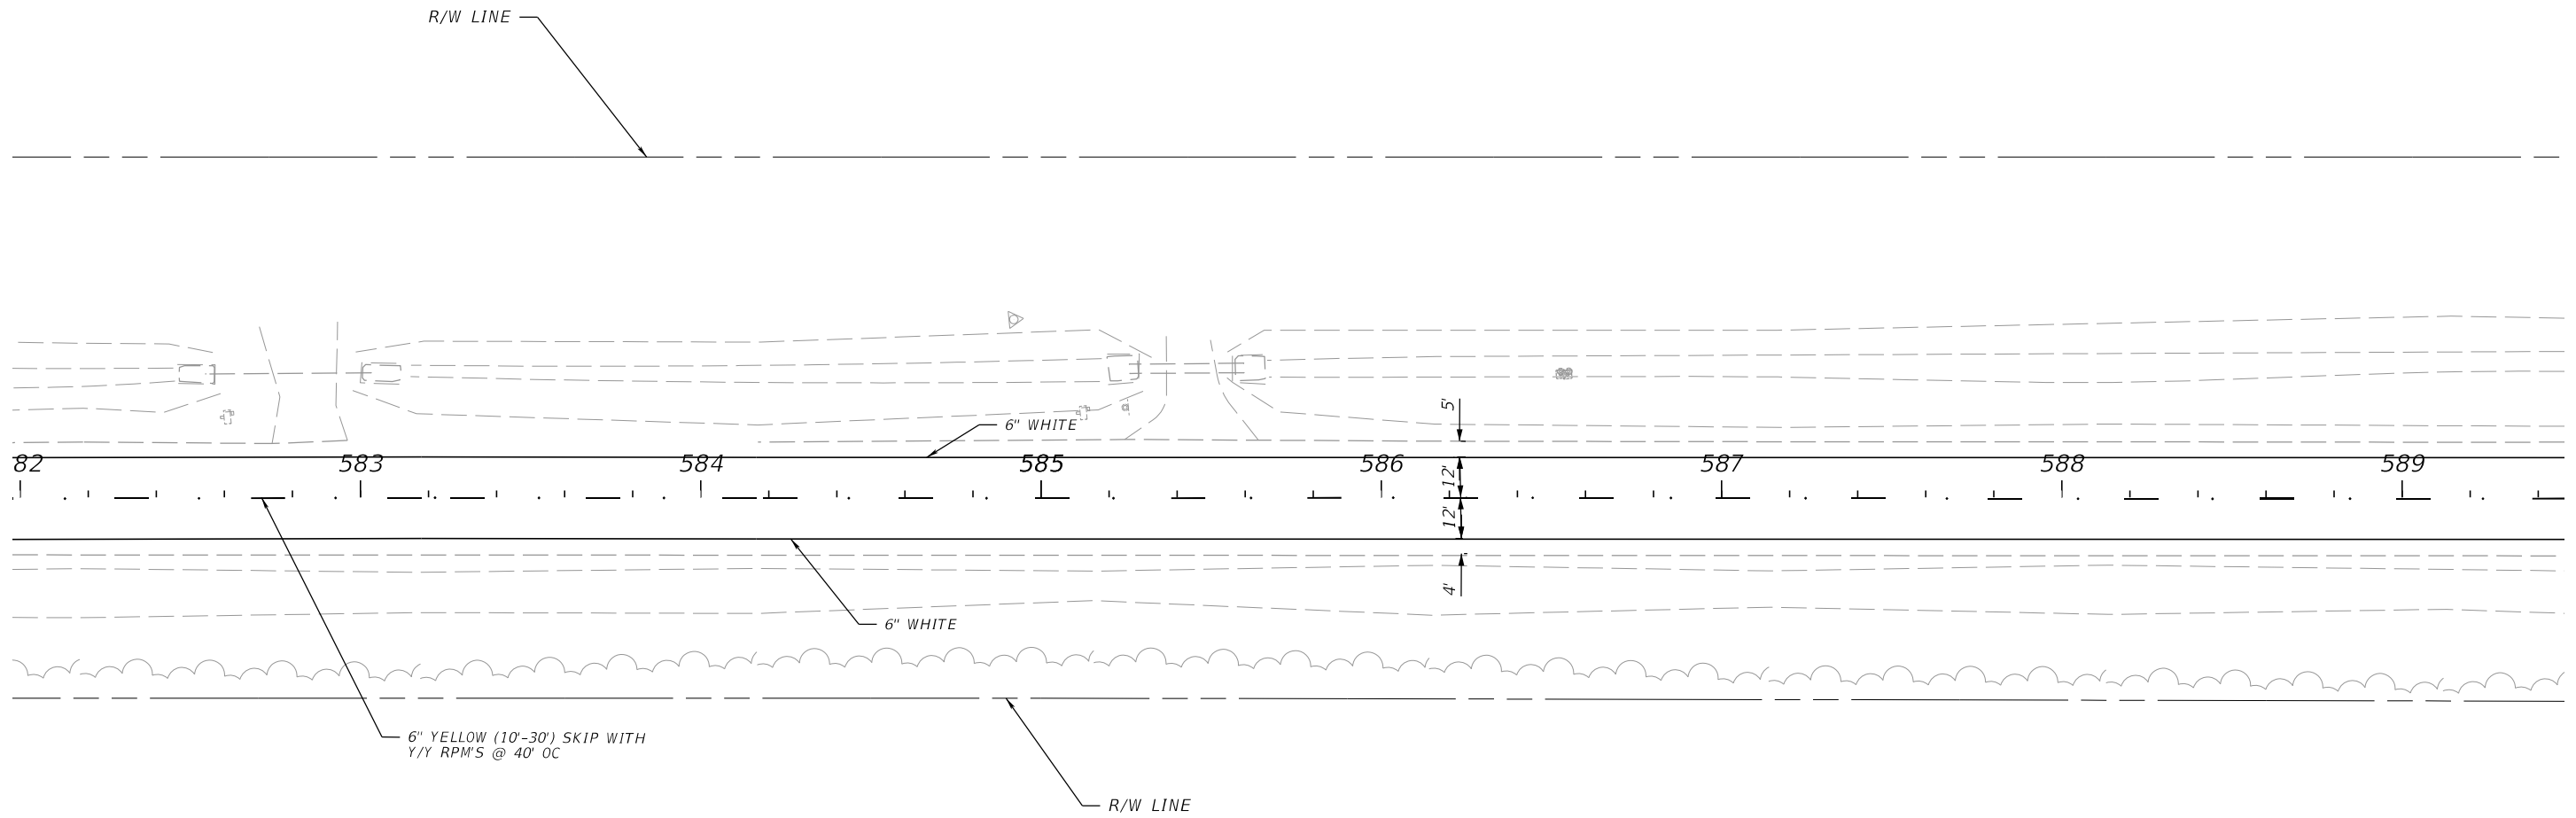
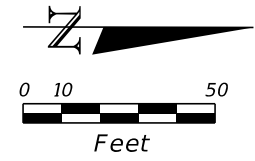


11/9/2023 12:00:25 PM MNADIR c:\pwworking\kpkpw01\nassim\_nadir\dms05209\PLAN\SP02.dgn

REVISIONS				ENGINEER OF RECORD		STATE OF FLORIDA DEPARTMENT OF TRANSPORTATION			<b>SIGNING AND PAVEMENT MARKING PLAN</b>	SHEET NO.
DATE	DESCRIPTION	DATE	DESCRIPTION	JOSE A. JARQUIN, P.E. LICENSE NUMBER: 89293 AMERICAN STRUCTUREPOINT, INC. 5405 CYPRESS CENTER DR, SUITE 310 TAMPA, FL 33609		ROAD NO.	COUNTY	FINANCIAL PROJECT ID		S-48
						SR 15	OKEECHOBEE	448974-1-52-01		

THE OFFICIAL RECORD OF THIS SHEET IS THE ELECTRONIC FILE DIGITALLY SIGNED AND SEALED UNDER RULE 61G15-23.004, F.A.C.





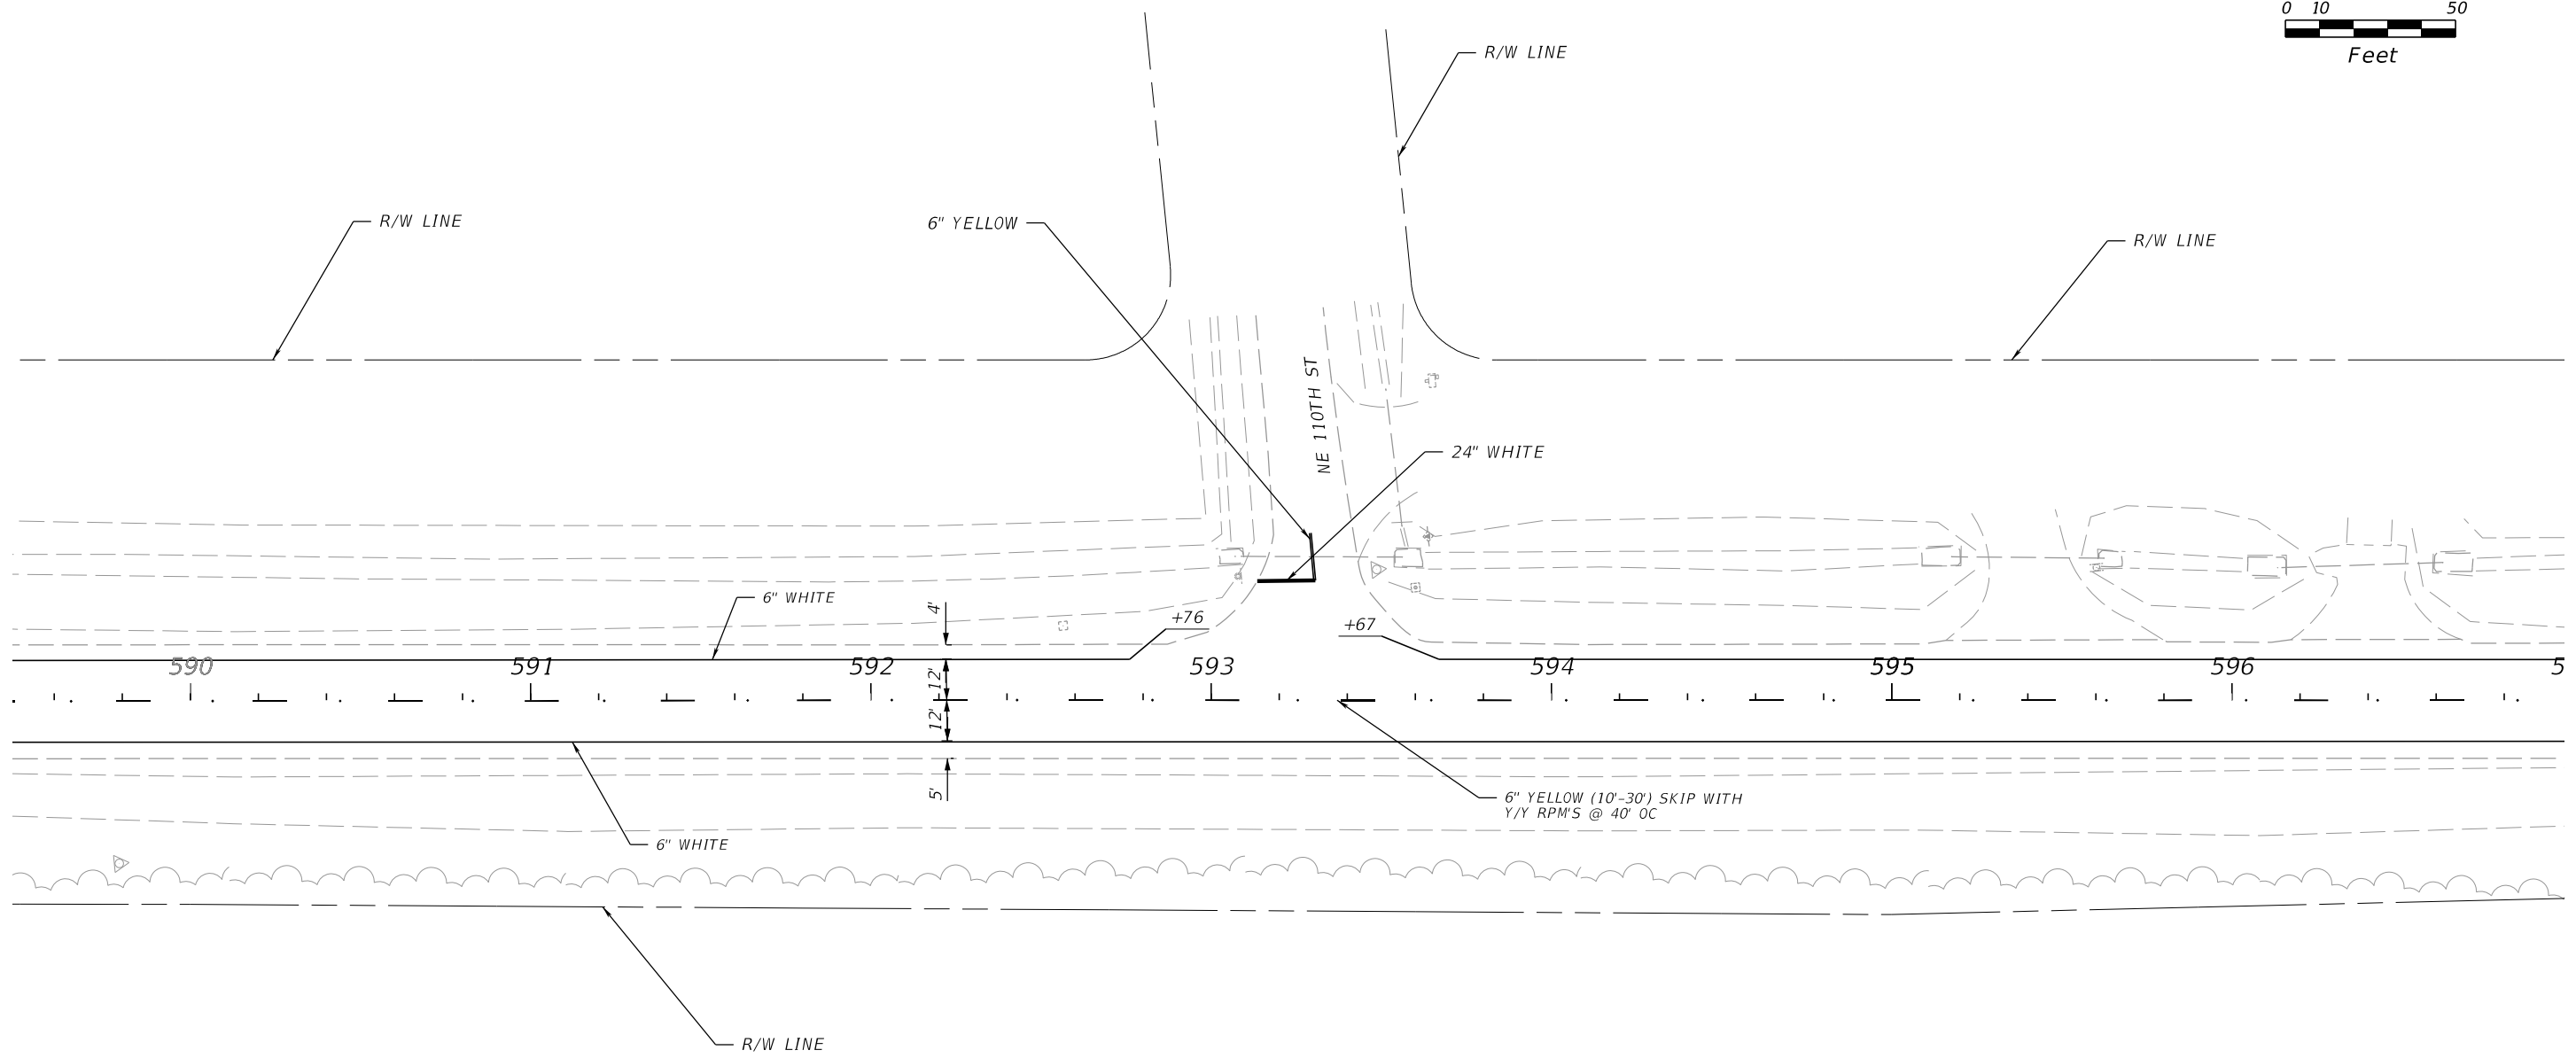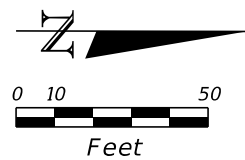

11/9/2023 12:00:28 PM MNADIR  
 c:\pwworking\kkipw01\nassim\nadir\dms05209\PLAN\SP02.dgn

REVISIONS				ENGINEER OF RECORD		STATE OF FLORIDA DEPARTMENT OF TRANSPORTATION			<b>SIGNING AND PAVEMENT MAKRING PLAN</b>	SHEET NO.
DATE	DESCRIPTION	DATE	DESCRIPTION	JOSE A. JARQUIN, P.E. LICENSE NUMBER: 89293 AMERICAN STRUCTUREPOINT, INC. 5404 CYPRESS CENTER DR, SUITE 310 TAMPA, FL 33609		ROAD NO.	COUNTY	FINANCIAL PROJECT ID		S-49
								SR 15		



THE OFFICIAL RECORD OF THIS SHEET IS THE ELECTRONIC FILE DIGITALLY SIGNED AND SEALED UNDER RULE 61G15-23.004, F.A.C.

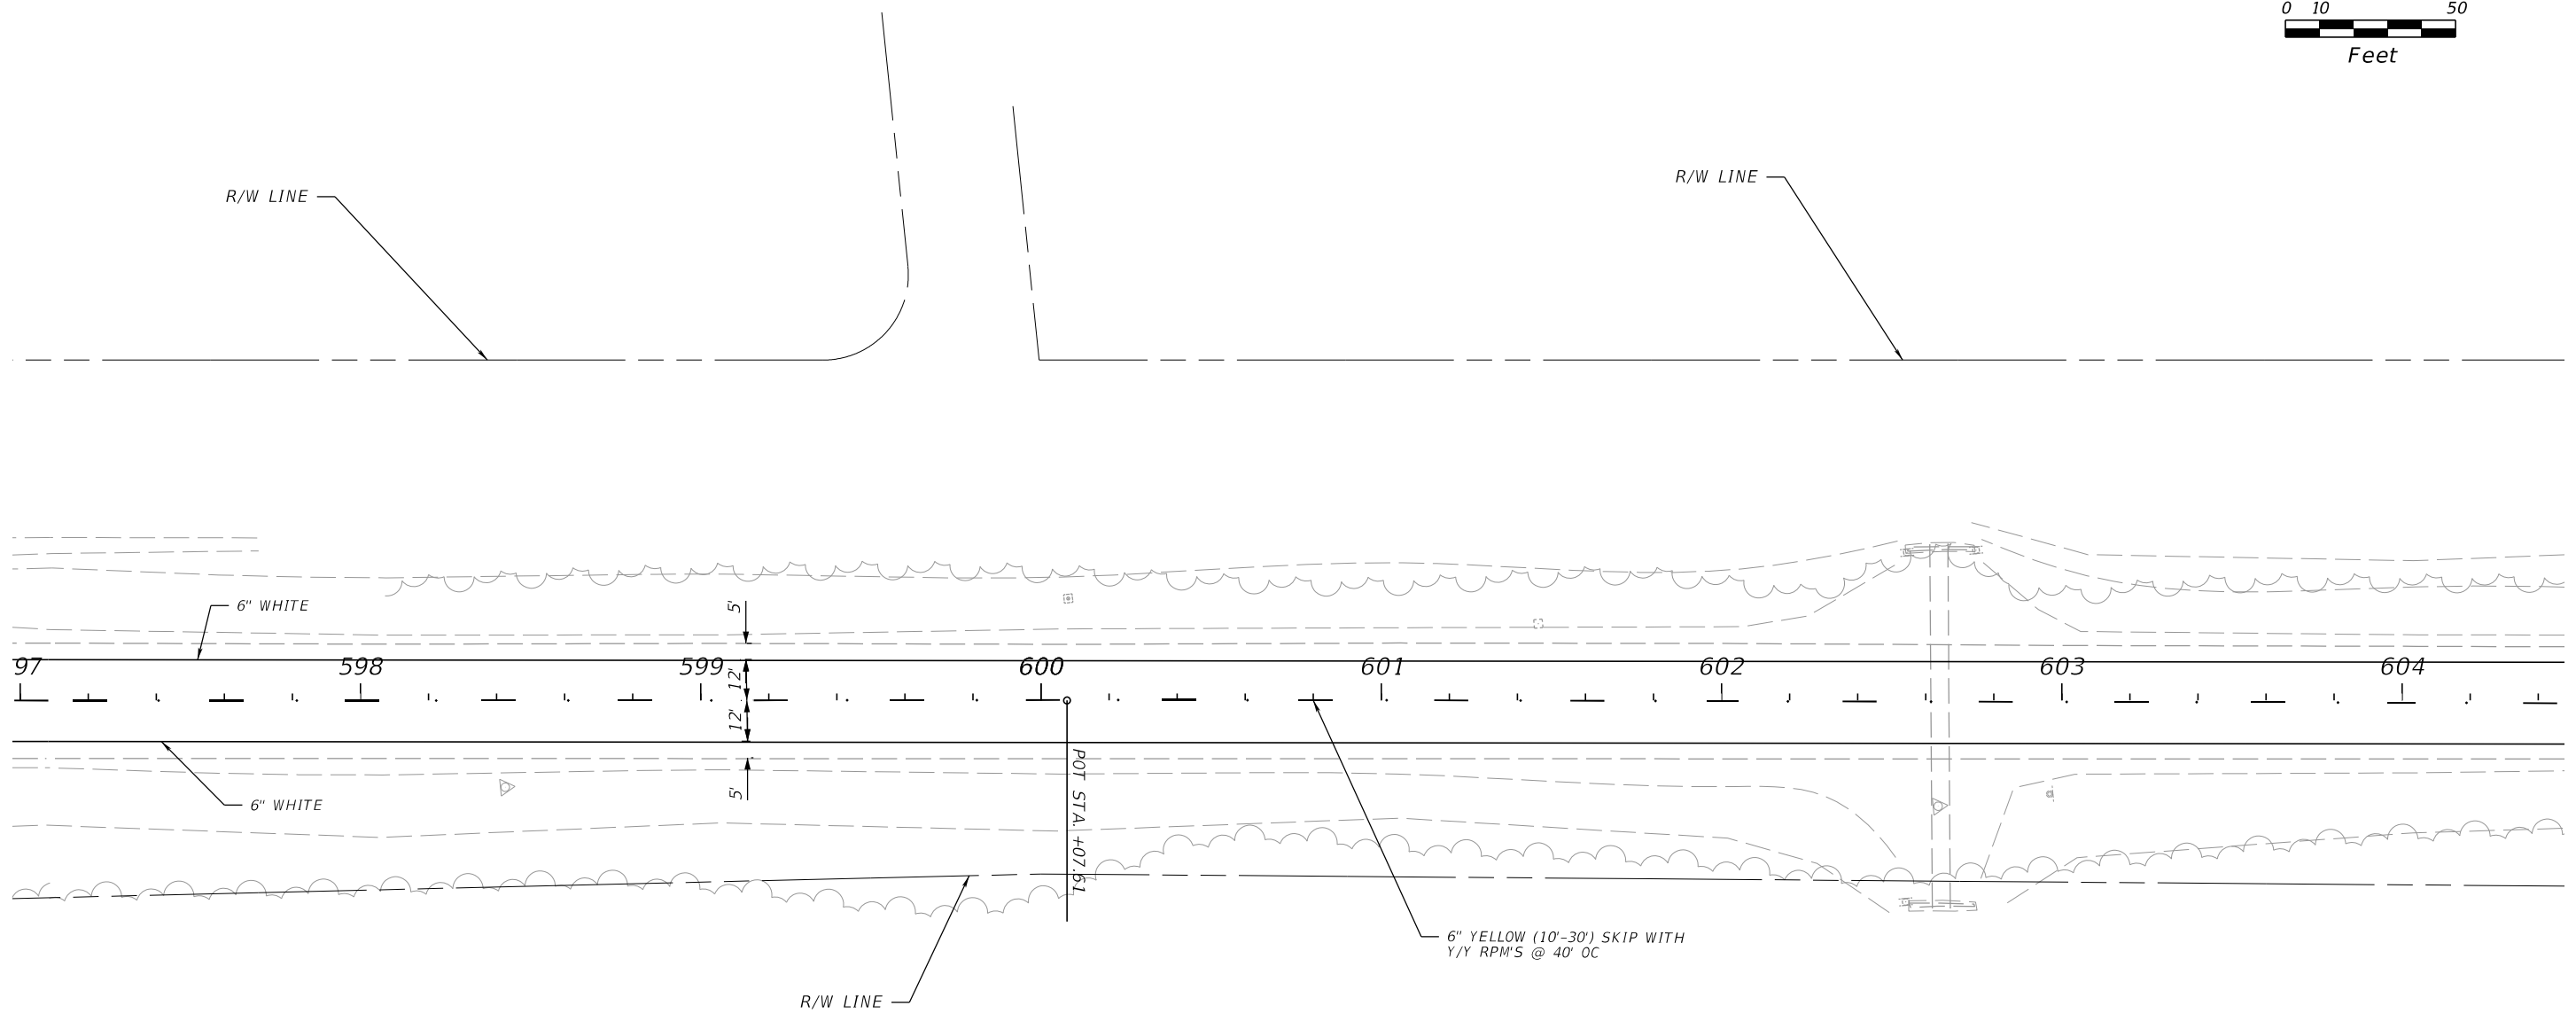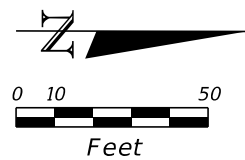

11/9/2023 12:00:31 PM MNADIR c:\pwworking\kkipw01\nadri\dms05209\PLAN\SP02.dgn

THE OFFICIAL RECORD OF THIS SHEET IS THE ELECTRONIC FILE DIGITALLY SIGNED AND SEALED UNDER RULE 61G15-23.004, F.A.C.



REVISIONS				ENGINEER OF RECORD	STATE OF FLORIDA DEPARTMENT OF TRANSPORTATION			SHEET NO.
DATE	DESCRIPTION	DATE	DESCRIPTION		ROAD NO.	COUNTY	FINANCIAL PROJECT ID	
				JOSE A. JARQUIN, P.E. LICENSE NUMBER: 89293 AMERICAN STRUCTUREPOINT, INC. 5405 CYPRESS CENTER DR, SUITE 310 TAMPA, FL 33609	SR 15	OKEECHOBEE	448974-1-52-01	<b>SIGNING AND PAVEMENT MARKING PLAN</b> S-50

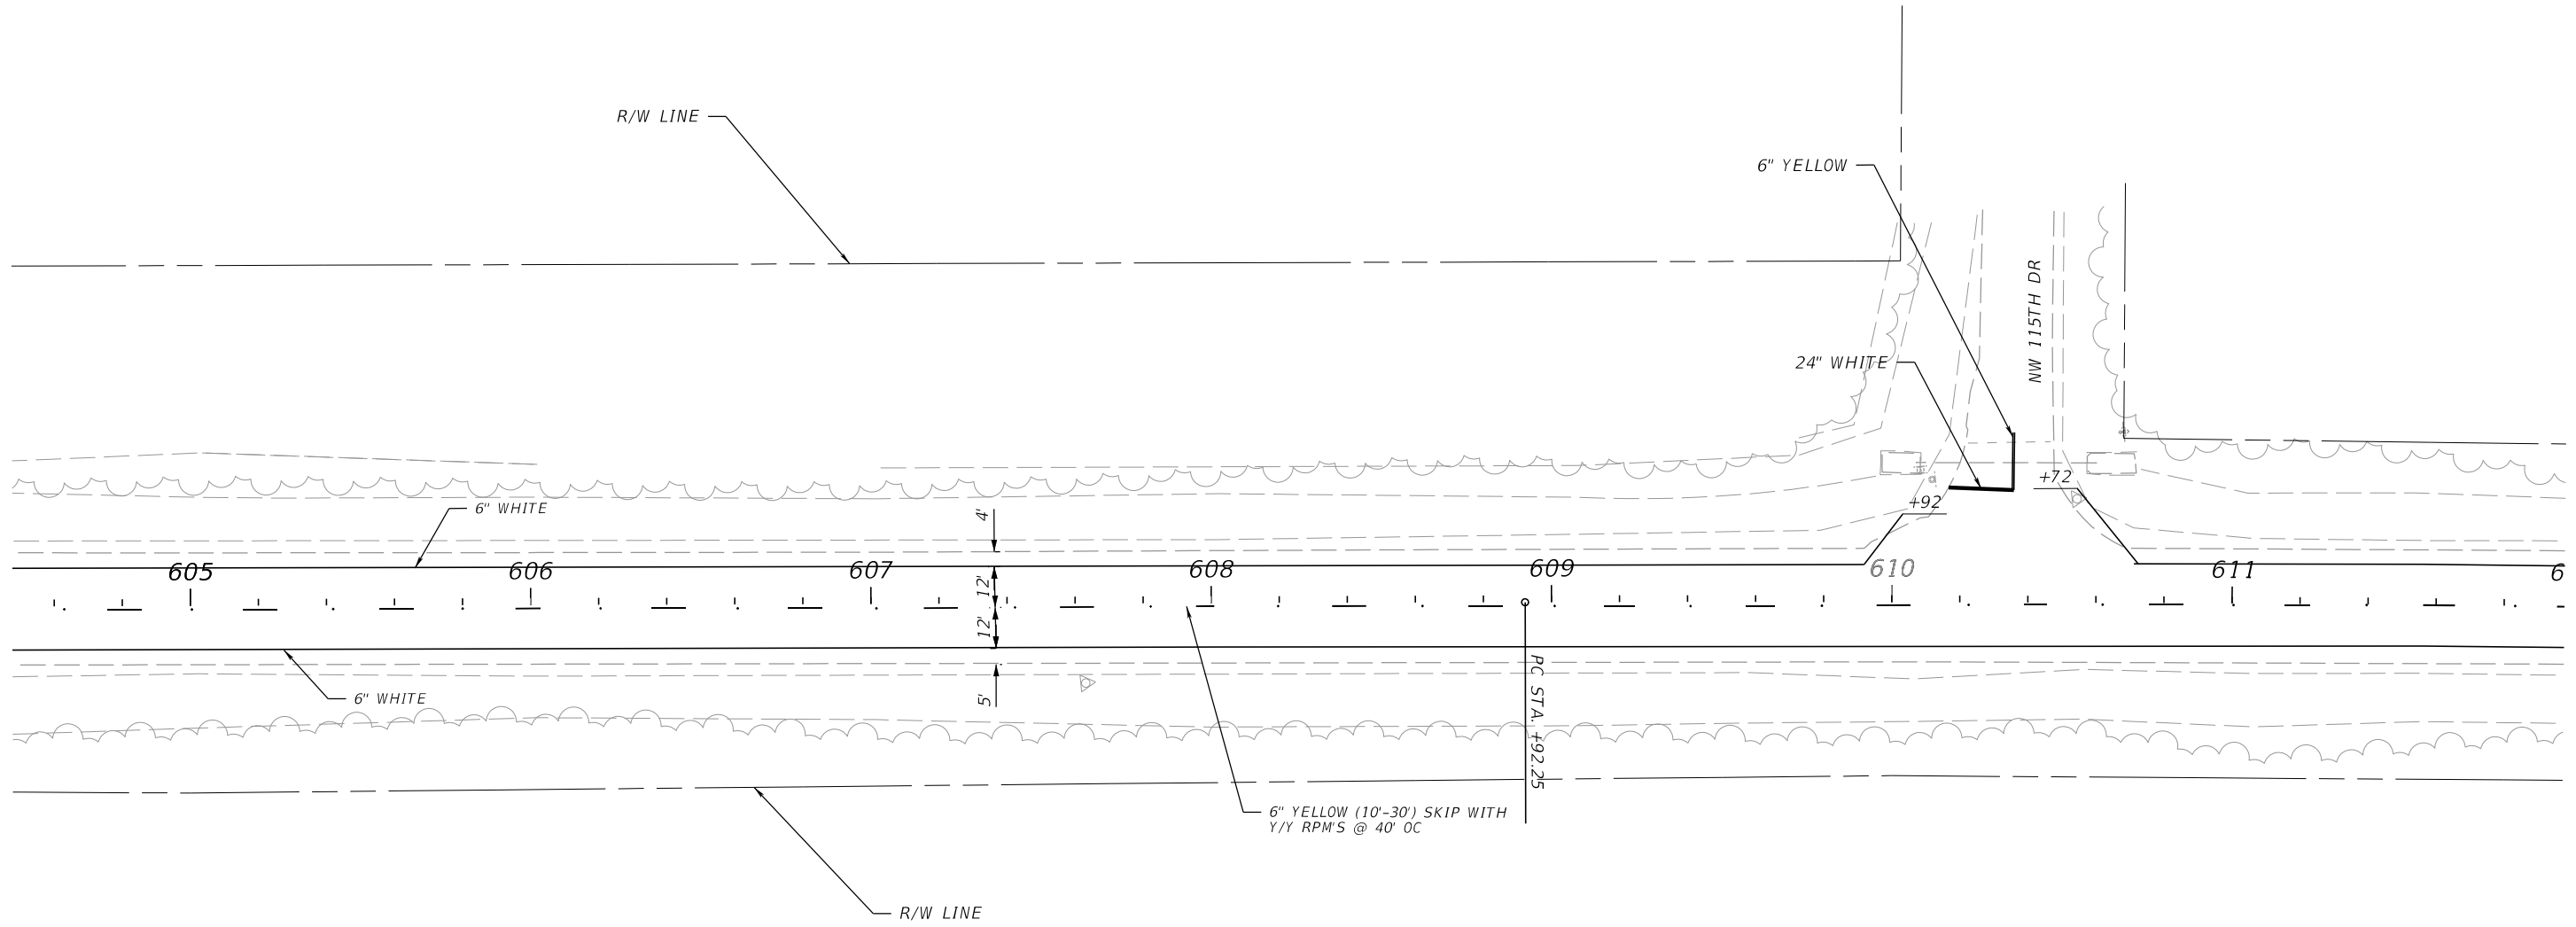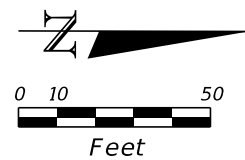

11/9/2023 12:00:33 PM MNADIR c:\pwworking\kpkpw01\massim nadir\dms05209\PLAN\SP02.dgn

REVISIONS				ENGINEER OF RECORD		STATE OF FLORIDA DEPARTMENT OF TRANSPORTATION			<b>SIGNING AND PAVEMENT MARKING PLAN</b>	SHEET NO.
DATE	DESCRIPTION	DATE	DESCRIPTION				ROAD NO.	COUNTY		FINANCIAL PROJECT ID
				JOSE A. JARQUIN, P.E. LICENSE NUMBER: 89293 AMERICAN STRUCTUREPOINT, INC. 5405 CYPRESS CENTER DR, SUITE 310 TAMPA, FL 33609			SR 15	OKEECHOBEE		448974-1-52-01



THE OFFICIAL RECORD OF THIS SHEET IS THE ELECTRONIC FILE DIGITALLY SIGNED AND SEALED UNDER RULE 61G15-23.004, F.A.C.

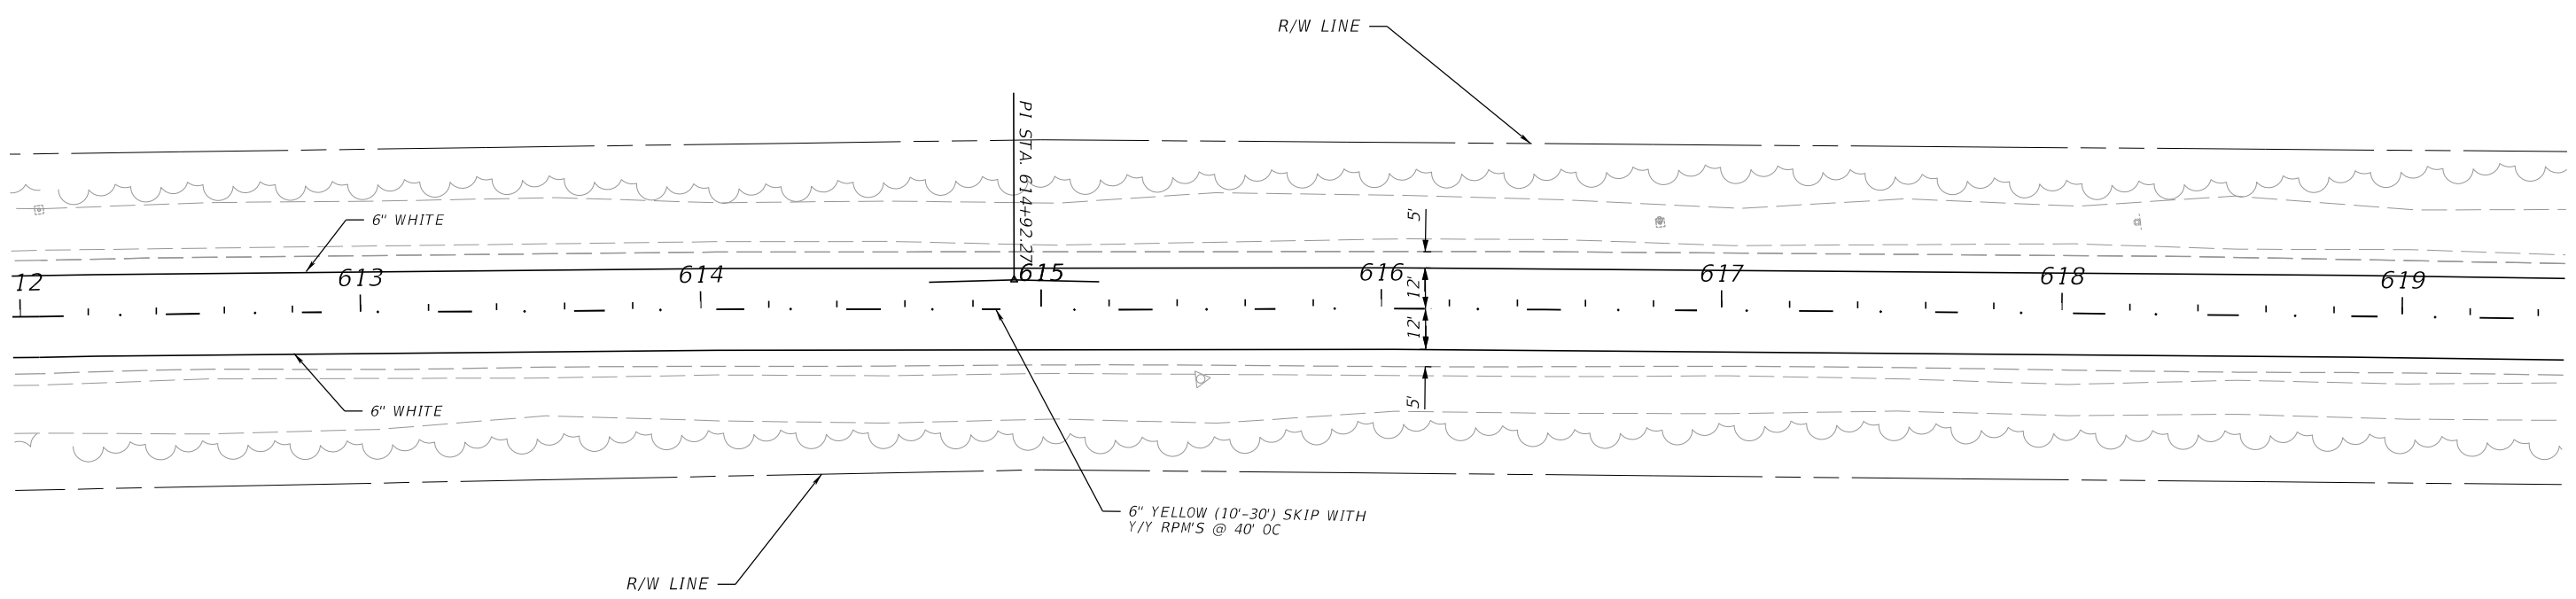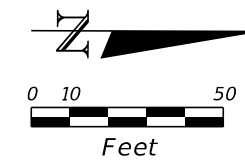

11/9/2023 12:00:36 PM MNADIR c:\pwworking\kpkpw01\massim\adir\dms05209\PLAN\SP02.dgn

REVISIONS				ENGINEER OF RECORD		STATE OF FLORIDA DEPARTMENT OF TRANSPORTATION			SIGNING AND PAVEMENT MARKING PLAN	SHEET NO.
DATE	DESCRIPTION	DATE	DESCRIPTION				ROAD NO.	COUNTY		FINANCIAL PROJECT ID
				JOSE A. JARQUIN, P.E. LICENSE NUMBER: 89293 AMERICAN STRUCTUREPOINT, INC. 5405 CYPRESS CENTER DR, SUITE 310 TAMPA, FL 33609			SR 15	OKEECHOBEE		448974-1-52-01



THE OFFICIAL RECORD OF THIS SHEET IS THE ELECTRONIC FILE DIGITALLY SIGNED AND SEALED UNDER RULE 61G15-23.004, F.A.C.

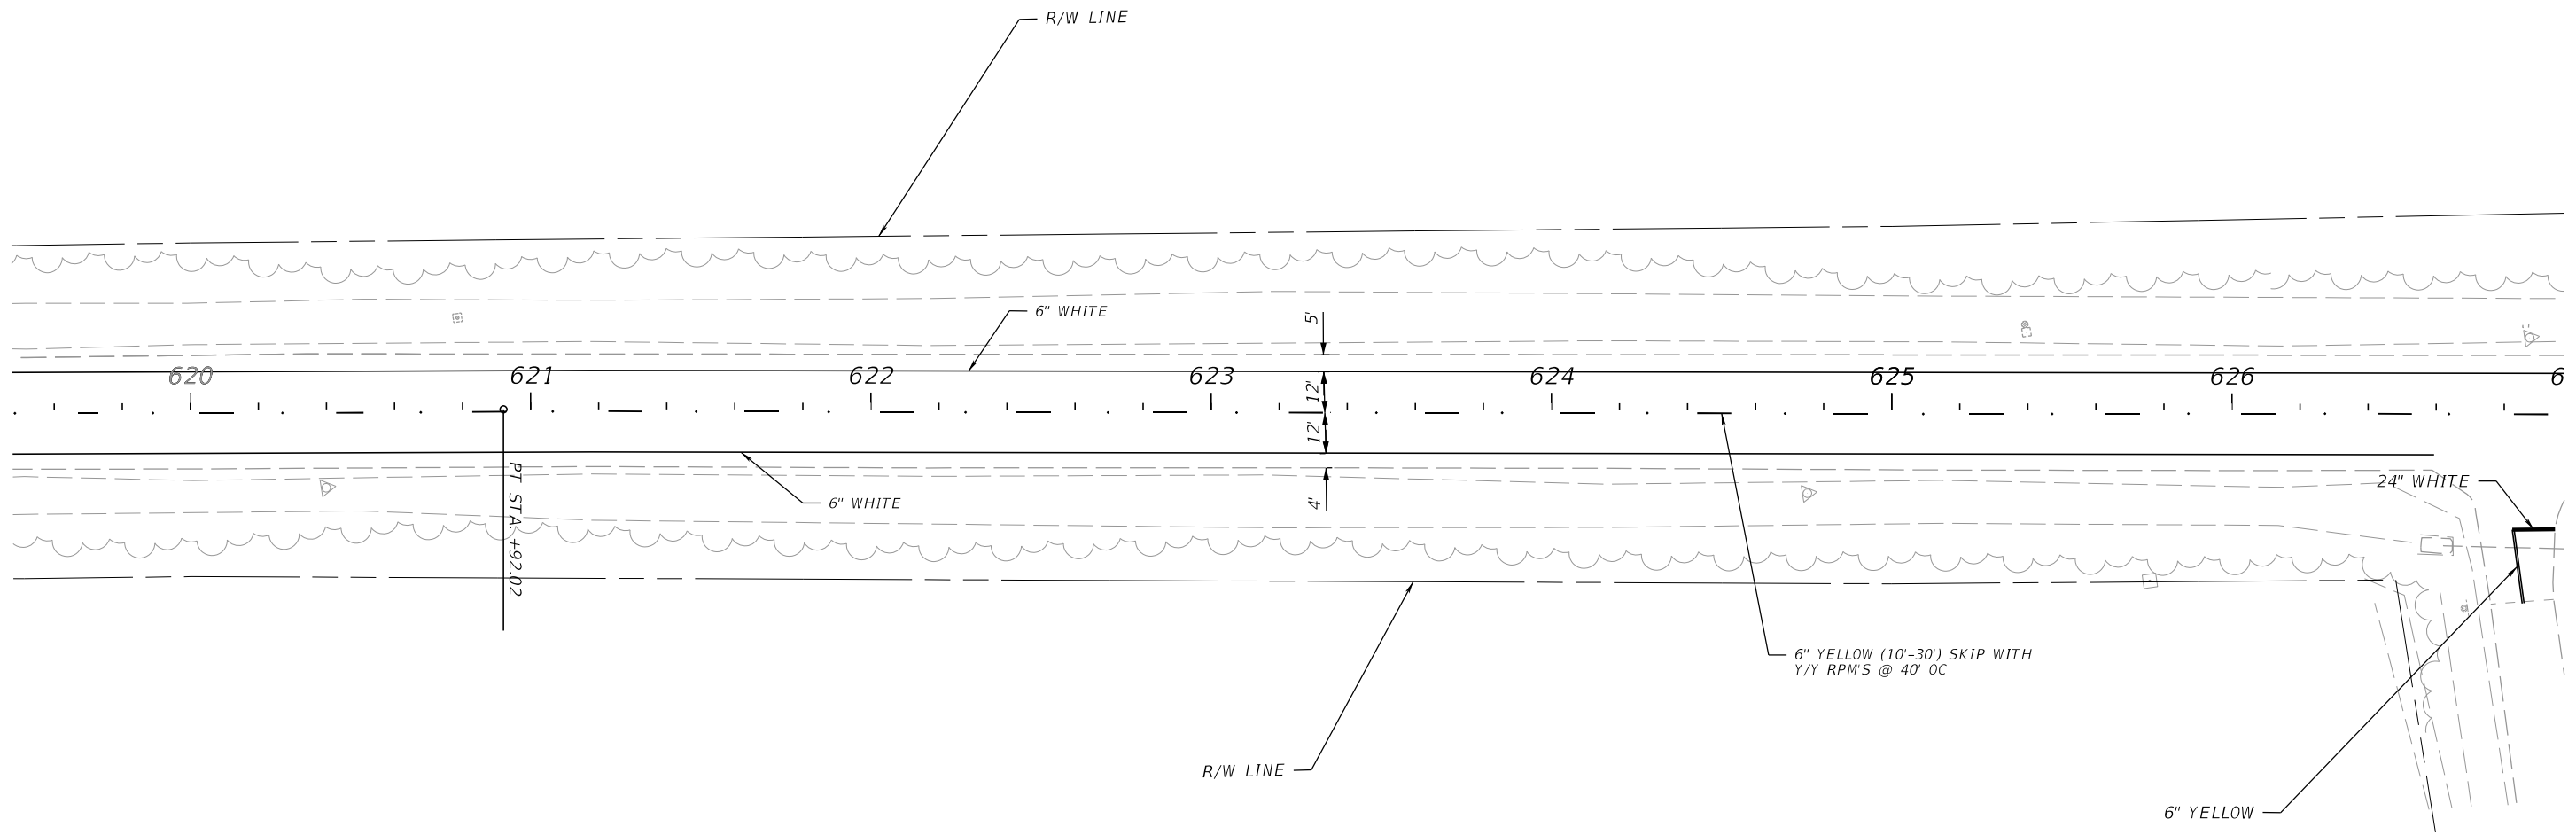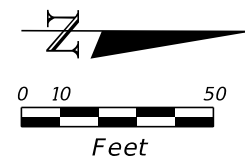

11/9/2023 12:00:39 PM MNADIR  
 c:\pwworking\kkipw01\massim nadir\dms05209\PLAN\SP02.dgn

THE OFFICIAL RECORD OF THIS SHEET IS THE ELECTRONIC FILE DIGITALLY SIGNED AND SEALED UNDER RULE 61G15-23.004, F.A.C.

REVISIONS				ENGINEER OF RECORD		STATE OF FLORIDA DEPARTMENT OF TRANSPORTATION			<b>SIGNING AND PAVEMENT MARKING PLAN</b>	SHEET NO.
DATE	DESCRIPTION	DATE	DESCRIPTION	JOSE A. JARQUIN, P.E. LICENSE NUMBER: 89293 AMERICAN STRUCTUREPOINT, INC. 5405 CYPRESS CENTER DR, SUITE 310 TAMPA, FL 33609		ROAD NO.	COUNTY	FINANCIAL PROJECT ID		S-53
						SR 15	OKEECHOBEE	448974-1-52-01		

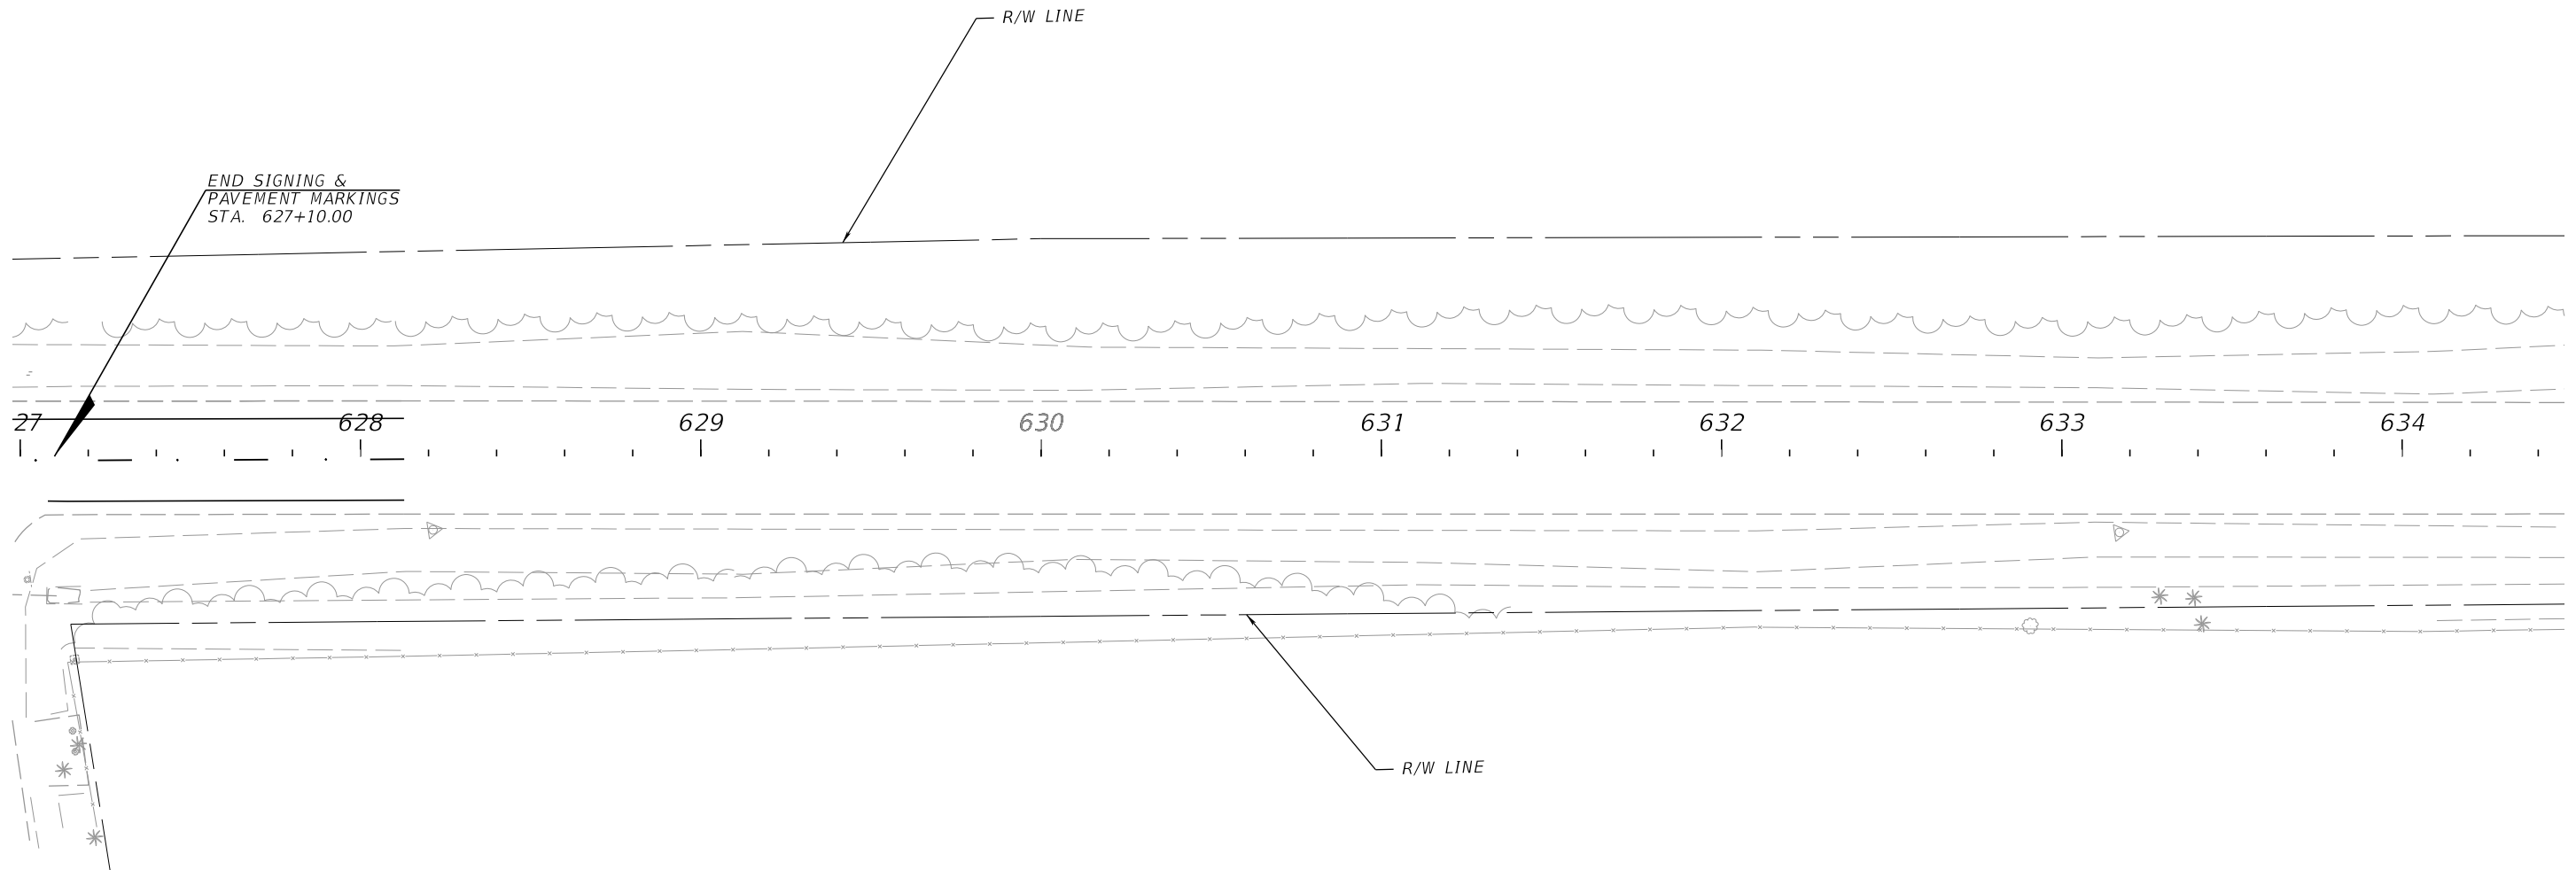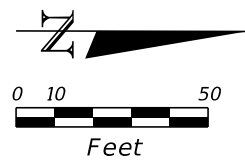

11/9/2023 12:00:41 PM MNADIR c:\pwworking\kpkpw01\massim nadir\dms05209\PLAN\SP02.dgn

THE OFFICIAL RECORD OF THIS SHEET IS THE ELECTRONIC FILE DIGITALLY SIGNED AND SEALED UNDER RULE 61G15-23.004, F.A.C.

REVISIONS				ENGINEER OF RECORD		STATE OF FLORIDA DEPARTMENT OF TRANSPORTATION			<b>SIGNING AND PAVEMENT MARKING PLAN</b>	SHEET NO.
DATE	DESCRIPTION	DATE	DESCRIPTION	JOSE A. JARQUIN, P.E. LICENSE NUMBER: 89293 AMERICAN STRUCTUREPOINT, INC. 5405 CYPRESS CENTER DR, SUITE 310 TAMPA, FL 33609		ROAD NO.	COUNTY	FINANCIAL PROJECT ID		S-54
						SR 15	OKEECHOBEE	448974-1-52-01		