

CONTRACT PLANS COMPONENTS

- ROADWAY PLANS
- SIGNING AND PAVEMENT MARKING PLANS
- SIGNALIZATION PLANS
- LIGHTING PLANS


STATE OF FLORIDA
DEPARTMENT OF TRANSPORTATION
SIGNING AND PAVEMENT MARKING PLANS

**FINANCIAL PROJECT ID 449232-1-52-01
(FEDERAL FUNDS)**

POLK COUNTY (16030)

STATE ROAD NO. 35 (US 17)

FROM 9TH ST NW TO N OF OAK HAMMOCK LOOP

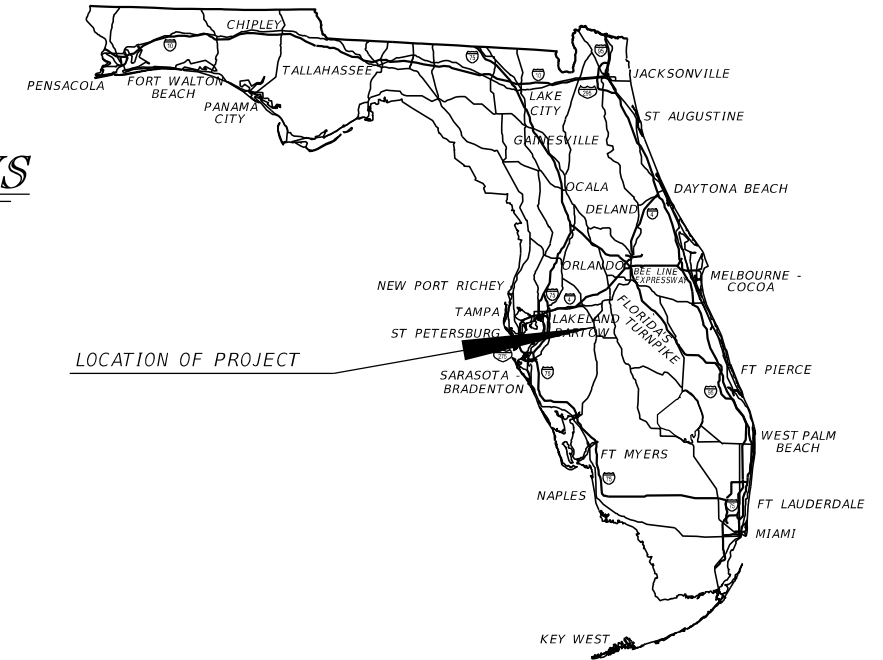

A DETAILED INDEX APPEARS ON THE KEY SHEET OF EACH COMPONENT

INDEX OF SIGNING AND PAVEMENT MARKING PLANS

SHEET NO.	SHEET DESCRIPTION
S-1	KEY SHEET
S-2	GENERAL NOTES
S-3 - S-29	SIGNING AND PAVEMENT MARKING PLANS
S-30 - S-34	GUIDE SIGN WORK SHEET
S-35	SIGN CROSS SECTIONS


PROJECT LOCATION URL: <https://tinyurl.com/yprd64fn>

PROJECT LIMITS: BEGIN MP 8.333 - END MP 15.959

EXCEPTIONS: NONE

BRIDGE LIMITS: BR#160085 MP 12.311 - MP 12.361
BR#160103 MP 12.333 - MP 12.382
BR#160012 MP 15.647 - MP 15.655

RAILROAD CROSSING: CSX Transportation Railroad Crossing
NO. 626466A, RR MP SVE 857.11

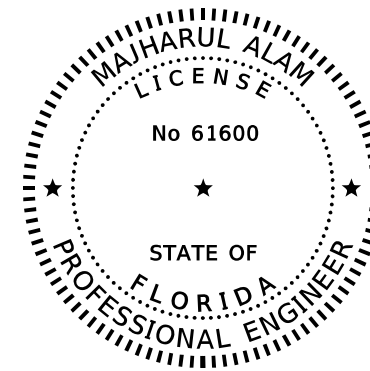

THIS ITEM HAS BEEN DIGITALLY SIGNED AND SEALED BY

ON THE DATE ADJACENT TO THE SEAL

PRINTED COPIES OF THIS DOCUMENT ARE NOT CONSIDERED SIGNED AND SEALED AND THE SIGNATURE MUST BE VERIFIED ON ANY ELECTRONIC COPIES.

**SIGNING AND PAVEMENT MARKING PLANS
ENGINEER OF RECORD:**

MAJHARUL ALAM, P.E.
P.E. LICENSE NUMBER 61600
PROPEL ENGINEERING, INC.
2711 N VISTA PARKWAY, SUITE B-7
WEST PALM BEACH, FL 33411
CONTRACT NO.: CAJ54
VENDOR NO.: F463316950
TEL: (561)-866-5730

FDOT PROJECT MANAGER:

MARIE CARVAJAL

GOVERNING STANDARD PLANS:

Florida Department of Transportation, FY2024-25 Standard Plans for Road and Bridge Construction and applicable Interim Revisions (IRs).

Standard Plans for Road Construction and associated IRs are available at the following website: <http://www.fdot.gov/design/standardplans>

GOVERNING STANDARD SPECIFICATIONS:

Florida Department of Transportation, FY2024-25 Standard Specifications for Road and Bridge Construction at the following website: <http://www.fdot.gov/programmanagement/Implemented/SpecBooks>

CONSTRUCTION CONTRACT NO.	FISCAL YEAR	SHEET NO.
T1903	25	S-1


GENERAL NOTES

1. ALL SIGNS MOUNTED OVER SIDEWALKS SHALL HAVE A VERTICAL CLEARANCE OF EIGHT FEET (8') STANDARD.
2. UNLESS OTHERWISE NOTED ON PLAN SHEETS, ALL CROSSWALKS ACROSS MAJOR STREET SHALL BE TEN FEET (10') IN WIDTH AND ALL CROSSWALKS ACROSS SIDE STREET SHALL BE SIX FEET (6') IN WIDTH. MEASUREMENTS SHALL BE FROM INSIDE TO INSIDE OF 12" STRIPES.
3. PAY ITEM 700-1-111: WHERE APPLICABLE, REMOVE THE STREET NAME PANELS AND/OR OTHER SPECIFIED SIGN PANELS FROM EXISTING STOP SIGN ASSEMBLIES THAT ARE BEING REMOVED AND INSTALL THEM ON NEW SIGN ASSEMBLIES AS CALLED FOR IN PLANS. IF EXISTING MOUNTING BRACKETS ARE UNUSABLE, PURCHASE APPROVED BRACKETS FOR ATTACHMENT OF RELOCATED SIGN PANELS TO ENSURE PROPER INSTALLATION OF COMPLETE ASSEMBLY FOR THE POST USED.
4. PAY ITEM 0705-10-2 INSTALL OR REPLACE IF MISSING OR DAMAGED FROM LOCATIONS SHOWN IN THE PLANS.
5. FOR RAILROAD REQUIREMENTS WHEN WORKING NEAR OR WITHIN RAILROAD RIGHT-OF-WAY, SEE SHEET 23 IN ROADWAY PLANS.

3/18/2024 5:31:26 PM Shuvo C:\worksets\FDOT\44923215201\signing\GMNTSP01.dgn

THE OFFICIAL RECORD OF THIS SHEET IS THE ELECTRONIC FILE DIGITALLY SIGNED AND SEALED UNDER RULE 61G15-23.004, F.A.C.


REVISIONS				ENGINEER OF RECORD	STATE OF FLORIDA DEPARTMENT OF TRANSPORTATION			<i>GENERAL NOTES</i>	SHEET NO.
DATE	DESCRIPTION	DATE	DESCRIPTION	MAJHARUL ALAM, P.E. LICENSE NUMBER 61600 PROPEL ENGINEERING, INC. 2711 N VISTA PARKWAY, SUITE B7 WEST PALM BEACH, FL 33411	ROAD NO.	COUNTY	FINANCIAL PROJECT ID		S-2
						SR 35	POLK		

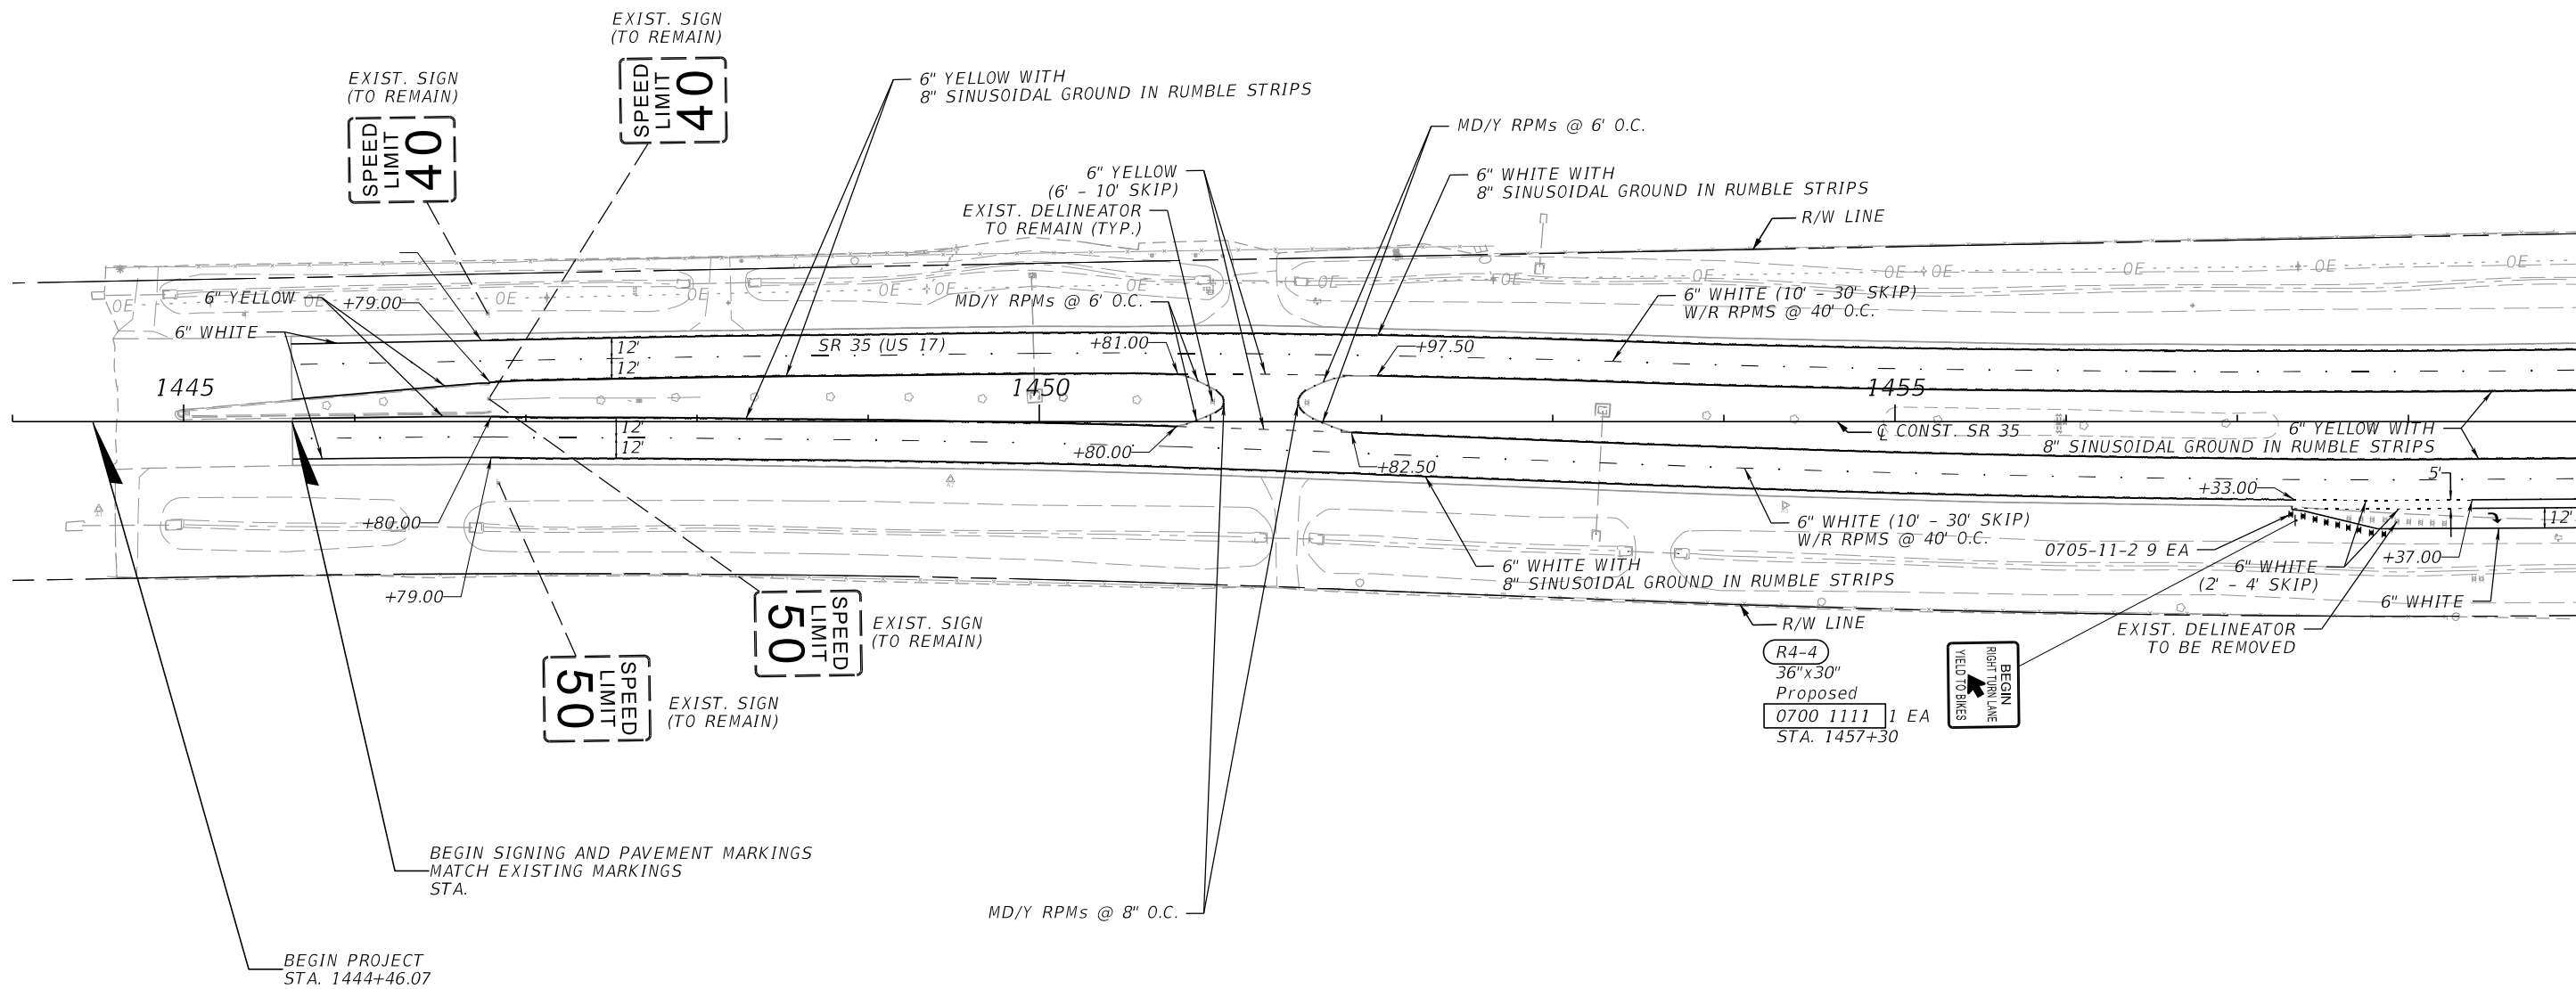

3/18/2024 5:31:39 PM Shuvo S:\2220010500-US17_SR35_3R\44923215201\signing\PLANS\PO1.dgn

THE OFFICIAL RECORD OF THIS SHEET IS THE ELECTRONIC FILE DIGITALLY SIGNED AND SEALED UNDER RULE 61G15-23.004, F.A.C.

REVISIONS				ENGINEER OF RECORD		STATE OF FLORIDA DEPARTMENT OF TRANSPORTATION			SIGNING AND PAVEMENT MARKING PLANS	SHEET NO.
DATE	DESCRIPTION	DATE	DESCRIPTION	MAJHARUL ALAM, P.E. LICENSE NUMBER 61600 PROPEL ENGINEERING, INC. 2711 N VISTA PARKWAY, SUITE B7 WEST PALM BEACH, FL 33411		ROAD NO.	COUNTY	FINANCIAL PROJECT ID		S-3
						SR 35	POLK	449232-1-52-01		

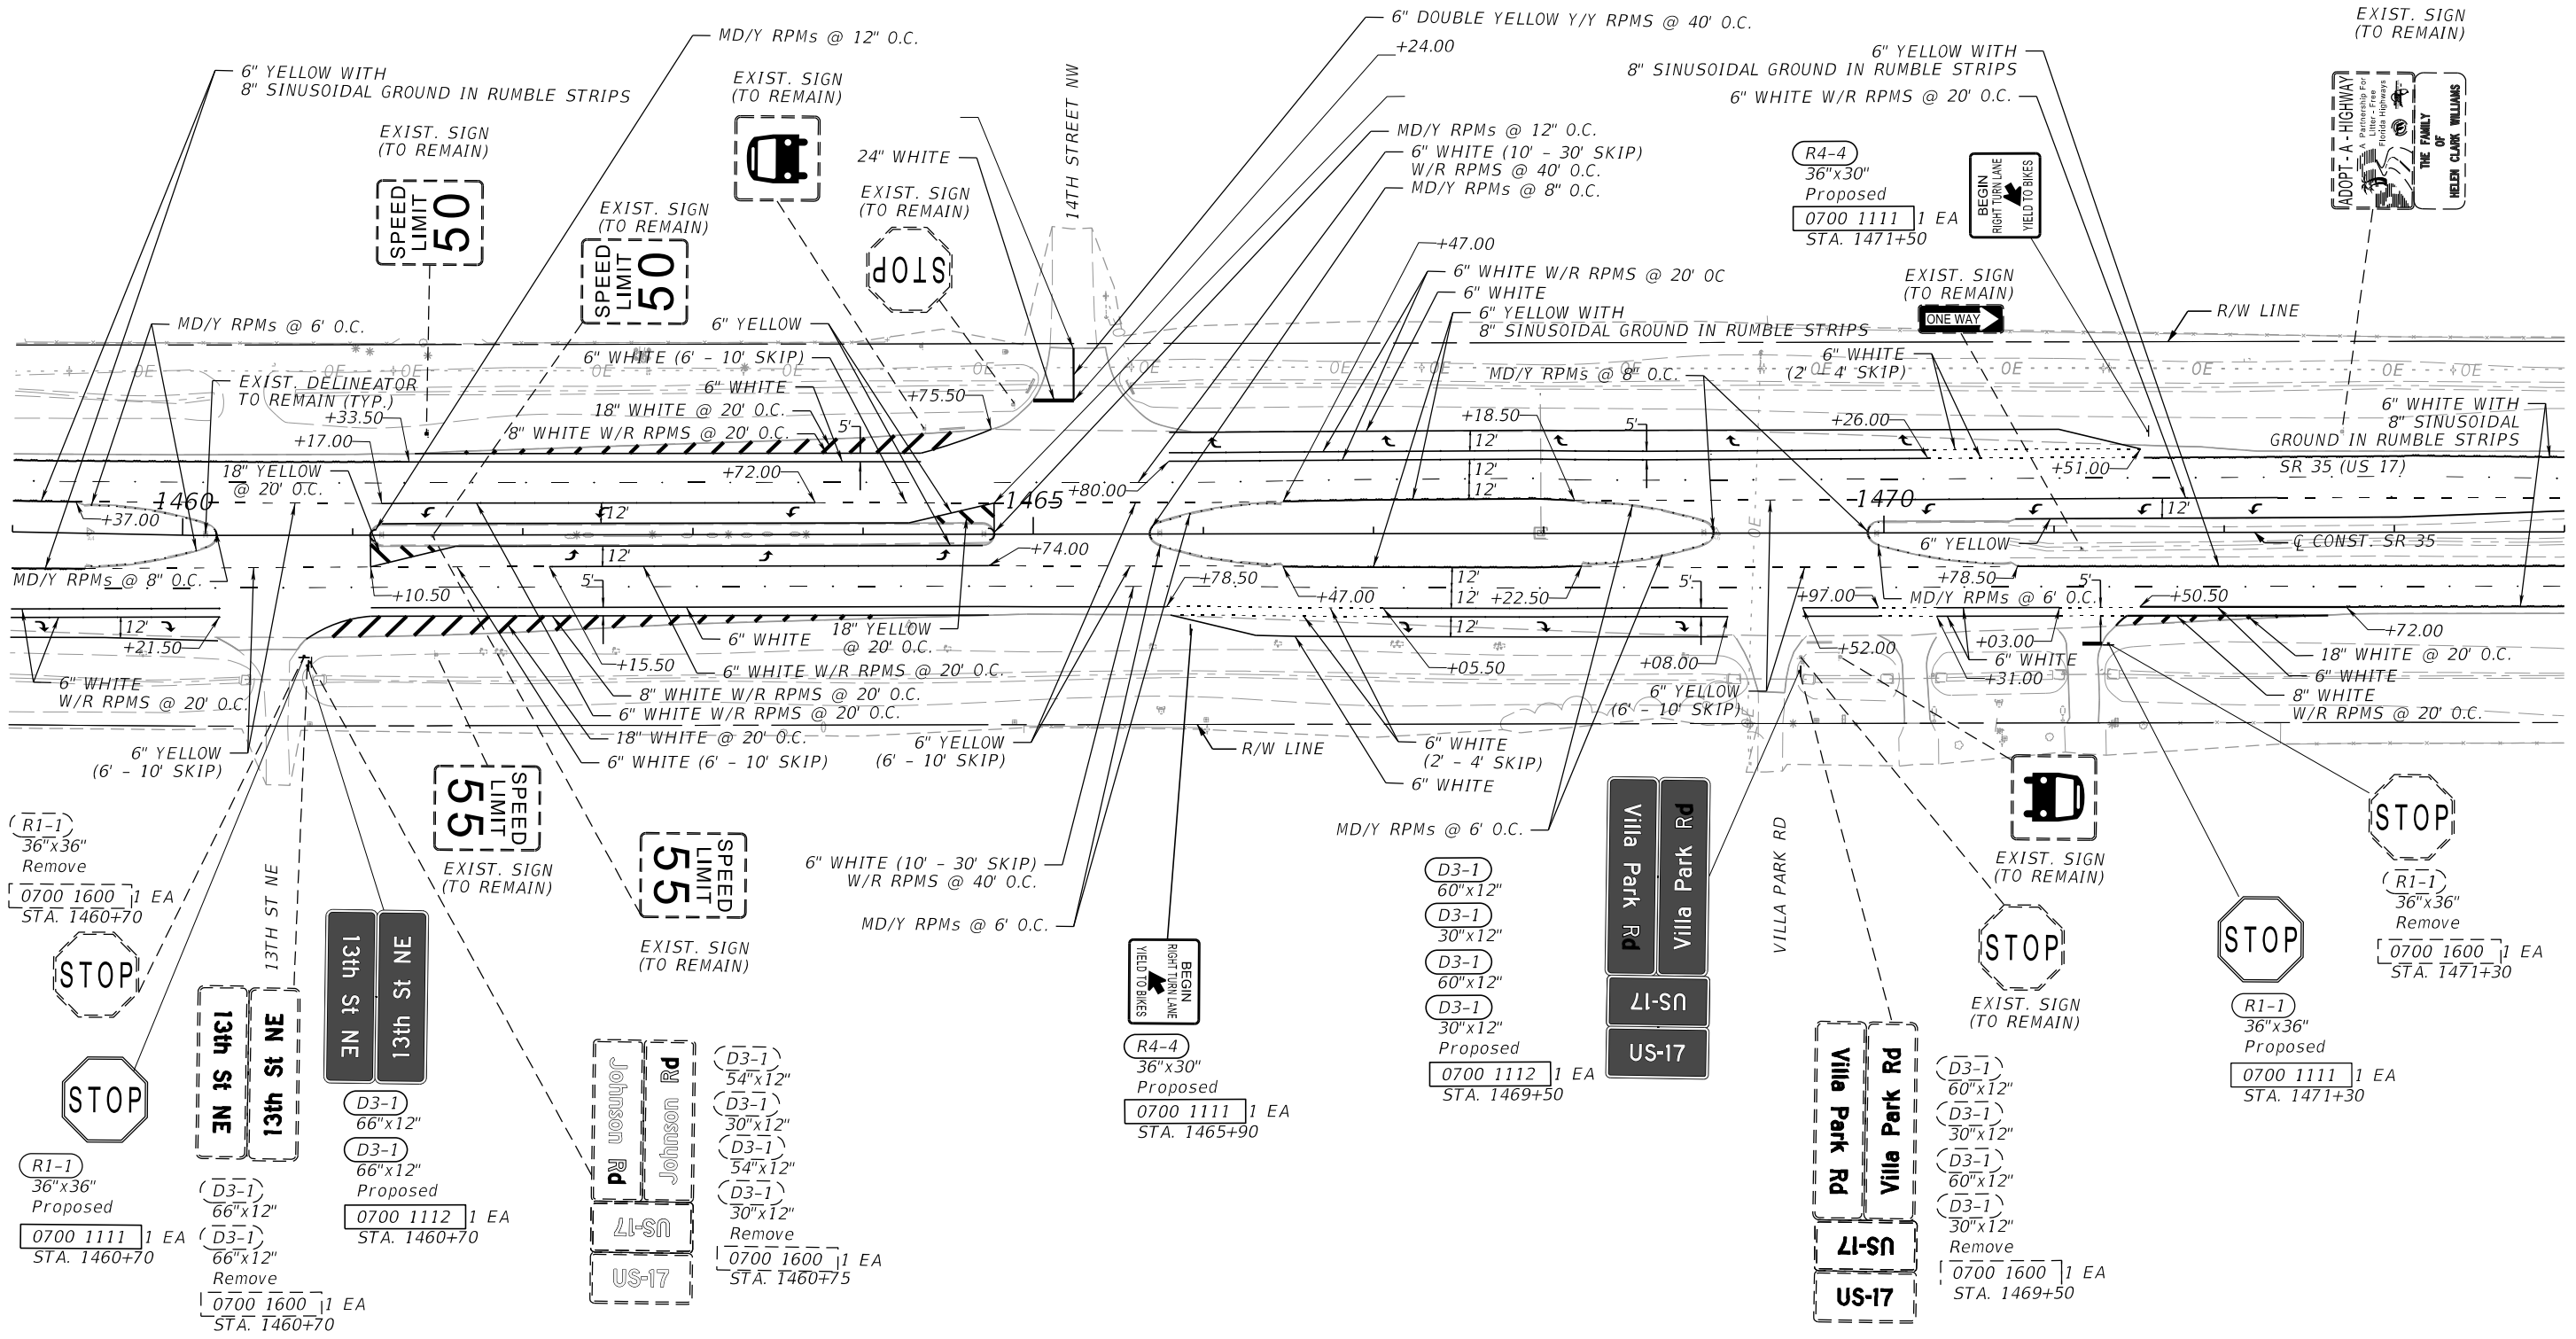


3/18/2024 5:31:40 PM Shuvo S:\2220010500-US17_SR35_3R\44923215201\signing\PLANS\SP01.dgn

THE OFFICIAL RECORD OF THIS SHEET IS THE ELECTRONIC FILE DIGITALLY SIGNED AND SEALED UNDER RULE 61G15-23.004, F.A.C.

REVISIONS		ENGINEER OF RECORD		STATE OF FLORIDA DEPARTMENT OF TRANSPORTATION			SHEET NO.
DATE	DESCRIPTION	DATE	DESCRIPTION	ROAD NO.	COUNTY	FINANCIAL PROJECT ID	
			MAJHARUL ALAM, P.E. LICENSE NUMBER 61600 PROPEL ENGINEERING, INC. 2711 N VISTA PARKWAY, SUITE B7 WEST PALM BEACH, FL 33411	SR 35	POLK	4492321-52-01	S-4

**SIGNING AND PAVEMENT
MARKING PLANS**


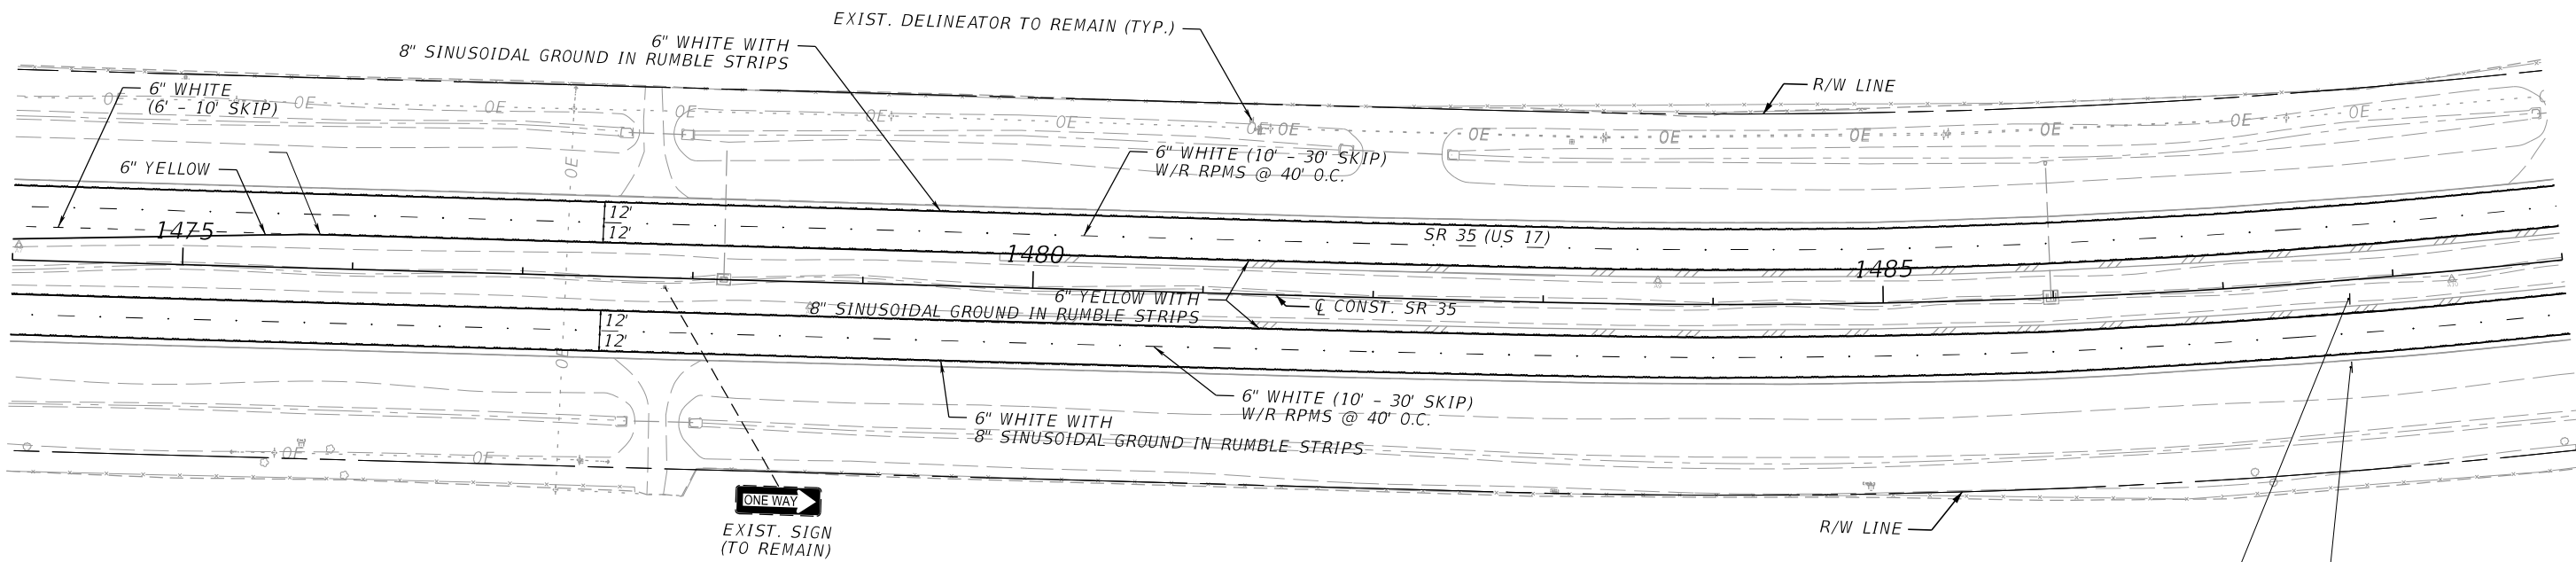


R5-1a 42"x30" Proposed	
0700 1111	1 EA
0700 13 15	1 EA
STA. 1487+70	
WRONG WAY	
R5-1a 42"x30" Proposed	
0700 1111	1 EA
0700 13 15	1 EA
STA. 1487+70	
WRONG WAY	

3/18/2024 5:31:41 PM Shuvo S:\2220010500-US17_SR35_3R\44923215201\signing\PLANS\PO1.dgn

REVISIONS				ENGINEER OF RECORD		STATE OF FLORIDA DEPARTMENT OF TRANSPORTATION			SIGNING AND PAVEMENT MARKING PLANS	SHEET NO.
DATE	DESCRIPTION	DATE	DESCRIPTION	MAJHARUL ALAM, P.E. LICENSE NUMBER 61600 PROPEL ENGINEERING, INC. 2711 N VISTA PARKWAY, SUITE B7 WEST PALM BEACH, FL 33411		ROAD NO.	COUNTY	FINANCIAL PROJECT ID		S-5
						SR 35	POLK	449232-1-52-01		


 
THE OFFICIAL RECORD OF THIS SHEET IS THE ELECTRONIC FILE DIGITALLY SIGNED AND SEALED UNDER RULE 61G15-23.004, F.A.C.

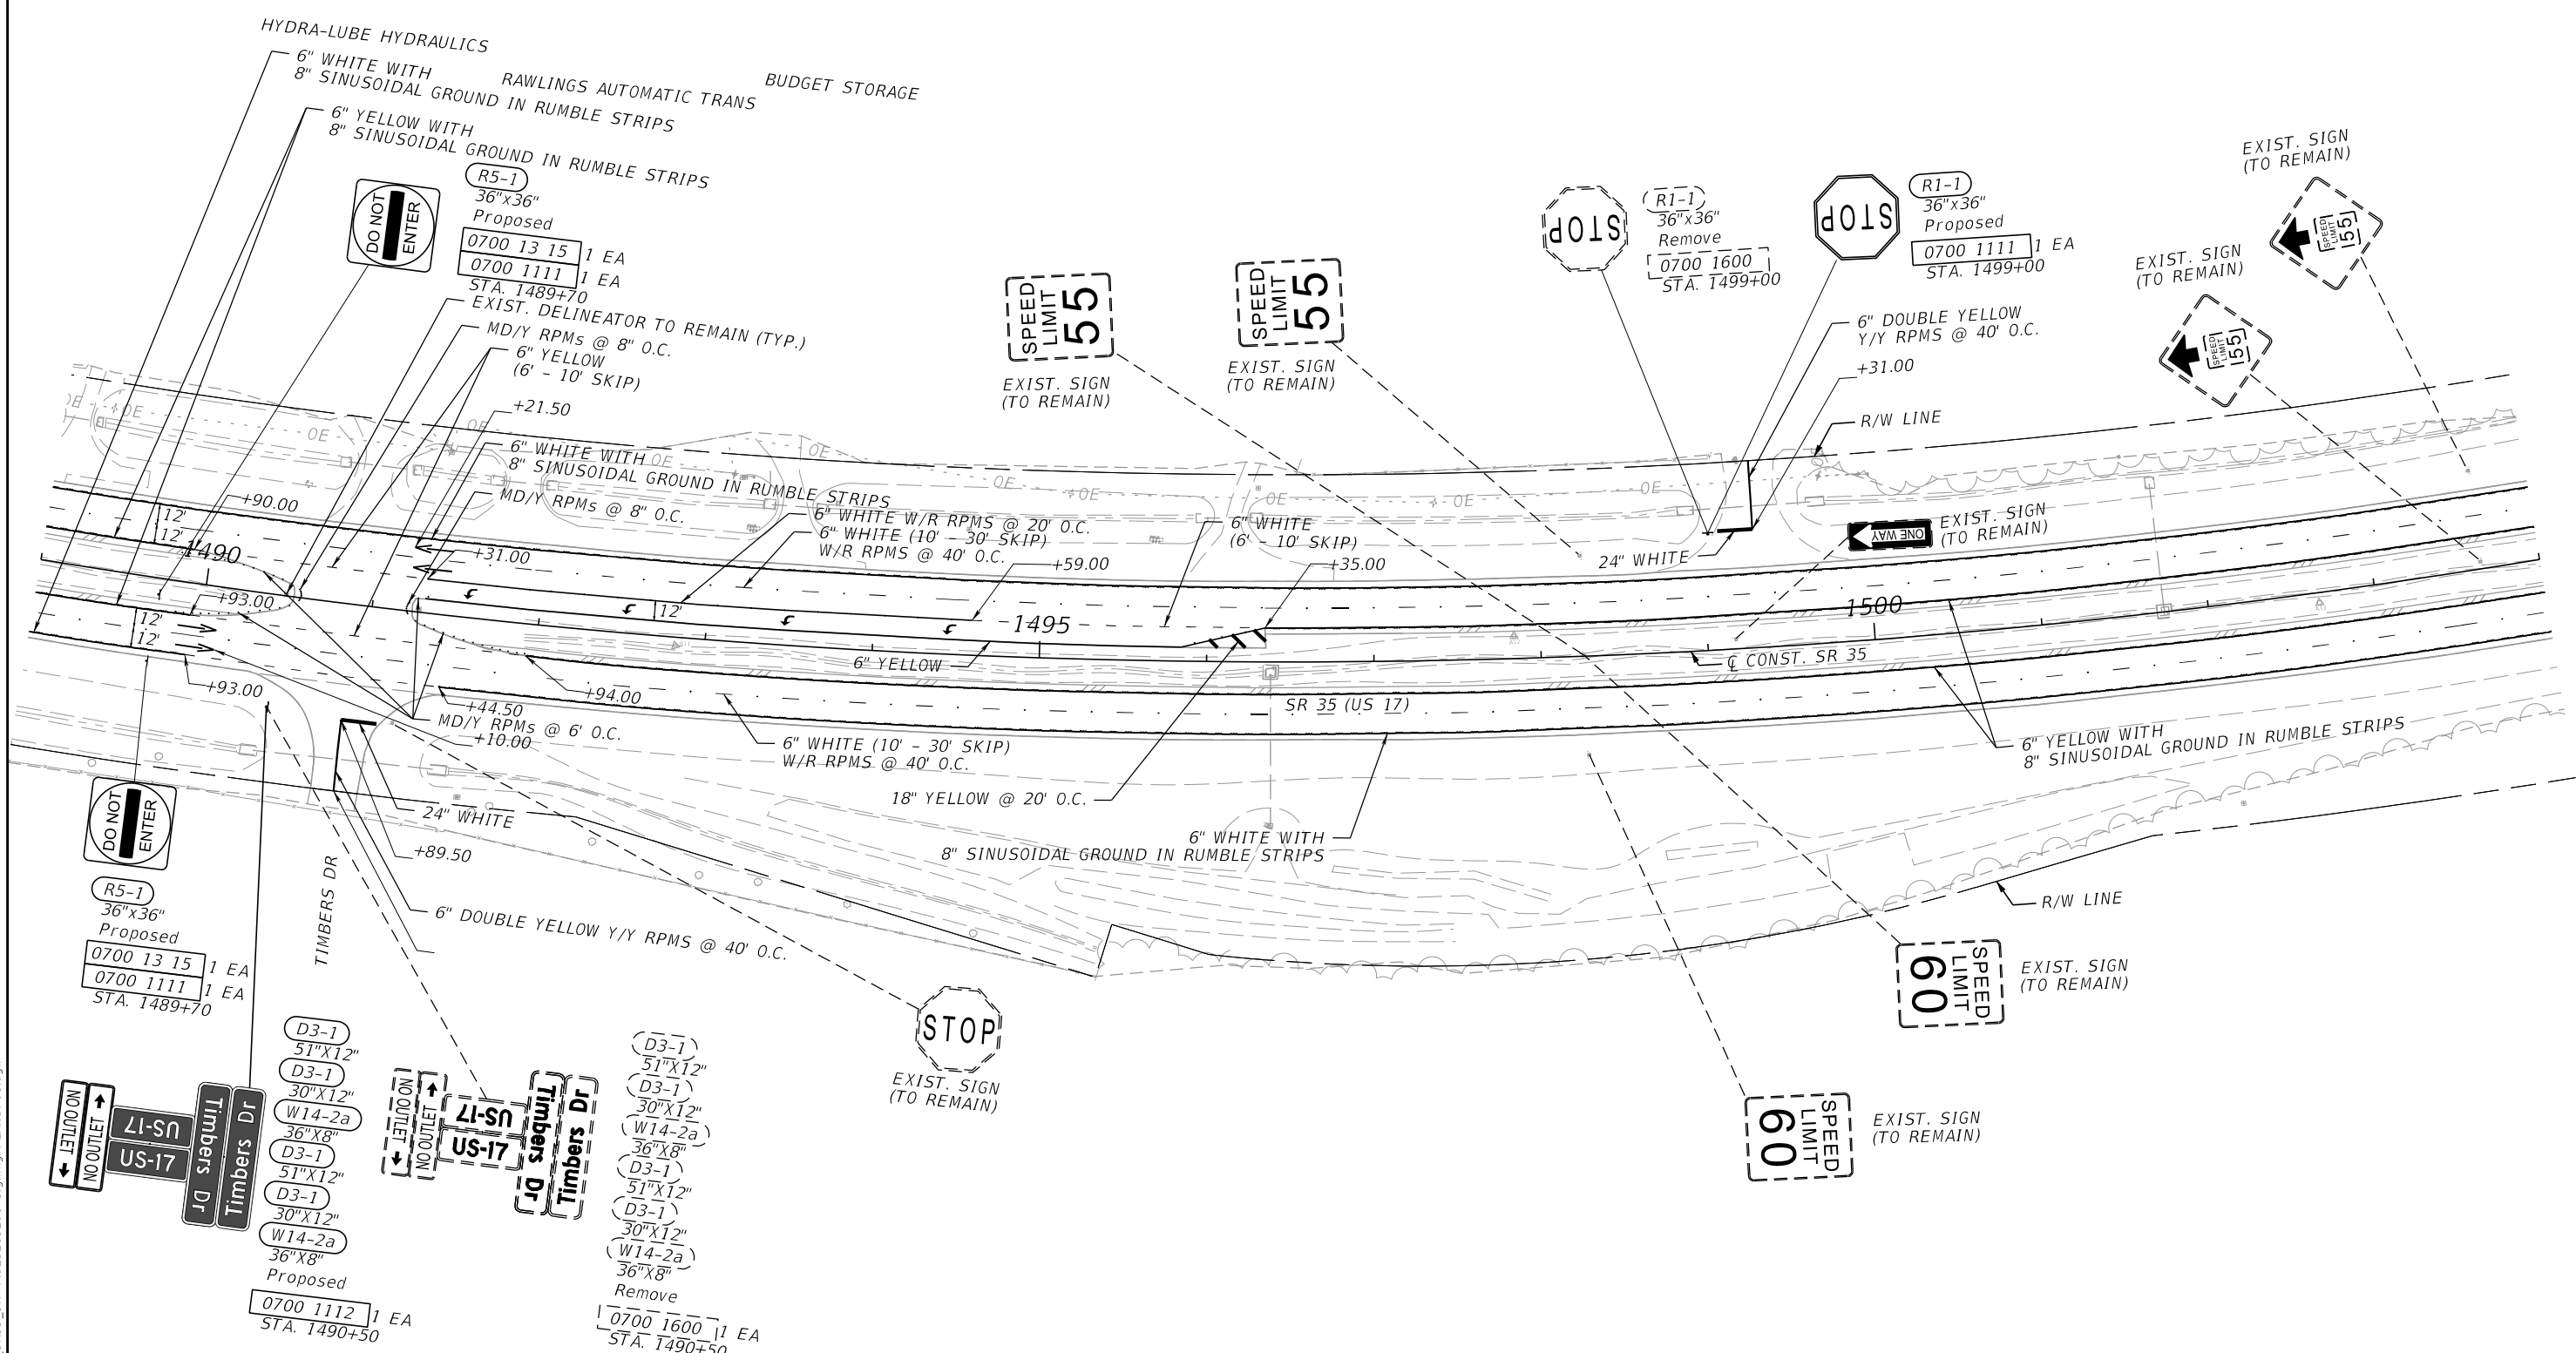

3/18/2024 5:31:41 PM Shuvo S:\2220010500-US17_SR35_3R\44923215201\signing\PLANS\PO1.dgn

THE OFFICIAL RECORD OF THIS SHEET IS THE ELECTRONIC FILE DIGITALLY SIGNED AND SEALED UNDER RULE 61G15-23.004, F.A.C.

REVISIONS		ENGINEER OF RECORD		STATE OF FLORIDA DEPARTMENT OF TRANSPORTATION			SHEET NO.
DATE	DESCRIPTION	DATE	DESCRIPTION	ROAD NO.	COUNTY	FINANCIAL PROJECT ID	
			MAJHARUL ALAM, P.E. LICENSE NUMBER 61600 PROPEL ENGINEERING, INC. 2711 N VISTA PARKWAY, SUITE B7 WEST PALM BEACH, FL 33411	SR 35	POLK	449232-1-52-01	S-6

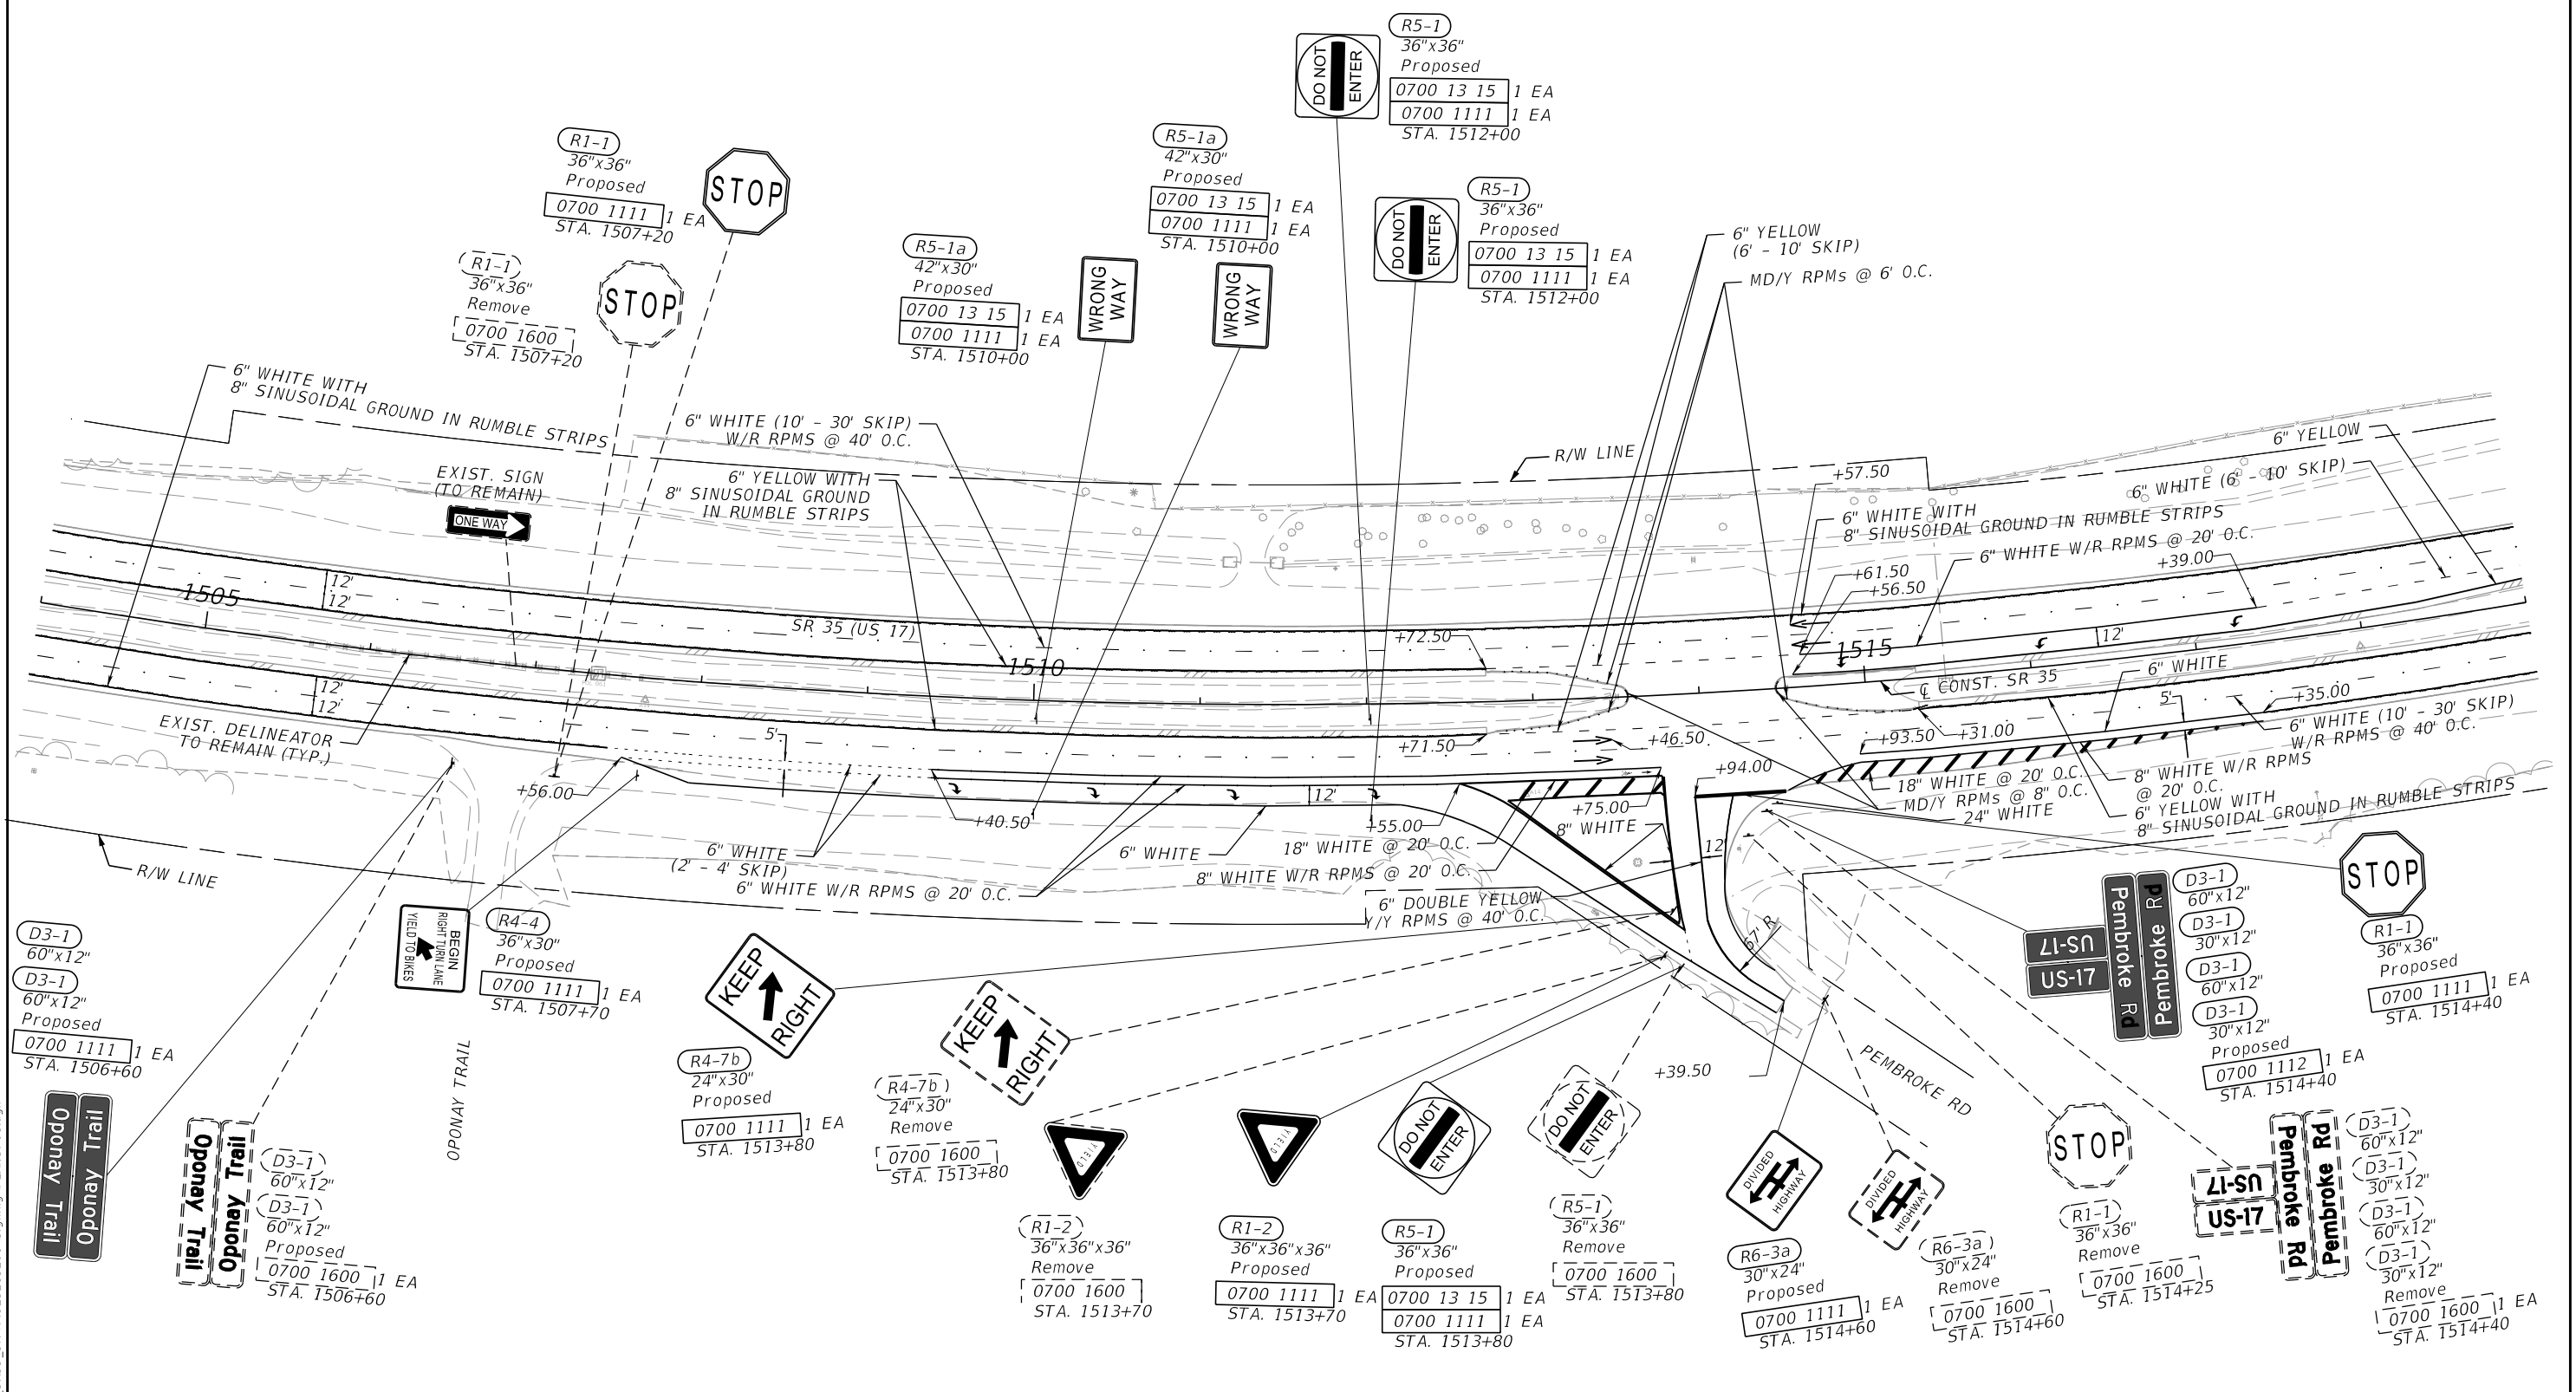
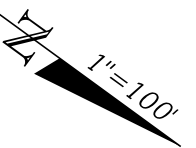


3/18/2024 5:31:42 PM Shuvo S:\2220010500-US17_SRP35_3R\44923215201\signing\PLANS\PO1.dgn

THE OFFICIAL RECORD OF THIS SHEET IS THE ELECTRONIC FILE DIGITALLY SIGNED AND SEALED UNDER RULE 61G15-23.004, F.A.C.

REVISIONS		ENGINEER OF RECORD		STATE OF FLORIDA DEPARTMENT OF TRANSPORTATION			SHEET NO.
DATE	DESCRIPTION	DATE	DESCRIPTION	ROAD NO.	COUNTY	FINANCIAL PROJECT ID	
			MAJHARUL ALAM, P.E. LICENSE NUMBER 61600 PROPEL ENGINEERING, INC. 2711 N VISTA PARKWAY, SUITE B7 WEST PALM BEACH, FL 33411	SR 35	POLK	449232-1-52-01	S-7

**SIGNING AND PAVEMENT
MARKING PLANS**

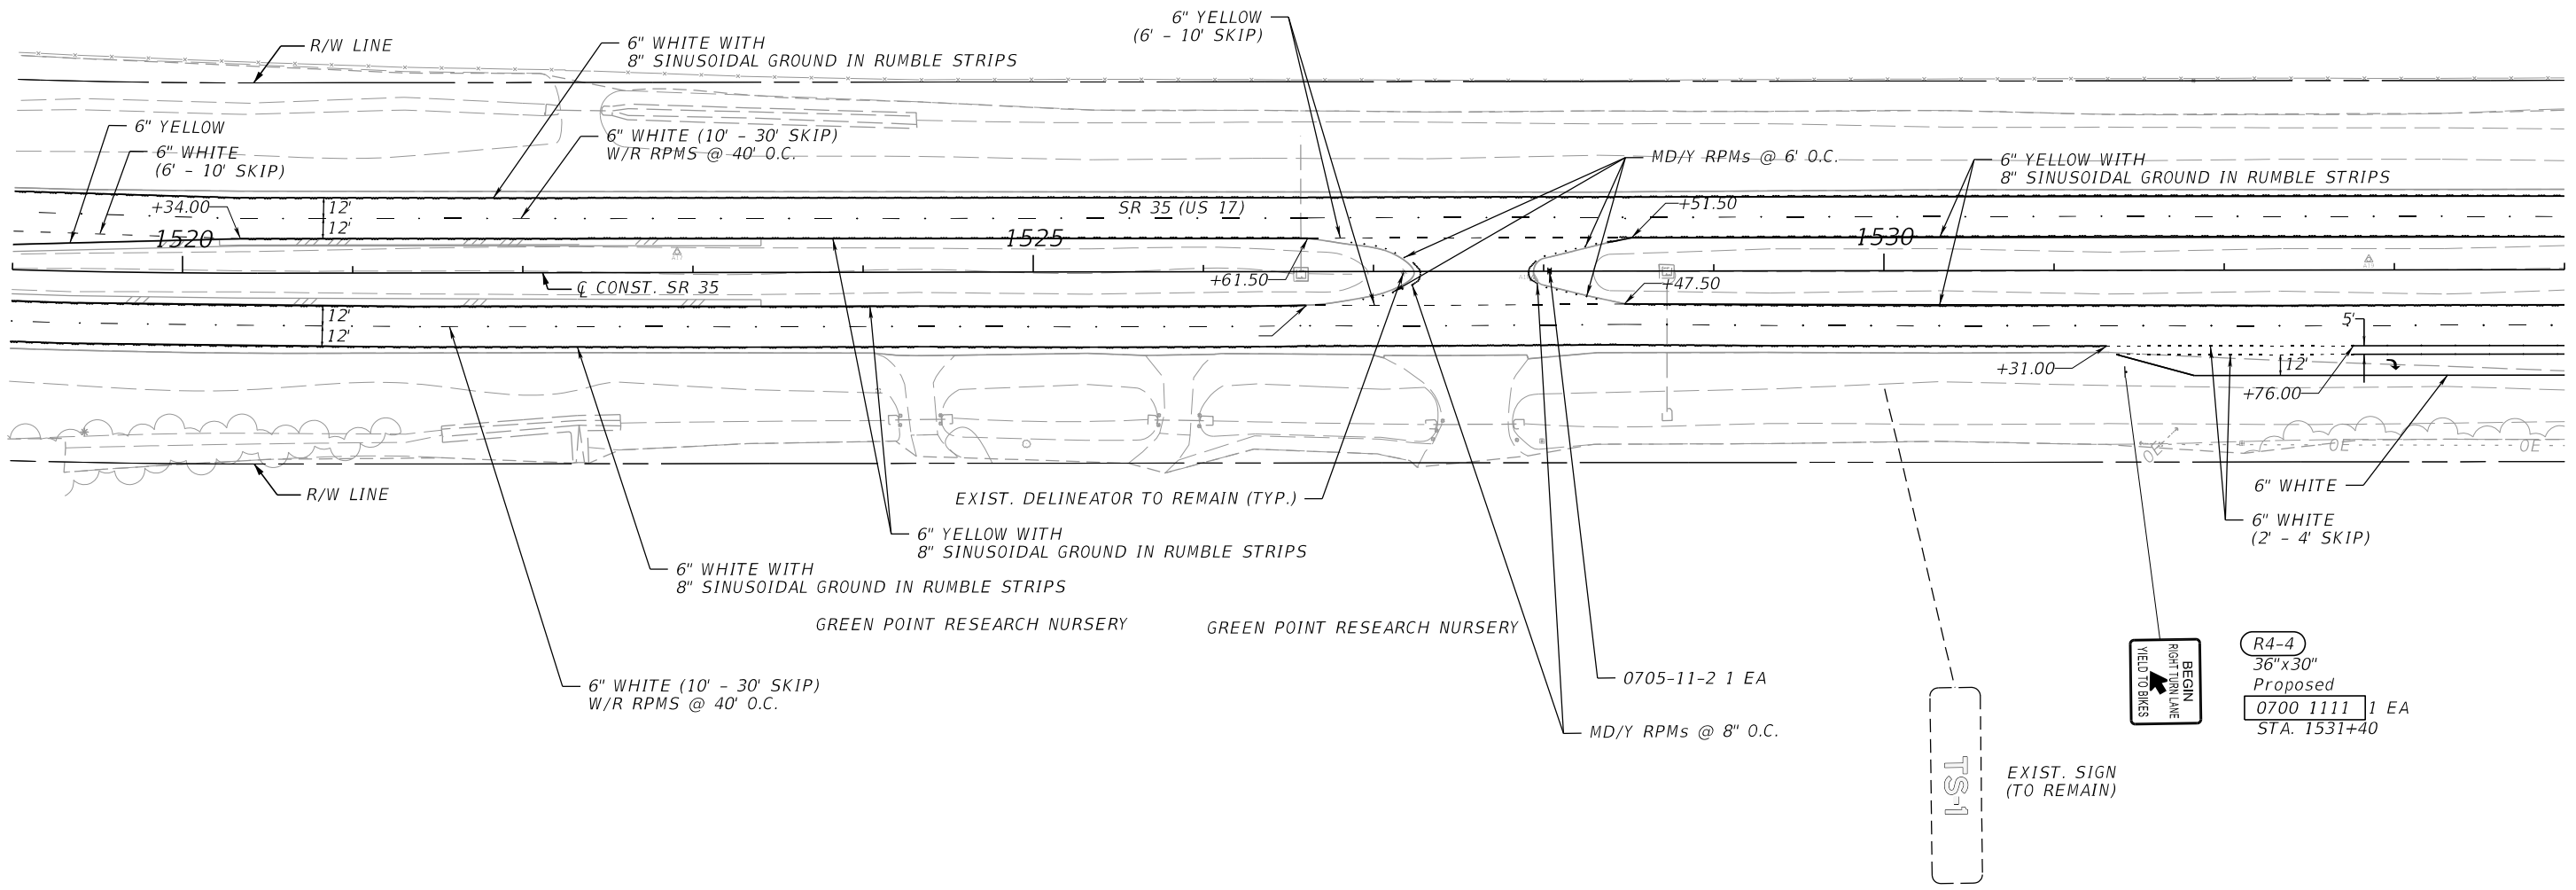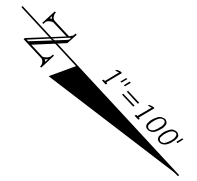


3/18/2024 5:31:43 PM Shuvo S:\2220010500-US17_SR35_3R\44923215201\signing\PLANS\PO1.dgn

THE OFFICIAL RECORD OF THIS SHEET IS THE ELECTRONIC FILE DIGITALLY SIGNED AND SEALED UNDER RULE 61G15-23.004, F.A.C.



REVISIONS				ENGINEER OF RECORD		STATE OF FLORIDA DEPARTMENT OF TRANSPORTATION			SIGNING AND PAVEMENT MARKING PLANS	SHEET NO.
DATE	DESCRIPTION	DATE	DESCRIPTION	MAJHARUL ALAM, P.E. LICENSE NUMBER 61600 PROPEL ENGINEERING, INC. 2711 N VISTA PARKWAY, SUITE B7 WEST PALM BEACH, FL 33411		ROAD NO.	COUNTY	FINANCIAL PROJECT ID		S-8
						SR 35	POLK	449232-1-52-01		

3/18/2024 5:31:43 PM Shuvo S:\2220010500-US17_SR35_3R\44923215201\signing\PLANS\PO1.dgn

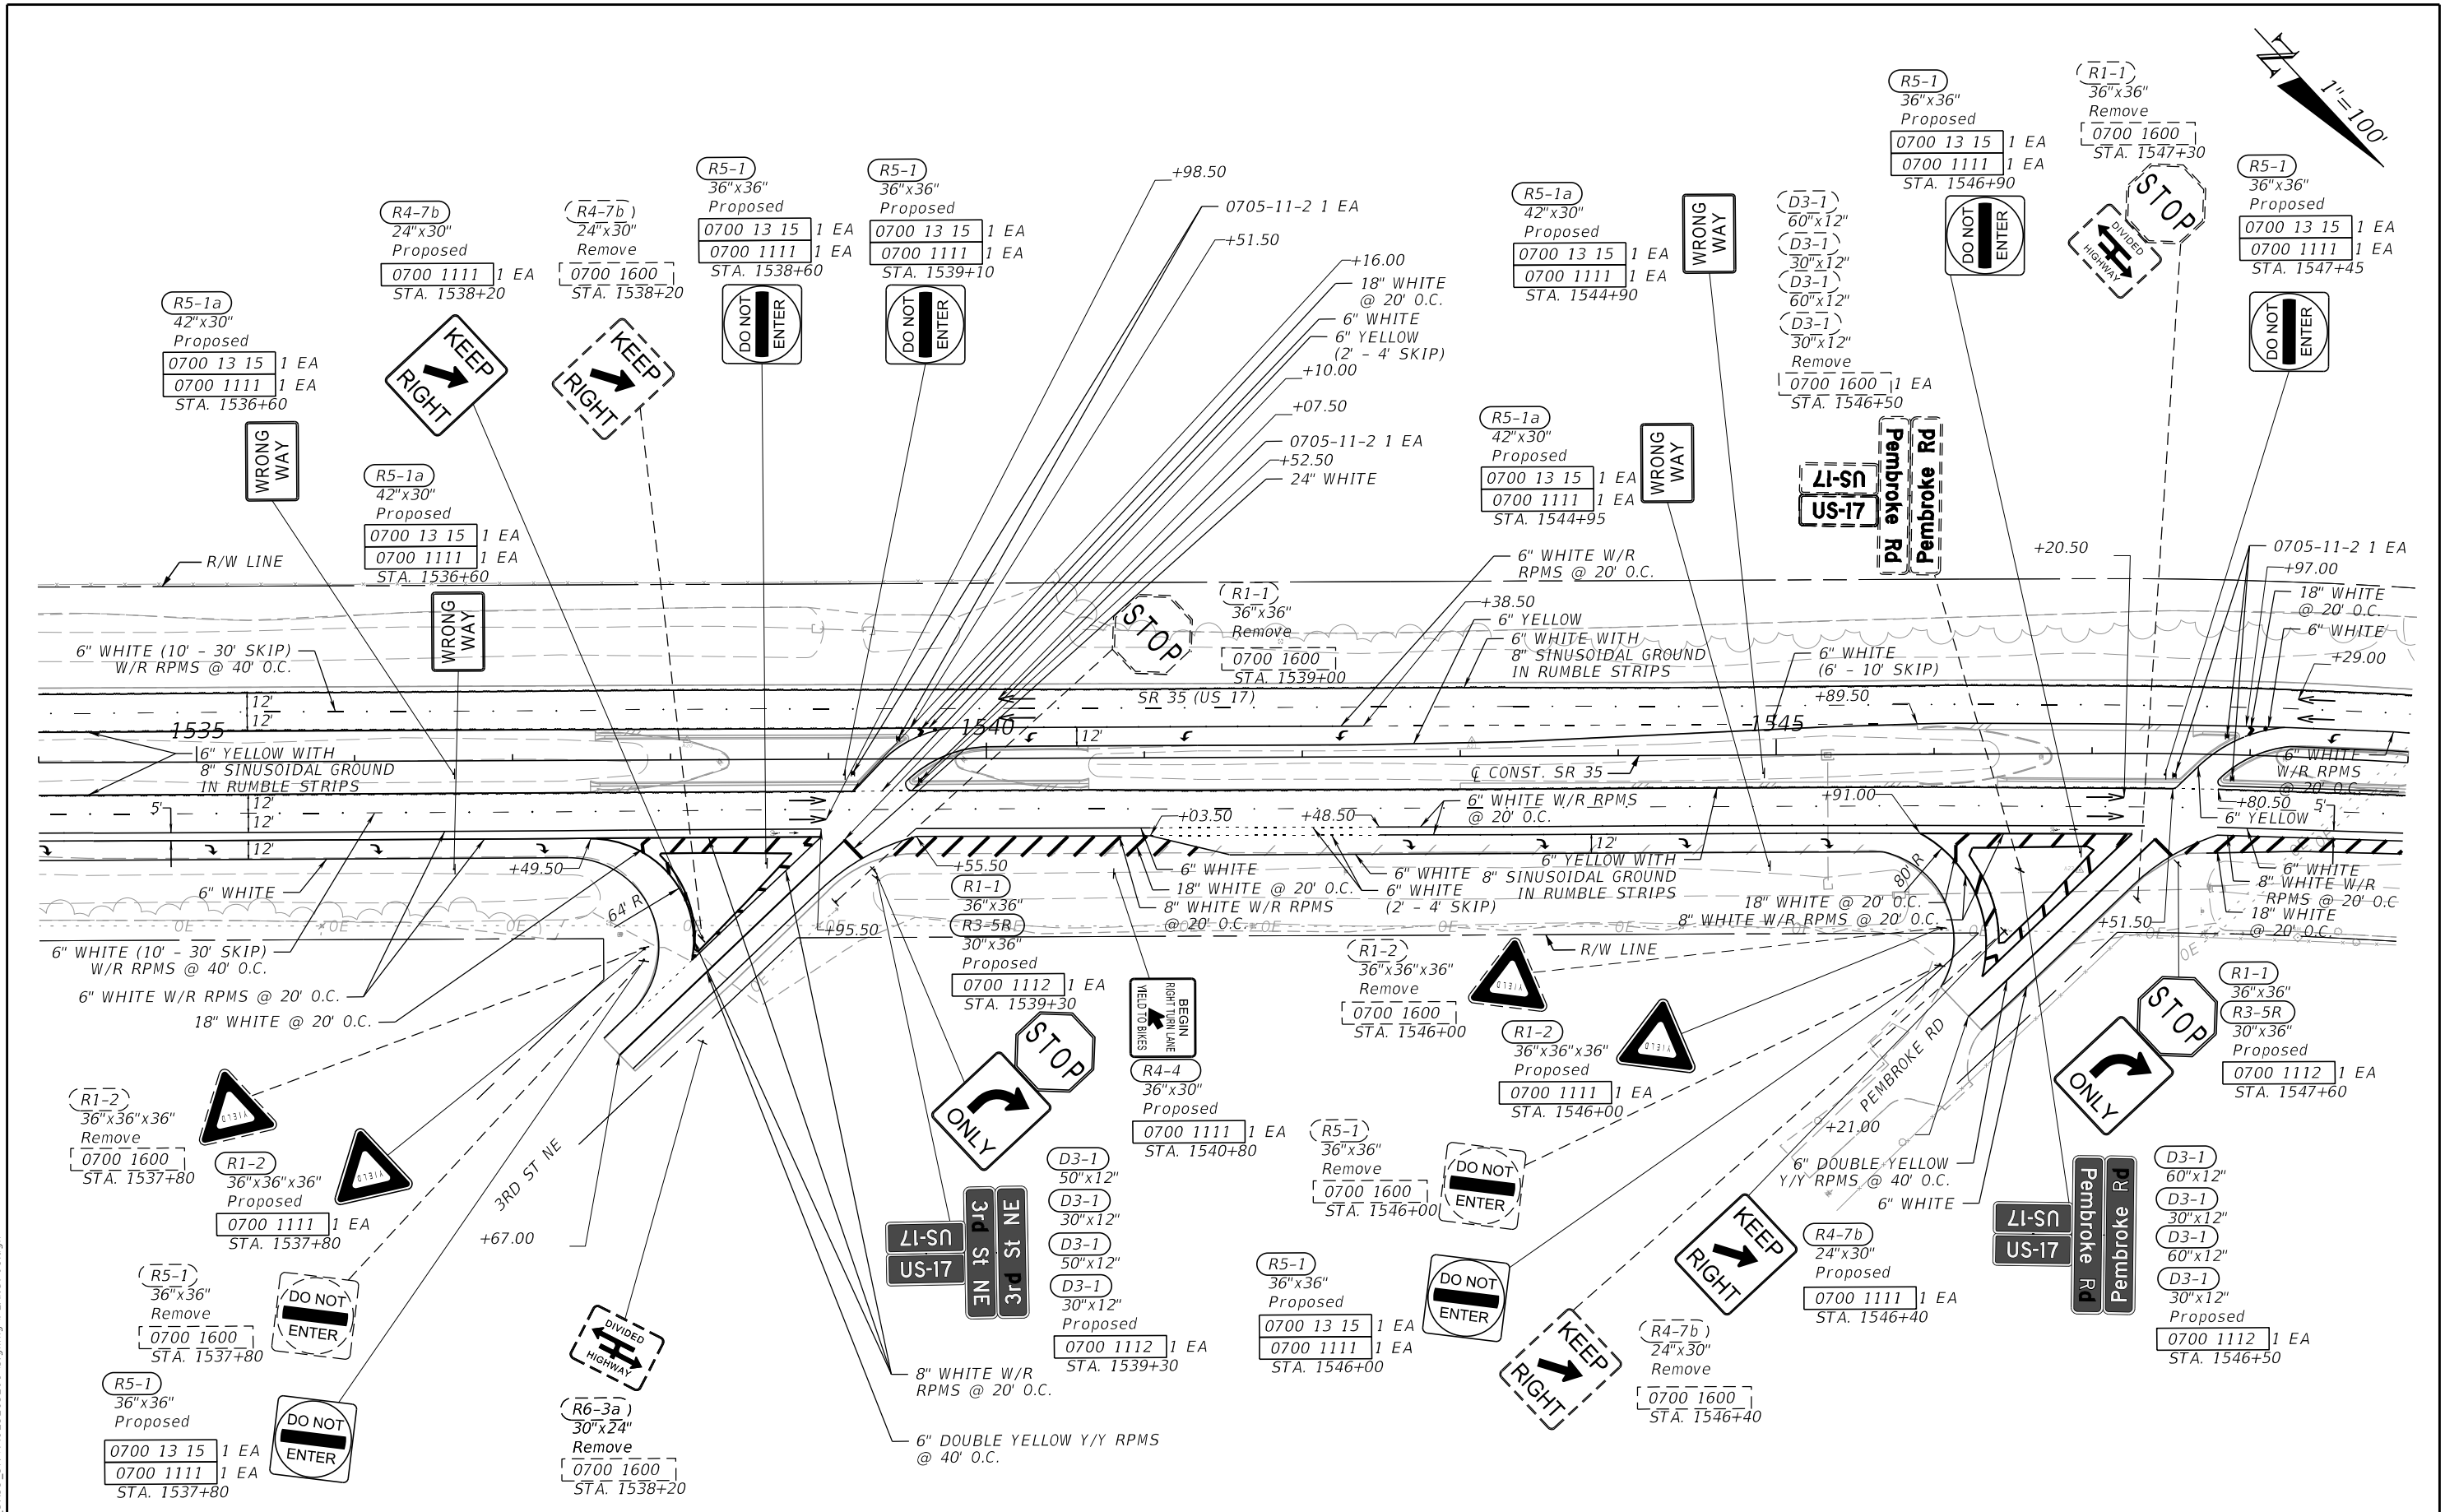

THE OFFICIAL RECORD OF THIS SHEET IS THE ELECTRONIC FILE DIGITALLY SIGNED AND SEALED UNDER RULE 61G15-23.004, F.A.C.

REVISIONS		ENGINEER OF RECORD		STATE OF FLORIDA DEPARTMENT OF TRANSPORTATION			SHEET NO.
DATE	DESCRIPTION	DATE	DESCRIPTION	ROAD NO.	COUNTY	FINANCIAL PROJECT ID	
			MAJHARUL ALAM, P.E. LICENSE NUMBER 61600 PROPEL ENGINEERING, INC. 2711 N VISTA PARKWAY, SUITE B7 WEST PALM BEACH, FL 33411	SR 35	POLK	449232-152-01	
SIGNING AND PAVEMENT MARKING PLANS							S-9

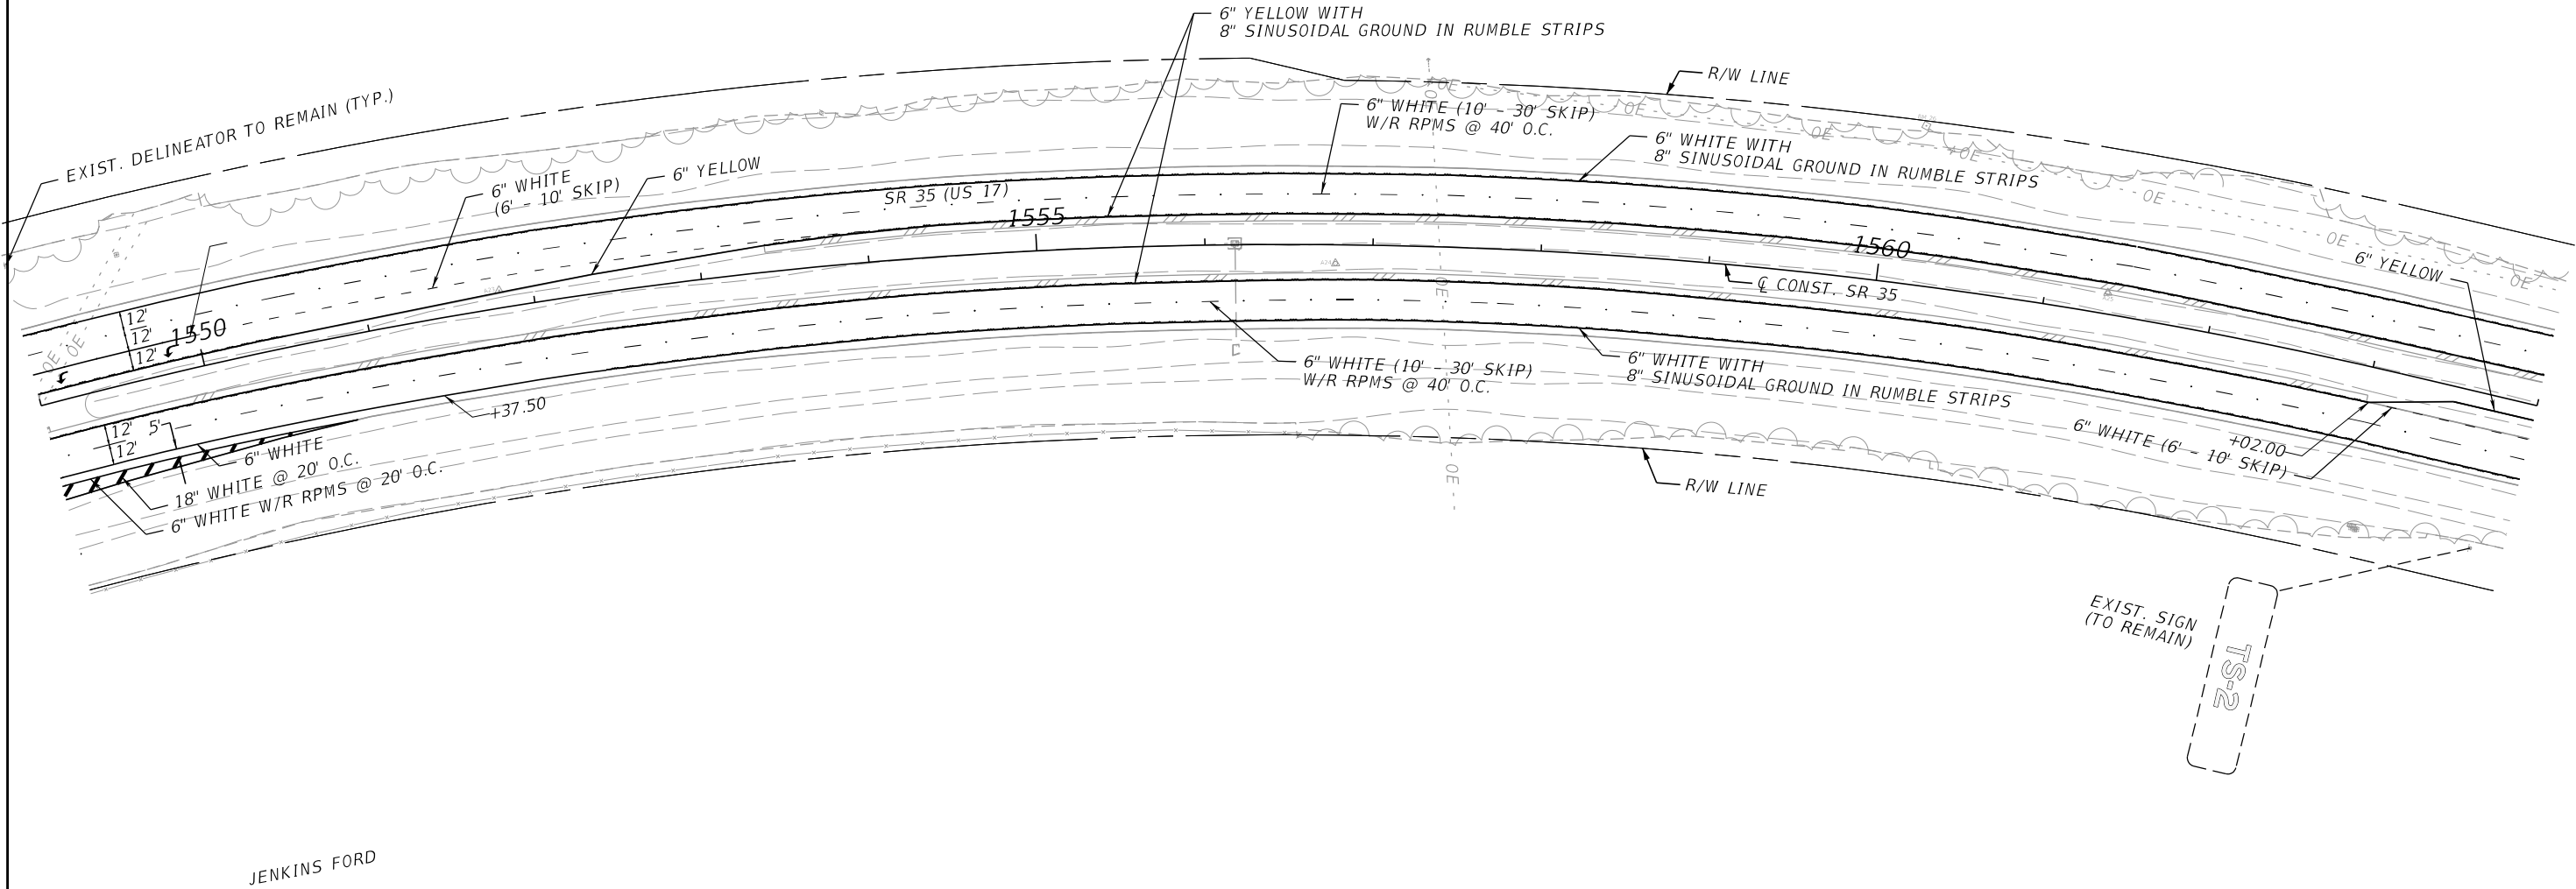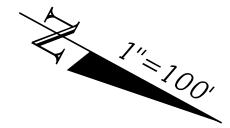

JENKINS FORD


EXIST. SIGN
(TO REMAIN)
TS-2

3/18/2024 5:31:44 PM Shuvo S:\2220010500-US17_SR35_BR\44923215201\signing\PLANS\PO1.dgn

THE OFFICIAL RECORD OF THIS SHEET IS THE ELECTRONIC FILE DIGITALLY SIGNED AND SEALED UNDER RULE 61G15-23.004, F.A.C.

REVISIONS				ENGINEER OF RECORD		STATE OF FLORIDA DEPARTMENT OF TRANSPORTATION			SIGNING AND PAVEMENT MARKING PLANS	SHEET NO.
DATE	DESCRIPTION	DATE	DESCRIPTION	MAJHARUL ALAM, P.E. LICENSE NUMBER 61600 PROPEL ENGINEERING, INC. 2711 N VISTA PARKWAY, SUITE B7 WEST PALM BEACH, FL 33411		ROAD NO.	COUNTY	FINANCIAL PROJECT ID		S-10
						SR 35	POLK	449232-1-52-01		

1"=100'

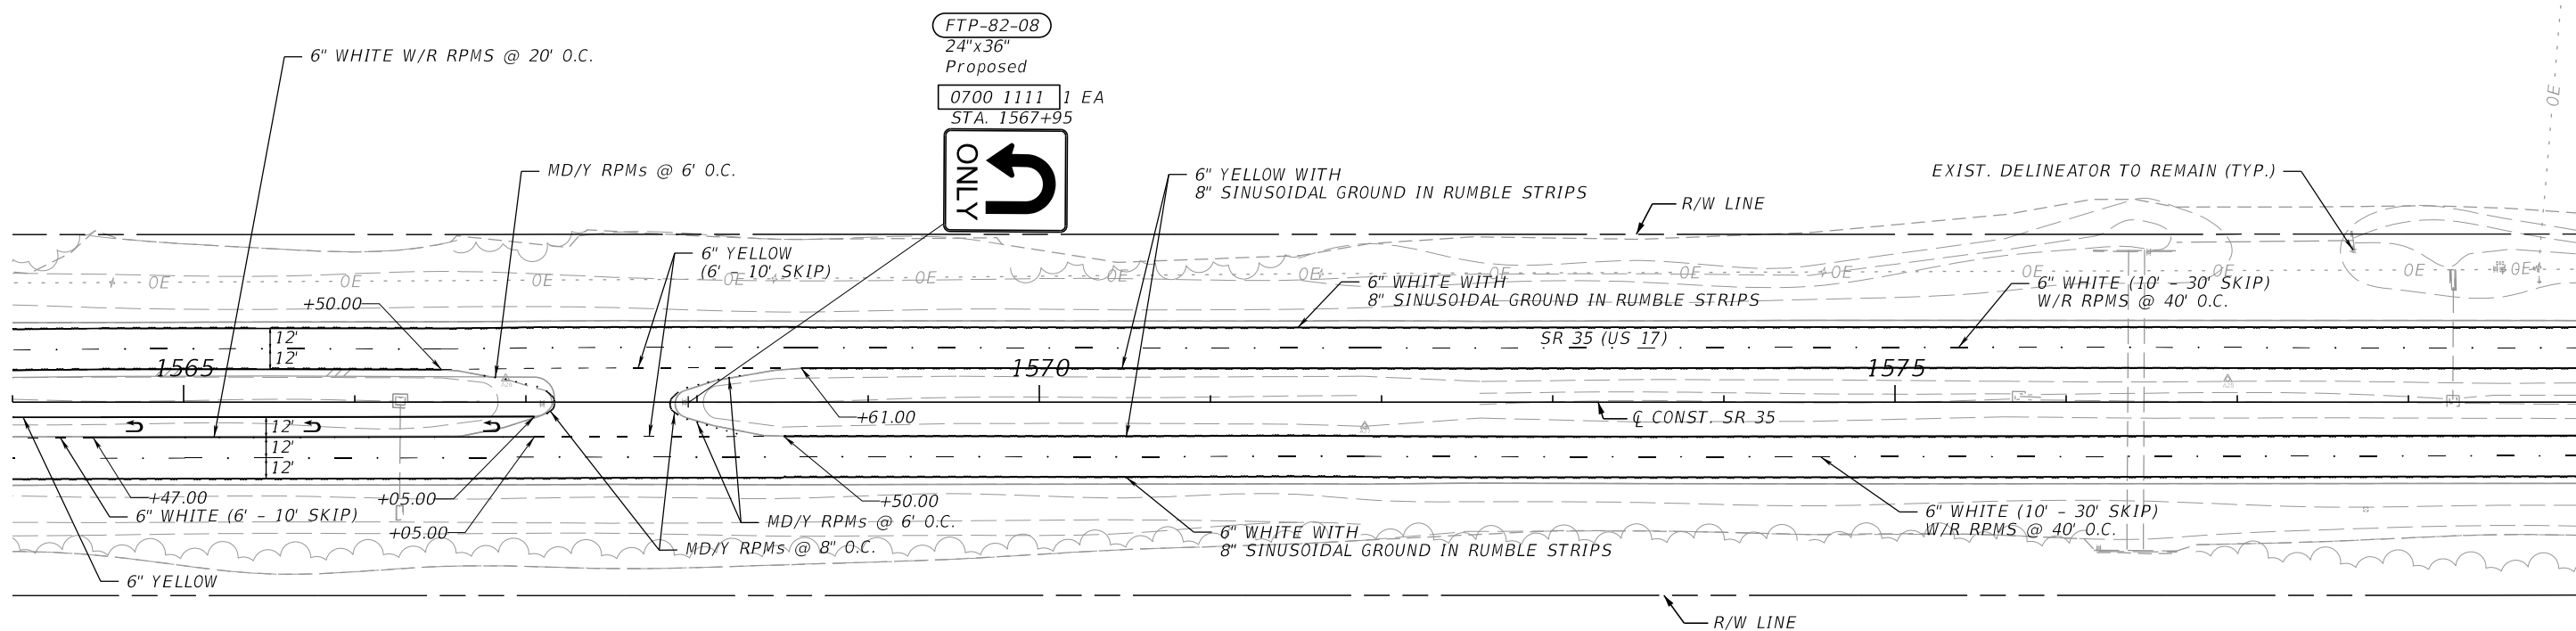

FTP-82-08
24"x36"
Proposed
0700 1111 1 EA
STA. 1567+95


U-TURN ONLY

3/18/2024 5:31:44 PM Shuvo S:\2220010500-US17_SR35_3R\44923215201\siging\PLANS\PO1.dgn

THE OFFICIAL RECORD OF THIS SHEET IS THE ELECTRONIC FILE DIGITALLY SIGNED AND SEALED UNDER RULE 61G15-23.004, F.A.C.

REVISIONS				ENGINEER OF RECORD		STATE OF FLORIDA DEPARTMENT OF TRANSPORTATION			SIGNING AND PAVEMENT MARKING PLANS	SHEET NO.
DATE	DESCRIPTION	DATE	DESCRIPTION	MAJHARUL ALAM, P.E. LICENSE NUMBER 61600 PROPEL ENGINEERING, INC. 2711 N VISTA PARKWAY, SUITE B7 WEST PALM BEACH, FL 33411		ROAD NO.	COUNTY	FINANCIAL PROJECT ID		S-11
						SR 35	POLK	449232-1-52-01		



1"=100'

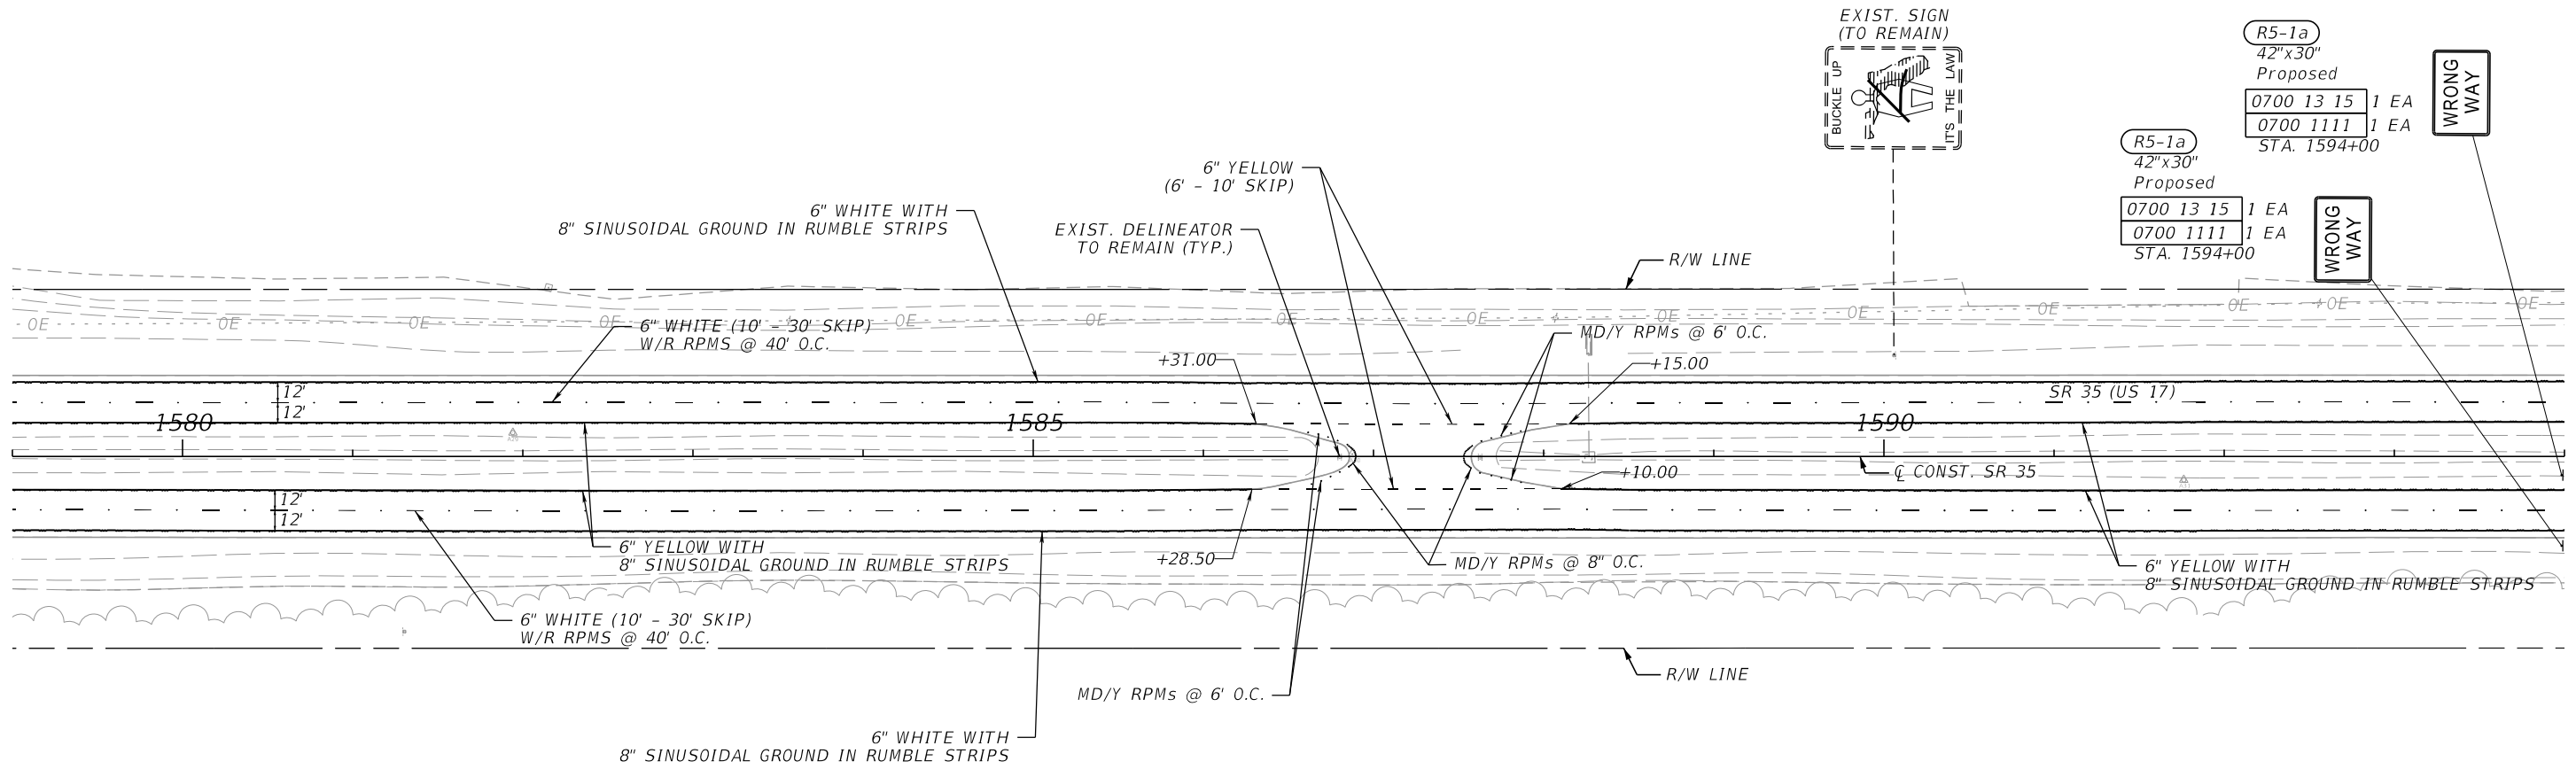

3/18/2024 5:31:45 PM Shuvo S:\2220010500-US17_SR35_3R\44923215201\signing\PLANS\PO1.dgn

THE OFFICIAL RECORD OF THIS SHEET IS THE ELECTRONIC FILE DIGITALLY SIGNED AND SEALED UNDER RULE 61G15-23.004, F.A.C.

REVISIONS				ENGINEER OF RECORD		STATE OF FLORIDA DEPARTMENT OF TRANSPORTATION			SIGNING AND PAVEMENT MARKING PLANS	SHEET NO.
DATE	DESCRIPTION	DATE	DESCRIPTION	MAJHARUL ALAM, P.E. LICENSE NUMBER 61600 PROPEL ENGINEERING, INC. 2711 N VISTA PARKWAY, SUITE B7 WEST PALM BEACH, FL 33411		ROAD NO.	COUNTY	FINANCIAL PROJECT ID		S-12
						SR 35	POLK	449232-1-52-01		

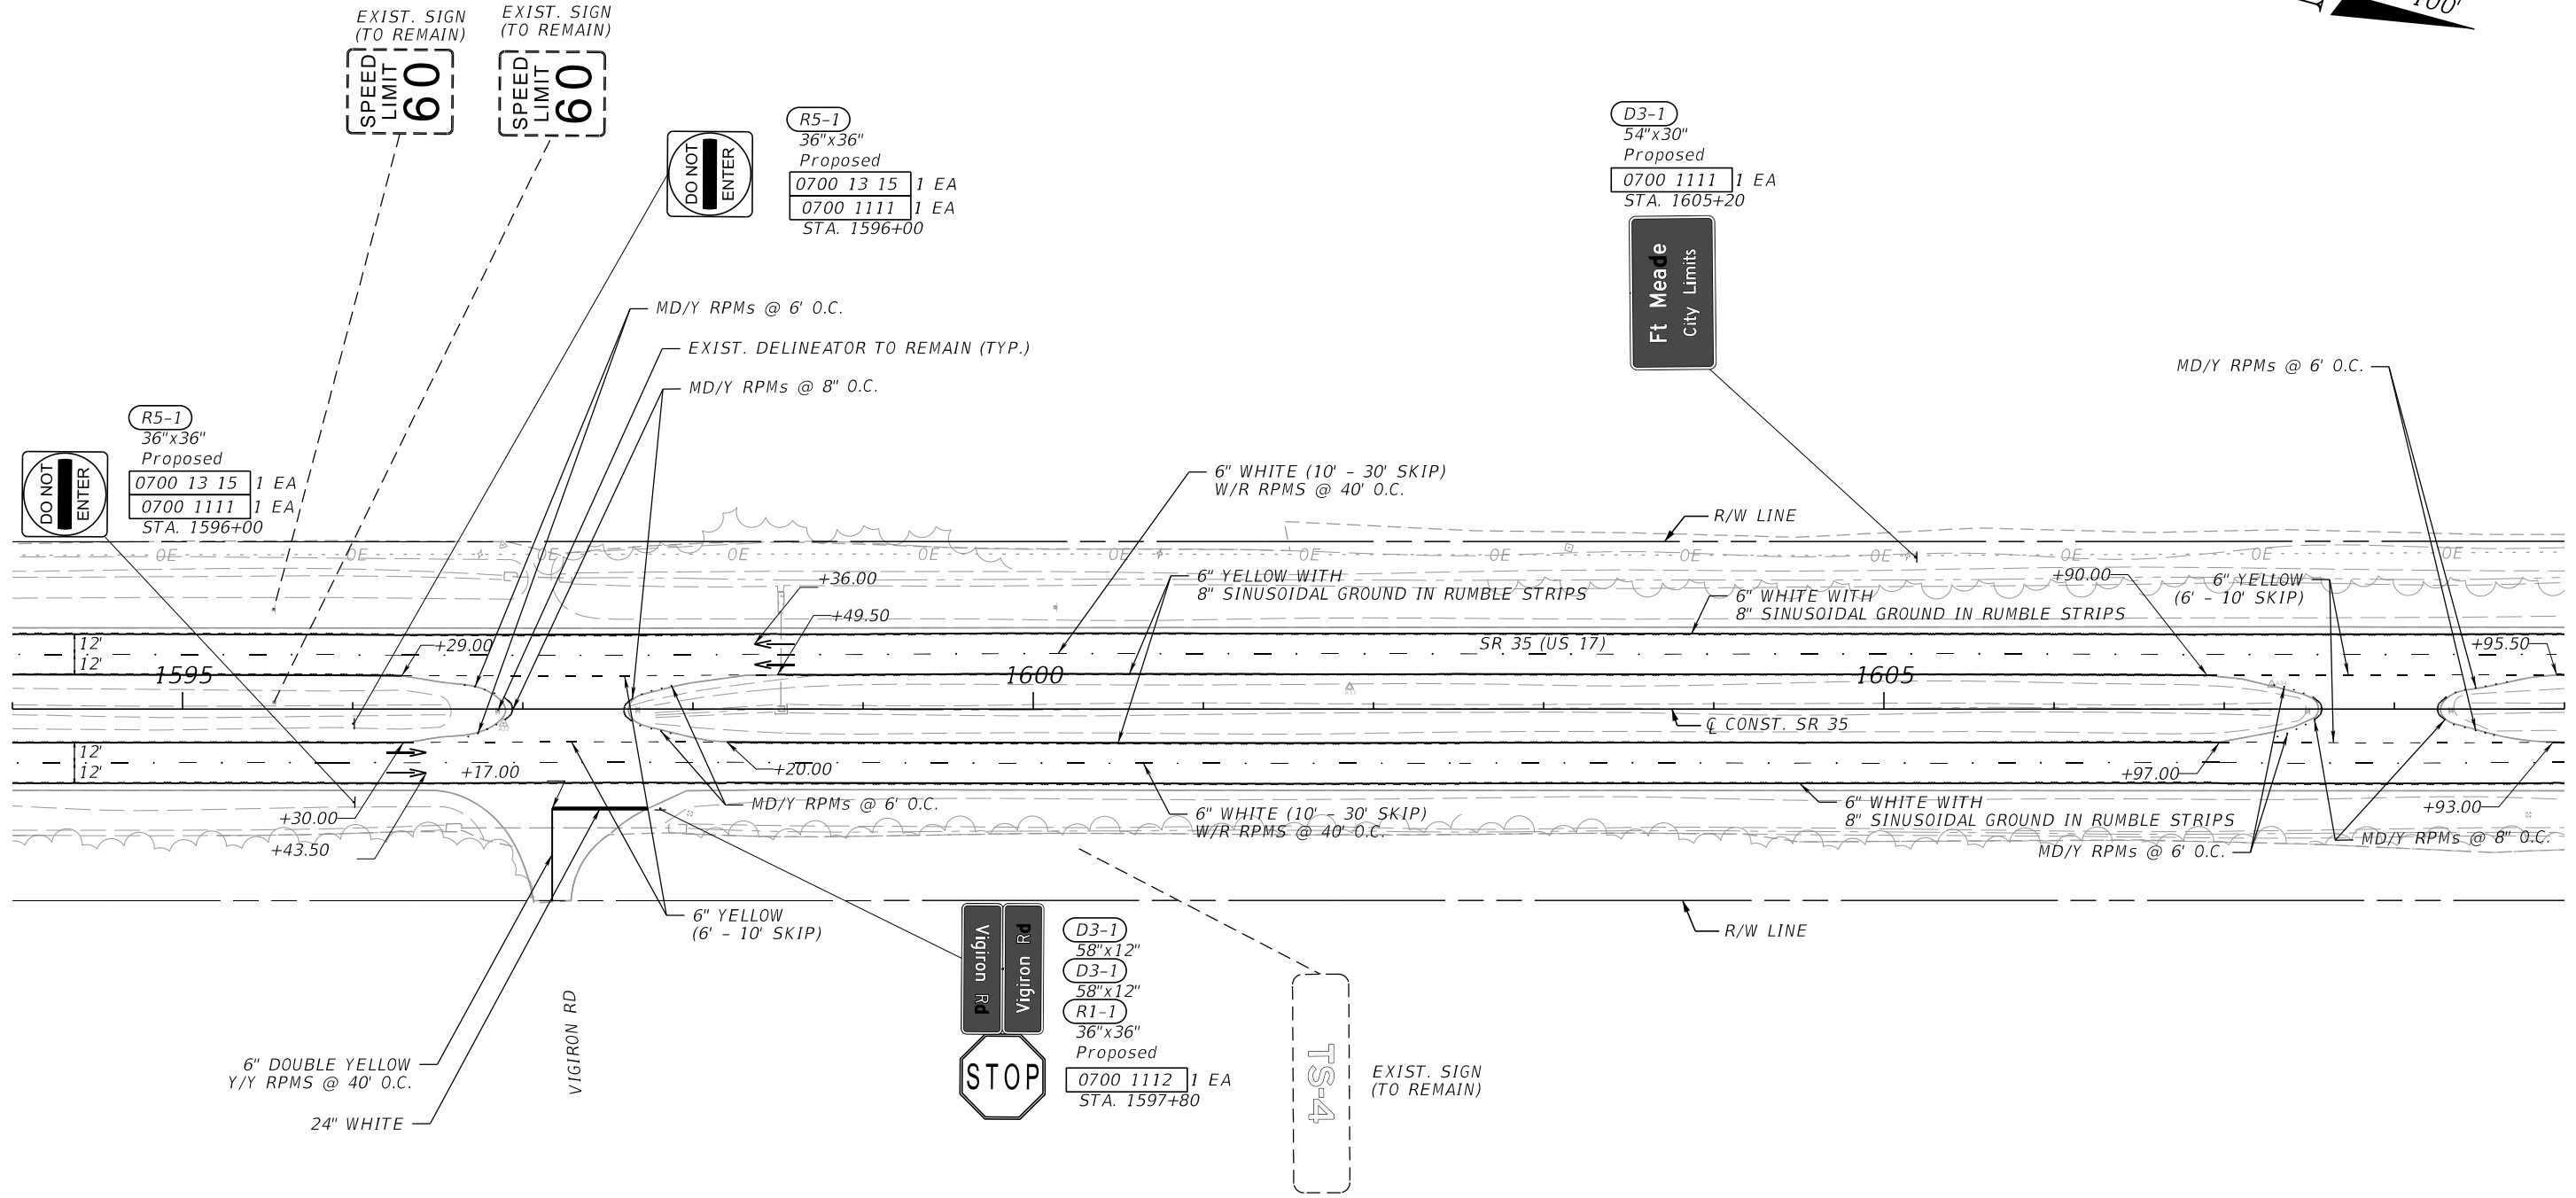 


3/18/2024 5:31:45 PM Shuvo S:\2220010500-US17_SR35_3R\44923215201\signing\PLANS\PO1.dgn

THE OFFICIAL RECORD OF THIS SHEET IS THE ELECTRONIC FILE DIGITALLY SIGNED AND SEALED UNDER RULE 61G15-23.004, F.A.C.

REVISIONS				ENGINEER OF RECORD		STATE OF FLORIDA DEPARTMENT OF TRANSPORTATION			SHEET NO.
DATE	DESCRIPTION	DATE	DESCRIPTION			ROAD NO.	COUNTY	FINANCIAL PROJECT ID	
				MAJHARUL ALAM, P.E. LICENSE NUMBER 61600 PROPEL ENGINEERING, INC. 2711 N VISTA PARKWAY, SUITE B7 WEST PALM BEACH, FL 33411		SR 35	POLK	449232-1-52-01	S-13
SIGNING AND PAVEMENT MARKING PLANS									


N 1"=100'

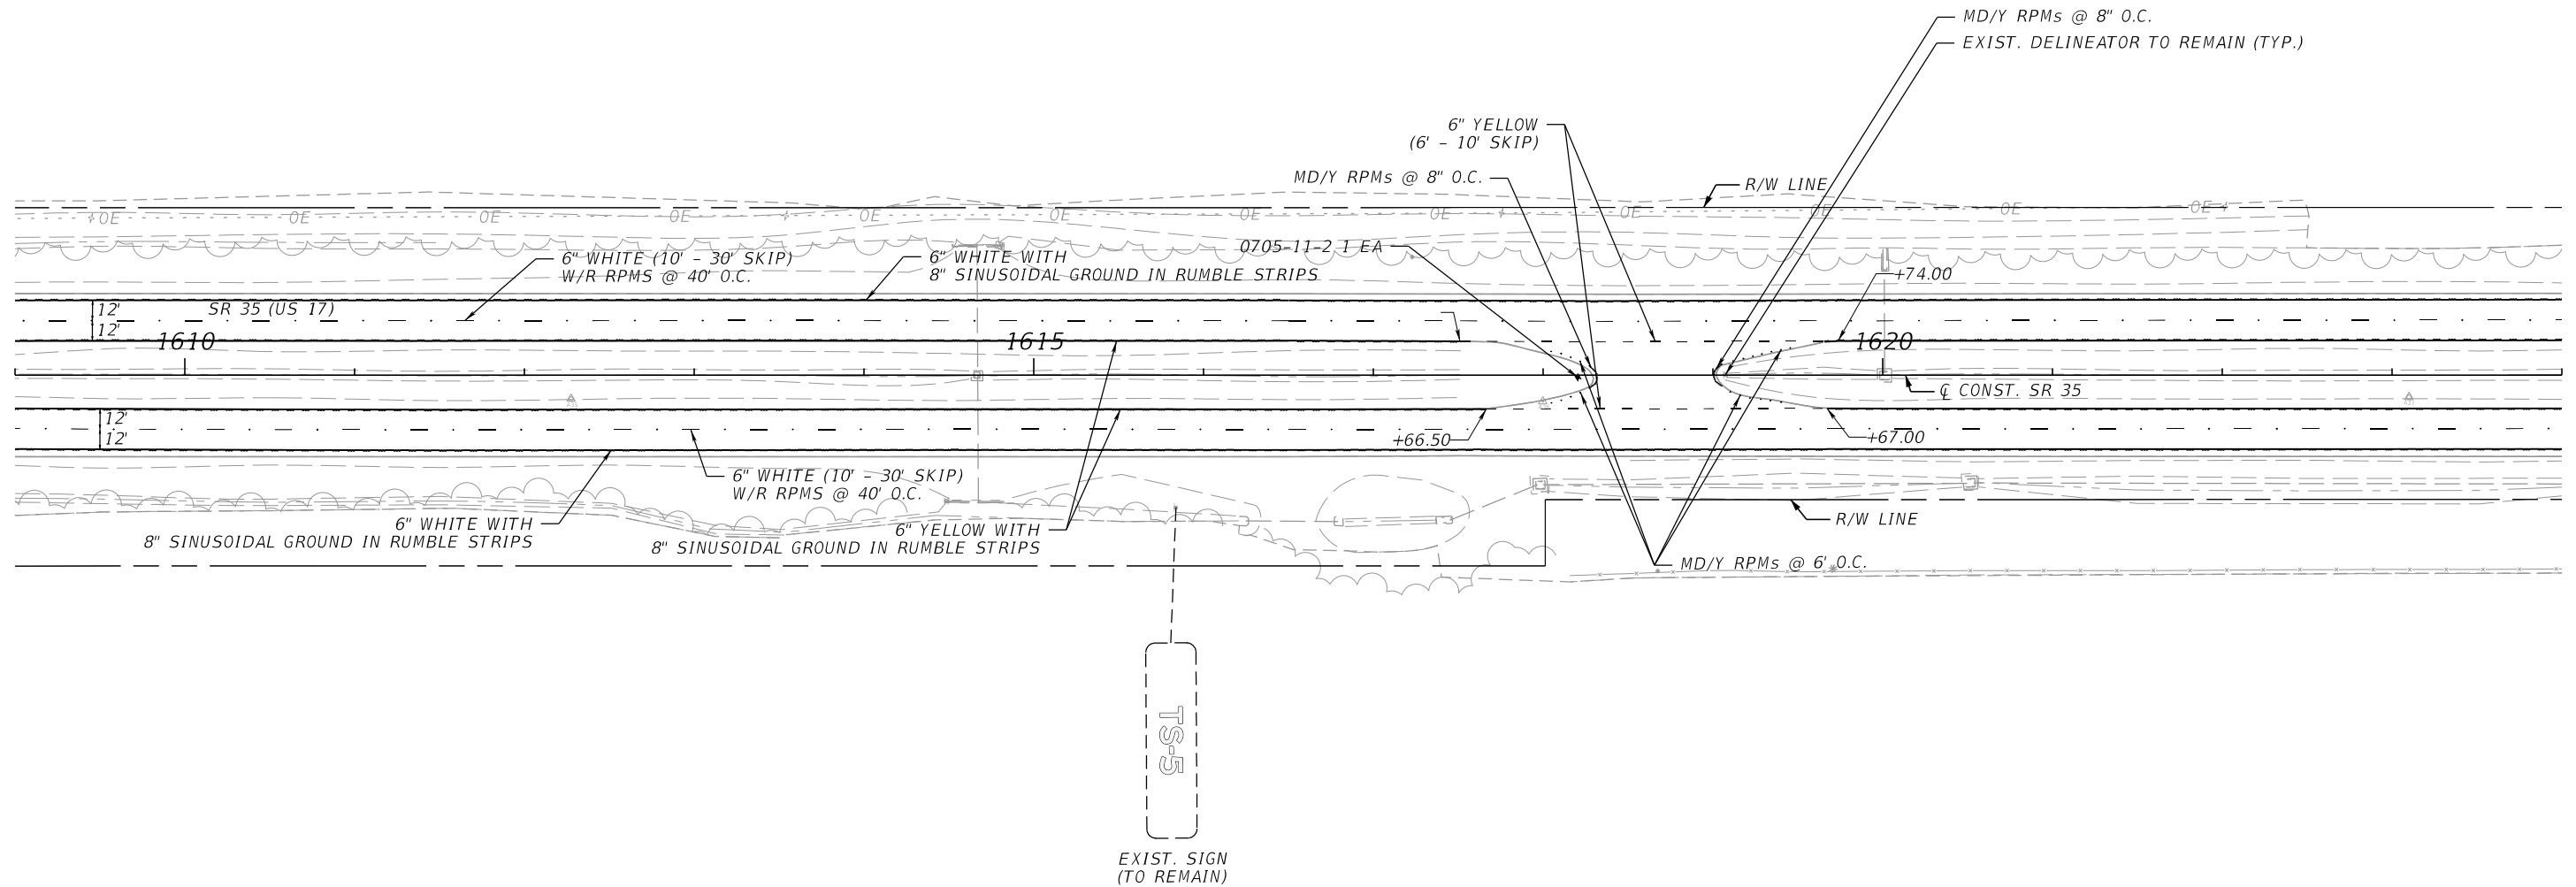

3/18/2024 5:31:46 PM Shuvo S:\2220010500-US17_SR35_3R\44923215201\signing\PLANS\PO1.dgn

THE OFFICIAL RECORD OF THIS SHEET IS THE ELECTRONIC FILE DIGITALLY SIGNED AND SEALED UNDER RULE 61G15-23.004, F.A.C.

REVISIONS				ENGINEER OF RECORD		STATE OF FLORIDA DEPARTMENT OF TRANSPORTATION			SIGNING AND PAVEMENT MARKING PLANS	SHEET NO.
DATE	DESCRIPTION	DATE	DESCRIPTION	MAJHARUL ALAM, P.E. LICENSE NUMBER 61600 PROPEL ENGINEERING, INC. 2711 N VISTA PARKWAY, SUITE B7 WEST PALM BEACH, FL 33411		ROAD NO.	COUNTY	FINANCIAL PROJECT ID		S-14
						SR 35	POLK	449232-1-52-01		

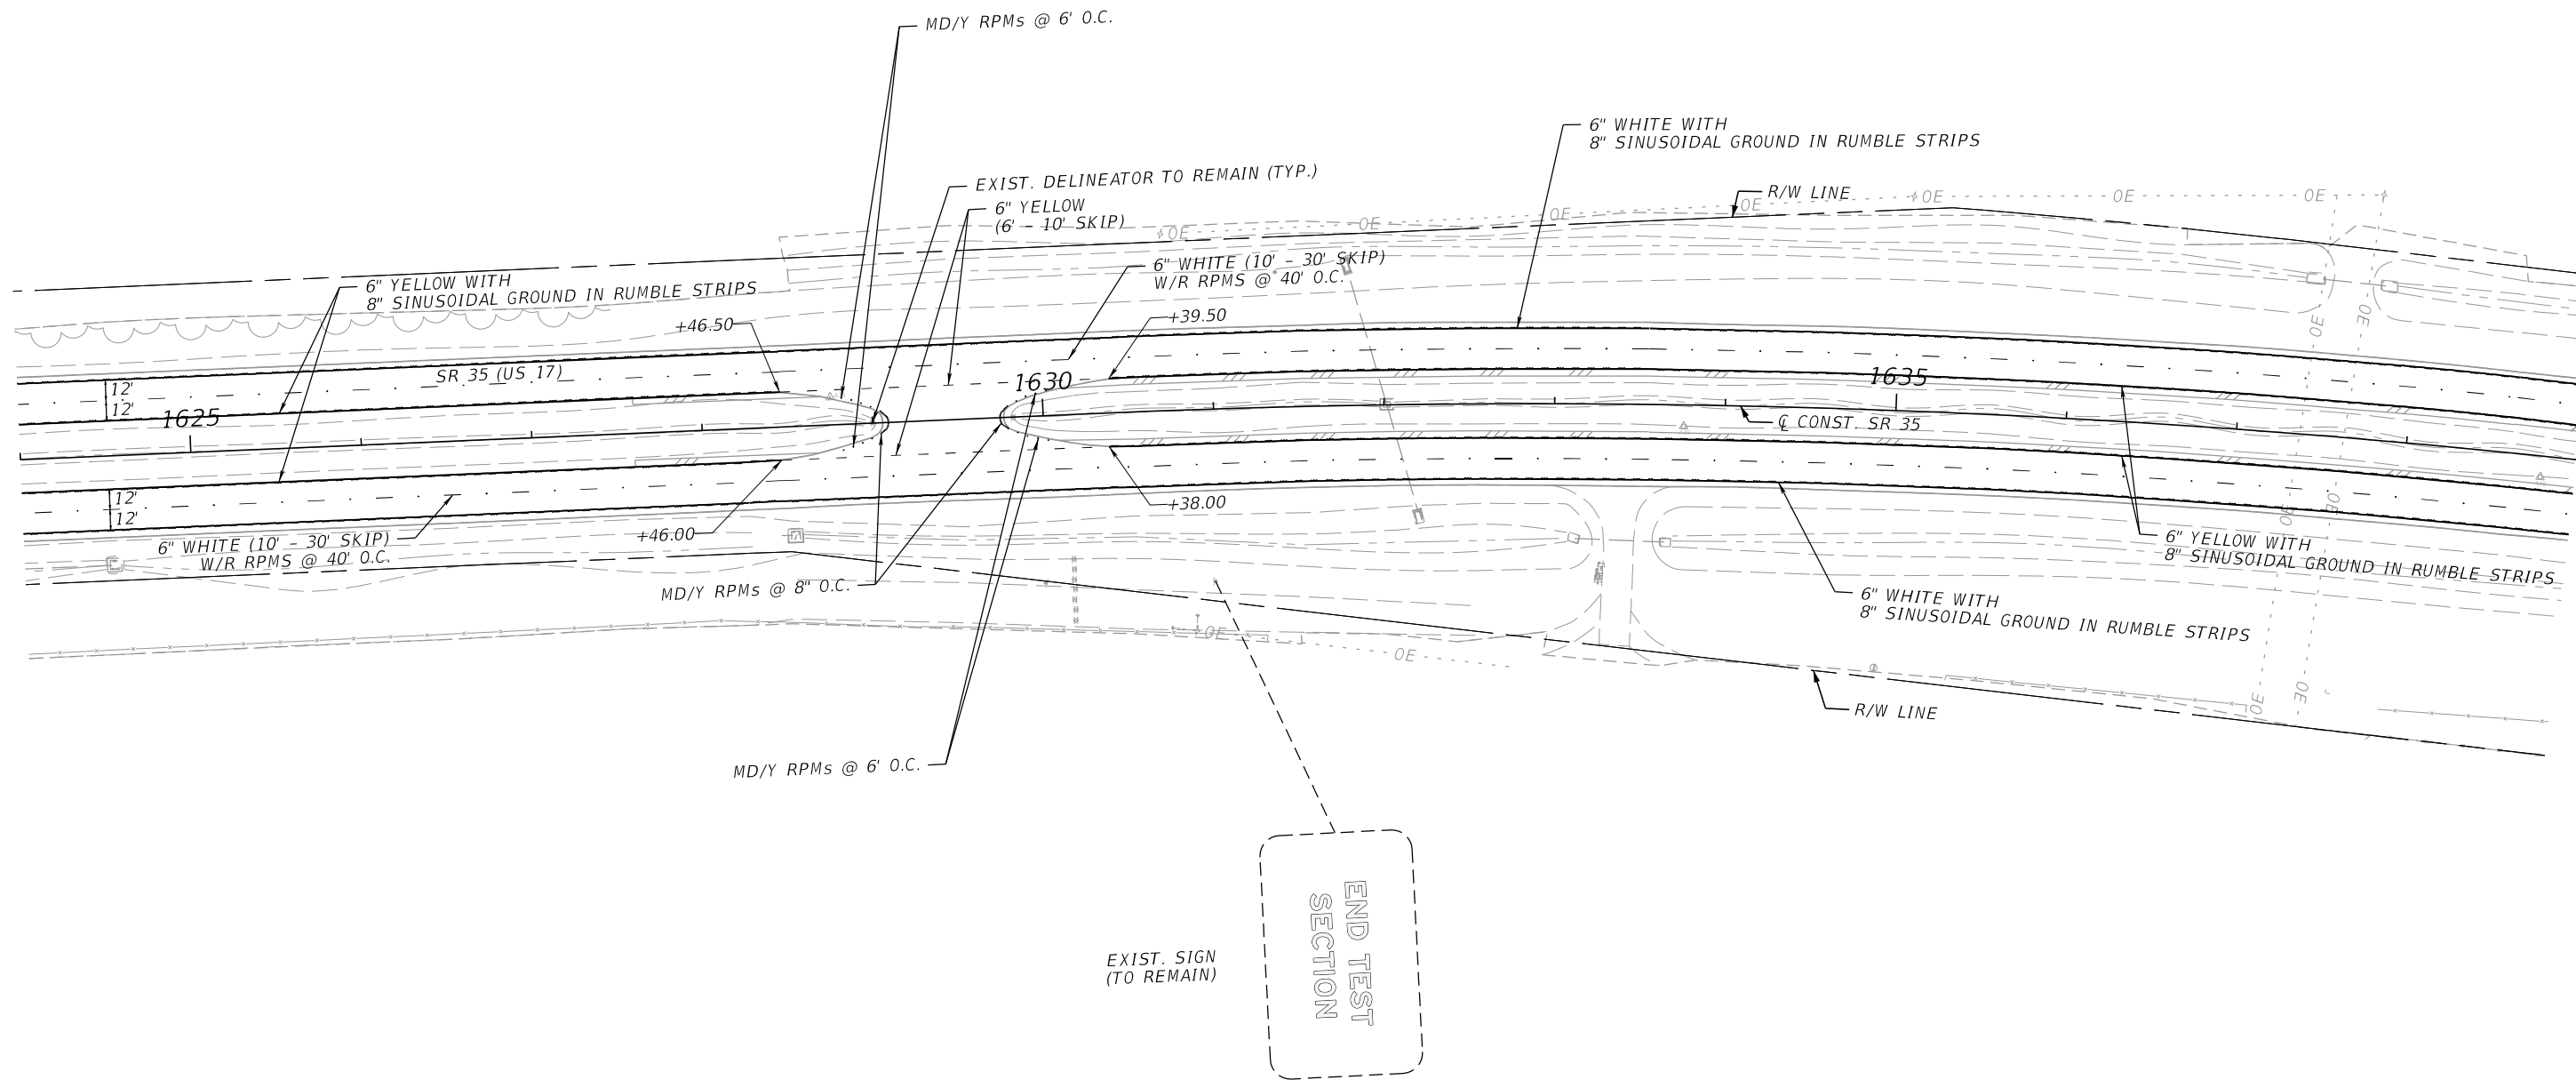


3/18/2024 5:31:47 PM Shuvo S:\2220010500-US17_SR35_3R\44923215201\signing\PLANS\PO1.dgn

THE OFFICIAL RECORD OF THIS SHEET IS THE ELECTRONIC FILE DIGITALLY SIGNED AND SEALED UNDER RULE 61G15-23.004, F.A.C.

REVISIONS				ENGINEER OF RECORD		STATE OF FLORIDA DEPARTMENT OF TRANSPORTATION			SHEET NO.
DATE	DESCRIPTION	DATE	DESCRIPTION			ROAD NO.	COUNTY	FINANCIAL PROJECT ID	
				MAJHARUL ALAM, P.E. LICENSE NUMBER 61600 PROPEL ENGINEERING, INC. 2711 N VISTA PARKWAY, SUITE B7 WEST PALM BEACH, FL 33411		SR 35	POLK	449232-1-52-01	S-15

**SIGNING AND PAVEMENT
MARKING PLANS**

1"=100'

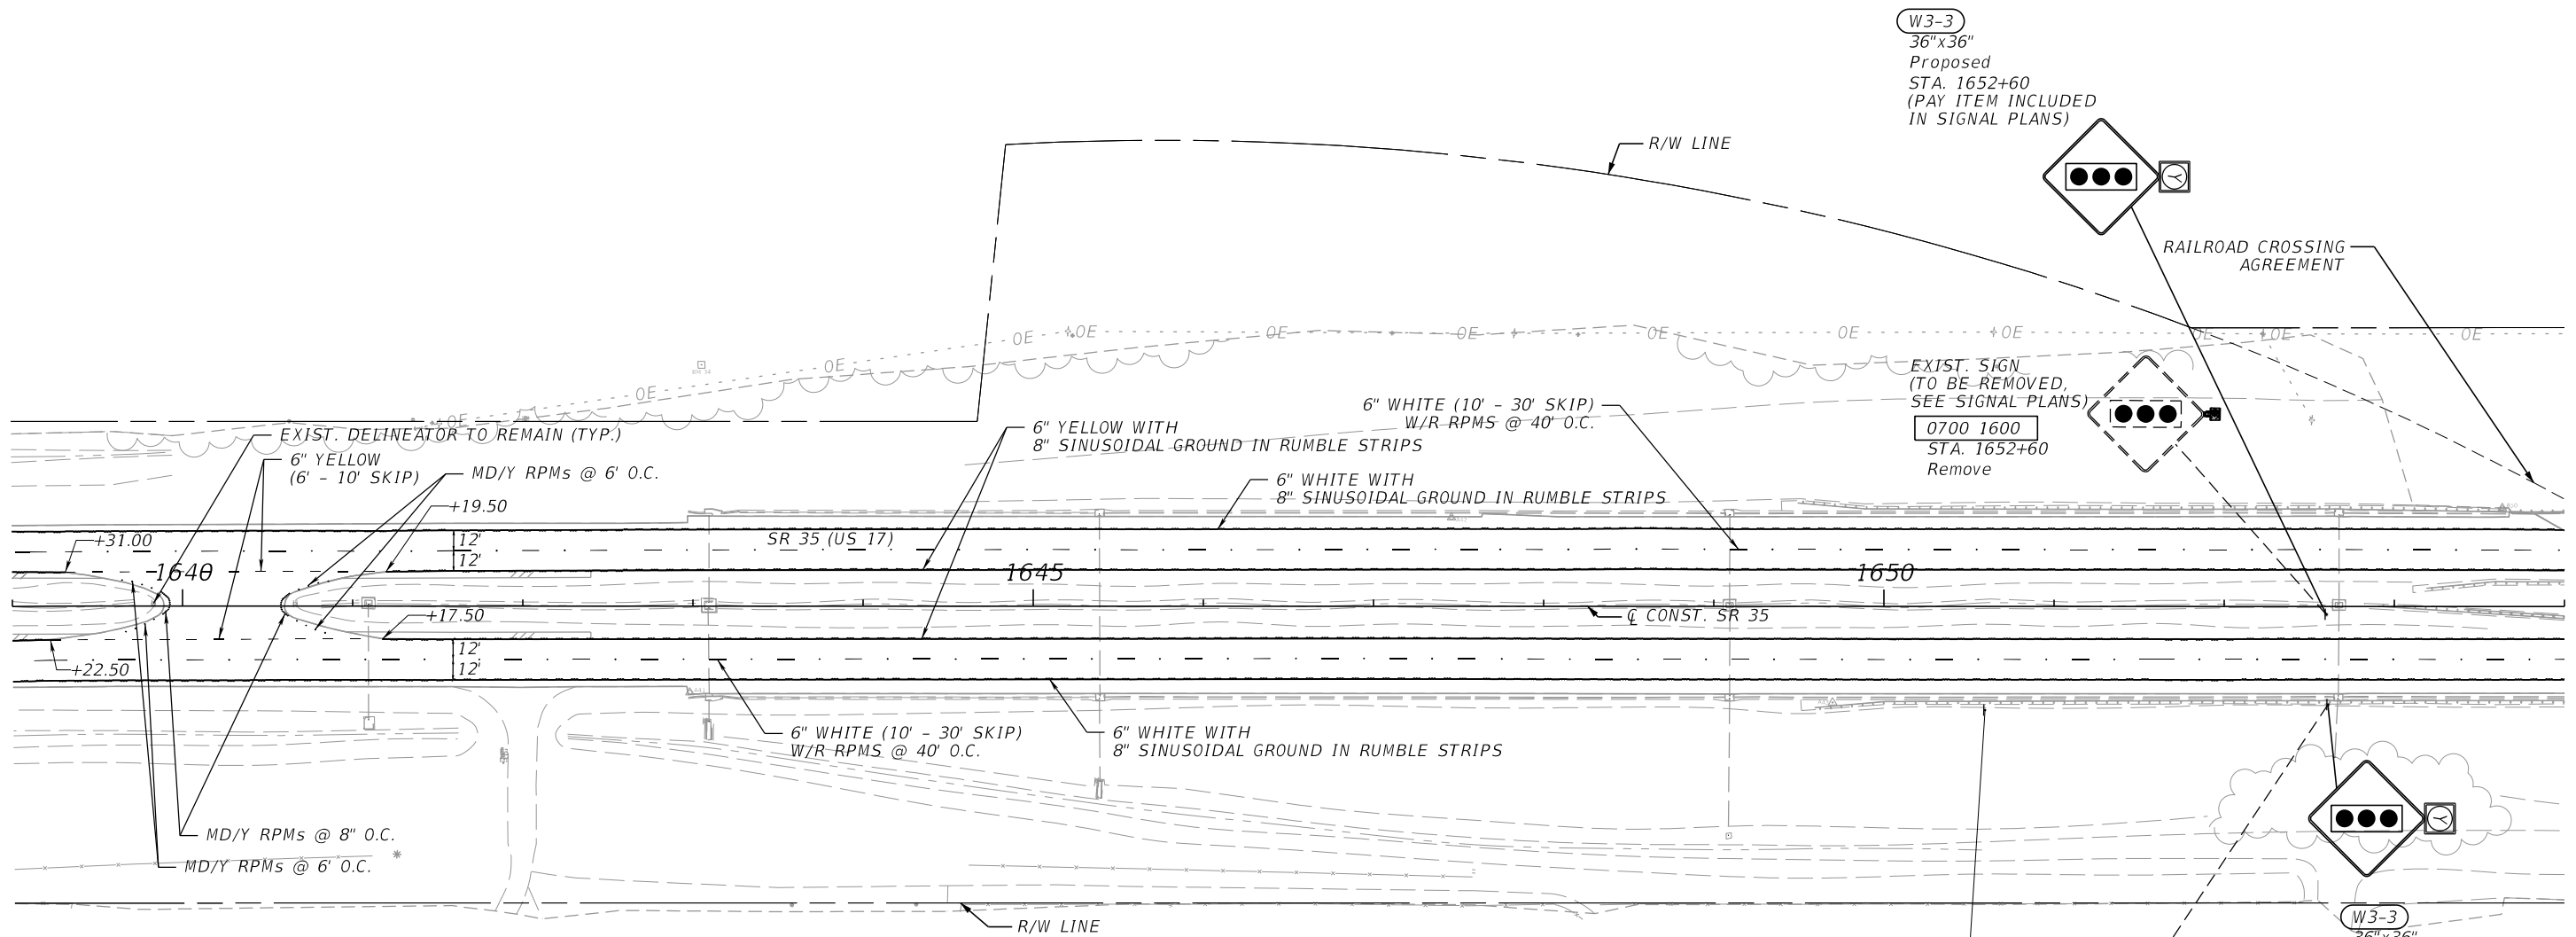

W3-3
36"x36"
Proposed
STA. 1652+60
(PAY ITEM INCLUDED
IN SIGNAL PLANS)

EXIST. SIGN
(TO BE REMOVED,
SEE SIGNAL PLANS)
0700 1600
STA. 1652+60
Remove

W3-3
36"x36"
Proposed
STA. 1652+60
(PAY ITEM INCLUDED
IN SIGNAL PLANS)

EXIST. SIGN
(TO BE REMOVED,
SEE SIGNAL PLANS)

0700 1600
STA. 1652+60
Remove


W8-5
36"x36"
Proposed
0700 1111 1 EA
STA. 1650+60

3/18/2024 5:31:47 PM Shuvo S:\2220010500-US17_S035_3R\44923215201\siging\PLANS\PO1.dgn

THE OFFICIAL RECORD OF THIS SHEET IS THE ELECTRONIC FILE DIGITALLY SIGNED AND SEALED UNDER RULE 61G15-23.004, F.A.C.

REVISIONS				ENGINEER OF RECORD		STATE OF FLORIDA DEPARTMENT OF TRANSPORTATION			SIGNING AND PAVEMENT MARKING PLANS	SHEET NO.
DATE	DESCRIPTION	DATE	DESCRIPTION	MAJHARUL ALAM, P.E. LICENSE NUMBER 61600 PROPEL ENGINEERING, INC. 2711 N VISTA PARKWAY, SUITE B7 WEST PALM BEACH, FL 33411		ROAD NO.	COUNTY	FINANCIAL PROJECT ID		S-16
						SR 35	POLK	449232-1-52-01		



1"=100'

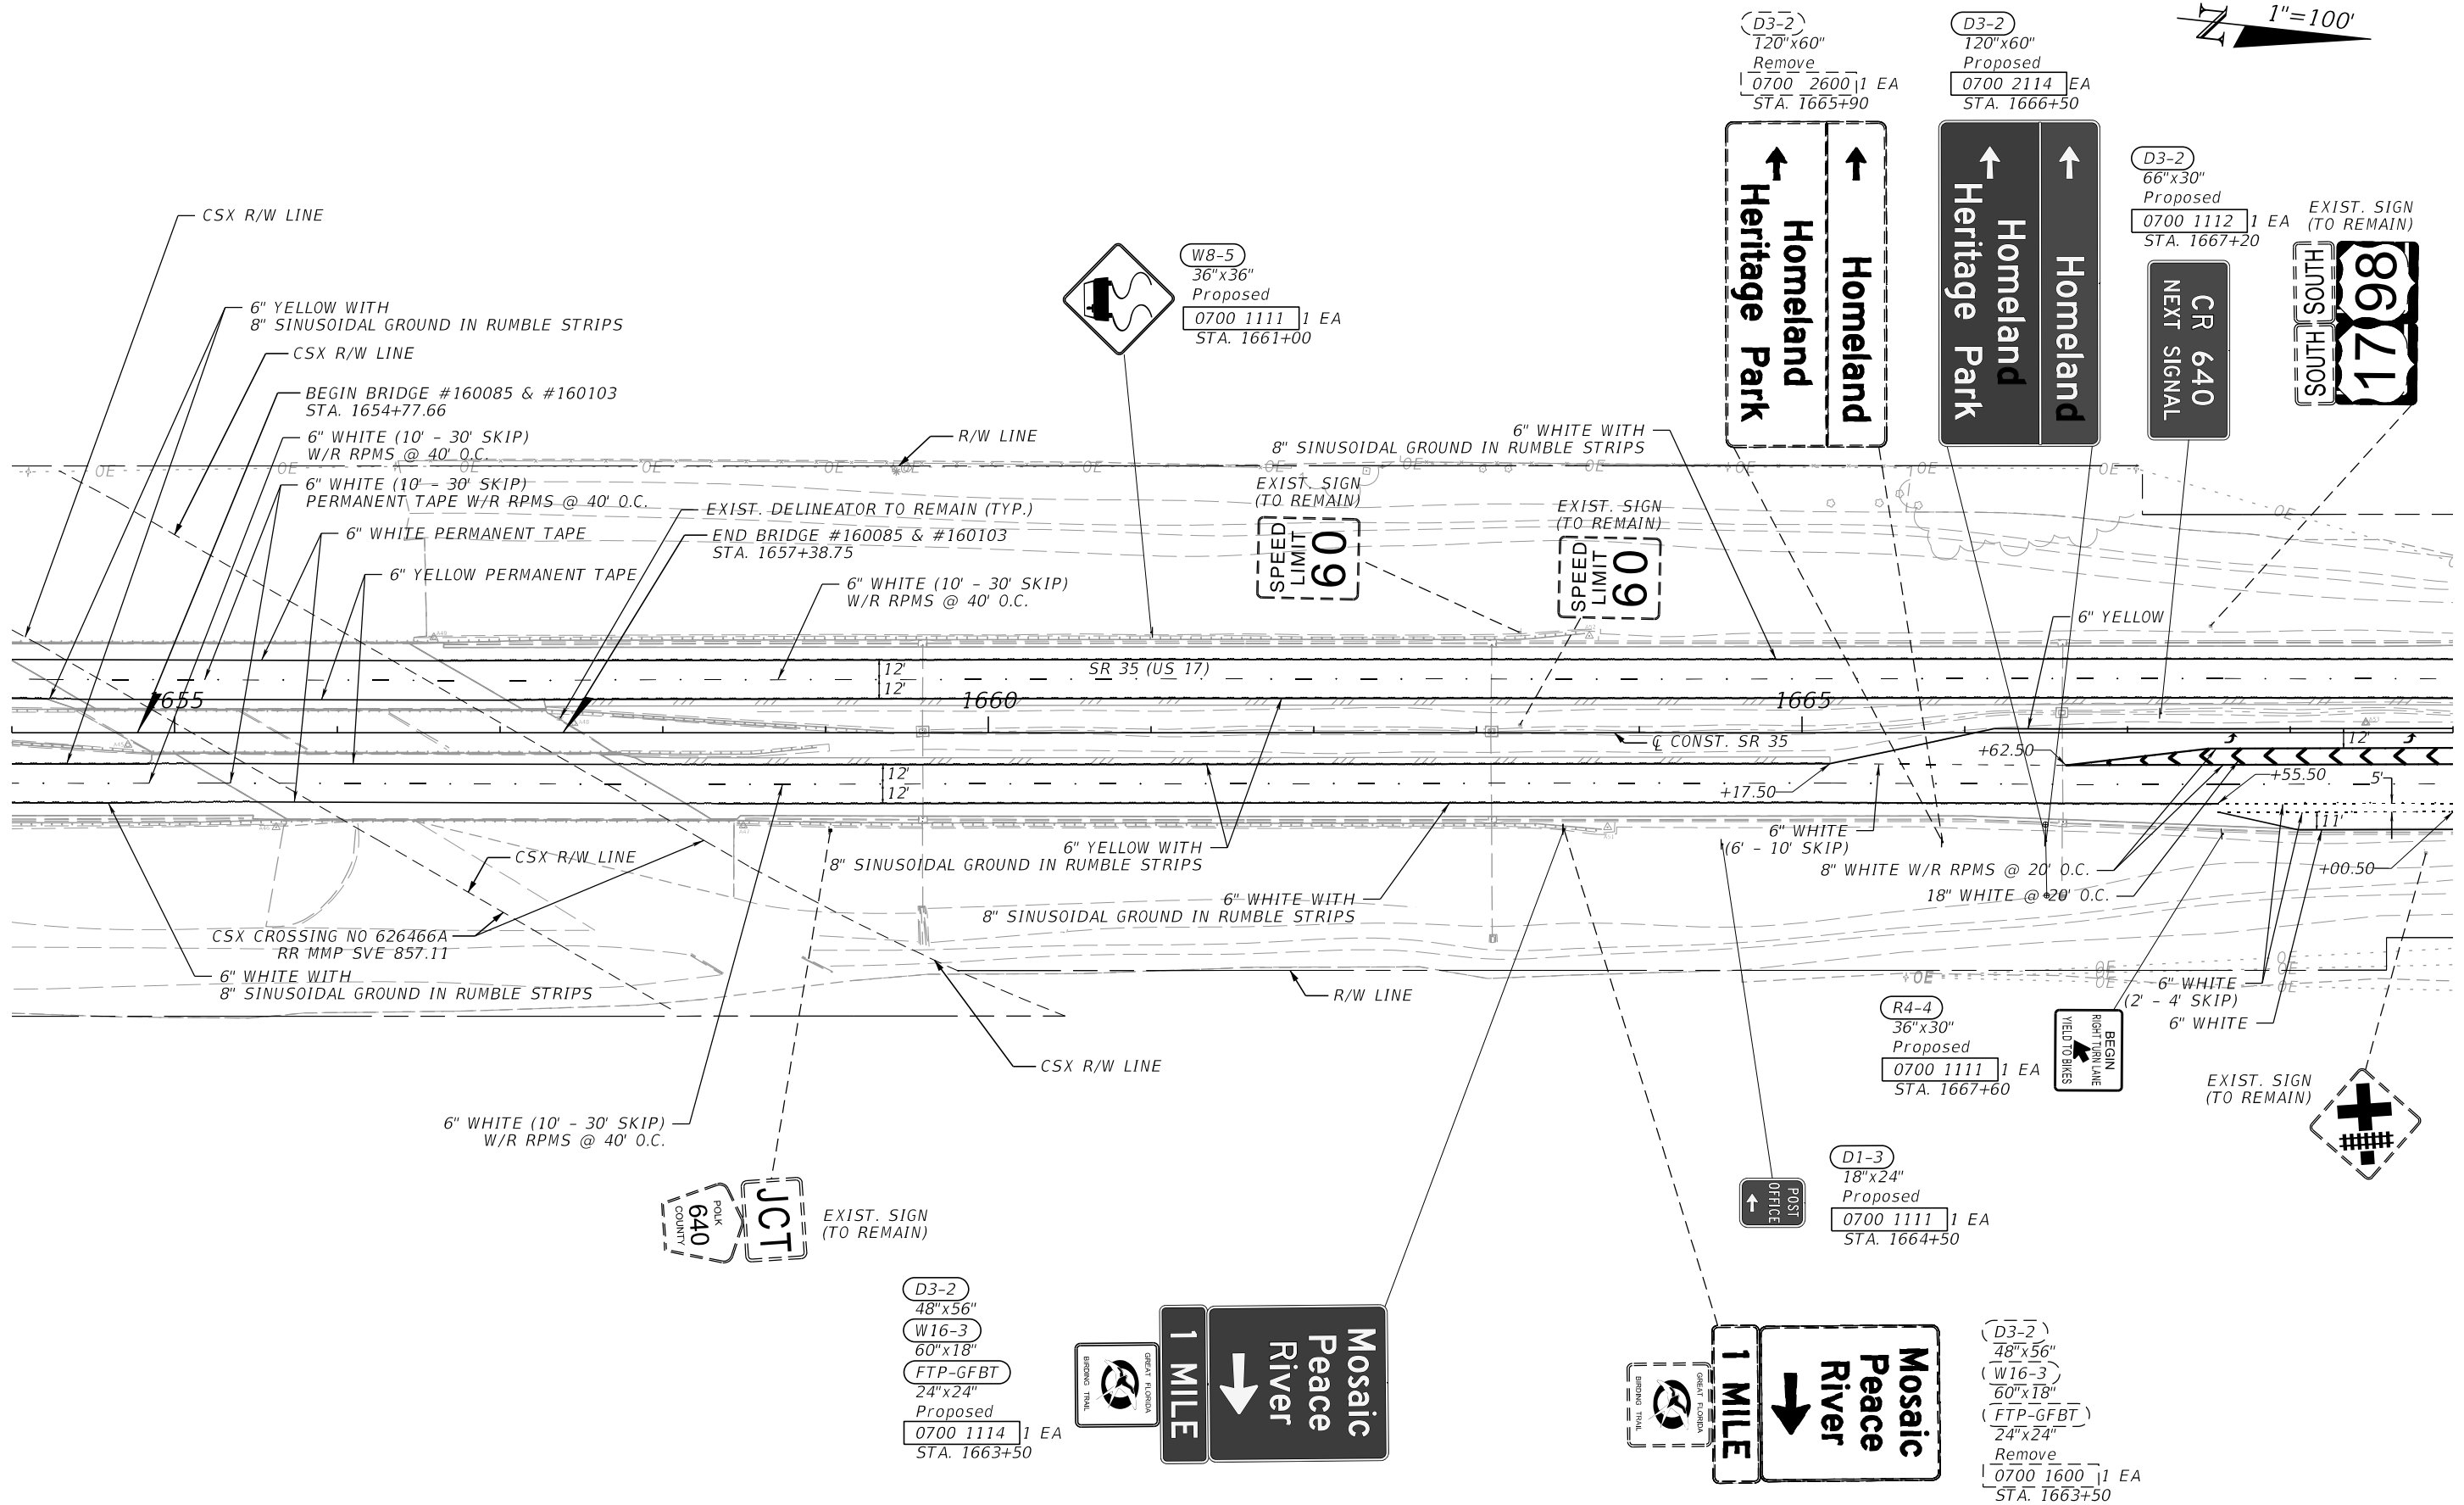

3/18/2024 5:31:48 PM Shuvo S:\2220010500-US17_SR35_BR\44923215201\signing\PLANS\PO1.dgn

THE OFFICIAL RECORD OF THIS SHEET IS THE ELECTRONIC FILE DIGITALLY SIGNED AND SEALED UNDER RULE 61G15-23.004, F.A.C.

REVISIONS		ENGINEER OF RECORD		STATE OF FLORIDA DEPARTMENT OF TRANSPORTATION			SHEET NO.
DATE	DESCRIPTION	DATE	DESCRIPTION	ROAD NO.	COUNTY	FINANCIAL PROJECT ID	
			MAJHARUL ALAM, P.E. LICENSE NUMBER 61600 PROPEL ENGINEERING, INC. 2711 N VISTA PARKWAY, SUITE B7 WEST PALM BEACH, FL 33411	SR 35	POLK	449232-1-52-01	S-17
				SIGNING AND PAVEMENT MARKING PLANS			

 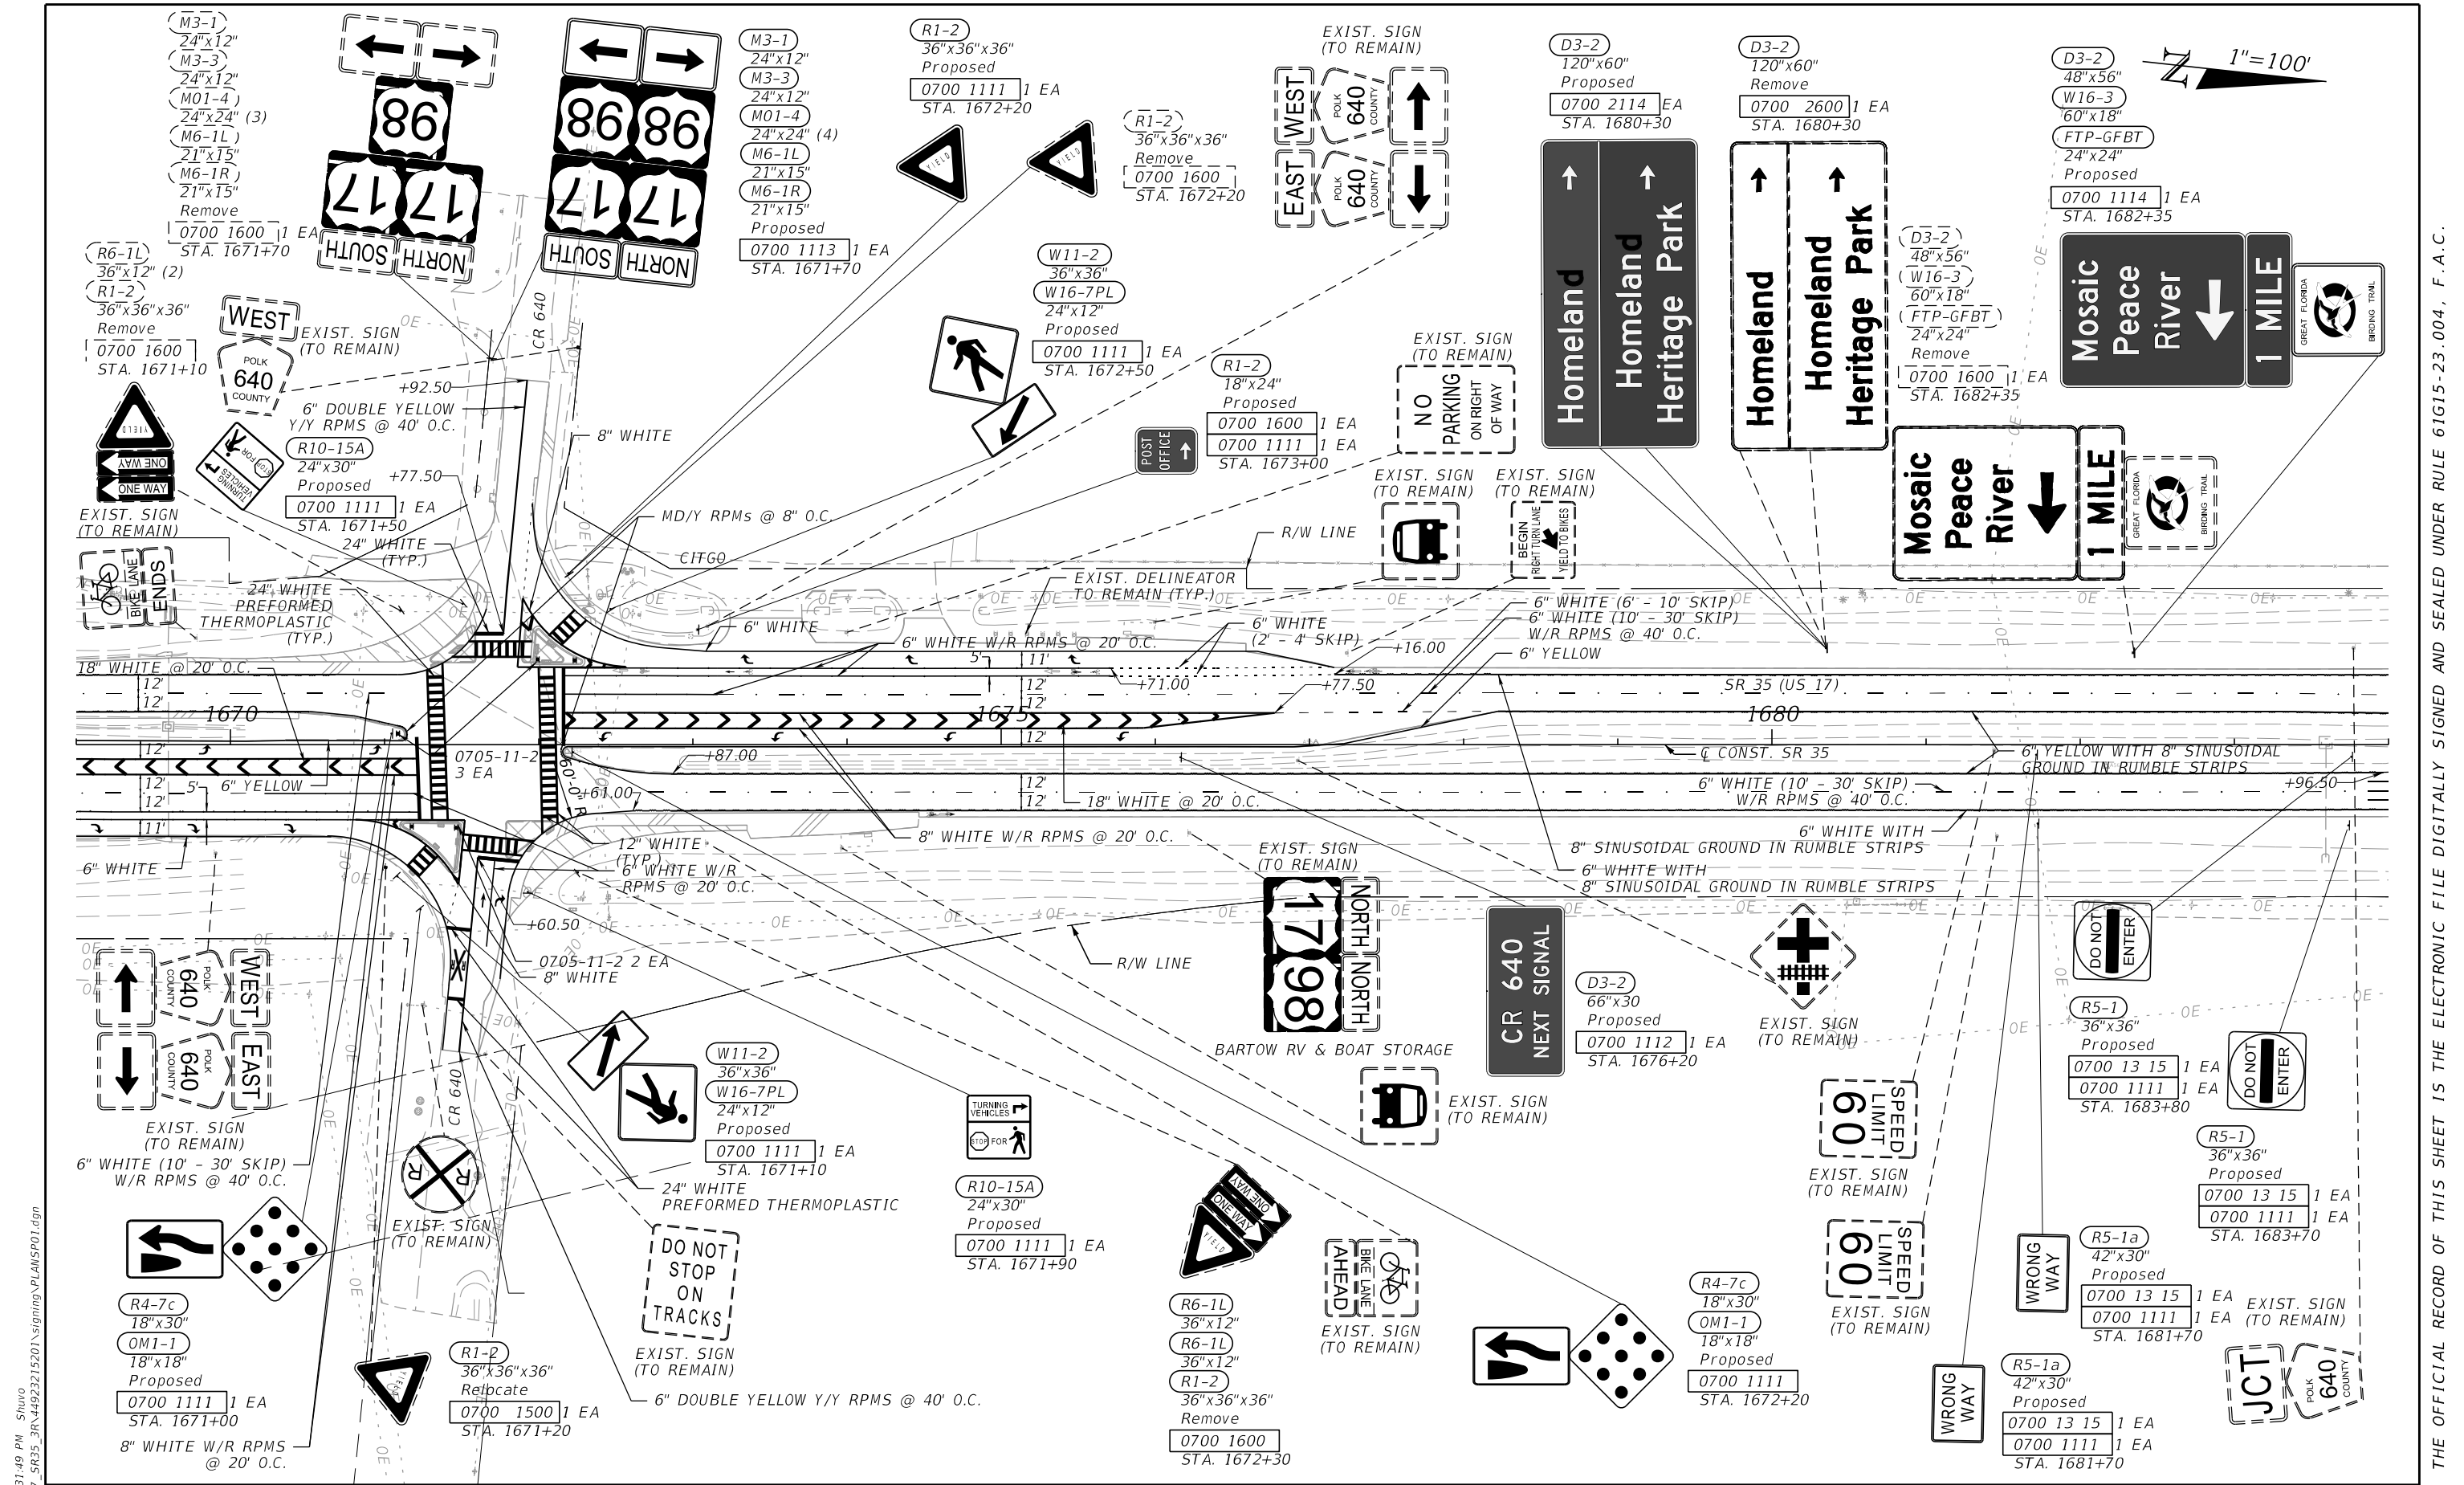


3/18/2024 5:31:49 PM Shuvo S:\2220010500-US17_SR35_3R\44923215201\signing\PLANS\01.dgn

THE OFFICIAL RECORD OF THIS SHEET IS THE ELECTRONIC FILE DIGITALLY SIGNED AND SEALED UNDER RULE 61G15-23.004, F.A.C.

REVISIONS		ENGINEER OF RECORD		STATE OF FLORIDA DEPARTMENT OF TRANSPORTATION			SHEET NO.
DATE	DESCRIPTION	DATE	DESCRIPTION	ROAD NO.	COUNTY	FINANCIAL PROJECT ID	
			MAJHARUL ALAM, P.E. LICENSE NUMBER 61600 PROPEL ENGINEERING, INC. 2711 N VISTA PARKWAY, SUITE B7 WEST PALM BEACH, FL 33411	SR 35	POLK	449232-1-52-01	S-18
				SIGNING AND PAVEMENT MARKING PLANS			

1"=100'

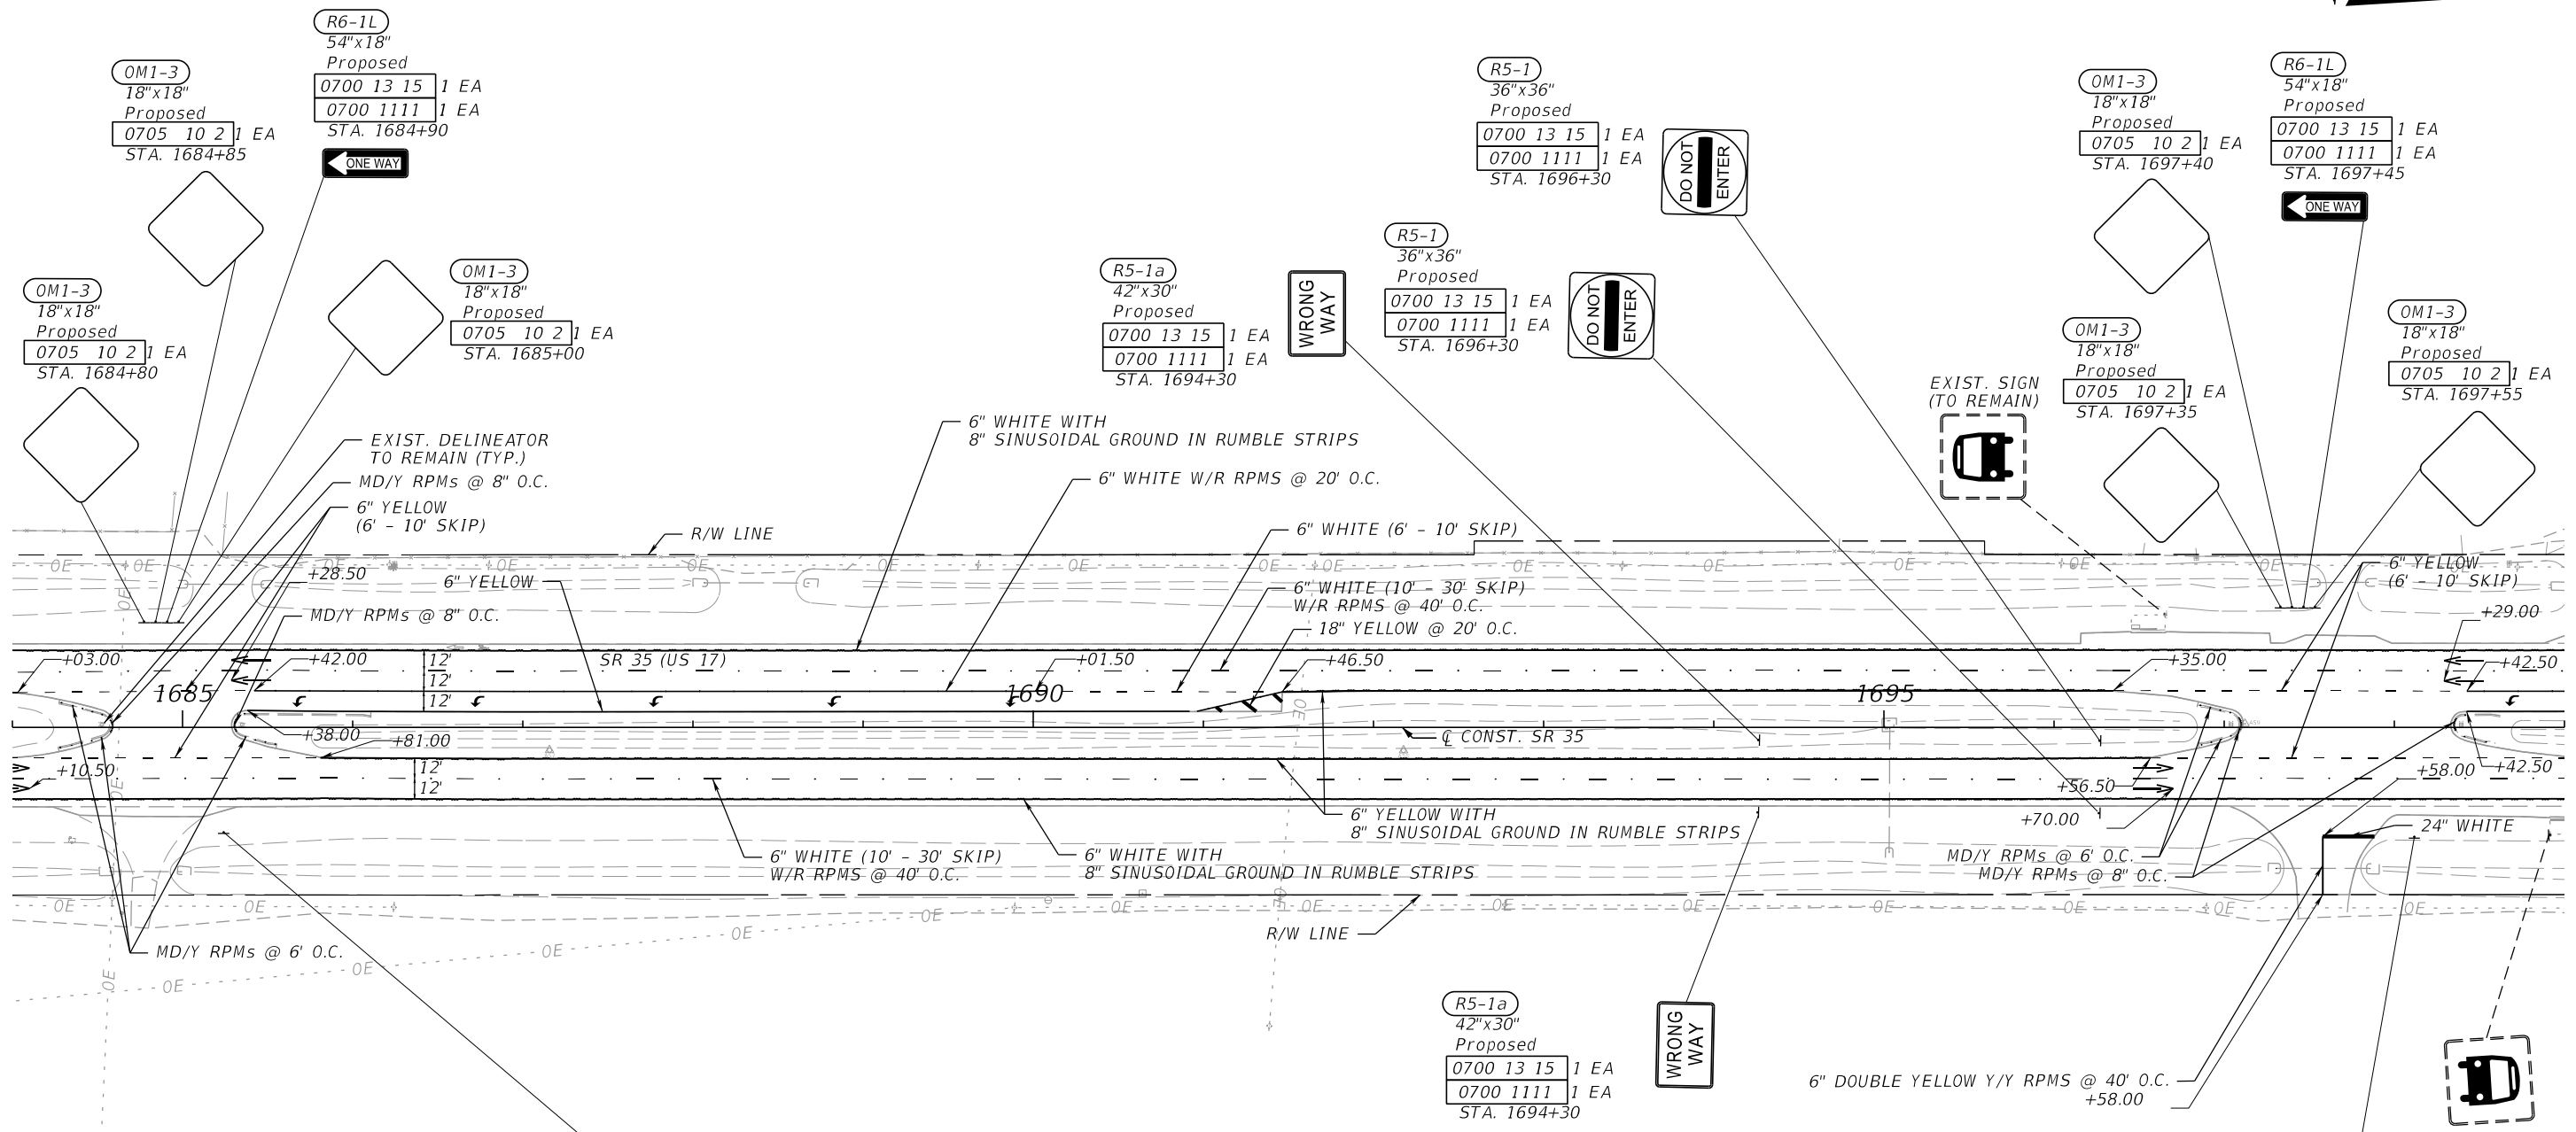

R6-1R
54"x18"
Proposed
0700 13 15 1 EA
0700 1113 1 EA
STA. 1685+20

R5-1a
42"x30"
Proposed
0700 13 15 1 EA
0700 1111 1 EA
STA. 1694+30

R6-1R
54"x18"
Proposed
R1-1
36"x36"
Proposed
R6-3a
30"x24"
Proposed
0700 13 15 1 EA
0700 1113 1 EA
STA. 1698+10




3/18/2024 5:31:50 PM Shuvo S:\2220010500-US17_SR35_3R\44923215201\signing\PLANS\PO1.dgn

THE OFFICIAL RECORD OF THIS SHEET IS THE ELECTRONIC FILE DIGITALLY SIGNED AND SEALED UNDER RULE 61G15-23.004, F.A.C.

REVISIONS		ENGINEER OF RECORD		STATE OF FLORIDA DEPARTMENT OF TRANSPORTATION			SHEET NO.
DATE	DESCRIPTION	DATE	DESCRIPTION	ROAD NO.	COUNTY	FINANCIAL PROJECT ID	
			MAJHARUL ALAM, P.E. LICENSE NUMBER 61600 PROPEL ENGINEERING, INC. 2711 N VISTA PARKWAY, SUITE B7 WEST PALM BEACH, FL 33411	SR 35	POLK	449232-1-52-01	S-19


**SIGNING AND PAVEMENT
MARKING PLANS**

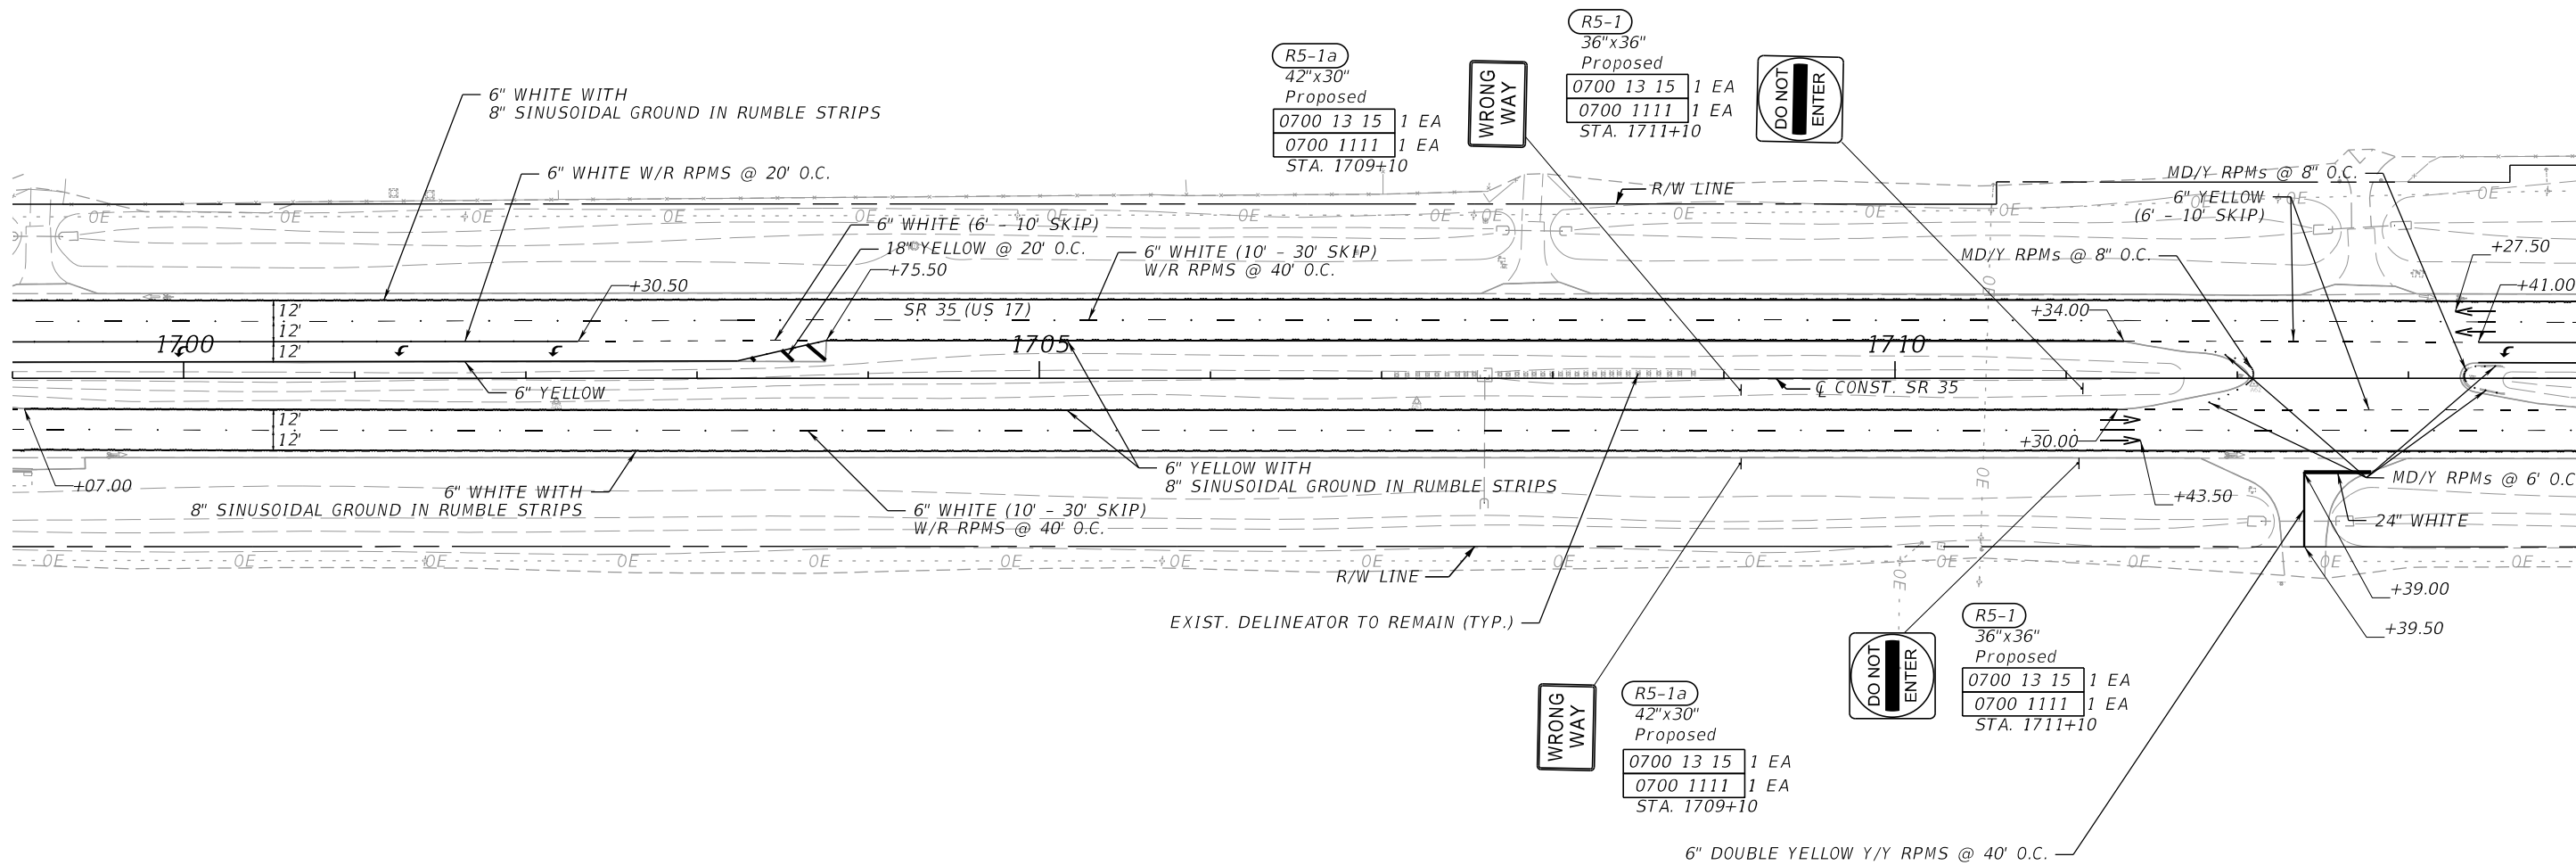

3/18/2024 5:31:51 PM Shuvo S:\2220010500-US17_SR35_BR\44923215201\signing\PLANS\PO1.dgn

THE OFFICIAL RECORD OF THIS SHEET IS THE ELECTRONIC FILE DIGITALLY SIGNED AND SEALED UNDER RULE 61G15-23.004, F.A.C.

REVISIONS				ENGINEER OF RECORD		STATE OF FLORIDA DEPARTMENT OF TRANSPORTATION			SIGNING AND PAVEMENT MARKING PLANS	SHEET NO.
DATE	DESCRIPTION	DATE	DESCRIPTION	MAJHARUL ALAM, P.E. LICENSE NUMBER 61600 PROPEL ENGINEERING, INC. 2711 N VISTA PARKWAY, SUITE B7 WEST PALM BEACH, FL 33411		ROAD NO.	COUNTY	FINANCIAL PROJECT ID		
						SR 35	POLK	449232-1-52-01		S-20

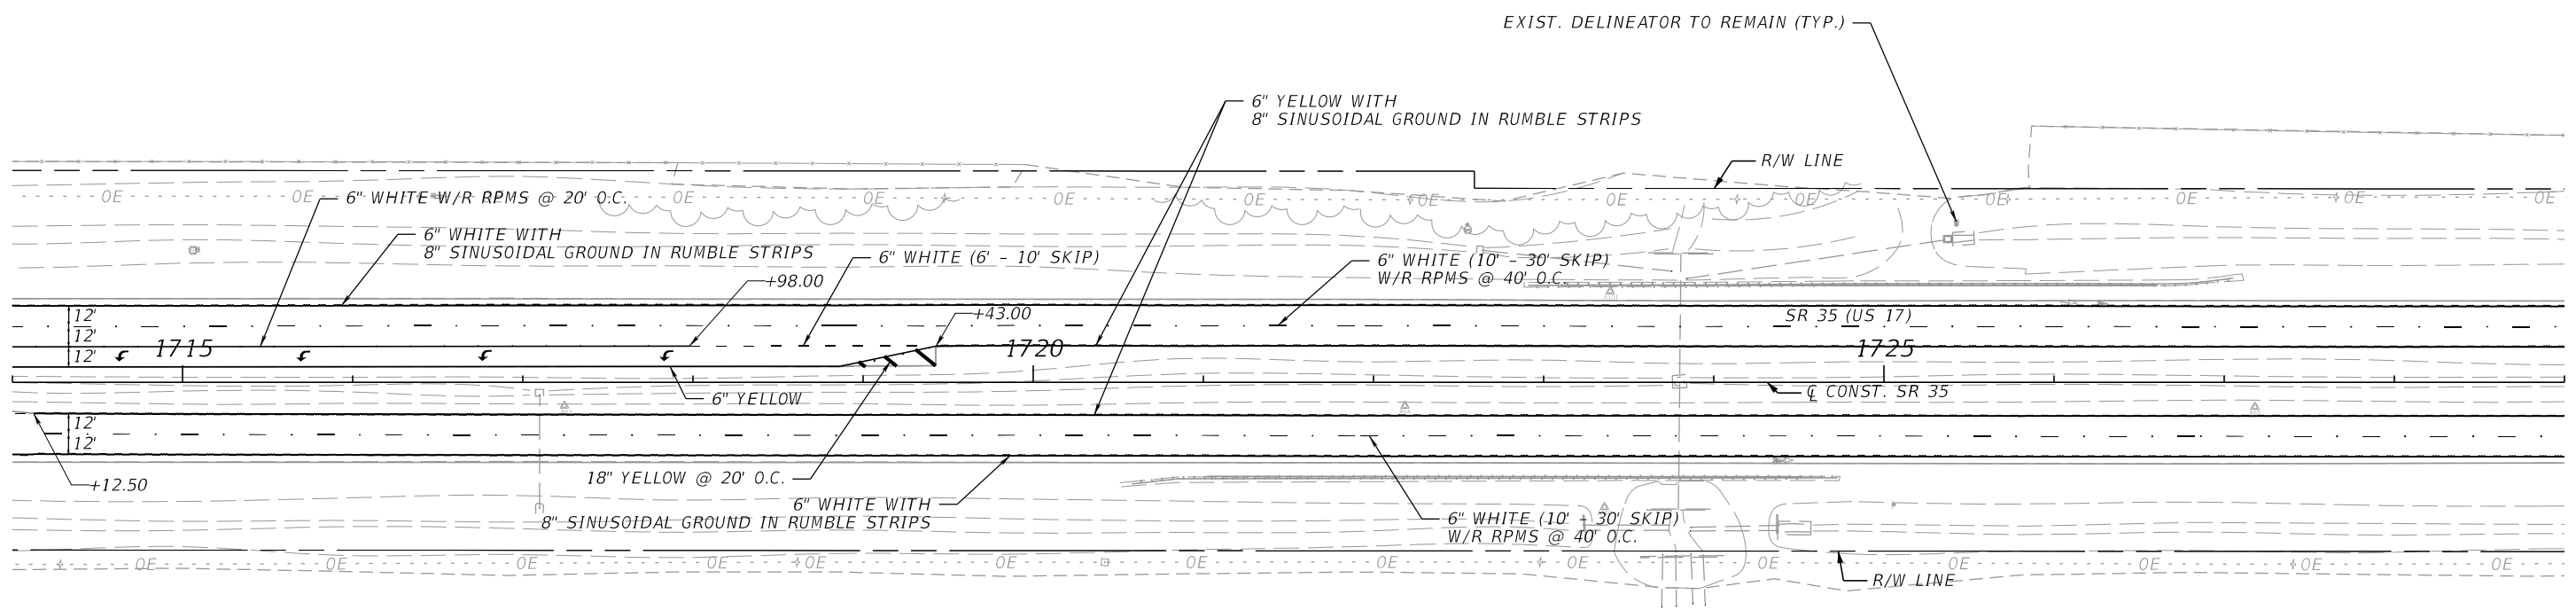


3/18/2024 5:31:51 PM Shuvo S:\2220010500-US17_SR35_3R\44923215201\signing\PLANS\PO1.dgn

THE OFFICIAL RECORD OF THIS SHEET IS THE ELECTRONIC FILE DIGITALLY SIGNED AND SEALED UNDER RULE 61G15-23.004, F.A.C.

REVISIONS				ENGINEER OF RECORD		STATE OF FLORIDA DEPARTMENT OF TRANSPORTATION			SIGNING AND PAVEMENT MARKING PLANS	SHEET NO.
DATE	DESCRIPTION	DATE	DESCRIPTION	MAJHARUL ALAM, P.E. LICENSE NUMBER 61600 PROPEL ENGINEERING, INC. 2711 N VISTA PARKWAY, SUITE B7 WEST PALM BEACH, FL 33411		ROAD NO.	COUNTY	FINANCIAL PROJECT ID		S-21
						SR 35	POLK	449232-1-52-01		


1"=100'

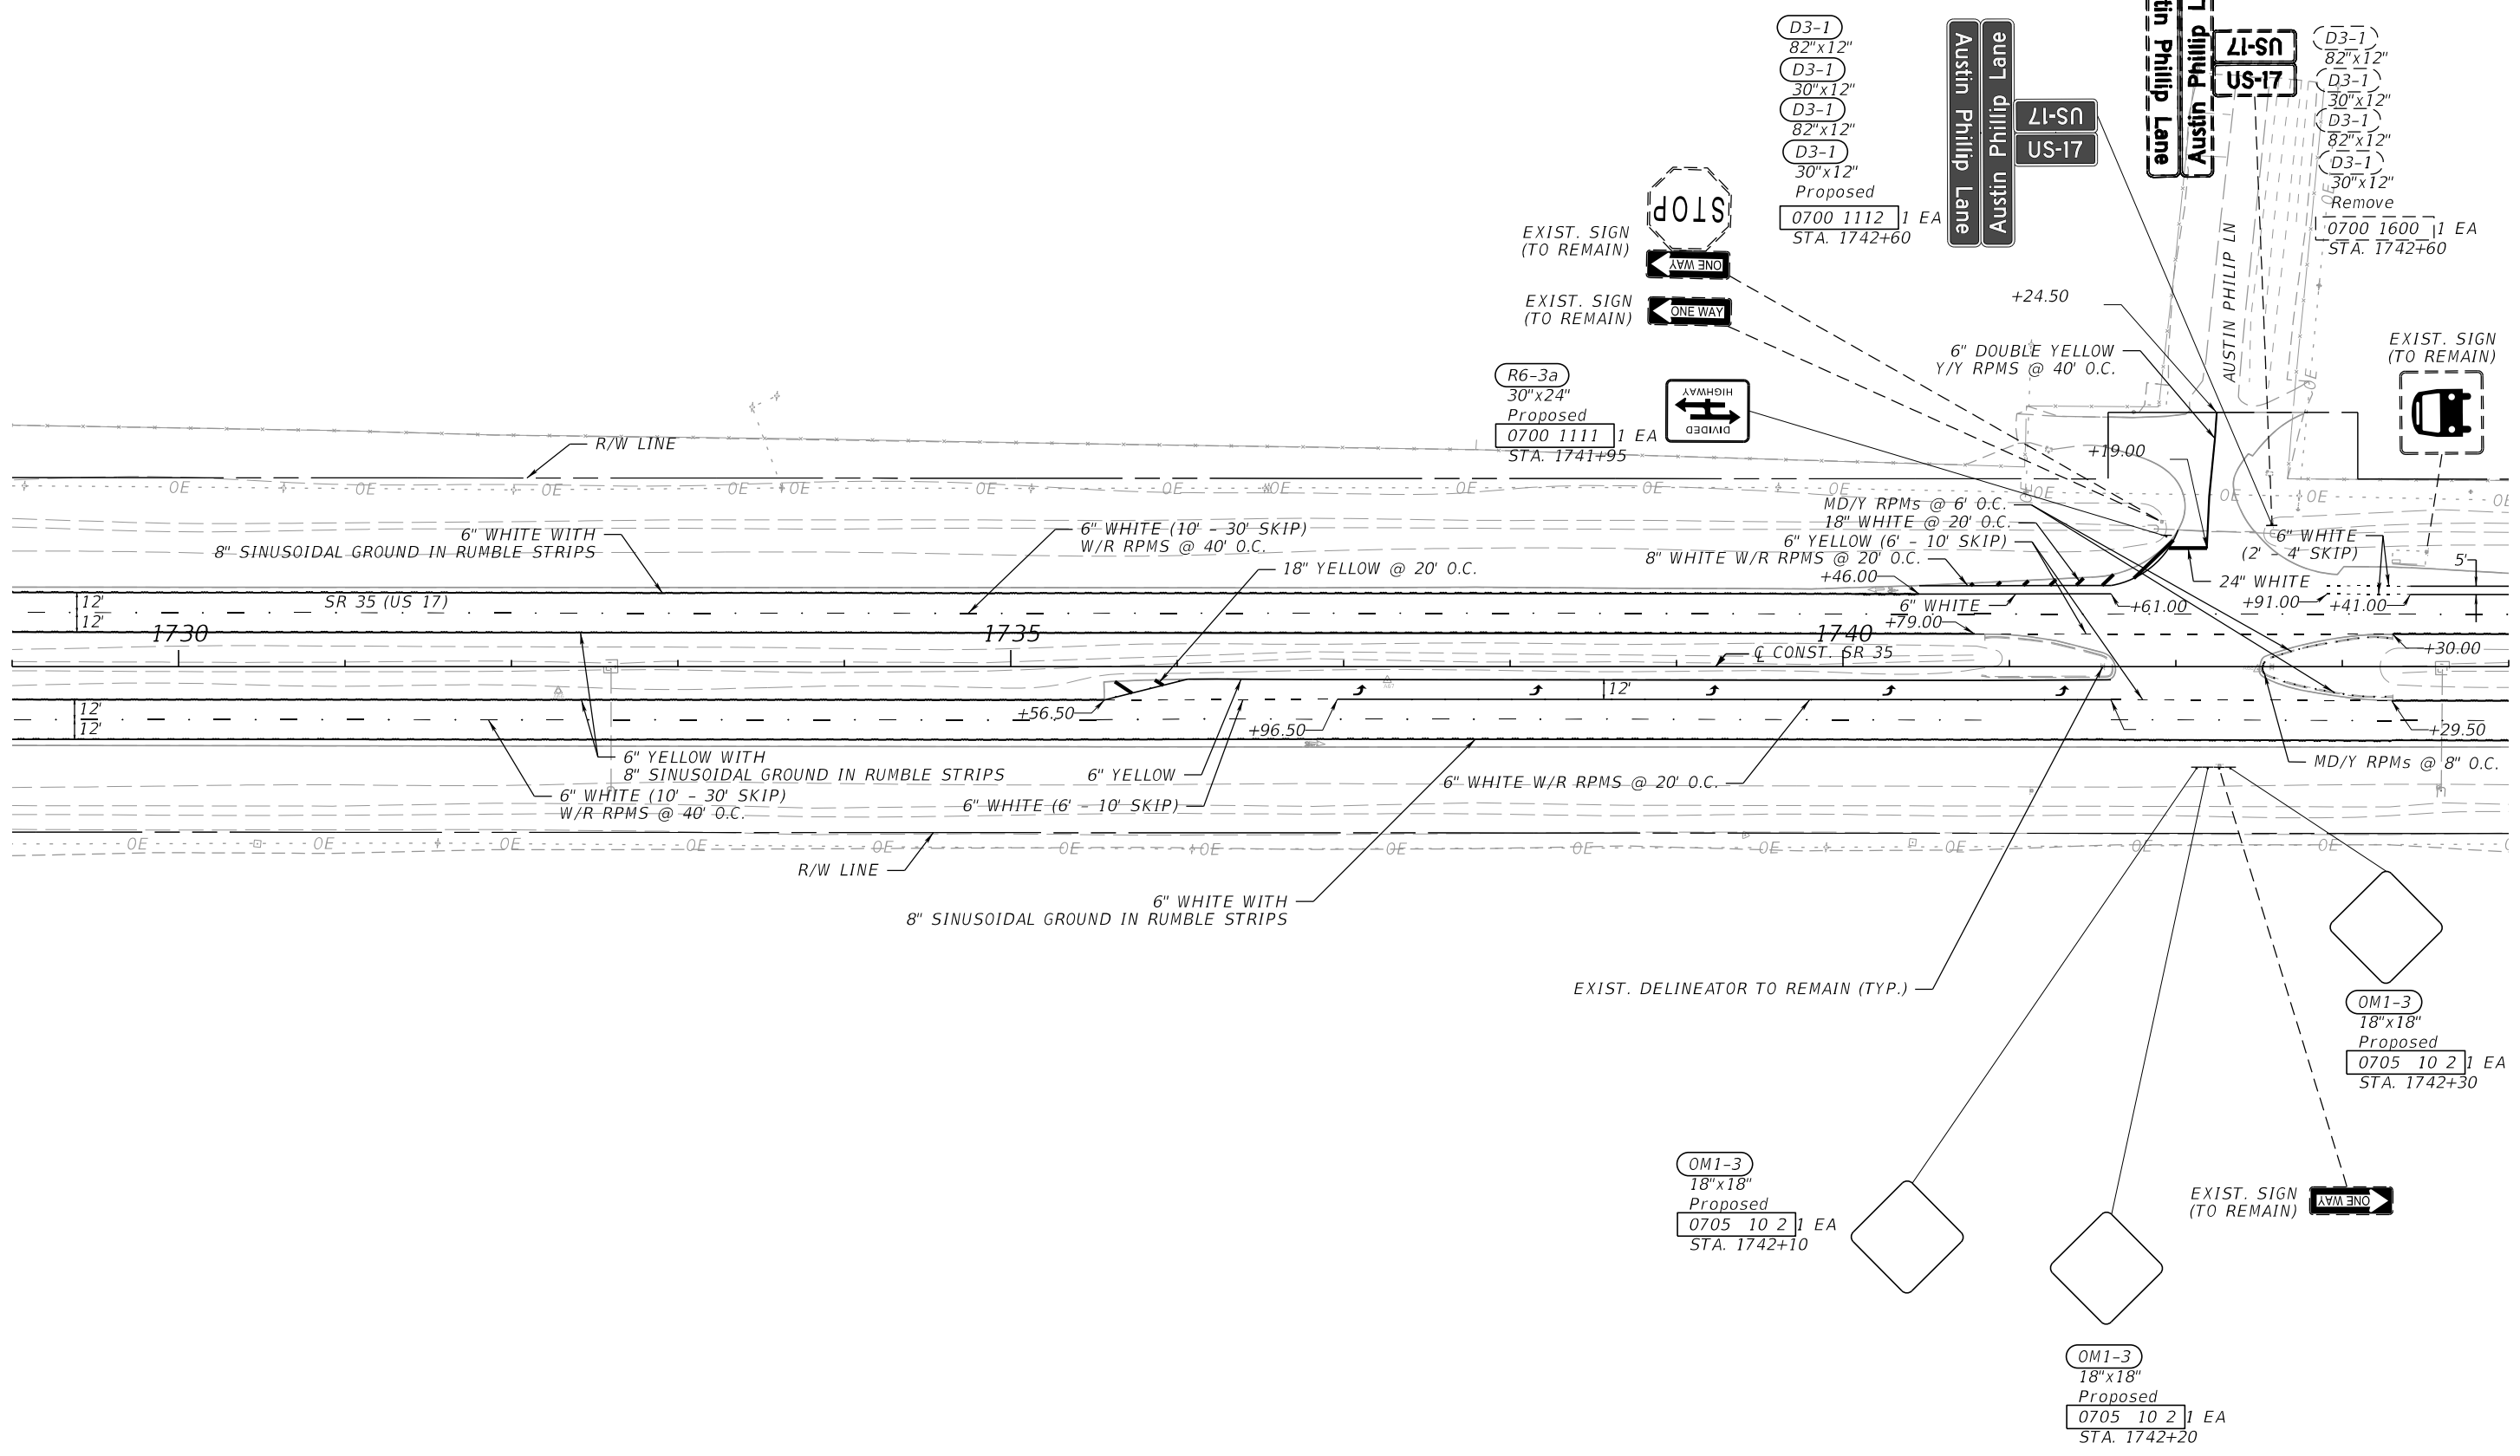

3/18/2024 5:31:52 PM Shuvo S:\2220010500-US17_S35_3R\44923215201\siging\PLANS\PO1.dgn

THE OFFICIAL RECORD OF THIS SHEET IS THE ELECTRONIC FILE DIGITALLY SIGNED AND SEALED UNDER RULE 61G15-23.004, F.A.C.

REVISIONS				ENGINEER OF RECORD		STATE OF FLORIDA DEPARTMENT OF TRANSPORTATION			SIGNING AND PAVEMENT MARKING PLANS	SHEET NO. S-22
DATE	DESCRIPTION	DATE	DESCRIPTION			ROAD NO.	COUNTY	FINANCIAL PROJECT ID		
				MAJHARUL ALAM, P.E. LICENSE NUMBER 61600 PROPEL ENGINEERING, INC. 2711 N VISTA PARKWAY, SUITE B7 WEST PALM BEACH, FL 33411		SR 35	POLK	449232-1-52-01		

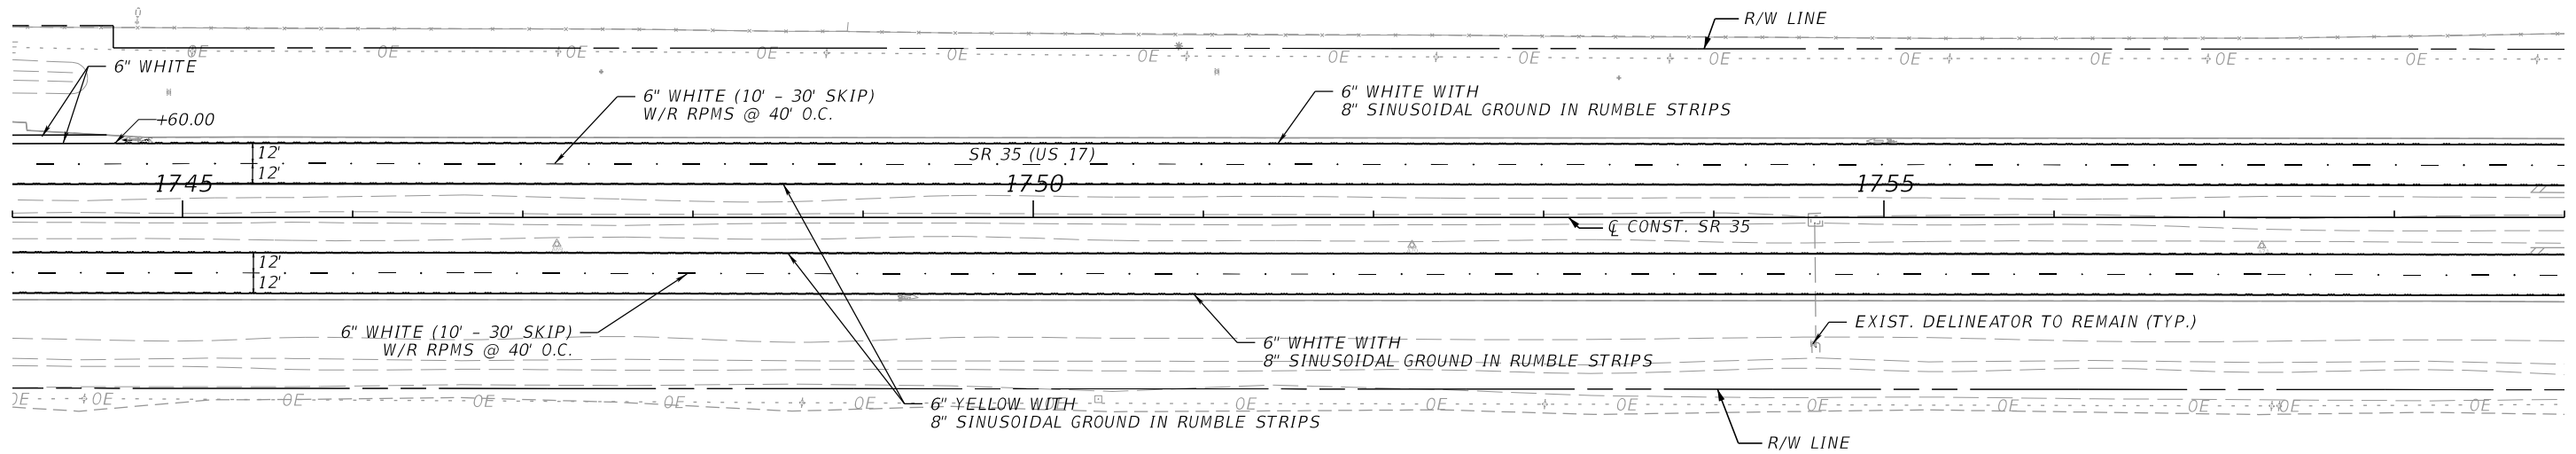

3/18/2024 5:31:52 PM Shuvo S:\2220010500-US17_SR35_3R\44923215201\signing\PLANS\PO1.dgn

THE OFFICIAL RECORD OF THIS SHEET IS THE ELECTRONIC FILE DIGITALLY SIGNED AND SEALED UNDER RULE 61G15-23.004, F.A.C.

REVISIONS				ENGINEER OF RECORD		STATE OF FLORIDA DEPARTMENT OF TRANSPORTATION			SIGNING AND PAVEMENT MARKING PLANS	SHEET NO.
DATE	DESCRIPTION	DATE	DESCRIPTION	MAJHARUL ALAM, P.E. LICENSE NUMBER 61600 PROPEL ENGINEERING, INC. 2711 N VISTA PARKWAY, SUITE B7 WEST PALM BEACH, FL 33411		ROAD NO.	COUNTY	FINANCIAL PROJECT ID		S-23
						SR 35	POLK	449232-1-52-01		

1"=100'

- R6-1R
54"x18"
- R1-1
36"x36"
- R6-3a
30"x24"
- Proposed
- 0700 13 15 1 EA
- 0700 1113 1 EA
- STA. 1768+50




 
 
 
 
 
 
 
 
 
 
 
 
 
 
 
 
 
 
METROMONT CORPORATION



0700 1600
STA. 1768+60
Remove



0700 1600
STA. 1768+60
Remove

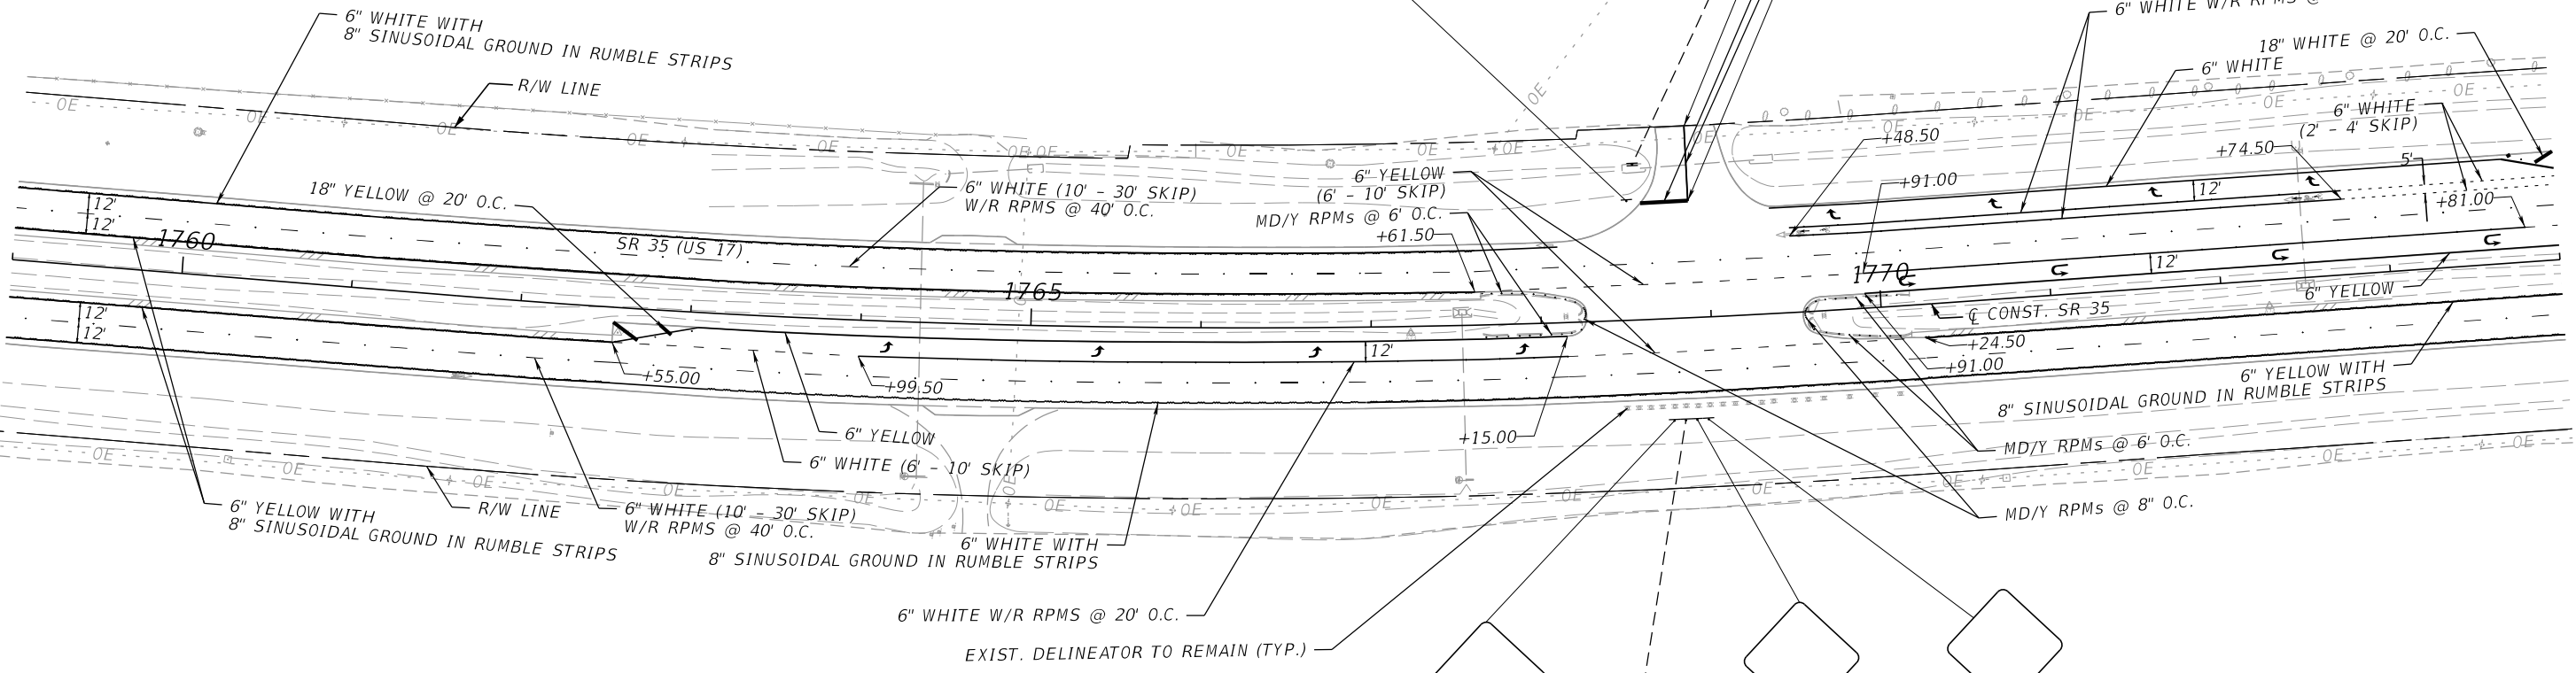


- EXIST. DELINEATOR TO REMAIN (TYP.)
- EXIST. SIGN (TO REMAIN)
- OM1-3
18"x18"
Proposed
0705 10 2 1 EA
STA. 1768+75
- OM1-3
18"x18"
Proposed
0705 10 2 1 EA
STA. 1768+90
- OM1-3
18"x18"
Proposed
0705 10 2 1 EA
STA. 1768+95

3/18/2024 5:31:53 PM Shuvo S:\2220010500-US17_S35_3R\44923215201\siging\PLANS\PO1.dgn

THE OFFICIAL RECORD OF THIS SHEET IS THE ELECTRONIC FILE DIGITALLY SIGNED AND SEALED UNDER RULE 61G15-23.004, F.A.C.

REVISIONS		ENGINEER OF RECORD		STATE OF FLORIDA DEPARTMENT OF TRANSPORTATION			SHEET NO.
DATE	DESCRIPTION	DATE	DESCRIPTION	ROAD NO.	COUNTY	FINANCIAL PROJECT ID	
			MAJHARUL ALAM, P.E. LICENSE NUMBER 61600 PROPEL ENGINEERING, INC. 2711 N VISTA PARKWAY, SUITE B7 WEST PALM BEACH, FL 33411	SR 35	POLK	449232-1-52-01	SIGNING AND PAVEMENT MARKING PLANS S-24

1"=100'

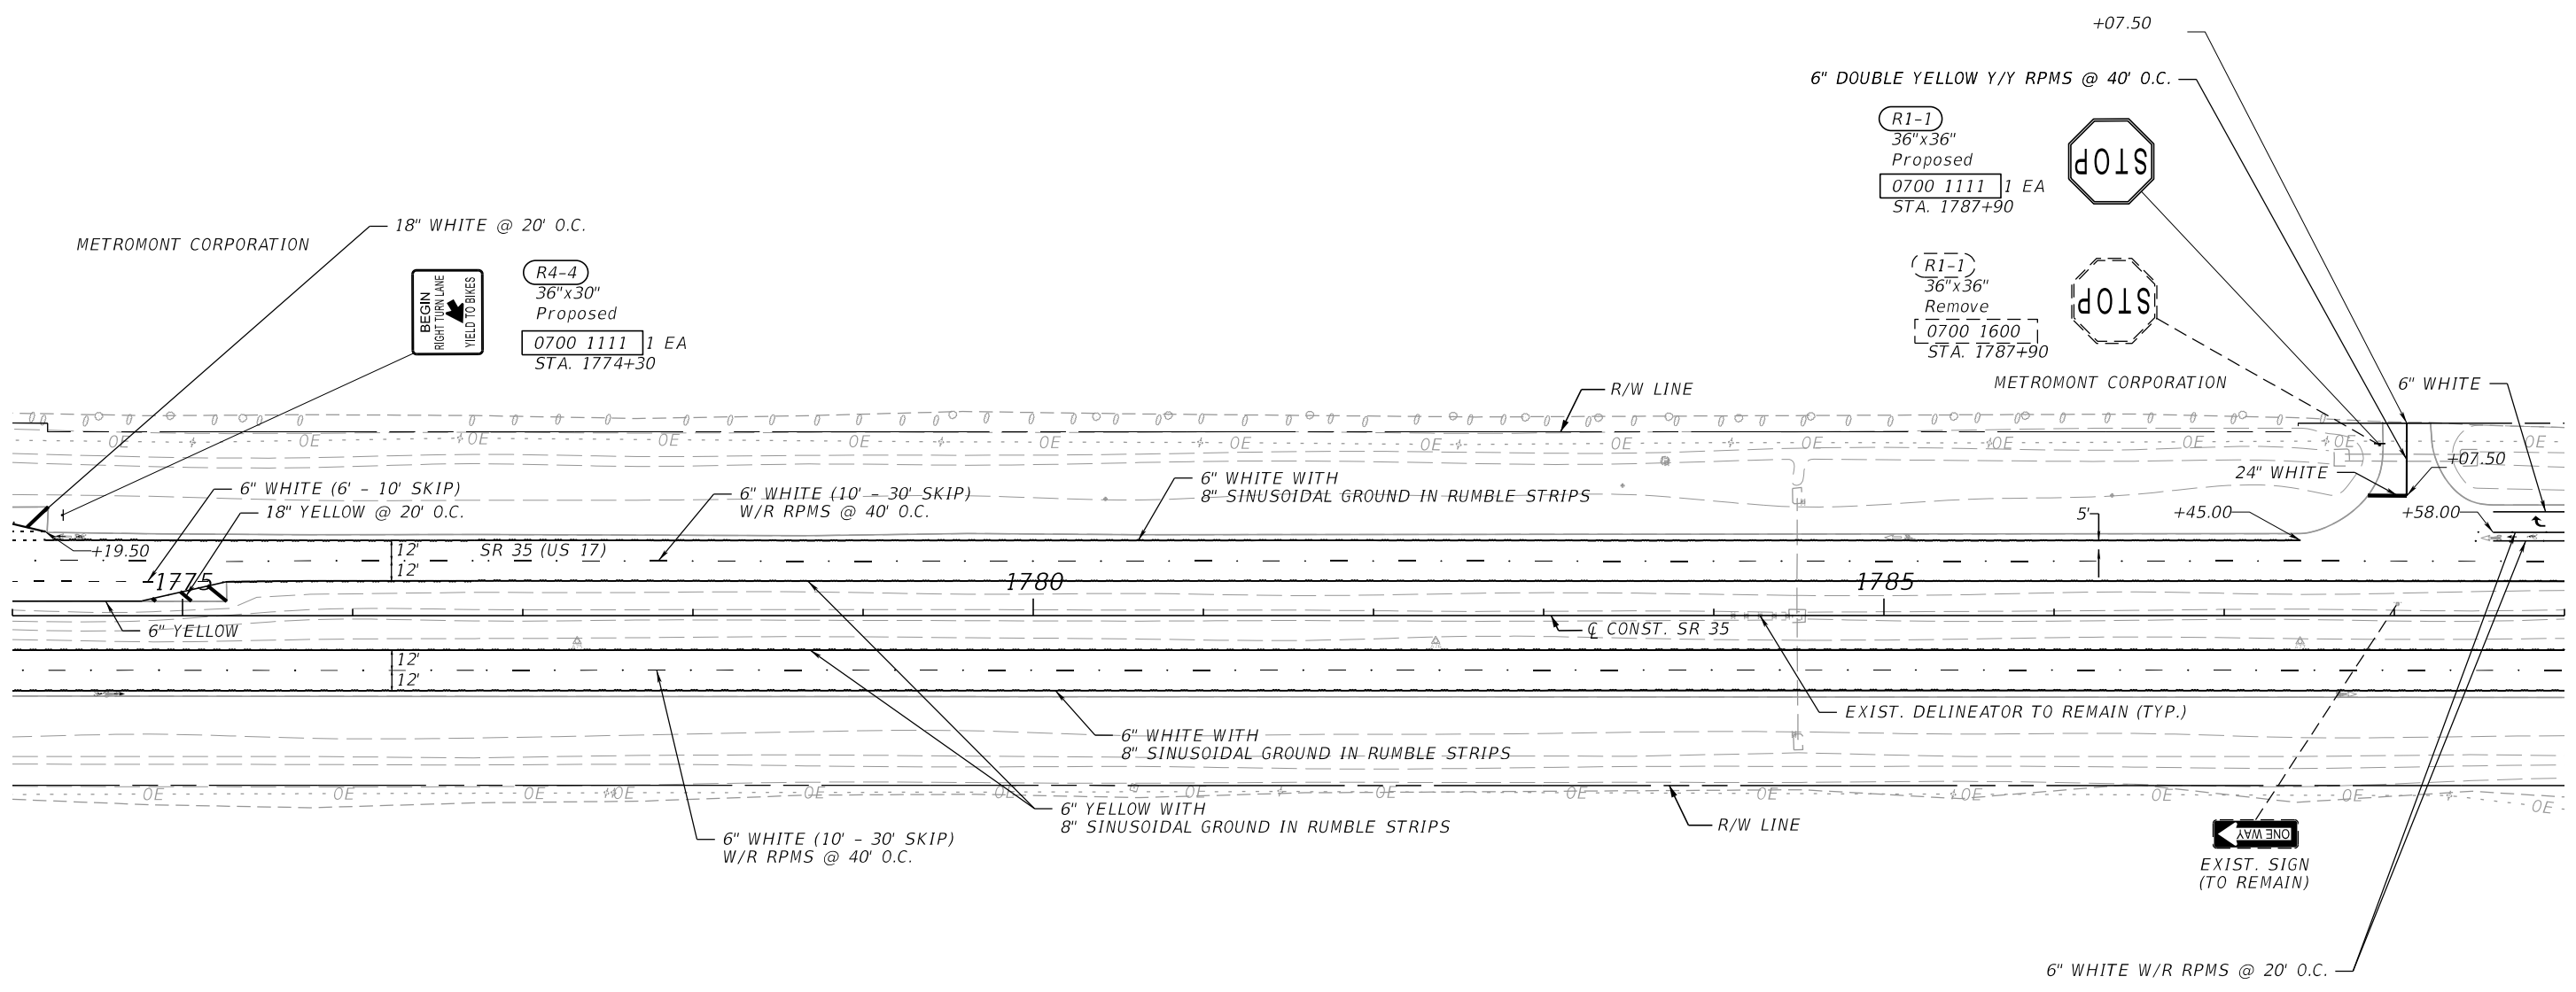


3/18/2024 5:31:54 PM Shuvo S:\2220010500-US17_SR35_3R\44923215201\signing\PLANS\PO1.dgn

THE OFFICIAL RECORD OF THIS SHEET IS THE ELECTRONIC FILE DIGITALLY SIGNED AND SEALED UNDER RULE 61G15-23.004, F.A.C.

REVISIONS				ENGINEER OF RECORD		STATE OF FLORIDA DEPARTMENT OF TRANSPORTATION			SIGNING AND PAVEMENT MARKING PLANS	SHEET NO.
DATE	DESCRIPTION	DATE	DESCRIPTION				ROAD NO.	COUNTY		FINANCIAL PROJECT ID
				MAJHARUL ALAM, P.E. LICENSE NUMBER 61600 PROPEL ENGINEERING, INC. 2711 N VISTA PARKWAY, SUITE B7 WEST PALM BEACH, FL 33411			SR 35	POLK		449232-1-52-01


1"=100'

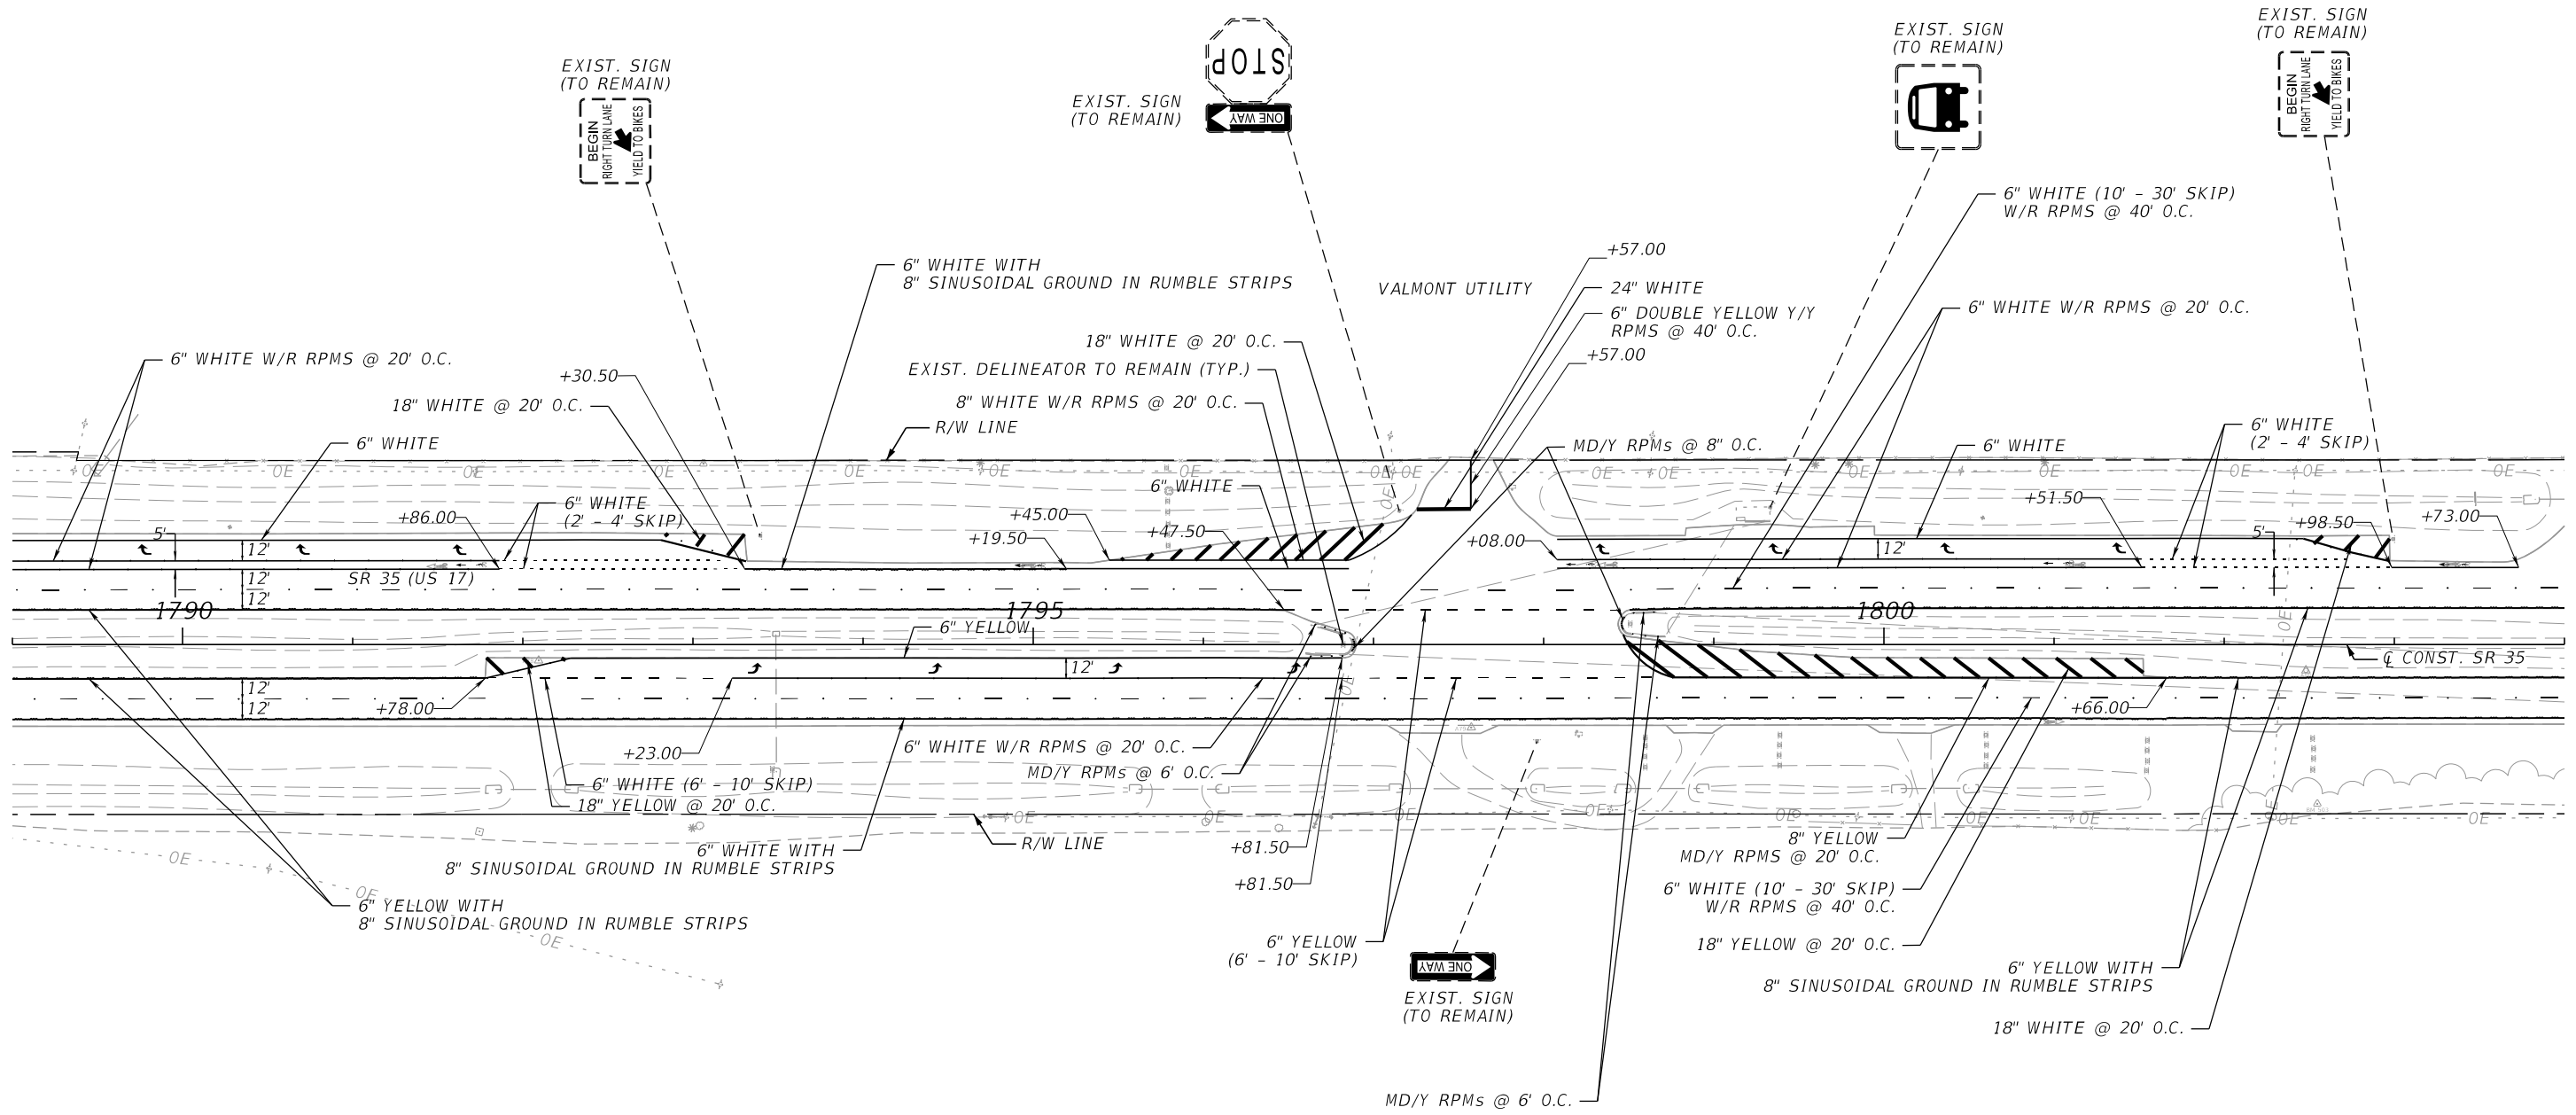

3/18/2024 5:31:54 PM Shuvo S:\2220010500-US17_SR35_BR\44923215201\siging\PLANS\PO1.dgn

THE OFFICIAL RECORD OF THIS SHEET IS THE ELECTRONIC FILE DIGITALLY SIGNED AND SEALED UNDER RULE 61G15-23.004, F.A.C.


REVISIONS				ENGINEER OF RECORD		STATE OF FLORIDA DEPARTMENT OF TRANSPORTATION			SIGNING AND PAVEMENT MARKING PLANS	SHEET NO. S-26
DATE	DESCRIPTION	DATE	DESCRIPTION			ROAD NO.	COUNTY	FINANCIAL PROJECT ID		
				MAJHARUL ALAM, P.E. LICENSE NUMBER 61600 PROPEL ENGINEERING, INC. 2711 N VISTA PARKWAY, SUITE B7 WEST PALM BEACH, FL 33411		SR 35	POLK	449232-1-52-01		

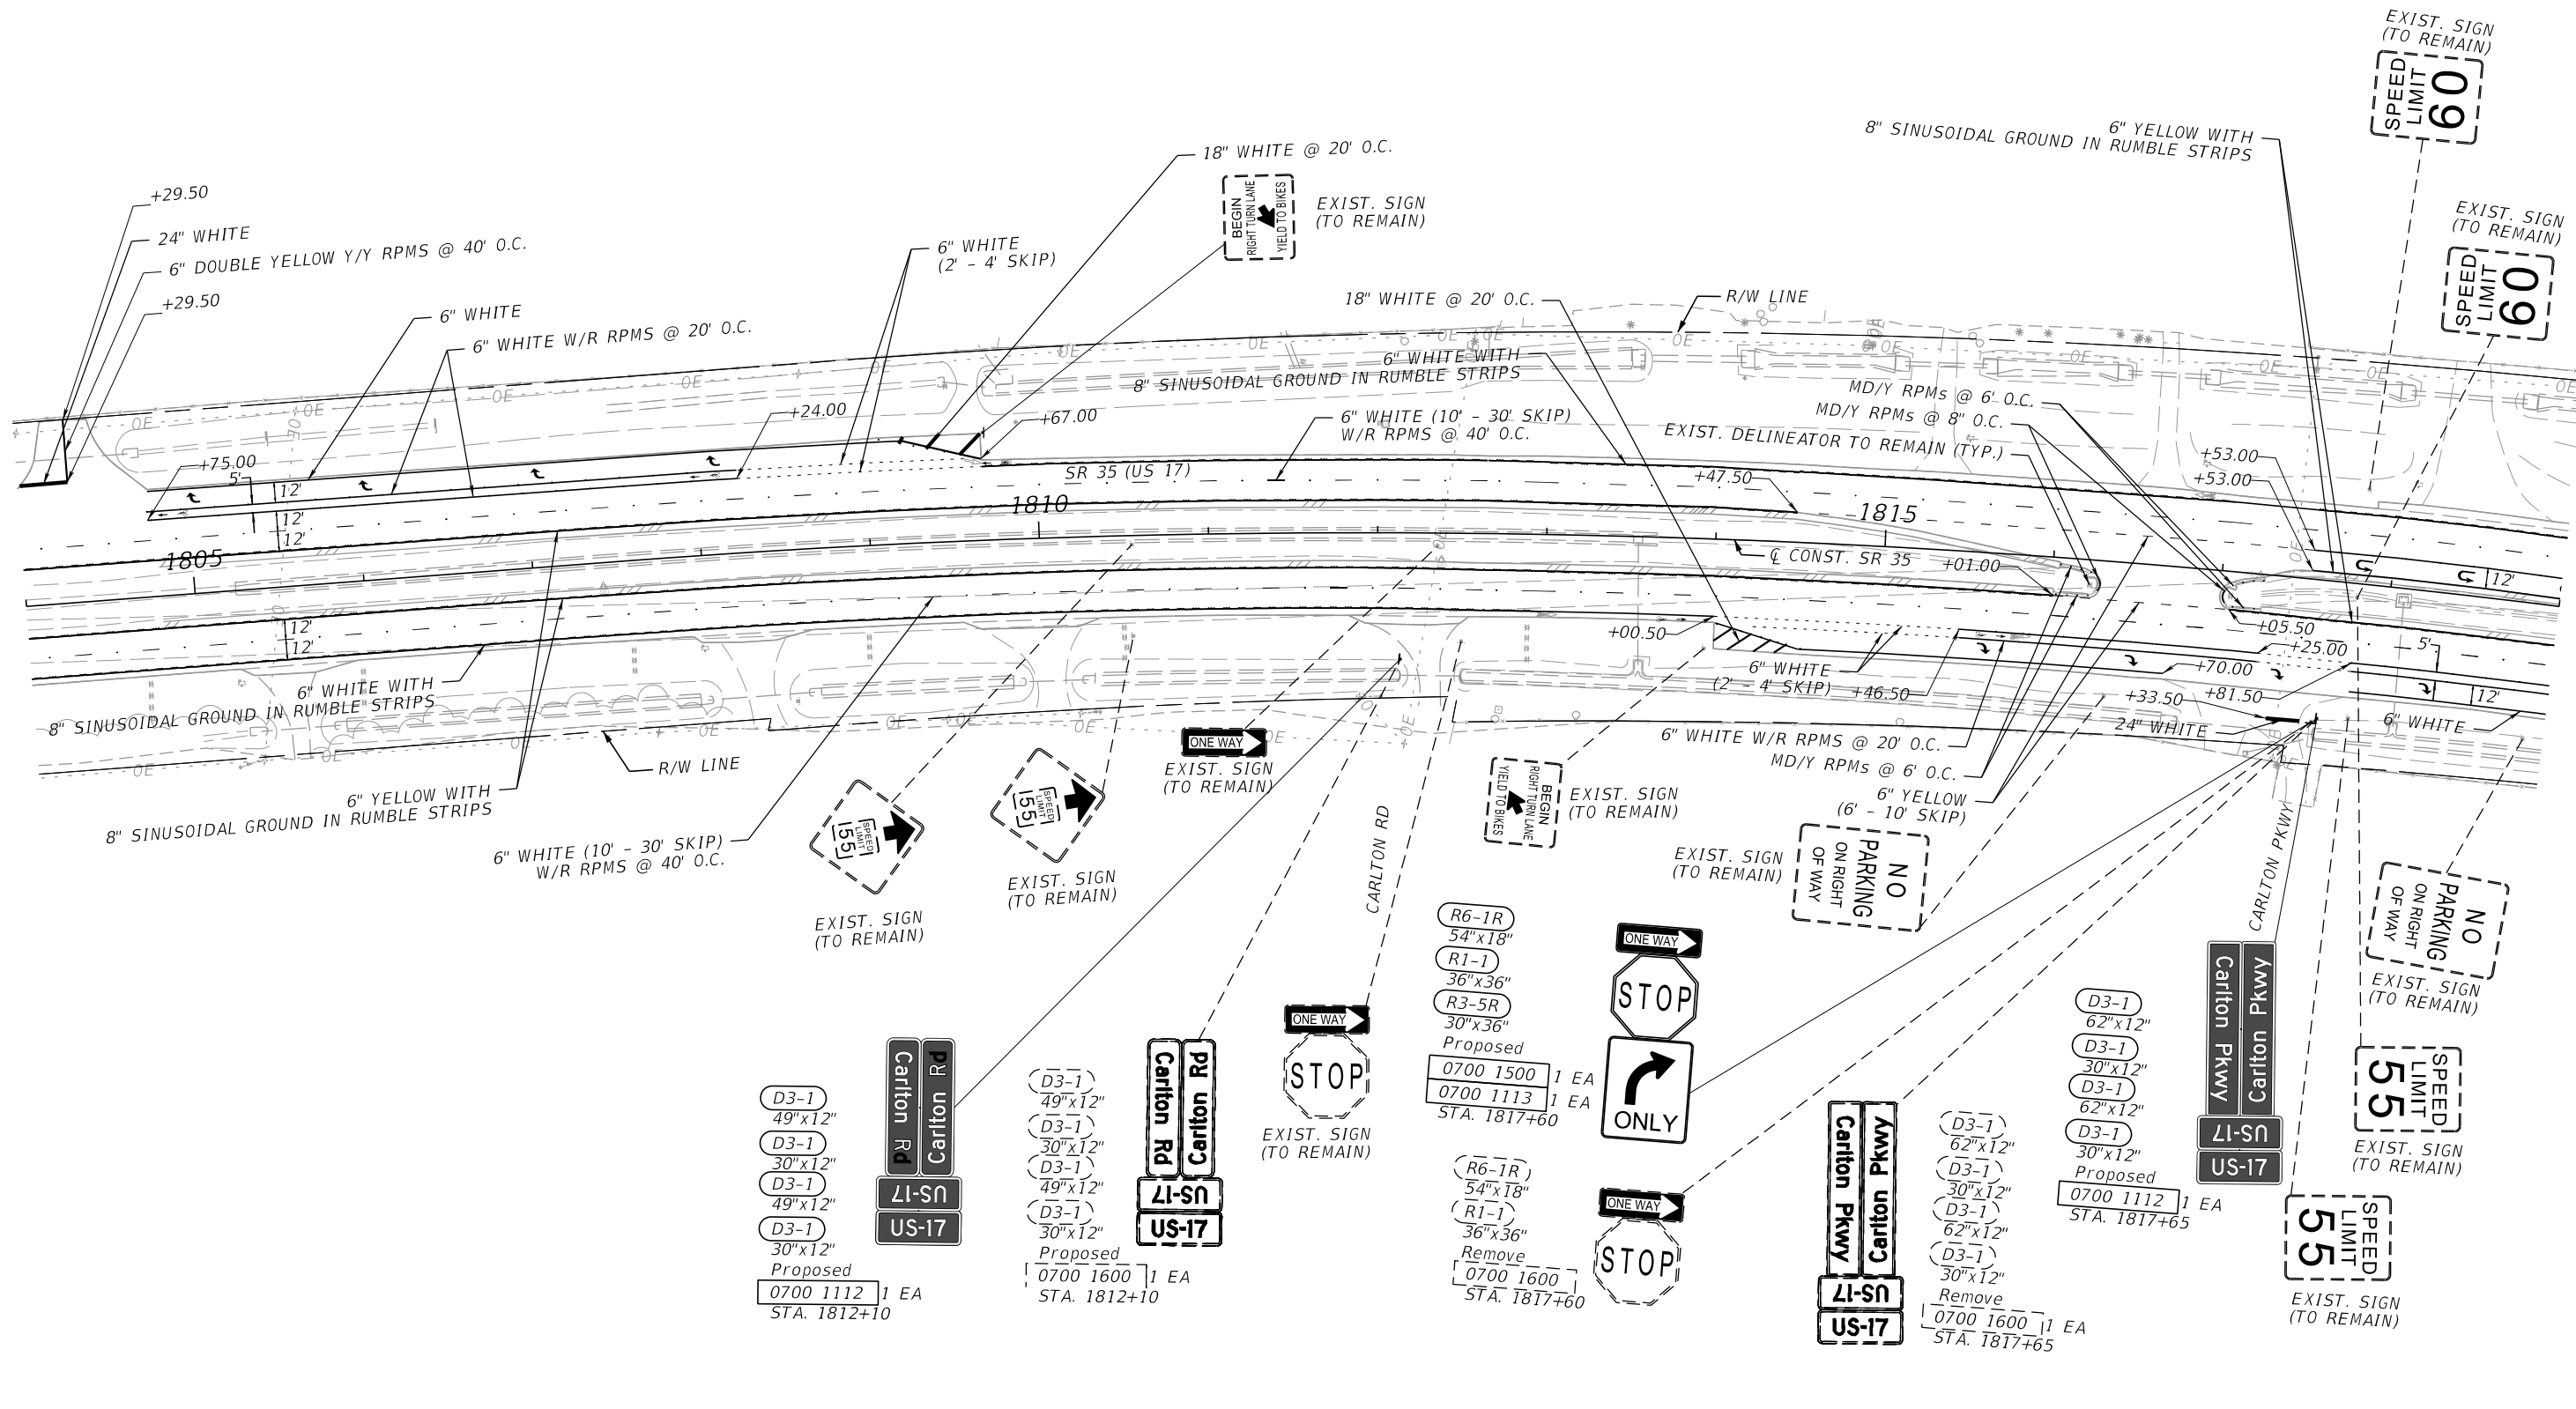

3/18/2024 5:31:55 PM Shuvo S:\2220010500-US17-SR35_3R\44923215201\signing\PLANS\PO1.dgn

THE OFFICIAL RECORD OF THIS SHEET IS THE ELECTRONIC FILE DIGITALLY SIGNED AND SEALED UNDER RULE 61G15-23.004, F.A.C.

REVISIONS		ENGINEER OF RECORD		STATE OF FLORIDA DEPARTMENT OF TRANSPORTATION			SHEET NO.
DATE	DESCRIPTION	DATE	DESCRIPTION	ROAD NO.	COUNTY	FINANCIAL PROJECT ID	
			MAJHARUL ALAM, P.E. LICENSE NUMBER 61600 PROPEL ENGINEERING, INC. 2711 N VISTA PARKWAY, SUITE B7 WEST PALM BEACH, FL 33411	SR 35	POLK	449232-1-52-01	5-27
SIGNING AND PAVEMENT MARKING PLANS							

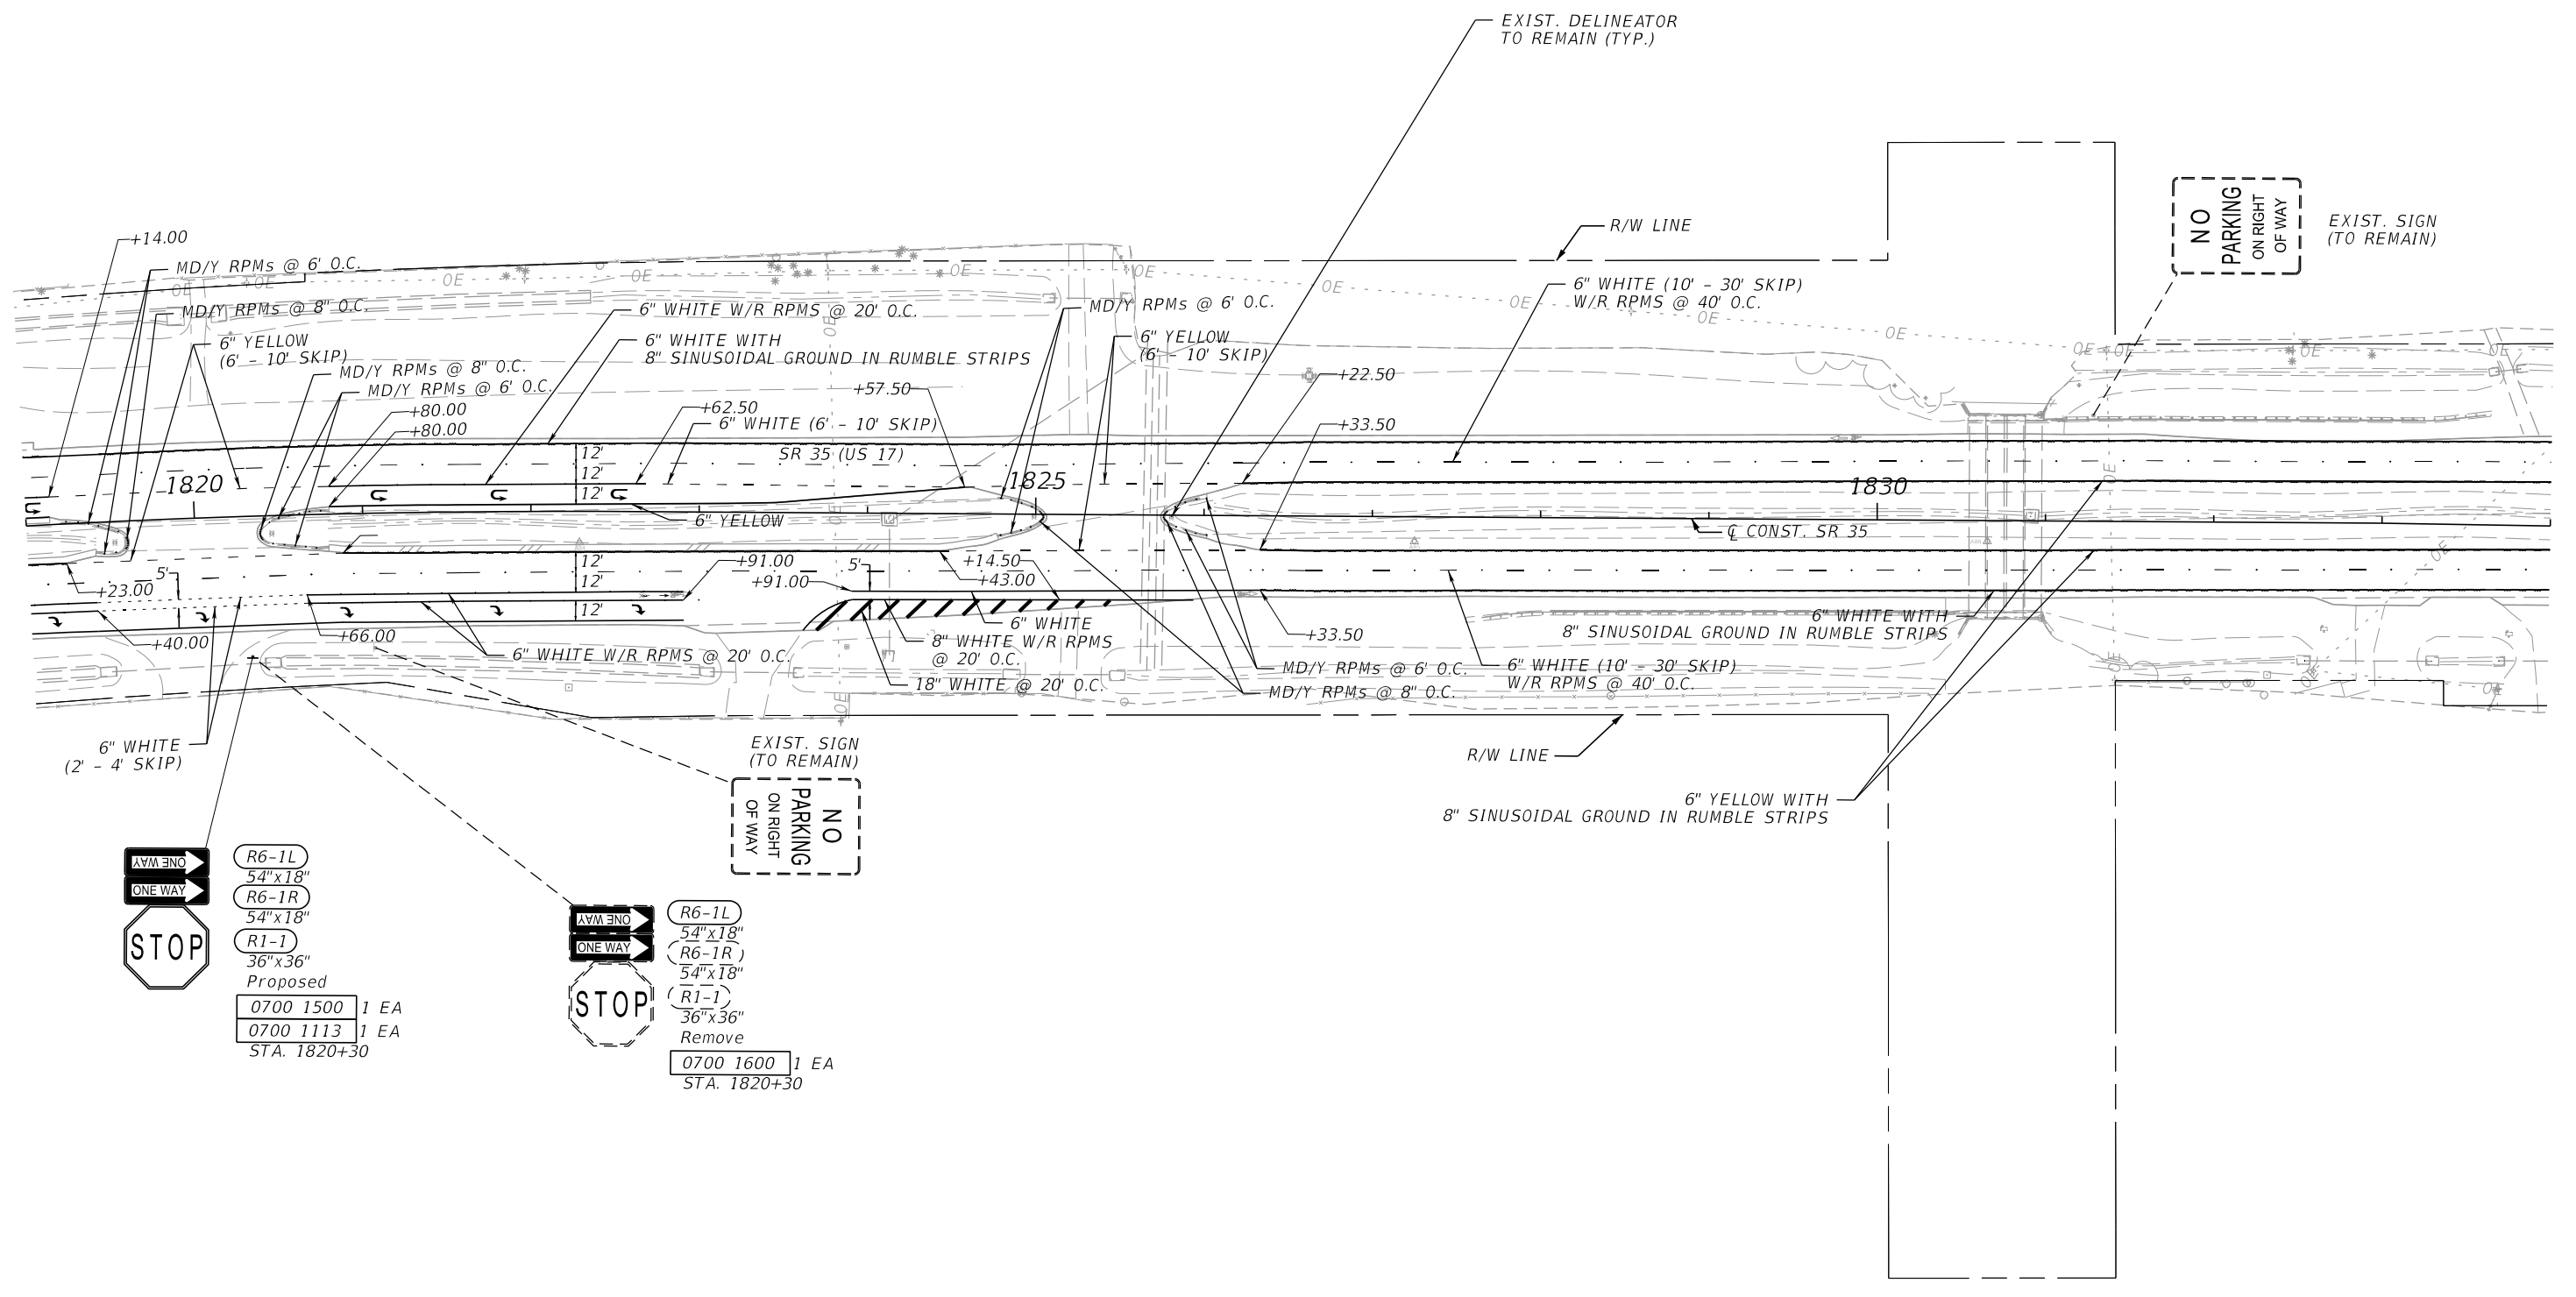

EXIST. SIGN (TO REMAIN)
NO PARKING ON RIGHT OF WAY


PROPOSED SIGNAGE:
 R6-1L 54"x18"
 R6-1R 54"x18"
 R1-1 36"x36"
 Proposed
 0700 1500 1 EA
 0700 1113 1 EA
 STA. 1820+30

REMOVE SIGNAGE:
 R6-1L 54"x18"
 R6-1R 54"x18"
 R1-1 36"x36"
 Remove
 0700 1600 1 EA
 STA. 1820+30

3/18/2024 5:31:55 PM Shuvo S:\2220010500-US17_SR35_3R\44923215201\signing\PLANS\PO1.dgn

THE OFFICIAL RECORD OF THIS SHEET IS THE ELECTRONIC FILE DIGITALLY SIGNED AND SEALED UNDER RULE 61G15-23.004, F.A.C.

REVISIONS		ENGINEER OF RECORD		STATE OF FLORIDA DEPARTMENT OF TRANSPORTATION			SHEET NO.
DATE	DESCRIPTION	DATE	DESCRIPTION	ROAD NO.	COUNTY	FINANCIAL PROJECT ID	
			MAJHARUL ALAM, P.E. LICENSE NUMBER 61600 PROPEL ENGINEERING, INC. 2711 N VISTA PARKWAY, SUITE B7 WEST PALM BEACH, FL 33411	SR 35	POLK	449232-1-52-01	S-28
SIGNING AND PAVEMENT MARKING PLANS							

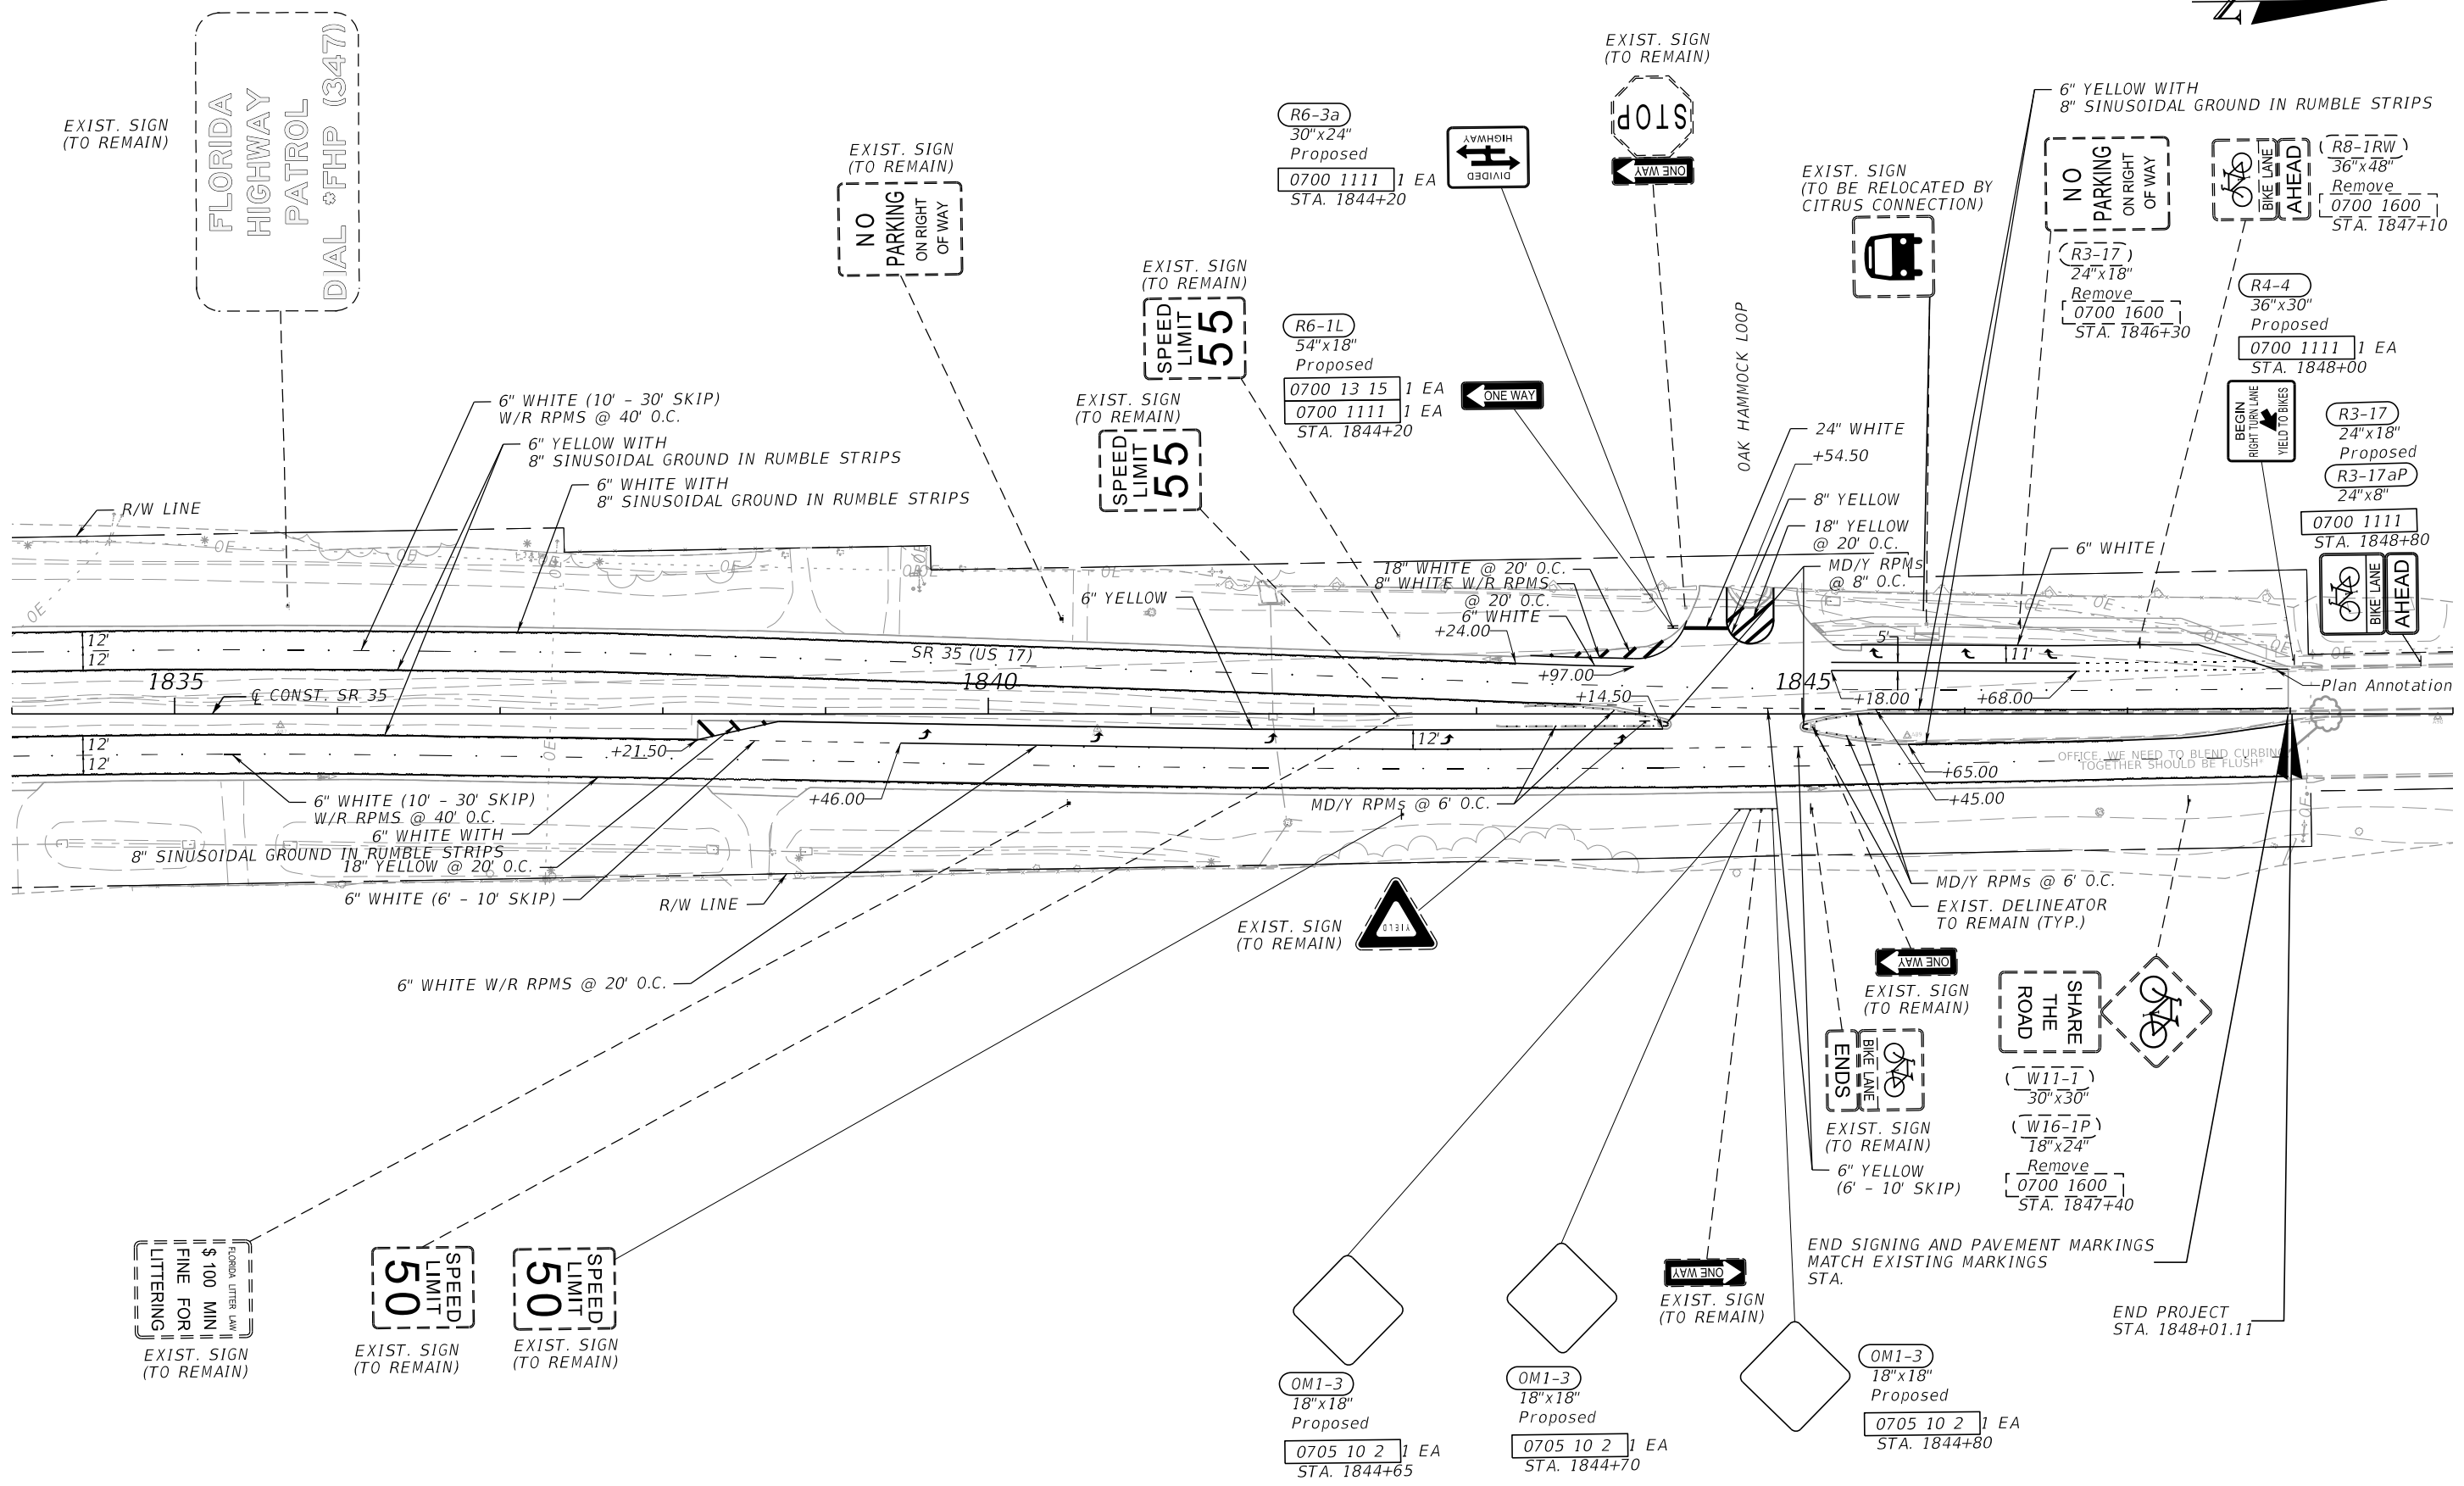



3/18/2024 5:31:56 PM Shuvo S:\2220010500-US17_SR35_3R\44923215201\signing\PLANS\PO1.dgn

THE OFFICIAL RECORD OF THIS SHEET IS THE ELECTRONIC FILE DIGITALLY SIGNED AND SEALED UNDER RULE 61G15-23.004, F.A.C.

REVISIONS		ENGINEER OF RECORD		STATE OF FLORIDA DEPARTMENT OF TRANSPORTATION			SHEET NO.
DATE	DESCRIPTION	DATE	DESCRIPTION	ROAD NO.	COUNTY	FINANCIAL PROJECT ID	
			MAJHARUL ALAM, P.E. LICENSE NUMBER 61600 PROPEL ENGINEERING, INC. 2711 N VISTA PARKWAY, SUITE B7 WEST PALM BEACH, FL 33411	SR 35	POLK	449232-1-52-01	SIGNING AND PAVEMENT MARKING PLANS S-29

3/26/2024 2:37:30 AM Istiak Ahmed
C:\Work\sets\FDOT\4492321\5201\Signing\Marking\RD\SRD01_Multi\post_Sign_Xsection.dgn

THE OFFICIAL RECORD OF THIS SHEET IS THE ELECTRONIC FILE DIGITALLY SIGNED AND SEALED UNDER RULE 61G15-23.004, F.A.C.

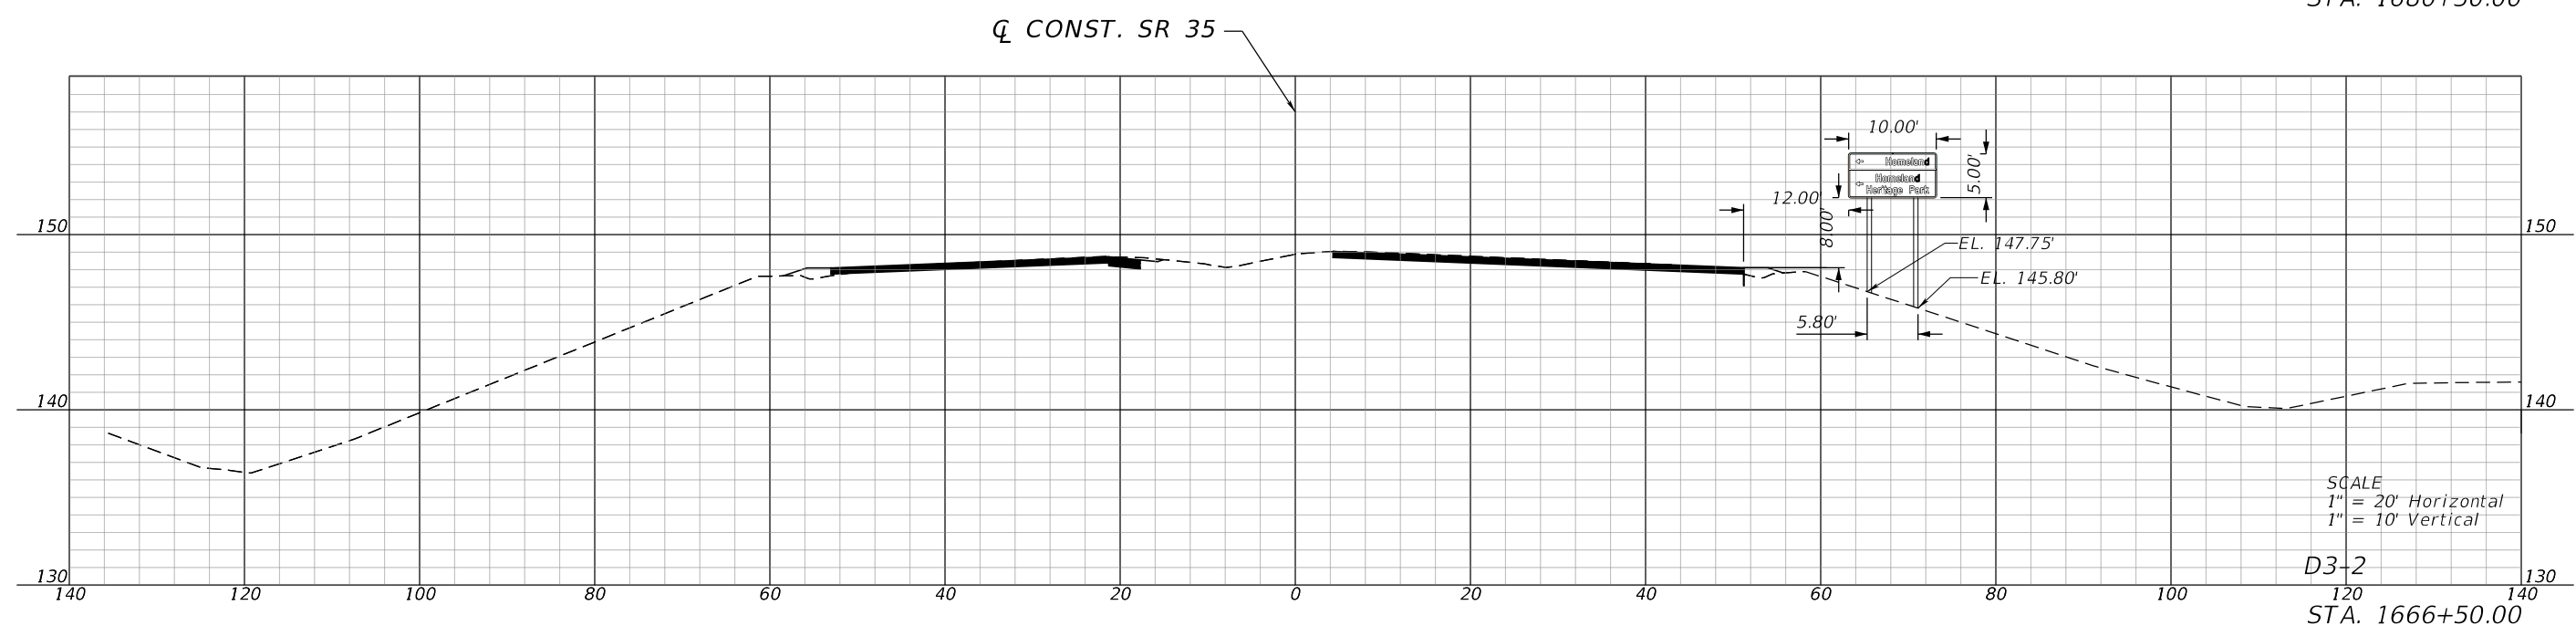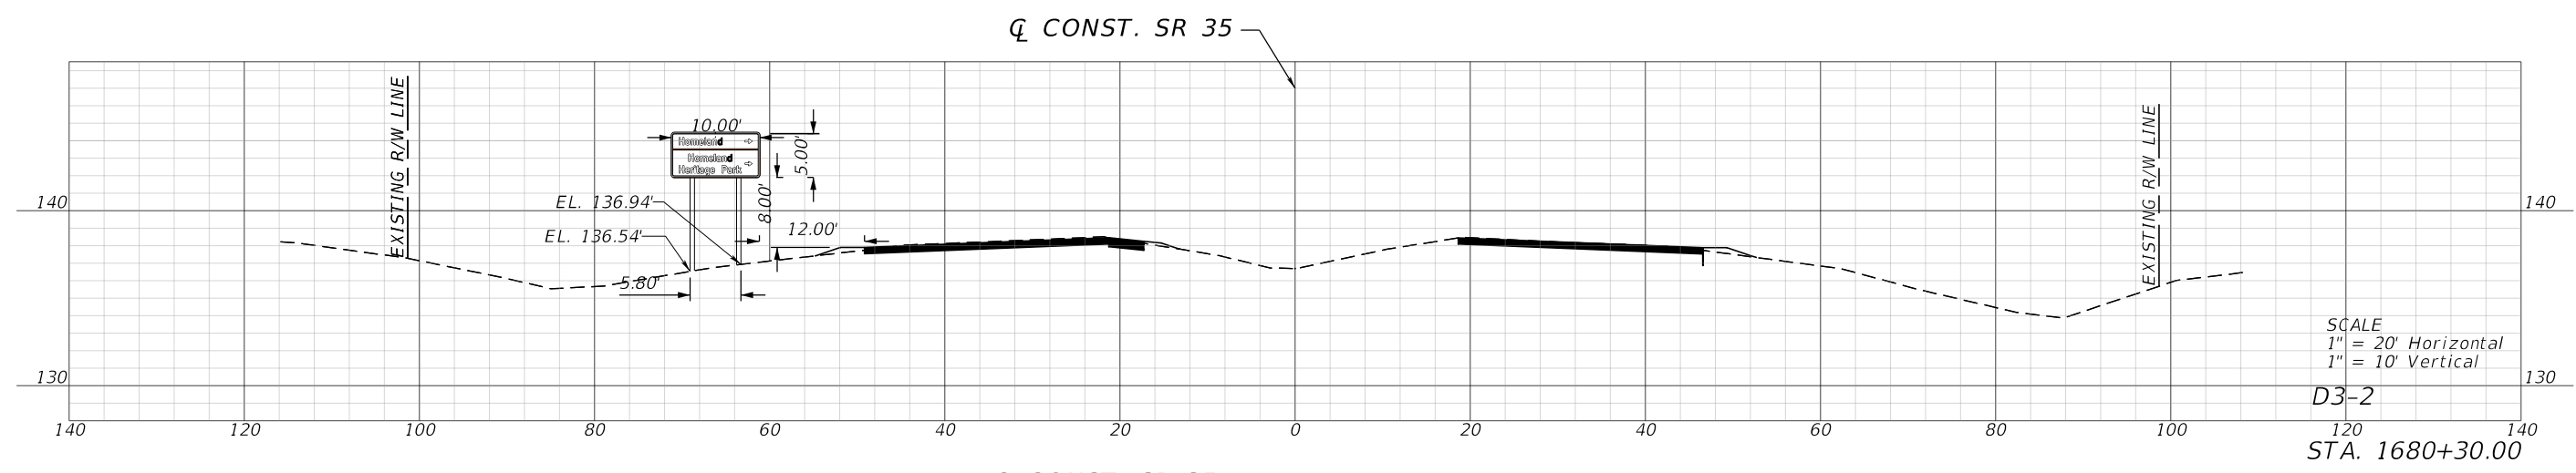

REVISIONS				ENGINEER OF RECORD		STATE OF FLORIDA DEPARTMENT OF TRANSPORTATION			SIGN CROSS SECTIONS	SHEET NO.
DATE	DESCRIPTION	DATE	DESCRIPTION	MAJHARUL ALAM, P.E. LICENSE NUMBER: 61600 PROPEL ENGINEERING, INC. 2711 N VISTA PARKWAY, SUITE B-7 WEST PALM BEACH, FL 33411		ROAD NO.	COUNTY	FINANCIAL PROJECT ID		S-35
						SR 35	POLK	449232-1-52-01		