

CONTRACT PLANS COMPONENTS

- ROADWAY PLANS
- SIGNING AND PAVEMENT MARKING PLANS
- SIGNALIZATION PLANS
- LIGHTING PLANS

STATE OF FLORIDA
DEPARTMENT OF TRANSPORTATION

SIGNING AND PAVEMENT MARKING PLANS


FINANCIAL PROJECT ID 446293-1-52-01, 446293-1-52-02 & 446293-1-52-03

(FEDERAL FUNDS)

LEE COUNTY (12001)

STATE ROAD NO: 739

SR 739 FROM NORTH OF THE
CALOOSAHATCHEE RIVER TO SR 78

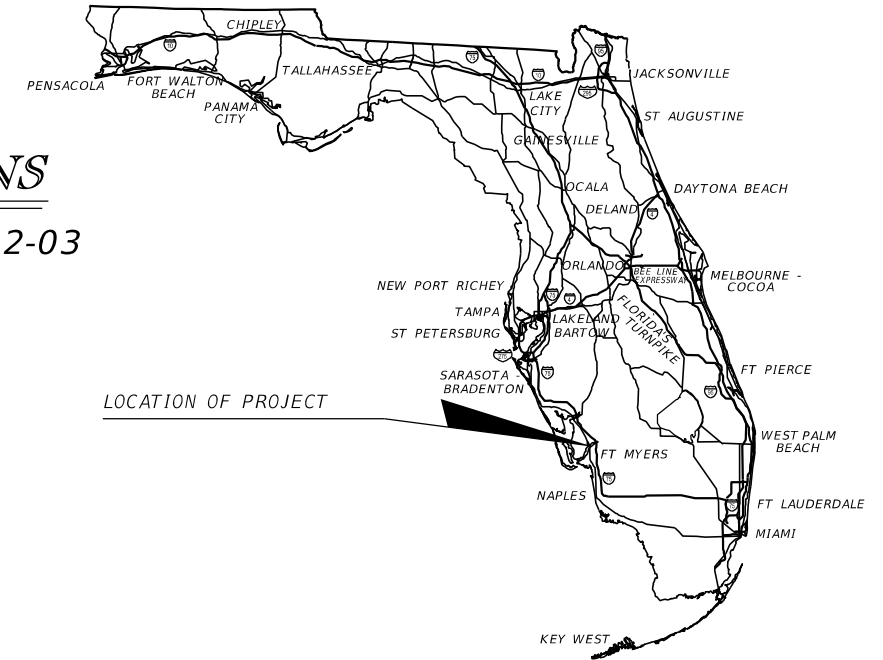


INDEX OF SIGNING AND PAVEMENT MARKING PLANS

SHEET NO.	SHEET DESCRIPTION
S-1	KEY SHEET
S-2	GENERAL NOTES
S-3 - S-22	SIGNING AND PAVEMENT MARKING PLAN
S-23	GUIDE SIGN WORKSHEET

PROJECT LOCATION URL: <https://tinyurl.com/3v46m4wa>
 WORK PROGRAM DESC.: RESURFACING
 PROJECT LIMITS: BEGIN MP 1.055 - END MP 2.741
 EXCEPTIONS: NONE
 BRIDGE LIMITS: NONE
 RAILROAD CROSSINGS: NONE

PHASE IV
AUGUST 2023

THIS ITEM HAS BEEN DIGITALLY
SIGNED AND SEALED BY

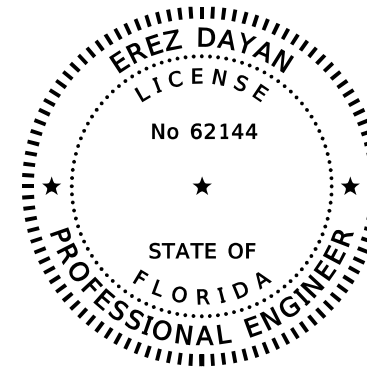

ON THE DATE ADJACENT TO THE SEAL

PRINTED COPIES OF THIS DOCUMENT ARE
NOT CONSIDERED SIGNED AND SEALED
AND THE SIGNATURE MUST BE VERIFIED
ON ANY ELECTRONIC COPIES.

THE ABOVE NAMED PROFESSIONAL IS
RESPONSIBLE FOR THE FOLLOWING SHEETS
IN ACCORDANCE WITH RULE 61G15-23.004, F.A.C.

**SIGNING AND
PAVEMENT MARKING PLANS
ENGINEER OF RECORD:**

EREZ DAYAN, P.E. NO.: 62144
AVANT ENGINEERING GROUP, LLC
2699 LEE ROAD, SUITE 401
WINTER PARK, FL 32789
(407) 775-2209
CONTRACT NO.: CAF70
VENDOR NO.: 833811146-01

FDOT PROJECT MANAGER:
RYAN L. PATTERSON

CONSTRUCTION CONTRACT NO.	FISCAL YEAR	SHEET NO.
T1863	24	S-1

GOVERNING STANDARD PLANS:

 
Florida Department of Transportation, FY2024-25 Standard Plans for Road and Bridge Construction and applicable Interim Revisions (IRs).

Standard Plans for Road Construction and associated IRs are available at the following website: <http://www.fdot.gov/design/standardplans>

APPLICABLE IRs: IR - -

GOVERNING STANDARD SPECIFICATIONS:

Florida Department of Transportation, FY 2024-25 Standard Specifications for Road and Bridge Construction at the following website: <http://www.fdot.gov/programmanagement/Implemented/SpecBooks>



STA. 322+00
 700-1-11 2 AS
 700-1-60 2 AS
 R2-1 30"X36"

STA. 323+01
 700-1-11 1 AS
 700-1-60 1 AS
 R9-6 12"X18"

STA. 323+68
 700-1-11 1 AS
 700-1-60 1 AS
 700-3-501 1 EA
 FTP-42-06 48"X30"

LEGEND
 ● YELLOW DELINEATOR FLEXIBLE TUBULAR
 705-11-1 1 EA

EXISTING TO REMAIN

BEGIN PROJECT
 BEGIN PAVEMENT MARKINGS
 (MATCH EXIST.
 PAVEMENT MARKINGS)
 STA. 323+03.53
 Q CONST. SR 739

EXISTING TO REMAIN
 NO DUMPING OF GARBAGE

EXISTING TO REMAIN

FT MYERS CITY LIMIT

YELLOW REFLECTIVE PAINT (ISLAND NOSE) WITH MD/Y RPMS AT 8" C/C

6" DOUBLE YELLOW WITH Y/Y RPMS AT 40' C/C

6" WHITE (10'-30' SKIP) WITH W/R RPMS AT 40' C/C

6" WHITE

SOUTHBOUND SR 739

NORTHBOUND SR 739

YELLOW DELINEATOR FLEXIBLE TUBULAR

Q CONST. SR 739

18" YELLOW AT 45° AT 30' SPACING

6" WHITE (10'-30' SKIP) WITH W/R RPMS AT 40' C/C

BEGIN SIGNING
 STA. 322+00.00
 Q CONST. SR 739



REMOVE EXIST. ASSEMBLY AND RELOCATE EXIST. EIVIE ASSOCIATION, INC. SIGN TO PROPOSED ASSEMBLY

FT. MYERS NORTH



EXISTING TO REMAIN

MATCH LINE STA. 326+80.00
 SEE SHEET S-4

8/14/2023 9:03:54 PM LizetteMartinez P:\FDOT\446293\15201\SigningAndMarking\PLANS\SP01.dgn

REVISIONS		ENGINEER OF RECORD		STATE OF FLORIDA DEPARTMENT OF TRANSPORTATION			SIGNING AND PAVEMENT MARKING PLAN (1)	SHEET NO. S-3
DATE	DESCRIPTION	DATE	DESCRIPTION	ROAD NO.	COUNTY	FINANCIAL PROJECT ID		
				SR 739	LEE	446293-1-52-01		

THE OFFICIAL RECORD OF THIS SHEET IS THE ELECTRONIC FILE DIGITALLY SIGNED AND SEALED UNDER RULE 61G15-23.004, F.A.C.

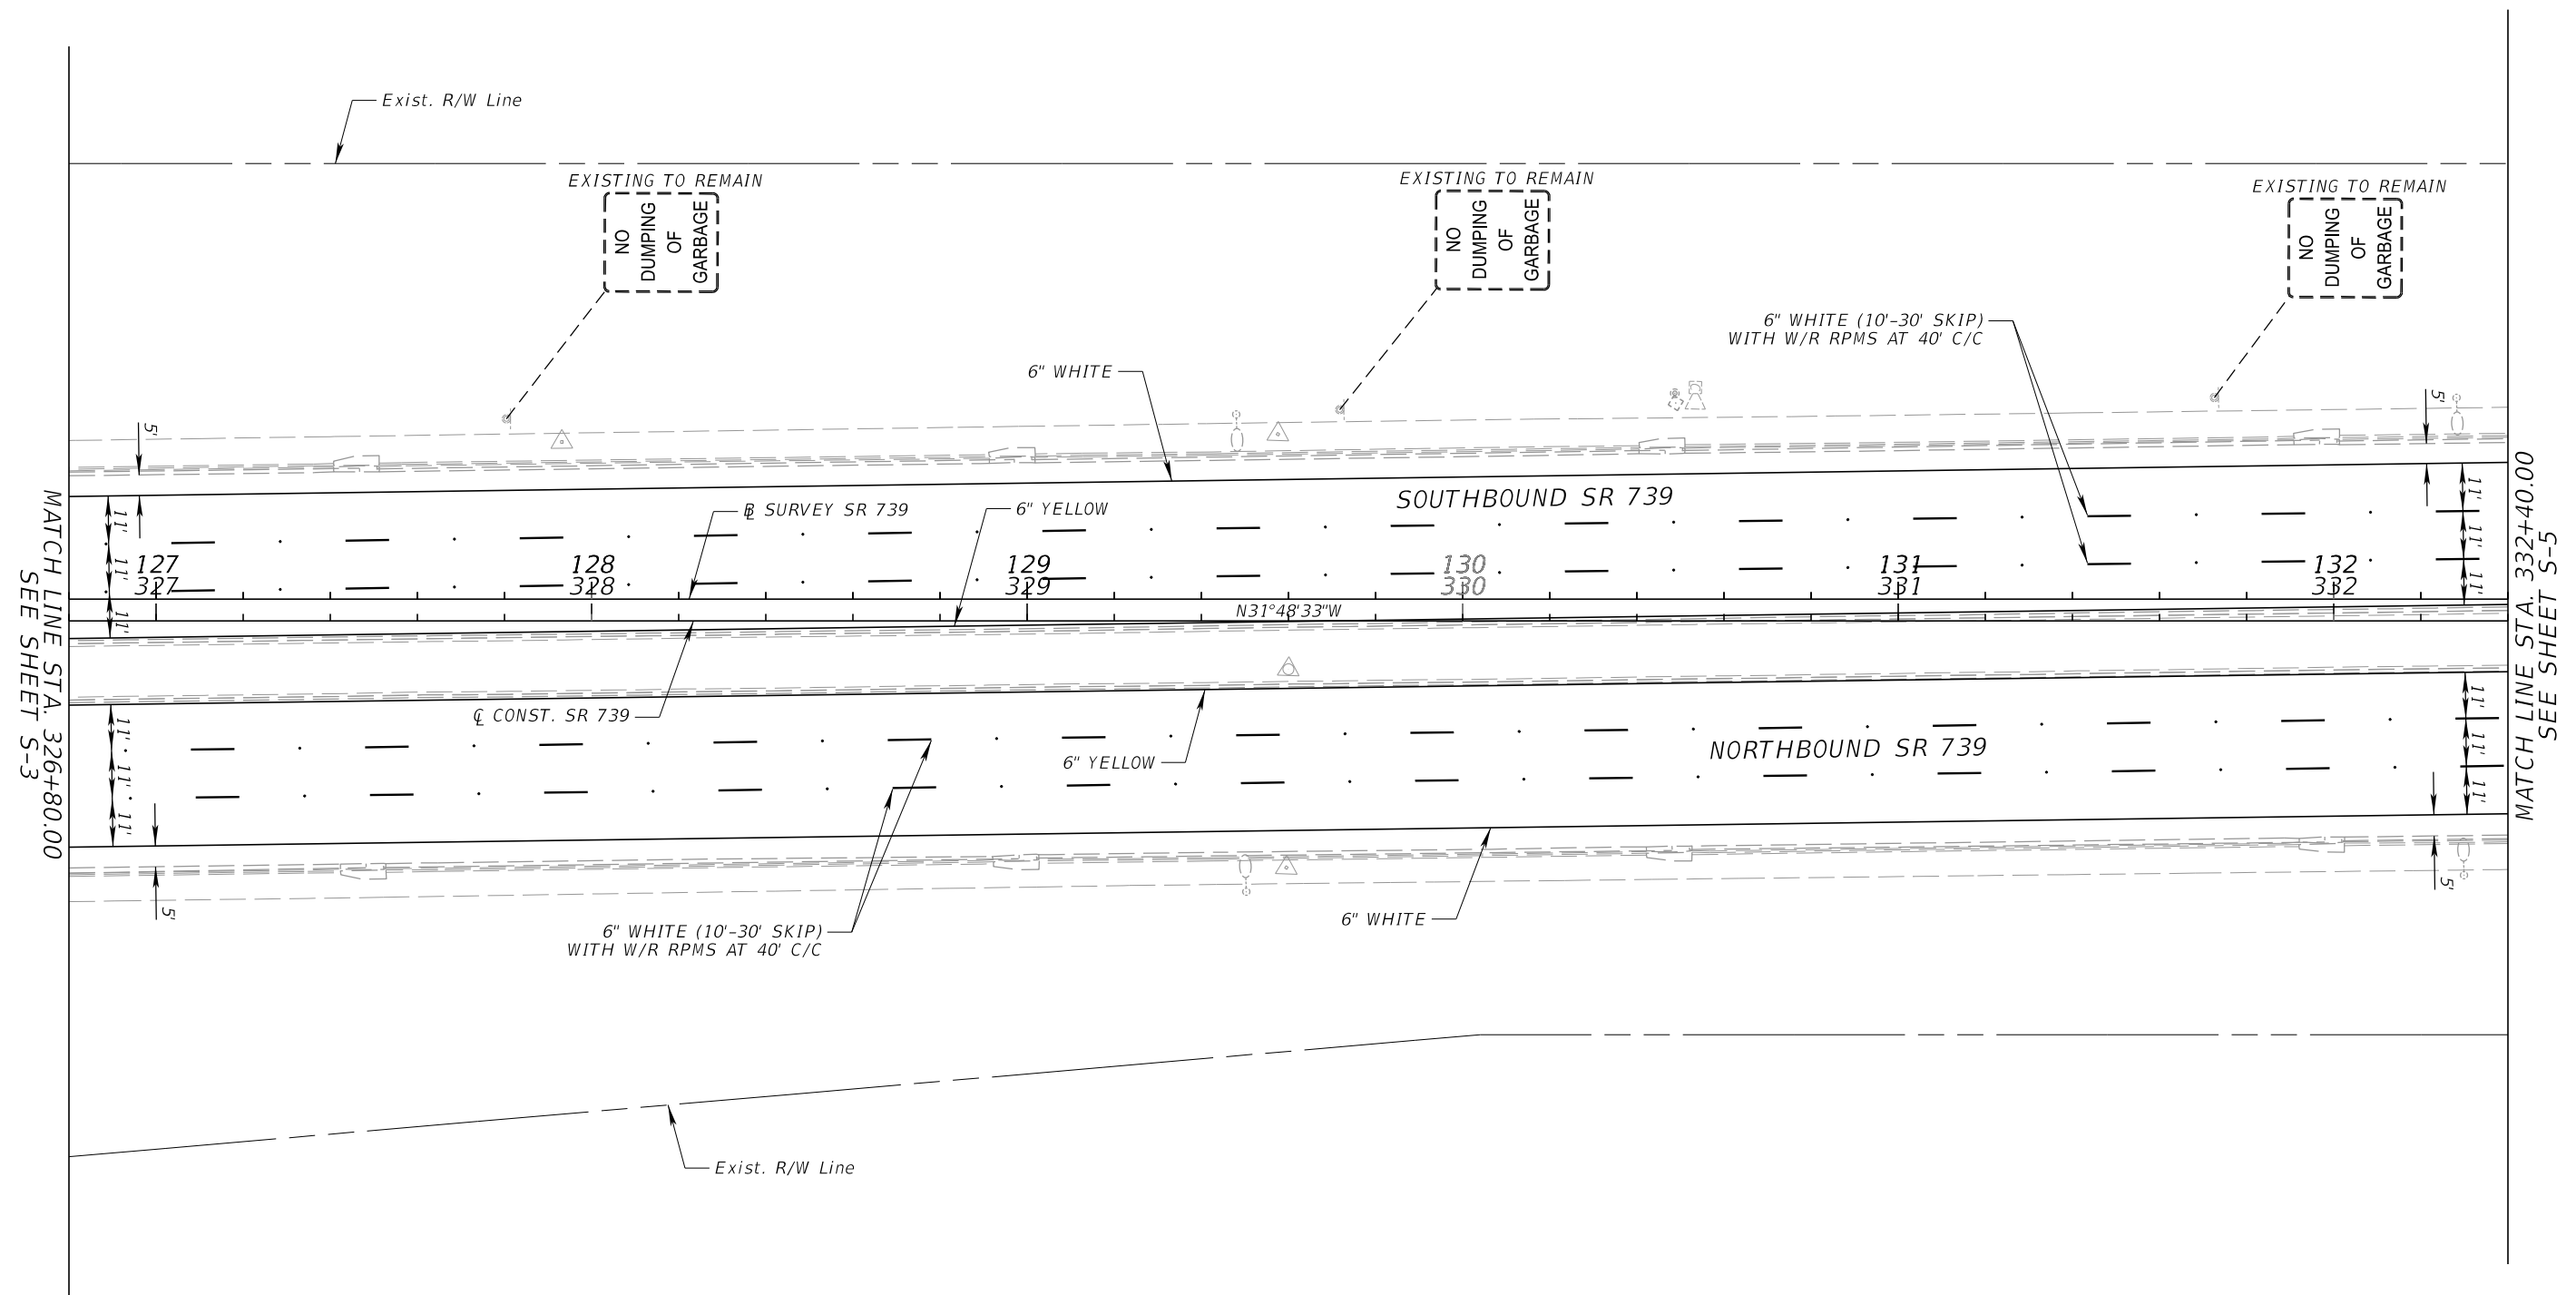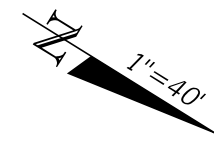

MATCH LINE STA. 326+80.00
SEE SHEET S-3


MATCH LINE STA. 332+40.00
SEE SHEET S-5

8/14/2023 9:03:54 PM LizetteMartinez
P:\FDOT\44629315201\SigningAndMarking\PLANS\01.dgn

REVISIONS				ENGINEER OF RECORD			STATE OF FLORIDA DEPARTMENT OF TRANSPORTATION			SIGNING AND PAVEMENT MARKING PLAN (2)	SHEET NO. S-4
DATE	DESCRIPTION	DATE	DESCRIPTION	EREZ DAYAN, P.E. LICENSE NUMBER: 62144 AVANT ENGINEERING GROUP, LLC 2699 LEE ROAD, SUITE 401 WINTER PARK, FL 32789			ROAD NO.	COUNTY	FINANCIAL PROJECT ID		
							SR 739	LEE	446293-1-52-01		

THE OFFICIAL RECORD OF THIS SHEET IS THE ELECTRONIC FILE DIGITALLY SIGNED AND SEALED UNDER RULE 61G15-23.004, F.A.C.

1"=40'

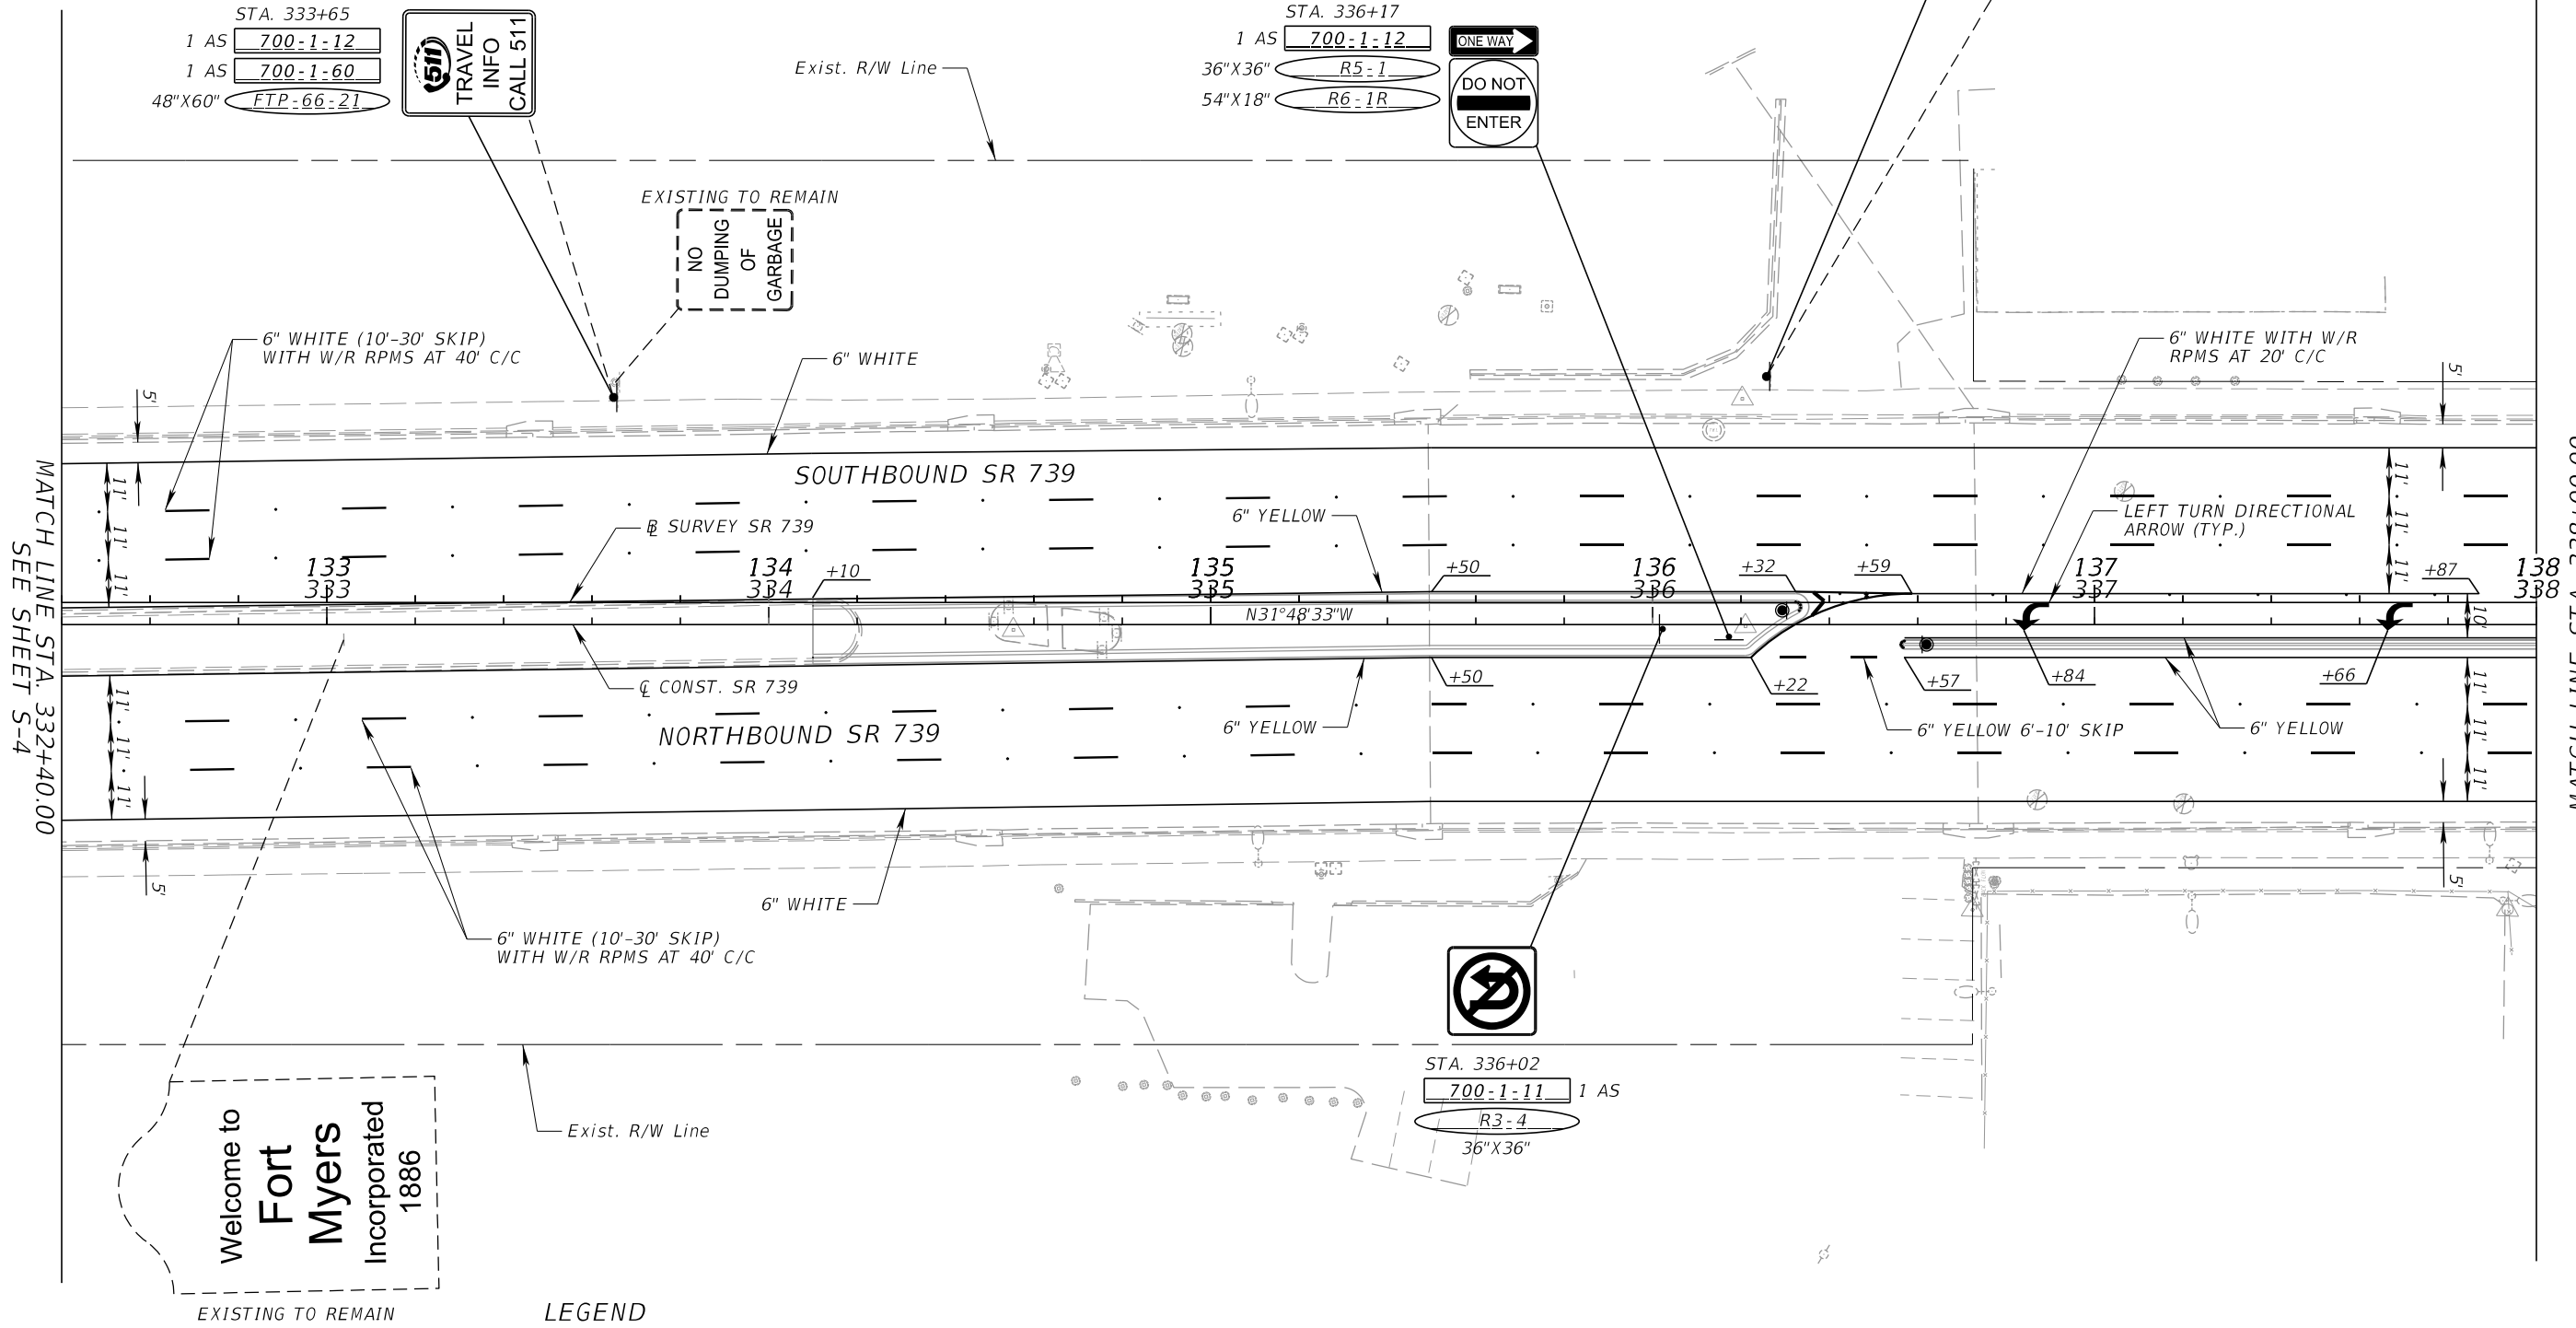

STA. 333+65
 1 AS 700-1-12
 1 AS 700-1-60
 48"X60" FTP-66-21

511 TRAVEL INFO CALL 511

STA. 336+17
 1 AS 700-1-12
 36"X36" R5-1
 54"X18" R6-1R

ONE WAY
 DO NOT ENTER

STA. 336+26
 1 AS 700-1-11
 1 AS 700-1-60
 24"X30" R8-1RW

NO PARKING ON RIGHT OF WAY

Welcome to Fort Myers Incorporated 1886

LEGEND
 ● YELLOW DELINEATOR FLEXIBLE TUBULAR
 705-11-1 2 EA



MATCH LINE STA. 332+40.00 SEE SHEET S-4

MATCH LINE STA. 338+00.00 SEE SHEET S-6

8/14/2023 9:03:55 PM LizetteMartinez P:\FDOT\44629315201\SigningAndMarking\PLANS\SP01.dgn

REVISIONS				ENGINEER OF RECORD		STATE OF FLORIDA DEPARTMENT OF TRANSPORTATION			SIGNING AND PAVEMENT MARKING PLAN (3)	SHEET NO. S-5
DATE	DESCRIPTION	DATE	DESCRIPTION	EREZ DAYAN, P.E. LICENSE NUMBER: 62144 AVANT ENGINEERING GROUP, LLC 2699 LEE ROAD, SUITE 401 WINTER PARK, FL 32789		ROAD NO.	COUNTY	FINANCIAL PROJECT ID		
						SR 739	LEE	446293-1-52-01		

THE OFFICIAL RECORD OF THIS SHEET IS THE ELECTRONIC FILE DIGITALLY SIGNED AND SEALED UNDER RULE 61G15-23.004, F.A.C.

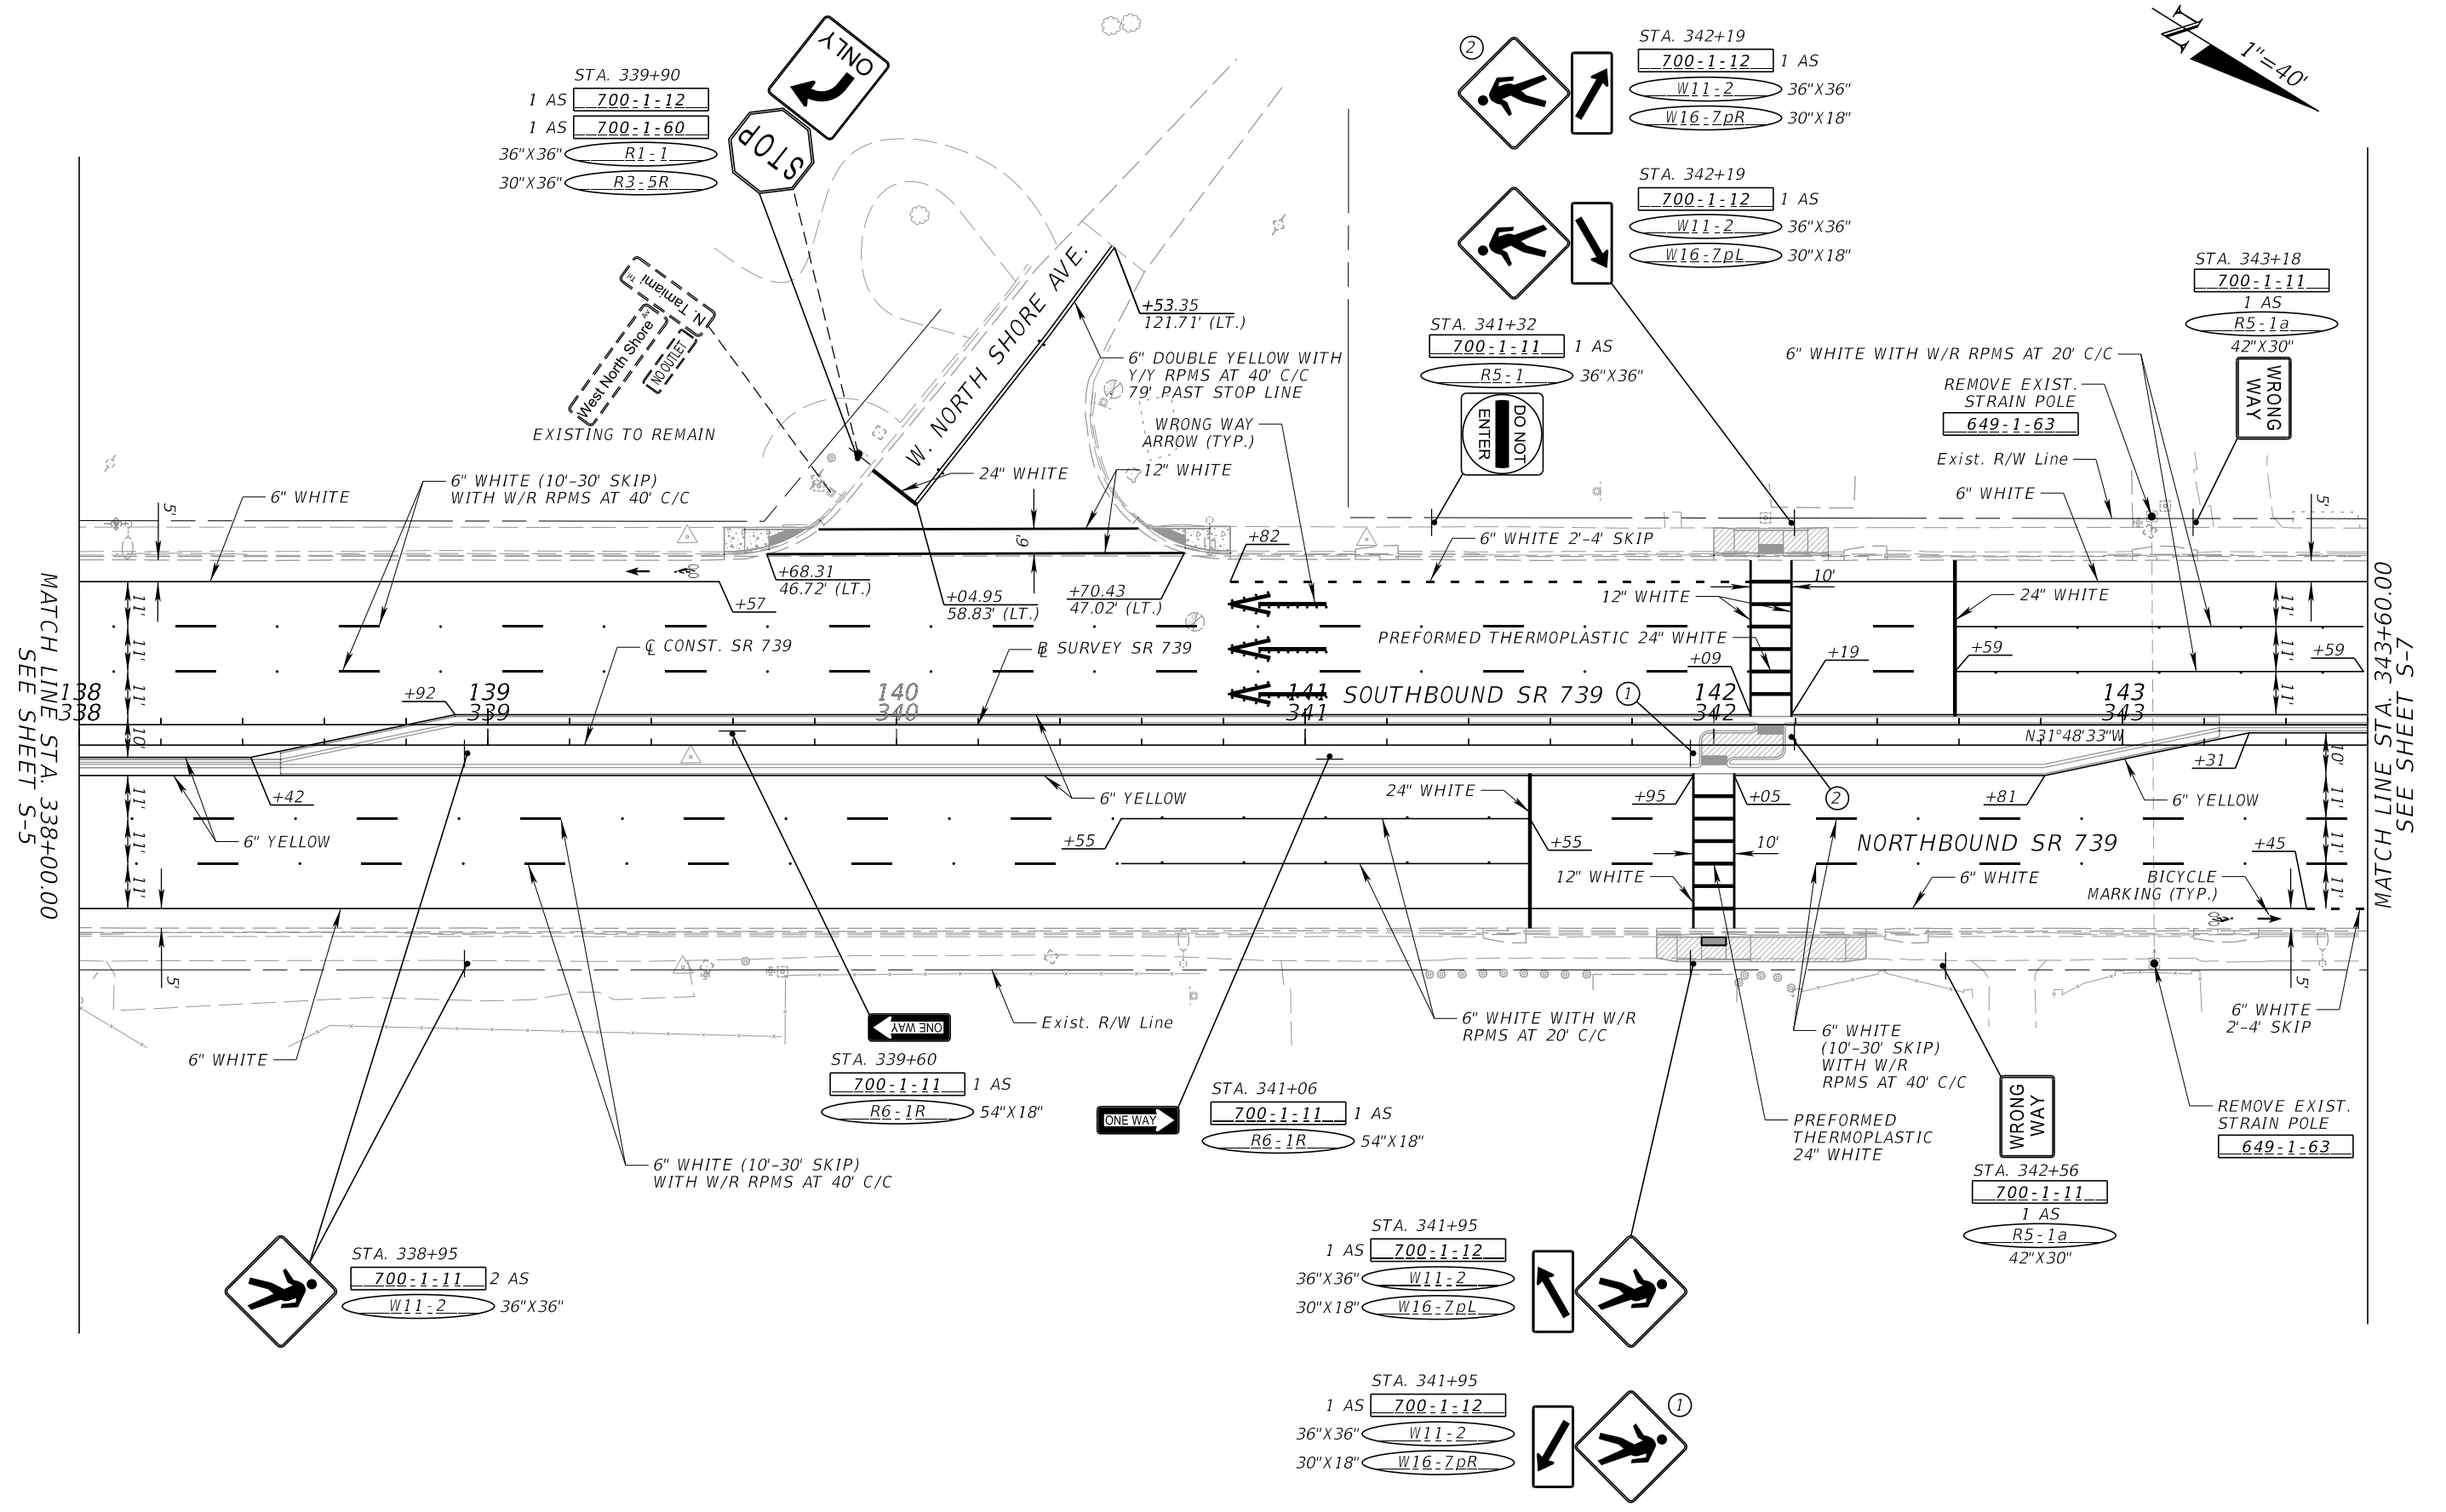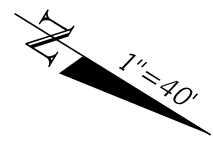

MATCH LINE STA. 338+00.00
SEE SHEET S-5


MATCH LINE STA. 343+60.00
SEE SHEET S-7

8/14/2023 9:03:56 PM LizetteMartinez
P:\FDOT\44629315201\SigningAndMarking\PLANS\SP01.dgn

REVISIONS				ENGINEER OF RECORD		STATE OF FLORIDA DEPARTMENT OF TRANSPORTATION			SIGNING AND PAVEMENT MARKING PLAN (4)	SHEET NO. S-6
DATE	DESCRIPTION	DATE	DESCRIPTION			ROAD NO.	COUNTY	FINANCIAL PROJECT ID		
				EREZ DAYAN, P.E. LICENSE NUMBER: 62144 AVANT ENGINEERING GROUP, LLC 2699 LEE ROAD, SUITE 401 WINTER PARK, FL 32789		SR 739	LEE	446293-1-52-01		

THE OFFICIAL RECORD OF THIS SHEET IS THE ELECTRONIC FILE DIGITALLY SIGNED AND SEALED UNDER RULE 61G15-23.004, F.A.C.

8/14/2023 9:03:58 PM LizetteMartinez P:\FDOT\44629315201\SigningAndMarking\PLANS\SP01.dgn

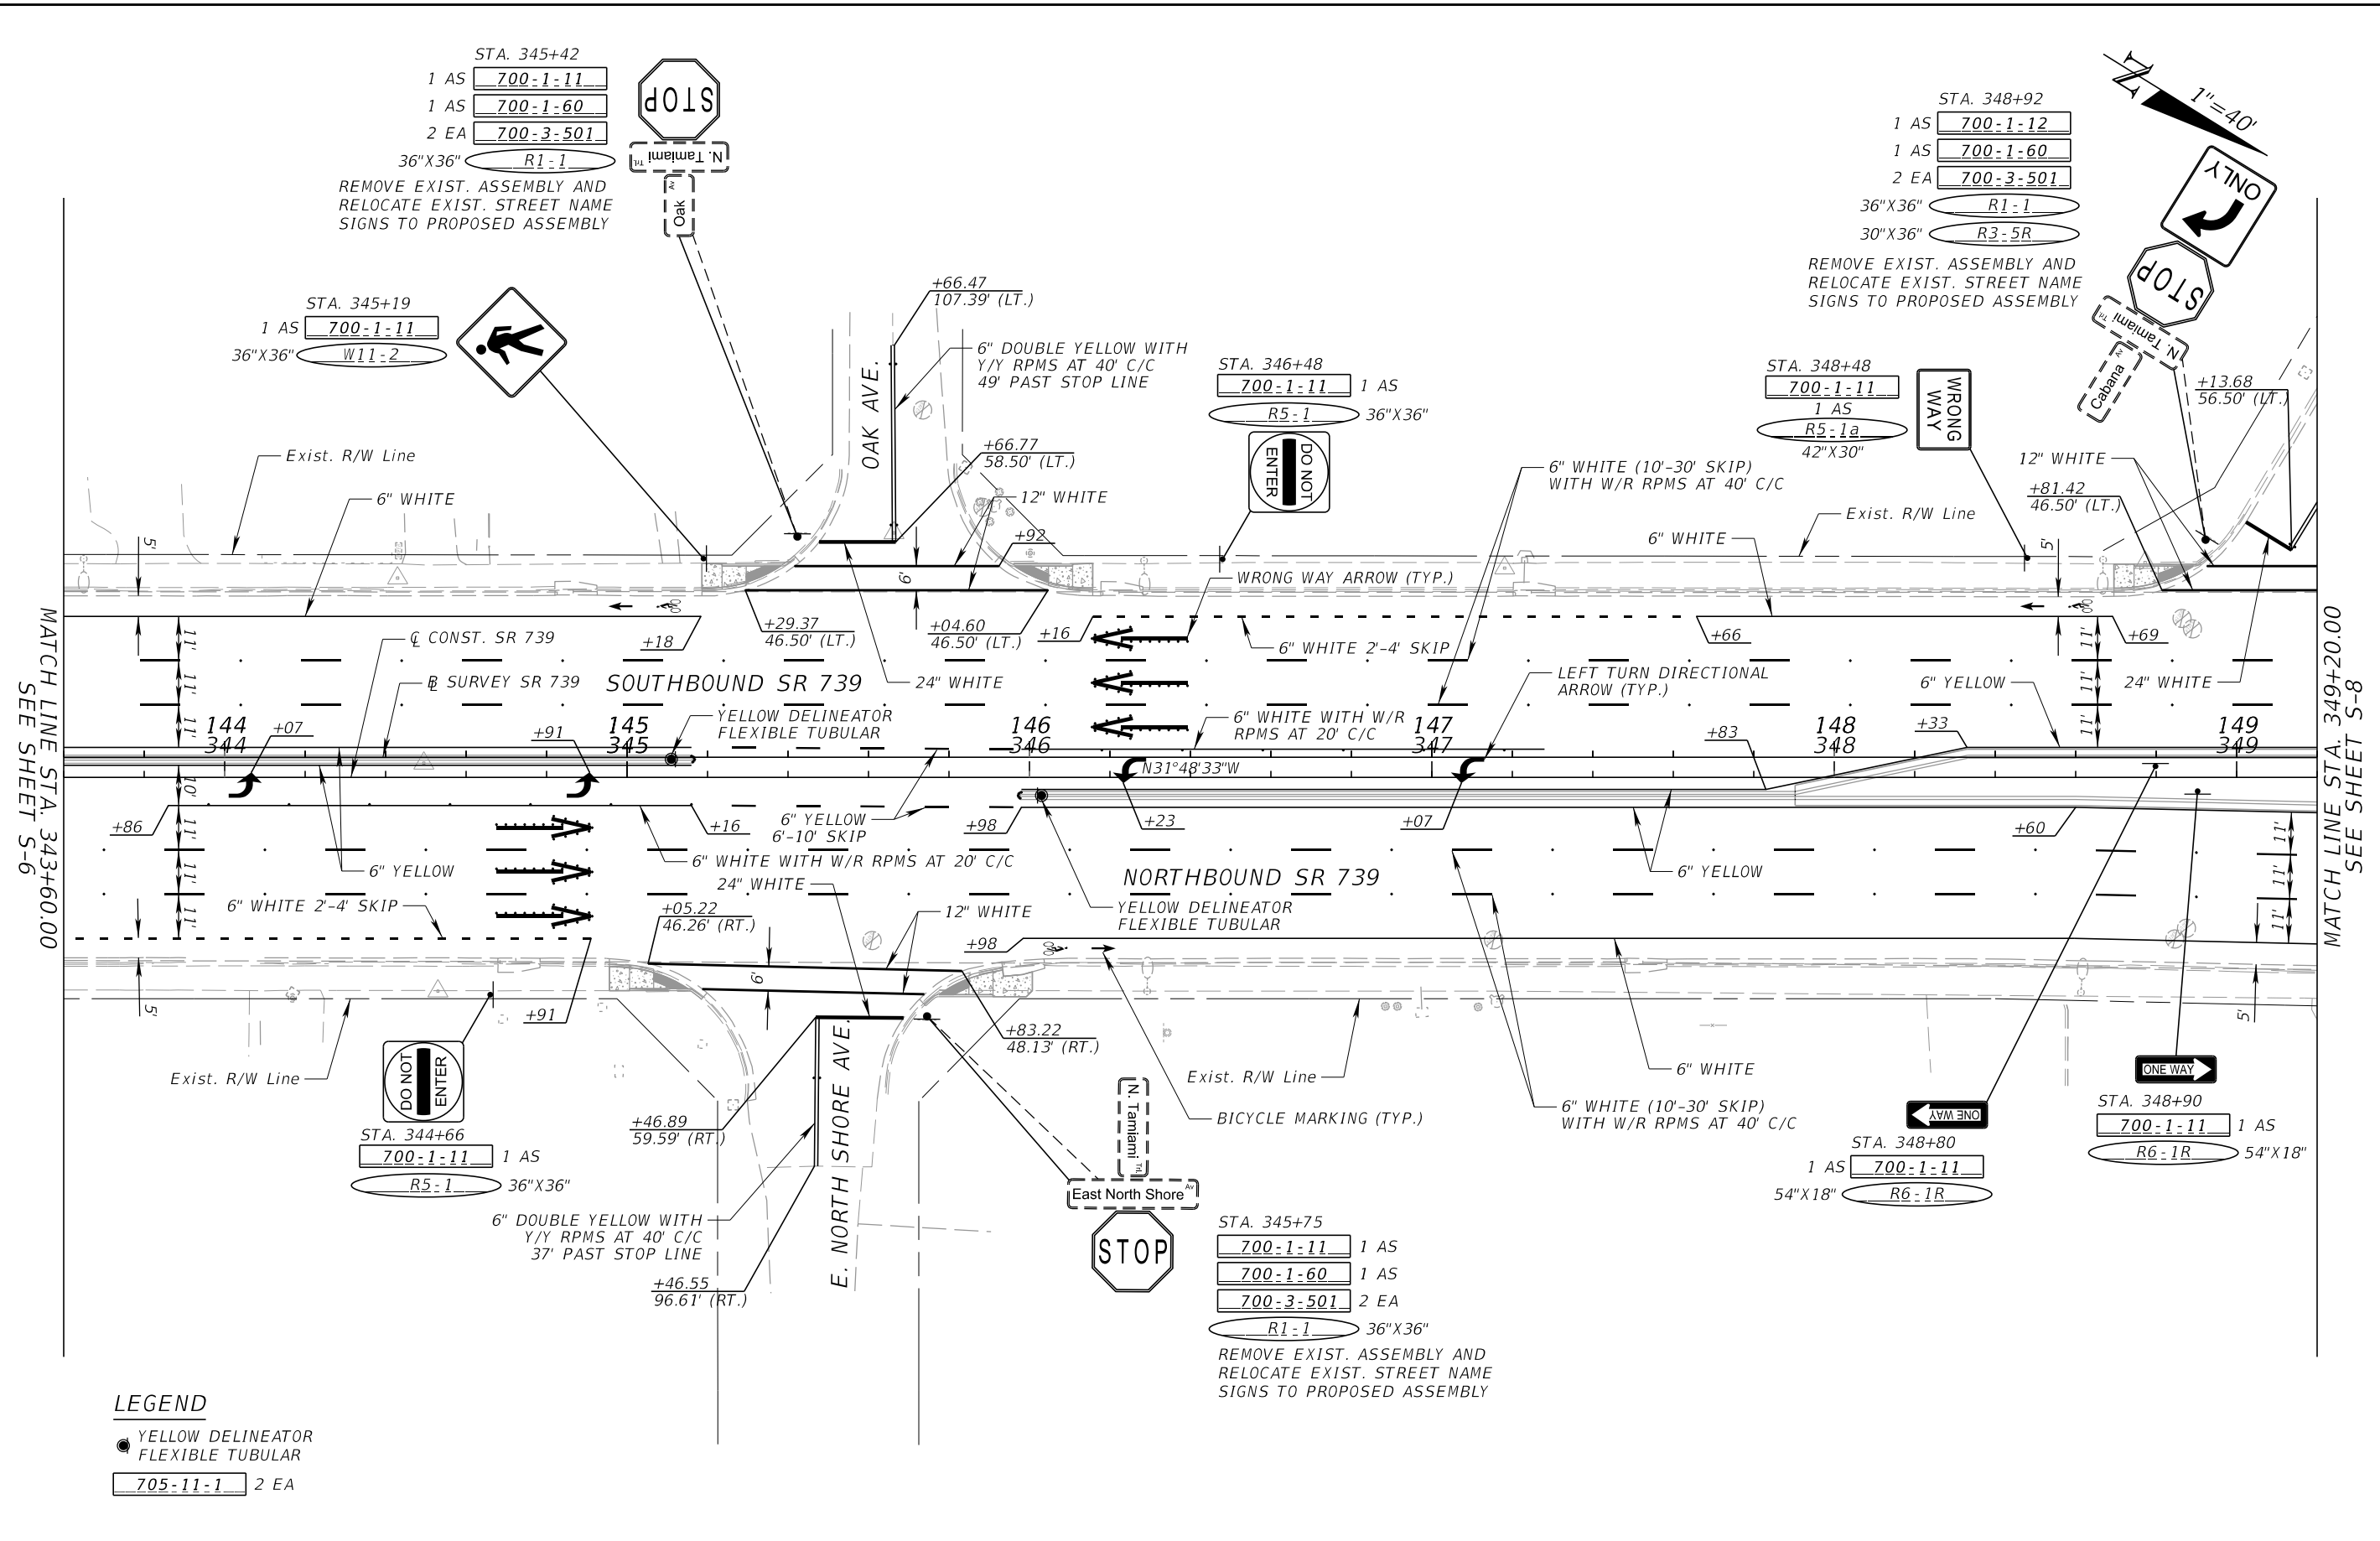


LEGEND

- YELLOW DELINEATOR FLEXIBLE TUBULAR
- 705-11-1 2 EA

REVISIONS				ENGINEER OF RECORD		STATE OF FLORIDA DEPARTMENT OF TRANSPORTATION			SHEET NO.
DATE	DESCRIPTION	DATE	DESCRIPTION	EREZ DAYAN, P.E. LICENSE NUMBER: 62144 AVANT ENGINEERING GROUP, LLC 2699 LEE ROAD, SUITE 401 WINTER PARK, FL 32789		ROAD NO.	COUNTY	FINANCIAL PROJECT ID	
						SR 739	LEE	446293-1-52-01	
SIGNING AND PAVEMENT MARKING PLAN (5)									S-7



THE OFFICIAL RECORD OF THIS SHEET IS THE ELECTRONIC FILE DIGITALLY SIGNED AND SEALED UNDER RULE 61G15-23.004, F.A.C.

8/14/2023 9:03:59 PM LizetteMartinez P:\FDOT\44629315201\SigningAndMarking\PLANS\SP01.dgn

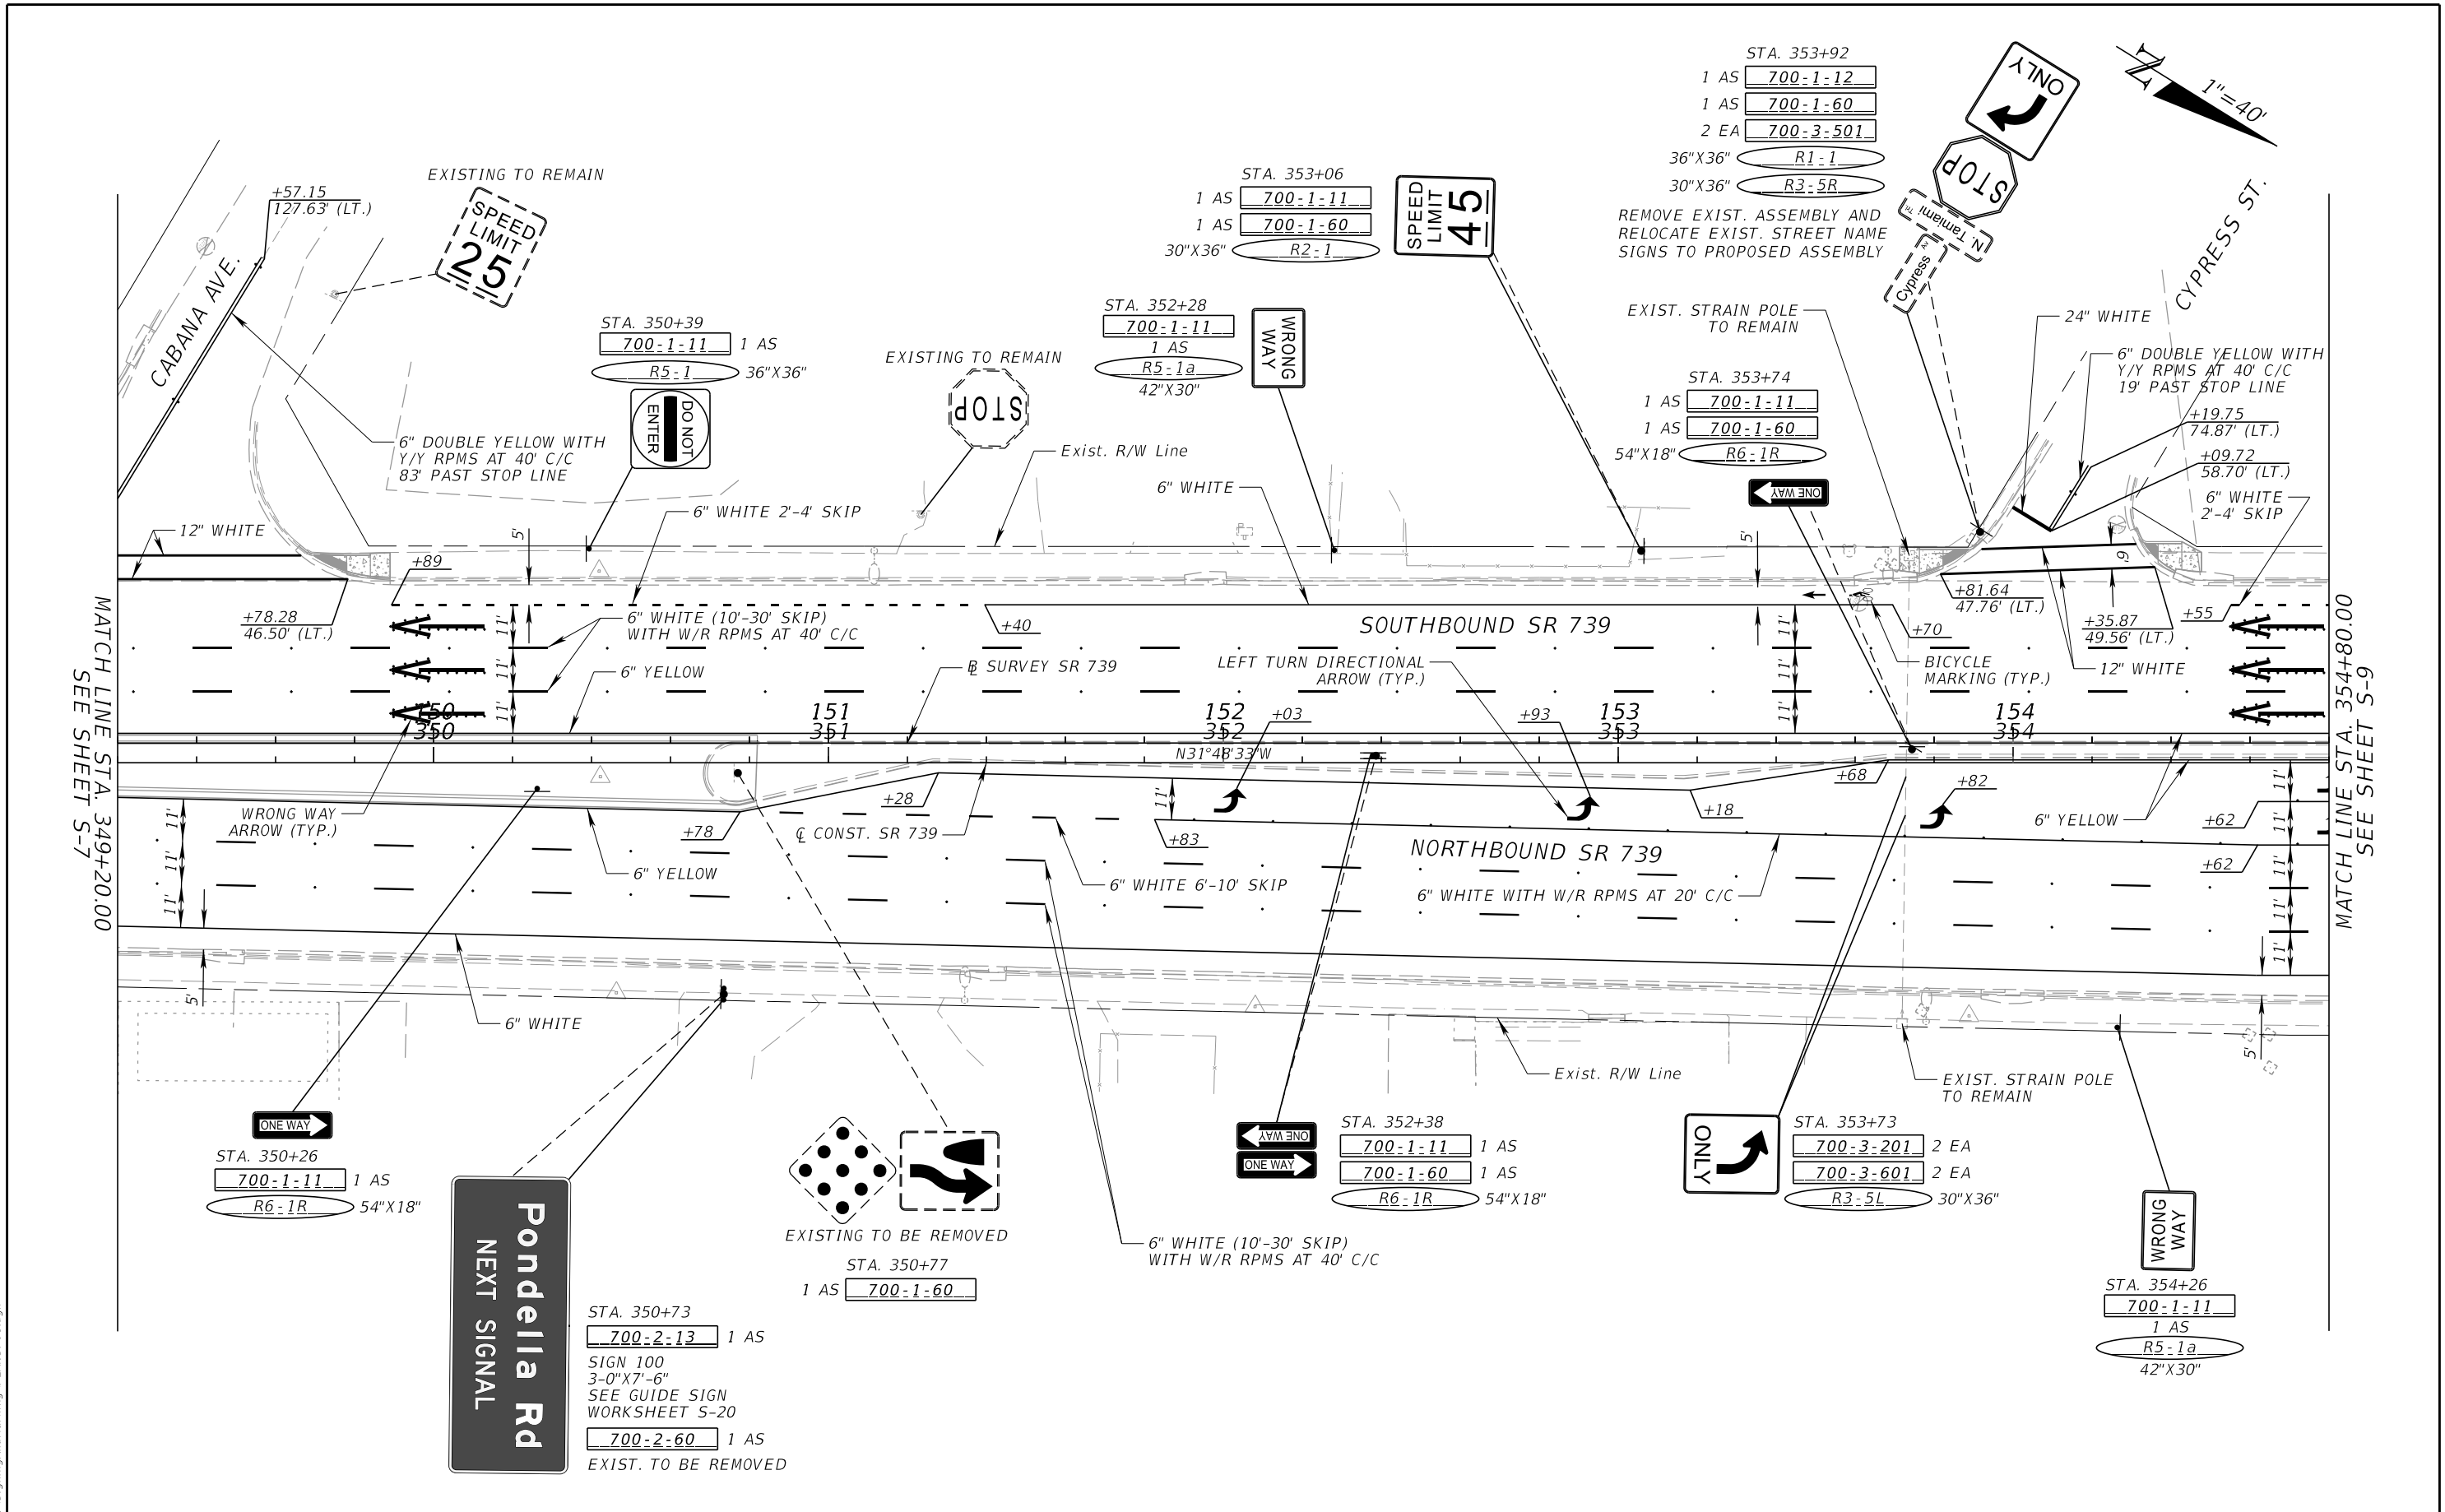

REVISIONS				ENGINEER OF RECORD		STATE OF FLORIDA DEPARTMENT OF TRANSPORTATION			SHEET NO.
DATE	DESCRIPTION	DATE	DESCRIPTION			ROAD NO.	COUNTY	FINANCIAL PROJECT ID	
				EREZ DAYAN, P.E. LICENSE NUMBER: 62144 AVANT ENGINEERING GROUP, LLC 2699 LEE ROAD, SUITE 401 WINTER PARK, FL 32789		SR 739	LEE	446293-1-52-01	
SIGNING AND PAVEMENT MARKING PLAN (6)									S-8

THE OFFICIAL RECORD OF THIS SHEET IS THE ELECTRONIC FILE DIGITALLY SIGNED AND SEALED UNDER RULE 61G15-23.004, F.A.C.

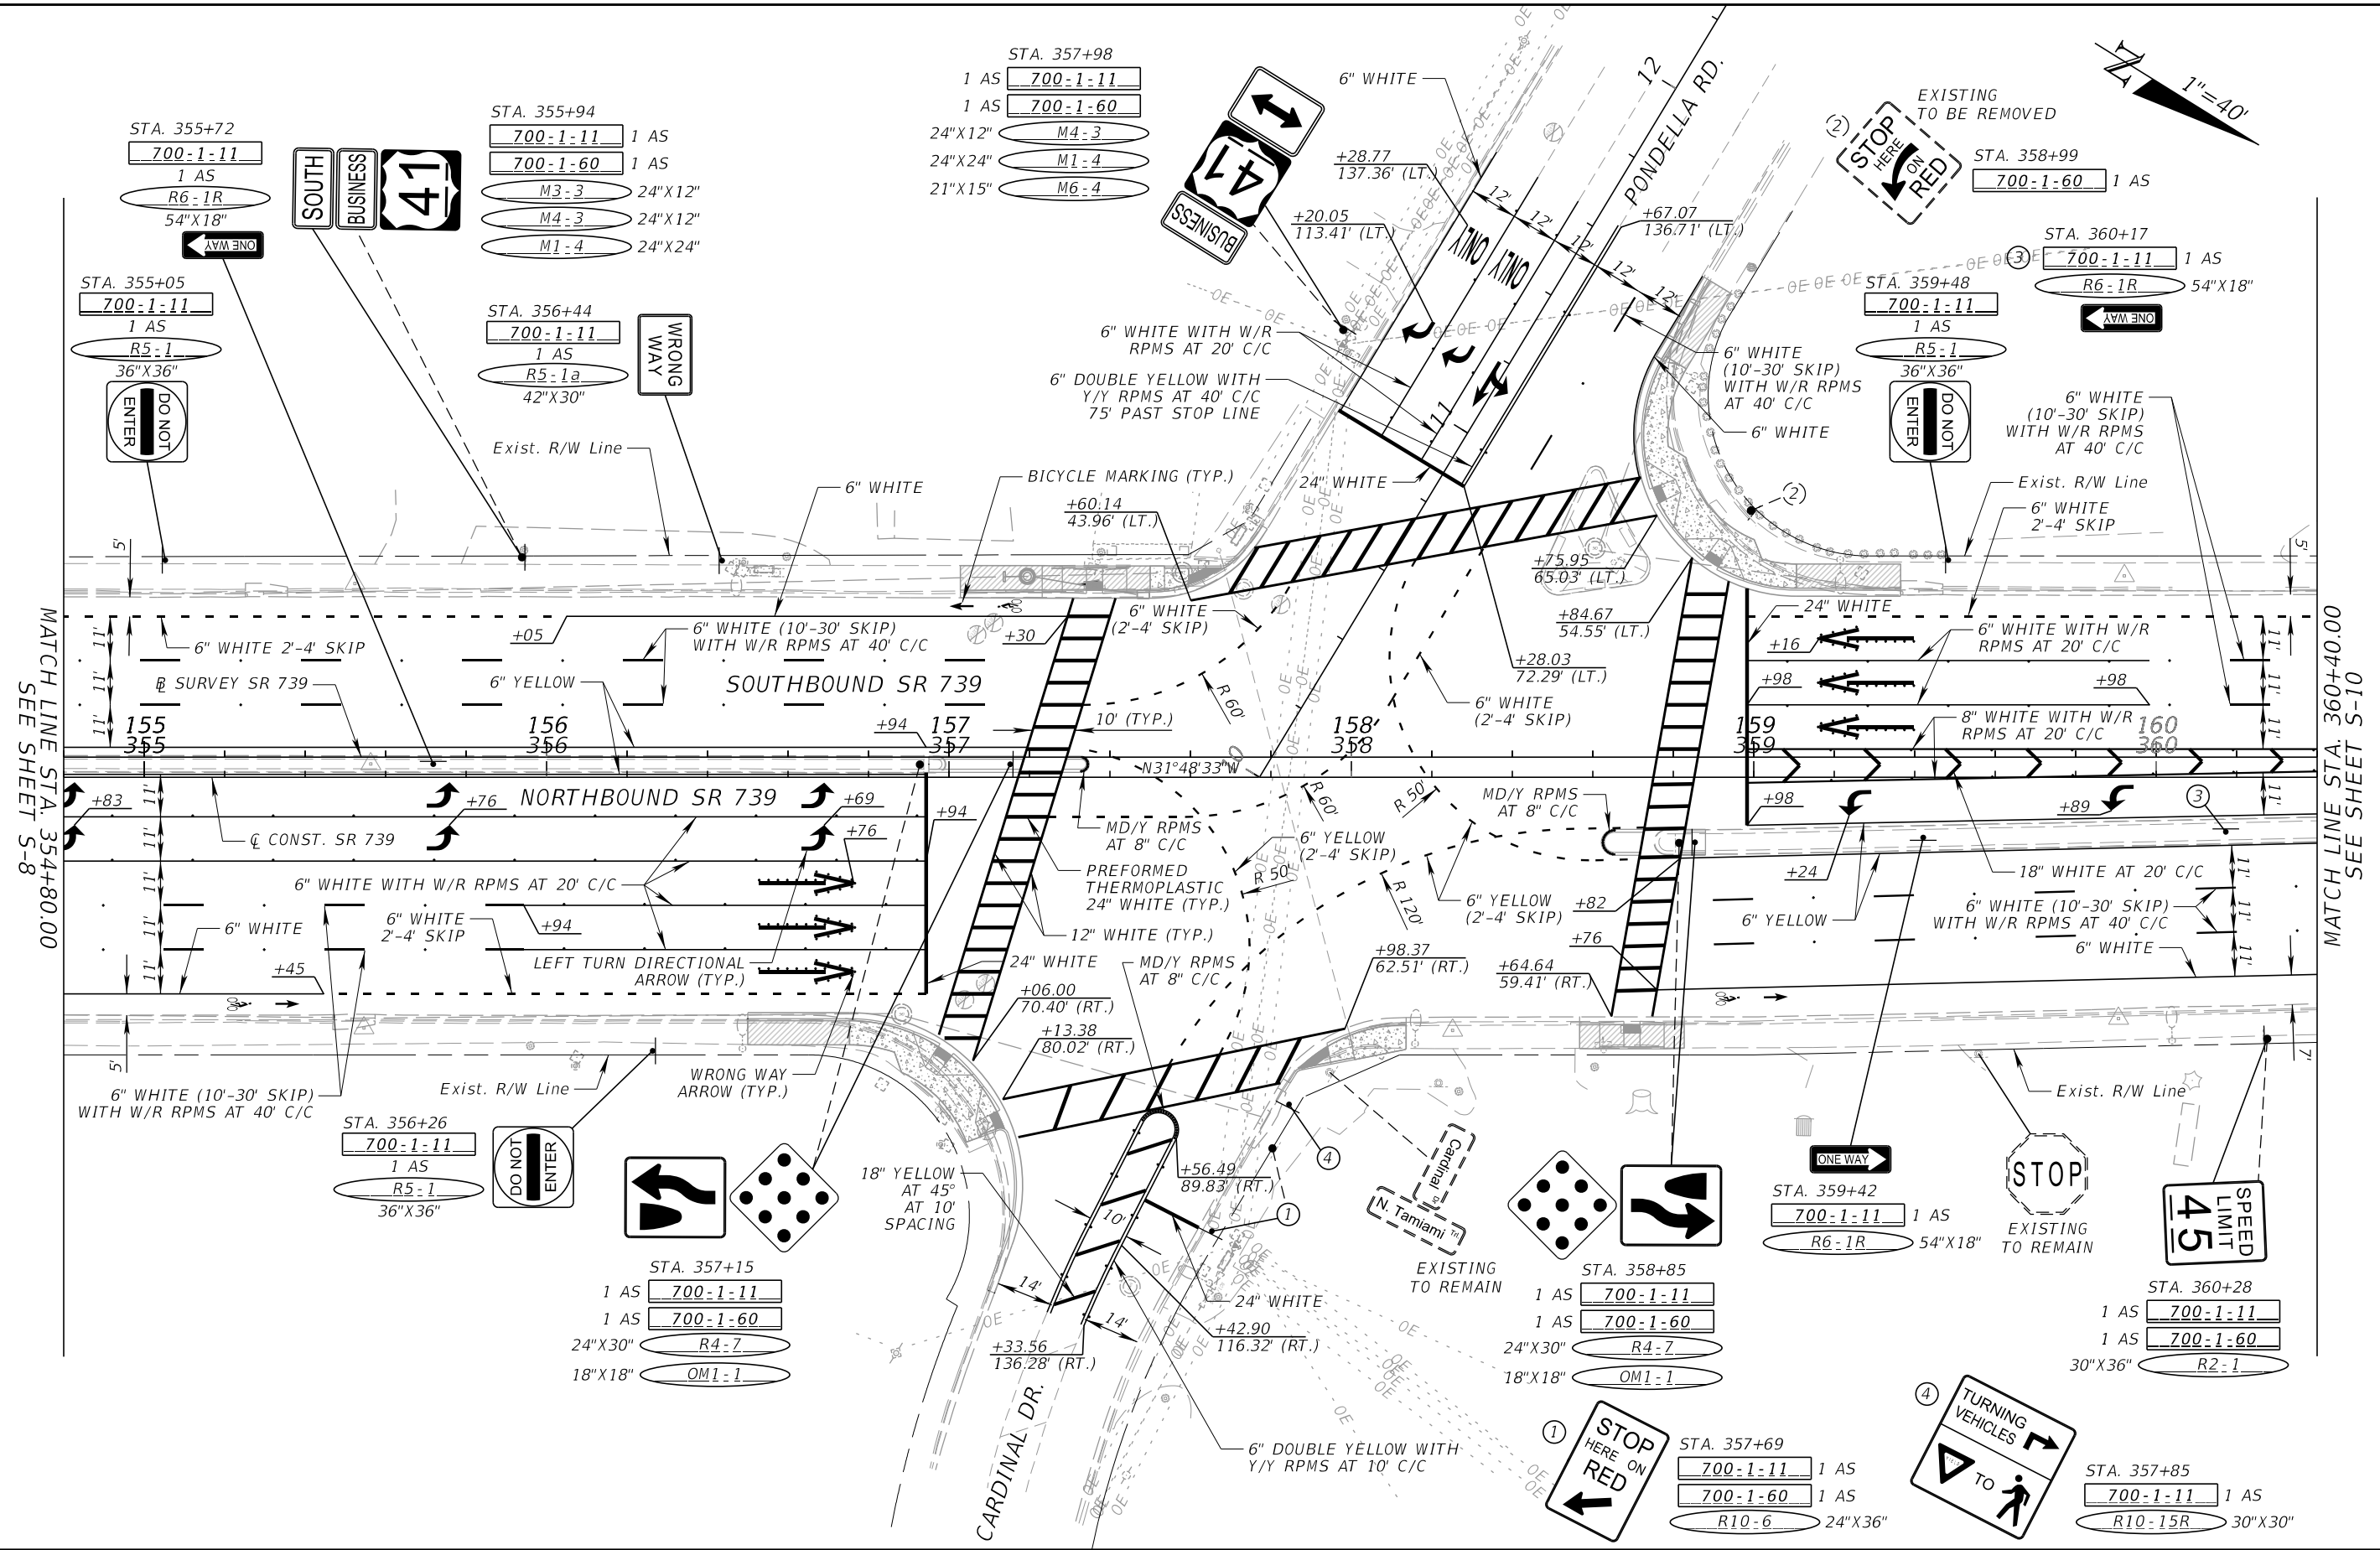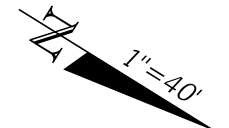


MATCH LINE STA. 354+80.00
SEE SHEET S-8

MATCH LINE STA. 360+40.00
SEE SHEET S-10

8/14/2023 9:04:01 PM LizetteMartinez
P:\FDDT\446293\15201\SigningAndMarking\PLANS\PO1.dgn

THE OFFICIAL RECORD OF THIS SHEET IS THE ELECTRONIC FILE DIGITALLY SIGNED AND SEALED UNDER RULE 61G15-23.004, F.A.C.

REVISIONS		REVISIONS		ENGINEER OF RECORD	STATE OF FLORIDA DEPARTMENT OF TRANSPORTATION			SHEET NO.
DATE	DESCRIPTION	DATE	DESCRIPTION		ROAD NO.	COUNTY	FINANCIAL PROJECT ID	
				EREZ DAYAN, P.E. LICENSE NUMBER: 62144 AVANT ENGINEERING GROUP, LLC 2699 LEE ROAD, SUITE 401 WINTER PARK, FL 32789	SR 739	LEE	446293-1-52-01	SIGNING AND PAVEMENT MARKING PLAN (7) S-9

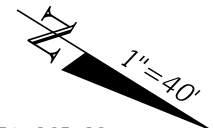

- STA. 364+00
700-2-13 1 AS
SIGN 100
3-0" X 7'-6"
SEE GUIDE SIGN
WORKSHEET S-20
700-2-60 1 AS
EXIST. TO BE REMOVED
- STA. 365+32
700-1-12 1 AS
R5-1 36" X 36"
R6-1R 54" X 18"
ONE WAY
DO NOT ENTER
- STA. 365+17
700-1-11 1 AS
R3-4 36" X 36"

Pondella Rd
NEXT SIGNAL

- STA. 363+51
1 AS 700-1-60
EXISTING TO BE REMOVED

- STA. 361+48
700-1-11 1 AS
R5-1a 42" X 30"
WRONG WAY
- STA. 361+86
700-1-11 1 AS
R6-1R 54" X 18"
ONE WAY


- STA. 361+20
700-1-11 1 AS
R6-1R 54" X 18"
ONE WAY

- STA. 361+92
700-1-11 1 AS
R5-1a 42" X 30"
WRONG WAY

- STA. 363+92
700-1-11 1 AS
R5-1 36" X 36"
DO NOT ENTER

- STA. 365+37
1 AS 700-1-12
1 AS 700-1-60
2 EA 700-3-501
36" X 36" R1-1
30" X 36" R3-5R

- LEGEND**
- YELLOW DELINEATOR FLEXIBLE TUBULAR
 - 705-11-1 2 EA

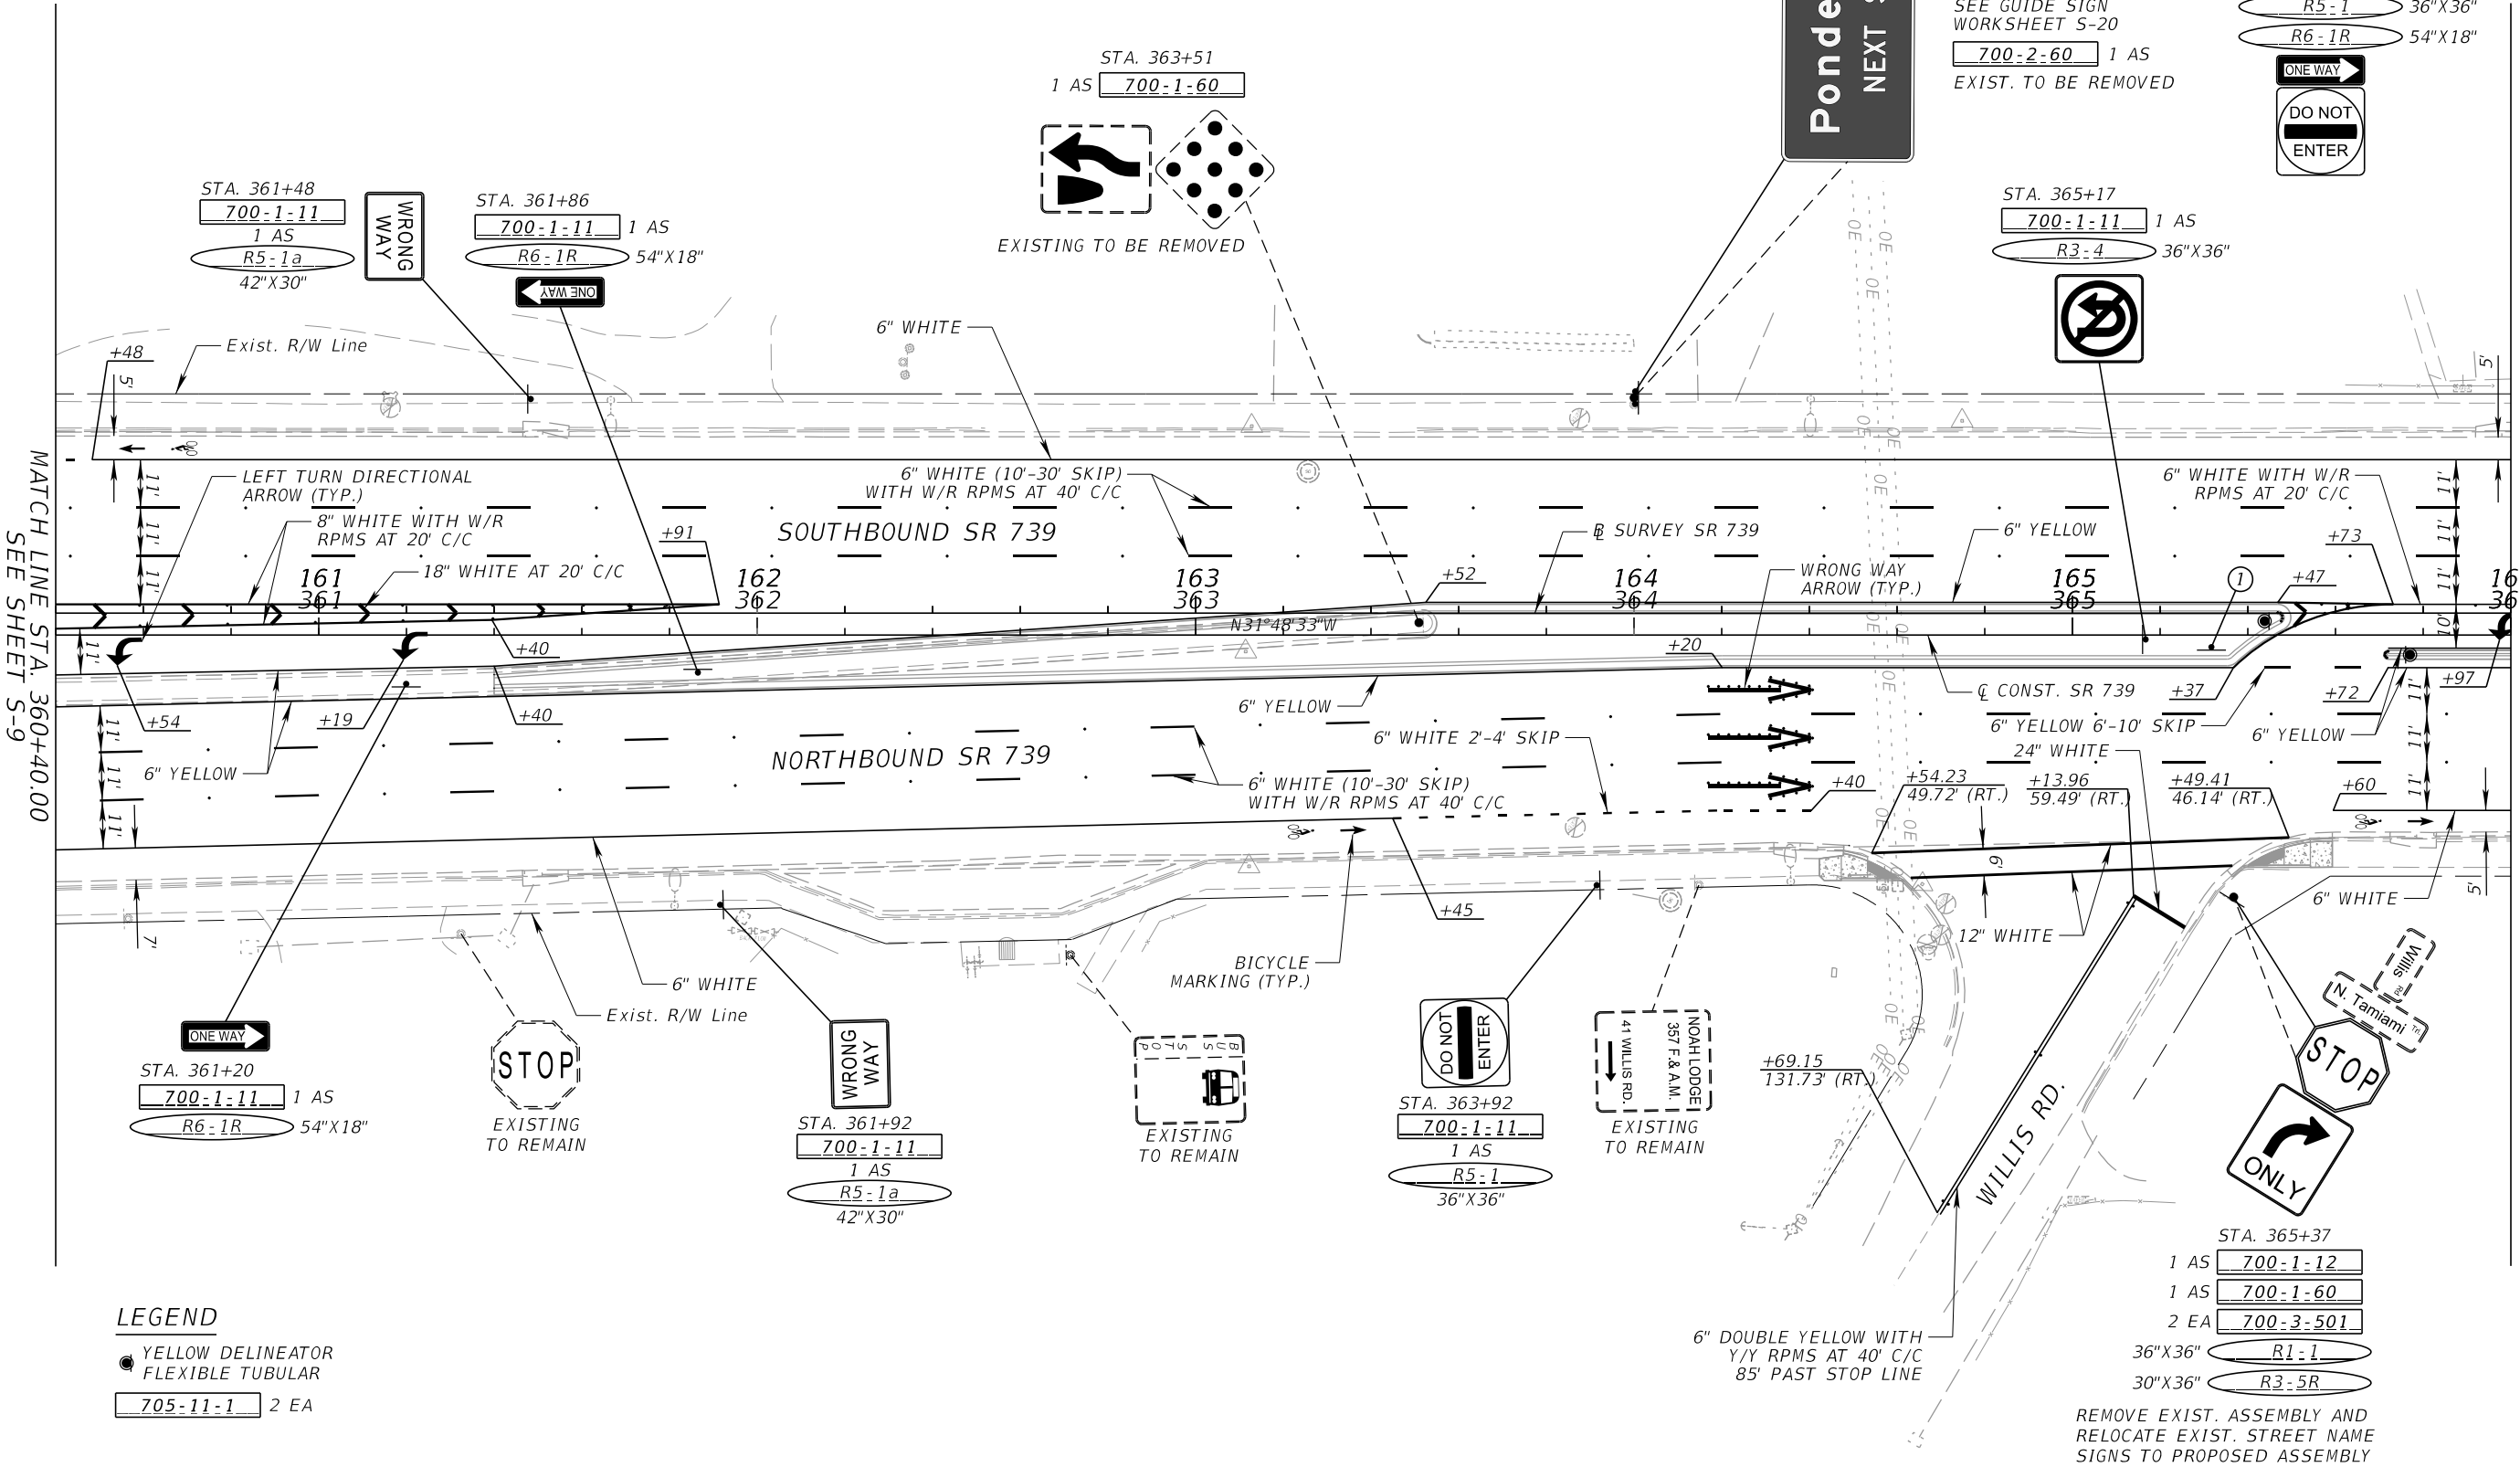

MATCH LINE STA. 360+40.00
SEE SHEET S-9

MATCH LINE STA. 366+00.00
SEE SHEET S-11



REMOVE EXIST. ASSEMBLY AND RELOCATE EXIST. STREET NAME SIGNS TO PROPOSED ASSEMBLY

8/14/2023 9:04:02 PM LizetteMartinez P:\FDDT\44629315201\SigningAndMarking\PLANS\SP01.dgn

REVISIONS		ENGINEER OF RECORD		STATE OF FLORIDA DEPARTMENT OF TRANSPORTATION			SHEET NO.
DATE	DESCRIPTION	DATE	DESCRIPTION	ROAD NO.	COUNTY	FINANCIAL PROJECT ID	
				SR 739	LEE	446293-1-52-01	

SIGNING AND PAVEMENT MARKING PLAN (8)

THE OFFICIAL RECORD OF THIS SHEET IS THE ELECTRONIC FILE DIGITALLY SIGNED AND SEALED UNDER RULE 61G15-23.004, F.A.C.

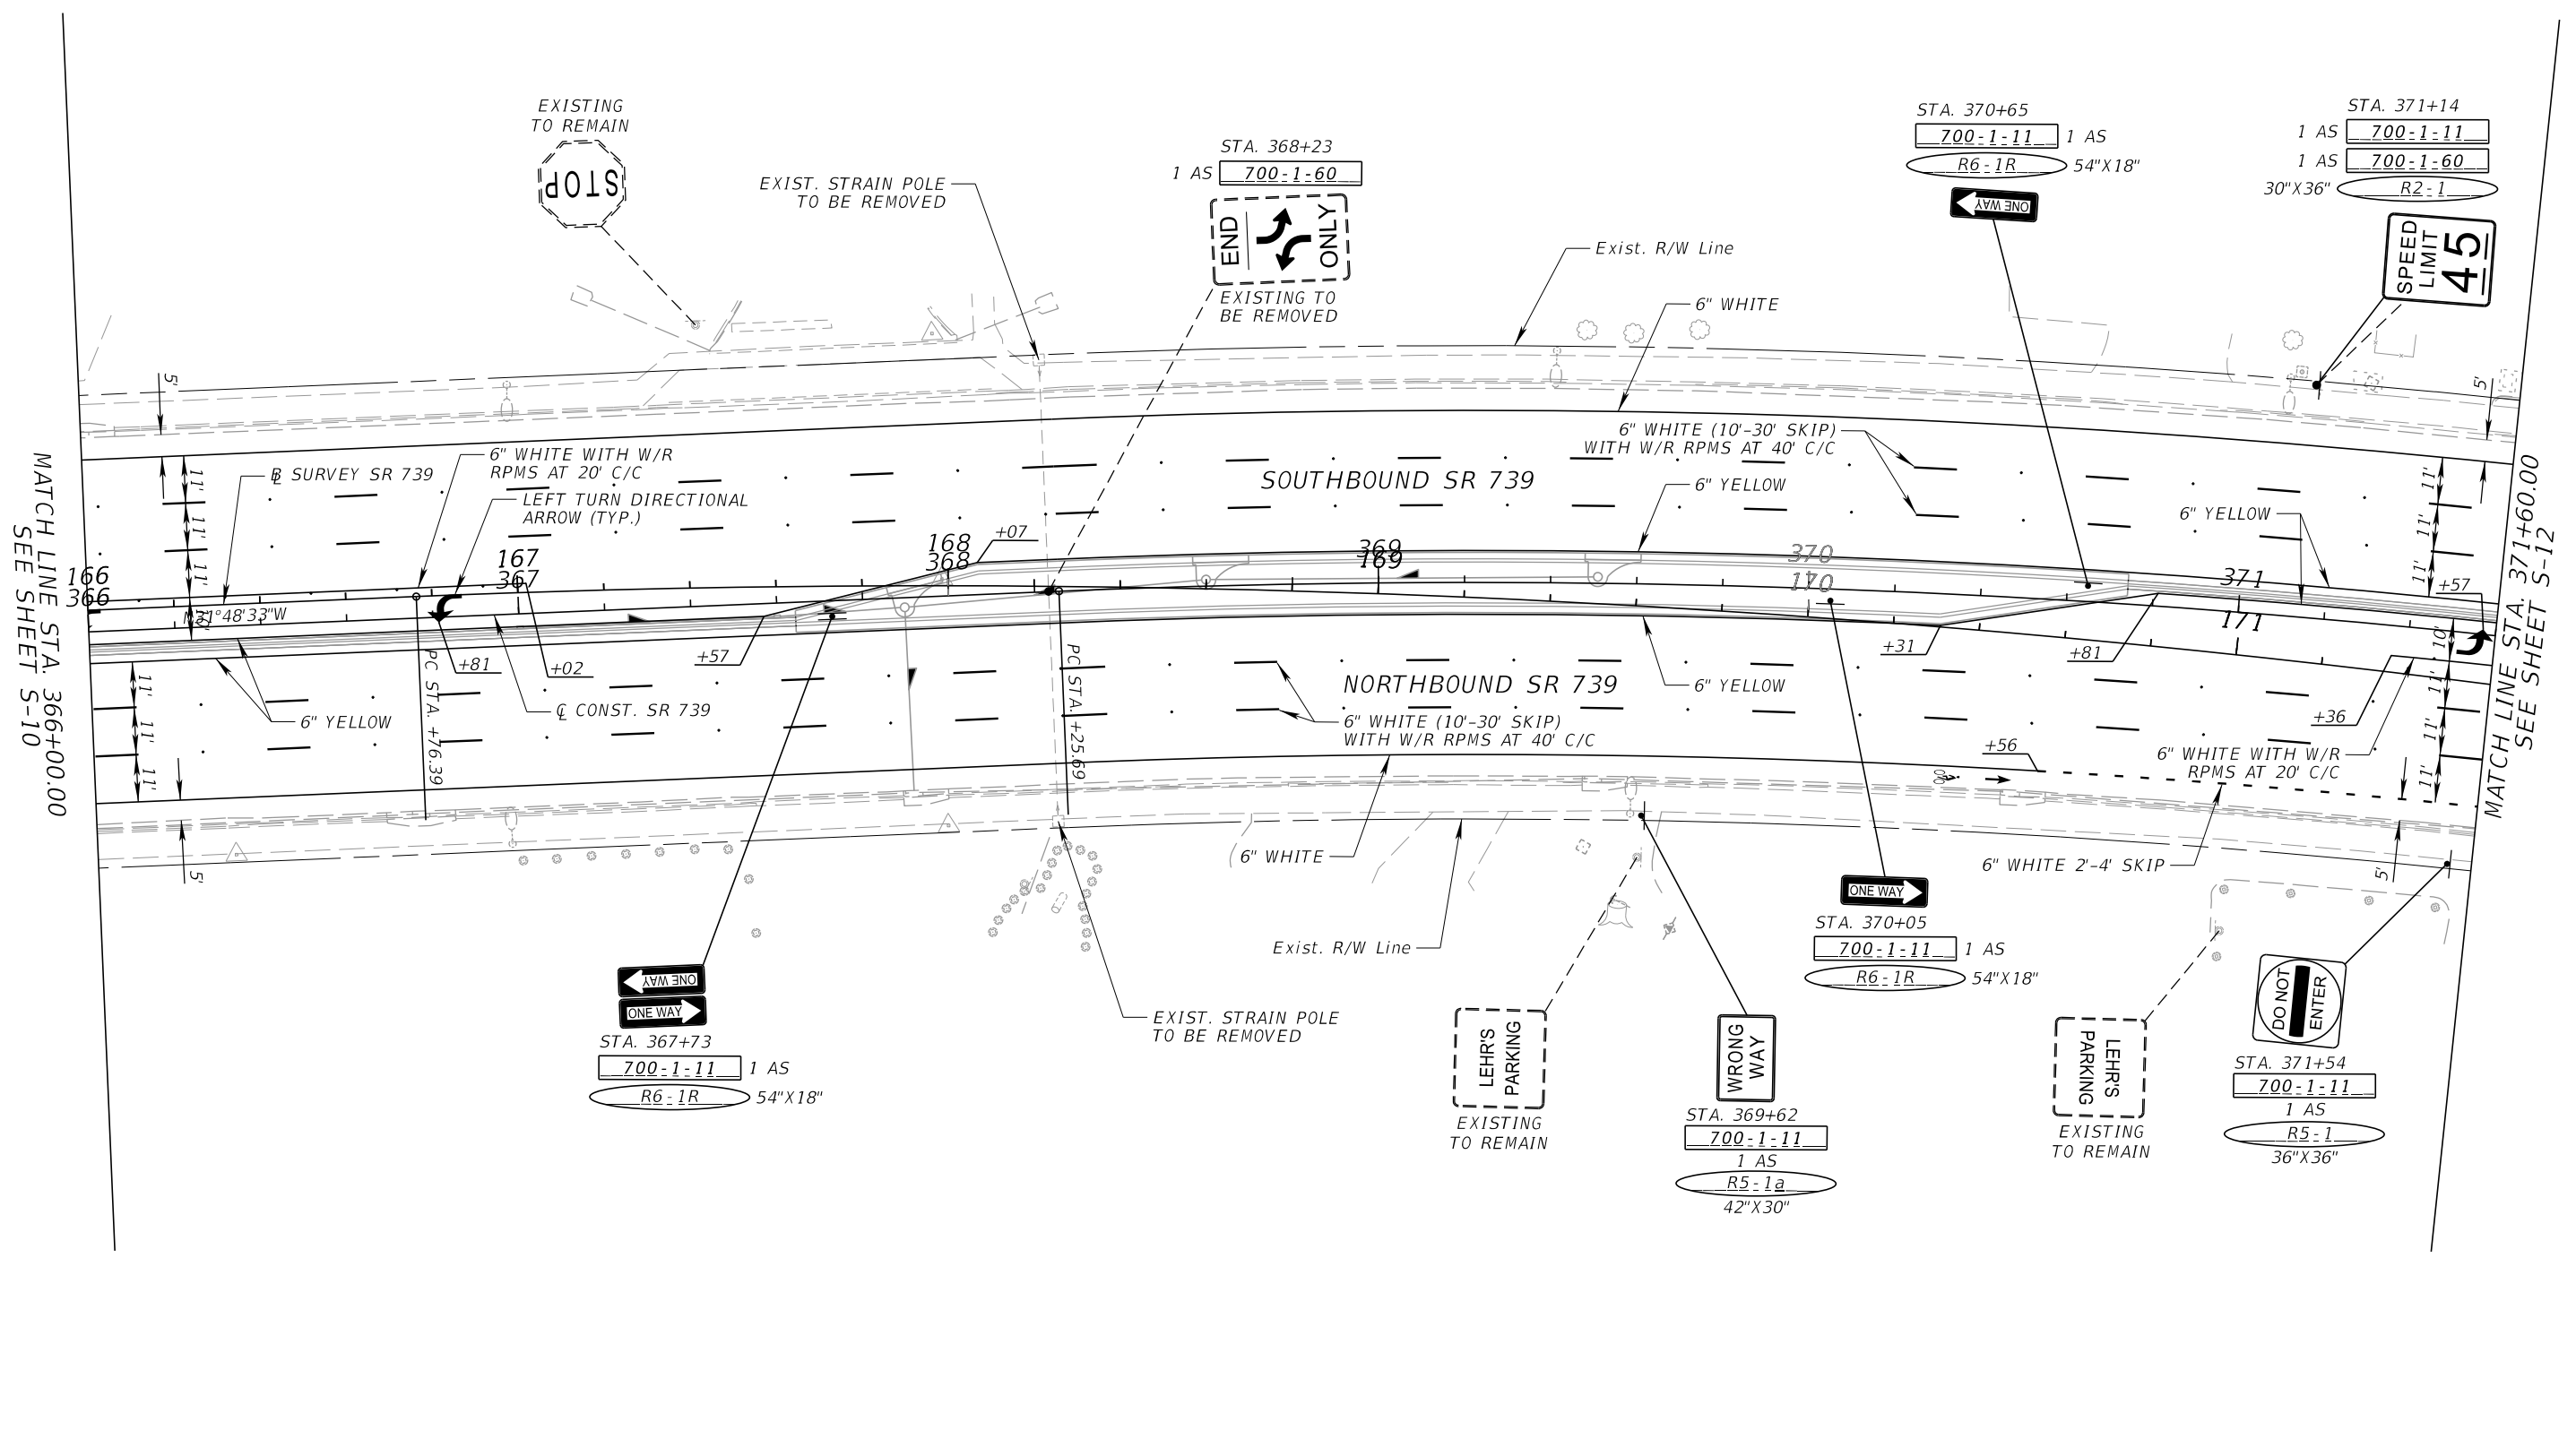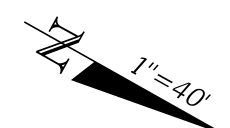

MATCH LINE STA. 366+00.00
SEE SHEET S-10


MATCH LINE STA. 371+60.00
SEE SHEET S-12

8/14/2023 9:04:03 PM LizetteMartinez
P:\FDOT\44629315201\SigningAndMarking\PLANS\01.dgn

THE OFFICIAL RECORD OF THIS SHEET IS THE ELECTRONIC FILE DIGITALLY SIGNED AND SEALED UNDER RULE 61G15-23.004, F.A.C.

REVISIONS				ENGINEER OF RECORD		STATE OF FLORIDA DEPARTMENT OF TRANSPORTATION			SIGNING AND PAVEMENT MARKING PLAN (9)	SHEET NO.
DATE	DESCRIPTION	DATE	DESCRIPTION	EREZ DAYAN, P.E. LICENSE NUMBER: 62144 AVANT ENGINEERING GROUP, LLC 2699 LEE ROAD, SUITE 401 WINTER PARK, FL 32789		ROAD NO.	COUNTY	FINANCIAL PROJECT ID		
						SR 739	LEE	446293-1-52-01		S-11

1"=40'

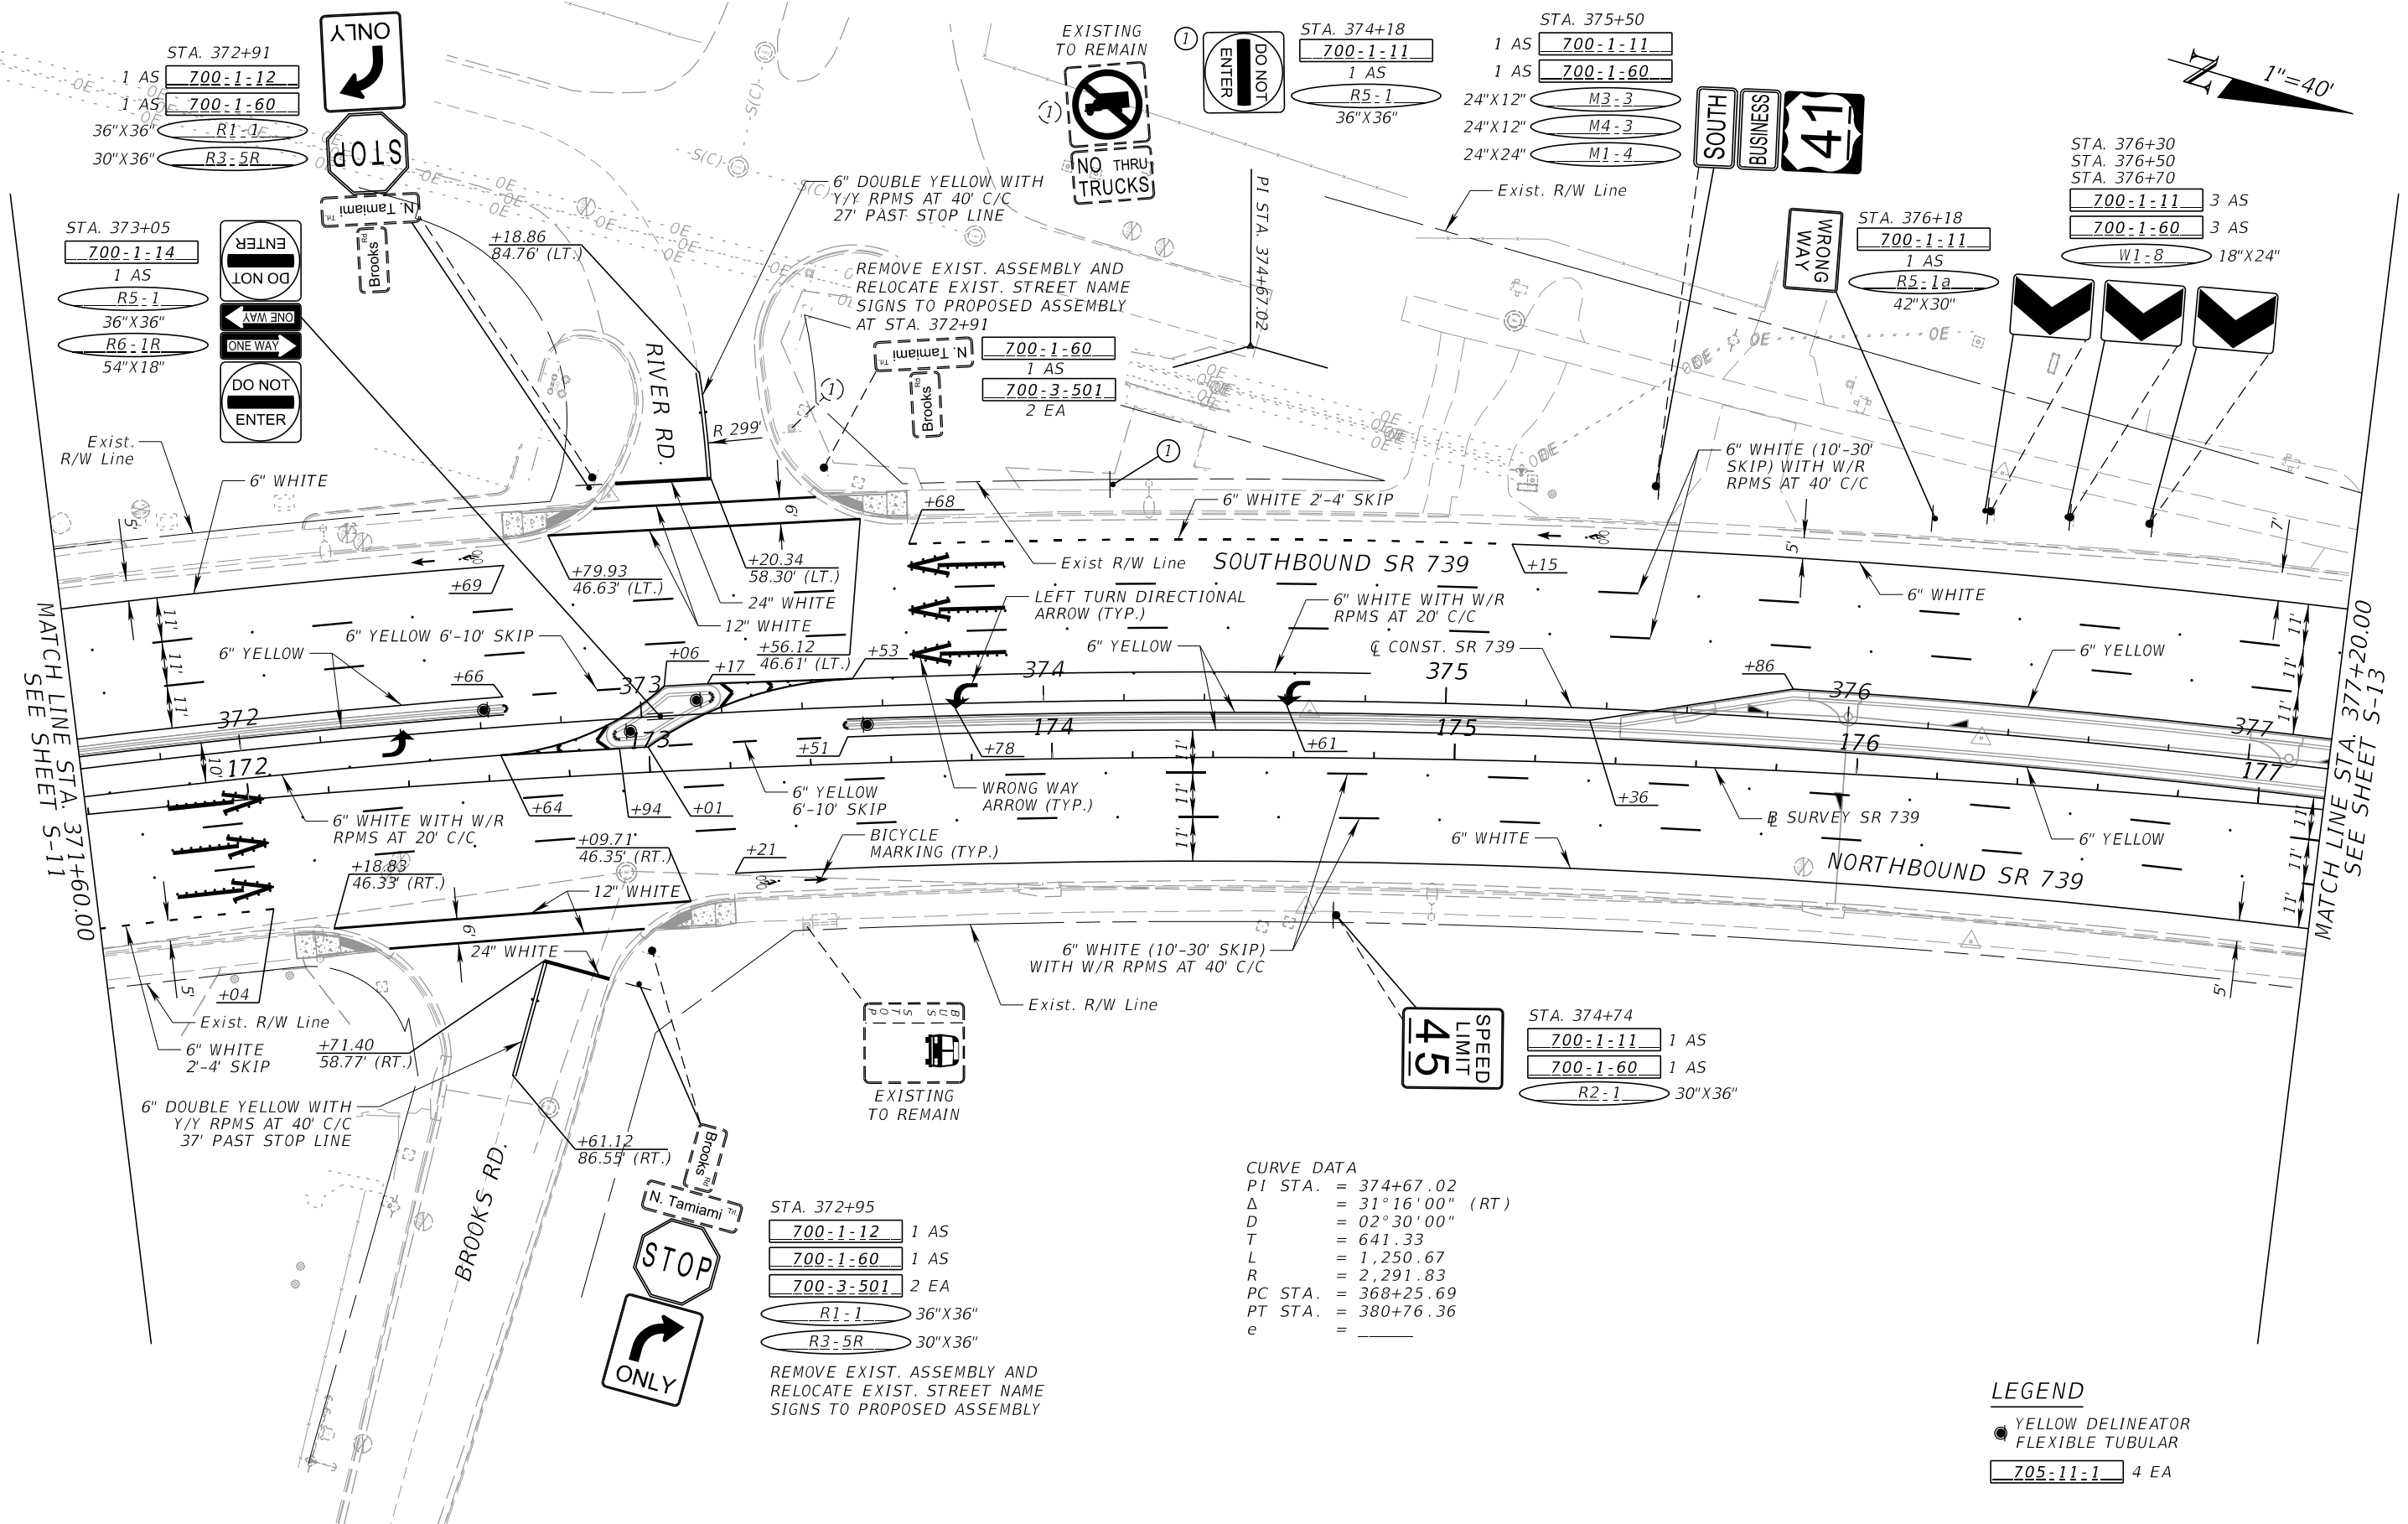

STA. 372+95
 700-1-12 1 AS
 700-1-60 1 AS
 700-3-501 2 EA
 R1-1 36"X36"
 R3-5R 30"X36"
 REMOVE EXIST. ASSEMBLY AND RELOCATE EXIST. STREET NAME SIGNS TO PROPOSED ASSEMBLY

CURVE DATA
 PI STA. = 374+67.02
 Δ = 31°16'00" (RT)
 D = 02°30'00"
 T = 641.33
 L = 1,250.67
 R = 2,291.83
 PC STA. = 368+25.69
 PT STA. = 380+76.36
 e =



LEGEND
 ● YELLOW DELINEATOR
 ● FLEXIBLE TUBULAR
 705-11-1 4 EA

8/14/2023 9:04:04 PM LizetteMartinez P:\FDDT\446293\15201\SigningAndMarking\PLANS\SP01.dgn

REVISIONS				ENGINEER OF RECORD		STATE OF FLORIDA DEPARTMENT OF TRANSPORTATION			SHEET NO. S-12
DATE	DESCRIPTION	DATE	DESCRIPTION	EREZ DAYAN, P.E. LICENSE NUMBER: 62144 AVANT ENGINEERING GROUP, LLC 2699 LEE ROAD, SUITE 401 WINTER PARK, FL 32789		ROAD NO.	COUNTY	FINANCIAL PROJECT ID	
						SR 739	LEE	446293-1-52-01	

**SIGNING AND PAVEMENT
MARKING PLAN (10)**

 THE OFFICIAL RECORD OF THIS SHEET IS THE ELECTRONIC FILE DIGITALLY SIGNED AND SEALED UNDER RULE 61G15-23.004, F.A.C.

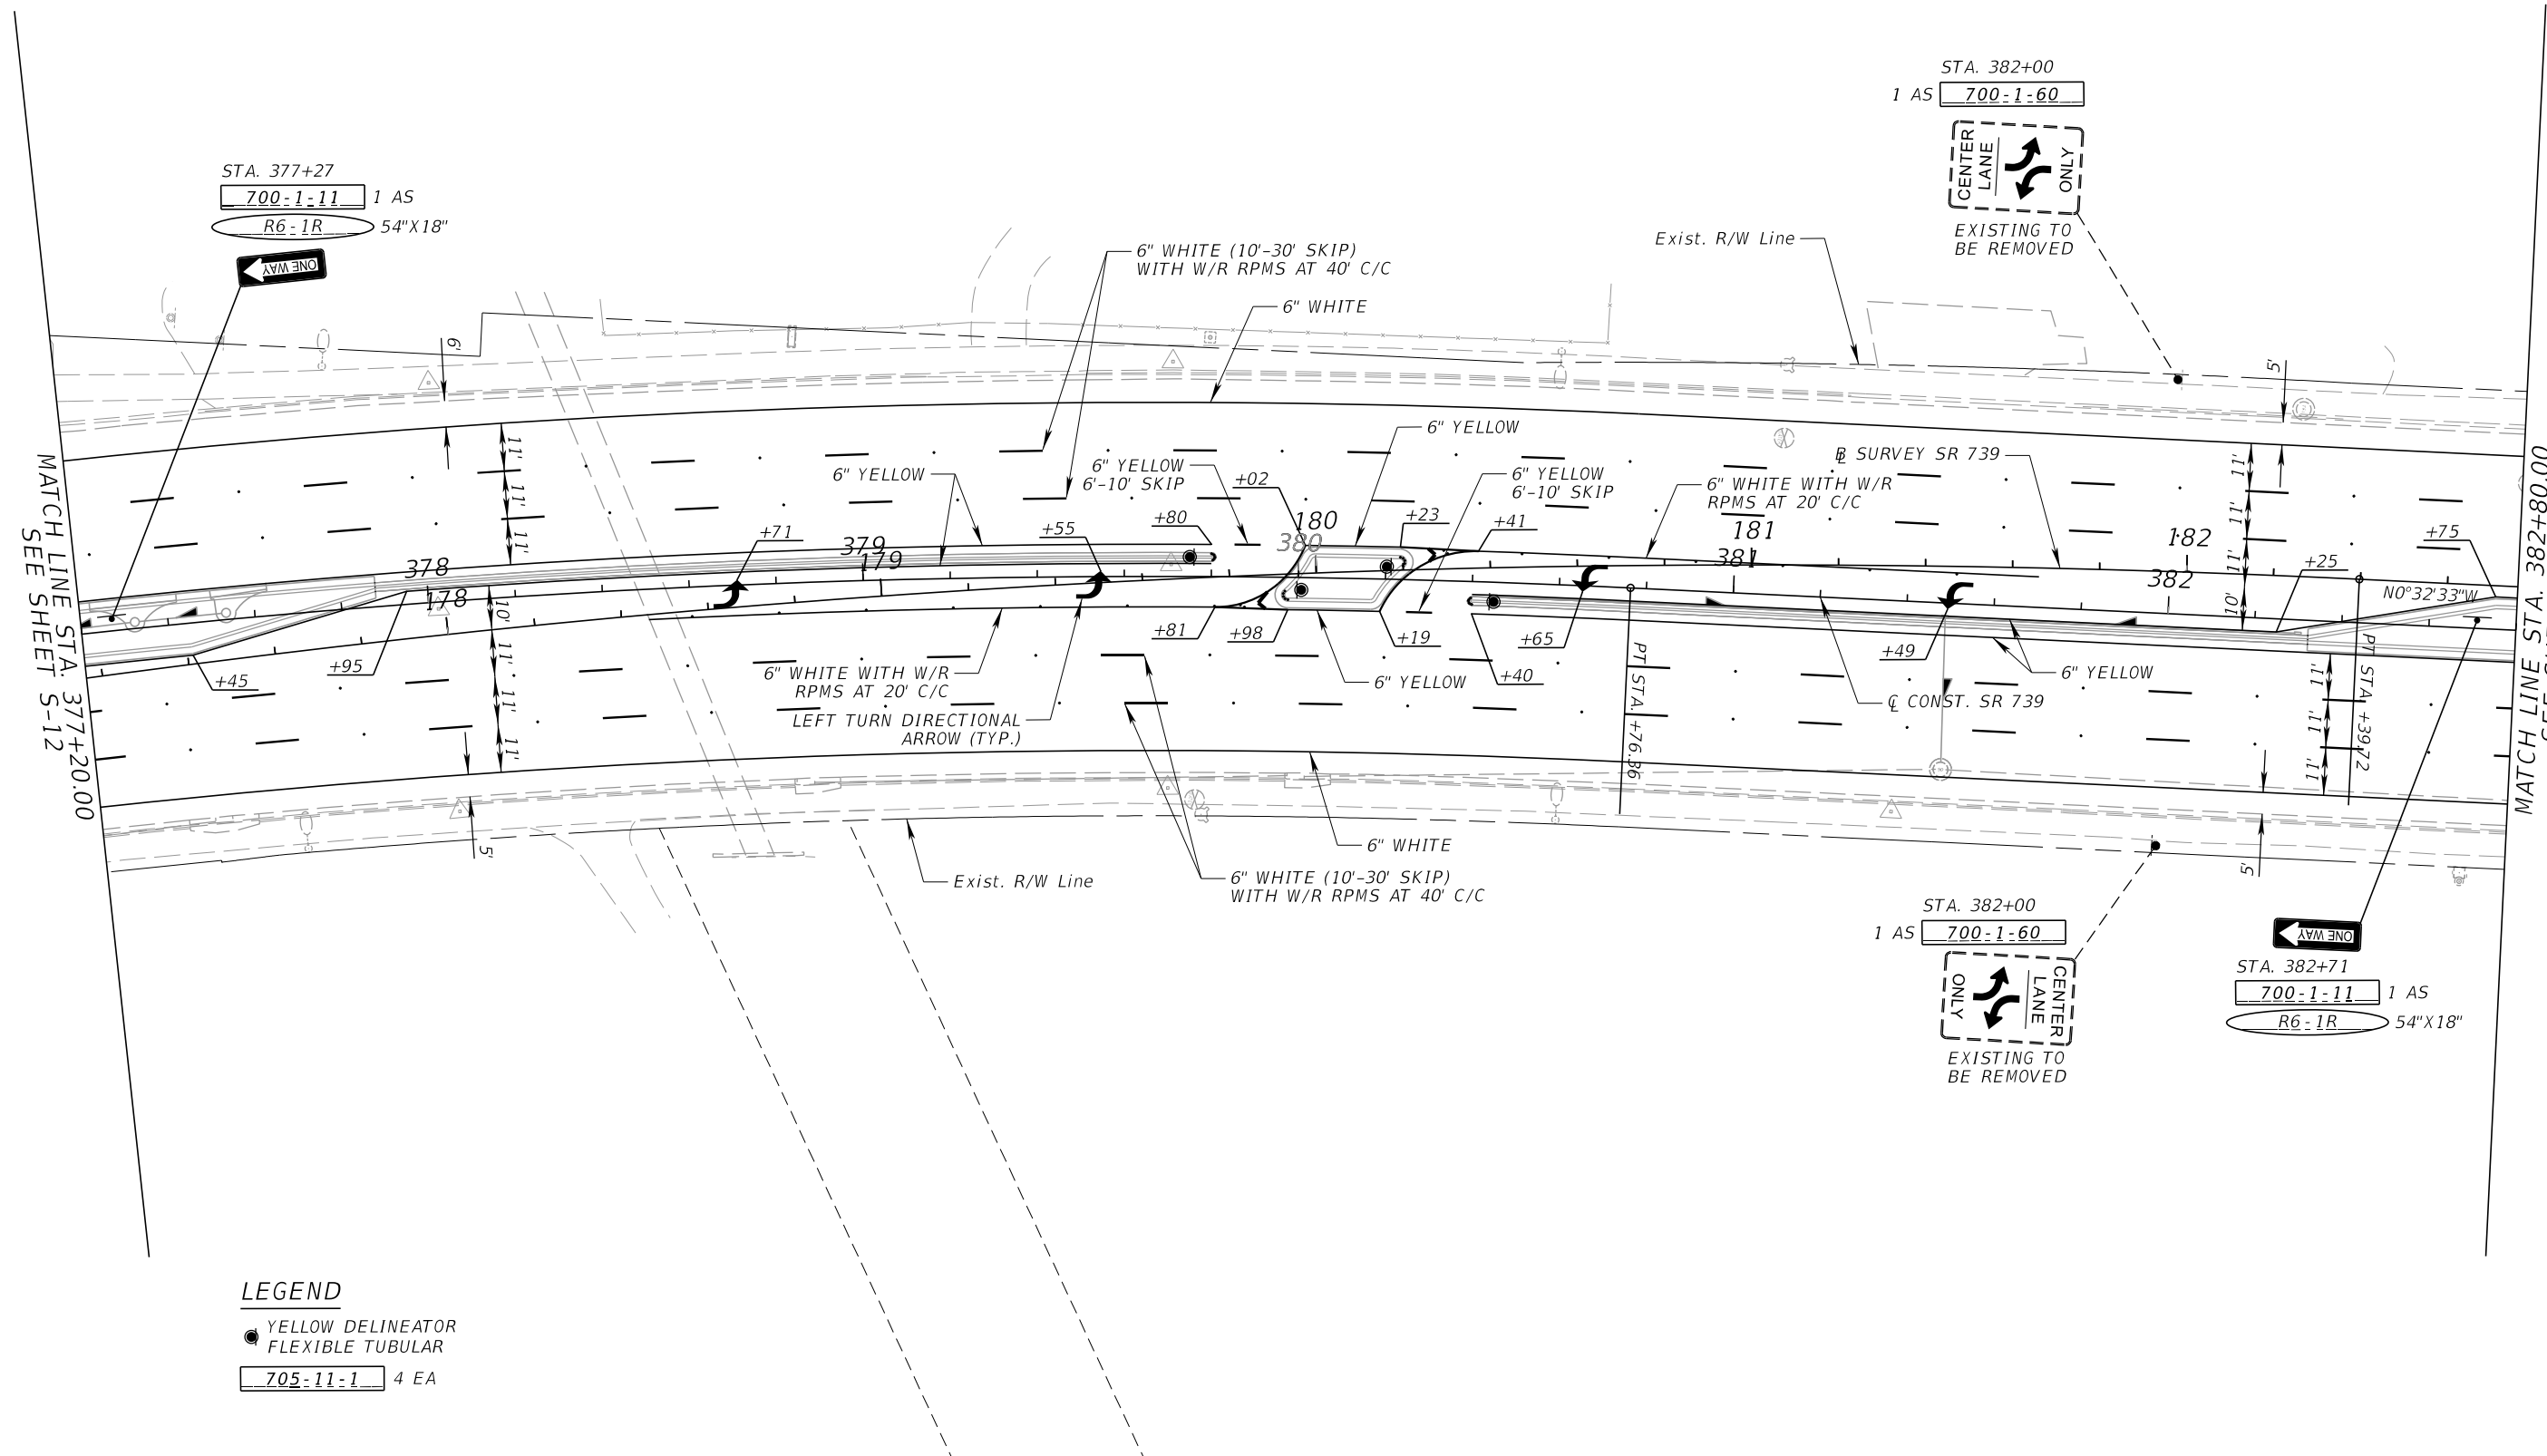

LEGEND

- YELLOW DELINEATOR
- FLEXIBLE TUBULAR
- 705-11-1 4 EA

MATCH LINE STA. 377+20.00
SEE SHEET S-12


MATCH LINE STA. 382+80.00
SEE SHEET S-14

8/14/2023 9:04:05 PM LizetteMartinez
P:\FDOT\44629315201\SigningAndMarking\PLANS\SP01.dgn

THE OFFICIAL RECORD OF THIS SHEET IS THE ELECTRONIC FILE DIGITALLY SIGNED AND SEALED UNDER RULE 61G15-23.004, F.A.C.

REVISIONS		ENGINEER OF RECORD		STATE OF FLORIDA DEPARTMENT OF TRANSPORTATION			SIGNING AND PAVEMENT MARKING PLAN (11)	SHEET NO.
DATE	DESCRIPTION	DATE	DESCRIPTION	ROAD NO.	COUNTY	FINANCIAL PROJECT ID		S-13
				SR 739	LEE	446293-1-52-01		

EREZ DAYAN, P.E.
LICENSE NUMBER: 62144
AVANT ENGINEERING GROUP, LLC
2699 LEE ROAD, SUITE 401
WINTER PARK, FL 32789

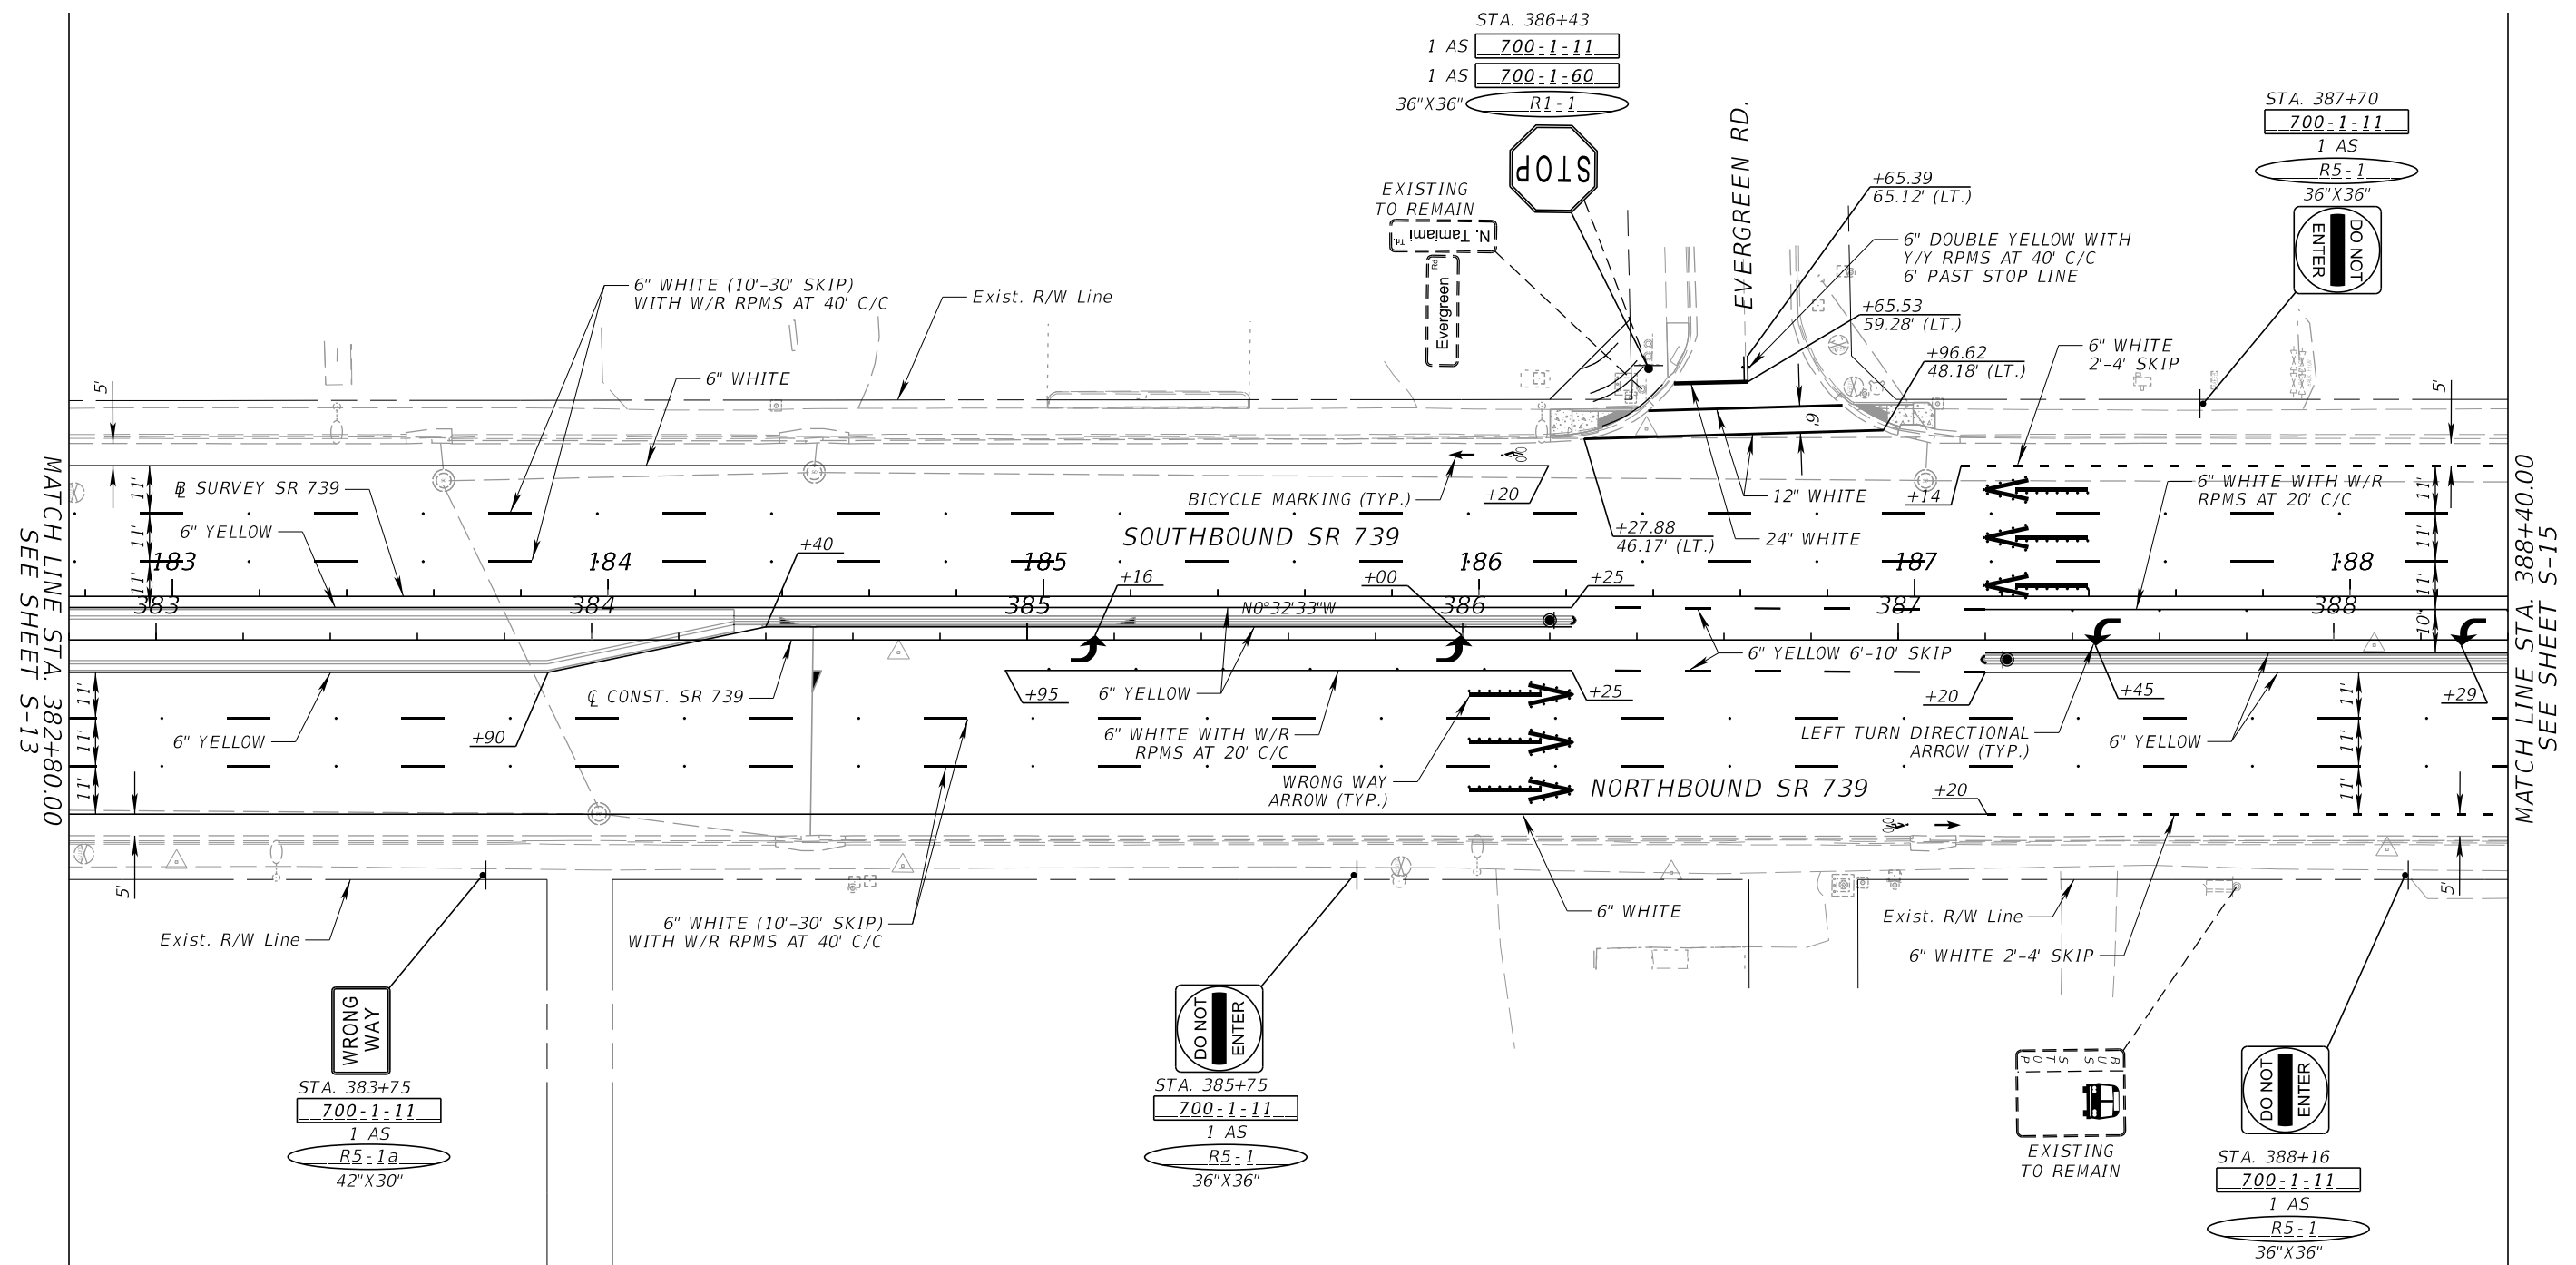

MATCH LINE STA. 382+80.00
SEE SHEET S-13

MATCH LINE STA. 388+40.00
SEE SHEET S-15

LEGEND

- YELLOW DELINEATOR FLEXIBLE TUBULAR
- 705-11-1 2 EA



STA. 383+75
700-1-11
1 AS
R5-1a
42"X30"

STA. 385+75
700-1-11
1 AS
R5-1
36"X36"

EXISTING TO REMAIN

STA. 388+16
700-1-11
1 AS
R5-1
36"X36"

REVISIONS				ENGINEER OF RECORD			STATE OF FLORIDA DEPARTMENT OF TRANSPORTATION			SIGNING AND PAVEMENT MARKING PLAN (12)	SHEET NO. S-14
DATE	DESCRIPTION	DATE	DESCRIPTION	EREZ DAYAN, P.E. LICENSE NUMBER: 62144 AVANT ENGINEERING GROUP, LLC 2699 LEE ROAD, SUITE 401 WINTER PARK, FL 32789			ROAD NO.	COUNTY	FINANCIAL PROJECT ID		
							SR 739	LEE	446293-1-52-01		

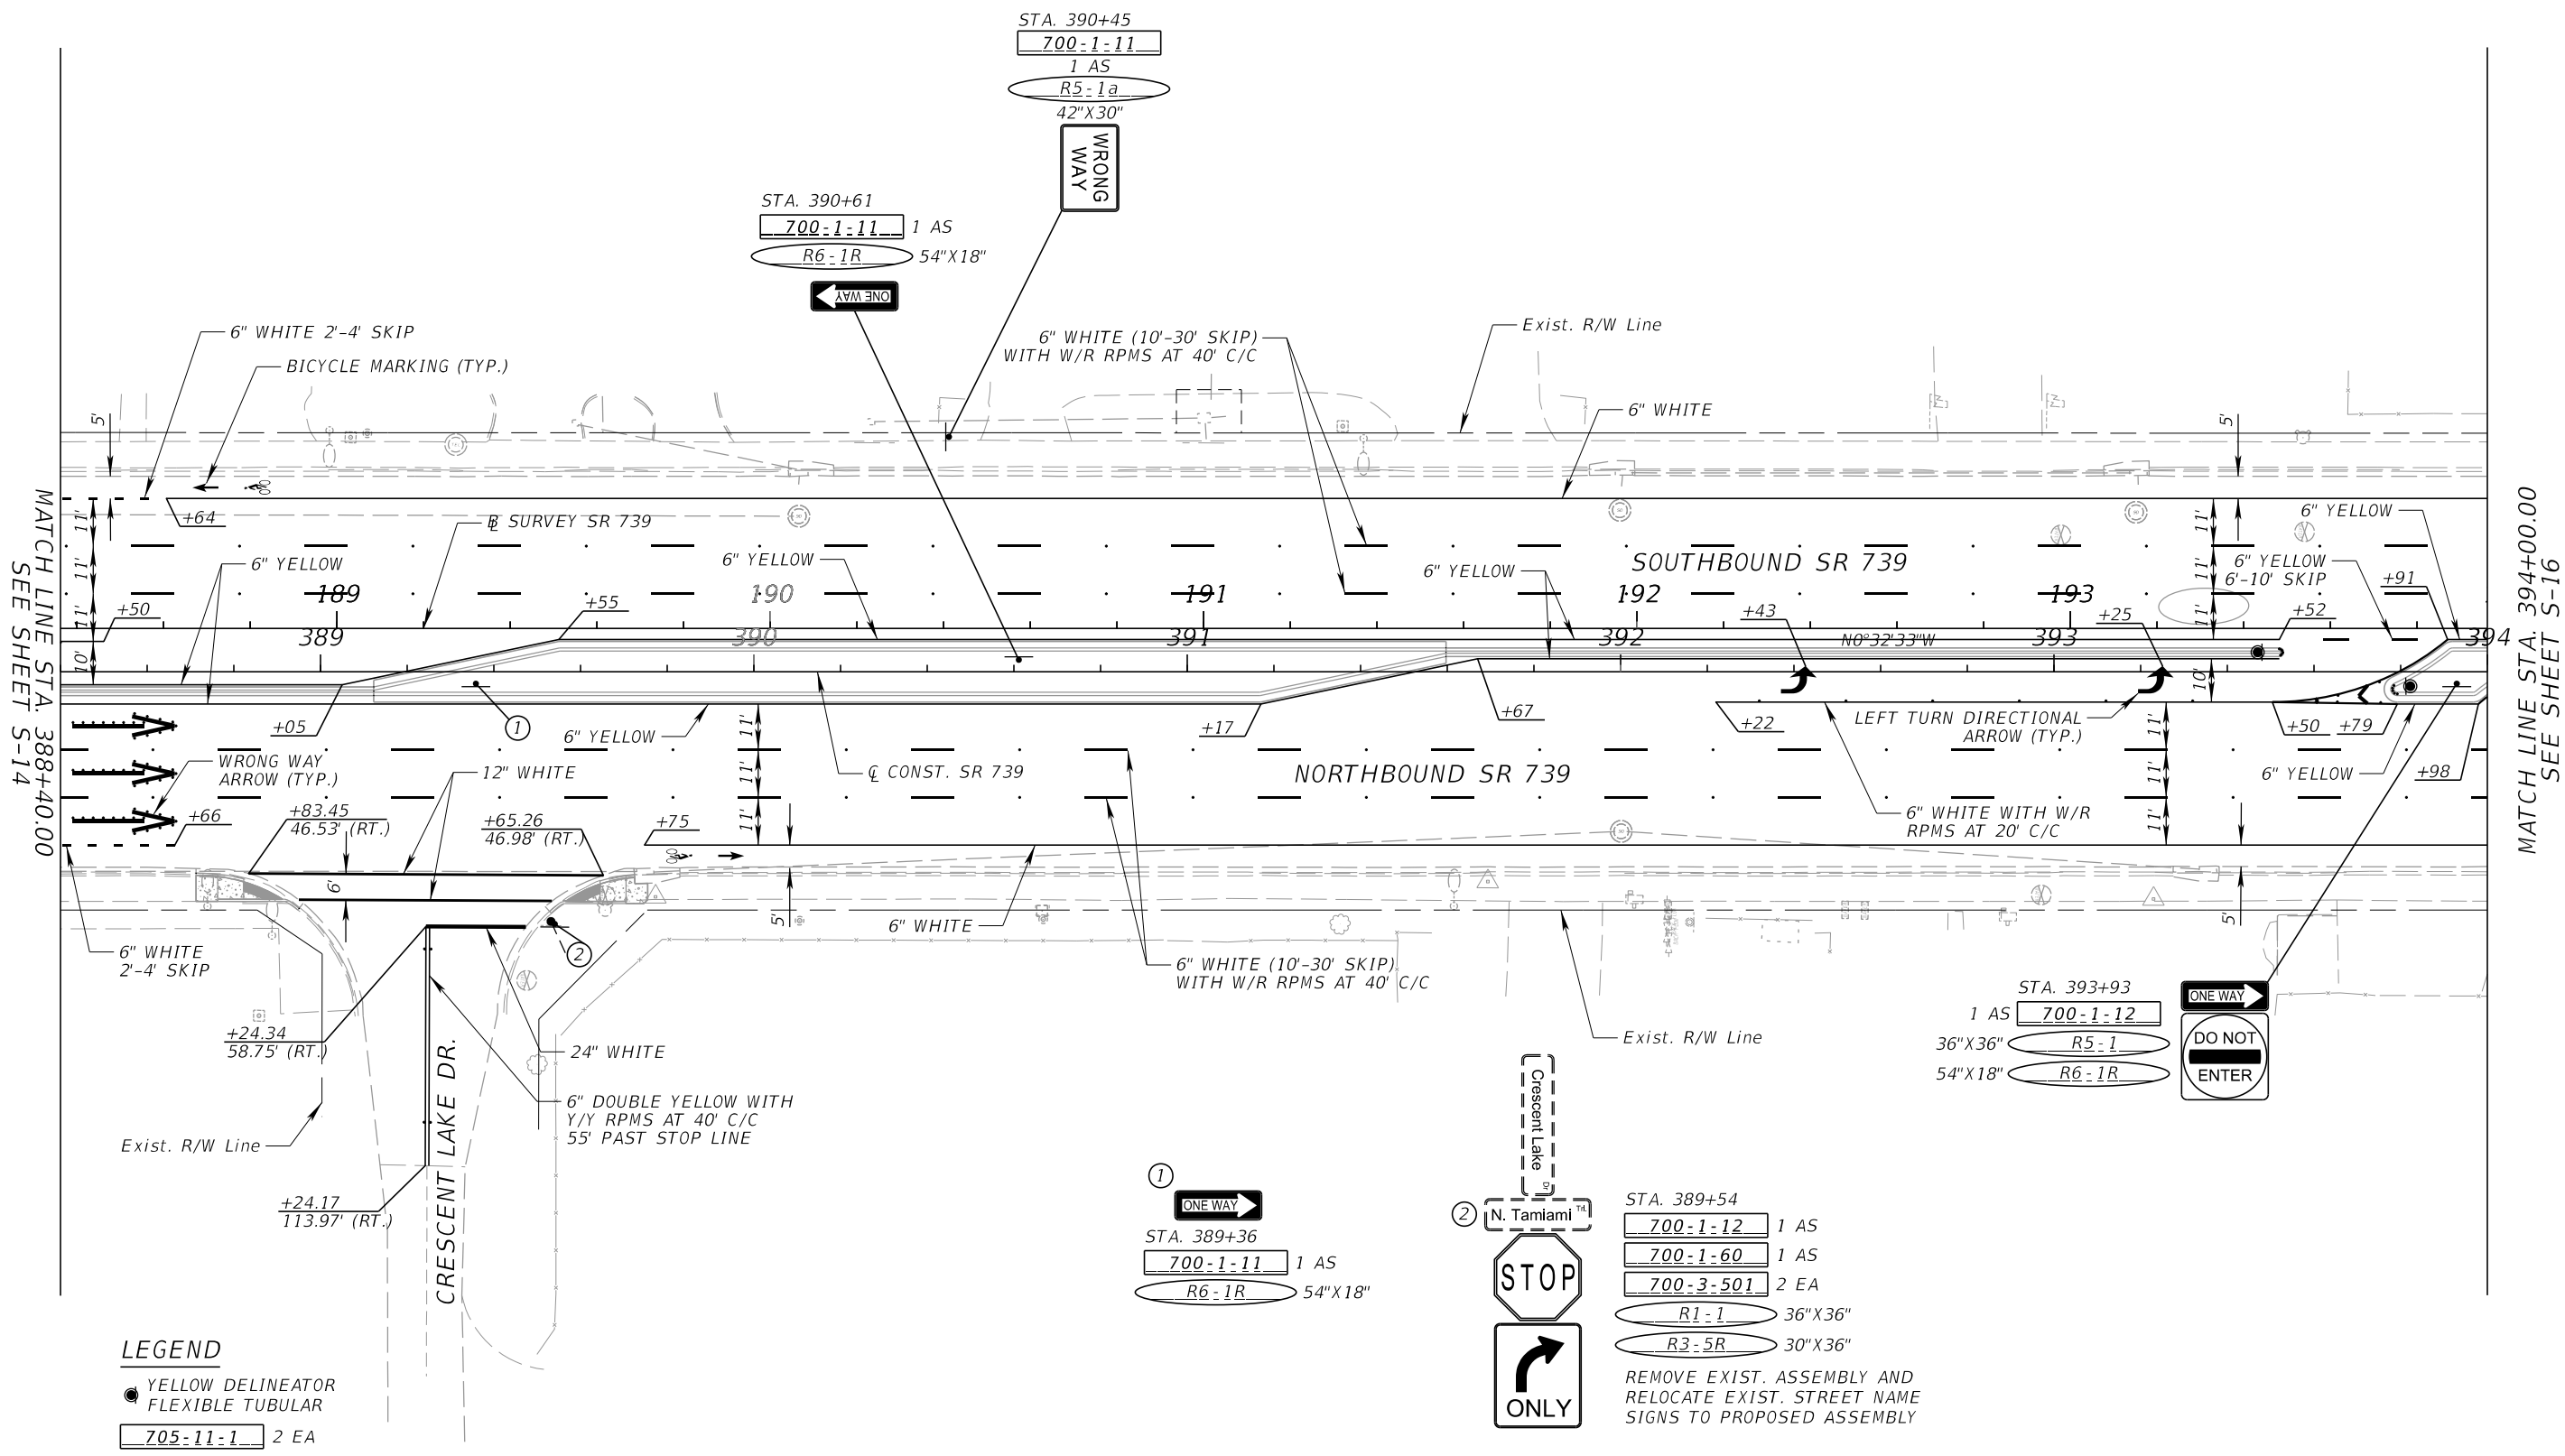 

MATCH LINE STA. 388+40.00
SEE SHEET S-14

MATCH LINE STA. 394+00.00
SEE SHEET S-16


LEGEND
 ● YELLOW DELINEATOR FLEXIBLE TUBULAR
 705-11-1 2 EA

REVISIONS				ENGINEER OF RECORD		STATE OF FLORIDA DEPARTMENT OF TRANSPORTATION			SIGNING AND PAVEMENT MARKING PLAN (13)	SHEET NO. S-15
DATE	DESCRIPTION	DATE	DESCRIPTION	EREZ DAYAN, P.E. LICENSE NUMBER: 62144 AVANT ENGINEERING GROUP, LLC 2699 LEE ROAD, SUITE 401 WINTER PARK, FL 32789		ROAD NO.	COUNTY	FINANCIAL PROJECT ID		
						SR 739	LEE	446293-1-52-01		

8/14/2023 9:04:07 PM LizetteMartinez P:\FDOT\446293\15201\SigningAndMarking\PLANS\01.dgn

THE OFFICIAL RECORD OF THIS SHEET IS THE ELECTRONIC FILE DIGITALLY SIGNED AND SEALED UNDER RULE 61G15-23.004, F.A.C.

N 1"=40'

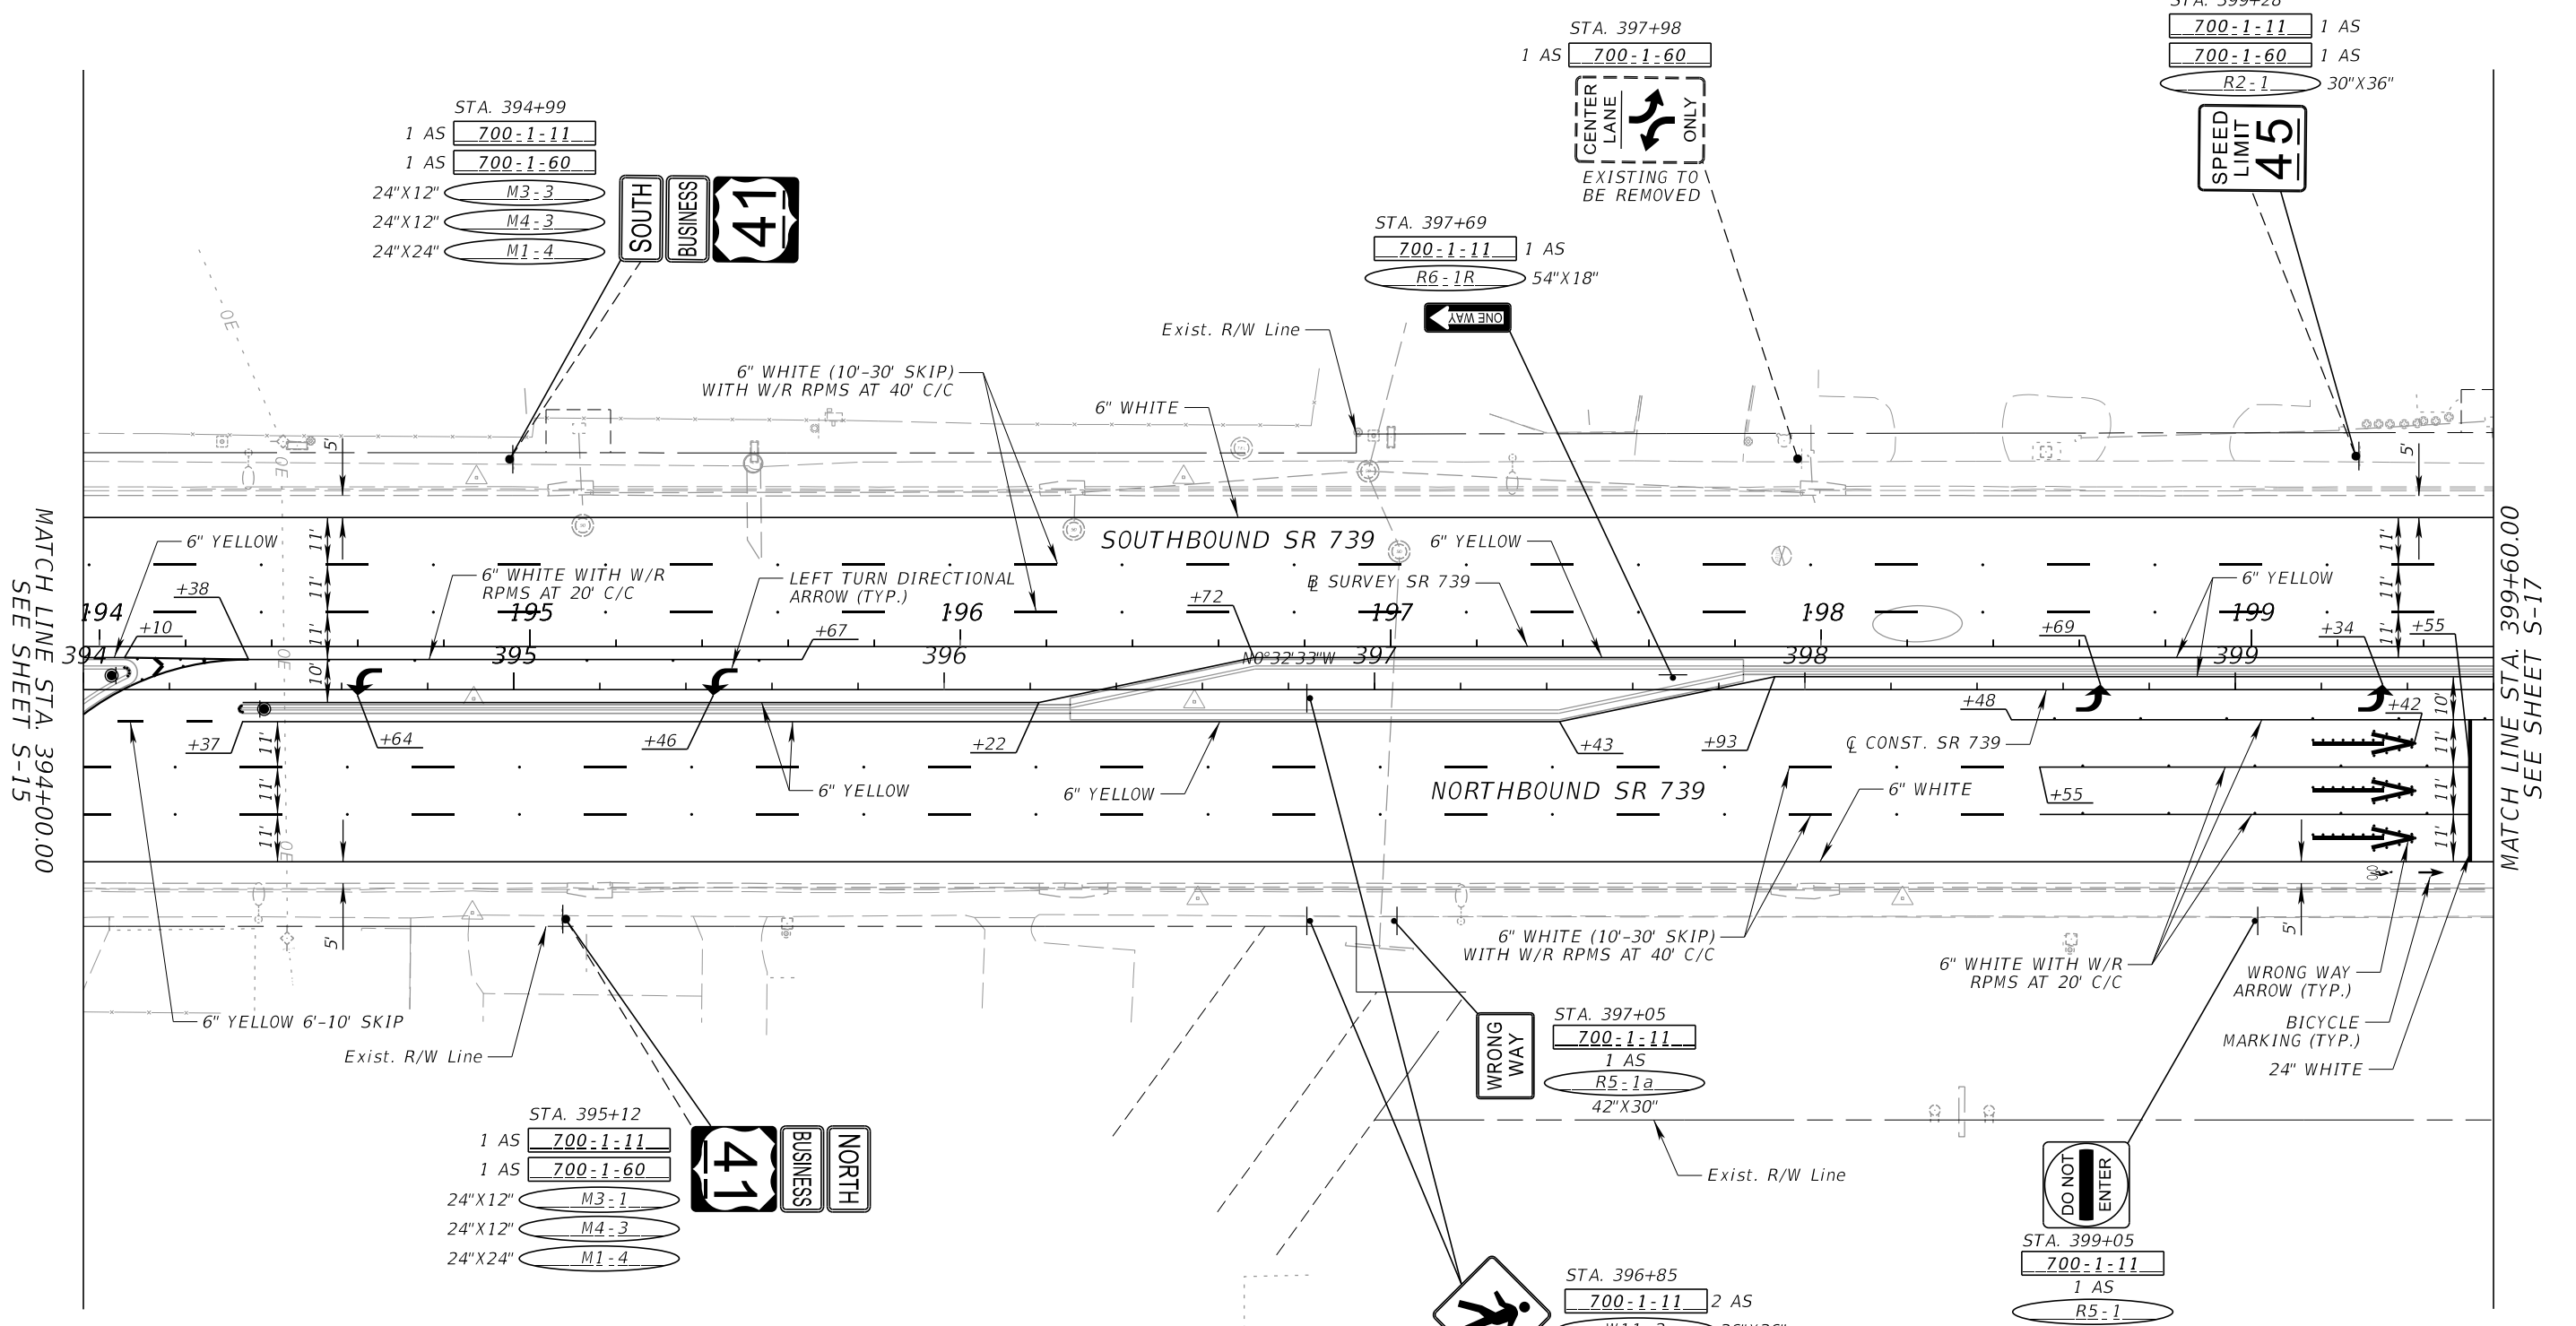

MATCH LINE STA. 394+00.00
SEE SHEET S-15

MATCH LINE STA. 399+60.00
SEE SHEET S-17

LEGEND

- YELLOW DELINEATOR FLEXIBLE TUBULAR
- 705-11-1 2 EA

8/14/2023 9:04:08 PM LizetteMartinez P:\FDOT\44629315201\SigningAndMarking\PLANS\PO1.dgn

REVISIONS				ENGINEER OF RECORD			STATE OF FLORIDA DEPARTMENT OF TRANSPORTATION			SHEET NO. S-16
DATE	DESCRIPTION	DATE	DESCRIPTION	EREZ DAYAN, P.E. LICENSE NUMBER: 62144 AVANT ENGINEERING GROUP, LLC 2699 LEE ROAD, SUITE 401 WINTER PARK, FL 32789			ROAD NO.	COUNTY	FINANCIAL PROJECT ID	
				SR 739	LEE	446293-1-52-01	SIGNING AND PAVEMENT MARKING PLAN (14)			

THE OFFICIAL RECORD OF THIS SHEET IS THE ELECTRONIC FILE DIGITALLY SIGNED AND SEALED UNDER RULE 61G15-23.004, F.A.C.

1"=40'

LEGEND


● YELLOW DELINEATOR
● FLEXIBLE TUBULAR

705-11-1 4 EA

6" DOUBLE YELLOW WITH
Y/Y RPMS AT 40' C/C
39' PAST STOP LINE



STA. 404+03
1 AS 700-1-12
1 AS 700-1-60
36"X36" R1-1
30"X36" R3-5R

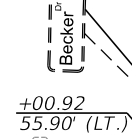

+00.92
55.90' (LT.)

24" WHITE
12" WHITE

STA. 404+17
1 AS 700-1-11
R6-1R 54"X18"

6" WHITE WITH W/R
RPMS AT 20' C/C

6" WHITE

STA. 404+46
1 AS 700-1-60

EXISTING TO BE REMOVED

EXISTING TO BE REMOVED

STA. 403+79
700-1-11 1 AS
700-1-60 1 AS
M2-1 21"X15"
FTP-17-06 24"X24"

7 6" WHITE WITH W/R
RPMS AT 20' C/C

REMOVE EXIST. ASSEMBLY AND
RELOCATE EXIST. STREET NAME
SIGNS TO PROPOSED ASSEMBLY
AT STA. 404+03

700-1-60 1 AS
700-3-501 2 EA

EXIST. R/W LINE
6" WHITE
2-4' SKIP

+29.31
102.83' (LT.)

+27.15
64.08' (LT.)

+66.40
48.29' (LT.)

+91

6" WHITE
6-10' SKIP


6" YELLOW

6" WHITE
6-10' SKIP

EXISTING TO BE REMOVED

STA. 404+70
1 AS 700-1-60

EXISTING TO BE REMOVED

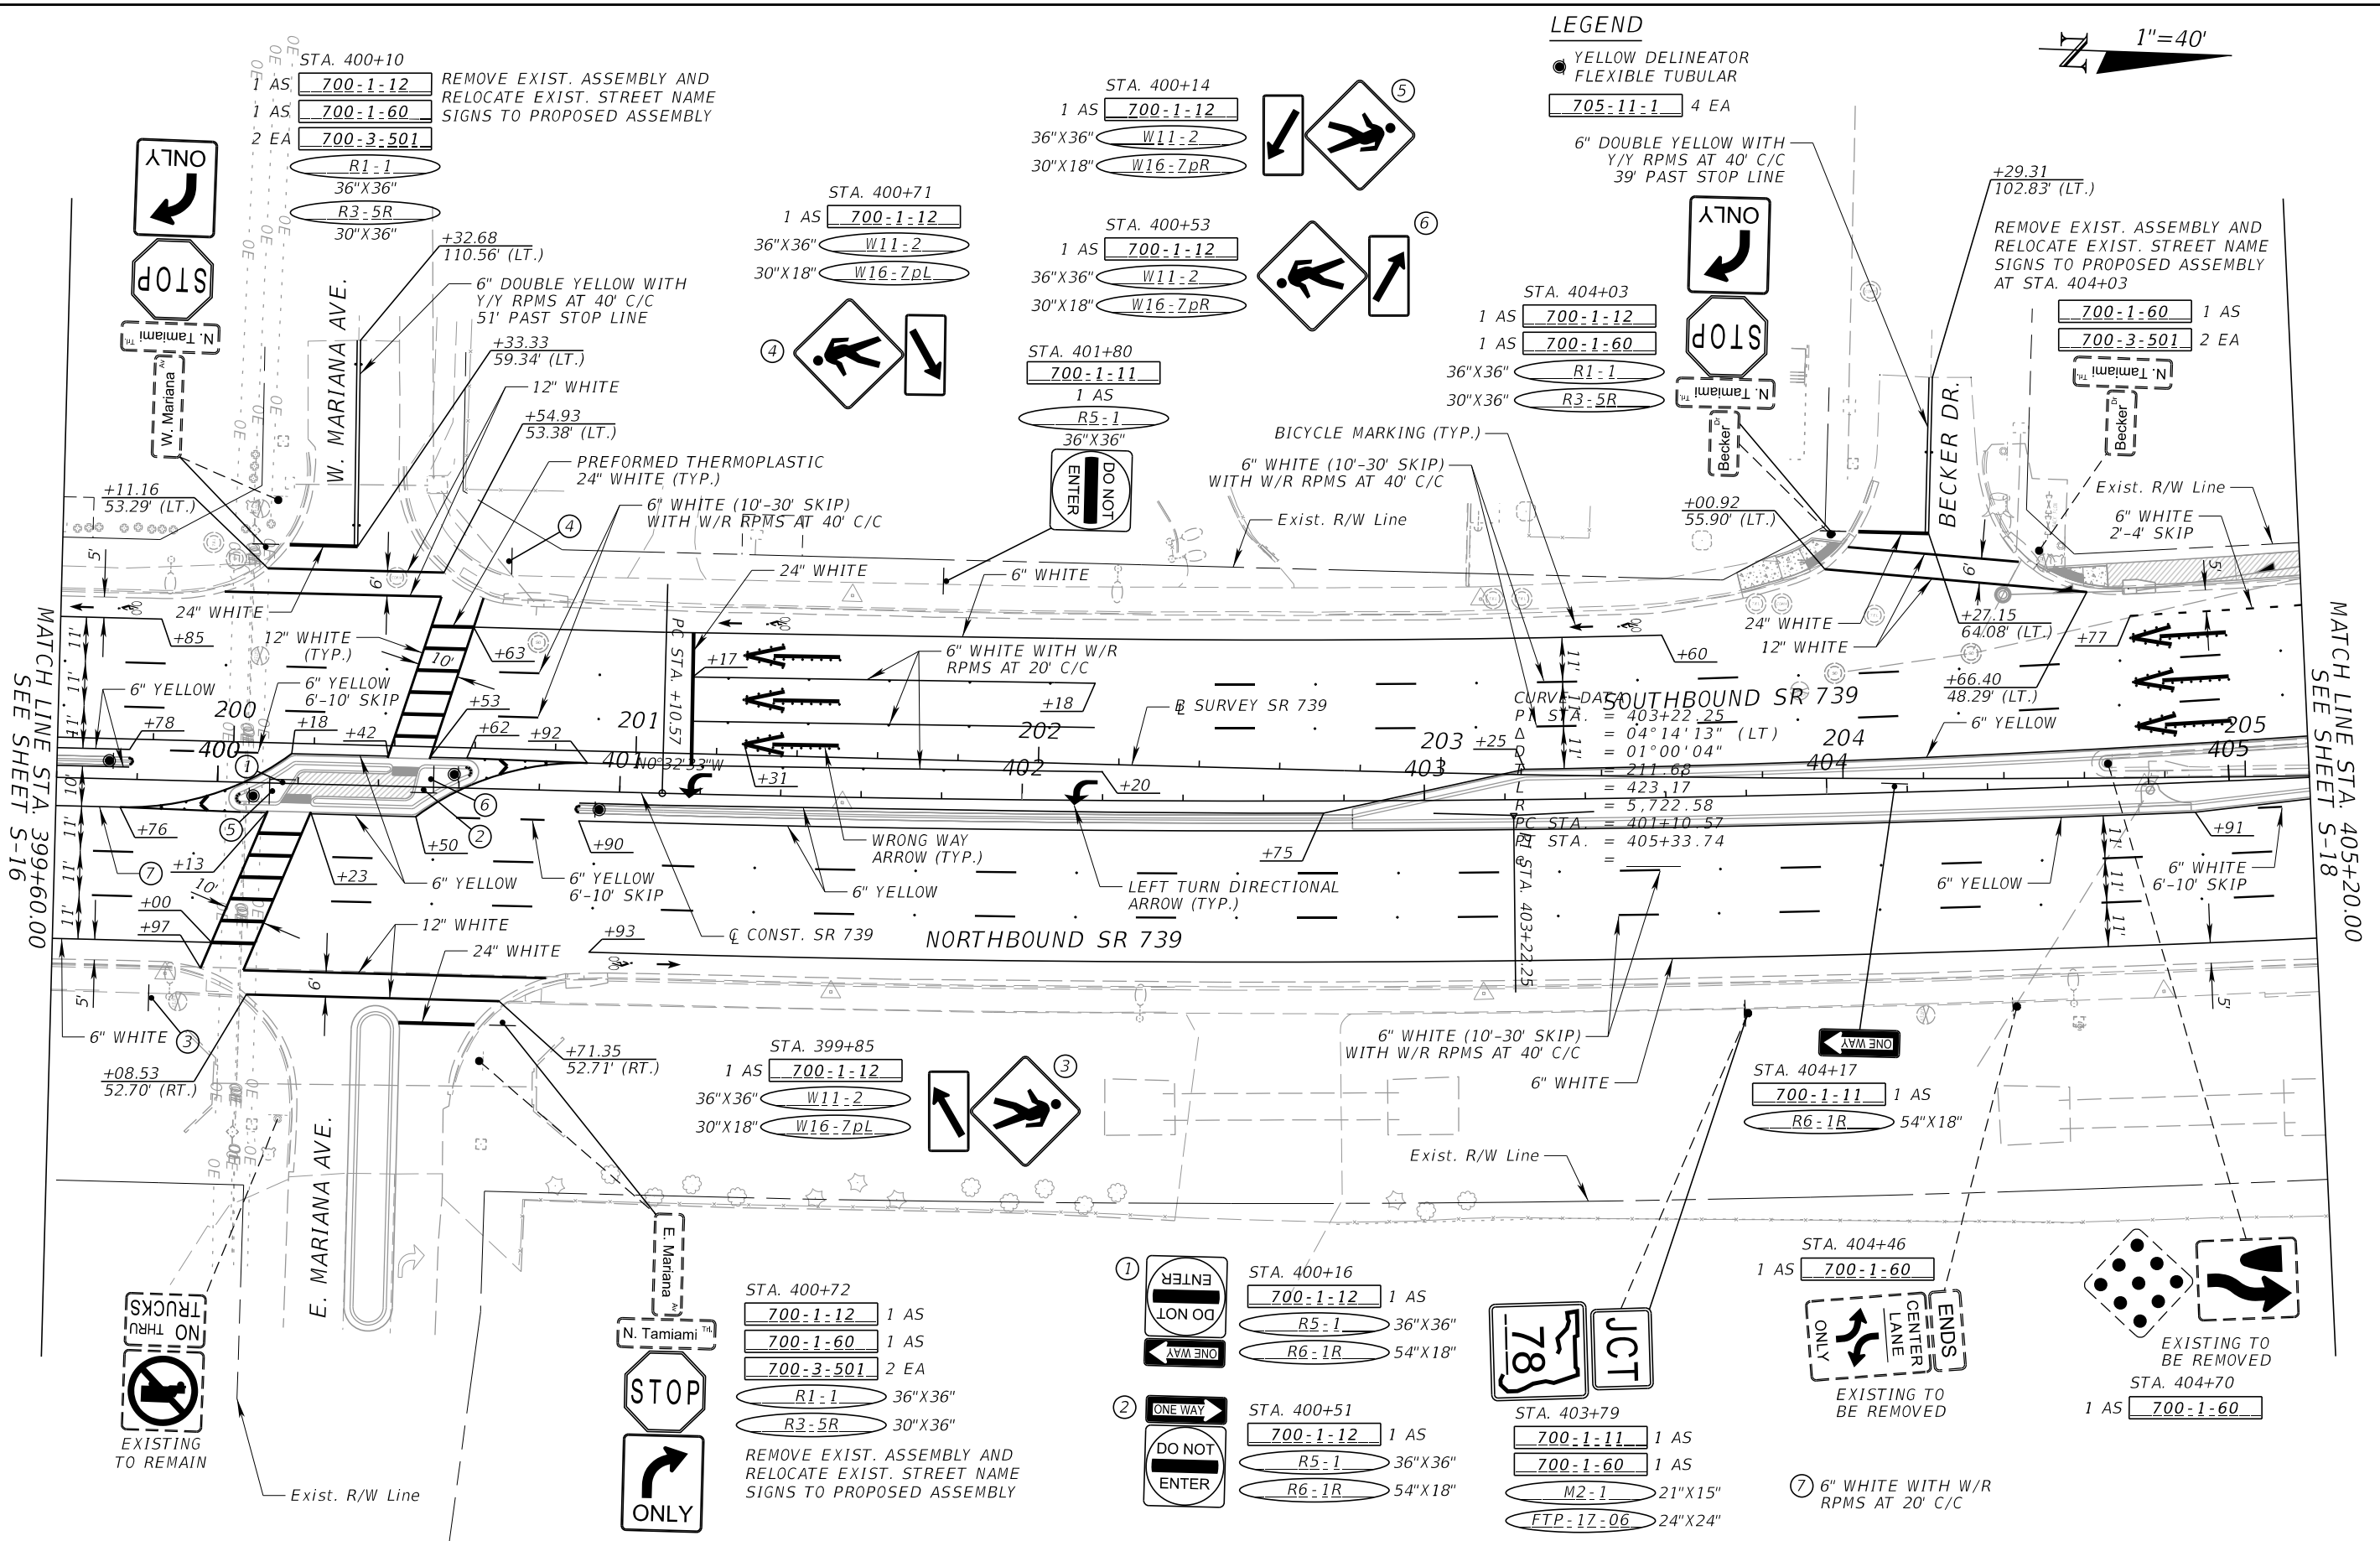

MATCH LINE STA. 399+60.00
SEE SHEET S-16

MATCH LINE STA. 405+20.00
SEE SHEET S-18

STA. 400+10
1 AS 700-1-12 REMOVE EXIST. ASSEMBLY AND
1 AS 700-1-60 RELOCATE EXIST. STREET NAME
2 EA 700-3-501 SIGNS TO PROPOSED ASSEMBLY

STA. 400+14
1 AS 700-1-12
36"X36" W11-2
30"X18" W16-7pL

STA. 400+71
1 AS 700-1-12
36"X36" W11-2
30"X18" W16-7pL

STA. 401+80
700-1-11 1 AS
R5-1 36"X36"
DO NOT ENTER

STA. 400+16
700-1-12 1 AS
R5-1 36"X36"
R6-1R 54"X18"

STA. 399+85
1 AS 700-1-12
36"X36" W11-2
30"X18" W16-7pL

STA. 400+72
700-1-12 1 AS
700-1-60 1 AS
700-3-501 2 EA
R1-1 36"X36"
R3-5R 30"X36"

REMOVE EXIST. ASSEMBLY AND
RELOCATE EXIST. STREET NAME
SIGNS TO PROPOSED ASSEMBLY

1 DO NOT ENTER
ONE WAY

2 ONE WAY
DO NOT ENTER

JCT 78

ENDS CENTER LANE ONLY

EXISTING TO BE REMOVED

8/14/2023 9:04:09 PM LizetteMartinez P:\FDDT\446293\15201\SigningAndMarking\PLANS\01.dgn

REVISIONS		REVISIONS	
DATE	DESCRIPTION	DATE	DESCRIPTION



ENGINEER OF RECORD
EREZ DAYAN, P.E.
LICENSE NUMBER: 62144
AVANT ENGINEERING GROUP, LLC
2699 LEE ROAD, SUITE 401
WINTER PARK, FL 32789

STATE OF FLORIDA DEPARTMENT OF TRANSPORTATION		
ROAD NO.	COUNTY	FINANCIAL PROJECT ID
SR 739	LEE	446293-1-52-01

**SIGNING AND PAVEMENT
MARKING PLAN (15)**

SHEET NO.
S-17

 THE OFFICIAL RECORD OF THIS SHEET IS THE ELECTRONIC FILE DIGITALLY SIGNED AND SEALED UNDER RULE 61G15-23.004, F.A.C.

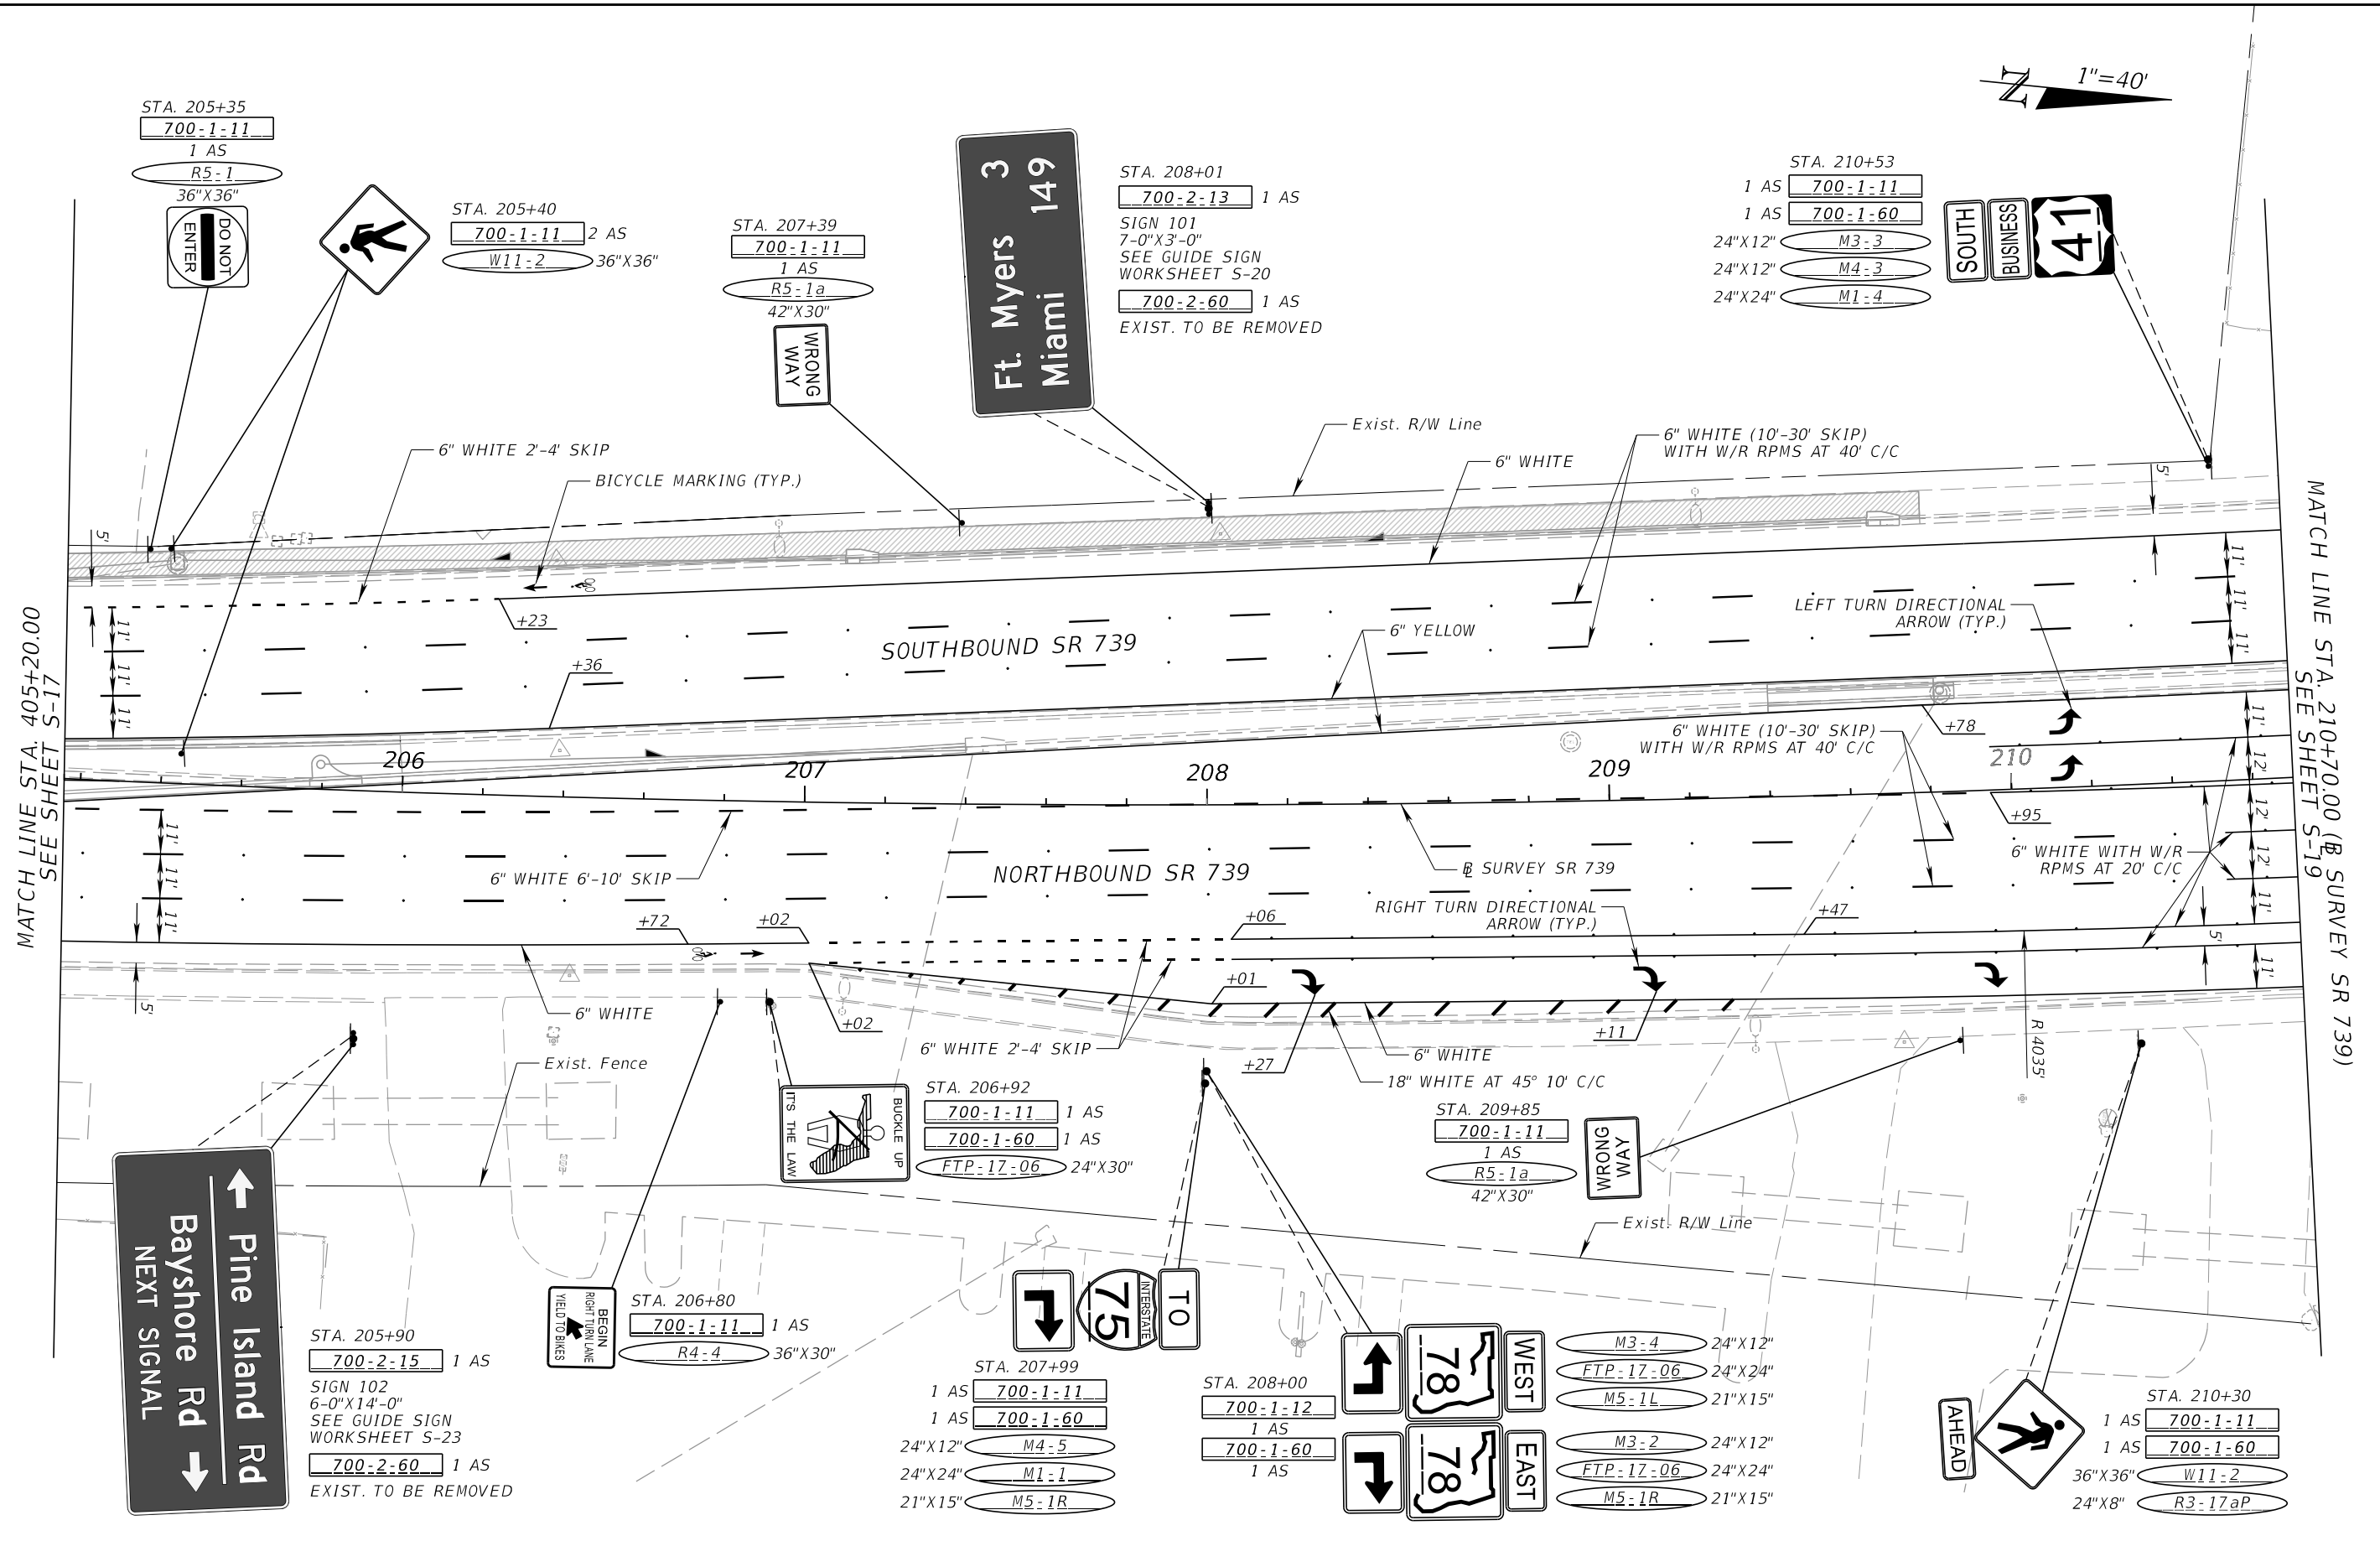

MATCH LINE STA. 405+20.00
SEE SHEET S-17

MATCH LINE STA. 210+70.00 (R) SURVEY SR 739
SEE SHEET S-19

STA. 205+35
700-1-11 1 AS
R5-1 36"X36"
DO NOT ENTER

STA. 205+40
700-1-11 2 AS
W11-2 36"X36"

STA. 207+39
700-1-11 1 AS
R5-1a 42"X30"
WRONG WAY

STA. 208+01
700-2-13 1 AS
SIGN 101
7'-0"X3'-0"
SEE GUIDE SIGN WORKSHEET S-20
700-2-60 1 AS
EXIST. TO BE REMOVED

STA. 210+53
1 AS 700-1-11
1 AS 700-1-60
24"X12" M3-3
24"X12" M4-3
24"X24" M1-4

Bayshore Rd
Pine Island Rd
NEXT SIGNAL

STA. 205+90
700-2-15 1 AS
SIGN 102
6'-0"X14'-0"
SEE GUIDE SIGN WORKSHEET S-23
700-2-60 1 AS
EXIST. TO BE REMOVED

STA. 206+80
700-1-11 1 AS
R4-4 36"X30"
BEGIN RIGHT TURN LANE YIELD TO BIKES

STA. 206+92
700-1-11 1 AS
700-1-60 1 AS
FTP-17-06 24"X30"
BUCKLE UP
ITS THE LAW

STA. 207+99
1 AS 700-1-11
1 AS 700-1-60
24"X12" M4-5
24"X24" M1-1
21"X15" M5-1R

STA. 208+00
700-1-12 1 AS
700-1-60 1 AS

STA. 209+85
700-1-11 1 AS
R5-1a 42"X30"
WRONG WAY



WEST EAST
78 78
M3-4 24"X12"
FTP-17-06 24"X24"
M5-1L 21"X15"
M3-2 24"X12"
FTP-17-06 24"X24"
M5-1R 21"X15"

STA. 210+30
1 AS 700-1-11
1 AS 700-1-60
36"X36" W11-2
24"X8" R3-17aP

8/14/2023 9:04:11 PM LizetteMartinez P:\FDOT\446293\15201\SigningAndMarking\PLANS\01.dgn

REVISIONS		REVISIONS		ENGINEER OF RECORD		STATE OF FLORIDA DEPARTMENT OF TRANSPORTATION			SIGNING AND PAVEMENT MARKING PLAN (16)	SHEET NO. S-18
DATE	DESCRIPTION	DATE	DESCRIPTION			ROAD NO.	COUNTY	FINANCIAL PROJECT ID		
				EREZ DAYAN, P.E. LICENSE NUMBER: 62144 AVANT ENGINEERING GROUP, LLC 2699 LEE ROAD, SUITE 401 WINTER PARK, FL 32789		SR 739	LEE	446293-1-52-01		

 THE OFFICIAL RECORD OF THIS SHEET IS THE ELECTRONIC FILE DIGITALLY SIGNED AND SEALED UNDER RULE 61G15-23.004, F.A.C.

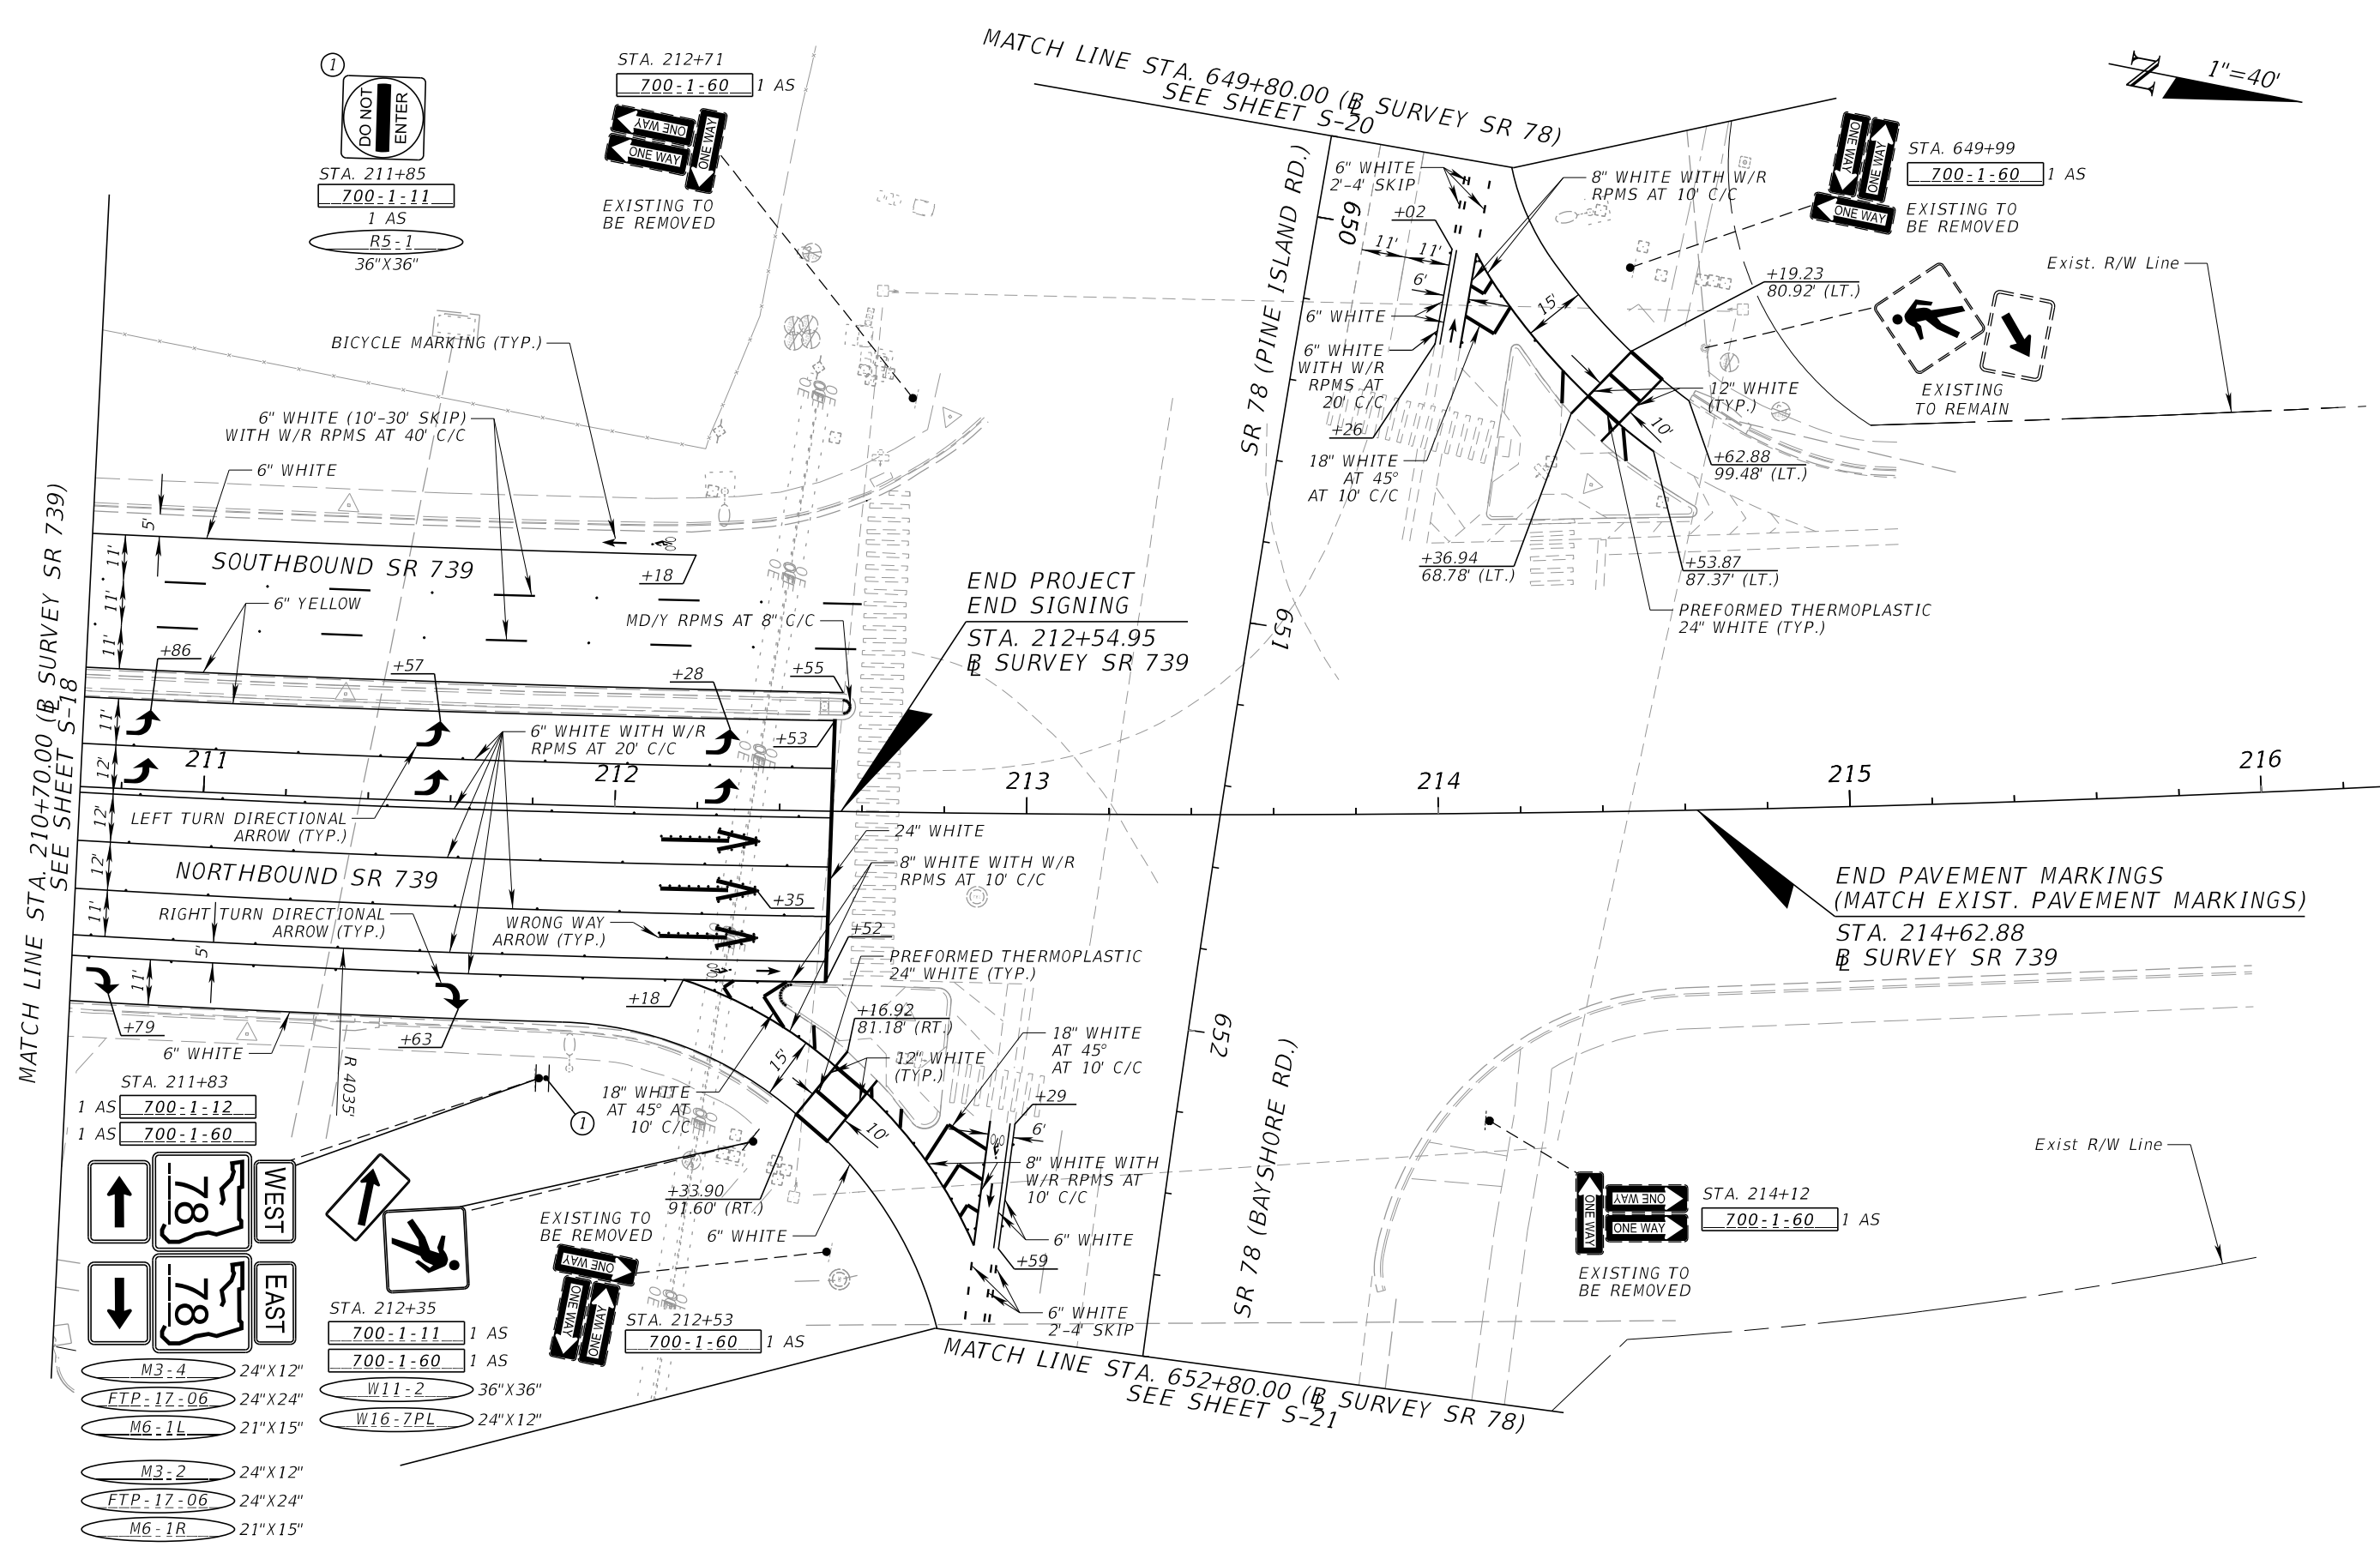

MATCH LINE STA. 210+70.00 (B SURVEY SR 739) SEE SHEET S-18

END PROJECT
END SIGNING
STA. 212+54.95
B SURVEY SR 739

END PAVEMENT MARKINGS
(MATCH EXIST. PAVEMENT MARKINGS)
STA. 214+62.88
B SURVEY SR 739

MATCH LINE STA. 652+80.00 (B SURVEY SR 78) SEE SHEET S-21

STA. 211+83
1 AS 700-1-12
1 AS 700-1-60

STA. 212+35
700-1-11 1 AS
700-1-60 1 AS
W11-2 36"X36"
W16-7PL 24"X12"

STA. 212+53
700-1-60 1 AS

STA. 214+12
700-1-60 1 AS


- M3-4 24"X12"
- FTP-17-06 24"X24"
- M6-1L 21"X15"
- M3-2 24"X12"
- FTP-17-06 24"X24"
- M6-1R 21"X15"

8/14/2023 9:04:12 PM LizetteMartinez P:\FDDT\44629315201\SigningAndMarking\PLANS\PO1.dgn


REVISIONS		REVISIONS		ENGINEER OF RECORD		STATE OF FLORIDA DEPARTMENT OF TRANSPORTATION			SIGNING AND PAVEMENT MARKING PLAN (17)	SHEET NO. S-19
DATE	DESCRIPTION	DATE	DESCRIPTION			ROAD NO.	COUNTY	FINANCIAL PROJECT ID		
				EREZ DAYAN, P.E. LICENSE NUMBER: 62144 AVANT ENGINEERING GROUP, LLC 2699 LEE ROAD, SUITE 401 WINTER PARK, FL 32789		SR 739	LEE	446293-1-52-01		

THE OFFICIAL RECORD OF THIS SHEET IS THE ELECTRONIC FILE DIGITALLY SIGNED AND SEALED UNDER RULE 61G15-23.004, F.A.C.

8/14/2023 9:04:13 PM LizetteMartinez
 C:\Users\lindquist\OneDrive\Projects - Documents\FDOT\44629315201\SigningAndMarking\PLANS\PO1.dgn

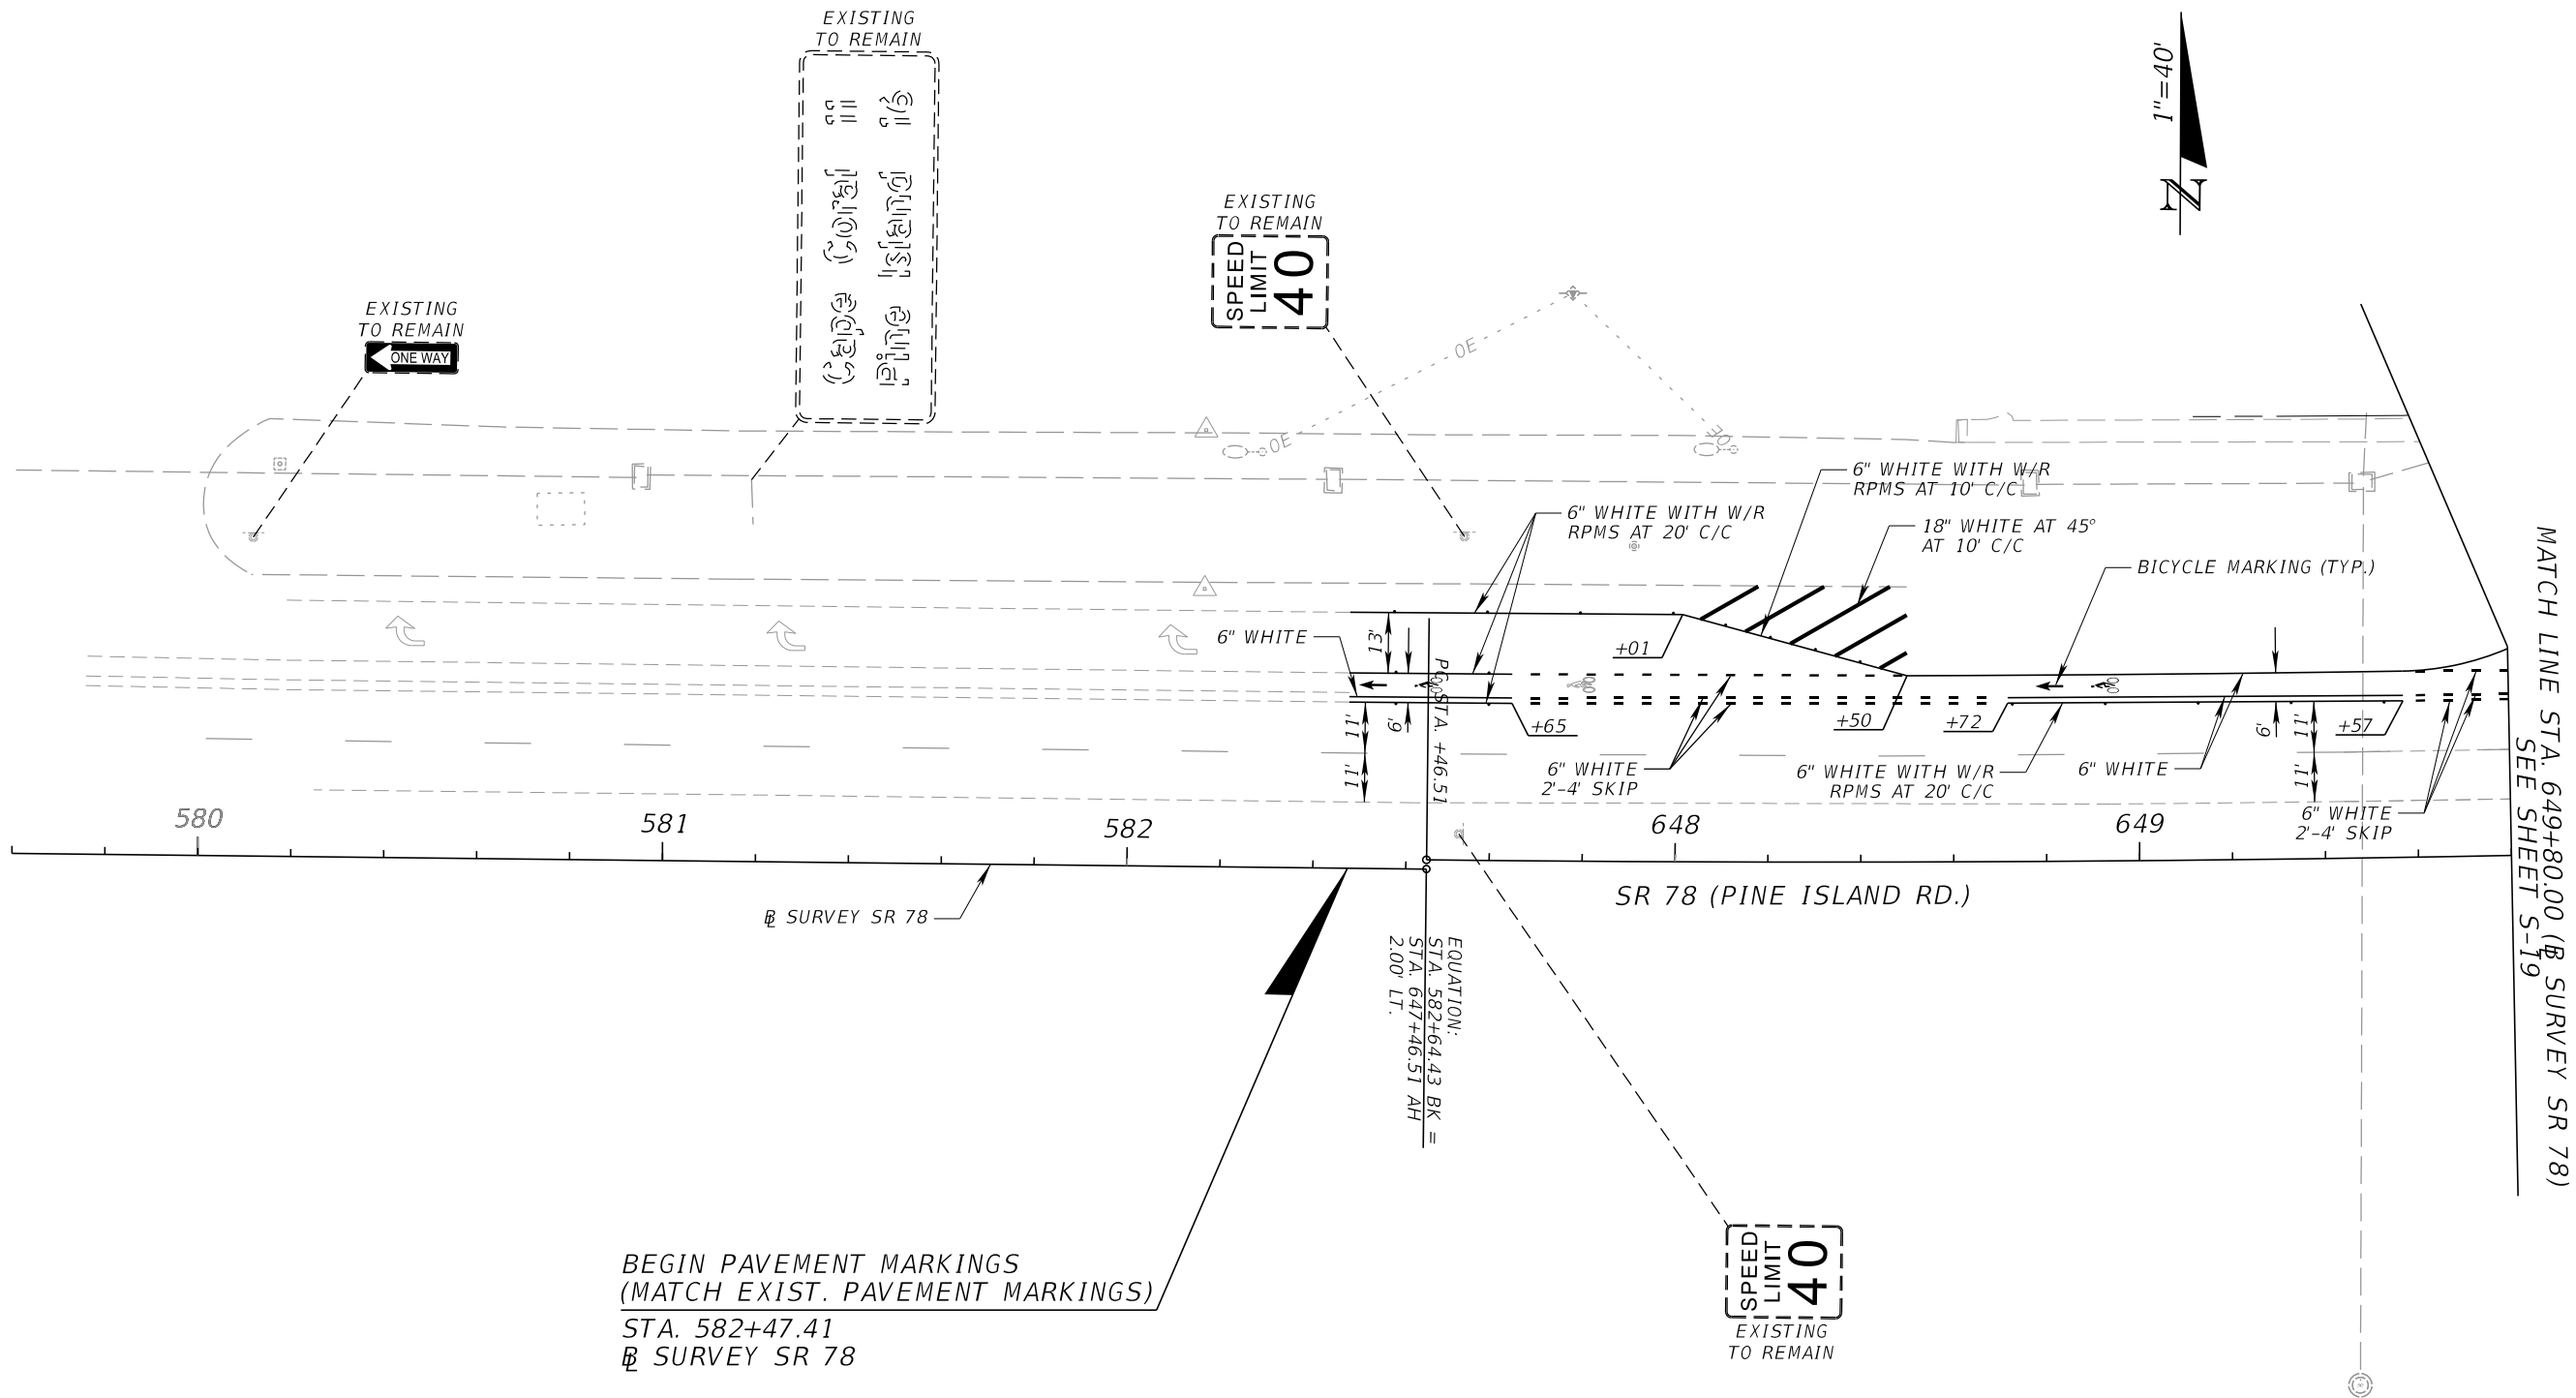

BEGIN PAVEMENT MARKINGS
 (MATCH EXIST. PAVEMENT MARKINGS)
 STA. 582+47.41
 @ SURVEY SR 78

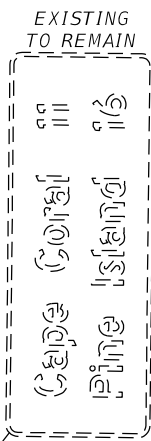


MATCH LINE STA. 649+80.00 (@ SURVEY SR 78)
 SEE SHEET S-19

REVISIONS				ENGINEER OF RECORD		STATE OF FLORIDA DEPARTMENT OF TRANSPORTATION			SIGNING AND PAVEMENT MARKING PLAN (18)	SHEET NO.
DATE	DESCRIPTION	DATE	DESCRIPTION	EREZ DAYAN, P.E. LICENSE NUMBER: 62144 AVANT ENGINEERING GROUP, LLC 2699 LEE ROAD, SUITE 401 WINTER PARK, FL 32789		ROAD NO.	COUNTY	FINANCIAL PROJECT ID		S-20
						SR 739	LEE	446293-1-52-01		

THE OFFICIAL RECORD OF THIS SHEET IS THE ELECTRONIC FILE DIGITALLY SIGNED AND SEALED UNDER RULE 61G15-23.004, F.A.C.



CURVE DATA
 PI STA. = 655+81.46
 Δ = 12° 28' 29" (LT)
 D = 00° 45' 00"
 T = 834.95
 L = 1,663.30
 R = 7,639.44
 PC STA. = 647+46.51
 PT STA. = 664+09.81
 e =

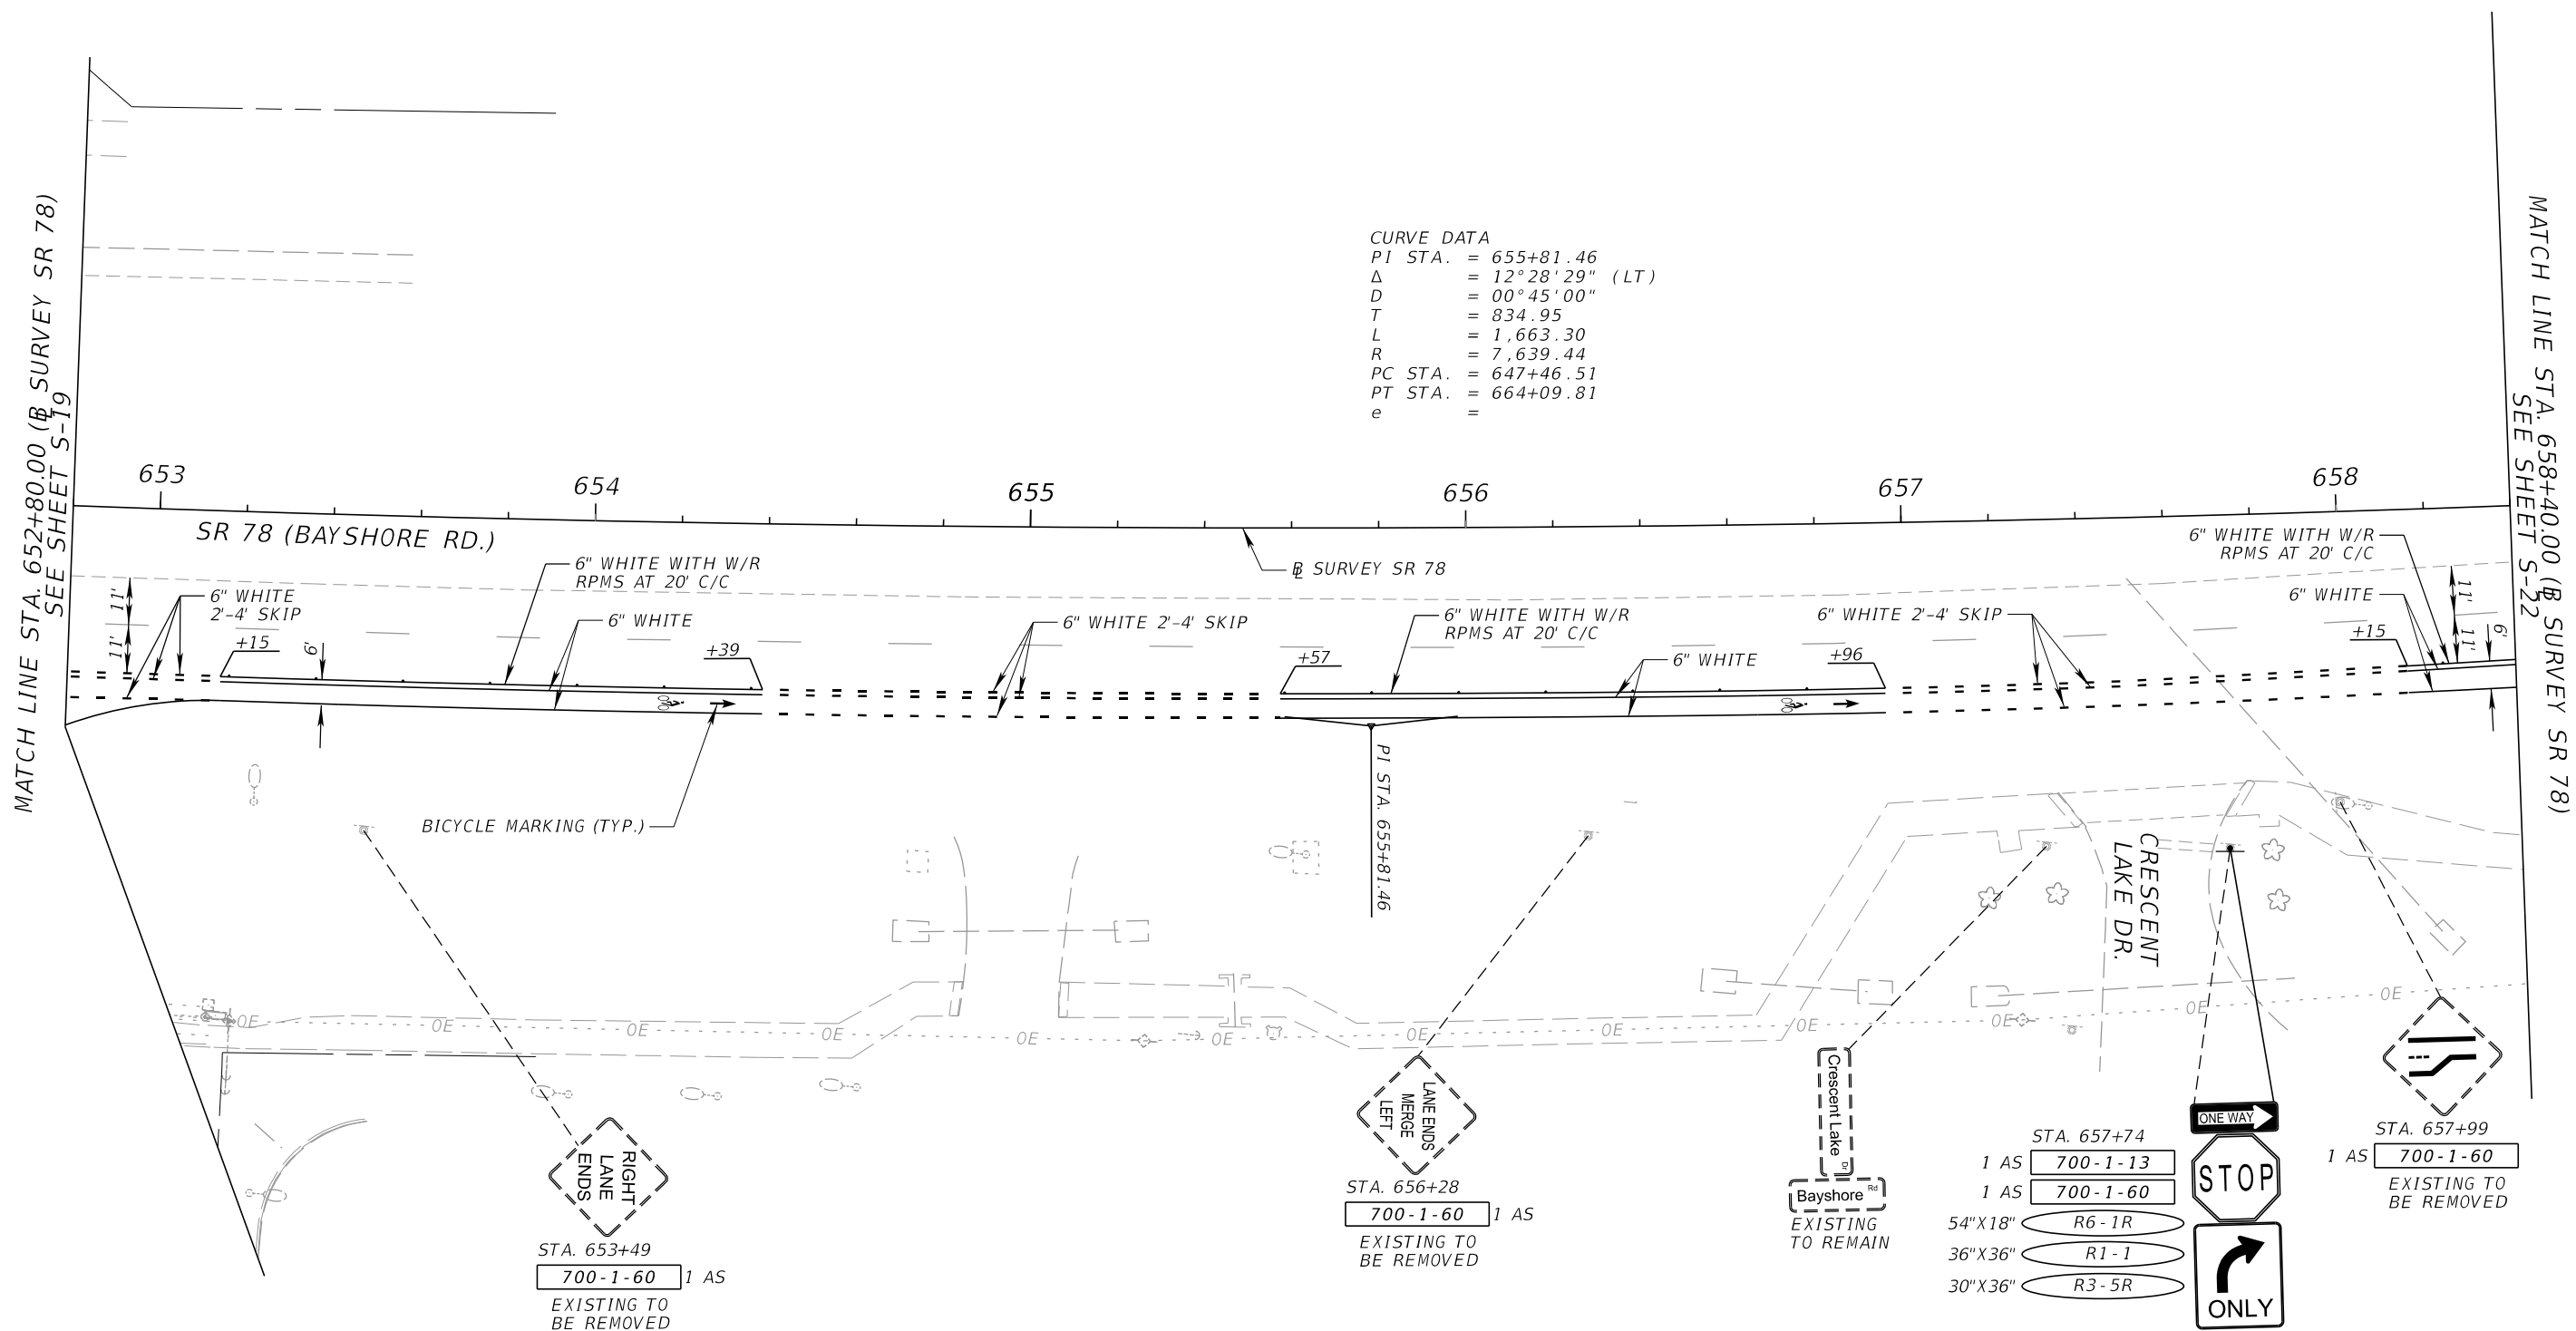

STA. 653+49
 700-1-60 1 AS
 EXISTING TO BE REMOVED

STA. 656+28
 700-1-60 1 AS
 EXISTING TO BE REMOVED

Bayshore
 EXISTING TO REMAIN

STA. 657+74
 1 AS 700-1-13
 1 AS 700-1-60
 54"X18" R6-1R
 36"X36" R1-1
 30"X36" R3-5R



STA. 657+99
 1 AS 700-1-60
 EXISTING TO BE REMOVED

8/14/2023 9:04:14 PM LizetteMartinez C:\Users\Justin\Inquiry\AEG\Projects - Documents\FDOT\44629315201\SigningAndMarking\PLANS\PO1.dgn

REVISIONS		REVISIONS	
DATE	DESCRIPTION	DATE	DESCRIPTION


ENGINEER OF RECORD
 EREZ DAYAN, P.E.
 LICENSE NUMBER: 62144
 AVANT ENGINEERING GROUP, LLC
 2699 LEE ROAD, SUITE 401
 WINTER PARK, FL 32789

STATE OF FLORIDA DEPARTMENT OF TRANSPORTATION		
ROAD NO.	COUNTY	FINANCIAL PROJECT ID
SR 739	LEE	446293-1-52-01

**SIGNING AND PAVEMENT
MARKING PLAN (19)**

SHEET NO.
S-21

THE OFFICIAL RECORD OF THIS SHEET IS THE ELECTRONIC FILE DIGITALLY SIGNED AND SEALED UNDER RULE 61G15-23.004, F.A.C.

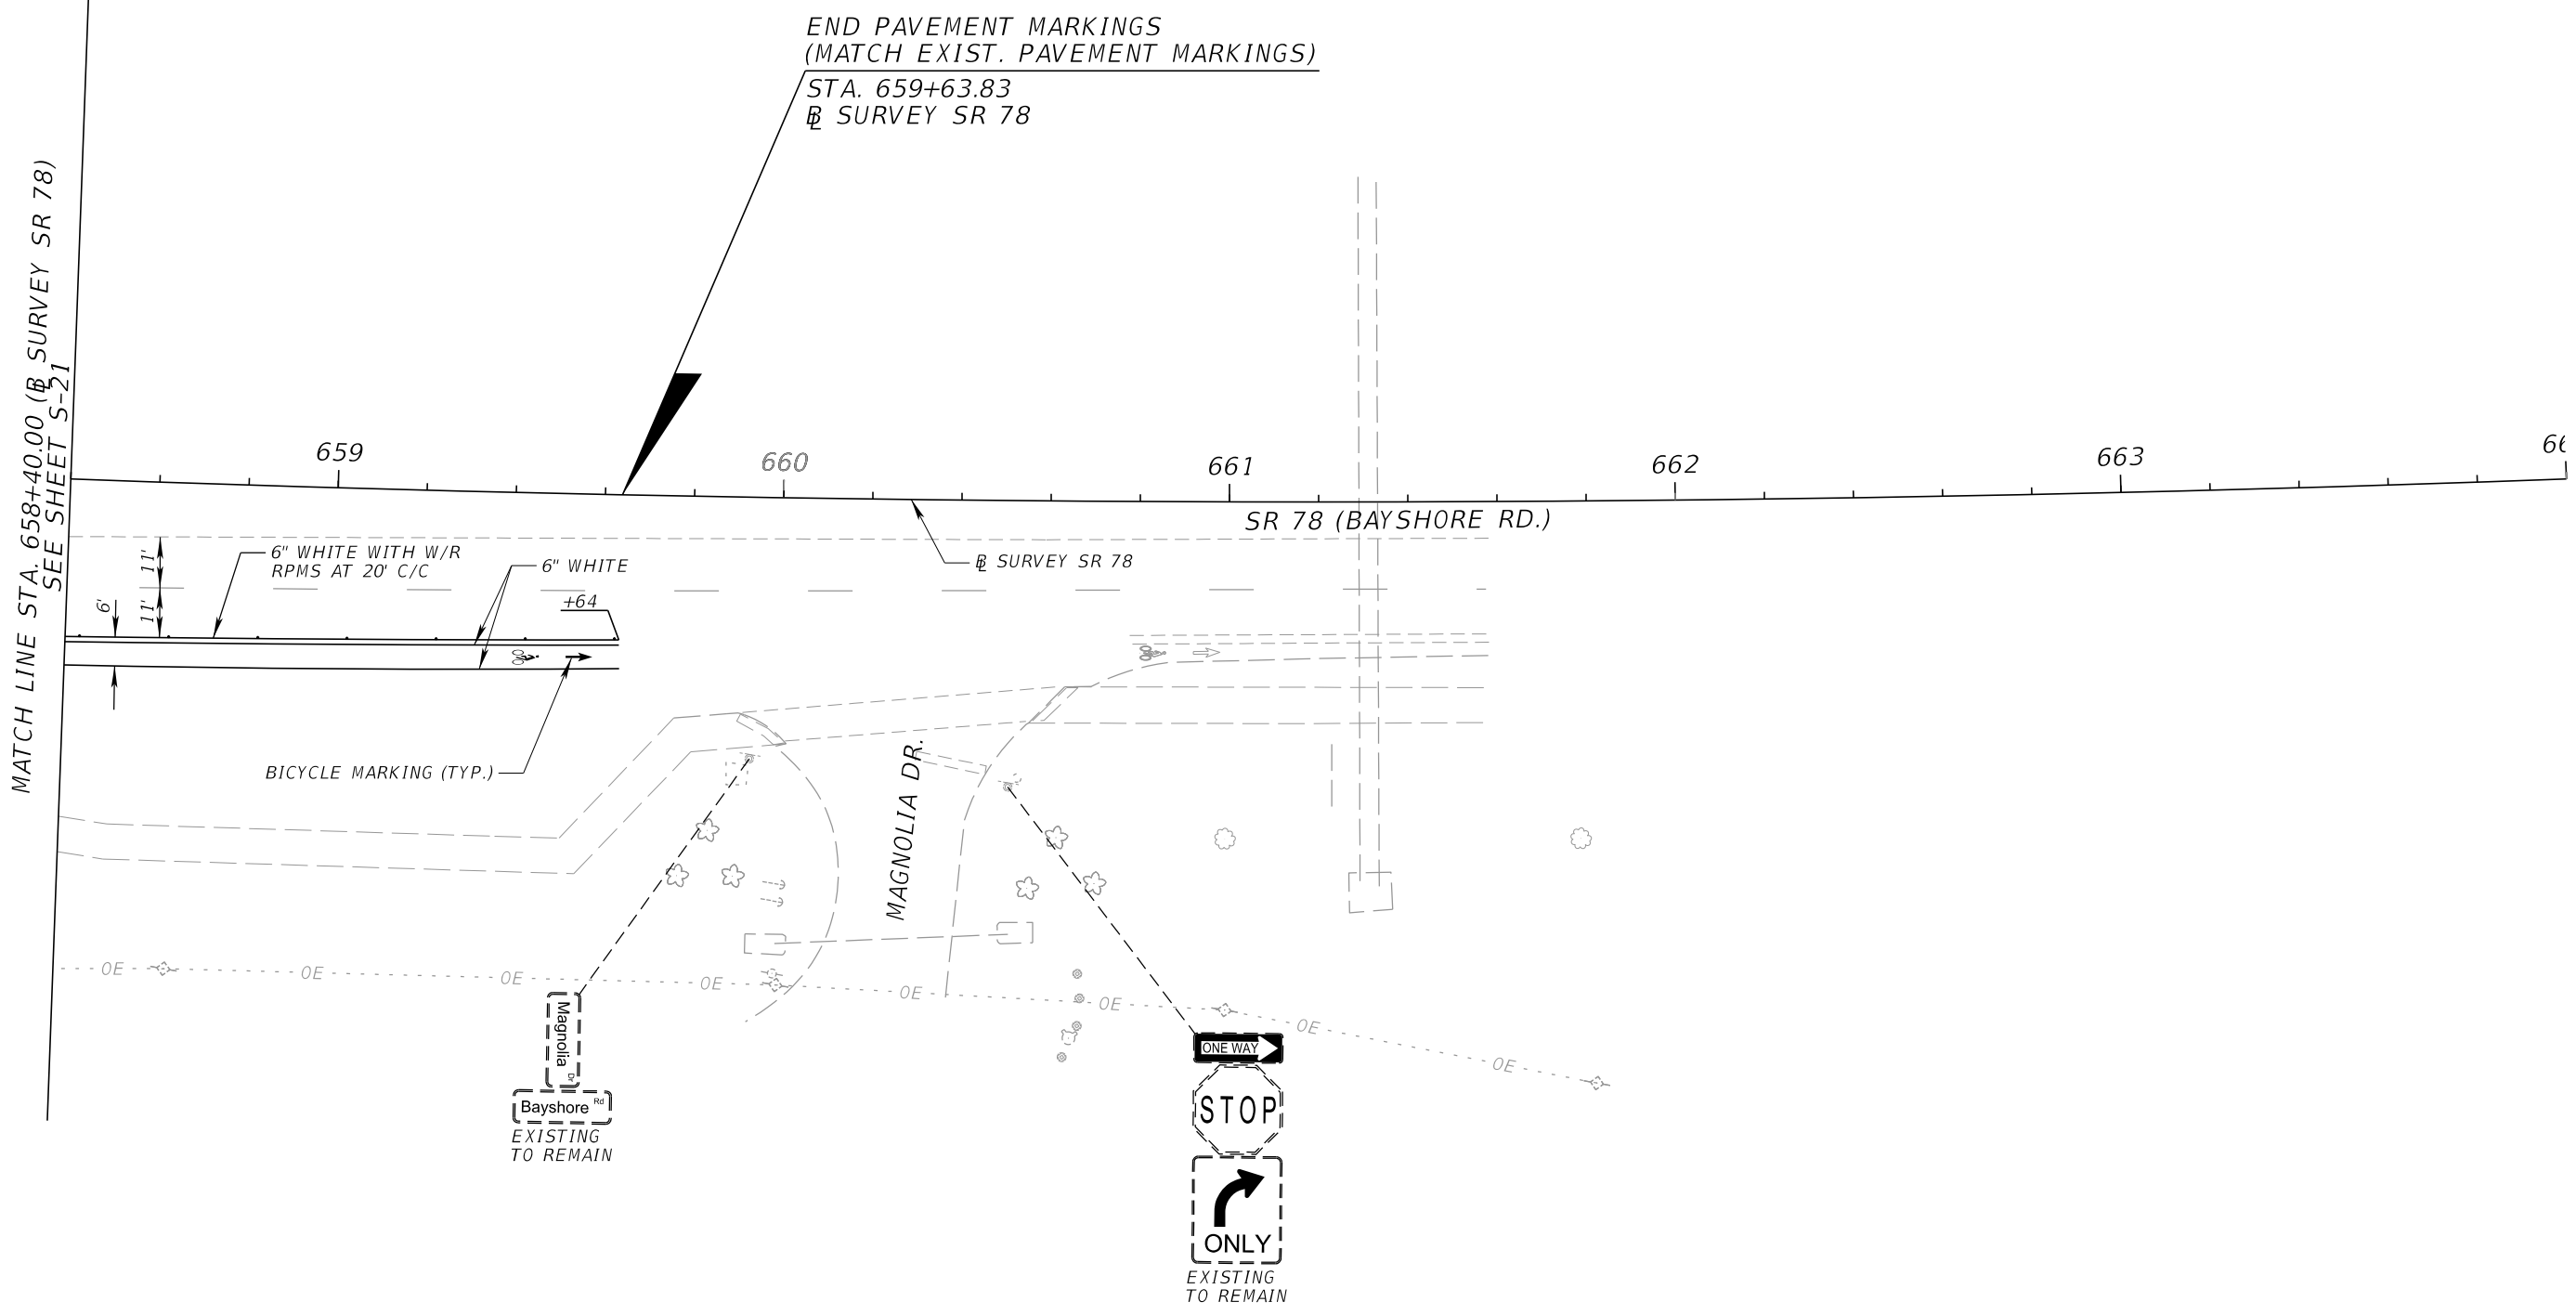

8/14/2023 9:04:15 PM LizetteMartinez C:\Users\Justin\Iniquist\AEG\Projects - Documents\FDOT\4629315201\SigningAndMarking\PLANS\PO1.dgn

REVISIONS				ENGINEER OF RECORD		STATE OF FLORIDA DEPARTMENT OF TRANSPORTATION			SHEET NO.	
DATE	DESCRIPTION	DATE	DESCRIPTION				ROAD NO.	COUNTY		FINANCIAL PROJECT ID
				EREZ DAYAN, P.E. LICENSE NUMBER: 62144 AVANT ENGINEERING GROUP, LLC 2699 LEE ROAD, SUITE 401 WINTER PARK, FL 32789			SR 739	LEE	446293-1-52-01	S-22

**SIGNING AND PAVEMENT
MARKING PLAN (20)**

THE OFFICIAL RECORD OF THIS SHEET IS THE ELECTRONIC FILE DIGITALLY SIGNED AND SEALED UNDER RULE 61G15-23.004, F.A.C.

