

CONTRACT PLANS COMPONENTS

ROADWAY
SIGNING AND PAVEMENT MARKING
SIGNALIZATION
LIGHTING
STRUCTURES

STATE OF FLORIDA
DEPARTMENT OF TRANSPORTATION
LIGHTING PLANS

FINANCIAL PROJECT ID 441512-1-52-01 & 441512-1-52-02
(FEDERAL FUNDS)
COLLIER COUNTY (03010)
SR 45 (US 41)


INDEX OF LIGHTING PLANS

SHEET NO.	SHEET DESCRIPTION
L-1	KEY SHEET
L-2	SIGNATURE SHEET
L-3	GENERAL NOTES AND LEGEND
L-4 - L-5	LIGHTING DATA TABLE
L-6 - L-14	LIGHTING PLAN

END PROJECT
STA. 131+73.57
MP 1.181

FROM N OF OLD US 41 TO S OF GULF PARK DR

STA. 383+11.88 @ SURVEY US 41 SOUTH =
STA. 107+05.94 @ SURVEY US 41 NORTH
T 48 S
T 49 S

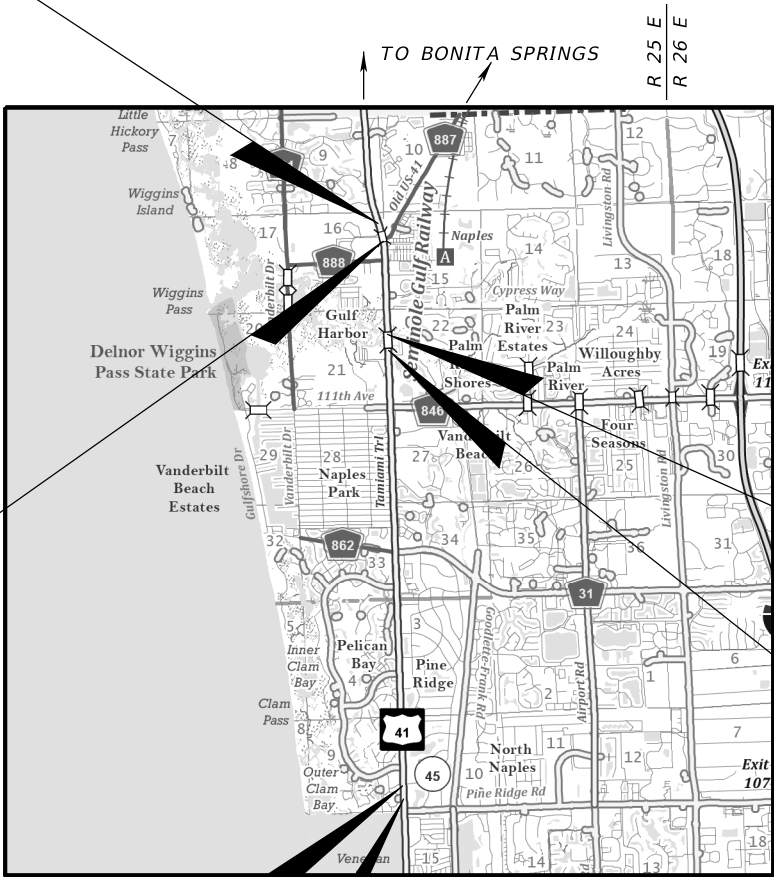

BEGIN PROJECT
STA. 159+05.02
MP 5.888

BEGIN CONSTRUCTION
STA. 156+07.05
MP 5.945

END BRIDGE NO. 030017
END BRIDGE NO. 030306
STA. 347+08.51

BEGIN BRIDGE NO. 030017
BEGIN BRIDGE NO. 030306
STA. 345+13.41

PHASE IIIR
MAY 2026

LIGHTING PLANS
ENGINEER OF RECORD:

TUCKER DAVID AMMERMAN, P.E.
P.E. LICENSE NUMBER 92342
FALLER, DAVIS & ASSOCIATES, INC.
1150 ASSEMBLY DRIVE, SUITE 400
TAMPA, FL 33607-4874
813-261-5136
CONTRACT NO.: CA411
VENDOR NO.: F592594956001

FDOT PROJECT MANAGER:
DAVID J. AGACINSKI

GOVERNING STANDARD PLANS:

Florida Department of Transportation, FY2026-27 Standard Plans for Road and Bridge Construction and applicable Interim Revisions (IRs).


Standard Plans for Road Construction and associated IRs are available at the following website: <http://www.fdot.gov/design/standardplans>

APPLICABLE IRs: N/A


Standard Plans for Bridge Construction are included in the Structures Plans Component

GOVERNING STANDARD SPECIFICATIONS:


Florida Department of Transportation, FY2026-27 Standard Specifications for Road and Bridge Construction at the following website: <http://www.fdot.gov/programmanagement/Implemented/SpecBooks>

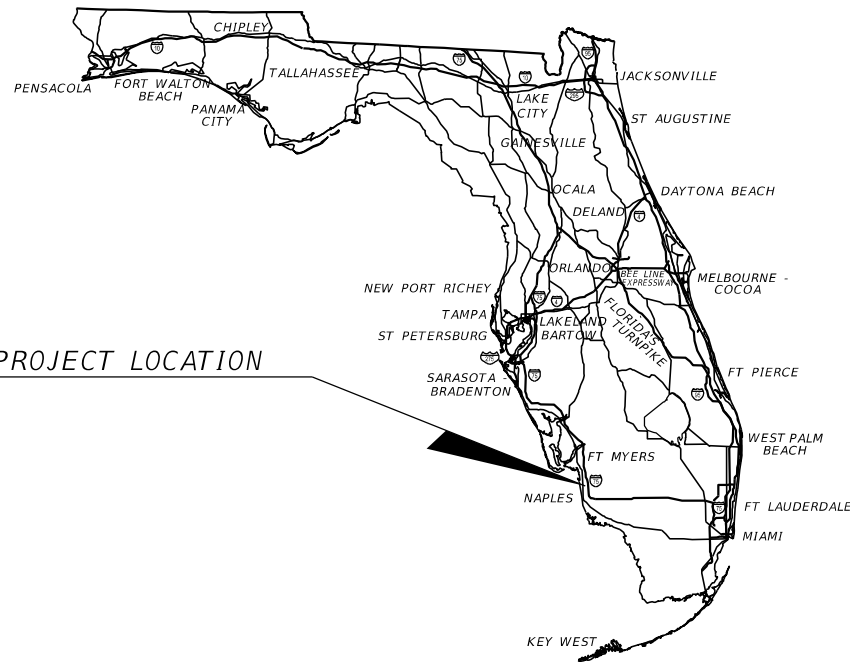

CONSTRUCTION CONTRACT NO.	FISCAL YEAR	SHEET NO.
T1837	27	L-1

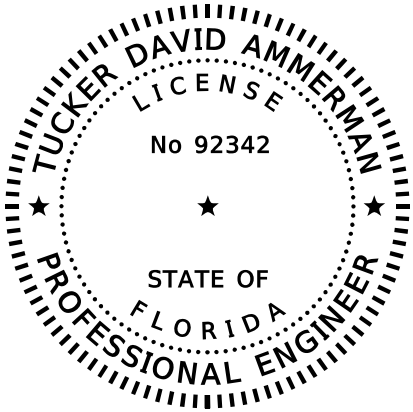

 THIS ITEM HAS BEEN DIGITALLY
SIGNED AND SEALED BY



ON THE DATE ADJACENT TO THE SEAL

SIGNATURE MUST BE VERIFIED
ON ANY ELECTRONIC COPIES.

FALLER, DAVIS & ASSOCIATES, INC
1150 ASSEMBLY DRIVE, SUITE 400
TAMPA, FLORIDA 33607-4874
TUCKER DAVID AMMERMAN, P.E. NO.: 92342

THE ABOVE NAMED PROFESSIONAL ENGINEER SHALL BE RESPONSIBLE FOR THE
FOLLOWING SHEETS IN ACCORDANCE WITH RULE 61G15-23.004, F.A.C.

<u>SHEET NO.</u>	<u>SHEET DESCRIPTION</u>
L - 1	KEY SHEET
L - 2	SIGNATURE SHEET
L - 3	GENERAL NOTES AND LEGEND
L - 4 - L - 5	LIGHTING DATA TABLE
L - 6 - L - 14	LIGHTING PLAN

REVISIONS				ENGINEER OF RECORD	STATE OF FLORIDA DEPARTMENT OF TRANSPORTATION			SIGNATURE SHEET	SHEET NO.
DATE	DESCRIPTION	DATE	DESCRIPTION	TUCKER DAVID AMMERMAN, P.E. LICENSE NUMBER: 92342 FALLER, DAVIS & ASSOCIATES, INC. 1150 ASSEMBLY DRIVE, SUITE 400 TAMPA, FL 33607-4874	ROAD NO.	COUNTY	FINANCIAL PROJECT ID		L-2
					SR 45	COLLIER	441512-1-52-01		

LEGEND

DESCRIPTION

GENERAL NOTES:

 
- 
- PROPOSED PULL BOX.
- 
- EXISTING PULL BOX.
- 
- PROPOSED TRAFFIC SIGNAL CONTROLLER.
- 
- EXISTING SERVICE POINT.
- 
- EXISTING LOAD CENTER.




OPEN TRENCH CONDUIT.



DIRECTIONAL BORE CONDUIT.



 PROPOSED LIGHT POLE. STANDARD SHAFT FOUNDATION.



PROPOSED LIGHT POLE. STANDARD SPREAD FOOTING FOUNDATION.



PROPOSED LUMINAIRE AND BRACKET. SIGNAL MOUNTED.



UTILITY CONFLICT POLE.



EXISTING LUMINAIRE TO BE RETROFIT.



EXISTING POLE AND LUMINAIRE TO REMAIN.



EXISTING LUMINAIRE AND POLE TO BE REMOVED.

1. CAP ALL SPARE CONDUITS AT PAVEMENT CROSSINGS AT BOTH ENDS AND ROUTE THEM TO THE NEAREST LIGHTING PULL BOX.
2. COLLIER COUNTY WILL MAINTAIN THE LIGHTING SYSTEM UPON FINAL ACCEPTANCE.
3. POWER THE LIGHTING SYSTEM THROUGH THE MINI LOAD CENTER IN THE SIGNAL CABINET. REFER TO THE SIGNAL PLANS FOR PAYMENT AND DETAILED NOTES.
4. CONSTRUCT THE CONCRETE SLAB INTEGRALLY WITH THE RECONSTRUCTED SIDEWALK WHEN THE SLAB IS SHOWN ADJACENT TO THE SIDEWALK.
5. HAND DIG THE FIRST FOUR (4) FEET AT EACH LOCATION OF LIGHT POLES.

PAY ITEM NOTES:

- 635-2-11: SPLICING OF EXISTING LIGHTING CONDUCTORS WHERE EXISTING LIGHT POLES ARE BEING REMOVED IS INCLUDED IN THE COST OF THE PULL BOX BEING PLACED AT THAT LOCATION.
- 635-2-14: 17 X 30 INCH DIMENSIONED PULL BOXES ARE TO BE USED ADJACENT TO SIGNAL PULL BOXES.

NOTE TO REVIEWER:
COORDINATION WITH UTILITIES IS ONGOING. POLE LOCATIONS ARE SUBJECT TO CHANGE.



REVISIONS				ENGINEER OF RECORD	STATE OF FLORIDA DEPARTMENT OF TRANSPORTATION			GENERAL NOTES AND LEGEND	SHEET NO.
DATE	DESCRIPTION		DATE	DESCRIPTION	ROAD NO.	COUNTY	FINANCIAL PROJECT ID		L-3
				TUCKER DAVID AMMERMAN, P.E. LICENSE NUMBER: 92342 FALLER, DAVIS & ASSOCIATES, INC. 1150 ASSEMBLY DRIVE, SUITE 400 TAMPA, FL 33607-4874	SR 45	COLLIER	441512-1-52-01		

LIGHTING DATA TABLE																	
US 41 INTERSECTION (CRITERIA USED)	POLE NO.	STATION	OFFSET	MAINTAINING AGENCY	POLE TYPE	ARM LENGTH	ORIENTATION (DEGREES)	LUMINAIRE MAKE/MODEL	LUMENS	IES DISTRIBUTION PATTERN	CORRELATED COLOR TEMPERATURE	MOUNTING HEIGHT	WATTAGE	VOLTAGE	CIRCUIT NUMBER	FOUNDATION	PAY ITEM NUMBER
PELICAN BAY BLVD (NEW)	2	208+92	51' RT.	COLLIER COUNTY	STANDARD	15'	*	ARCHEON LARGE	32484	IV	3000K	40'	280	120	A-2	SPREAD FOOT.	715-61-352
	1-4	209+60	108' LT.	COLLIER COUNTY	SIGNAL	15'	***	ARCHEON LARGE	22604	IV	3000K	40'	160	120	A-1	N/A	715-5-32
	1-3	209+69	49' RT.	COLLIER COUNTY	SIGNAL	15'	***	ARCHEON LARGE	22604	IV	3000K	40'	160	120	A-2	N/A	715-5-32
	4	209+69	161' LT.	COLLIER COUNTY	STANDARD	0'	*	ARCHEON MEDIUM	19977	IV	3000K	40'	160	120	A-1	SHAFT	715-61-300
	1-2	210+72	44' RT.	COLLIER COUNTY	SIGNAL	15'	***	ARCHEON LARGE	22604	IV	3000K	40'	160	120	A-2	N/A	715-5-32
	1-1	210+93	113' LT.	COLLIER COUNTY	SIGNAL	15'	***	ARCHEON LARGE	22604	IV	3000K	40'	160	120	A-1	N/A	715-5-32
	6	211+53	95' LT.	COLLIER COUNTY	STANDARD	0'	*	ARCHEON LARGE	32484	IV	3000K	40'	280	120	A-1	SPREAD FOOT.	715-61-300
	144	EXIST.	EXIST.	COLLIER COUNTY	EXIST.	EXIST.	*	ARCHEON LARGE	32484	IV	3000K	EXIST.	280	120	EXIST.	EXIST.	715-11-211
VANDERBILT BEACH RD (NEW)	11	228+66	58' RT.	COLLIER COUNTY	STANDARD	15'	*	ARCHEON LARGE	32484	IV	3000K	40'	280	120	B-1	SPREAD FOOT.	715-61-352
	2-3	229+03	73' RT.	COLLIER COUNTY	SIGNAL	15'	***	ARCHEON LARGE	32484	IV	3000K	40'	280	120	B-1	N/A	715-5-32
	92	EXIST.	EXIST.	COLLIER COUNTY	EXIST.	EXIST.	*	ARCHEON LARGE	32484	IV	3000K	EXIST.	280	120	EXIST.	EXIST.	715-11-211
	16	230+34	134' RT.	COLLIER COUNTY	STANDARD	15'	*	ARCHEON LARGE	32484	IV	3000K	40'	280	120	B-1	SPREAD FOOT.	715-61-352
	2-1	230+45	120' LT.	COLLIER COUNTY	SIGNAL	15'	***	ARCHEON LARGE	32484	IV	3000K	40'	280	120	B-2	N/A	715-5-32
	2-2	230+48	54' RT.	COLLIER COUNTY	SIGNAL	15'	***	ARCHEON LARGE	32484	IV	3000K	40'	280	120	B-1	N/A	715-5-32
	2-4	228+91	93' LT.	COLLIER COUNTY	SIGNAL	15'	***	ARCHEON LARGE	32484	IV	3000K	40'	280	120	B-2	N/A	715-5-32
	18	231+39	95' LT.	COLLIER COUNTY	STANDARD	15'	*	ARCHEON LARGE	32484	IV	3000K	40'	280	120	B-2	SPREAD FOOT.	715-61-352
	19	EXIST.	EXIST.	COLLIER COUNTY	EXIST.	EXIST.	*	ARCHEON LARGE	32484	IV	3000K	40'	280	120	B-2	EXIST.	715-11-211
STRADA PLACE/ 91ST AVE N (RETROFIT)	21	242+88	84' LT.	COLLIER COUNTY	STANDARD	15'	*	ARCHEON LARGE	26316	IV	3000K	40'	200	120	C-1	SPREAD FOOT.	715-61-352
	114	EXIST.	EXIST.	COLLIER COUNTY	EXIST.	EXIST.	*	ARCHEON LARGE	26316	IV	3000K	EXIST.	200	120	EXIST.	EXIST.	715-11-211
	22	243+46	125' LT.	COLLIER COUNTY	STANDARD	0'	*	ARCHEON LARGE	26316	IV	3000K	40'	200	120	C-1	SPREAD FOOT.	715-61-300
	24	244+63	84' LT.	COLLIER COUNTY	STANDARD	15'	*	ARCHEON LARGE	26316	IV	3000K	40'	200	120	C-1	SPREAD FOOT.	715-61-352
	25	244+70	50' RT.	COLLIER COUNTY	STANDARD	15'	*	ARCHEON LARGE	26316	IV	3000K	40'	200	120	C-1	SPREAD FOOT.	715-61-352
PELICAN MARSH BLVD/ 99TH AVE N (NEW)	94B	EXIST.	EXIST.	COLLIER COUNTY	EXIST.	EXIST.	*	ARCHEON MEDIUM	19977	IV	3000K	EXIST.	160	120	EXIST.	EXIST.	715-11-211
	32	269+38	60' RT.	COLLIER COUNTY	STANDARD	0'	45 **	ARCHEON MEDIUM	19977	IV	3000K	40'	160	120	D-1	SPREAD FOOT.	715-61-300
	33	269+77	93' LT.	COLLIER COUNTY	STANDARD	0'	300 **	ARCHEON MEDIUM	19977	IV	3000K	40'	160	120	D-1	SHAFT	715-61-300
	4-2	270+80	47' RT.	COLLIER COUNTY	SIGNAL	15'	***	ARCHEON MEDIUM	19977	IV	3000K	40'	160	120	D-1	N/A	715-5-32
	61	EXIST.	EXIST.	COLLIER COUNTY	EXIST.	EXIST.	*	ARCHEON LARGE	32484	IV	3000K	EXIST.	280	120	EXIST.	EXIST.	715-11-211
* LUMINAIRE IS ORIENTED PERPENDICULAR TO ROADWAY ** ORIENTATION MEASURED COUNTER CLOCKWISE FROM TRUE NORTH *** SEE SIGNAL PLANS																	
SIGNALIZED INTERSECTION NEW RECONSTRUCTION CRITERIA AVERAGE INITIAL HORIZONTAL INTENSITY AVERAGE INITIAL VERTICAL INTENSITY UNIFORMITY RATIO AVG./MIN. UNIFORMITY RATIO MAX./MIN. WIND SPEED 3.0 FC STANDARD 1.5 FC MINIMUM 1.5 FC STANDARD 1.2 FC MINIMUM 4:1 OR LESS 10:1 OR LESS 160 MPH SIGNALIZED INTERSECTION LIGHTING RETROFIT CRITERIA AVERAGE INITIAL HORIZONTAL INTENSITY AVERAGE INITIAL VERTICAL INTENSITY UNIFORMITY RATIO AVG./MIN. UNIFORMITY RATIO MAX./MIN. WIND SPEED 1.5 FC STANDARD 1.0 FC MINIMUM 1.5 FC STANDARD 1.0 FC MINIMUM 4:1 OR LESS 10:1 OR LESS 160 MPH																	
REVISIONS						ENGINEER OF RECORD				STATE OF FLORIDA DEPARTMENT OF TRANSPORTATION			LIGHTING DATA TABLE (1)				SHEET NO.
DATE	DESCRIPTION		DATE	DESCRIPTION		TUCKER DAVID AMMERMAN, P.E. LICENSE NUMBER: 92342 FALLER, DAVIS & ASSOCIATES, INC. 1150 ASSEMBLY DRIVE, SUITE 400 TAMPA, FL 33607-4874				ROAD NO.	COUNTY	FINANCIAL PROJECT ID					L-4
										SR 45	COLLIER	441512-1-52-01					

THE OFFICIAL RECORD OF THIS SHEET IS THE ELECTRONIC FILE DIGITALLY SIGNED AND SEALED UNDER RULE 61G15-23.004, F.A.C.

LIGHTING DATA TABLE																	
US 41 INTERSECTION (CRITERIA USED)	POLE NO.	STATION	OFFSET	MAINTAINING AGENCY	POLE TYPE	ARM LENGTH	ORIENTATION (DEGREES)	LUMINAIRE MAKE/MODEL	LUMENS	IES DISTRIBUTION PATTERN	CORRELATED COLOR TEMPERATURE	MOUNTING HEIGHT	WATTAGE	VOLTAGE	CIRCUIT NUMBER	FOUNDATION	PAY ITEM NUMBER
CREEKSIDE BLVD/ 107TH AVE N (RETORFIT)	44	296+71	97' RT.	COLLIER COUNTY	STANDARD	0'	*	ARCHEON MEDIUM	19977	IV	3000K	40'	160	120	E-1	SPREAD FOOT.	715-61-300
	5-1	EXIST.	EXIST.	COLLIER COUNTY	EXIST.	EXIST.	EXIST.	ARCHEON MEDIUM	19977	IV	3000K	EXIST.	160	120	E-1	N/A	715-11-211
	5-2	EXIST.	EXIST.	COLLIER COUNTY	EXIST.	EXIST.	EXIST.	ARCHEON MEDIUM	19977	IV	3000K	EXIST.	160	120	E-1	N/A	715-11-211
IMMOKALEE RD/ 111TH AVE N (NEW)	31	EXIST.	EXIST.	COLLIER COUNTY	EXIST.	EXIST.	*	ARCHEON LARGE	32484	IV	3000K	EXIST.	280	120	EXIST.	EXIST.	715-11-211
	51	307+84	54' RT.	COLLIER COUNTY	STANDARD	0'	*	ARCHEON LARGE	32484	IV	3000K	40'	280	120	F-2	SPREAD FOOT.	715-61-300
	6-4	308+65	76' RT.	COLLIER COUNTY	SIGNAL	15'	***	ARCHEON LARGE	32484	IV	3000K	40'	280	120	F-2	N/A	715-5-32
	6-5	308+65	98' LT.	COLLIER COUNTY	SIGNAL	15'	***	ARCHEON LARGE	32484	IV	3000K	40'	280	120	F-1	N/A	715-5-32
	53	308+75	145' LT.	COLLIER COUNTY	STANDARD	0'	*	ARCHEON LARGE	32484	IV	3000K	40'	280	120	F-1	SHAFT	715-61-300
	6-1	310+11	111' LT.	COLLIER COUNTY	SIGNAL	15'	***	ARCHEON LARGE	32484	IV	3000K	40'	280	120	F-1	N/A	715-5-32
	54	310+12	154' RT.	COLLIER COUNTY	STANDARD	0'	*	ARCHEON LARGE	32484	IV	3000K	40'	280	120	F-2	SPREAD FOOT.	715-61-300
	6-3	310+16	74' RT.	COLLIER COUNTY	SIGNAL	15'	***	ARCHEON LARGE	32484	IV	3000K	40'	280	120	F-2	N/A	715-5-32
IMPERIAL GOLF COURSE BLVD (NEW)	56	310+55	96' LT.	COLLIER COUNTY	STANDARD	15'	*	ARCHEON LARGE	32484	IV	3000K	40'	280	120	F-1	SPREAD FOOT.	715-61-352
	61	369+64	46' RT.	COLLIER COUNTY	STANDARD	15'	*	ARCHEON LARGE	32484	IV	3000K	40'	280	120	G-1	SPREAD FOOT.	715-61-352
	62	370+44	85' LT.	COLLIER COUNTY	UTIL. CONFL. POLE	16'	*	ARCHEON LARGE	32484	IV	3000K	35'	280	120	G-1	SPREAD FOOT.	715-65-266
	7-1	371+42	41' RT.	COLLIER COUNTY	SIGNAL	15'	***	ARCHEON LARGE	32484	IV	3000K	40'	280	120	G-1	N/A	715-5-32
WIGGINS PASS RD (NEW)	63	371+58	85' LT	COLLIER COUNTY	UTIL. CONFL. POLE	16'	*	ARCHEON LARGE	32484	IV	3000K	35'	280	120	G-1	SPREAD FOOT.	715-65-266
	16	EXIST.	EXIST.	COLLIER COUNTY	EXIST.	EXIST.	*	ARCHEON LARGE	32484	IV	3000K	EXIST.	280	120	EXIST.	EXIST.	715-11-211
	13	EXIST.	EXIST.	COLLIER COUNTY	EXIST.	EXIST.	*	ARCHEON LARGE	32484	IV	3000K	EXIST.	280	120	EXIST.	EXIST.	715-11-211
	11	EXIST.	EXIST.	COLLIER COUNTY	EXIST.	EXIST.	*	ARCHEON LARGE	32484	IV	3000K	EXIST.	280	120	EXIST.	EXIST.	715-11-211
	8-3	113+10	66' LT.	COLLIER COUNTY	SIGNAL	15'	***	ARCHEON LARGE	28072	IV	3000K	40'	220	120	H-1	N/A	715-5-32
	71	112+92	98' RT.	COLLIER COUNTY	STANDARD	0'	40**	ARCHEON LARGE	32484	IV	3000K	40'	280	120	H-2	SPREAD FOOT.	715-61-300
	72	114+33	132' LT.	COLLIER COUNTY	STANDARD	15'	*	ARCHEON LARGE	32484	IV	3000K	40'	280	120	H-1	SHAFT	715-61-352
	73	113+89	127' RT.	COLLIER COUNTY	STANDARD	0'	*	ARCHEON LARGE	32484	IV	3000K	40'	280	120	H-2	SPREAD FOOT.	715-61-300
OLD US 41/ SHOPPING CENTER ENTRANCE (NEW)	74	114+33	73' LT.	COLLIER COUNTY	STANDARD	0'	220**	ARCHEON LARGE	28072	IV	3000K	40'	220	120	H-1	SHAFT	715-61-300
	8-2	114+00	80' RT.	COLLIER COUNTY	SIGNAL	15'	***	ARCHEON LARGE	28072	IV	3000K	40'	220	120	H-2	N/A	715-5-32
	5	EXIST.	EXIST.	COLLIER COUNTY	EXIST.	EXIST.	*	ARCHEON LARGE	28072	IV	3000K	EXIST.	220	120	EXIST.	EXIST.	715-11-211
	6	EXIST.	EXIST.	COLLIER COUNTY	EXIST.	EXIST.	*	ARCHEON LARGE	32484	IV	3000K	EXIST.	280	120	EXIST.	EXIST.	715-11-211
	82	125+16	120' RT.	COLLIER COUNTY	UTIL. CONFL. POLE	16'	*	ARCHEON MEDIUM	18292	IV	3000K	35'	140	120	I-2	SHAFT	715-65-266
	83	126+33	84' LT.	COLLIER COUNTY	STANDARD	0'	270**	ARCHEON LARGE	28072	IV	3000K	40'	220	120	I-1	SHAFT	715-61-300
	9-3	124+75	72' LT.	COLLIER COUNTY	SIGNAL	8'	***	ARCHEON MEDIUM	19977	IV	3000K	40'	160	120	I-1	N/A	715-5-32
	85	125+16	110' RT.	COLLIER COUNTY	UTIL. CONFL. POLE	16'	85**	ARCHEON LARGE	28072	IV	3000K	35'	220	120	I-2	SHAFT	715-65-266
	86	125+98	82' RT	COLLIER COUNTY	STANDARD	15'	150**	ARCHEON MEDIUM	18292	IV	3000K	40'	140	120	I-2	SHAFT	715-61-352
	7	EXIST.	EXIST.	COLLIER COUNTY	EXIST.	EXIST.	*	ARCHEON LARGE	28072	IV	3000K	EXIST.	220	120	EXIST.	EXIST.	715-11-211
* LUMINAIRE IS ORIENTED PERPENDICULAR TO ROADWAY ** ORIENTATION MEASURED COUNTER CLOCKWISE FROM TRUE NORTH *** SEE SIGNAL PLANS																	
REVISIONS						ENGINEER OF RECORD				STATE OF FLORIDA DEPARTMENT OF TRANSPORTATION			LIGHTING DATA TABLE (2)				SHEET NO.
DATE	DESCRIPTION		DATE	DESCRIPTION		TUCKER DAVID AMMERMAN, P.E. LICENSE NUMBER: 92342 FALLER, DAVIS & ASSOCIATES, INC. 1150 ASSEMBLY DRIVE, SUITE 400 TAMPA, FL 33607-4874				ROAD NO.	COUNTY	FINANCIAL PROJECT ID					L-5
										SR 45	COLLIER	441512-1-52-01					

THE OFFICIAL RECORD OF THIS SHEET IS THE ELECTRONIC FILE DIGITALLY SIGNED AND SEALED UNDER RULE 61G15-23.004, F.A.C.

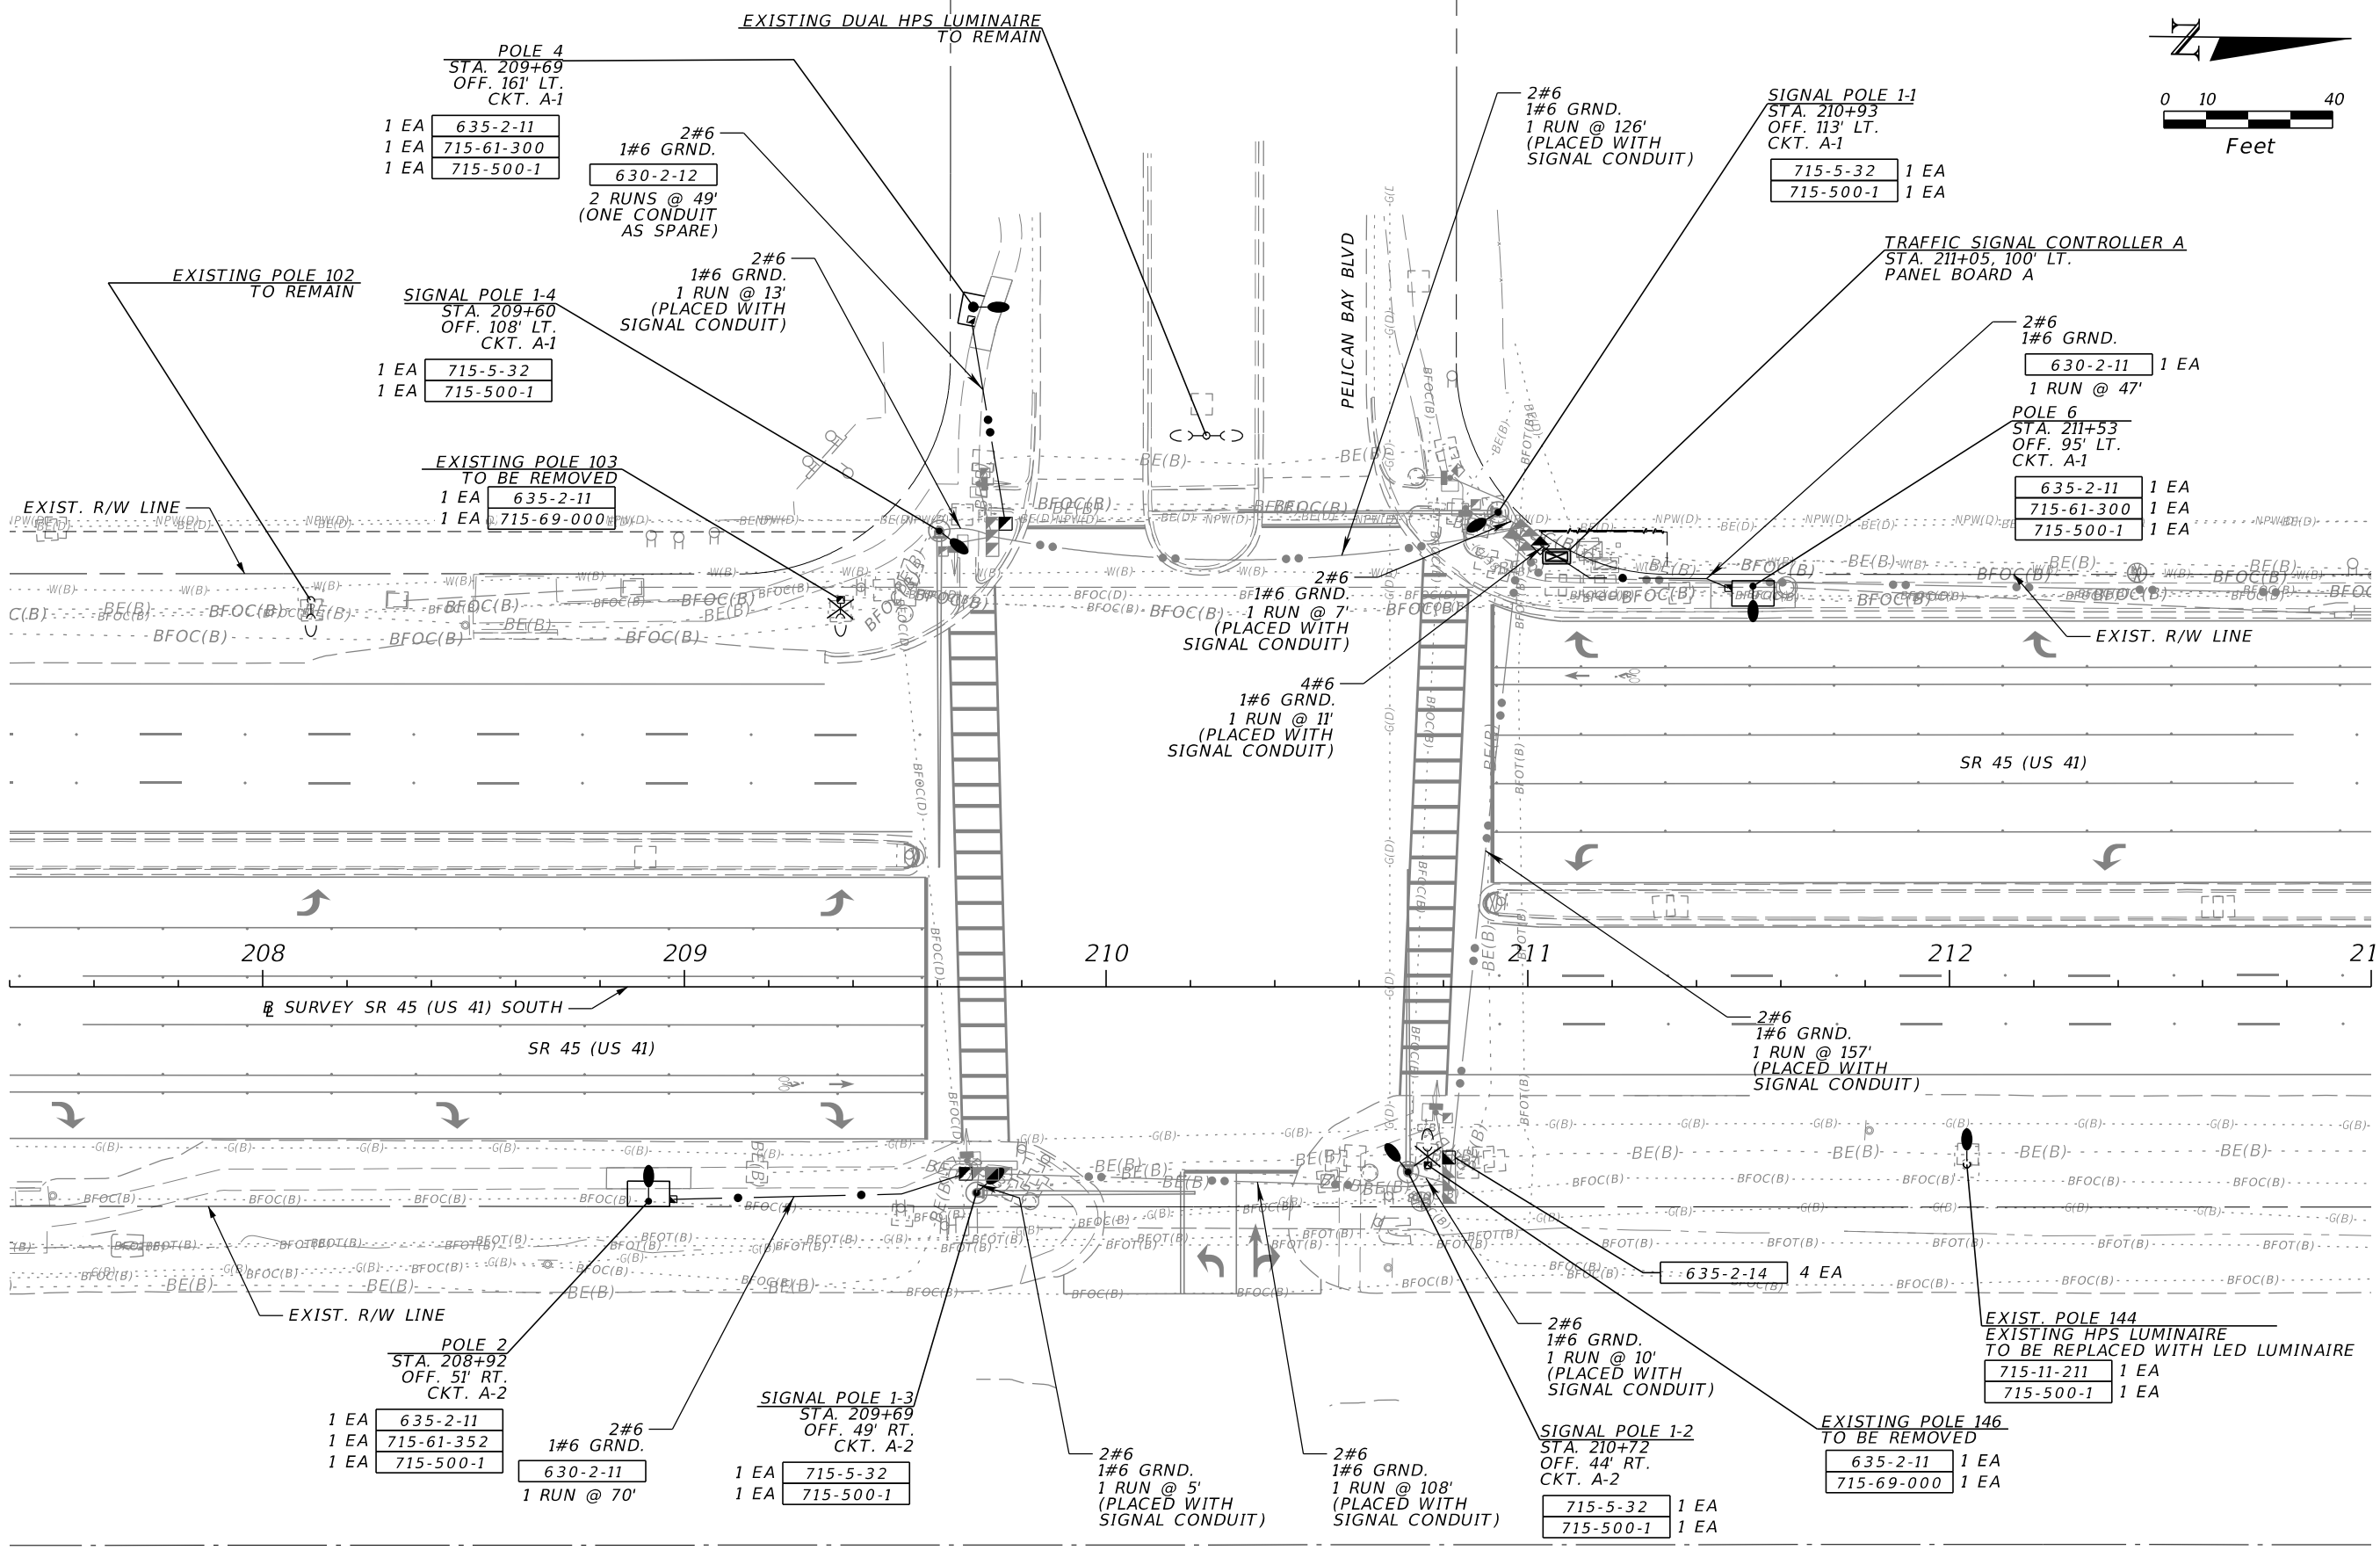
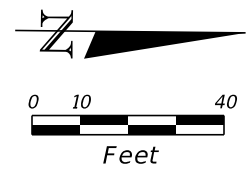


REVISIONS				ENGINEER OF RECORD	STATE OF FLORIDA DEPARTMENT OF TRANSPORTATION			SHEET NO.
DATE	DESCRIPTION	DATE	DESCRIPTION		ROAD NO.	COUNTY	FINANCIAL PROJECT ID	
					SR 45	COLLIER	441512-1-52-01	

LIGHTING PLAN (1)

L-6

THE OFFICIAL RECORD OF THIS SHEET IS THE ELECTRONIC FILE DIGITALLY SIGNED AND SEALED UNDER RULE 61G15-23.004, F.A.C.

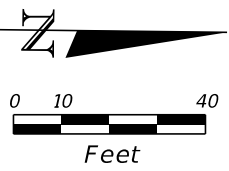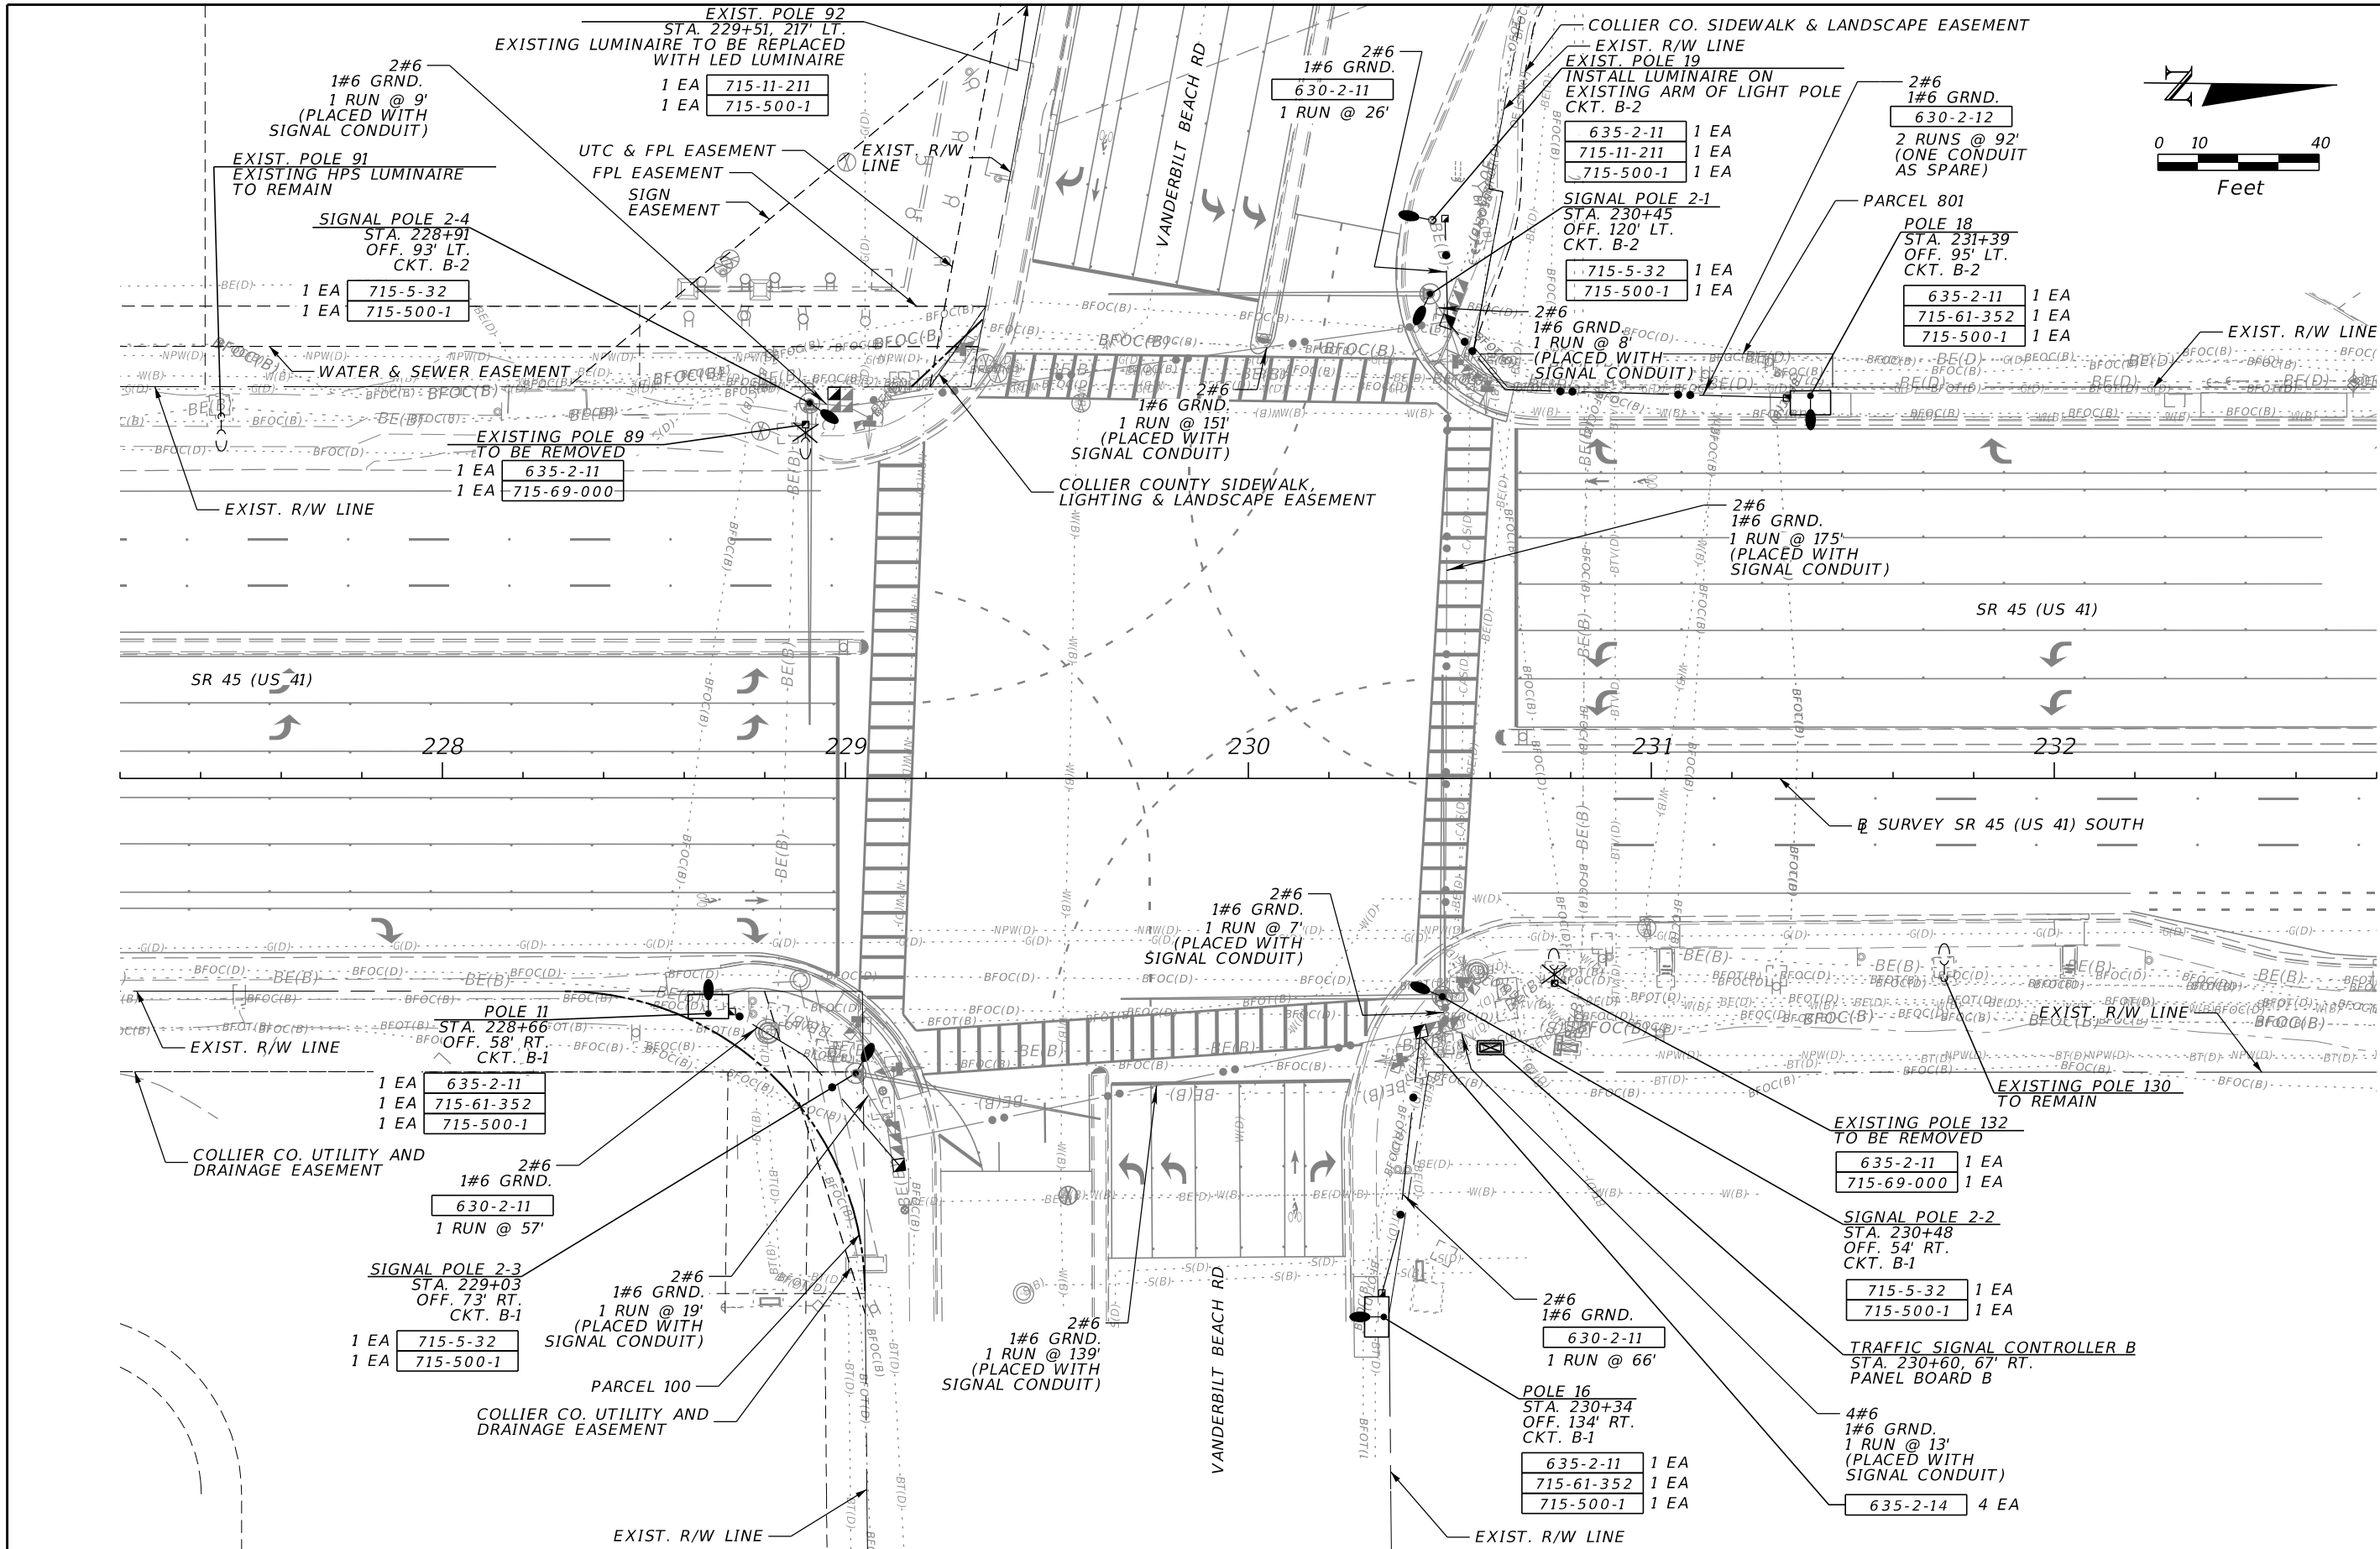


REVISIONS				ENGINEER OF RECORD	STATE OF FLORIDA DEPARTMENT OF TRANSPORTATION			SHEET NO.
DATE	DESCRIPTION	DATE	DESCRIPTION		ROAD NO.	COUNTY	FINANCIAL PROJECT ID	
					SR 45	COLLIER	441512-1-52-01	

LIGHTING PLAN (2)

L-7



THE OFFICIAL RECORD OF THIS SHEET IS THE ELECTRONIC FILE DIGITALLY SIGNED AND SEALED UNDER RULE 61G15-23.004, F.A.C.

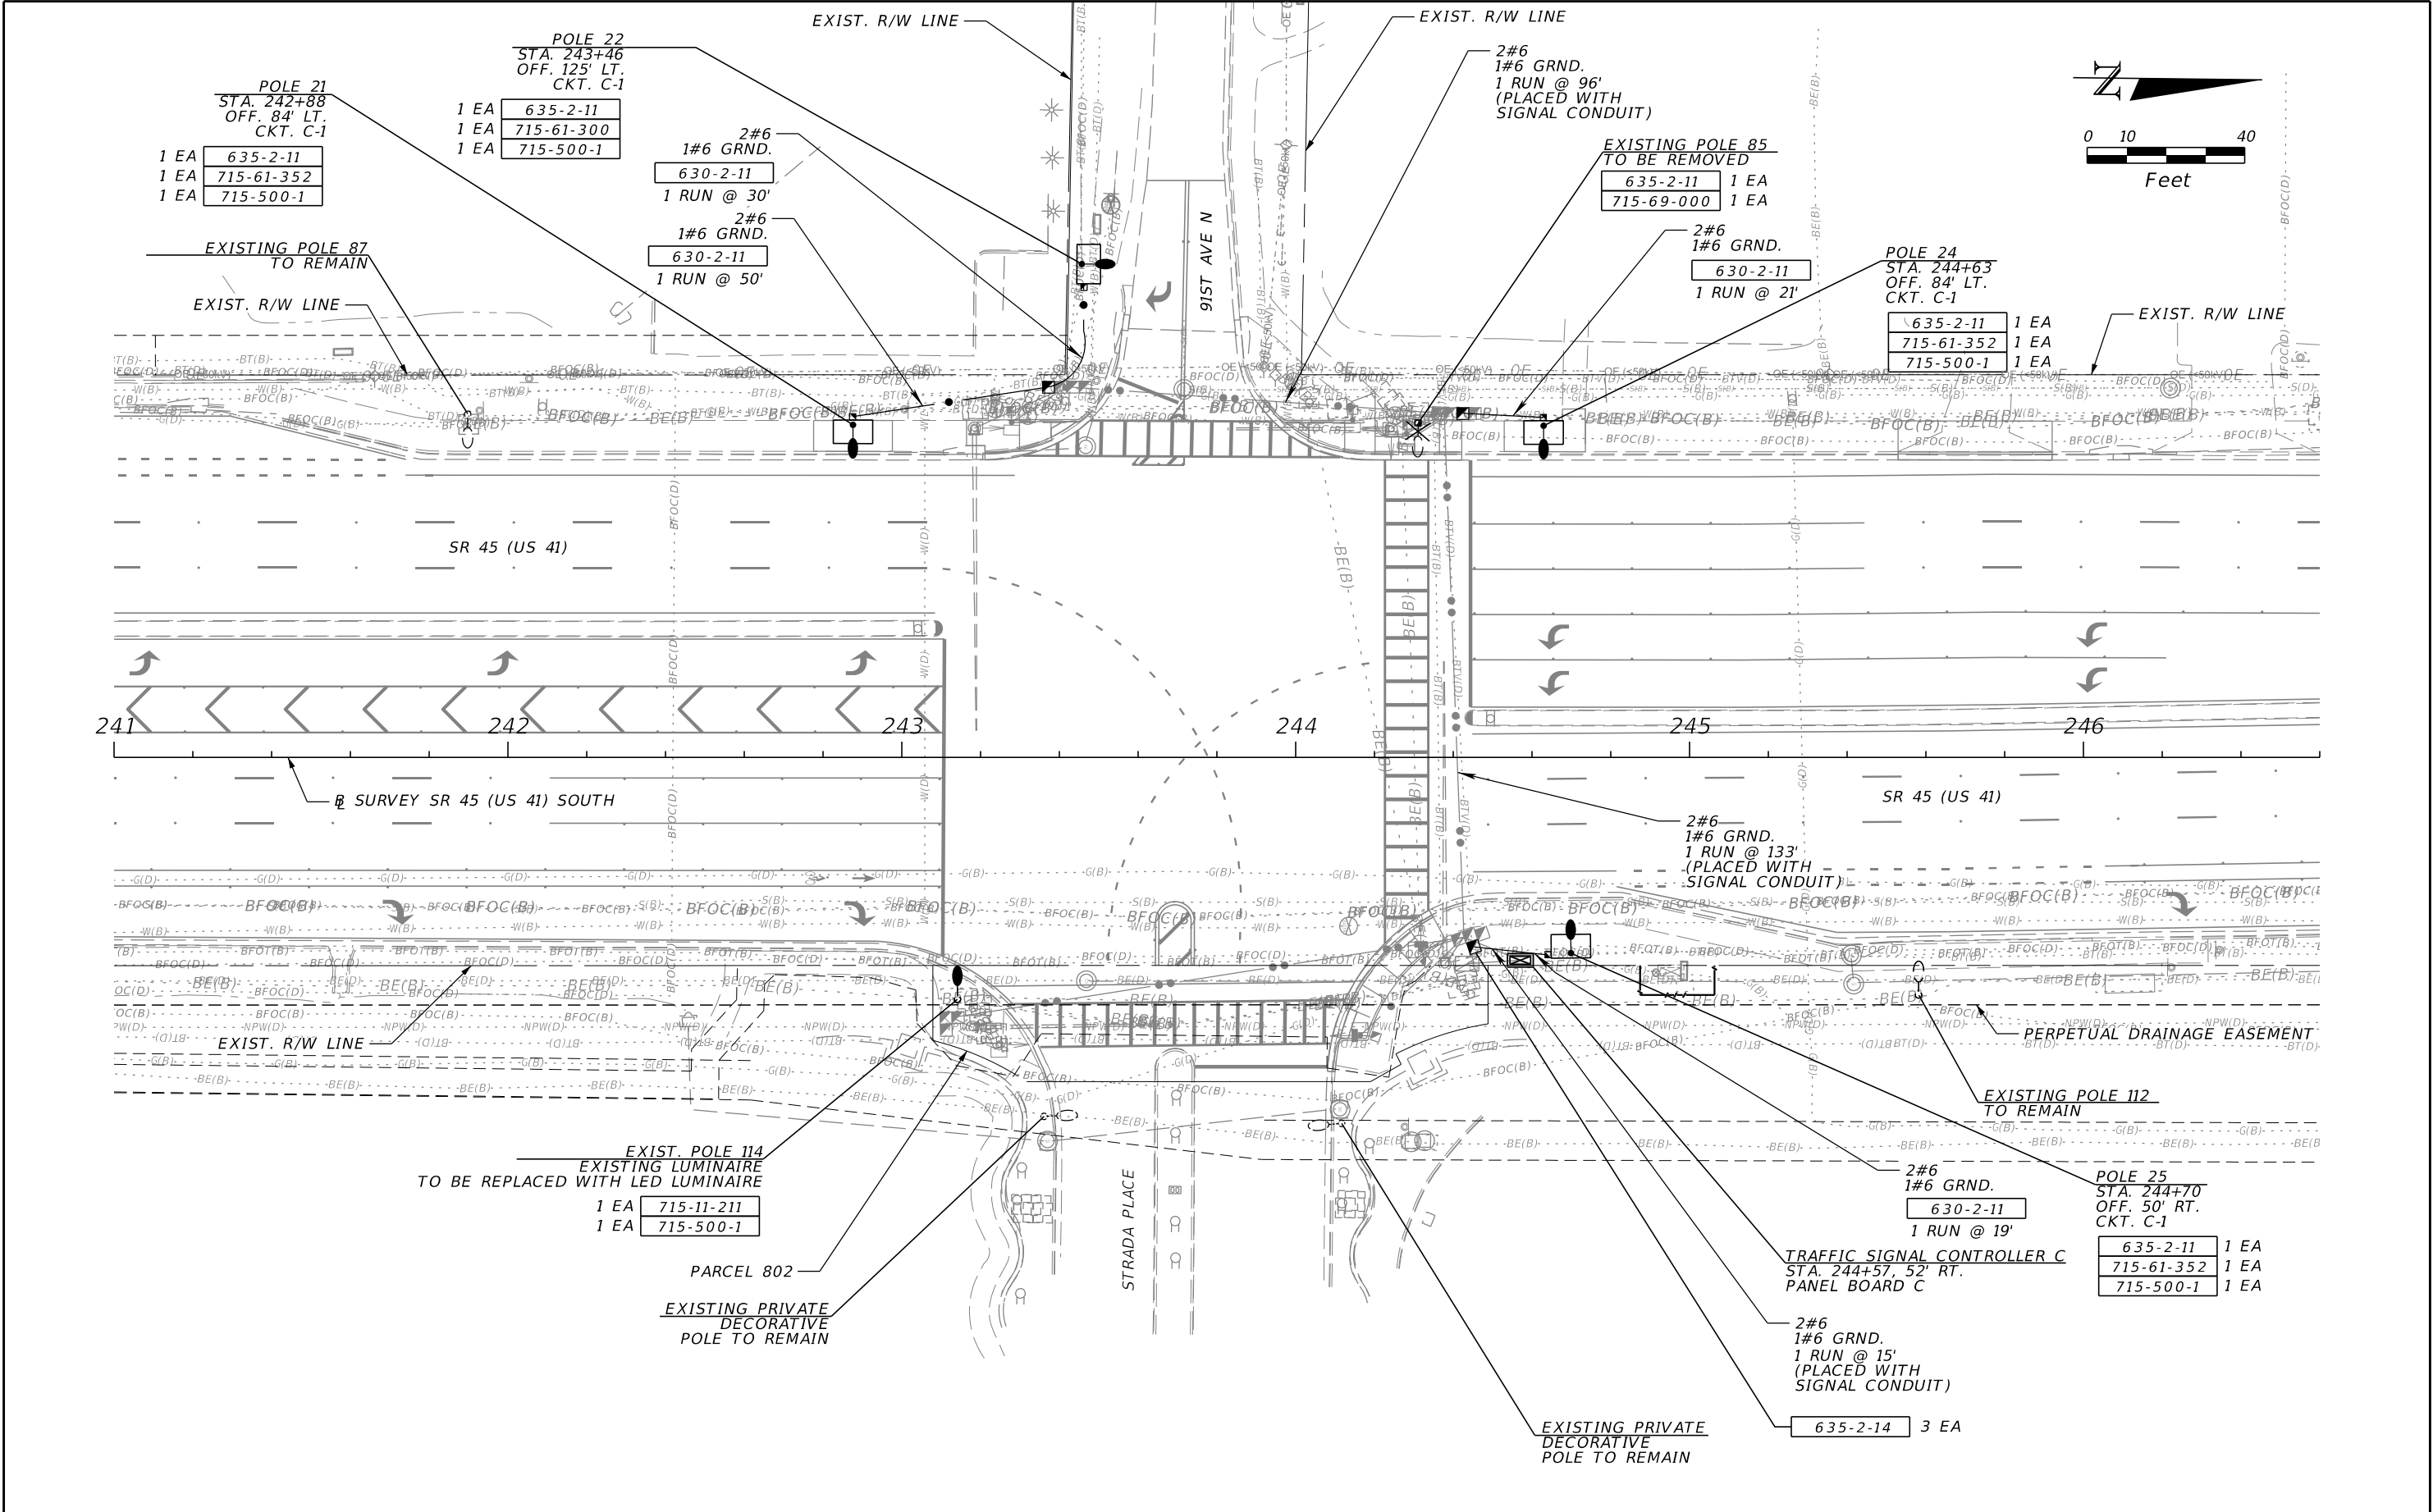

REVISIONS				ENGINEER OF RECORD		STATE OF FLORIDA DEPARTMENT OF TRANSPORTATION			SHEET NO.
DATE	DESCRIPTION	DATE	DESCRIPTION	TUCKER DAVID AMMERMAN, P.E. LICENSE NUMBER: 92342 FALLER, DAVIS & ASSOCIATES, INC. 1150 ASSEMBLY DRIVE, SUITE 400 TAMPA, FL 33607-4874		ROAD NO.	COUNTY	FINANCIAL PROJECT ID	
						SR 45	COLLIER	441512-1-52-01	

LIGHTING PLAN (3)



THE OFFICIAL RECORD OF THIS SHEET IS THE ELECTRONIC FILE DIGITALLY SIGNED AND SEALED UNDER RULE 61G15-23.004, F.A.C.

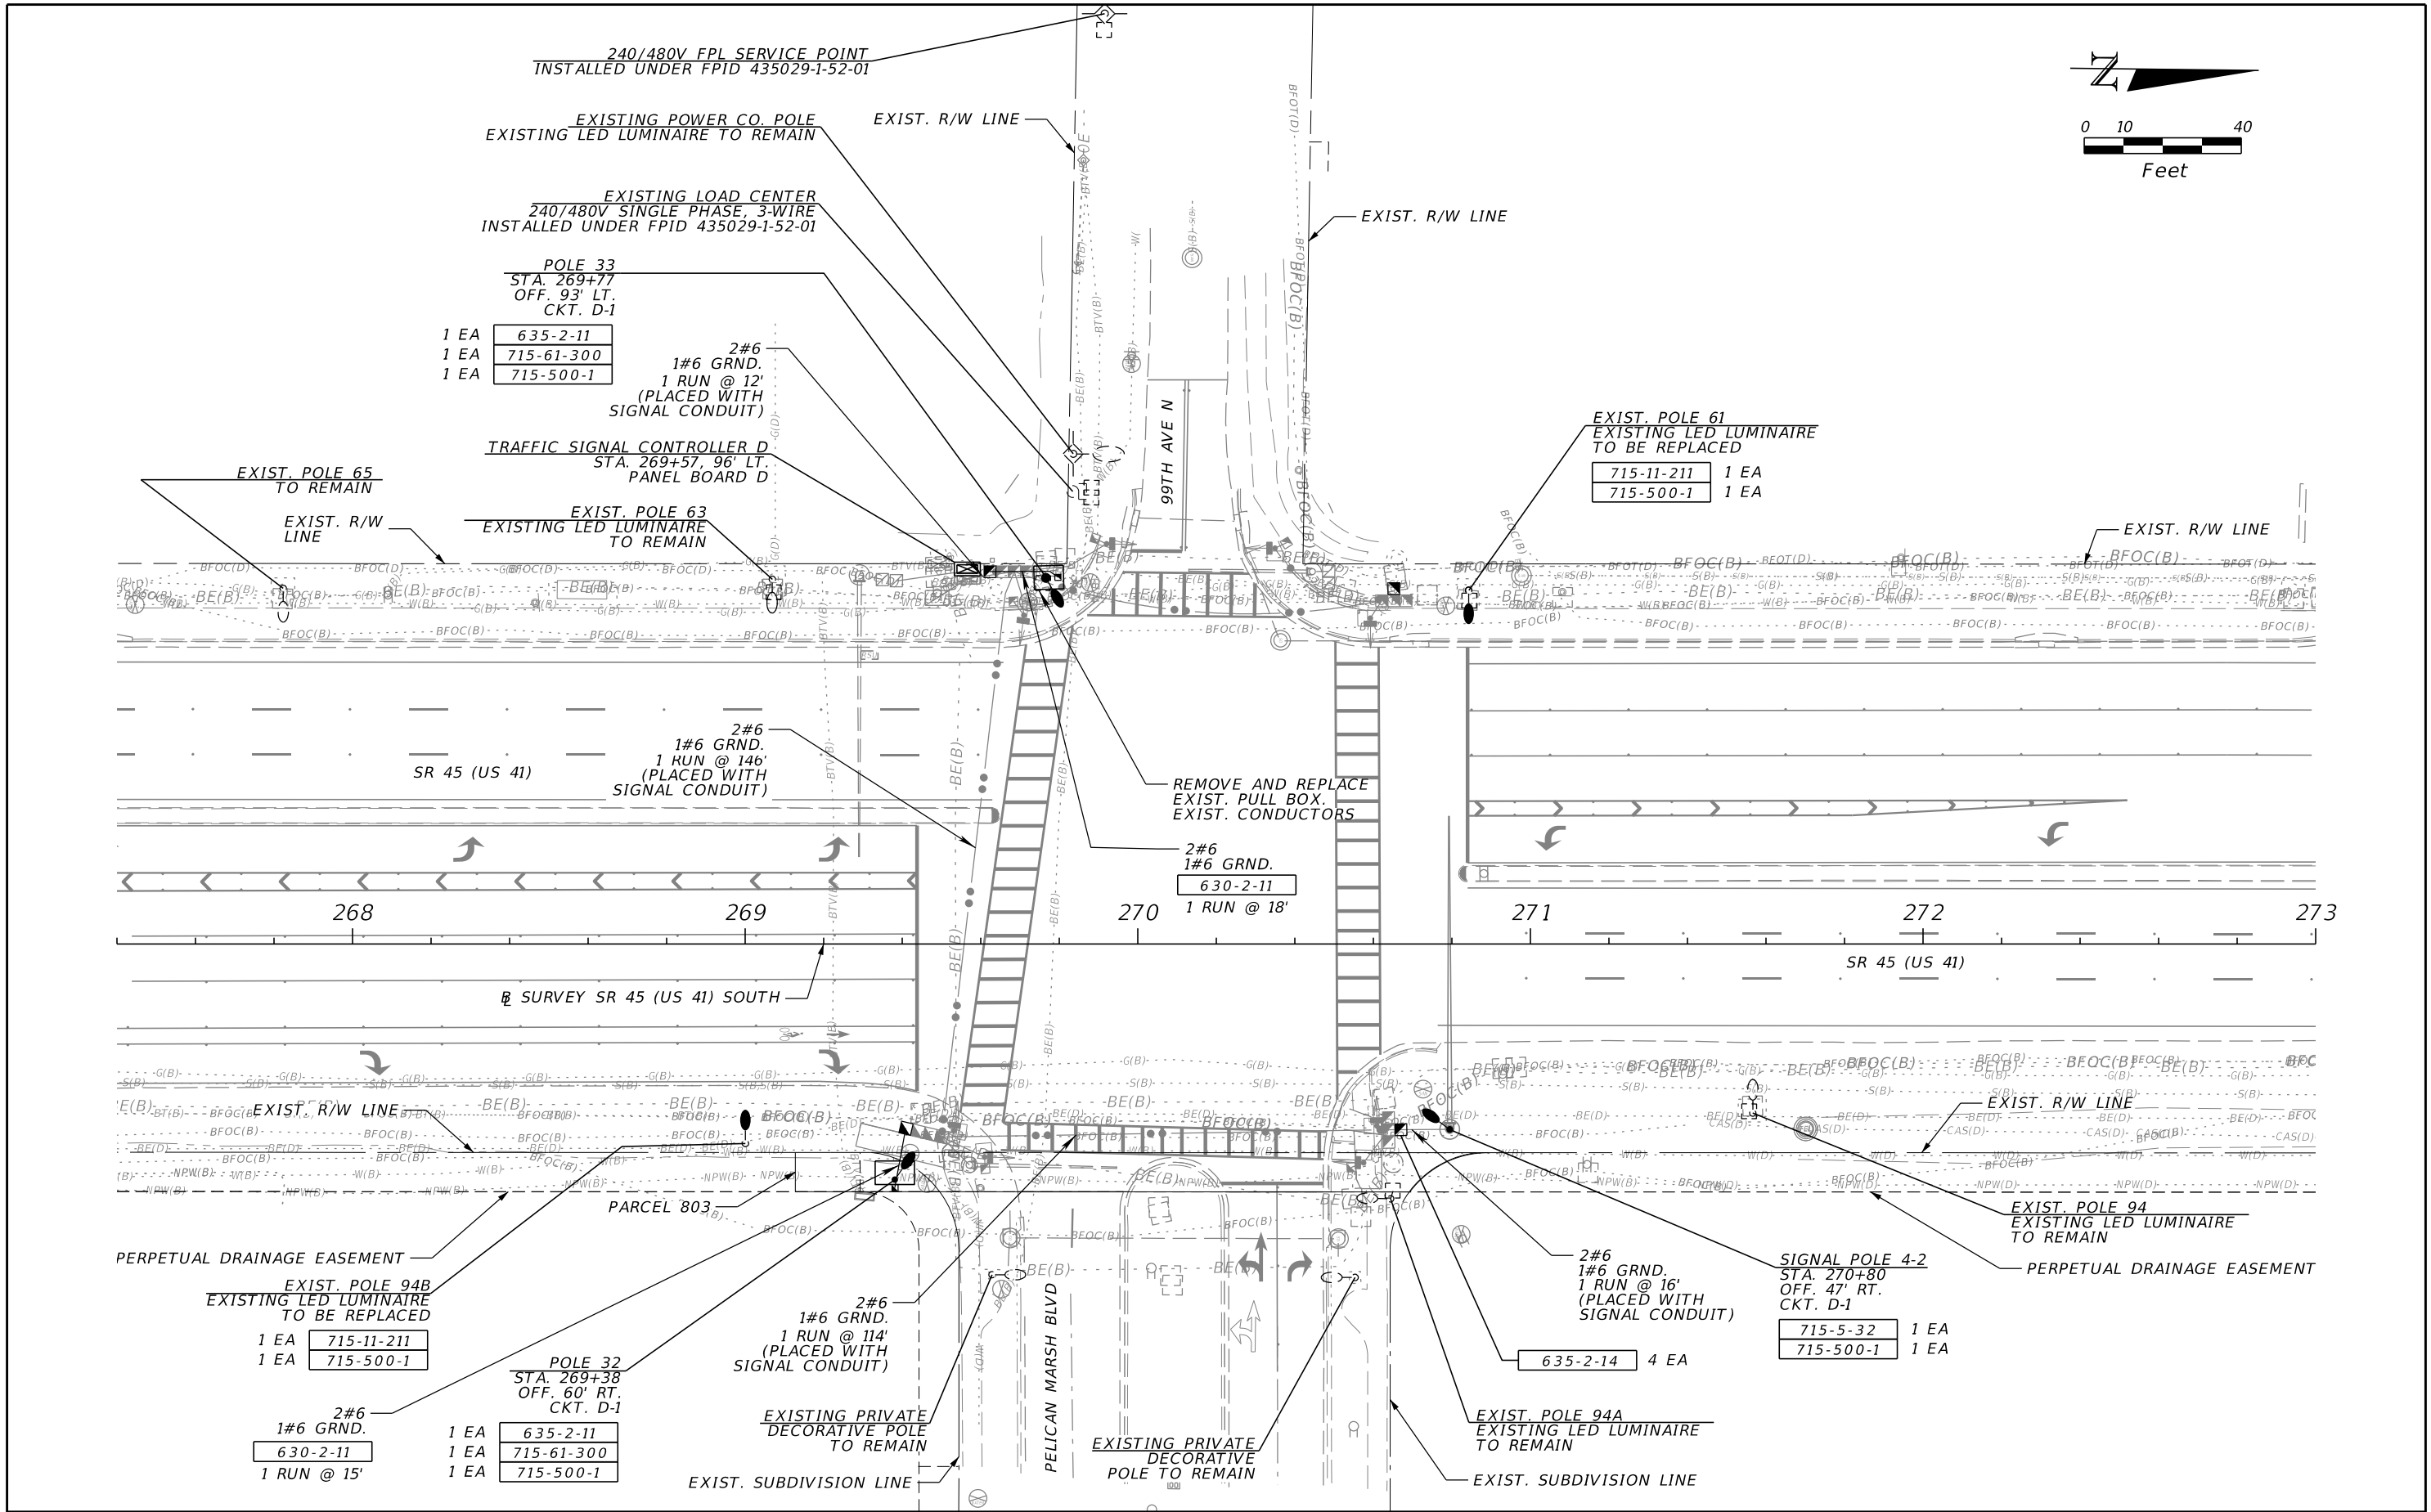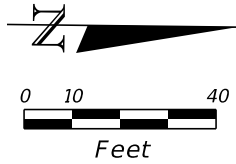

REVISIONS				ENGINEER OF RECORD	STATE OF FLORIDA DEPARTMENT OF TRANSPORTATION			LIGHTING PLAN (4)	SHEET NO.
DATE	DESCRIPTION	DATE	DESCRIPTION	TUCKER DAVID AMMERMAN, P.E. LICENSE NUMBER: 92342 FALLER, DAVIS & ASSOCIATES, INC. 1150 ASSEMBLY DRIVE, SUITE 400 TAMPA, FL 33607-4874	ROAD NO.	COUNTY	FINANCIAL PROJECT ID		L-9
					SR 45	COLLIER	441512-1-52-01		

LIGHTING PLAN (4)


THE OFFICIAL RECORD OF THIS SHEET IS THE ELECTRONIC FILE DIGITALLY SIGNED AND SEALED UNDER RULE 61G15-23.004, F.A.C.

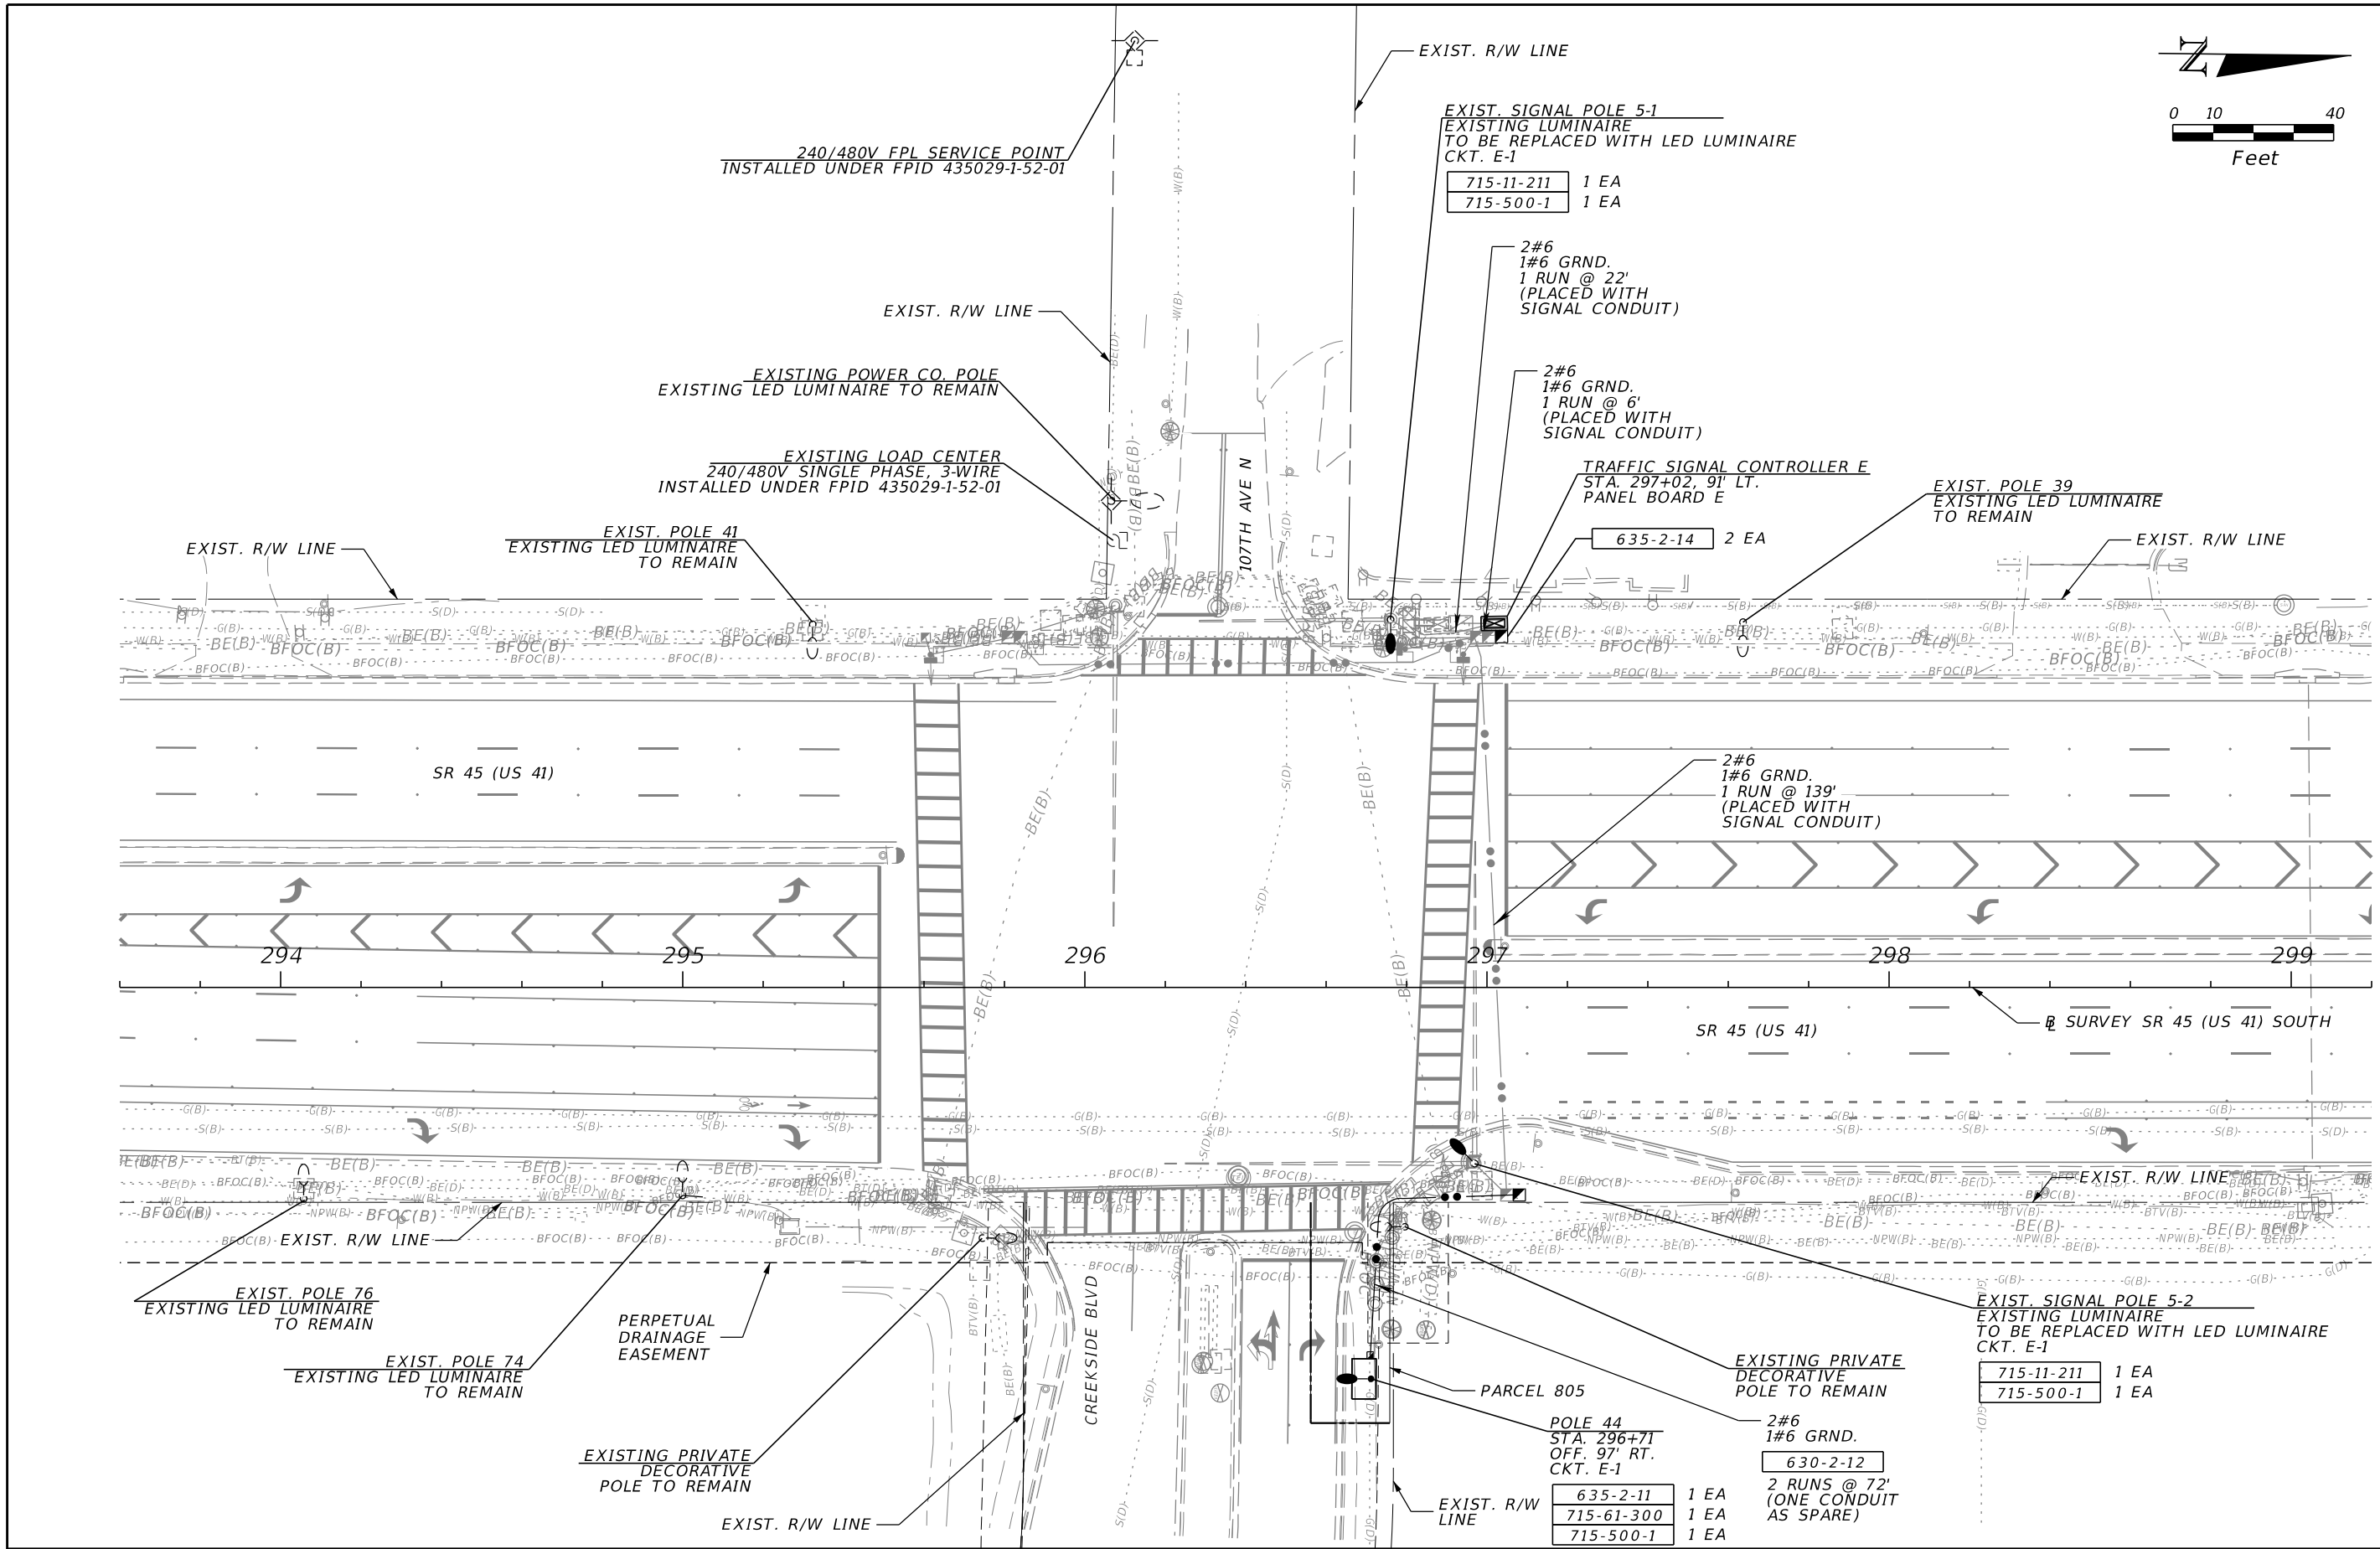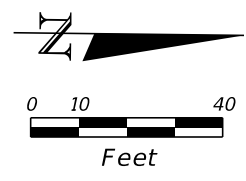


REVISIONS				ENGINEER OF RECORD	STATE OF FLORIDA DEPARTMENT OF TRANSPORTATION			LIGHTING PLAN (5)
DATE	DESCRIPTION	DATE	DESCRIPTION	TUCKER DAVID AMMERMAN, P.E. LICENSE NUMBER: 92342 FALLER, DAVIS & ASSOCIATES, INC. 1150 ASSEMBLY DRIVE, SUITE 400 TAMPA, FL 33607-4874	ROAD NO.	COUNTY	FINANCIAL PROJECT ID	
					SR 45	COLLIER	441512-1-52-01	

LIGHTING PLAN (5)

THE OFFICIAL RECORD OF THIS SHEET IS THE ELECTRONIC FILE DIGITALLY SIGNED AND SEALED UNDER RULE 61G15-23.004, F.A.C.

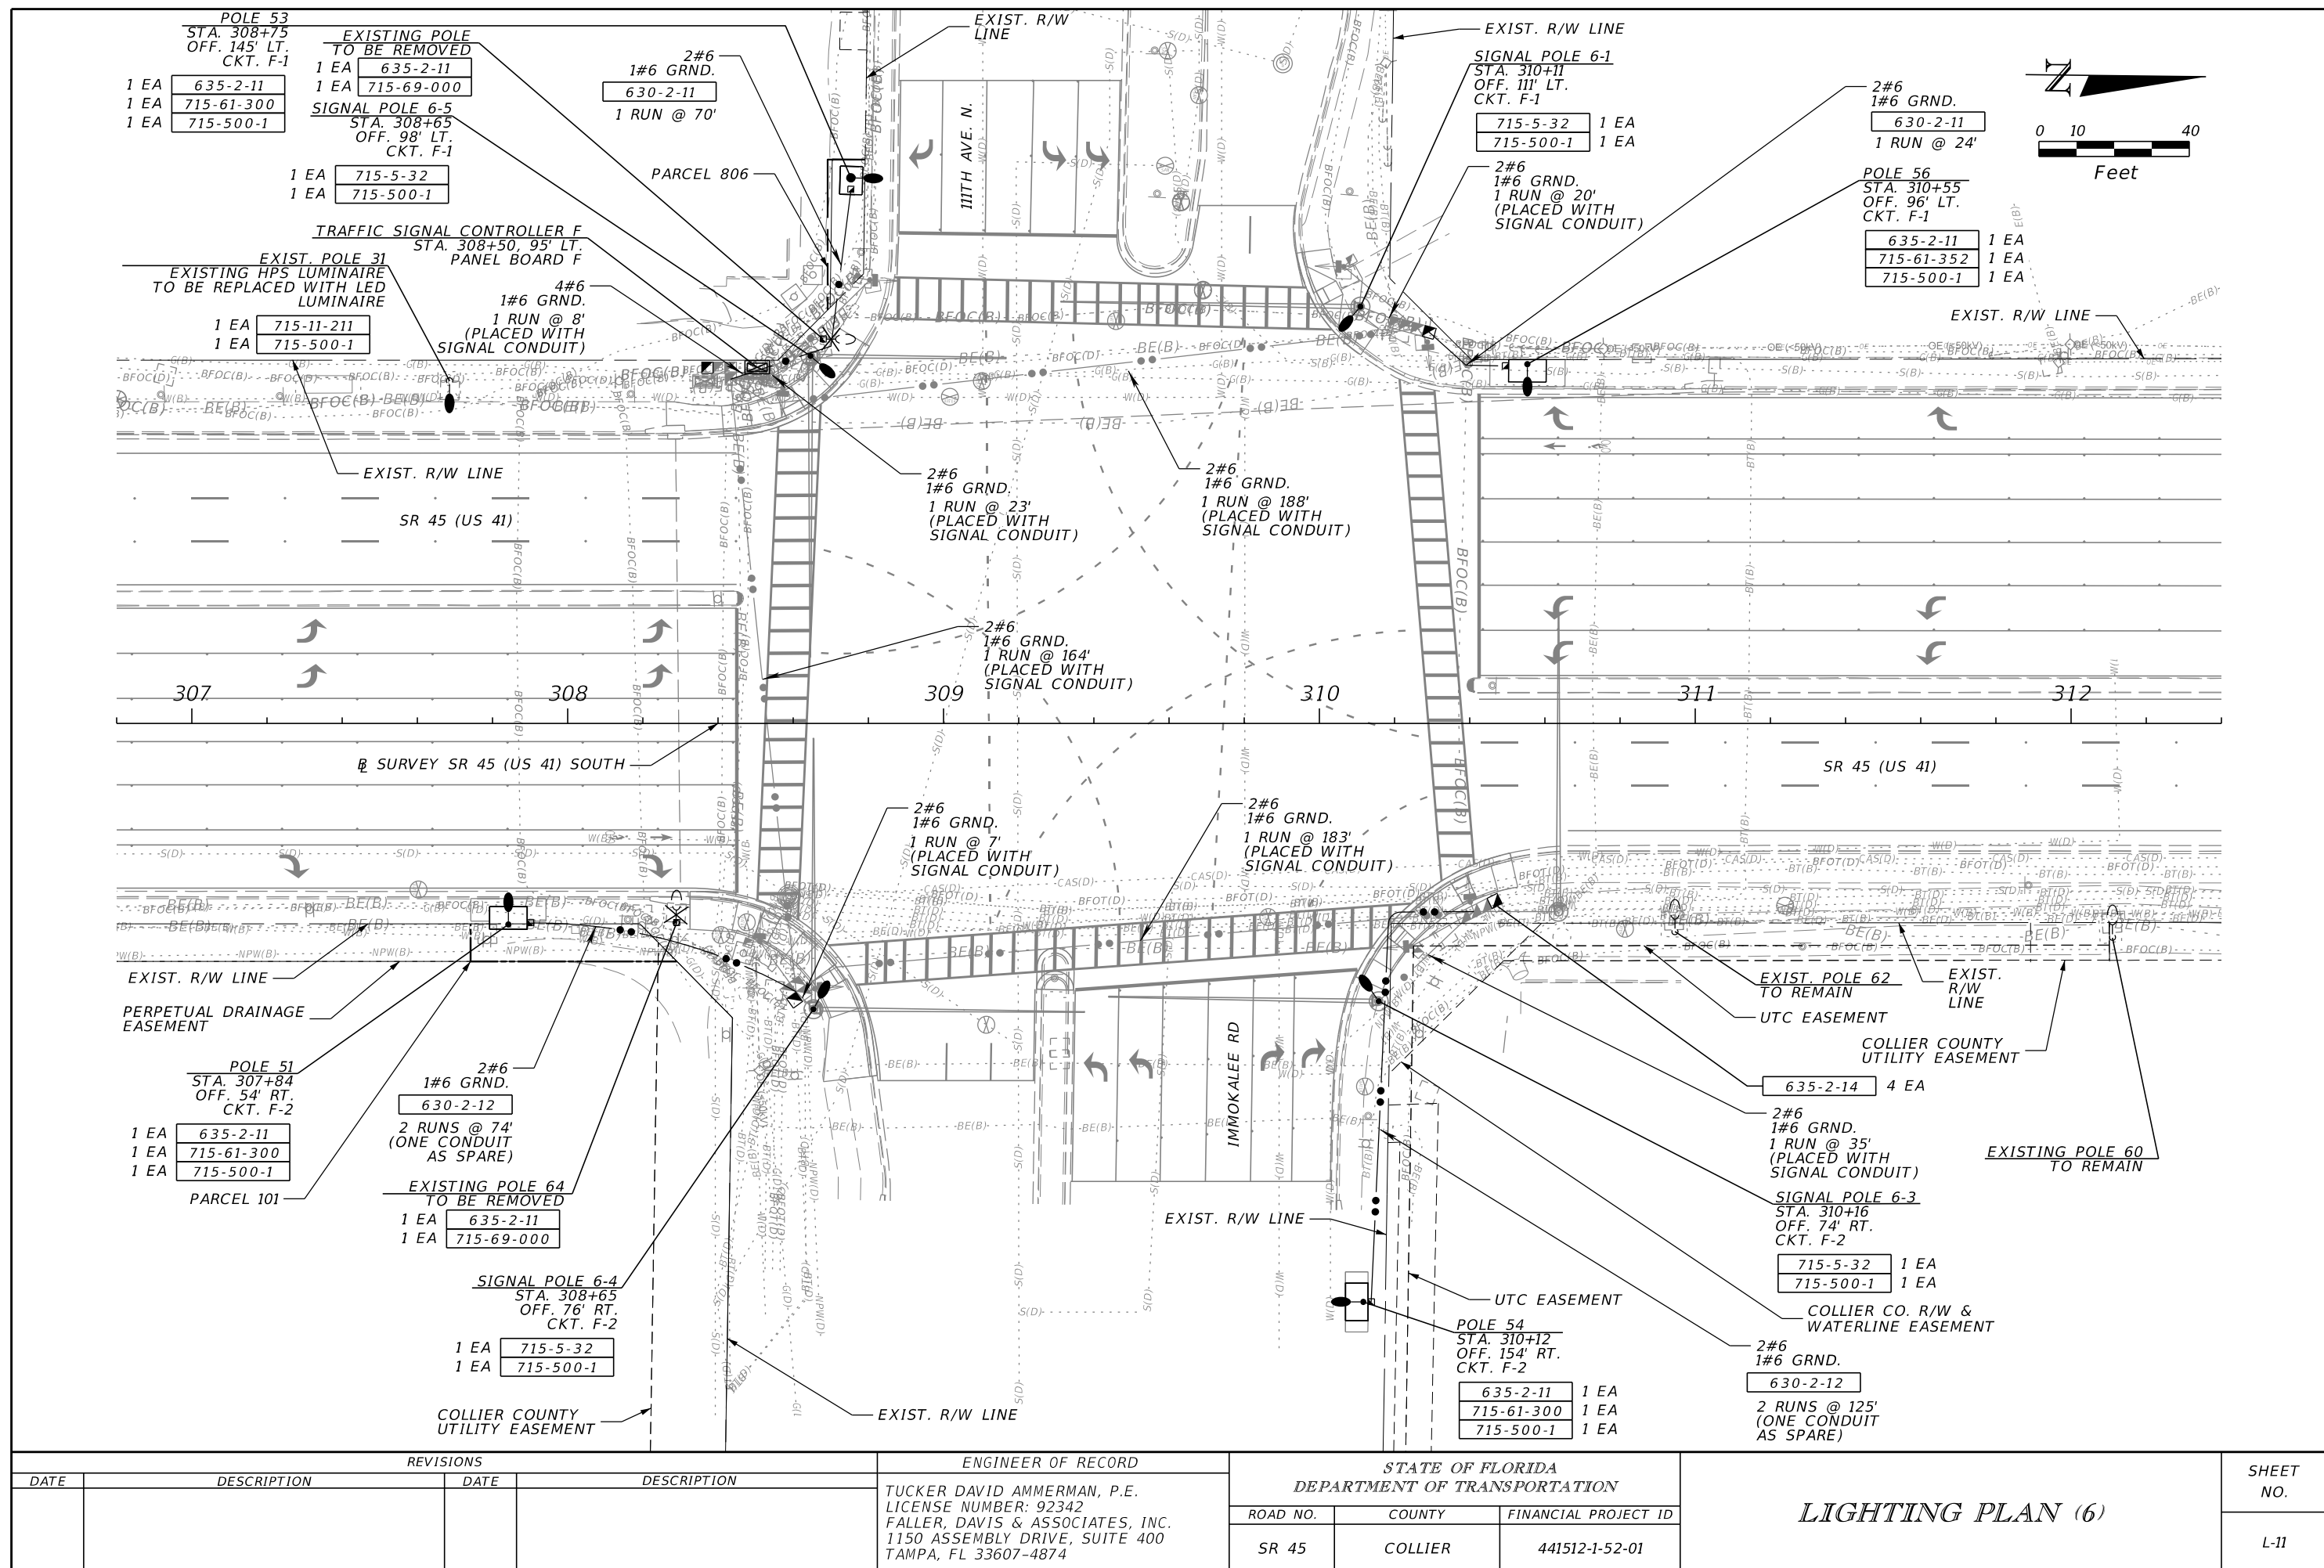


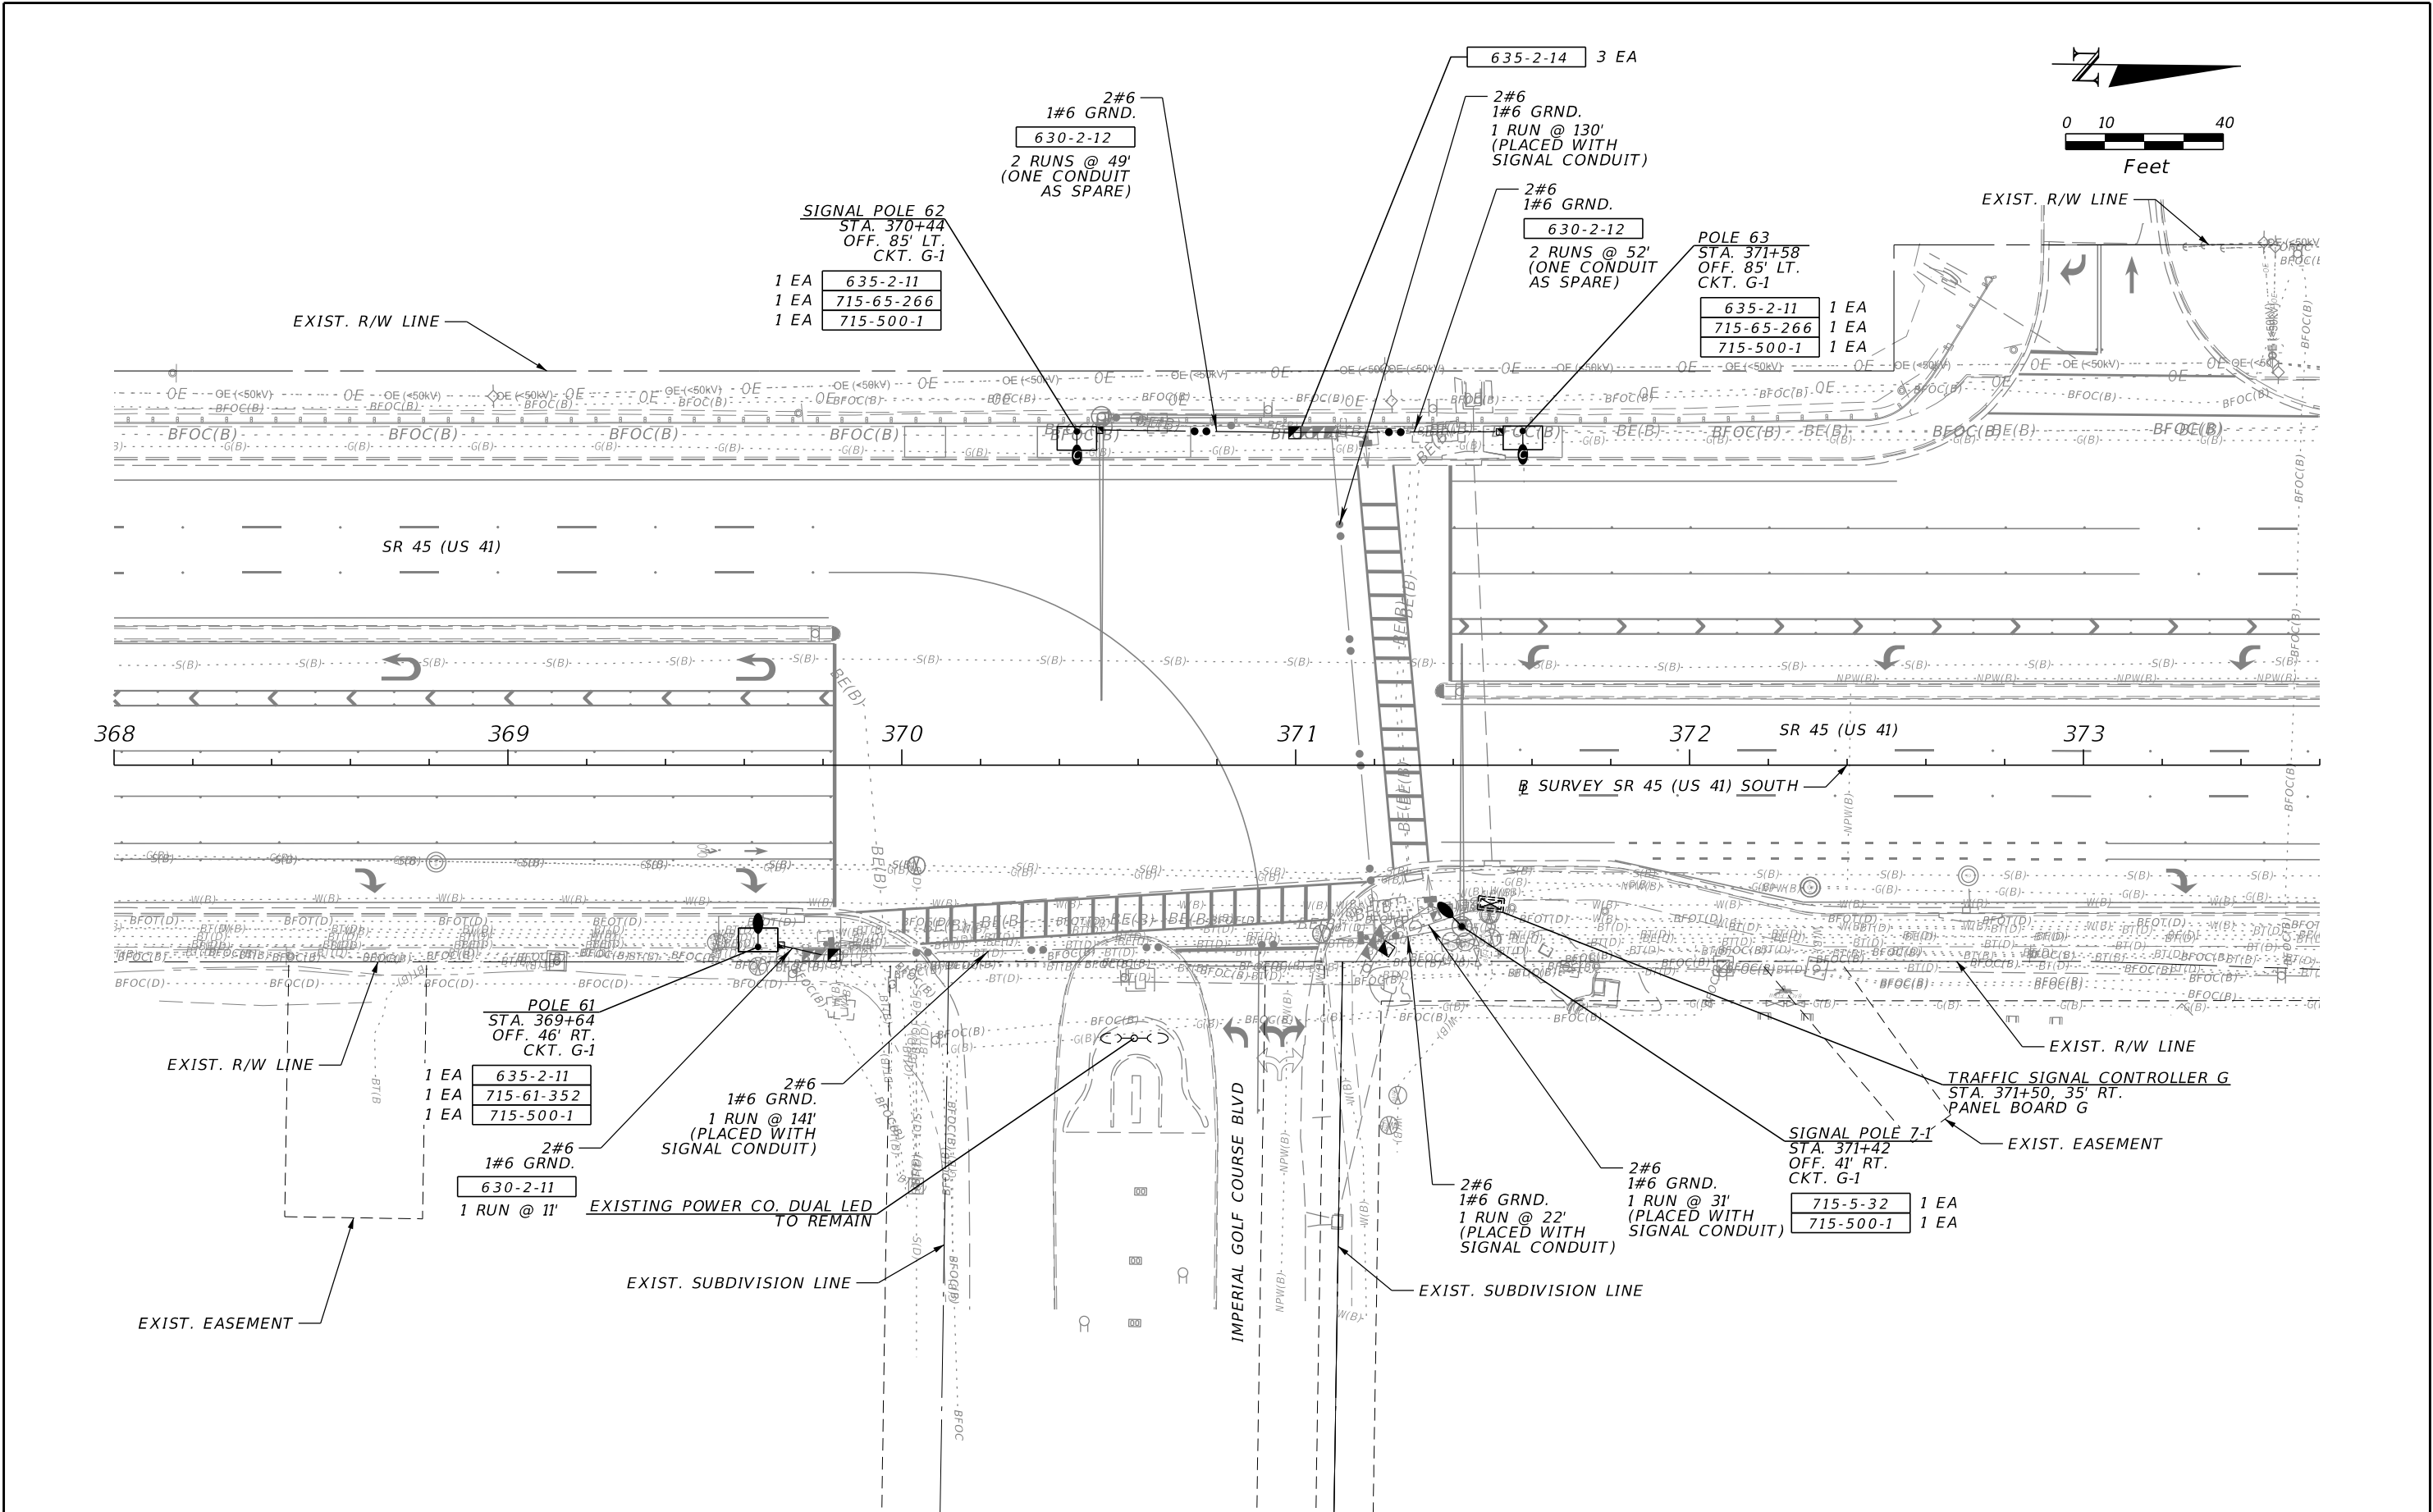

REVISIONS				ENGINEER OF RECORD		STATE OF FLORIDA DEPARTMENT OF TRANSPORTATION			SHEET NO.
DATE	DESCRIPTION	DATE	DESCRIPTION	TUCKER DAVID AMMERMAN, P.E. LICENSE NUMBER: 92342 FALLER, DAVIS & ASSOCIATES, INC. 1150 ASSEMBLY DRIVE, SUITE 400 TAMPA, FL 33607-4874		ROAD NO.	COUNTY	FINANCIAL PROJECT ID	
						SR 45	COLLIER	441512-1-52-01	

LIGHTING PLAN (7)


THE OFFICIAL RECORD OF THIS SHEET IS THE ELECTRONIC FILE DIGITALLY SIGNED AND SEALED UNDER RULE 61G15-23.004, F.A.C.

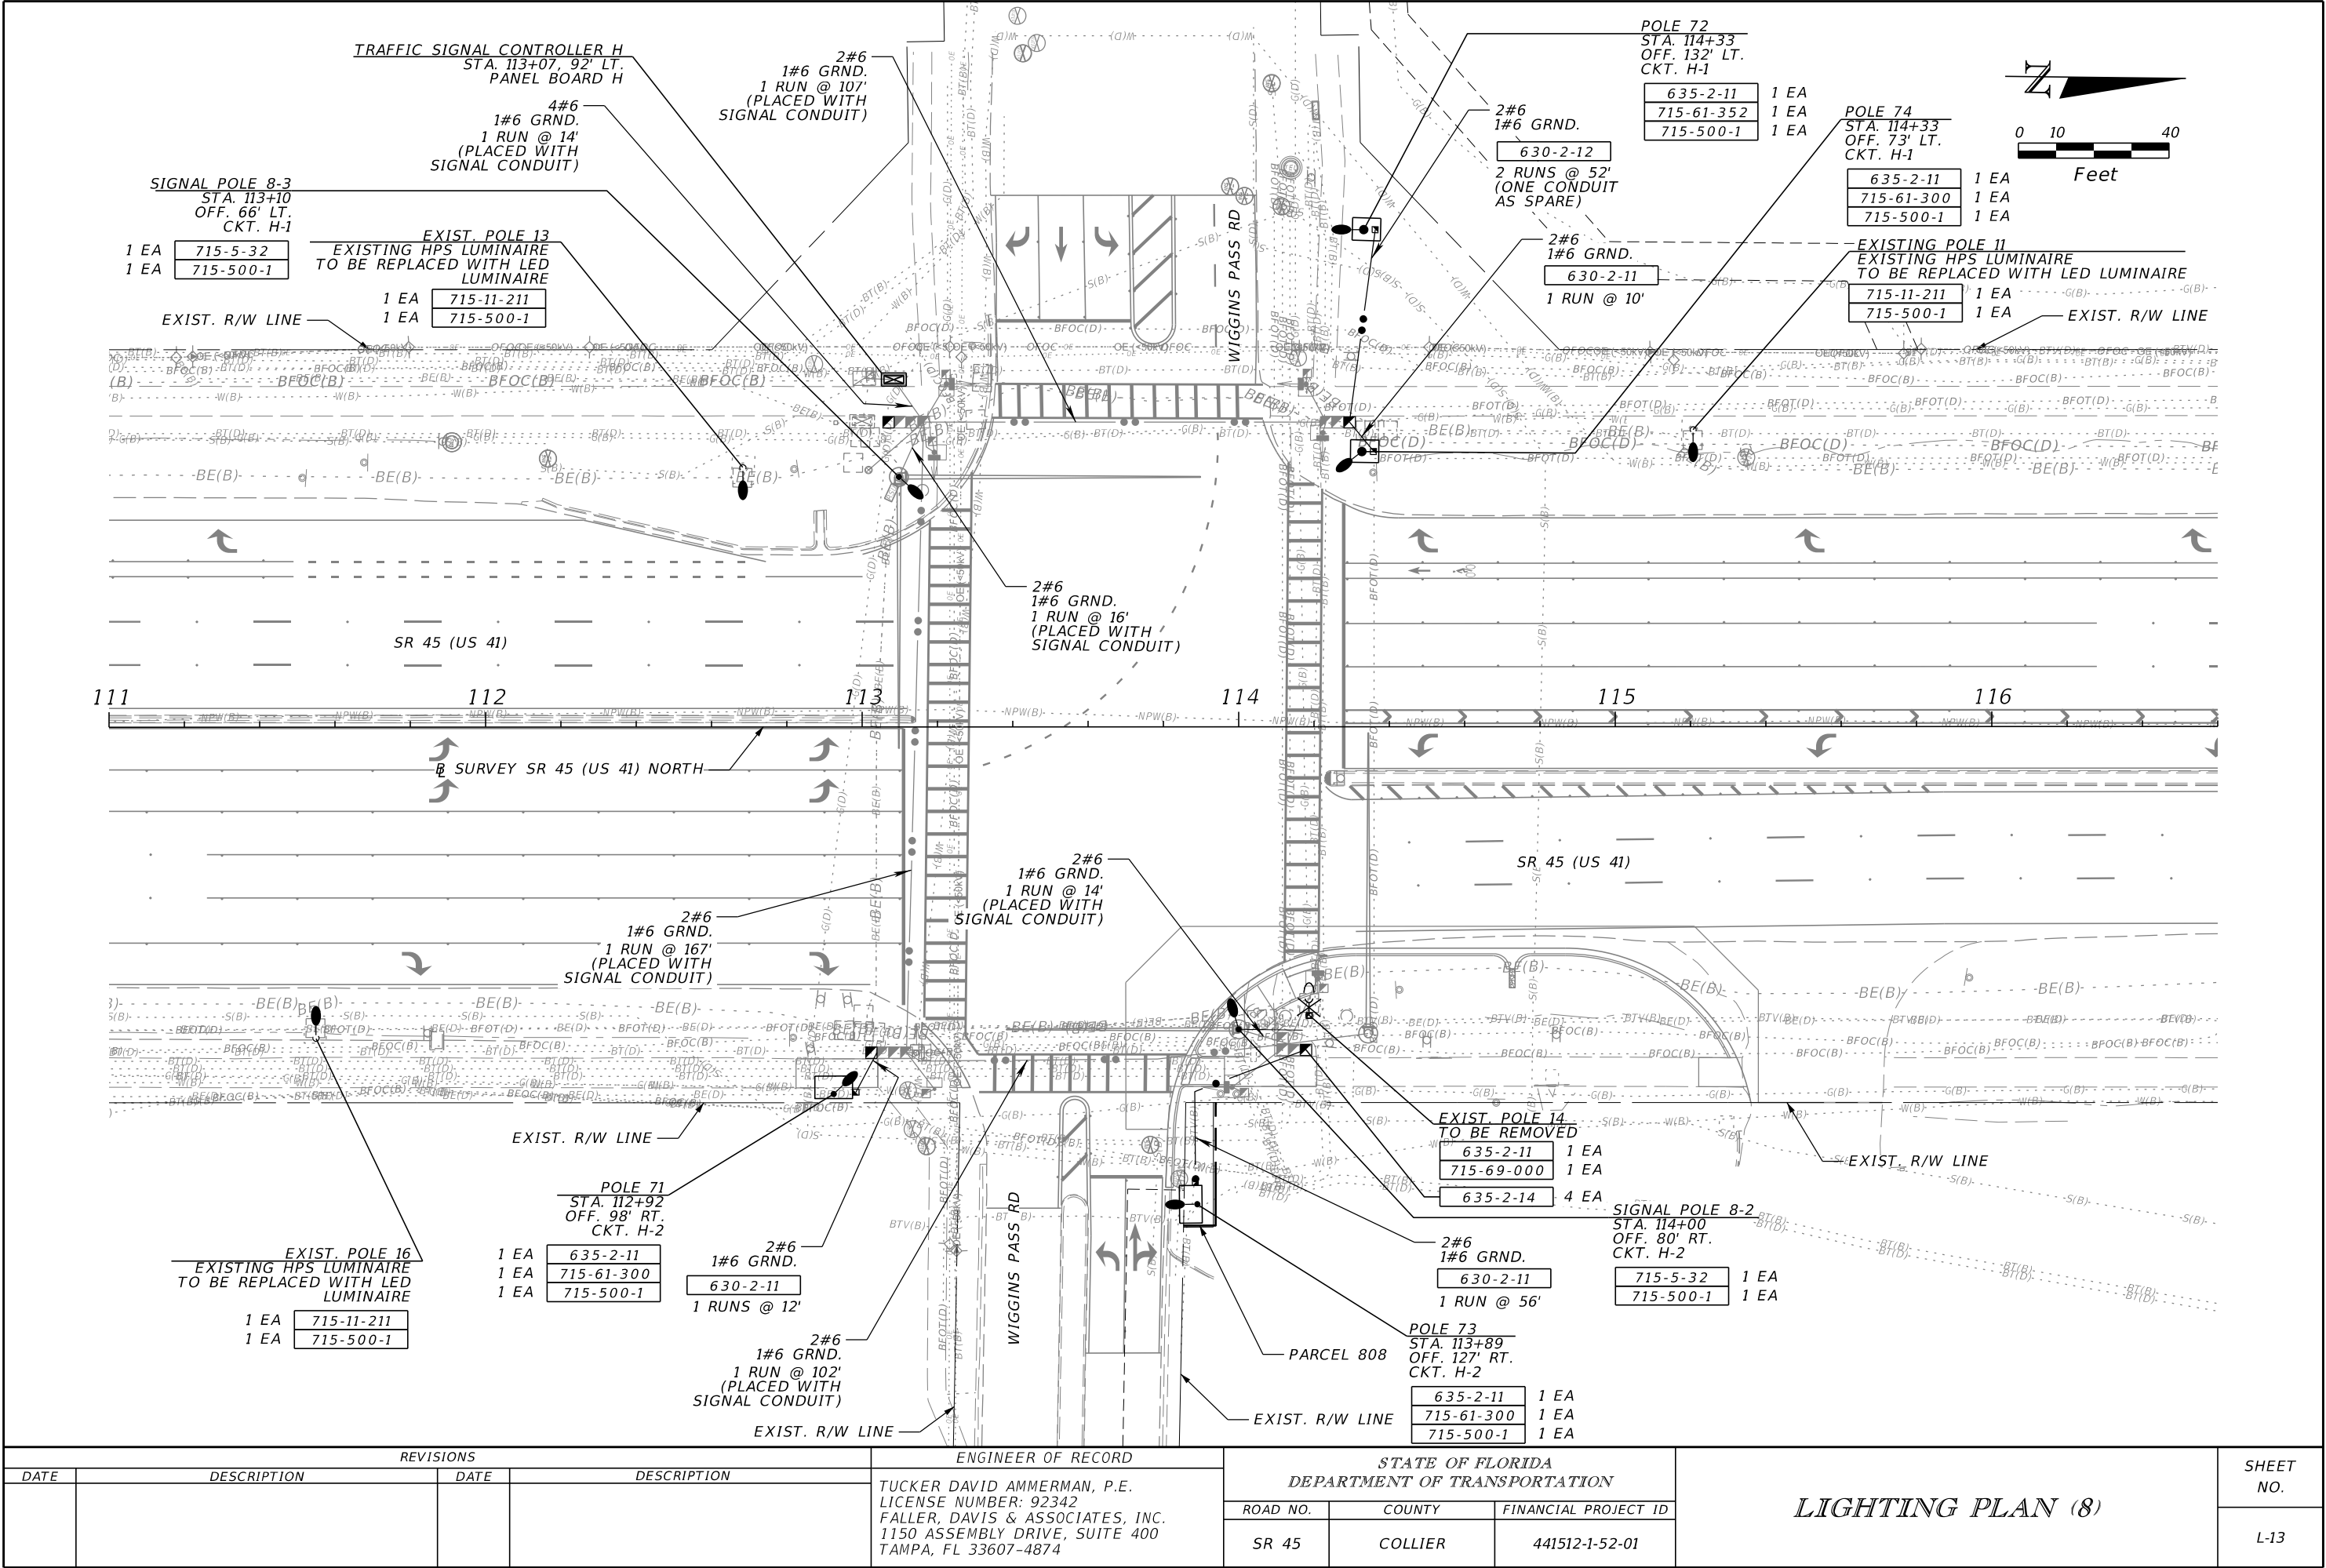

REVISIONS				ENGINEER OF RECORD	STATE OF FLORIDA DEPARTMENT OF TRANSPORTATION			LIGHTING PLAN (8)	SHEET NO.
DATE	DESCRIPTION	DATE	DESCRIPTION	TUCKER DAVID AMMERMAN, P.E. LICENSE NUMBER: 92342 FALLER, DAVIS & ASSOCIATES, INC. 1150 ASSEMBLY DRIVE, SUITE 400 TAMPA, FL 33607-4874	ROAD NO.	COUNTY	FINANCIAL PROJECT ID		L-13
					SR 45	COLLIER	441512-1-52-01		

LIGHTING PLAN (8)

THE OFFICIAL RECORD OF THIS SHEET IS THE ELECTRONIC FILE DIGITALLY SIGNED AND SEALED UNDER RULE 61G15-23.004, F.A.C.

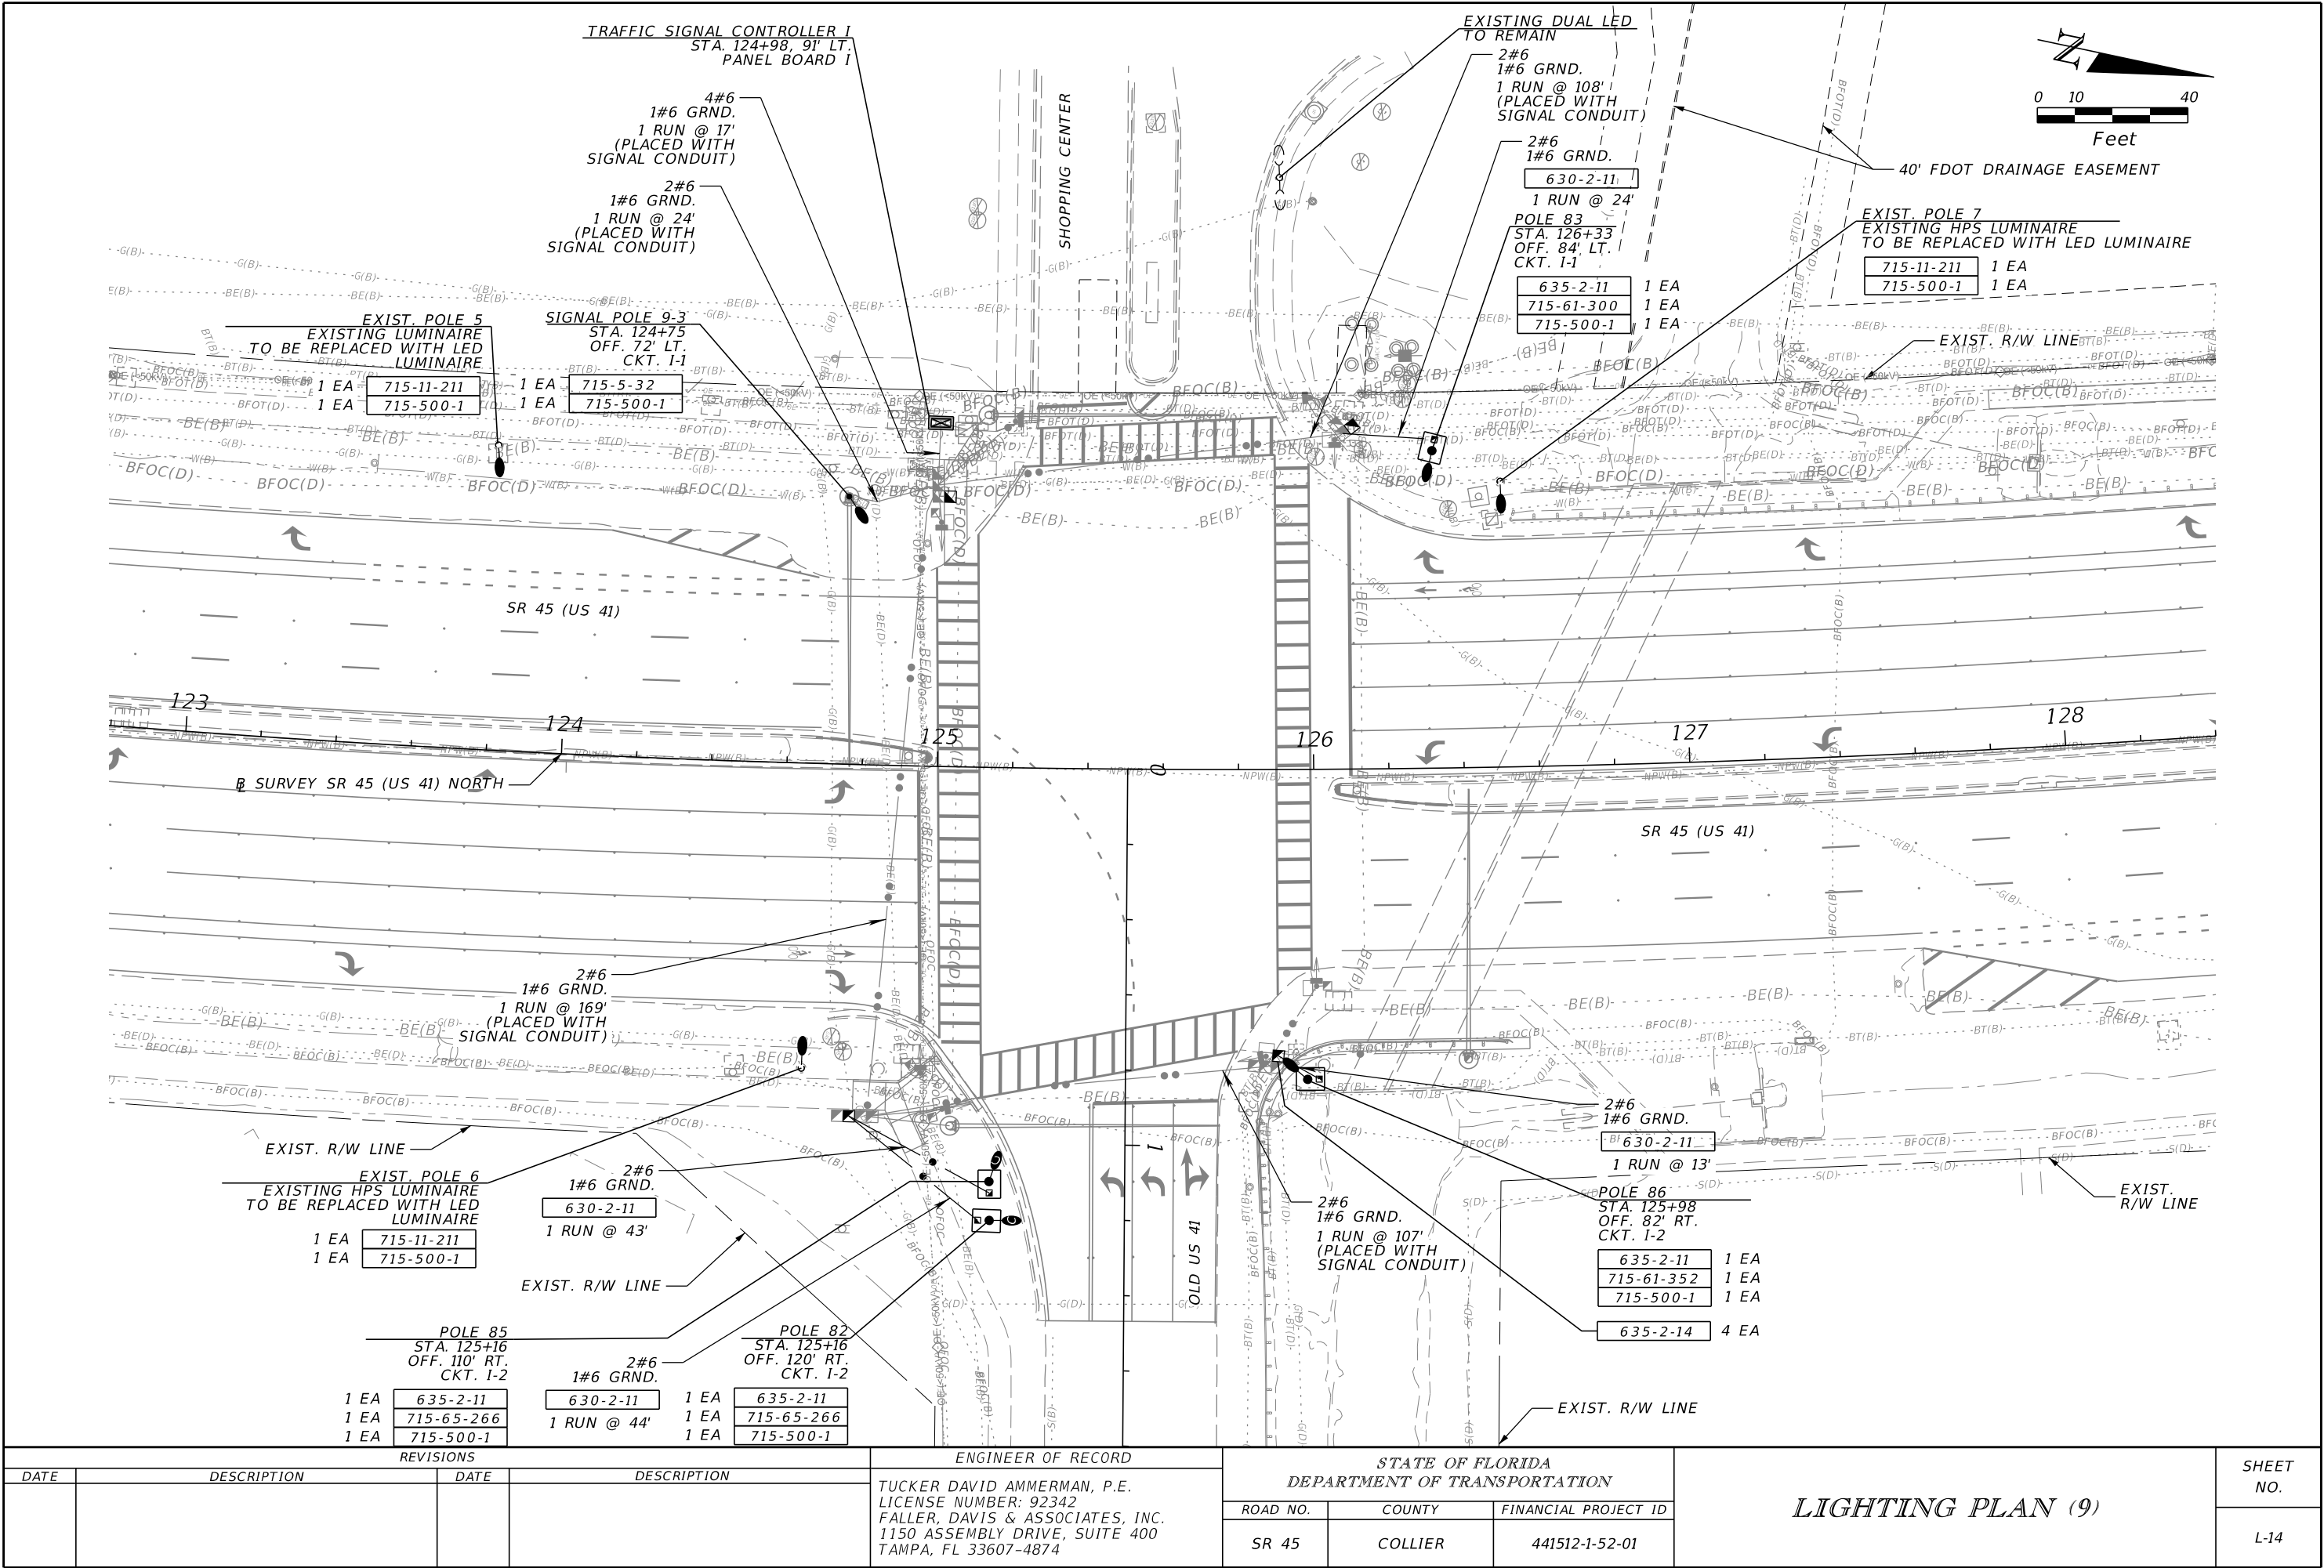

REVISIONS		REVISIONS	
DATE	DESCRIPTION	DATE	DESCRIPTION

ENGINEER OF RECORD	
TUCKER DAVID AMMERMAN, P.E. LICENSE NUMBER: 92342 FALLER, DAVIS & ASSOCIATES, INC. 1150 ASSEMBLY DRIVE, SUITE 400 TAMPA, FL 33607-4874	

STATE OF FLORIDA DEPARTMENT OF TRANSPORTATION		
ROAD NO.	COUNTY	FINANCIAL PROJECT ID
SR 45	COLLIER	441512-1-52-01

LIGHTING PLAN (9)	
SHEET NO.	
L-14	